

SCALE 1"=200'


Avoid cutting underground utility lines. It's costly.

**Call
before you
Dig**

1-800-227-26
UNDERGROUND SERVICE

2	23 JUN 91	Ed	CHANGE CALICO BASIN TO CRIMSON CANYON DRIVE
1	23 APR 90	Ed	CENTEL STUBS AND PULLBOX LOCATIONS

SCALE : 1" = 200'
DESIGNED : NEM/MS
DRAWN : Ed/MEF
CHECKED : WSC
DATE : OCT. '89
N : 900401

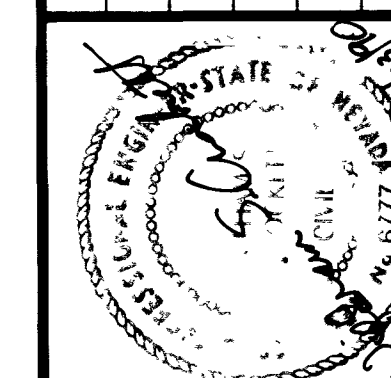


DELTA ENGINEERING INC
ENGINEERING • LAND SURVEYING • PLANNING
4500 WEST OAKLEY BLVD. • LAS VEGAS, NEVADA 89102

**GAS AND TELEPHONE UTILITY PLAN
LAS VEGAS TECHNOLOGY CENTER
INFRASTRUCTURE DEVELOPMENT PHASE II**

SHEET No.

13 OF 16

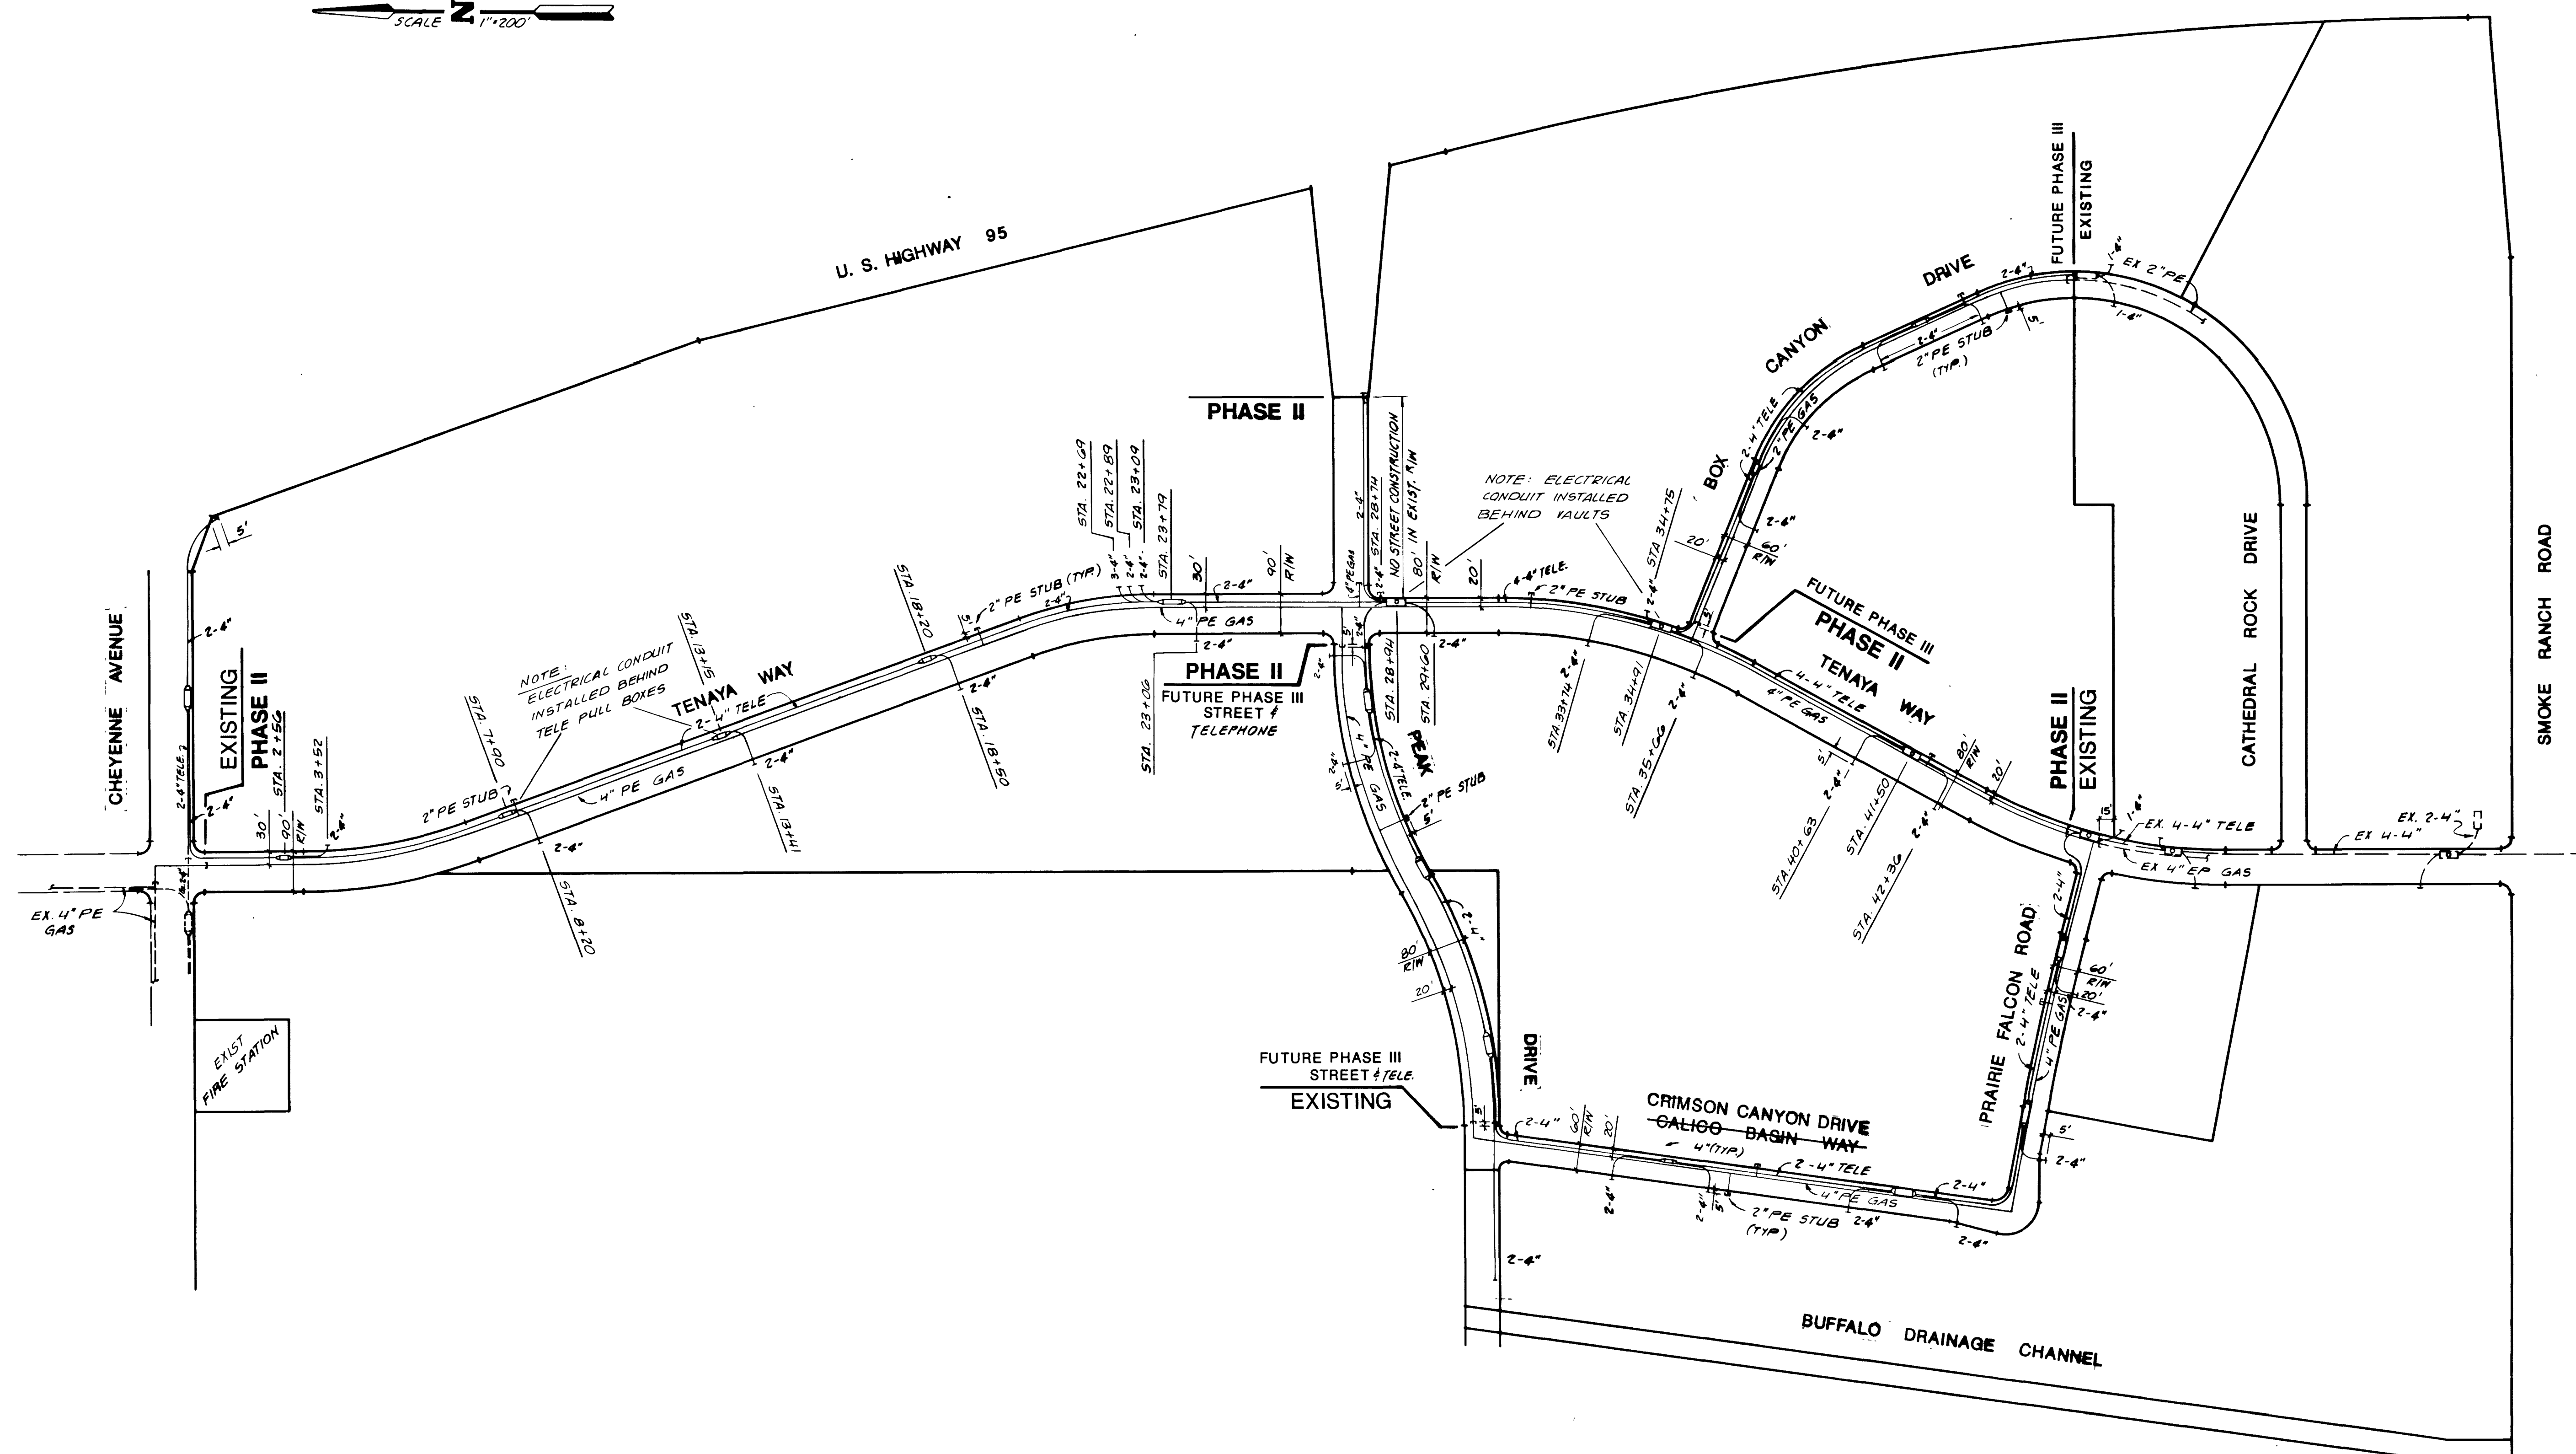

NOTE:

CONSTRUCTION OF GAS PIPE AND FACILITIES BY OTHERS.
NOT A PART OF THIS CONTRACT.
CONTRACTOR SHALL COORDINATE CONSTRUCTION WITH
SOUTHWEST GAS CO.

LEGEND

- 5' X 10'-6" X 7' MANHOLE EQUIPPED WITH EIGHT 37-HOLE CABLE RACKS
ONE 9' LADDER, 30" COLLAR AND STEEL TRAFFIC COVER.
- 3' X 6' X 4' PULLBOX EQUIPPED WITH FOUR 18-HOLE CABLE RACKS AND
STEEL TRAFFIC COVER.
- 4" CONDUIT, PVC - DE 100 GRADE.

NOTE: SERVICE LATERALS INSTALLED WITH
TRANSPONDERS AT END OF CONDUIT

RECORD DRAWING

From Information Provided
By The City of Las Vegas

William S. Cochart 10/1/91
Signature Date

