



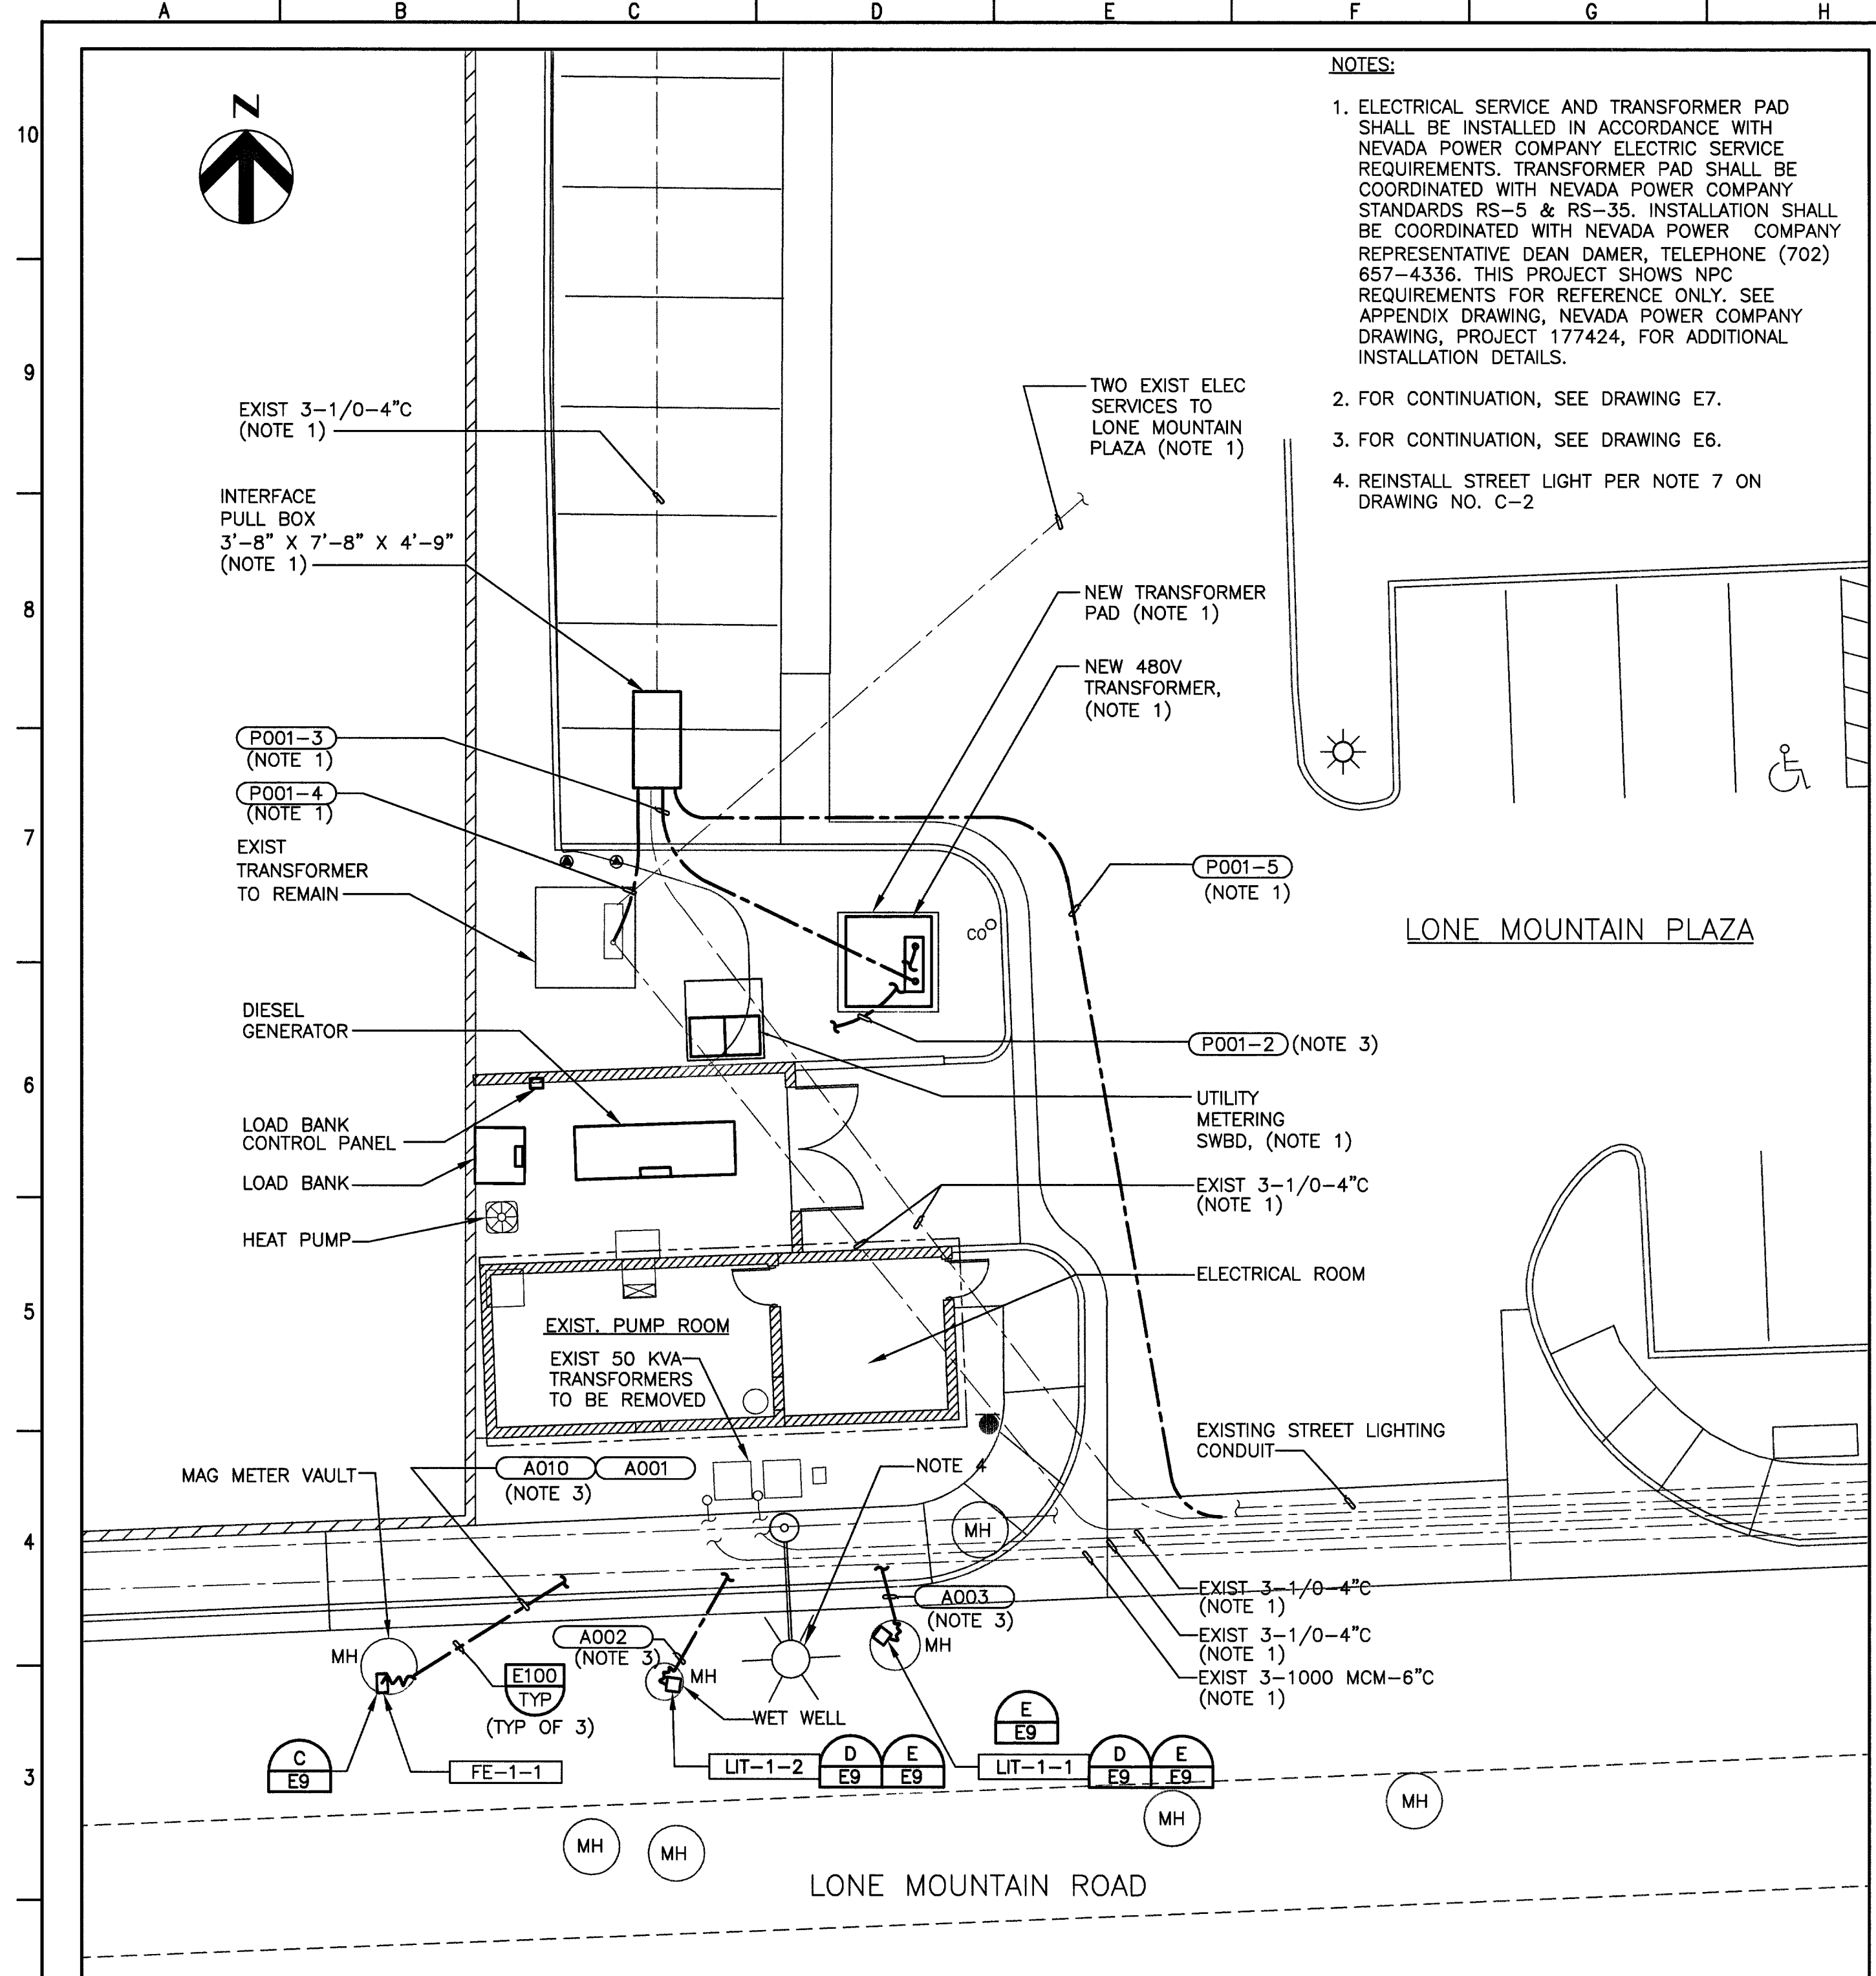


POWER SITE PLAN

1" = 10'

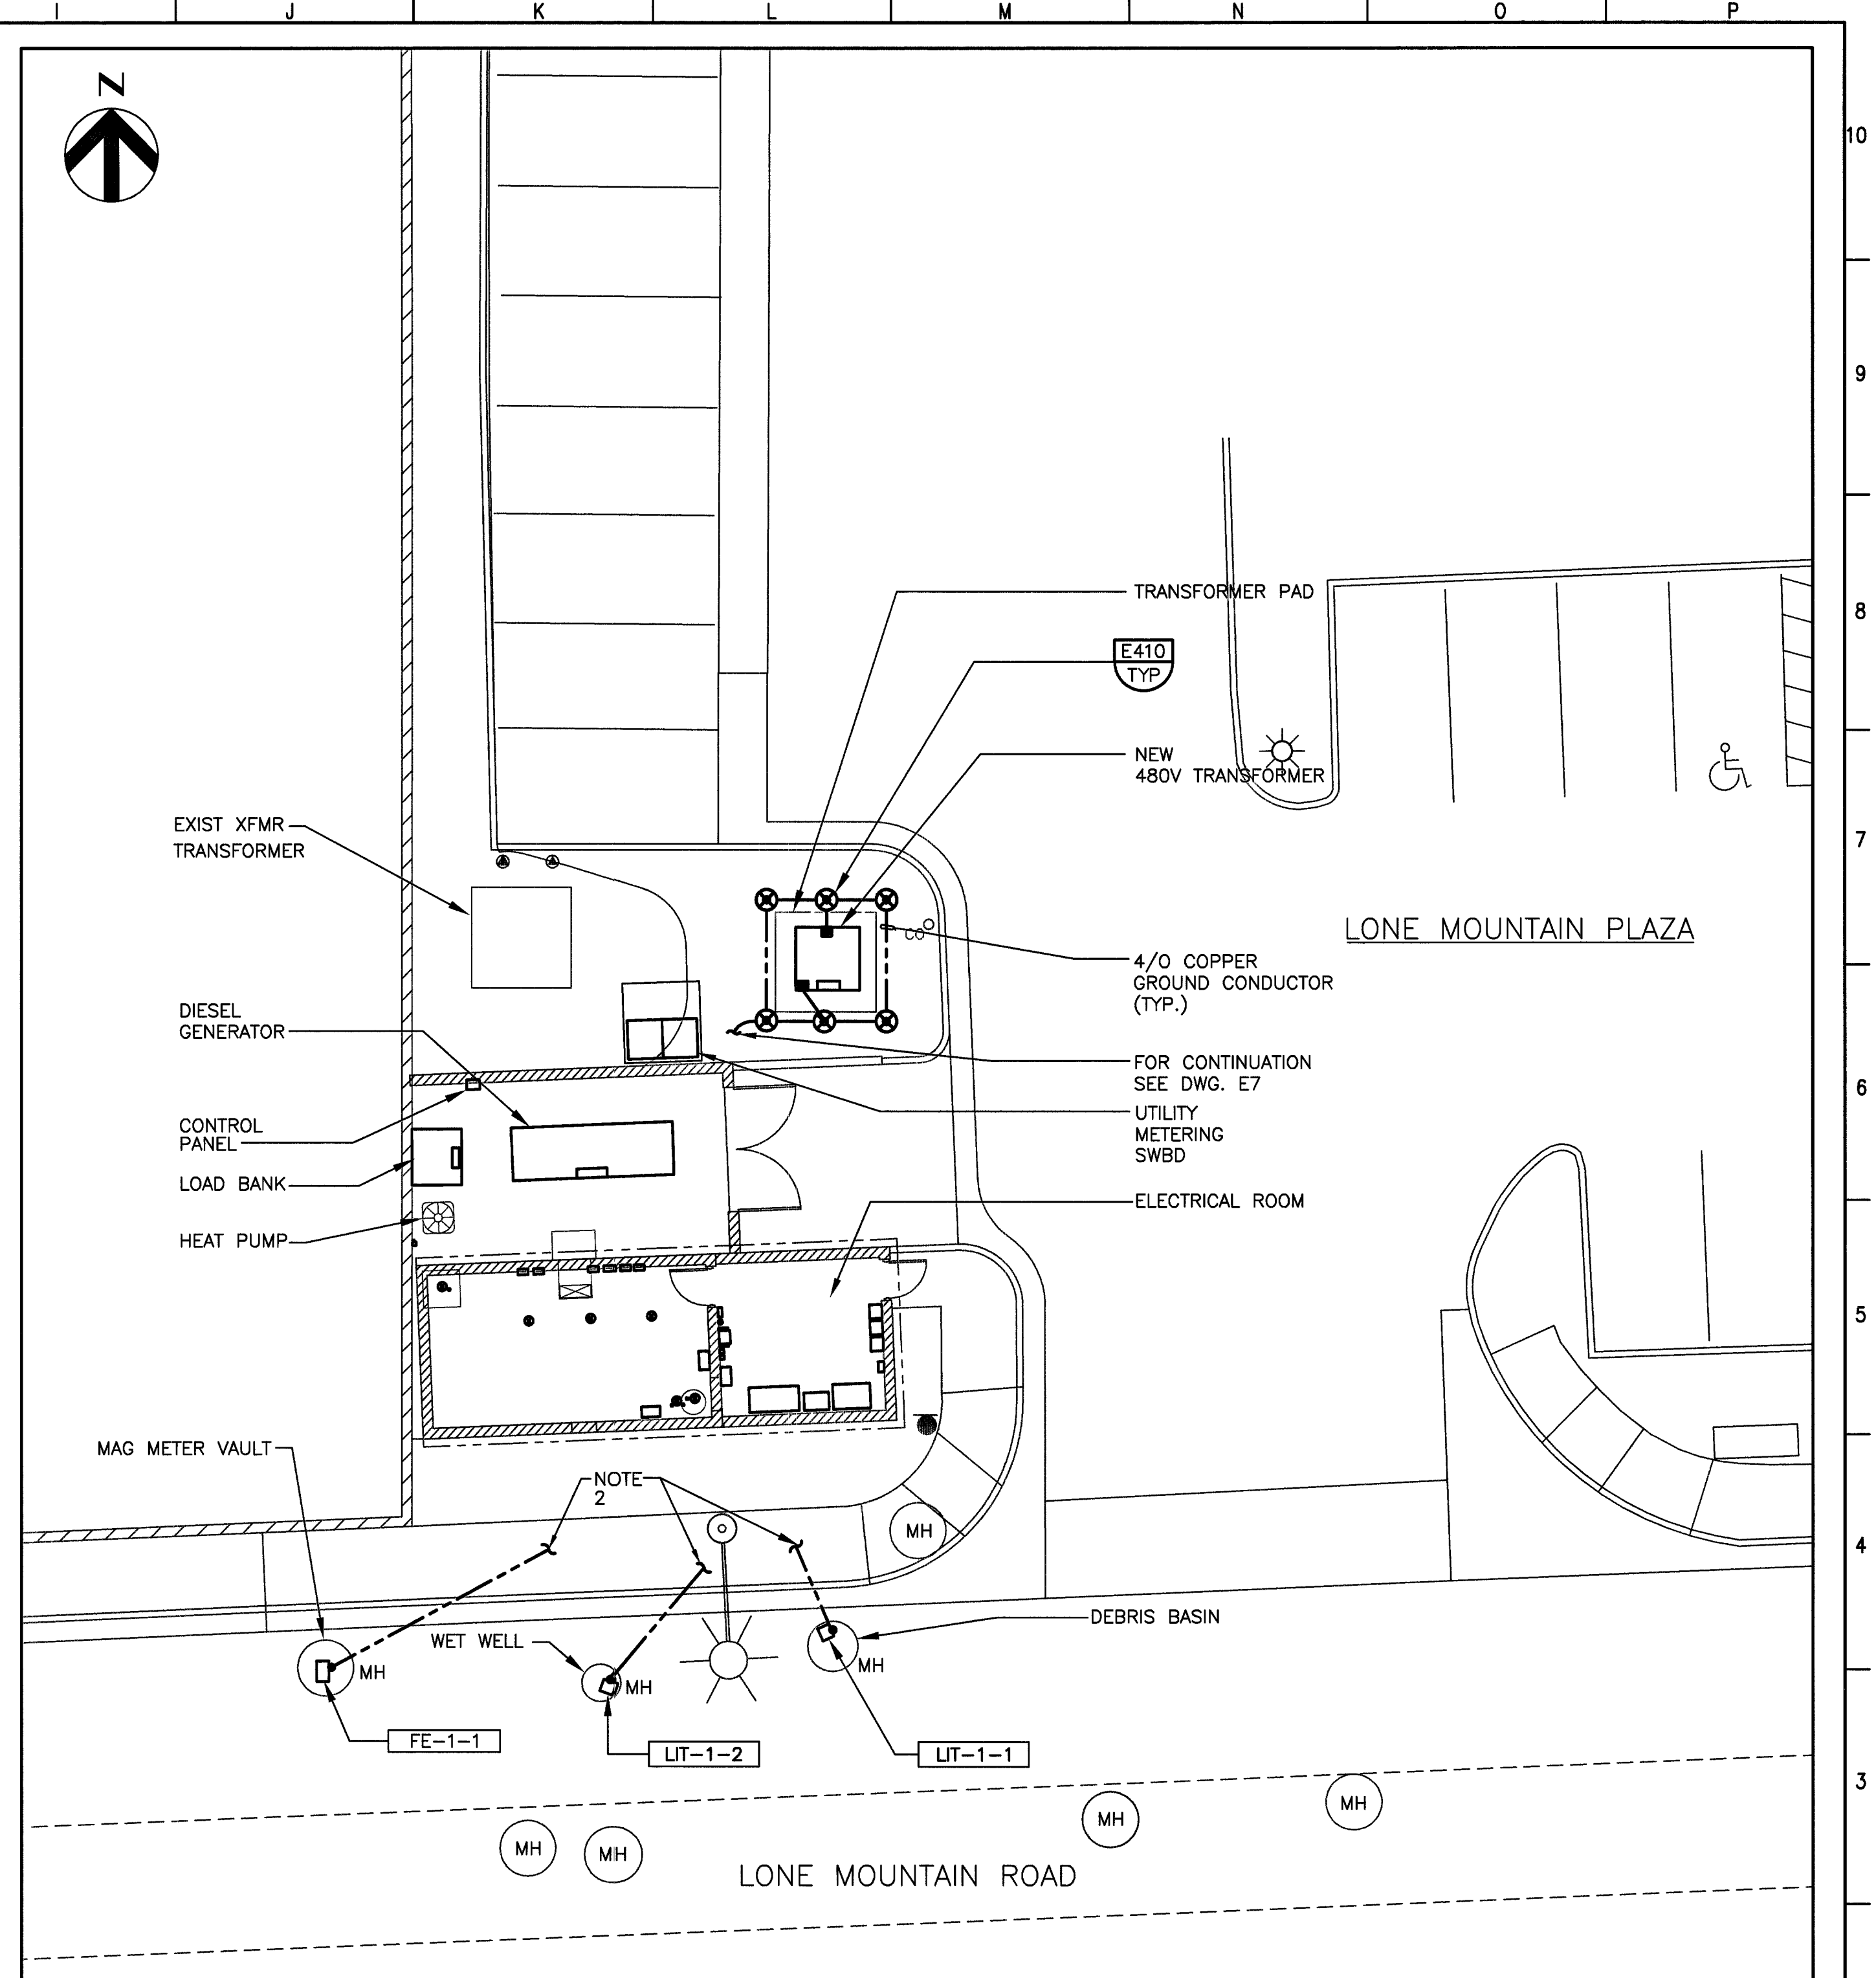

GROUNDING SITE PLAN

 1" = 10'




Avoid cutting underground utility lines. It's costly.
Call before you Dig
 1-800-227-2600


Avoid overhead power line contact. It's costly.
Call before you OVERHEAD
 1-702-593-6111

VERIFY SCALES
 BAR IS ONE INCH ON ORIGINAL DRAWING
 0 1"
 IF NOT ONE INCH ON THIS SHEET, ADJUST SCALES ACCORDINGLY.

REV NO.	REVISION DESCRIPTION	DATE	DRAWN	CHECKED
79402				

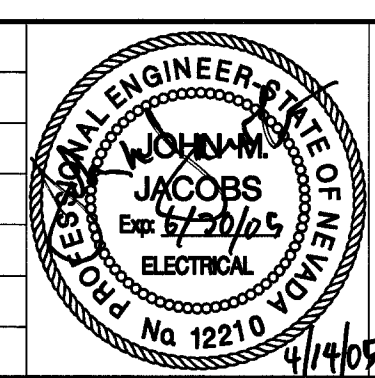

City of Las Vegas
 DEPARTMENT OF PUBLIC WORKS

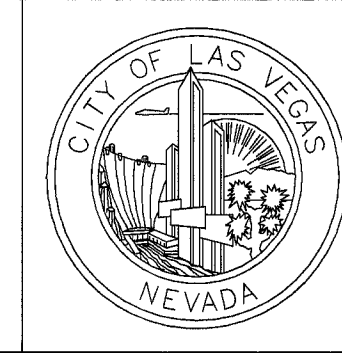

Environmental Division
 LONE MOUNTAIN SEWER LIFT STATION MODIFICATIONS
 DURANGO HILLS WATER RESOURCE CENTER MISC IMPROVEMENTS
 SUPERSEDES DWG NO. DESIGNED BY: R. VEGA
 DRAWN BY: R. VEGA
 CHECKED BY: L. WONG

LONE MOUNTAIN SEWER LIFT STATION ELECTRICAL SITE PLANS
 SCALE: 1" = 10' DRAWING NO. E-4 SHEET NO. 34 of 46

304/19