


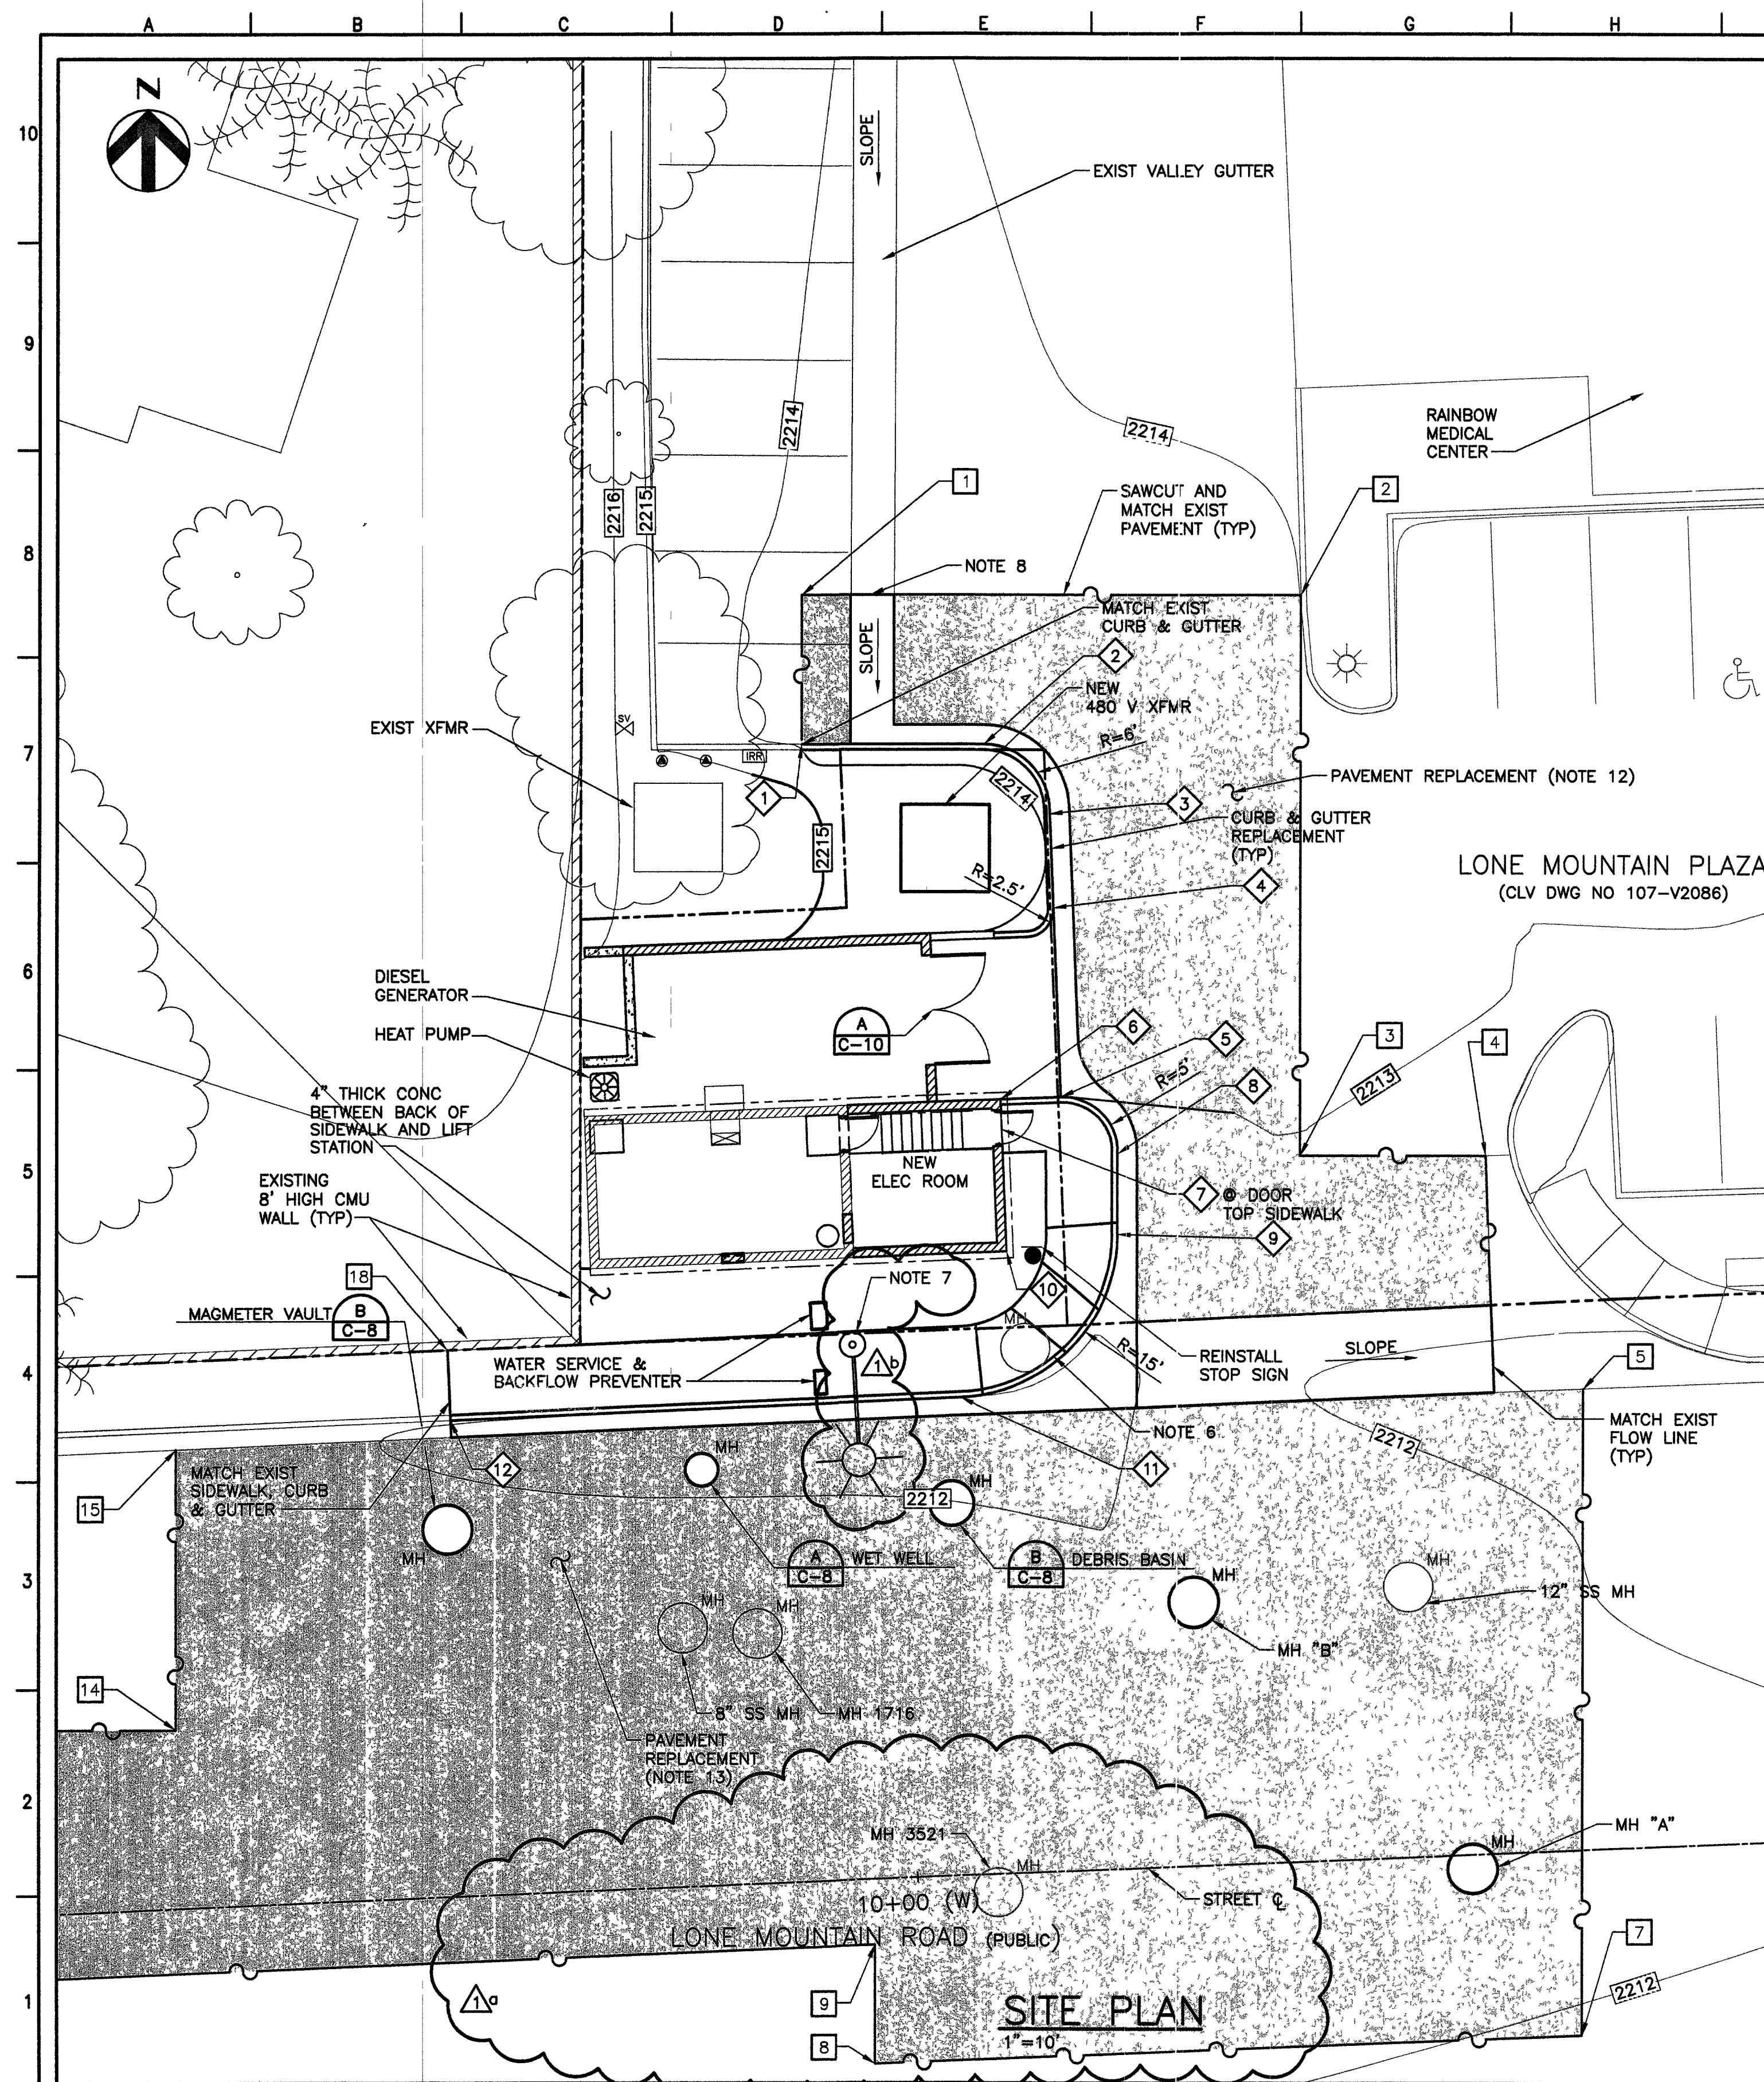

	TC	FL
1	2214.30±	2213.80±
2	2214.00	2213.50
3	2213.83	2213.33
4	2213.75	2213.25
5	2213.50	2213.00
6	2213.83	2213.33
7	2213.83	2213.33
8	2213.25	2212.75
9	2213.00	2212.50
10	2213.33	
11	2212.45	2211.95
12	2212.50±	2212.00±

COORDINATE CONTROL DATA

	N	E
1	26796774.83	766411.51
2	26796774.83	766457.13
3	26796723.48	766457.14
4	26796723.48	766474.06
5	26796702.03	766483.01
6	DELETED	
7	26796643.01	766483.01
8	26796640.34	766418.38
9	26796651.18	766463.01
10	DELETED	
11	DELETED	
12	DELETED	
13	DELETED	
14	26796670.92	766354.65
15	26796696.45	766354.65
16	DELETED	
17	DELETED	
18	26796705.59	766379.37

NOTES:


- CONTRACTOR SHALL REPLACE ANY DAMAGED PAVEMENT IN STAGING AREA AND TEMPORARY CONSTRUCTION EASEMENT.
- CONTRACTOR SHALL REPAINT ALL PAVEMENT MARKINGS IN STAGING AREA AND TEMPORARY CONSTRUCTION EASEMENT.
- CONTRACTOR SHALL MAINTAIN ACCESS THROUGH TEMPORARY CONSTRUCTION EASEMENT.
- FINAL LOCATION OF NEW XFMR TO BE DETERMINED BY NEVADA POWER COMPANY. REFER TO DWG E-4 FOR DETAILS.
- COORDINATE CONTROL SURVEY TIES REFERENCED ON DWG G-7.
- REPLACE SIDEWALK RAMP IN KIND WITH ELEC MH COVER PER USD NO 235, CASE 1.
- REMOVE AND REINSTALL STREET LIGHT FOR INSTALLATION OF LIFT STATION PIPING, WETWELL AND OTHER APPURTENANCES. INSTALL PER USD NOS 320 & 321. INSTALL CONDUITS AND WIRING AS REQUIRED. PROVIDE TEMPORARY LIGHTING IN ACCORDANCE WITH USS 623 G.03.01
- INSTALL 4' VALLEY GUTTER WITH 1 1/2" TO FLOW LINE SIMILAR TO . MATCH EXIST FLOW LINES.
- INSTALL SIDEWALK PER USD DWG NO 234.
- INSTALL "L" CURB & GUTTER PER USD DWG NO 216.
- INSTALL "A" CURB PER USD DWG NO 219.
- INSTALL ON-SITE PAVEMENT 2" ACC MIN OVER RECOMPACTED BASE, EXCEPT AS SHOWN IN TRENCH SECTION.
- INSTALL ROAD PAVEMENT PATCHING 4" ACC MIN OVER RECOMPACTED BASE, EXCEPT AS SHOWN IN TRENCH SECTION.

Call
before you
Dig
1-800-227-2600


Call
before you
OVERHEAD
1-702-593-6111

VERIFY SCALES
BAR IS ONE INCH ON
ORIGINAL DRAWING
0 1"
IF NOT ONE INCH ON
THIS SHEET, ADJUST
SCALES ACCORDINGLY

REV NO.	REVISION DESCRIPTION	DATE	DRAWN	CHECKED
1	RECORD DRAWING	3/2007	WRH	BDH

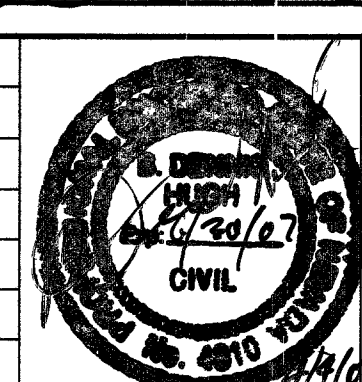

City of Las Vegas
DEPARTMENT OF PUBLIC WORKS

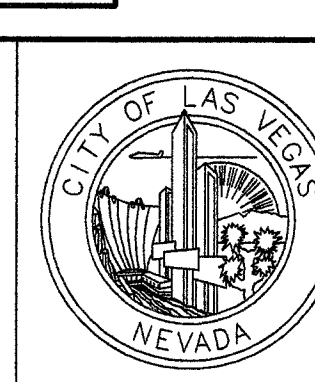

Environmental Division
LONE MOUNTAIN SEWER LIFT STATION MODIFICATIONS
DURANGO HILLS WATER RESOURCE CENTER MISC IMPROVEMENTS
SUPERSEDES DWG NO.
DESIGNED BY: T. RIDDIOUGH
DRAWN BY: A. EVANS
CHECKED BY: R. RASH

LONE MOUNTAIN SEWER LIFT STATION
GRADING PLAN
As-Built
SCALE: 1"=10'
DRAWING NO. C-2
SHEET NO. 10 of 46