


FILE NAME: 92102IMP.dwg
VIEW NAME: 401

NOTE:
ALL INTERIOR STREETS ARE PRIVATE DRIVES. PRIVATE DRIVES ARE PUBLIC UTILITY EASEMENTS, CLV PUBLIC SEWER EASEMENTS AND PUBLIC DRAINAGE EASEMENTS TO BE PRIVATELY MAINTAINED.

3357d 34339

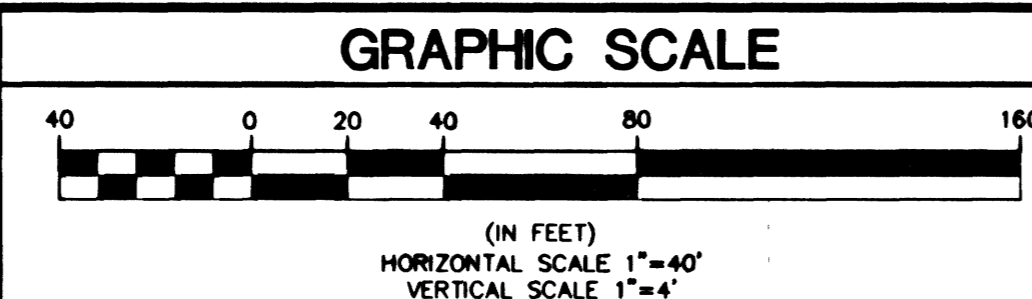

BENCHMARK
CITY OF LAS VEGAS BENCHMARK No. 5 STATION 1LV90-16NWS
USC AND GS BM # U169,
764.7181 METERS (NAVD 88)
764.7181 x (3937/1200) = 2508.913 FEET (NAVD 88)


MATCHLINE SEE SHEET 301



LEGEND

EXISTING STREET LIGHT	
NEW STREET LIGHT (UNLESS NOTED AS EXISTING)	
TRAFFIC SIGNAL W/ STREET LIGHT	
SERVICE POINT AND ROCC	
PHOTO EYE	
ELECTRICAL PEDESTAL	
PULL BOX AS SHOWN	
GATE VALVE	
EXISTING FIRE HYDRANT	
NEW FIRE HYDRANT (UNLESS NOTED AS EXISTING)	
BACKWATER VALVE	
SEWER MANHOLE	
EXISTING SEWER MANHOLE	
STORM DRAIN MANHOLE	
SEWER AND WATER SERVICE	
STREET NAME SIGN	
STOP SIGN	
FUTURE IMPROVEMENTS	
EX. IMPROVEMENTS	
UNIT LINE	
SEWER	
WATER	
3" INTERCONNECT CONDUIT	
1 1/4" STREET LIGHT CONDUIT	

- CONSTRUCTION NOTES**
- 8" WATER WITH 12" DUCTILE IRON PIPE
 - 8" GATE VALVE
 - 8" TEE
 - 8" CROSS
 - 8" 90°
 - STD. F.H. ASSY. W/ 8"-8" 45° TEE, 6" GV AND LATERAL PER UDACS PLATE #7
 - CAP & 2" BLOWOFF VALVE PER UDACS PLATE #4
 - 2 - 4" IRRIGATION CONDUITS
 - 12"x12" 45° MECHANICAL TAPPING TEE AND 2" TAPPING GATE VALVE
 - 8" GATE VALVE, 10 LF 8" PVC W, 2" BLOWOFF AND CAP CONNECT TO EXIST UTILITY
 - 5/8" WATER METER W/ 1" SERVICE PER UDACS PLATE 18
 - EDGE OF ROAD MARKER (W-8(L))
 - STOP SIGN (MUTCD R1-1)
 - 4" WHITE COLD POLYMER EDGE LINE
 - STREET NAME SIGN (MUTCD D3)
 - 25 MPH SPEED LIMIT SIGN (MUTCD R2)
 - 4" SOLID YELLOW CL. (MUTCD 3A-7 #6)
 - 4" BROKEN YELLOW SINGLE CL. (MUTCD 3A-7 #2)
 - PAINT FIRE LANE CURB RED
 - NO PARKING SIGN (MUTCD R7-1)

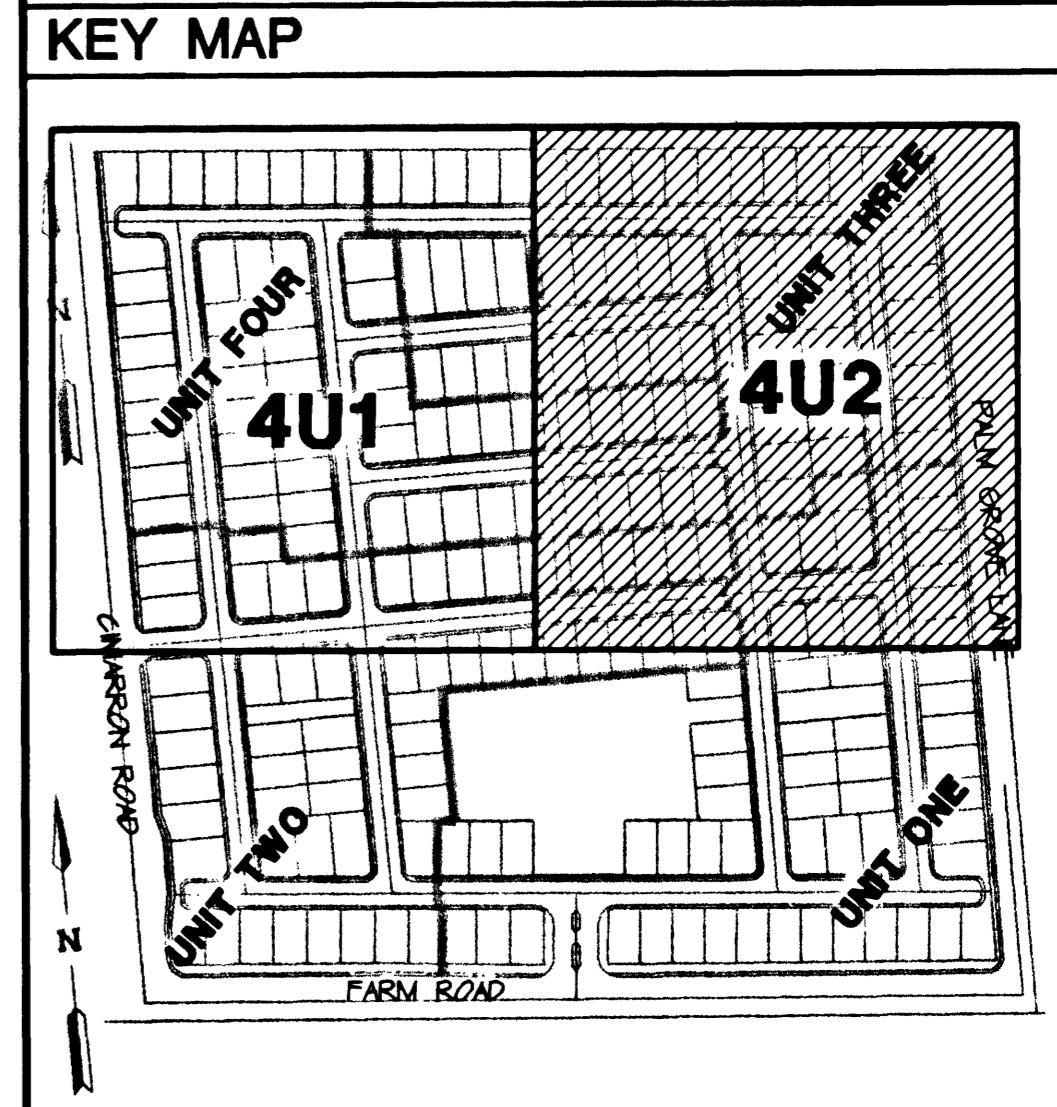

APPROVAL BLOCK

	7.6.01	DATE
	8/7/01	DATE
	7.9.01	DATE
	7.9.01	DATE
	07.06.01	DATE

NOTICE!

EXISTING UTILITIES ARE SHOWN ON PLANS FOR THE CONVENIENCE OF THE CONTRACTOR ONLY. THE CONTRACTOR IS RESPONSIBLE FOR THE PROTECTION OF ALL UTILITIES. THE ENGINEER BEARS NO RESPONSIBILITY FOR UTILITIES NOT SHOWN OR SHOWN INCORRECTLY.

Call BEFORE YOU Dig

1-800-227-2600
UNDERGROUND SERVICE (USA)

<p>CARINA CORPORATION 2880 BUSINESS PARK COURT, SUITE 210 LAS VEGAS, NEVADA 89128 (702) 228-6376</p>	<p>ENGINEERING COMPANY 50 So. Jones #202, Las Vegas, NV 89107 Telephone: (702) 877-1560</p>	<p>SHEET 402</p>
		<p>7 OF 17 SHEETS</p>
<p>UTILITY PLAN EAST</p>	<p>LAMPLIGHT VILLAGE AT CENTENNIAL SPRINGS</p>	<p>PROJECT NO: 5211-02</p>
<p>DRAWN BY: 07.05.01</p>	<p>DESIGNED BY: 07.05.01</p>	<p>CHECKED BY: 07.05.01</p>
<p>SCALE: 1"=40'</p>	<p>DATE: 07.06.01</p>	<p>DATE: 07.06.01</p>