


TEST HOLE DATA

TEST HOLE NUMBER	ELEVATIONS		UTILITY
	DEPTH (FT)	TOP/INV	
1	5.40	(2344.61 TOP)	1" GAS
2	4.46	(2343.73 TOP)	4" GAS
3	3.25	(2343.82 TOP)	4"/6" ELEC
4	4.28	(2342.77 TOP)	4" ELEC
5	4.28	(2341.91 TOP)	6" GAS
6	6.08	(2340.58 TOP)	4" GAS

MATCH LINE "ER" 19+00.00
SEE SHEET SS-1

MATCH LINE "ER" 29+00.00
SEE SHEET SS-3

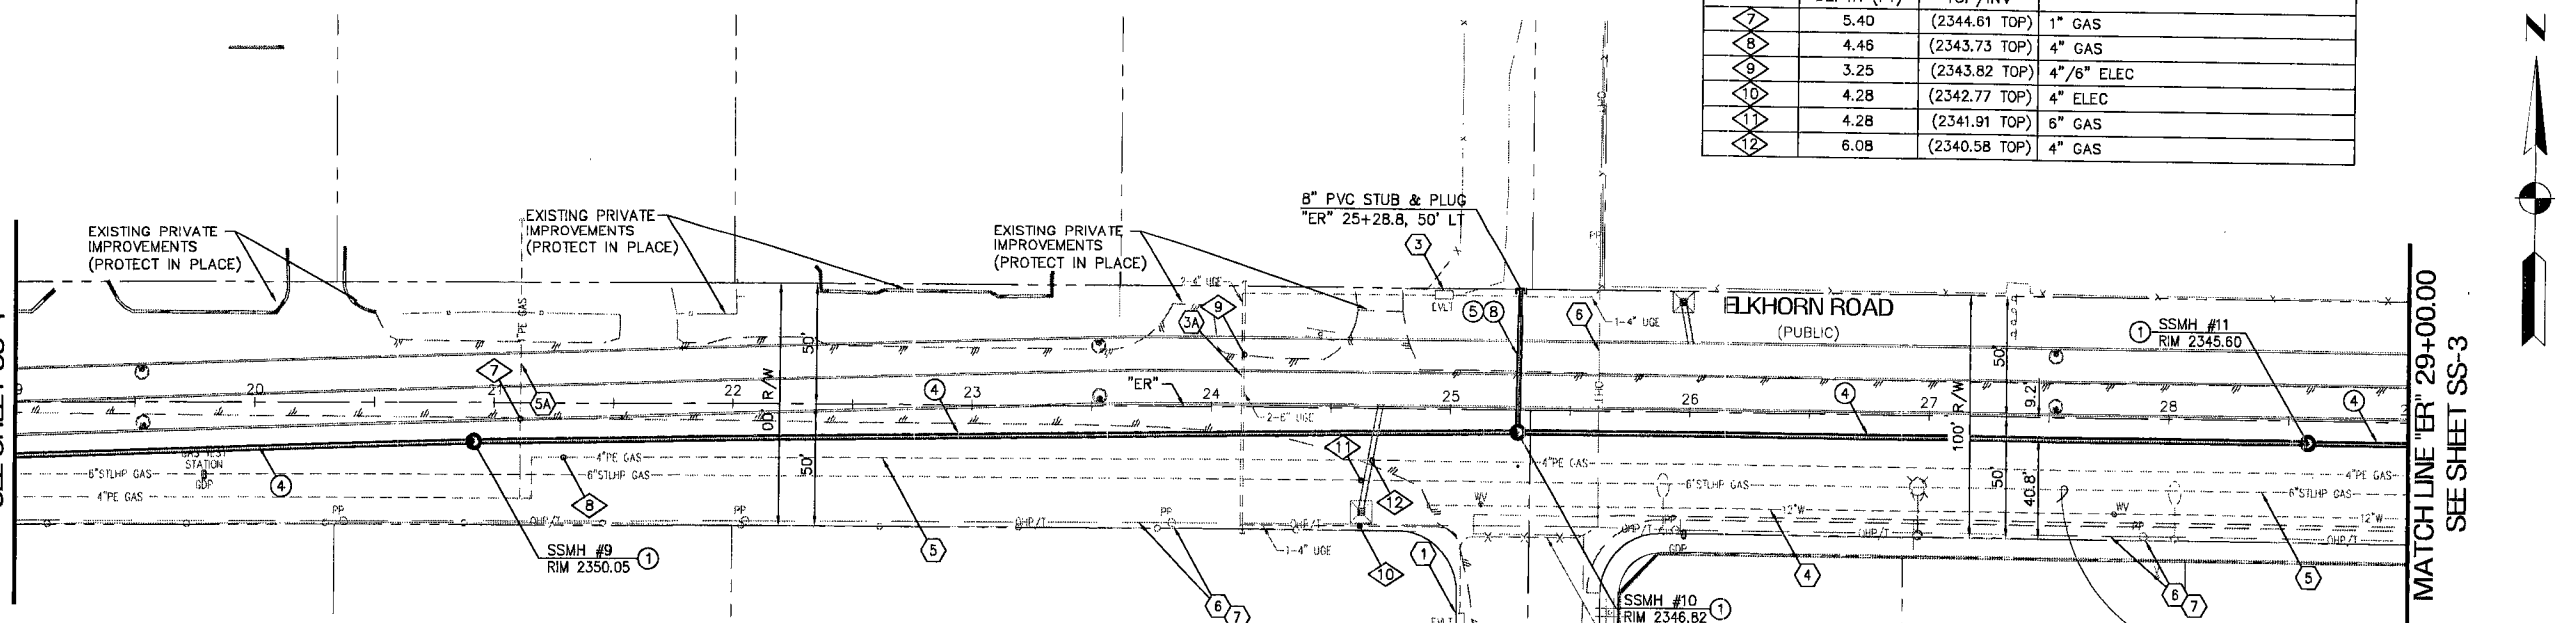

CONSTRUCTION NOTES:

- "ER" 20+91.50, 16.00' RT
"ER" 25+28.00, 9.18' RT
"ER" 28+58.12, 9.18' RT
CONSTRUCT 60" SSMH PER DCSWCS STD DWG SD-1.
- "ER" 19+00.00, 21.00' RT TO
"ER" 29+00.00, 9.18' RT
CONSTRUCT 18" PVC (C-905) SANITARY SEWER PER DCSWCS.
- "ER" 25+28.00, 9.18' RT TO
"ER" 25+28.81, 50.00' LT
CONSTRUCT 8" PVC (SDR 35) SANITARY SEWER PER DCSWCS. (SEE LATERAL "A", SHEET SS-B)
- "ER" 25+28.00, 9.18' RT TO
"ER" 25+28.66, 39.00' LT
CONSTRUCT 4" CEMENT SLURRY CAP OVER 8" SS PER DCSWCS SD-20.

UTILITY NOTES:

 
- UNDERGROUND TELEPHONE TO REMAIN.
- UNDERGROUND ELECTRIC TO REMAIN.
- UNDERGROUND ELECTRIC TO BE RELOCATED BY NEVADA POWER COMPANY.
- EXISTING WATER TO REMAIN.
- EXISTING GAS TO REMAIN.
- EXISTING GAS TO BE RELOCATED BY OTHERS.
- EXISTING POLES AND AERIAL FACILITIES TO REMAIN.
- EXISTING AERIAL CATV TO REMAIN.

NOTE:
SEE PP-2 FOR PROPOSED RCB'S

APPROVED FOR CONSTRUCTION
LAS VEGAS VALLEY WATER DISTRICT
PROJECT #113703
DATE 10/19/07

CAUTION:
HIGH PRESSURE GAS LINE. CONTRACTOR TO CALL SOUTHWEST GAS AT 365-2296 FOR STANDBY WHEN EXCAVATING OVER OR NEAR HIGH PRESSURE GAS.

CAUTION:
CONTRACTOR TO VERIFY ALL EXISTING UNDERGROUND UTILITY LOCATIONS AND ELEVATIONS PRIOR TO CONSTRUCTION.




Call before you dig
1-800-227-2600
1-702-455-7511

Call before you dig
1-800-227-2600
1-702-455-7511

SAFETY ALERT
Call before you dig
OVERHEAD
1-702-593-6111

MATCH LINE "ER" 19+00.00
SEE SHEET SS-1


MATCH LINE "ER" 29+00.00
SEE SHEET SS-3

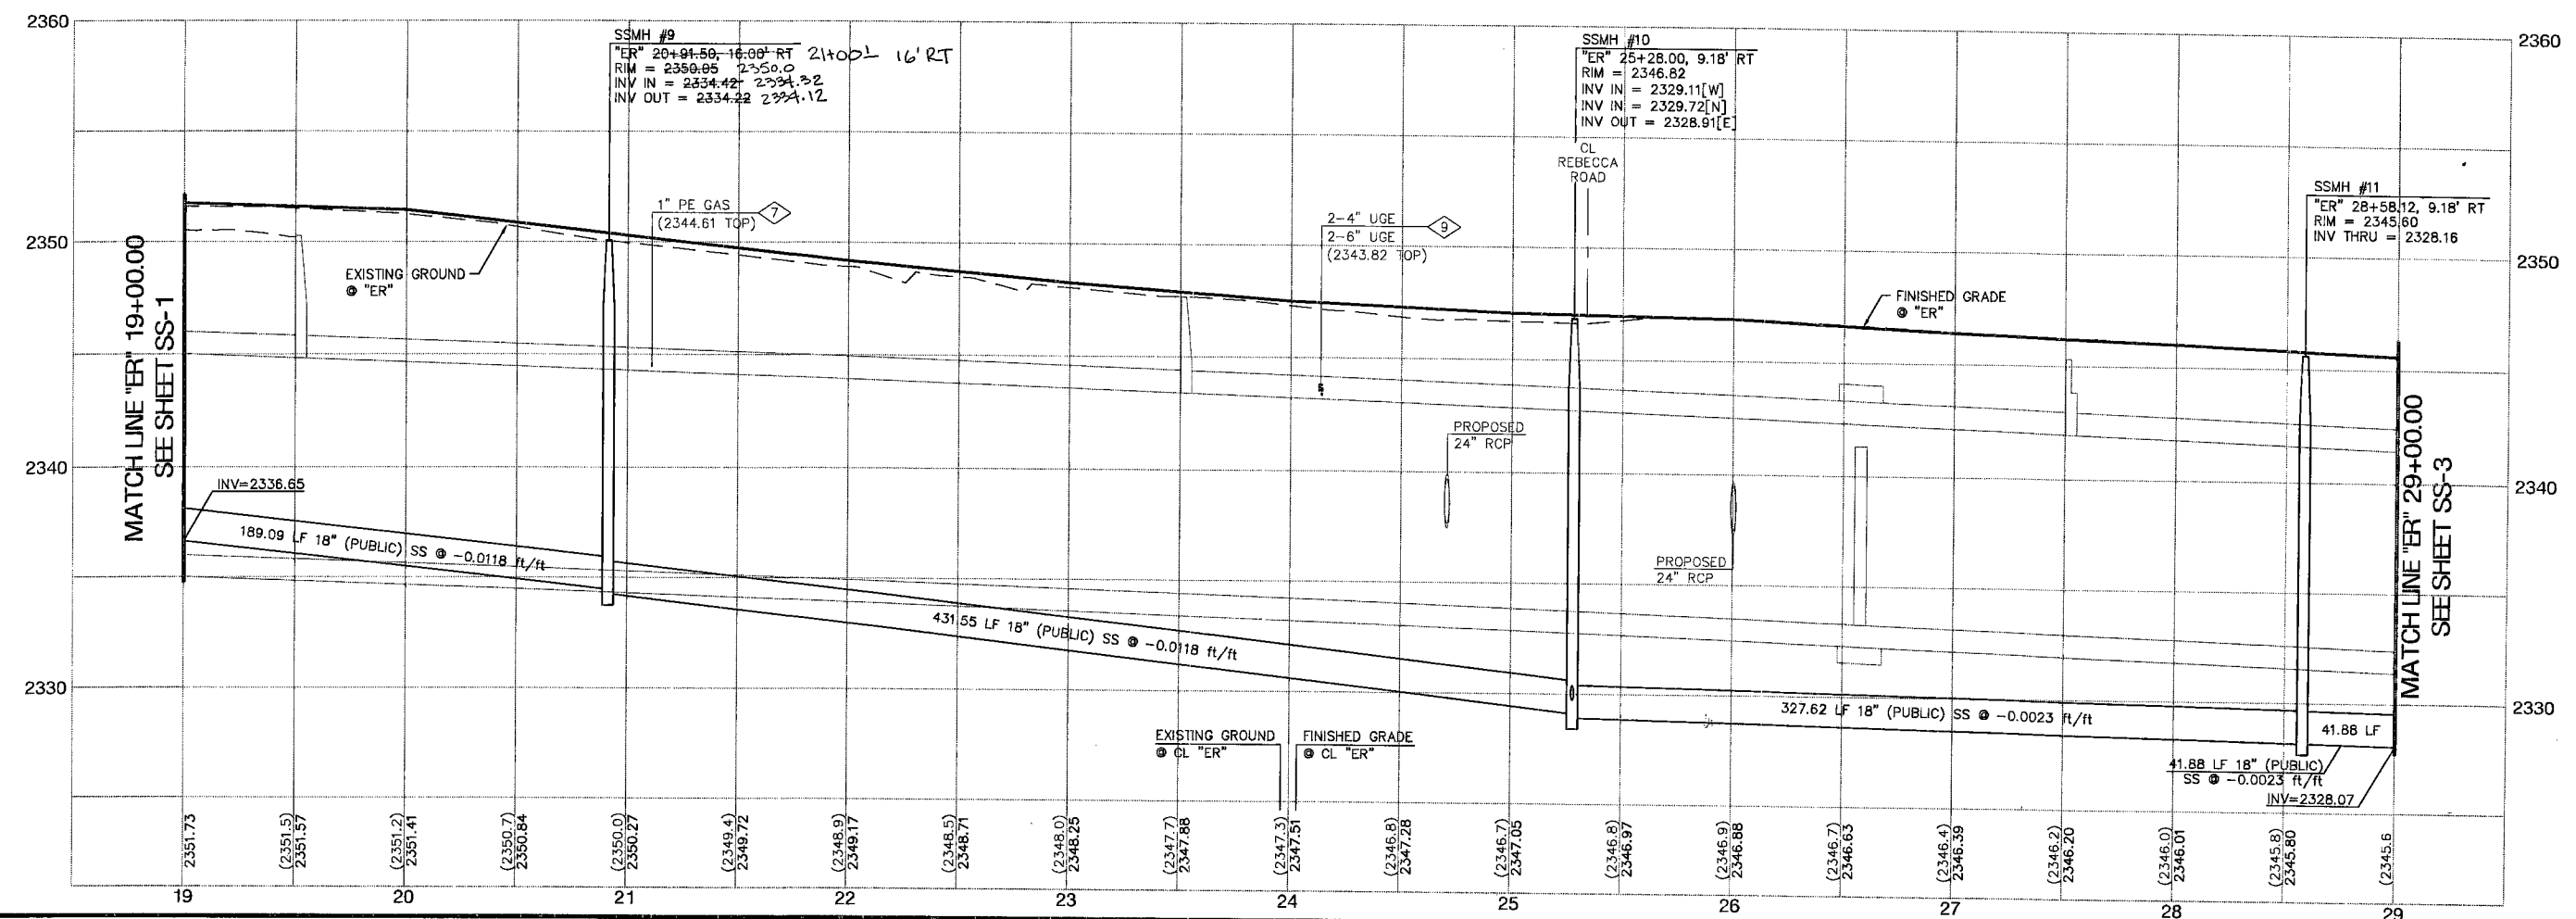

DEPARTMENT OF PUBLIC WORKS

PROJECT:
LAS VEGAS WASH MIDDLE BRANCH
ELKHORN STORM DRAIN
RAINBOW BOULEVARD TO
TORREY PINES DRIVE

SHEET:
18" SANITARY SEWER
PLAN AND PROFILE
"ER" 19+00.00 TO "ER" 29+00.00

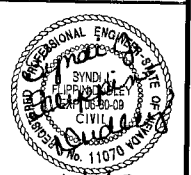

SHEET:
SS-2
CLV DRAWING NO:
327V275

LAS VEGAS WASH - MIDDLE BRANCH ELKHORN STORM DRAIN