


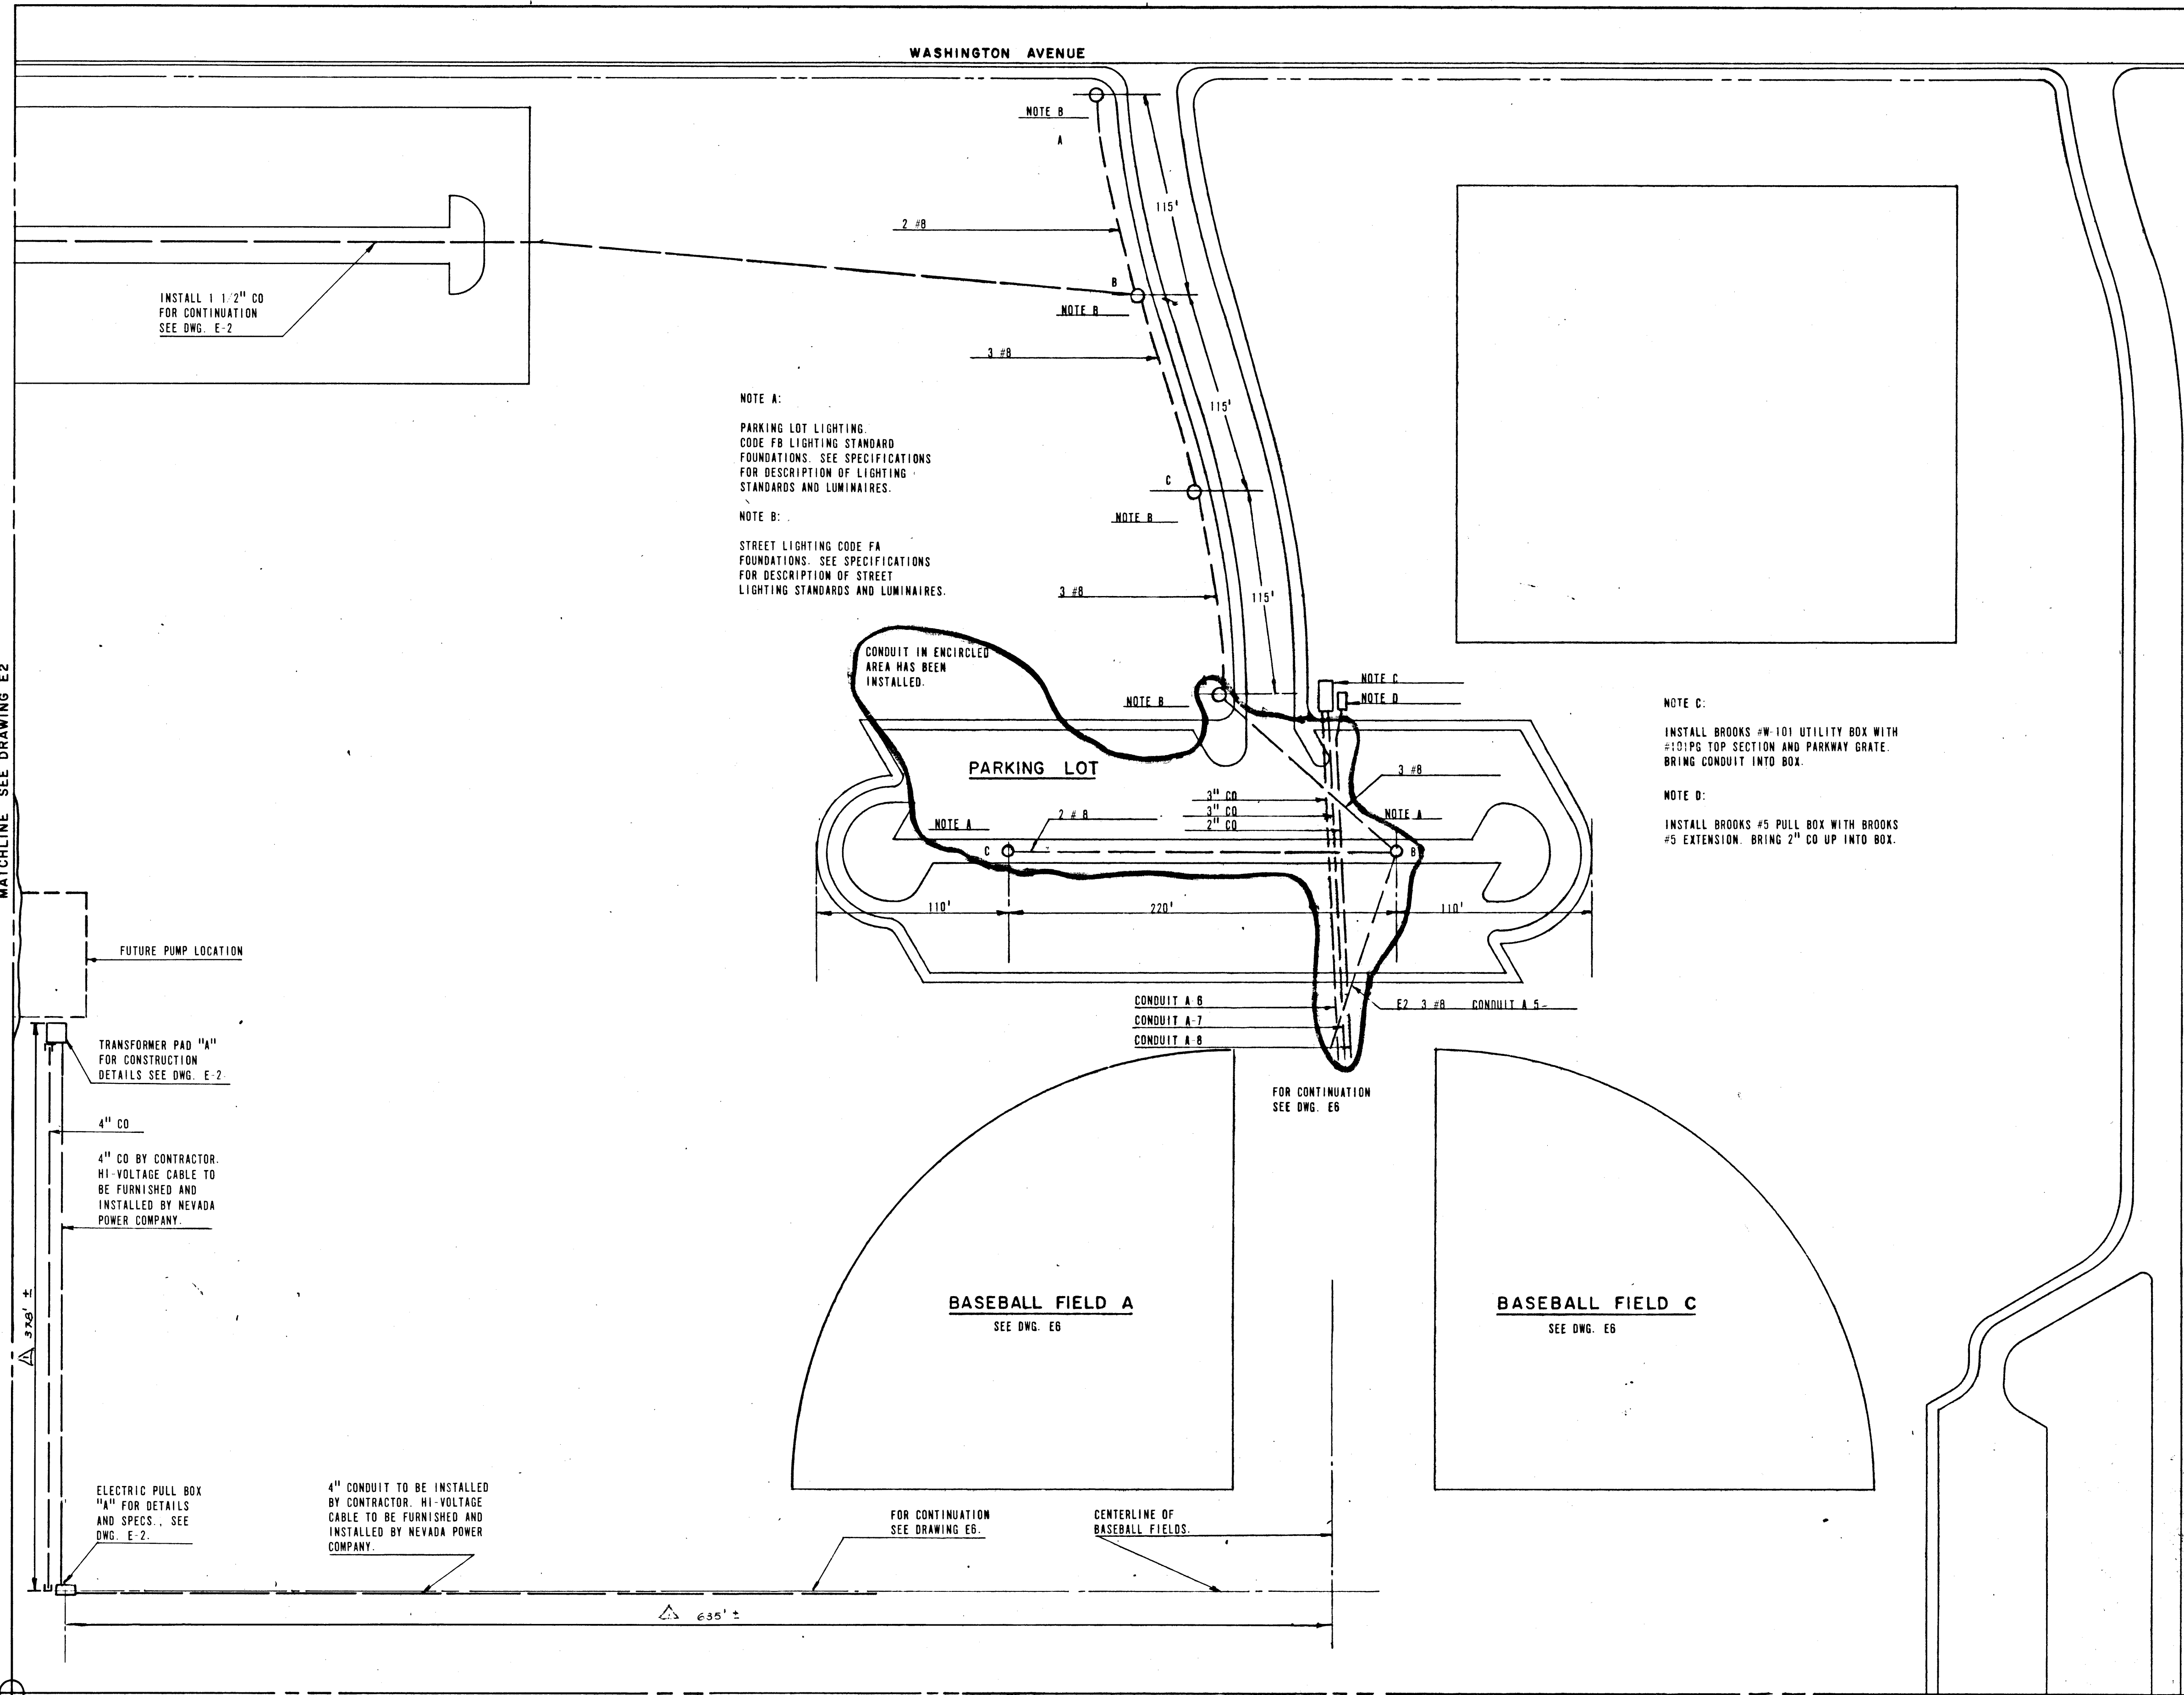

SCALE 1" = 50'-0"



NOTE A:
PARKING LOT LIGHTING.
CODE FB LIGHTING STANDARD
FOUNDATIONS. SEE SPECIFICATIONS
FOR DESCRIPTION OF LIGHTING
STANDARDS AND LUMINAIRES.

NOTE B:
STREET LIGHTING CODE FA
FOUNDATIONS. SEE SPECIFICATIONS
FOR DESCRIPTION OF STREET
LIGHTING STANDARDS AND LUMINAIRES.

NOTE C:
INSTALL BROOKS #W-101 UTILITY BOX WITH
#101PG TOP SECTION AND PARKWAY GRATE.
BRING CONDUIT INTO BOX.

NOTE D:
INSTALL BROOKS #5 PULL BOX WITH BROOKS
#5 EXTENSION. BRING 2" CO UP INTO BOX.

REVISION NO.	DESCRIPTION	BY	DATE	APPROVAL
1	ADD DIMENSIONS	LWZ	7-23-70	<i>[Signature]</i>

CONTRACT
DRAWING
MAY 15 1970

NEV. OSD-7

JOSEPH P. GEDWILL
CONSULTING ENGINEERS
3536 INDUSTRIAL ROAD
LAS VEGAS NEVADA 89103

CITY OF LAS VEGAS NEVADA
DEPARTMENT OF PUBLIC WORKS
SERVICES DIVISION

LORENZI PARK POWER & LIGHTING
PARKING LOT & STREET LIGHTING PLAN

W.D. NO.	FBK. NO.	DATE	DRAWING NO.
SC. (H)	SC. (V)		E3
DES. J. P. GEDWILL			
DR. G. PEREZ		4/14/70	FILE NO.
APPROVED BY DIRECTOR OF PUBLIC WORKS			650.19-13
<i>[Signature]</i>			SHEET 3 OF 9

APPROVED

RT	DIV	DATE
4	D.P.W.	5/12/70
3	SERV.	5/12/70
2	FIELD	5/12/70
	R/W	
	TRAFF.	
	UTIL.	
	SUBD.	
	S/D	
1	ENGR.	<i>[Signature]</i>