
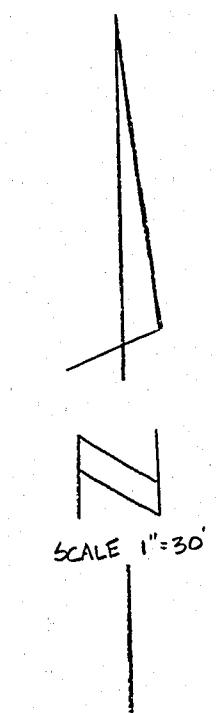


14-13-134

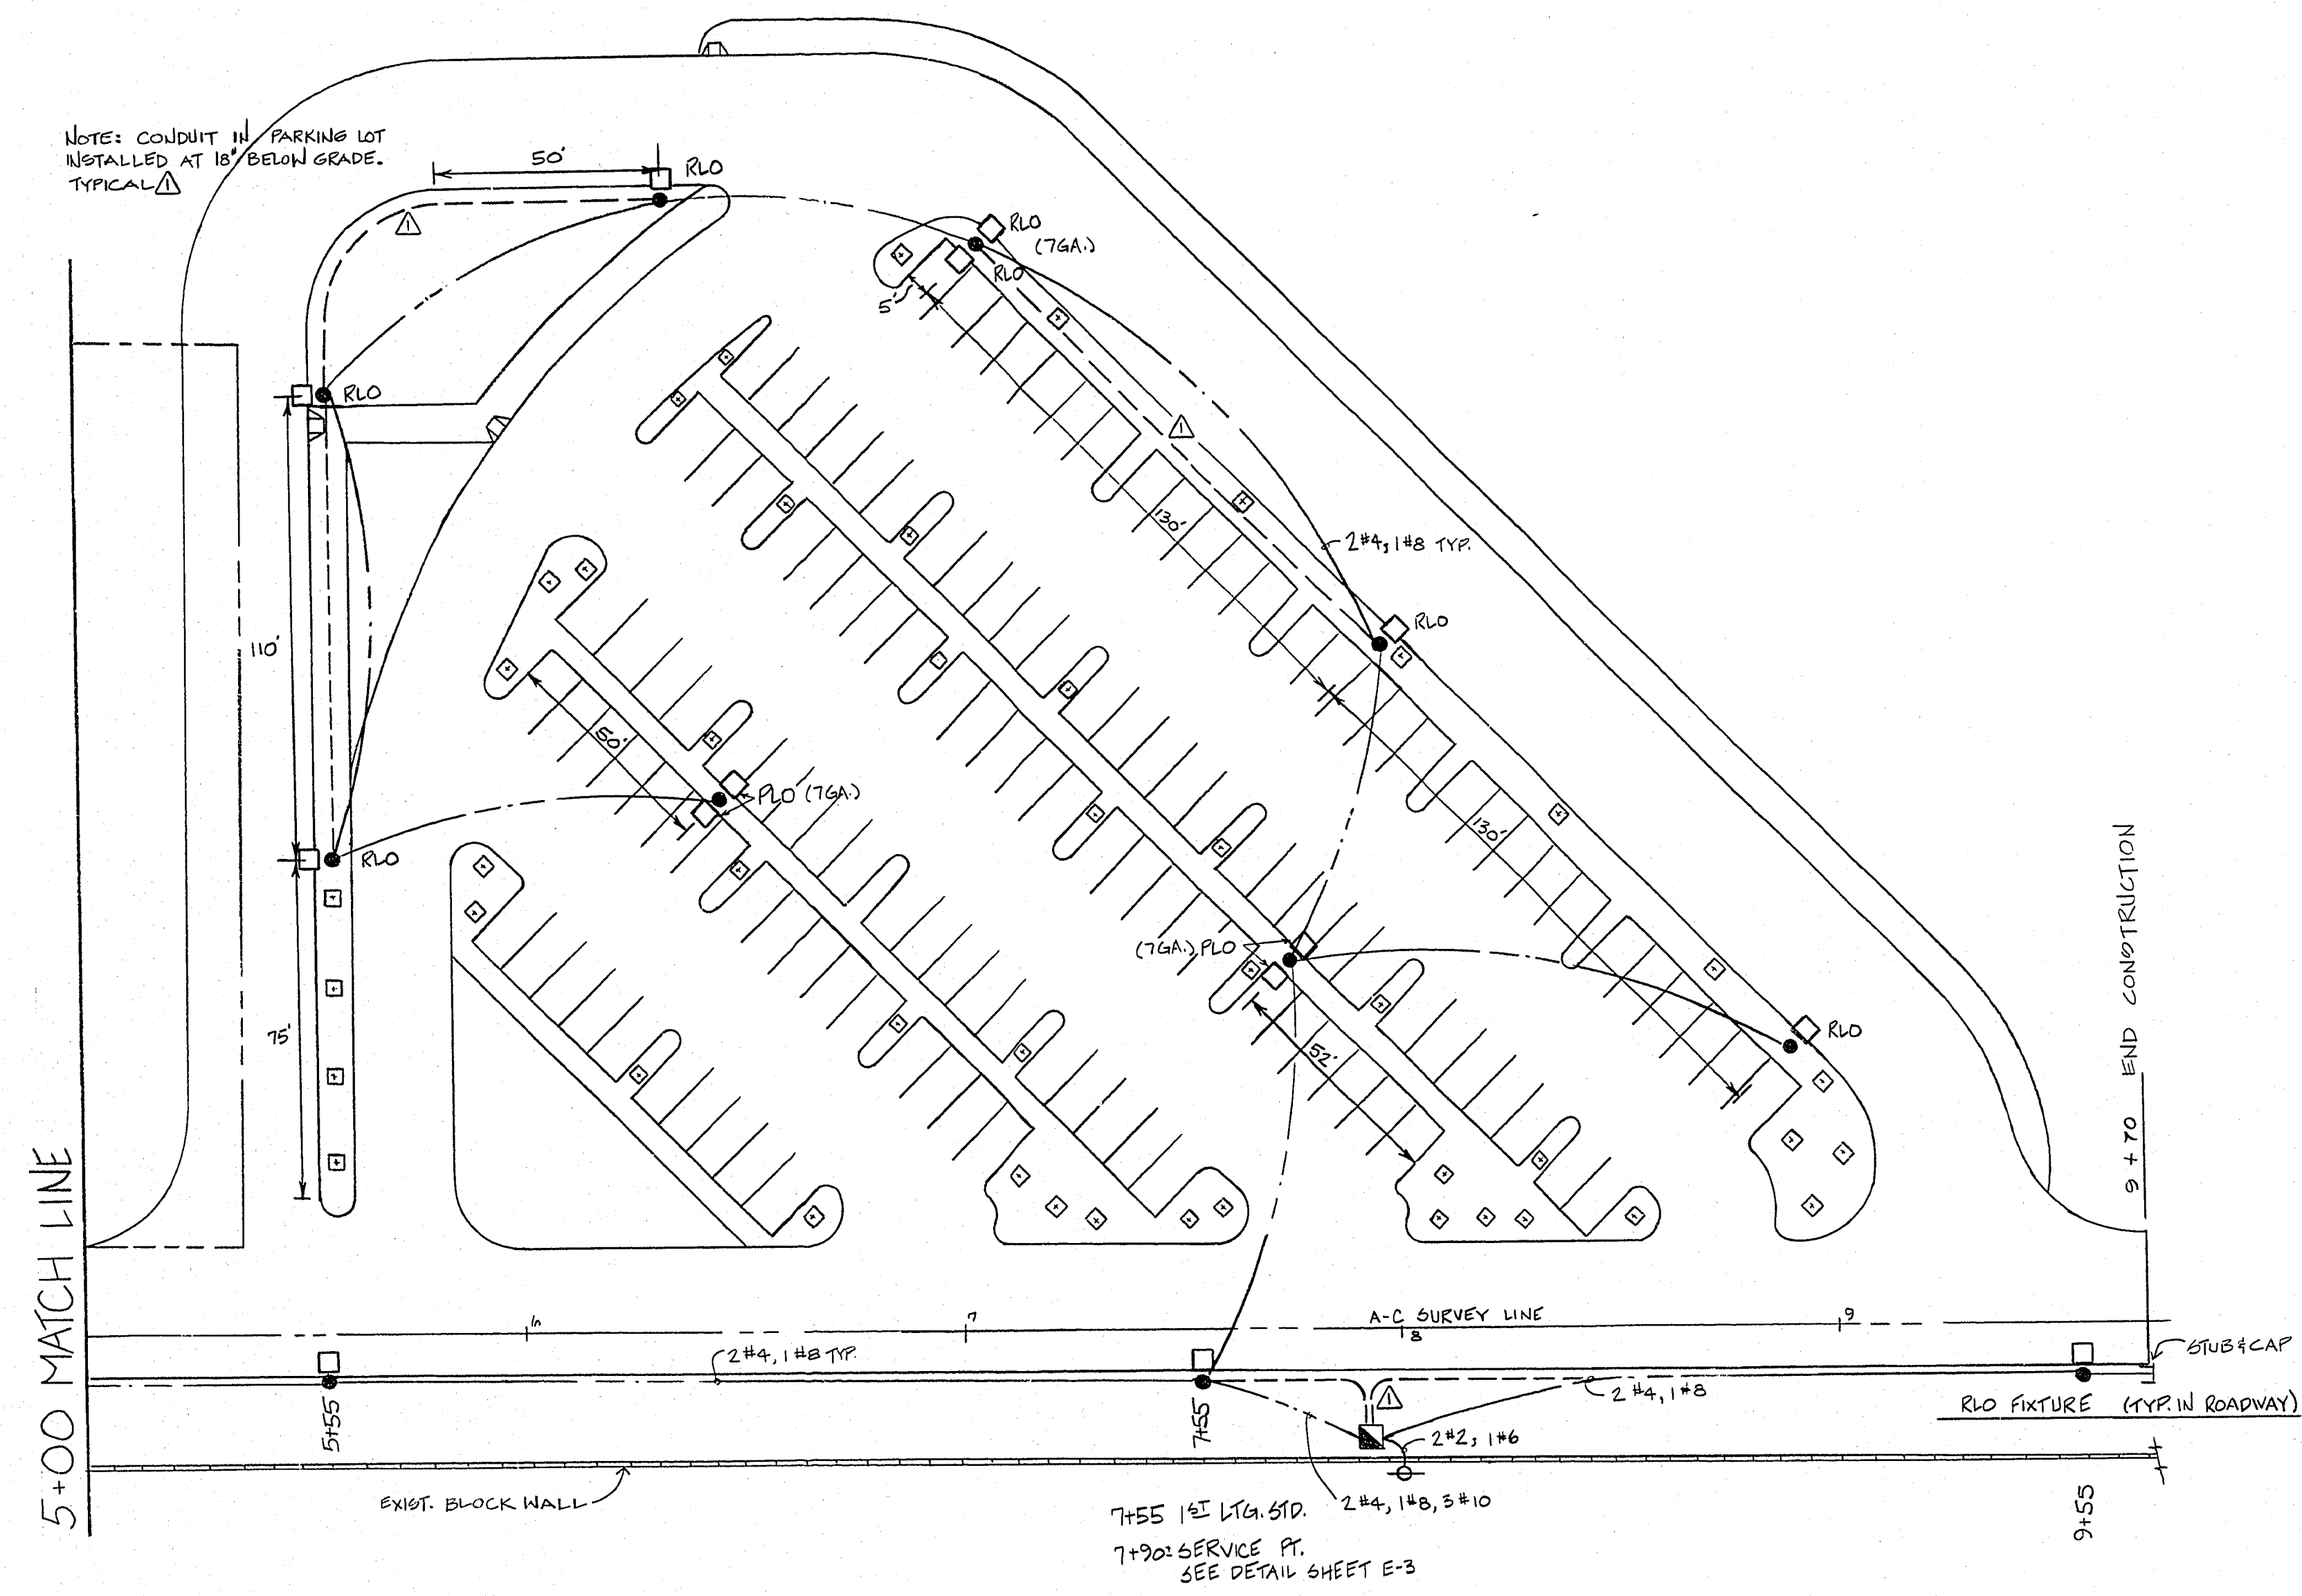

AS BUILT
5-2-83 P.L.L.

CONTRACT
DRAWING
APR 2 1982

EXISTING UTILITIES ARE LOCATED ON THE PLANS FOR THE CONVENIENCE OF THE CONTRACTOR ONLY. THE CONTRACTOR SHALL BEAR FULL RESPONSIBILITY FOR PROTECTION OF UTILITIES AND THE CITY BEARS NO RESPONSIBILITY FOR UTILITIES NOT SHOWN ON THE PLANS OR NOT IN THE LOCATION SHOWN ON THE PLANS.

Department of Public Services		Engineering Design Division		W.A. 2091		Scale (h) 1" = 30'		Scale (v)		Date JUNE 1981		Fid. bk. no.		Design by M. Jones		Drawn by M. Jones		Revisions		Date	
LORENZO PARK STATE MUSEUM PARKING LOT & ROADWAY		ELECTRICAL PLAN																			
Drawing no. 650.19-32		E 2																			