
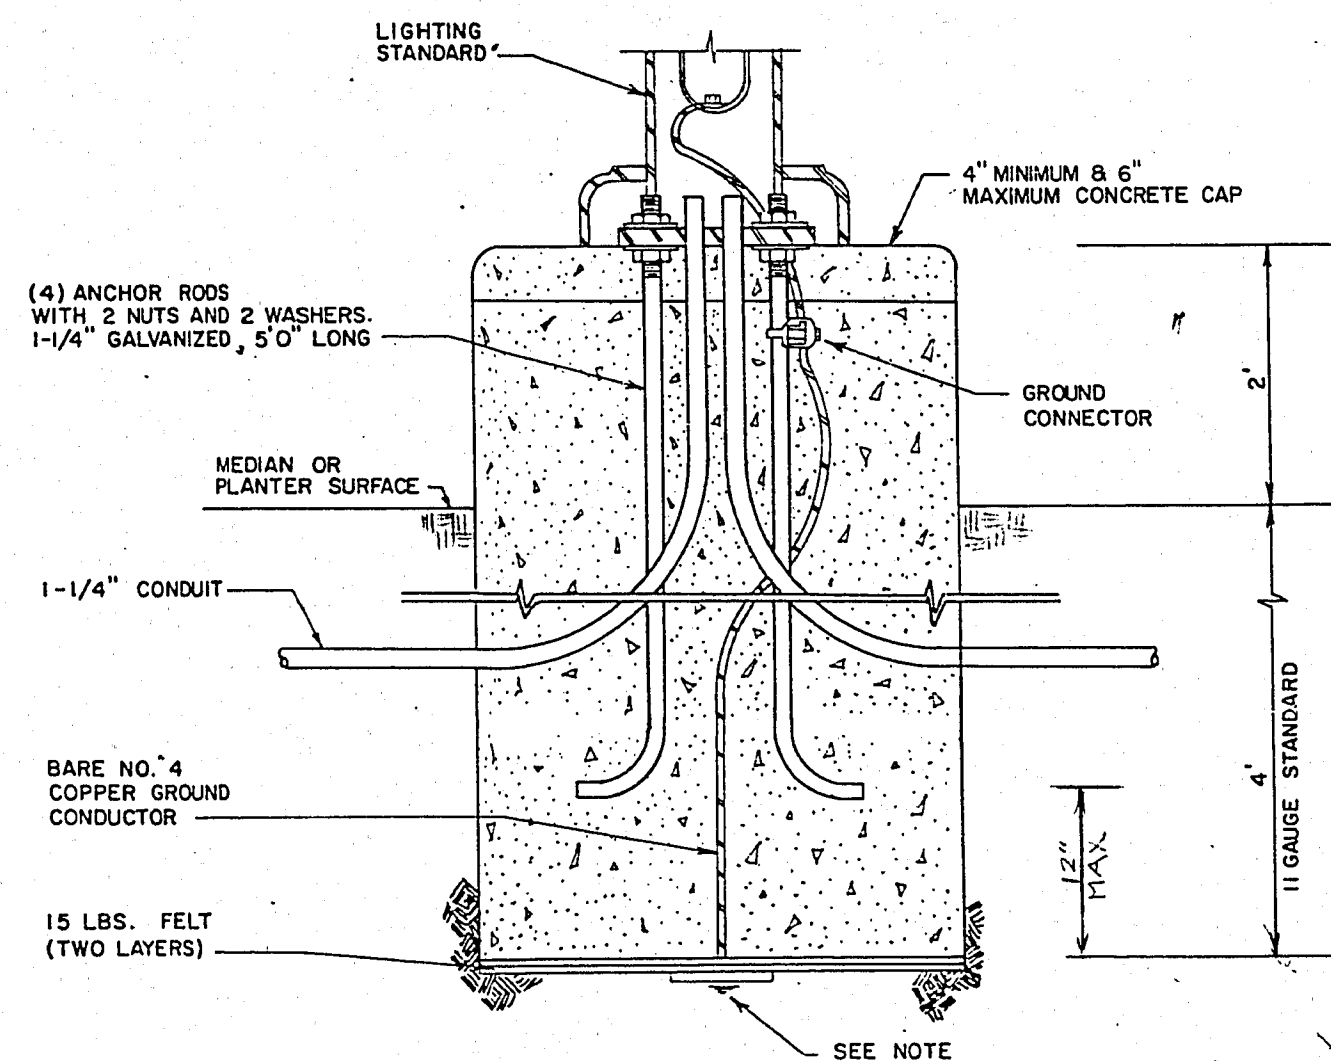


NOTE:
TOP OF FOUNDATION TO
SLOPE DOWN 8 AWAY FROM
THE STANDARD FOR DRAINAGE



MADE ELECTRODE SHALL BE
IN ACCORDANCE WITH ARTICLE
250-83 OF THE NATIONAL
ELECTRICAL CODE AND MUST
BE COPPER OR COPPER PLATED

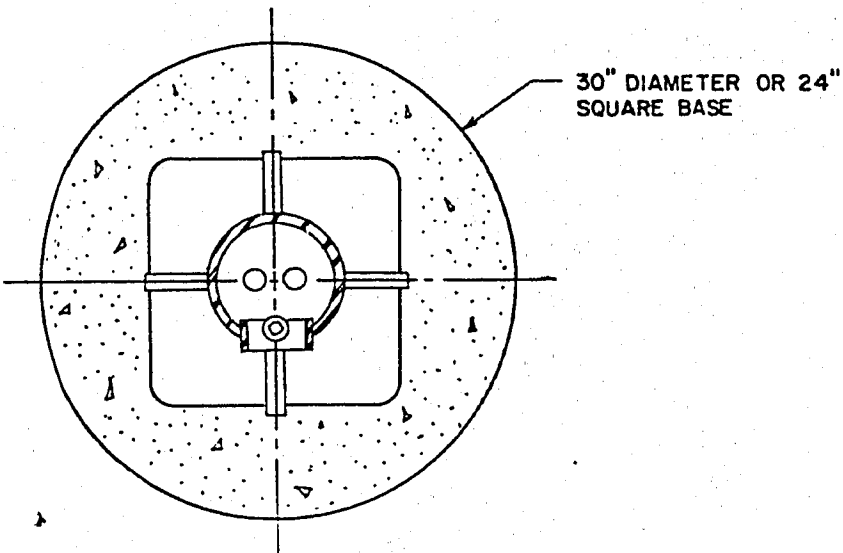


FOUNDATION DETAIL FOR
POLES IN PARKING LOT
NO SCALE

NOTE:
TOP OF FOUNDATION TO
SLOPE DOWN 8 AWAY FROM
THE STANDARD FOR DRAINAGE


MADE ELECTRODE SHALL BE
IN ACCORDANCE WITH
ARTICLE 250-83 OF THE
NATIONAL ELECTRICAL
CODE & MUST BE COPPER
OR COPPER PLATED

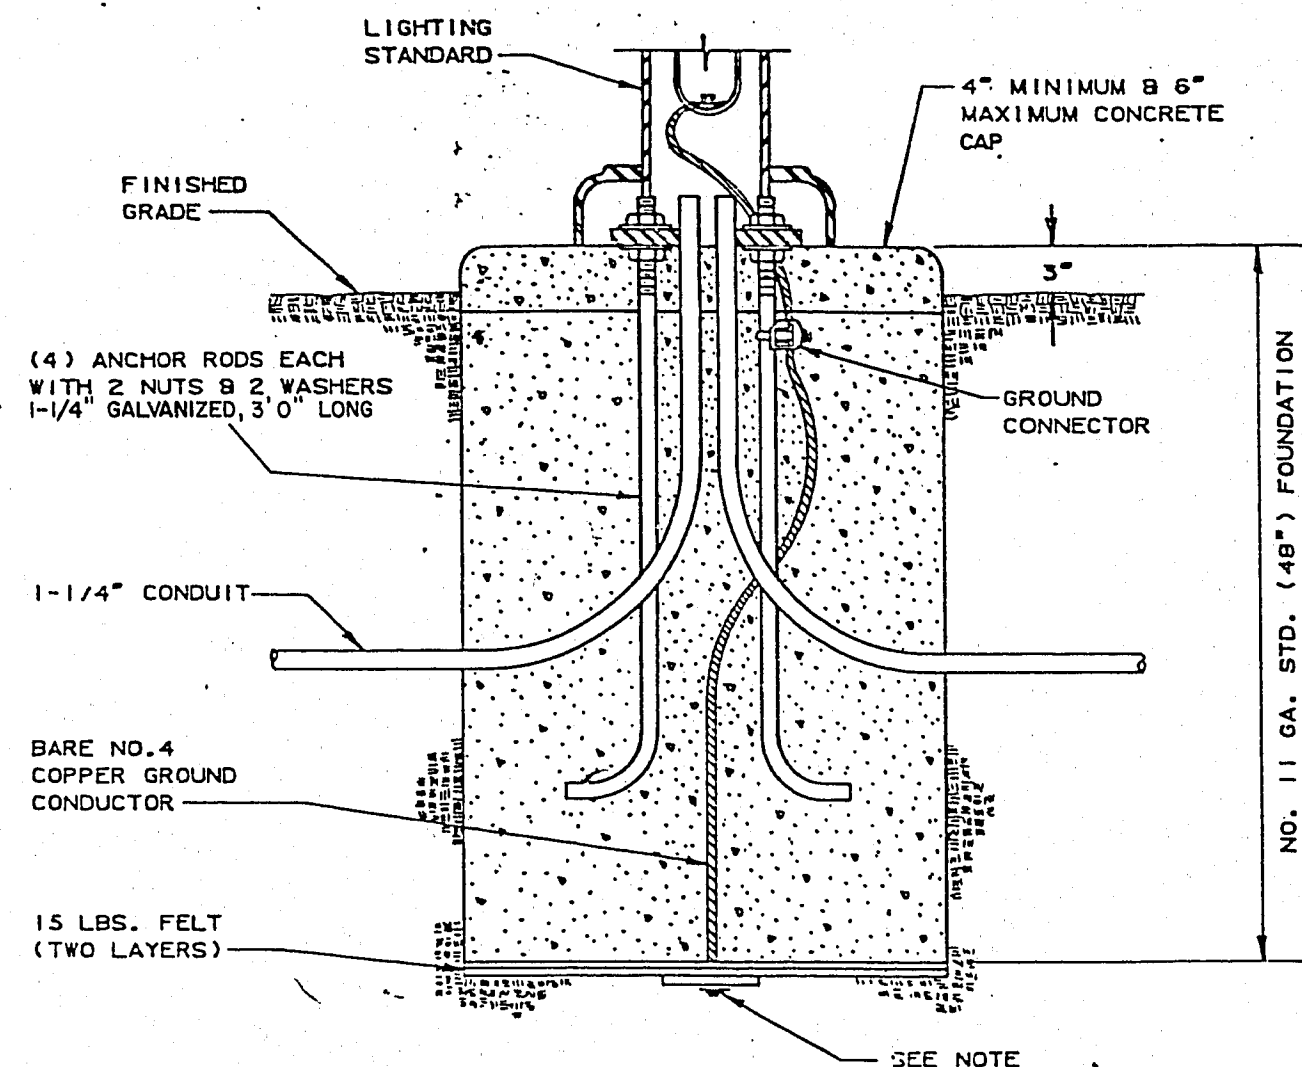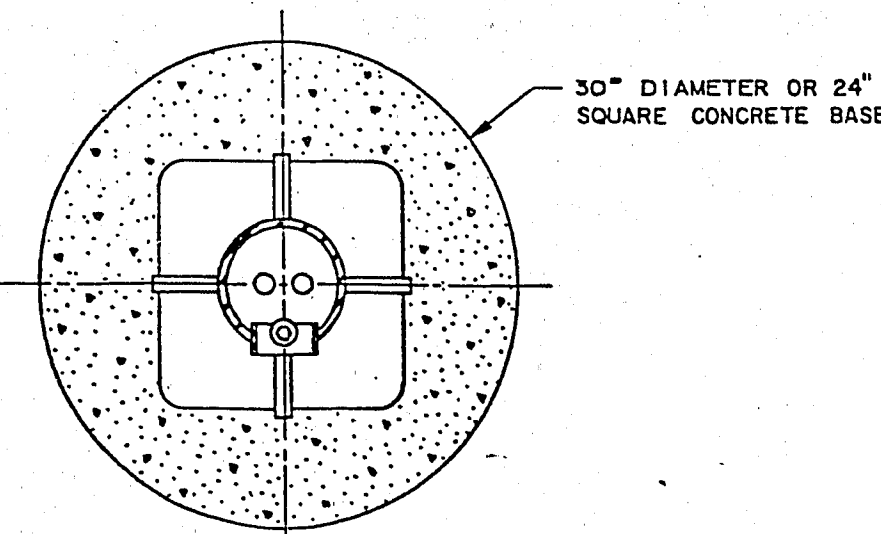


FOUNDATION DETAIL FOR
POLES IN ROADWAY
NO SCALE

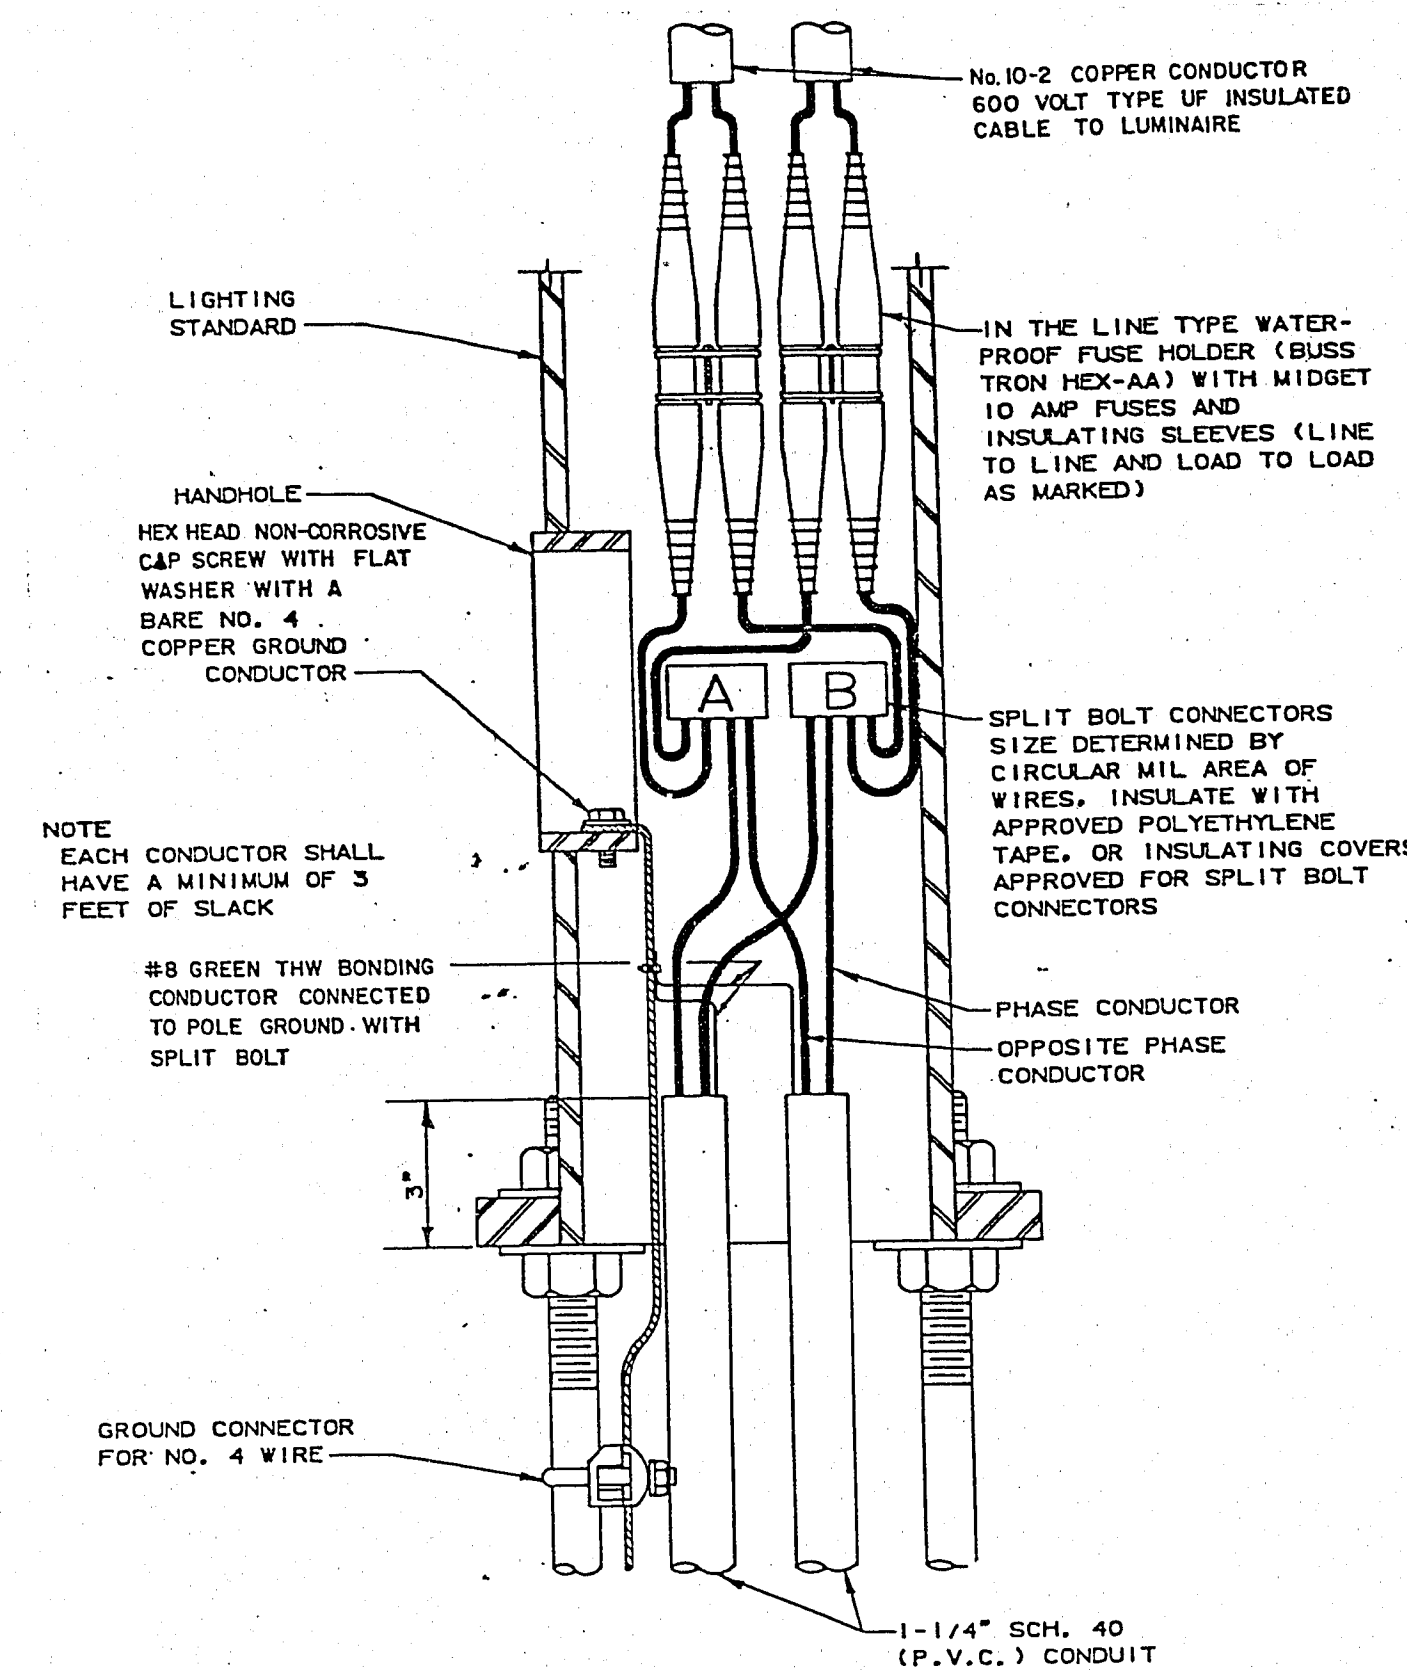


WIRING DIAGRAM FOR
DOUBLE LUMINAIRE
NO SCALE

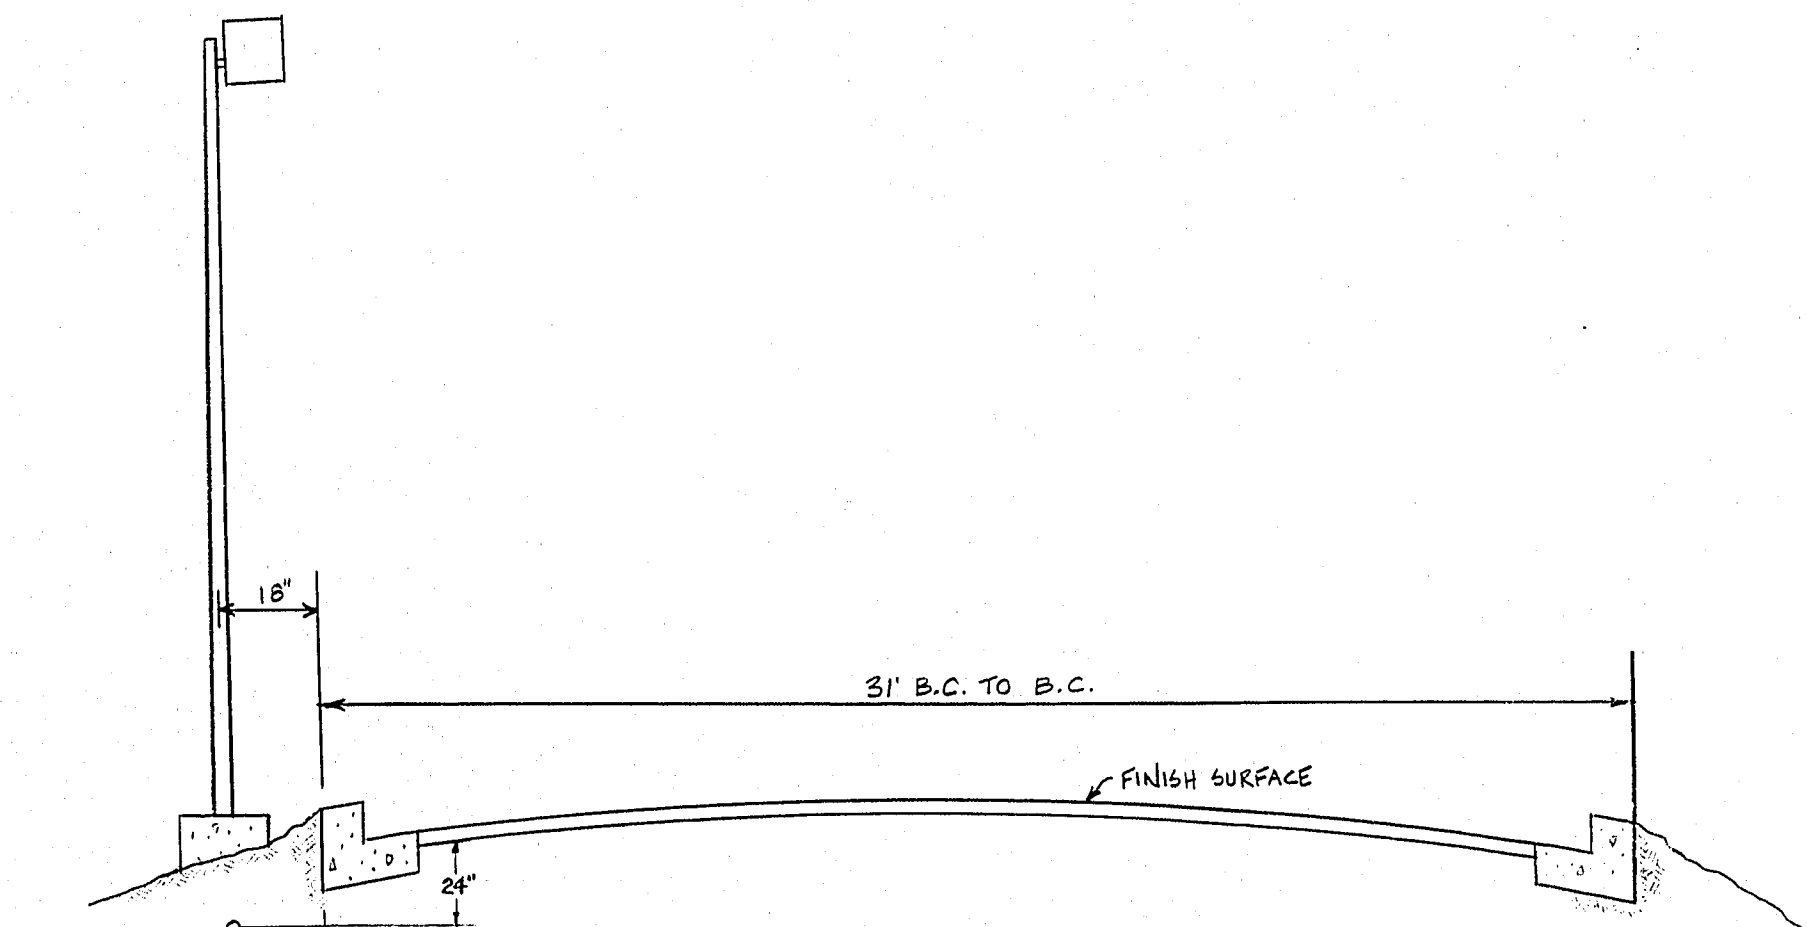


POLE & CONDUIT LOCATIONS FOR
ROADWAY LUMINAIRE
NO SCALE

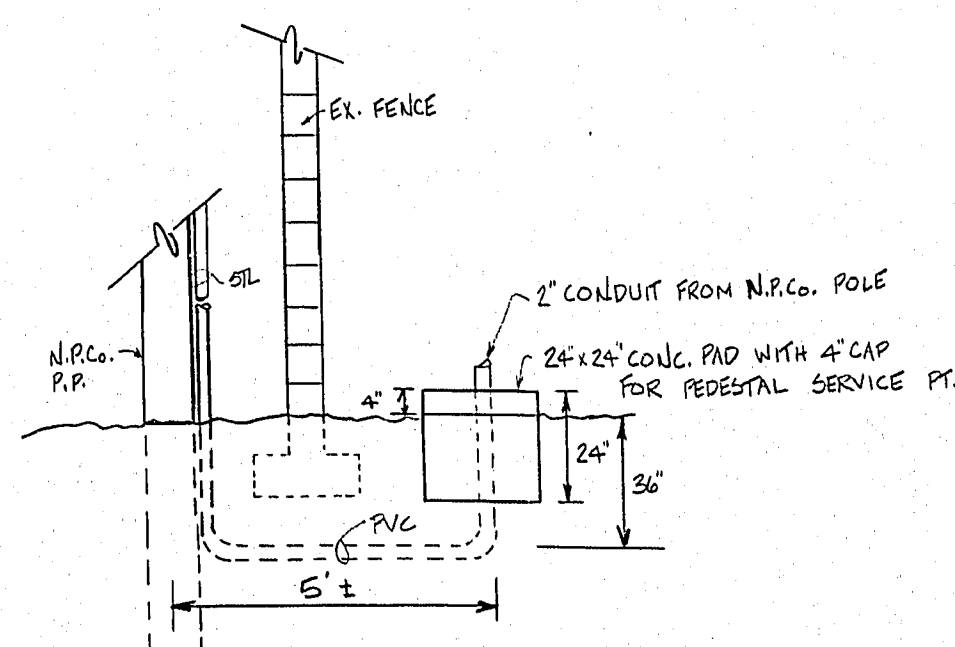

TRENCH DETAIL FROM
SERVICE PIT TO P.P.
NO SCALE

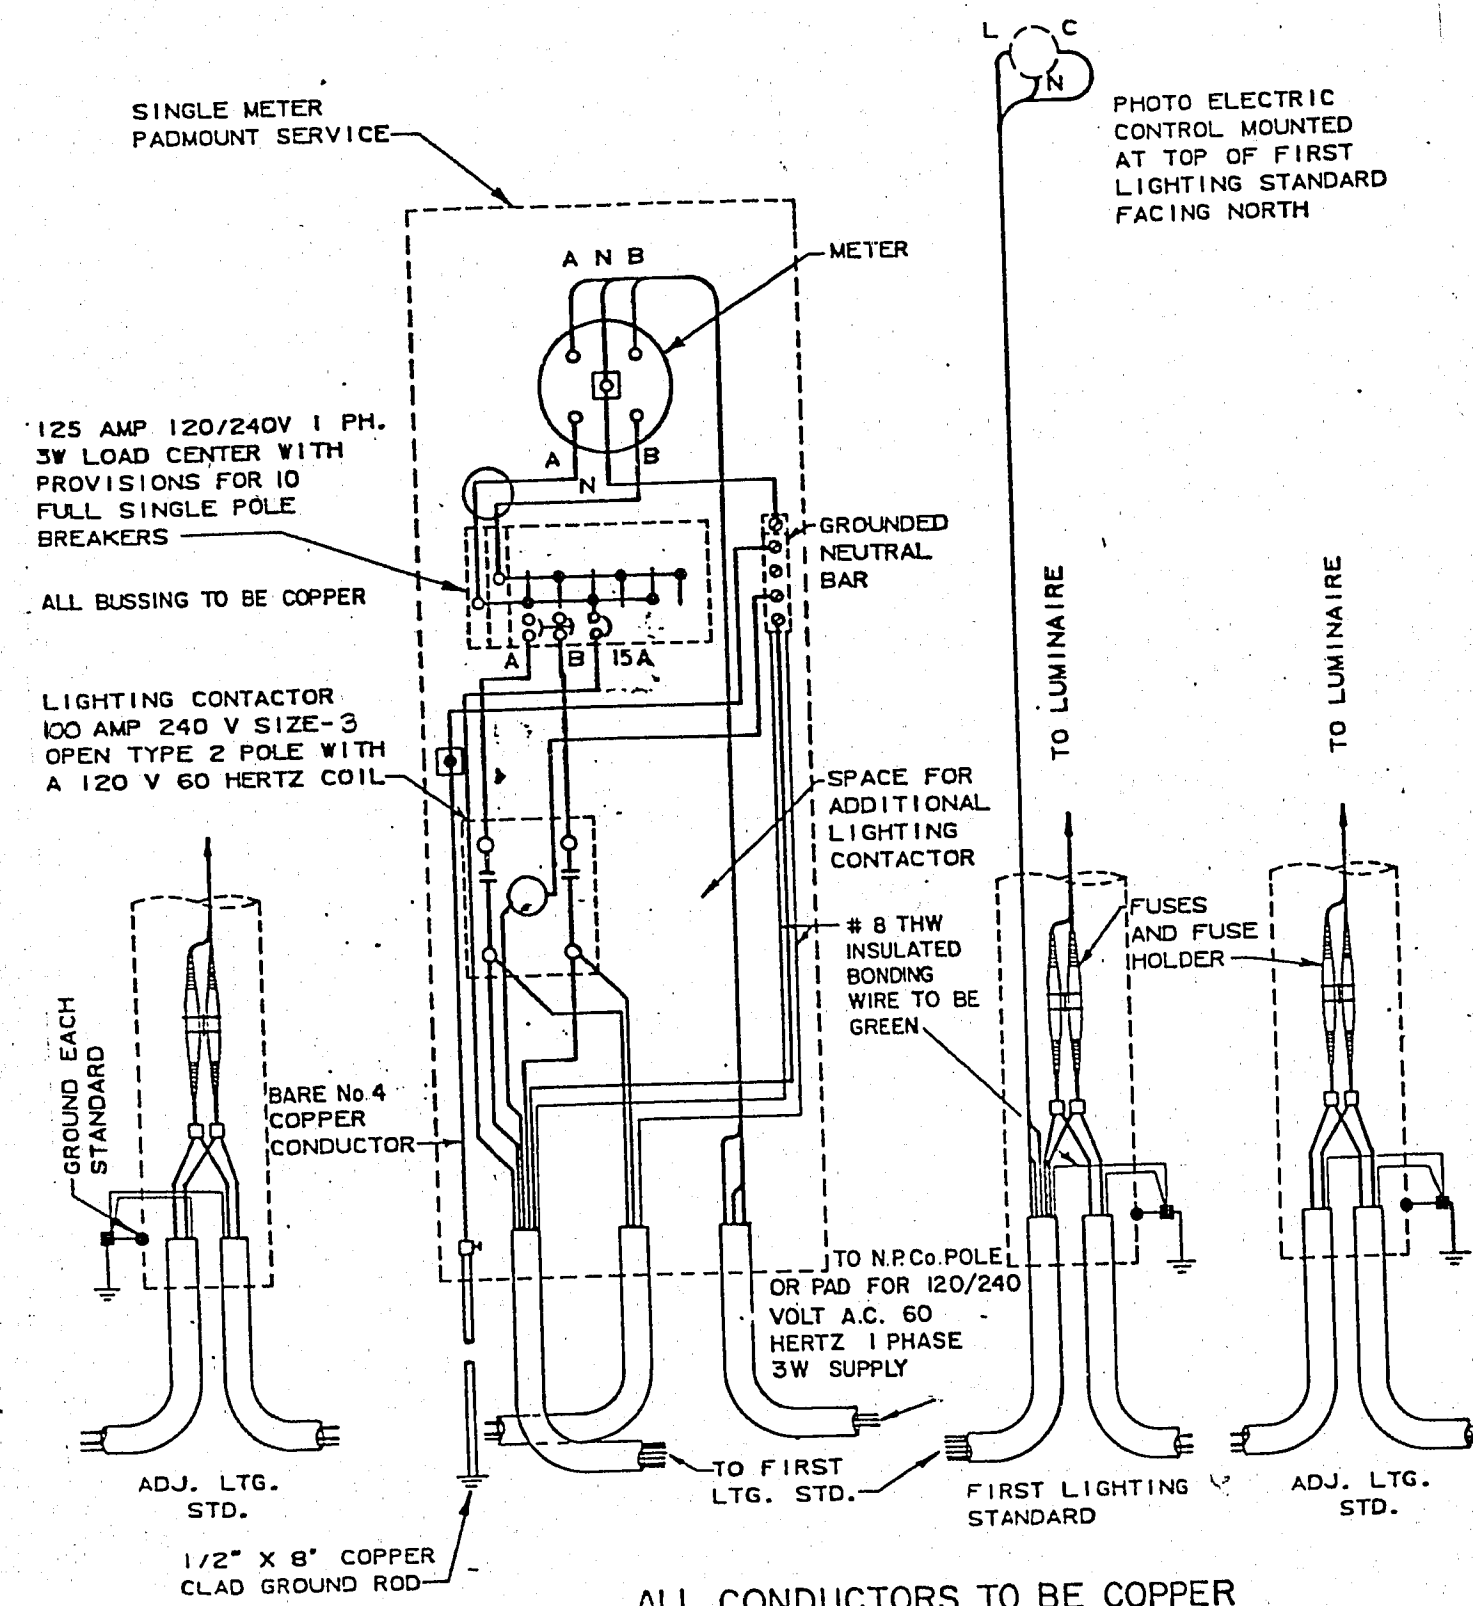

240 VOLT 2 WIRE
WIRING DIAGRAM
NO SCALE

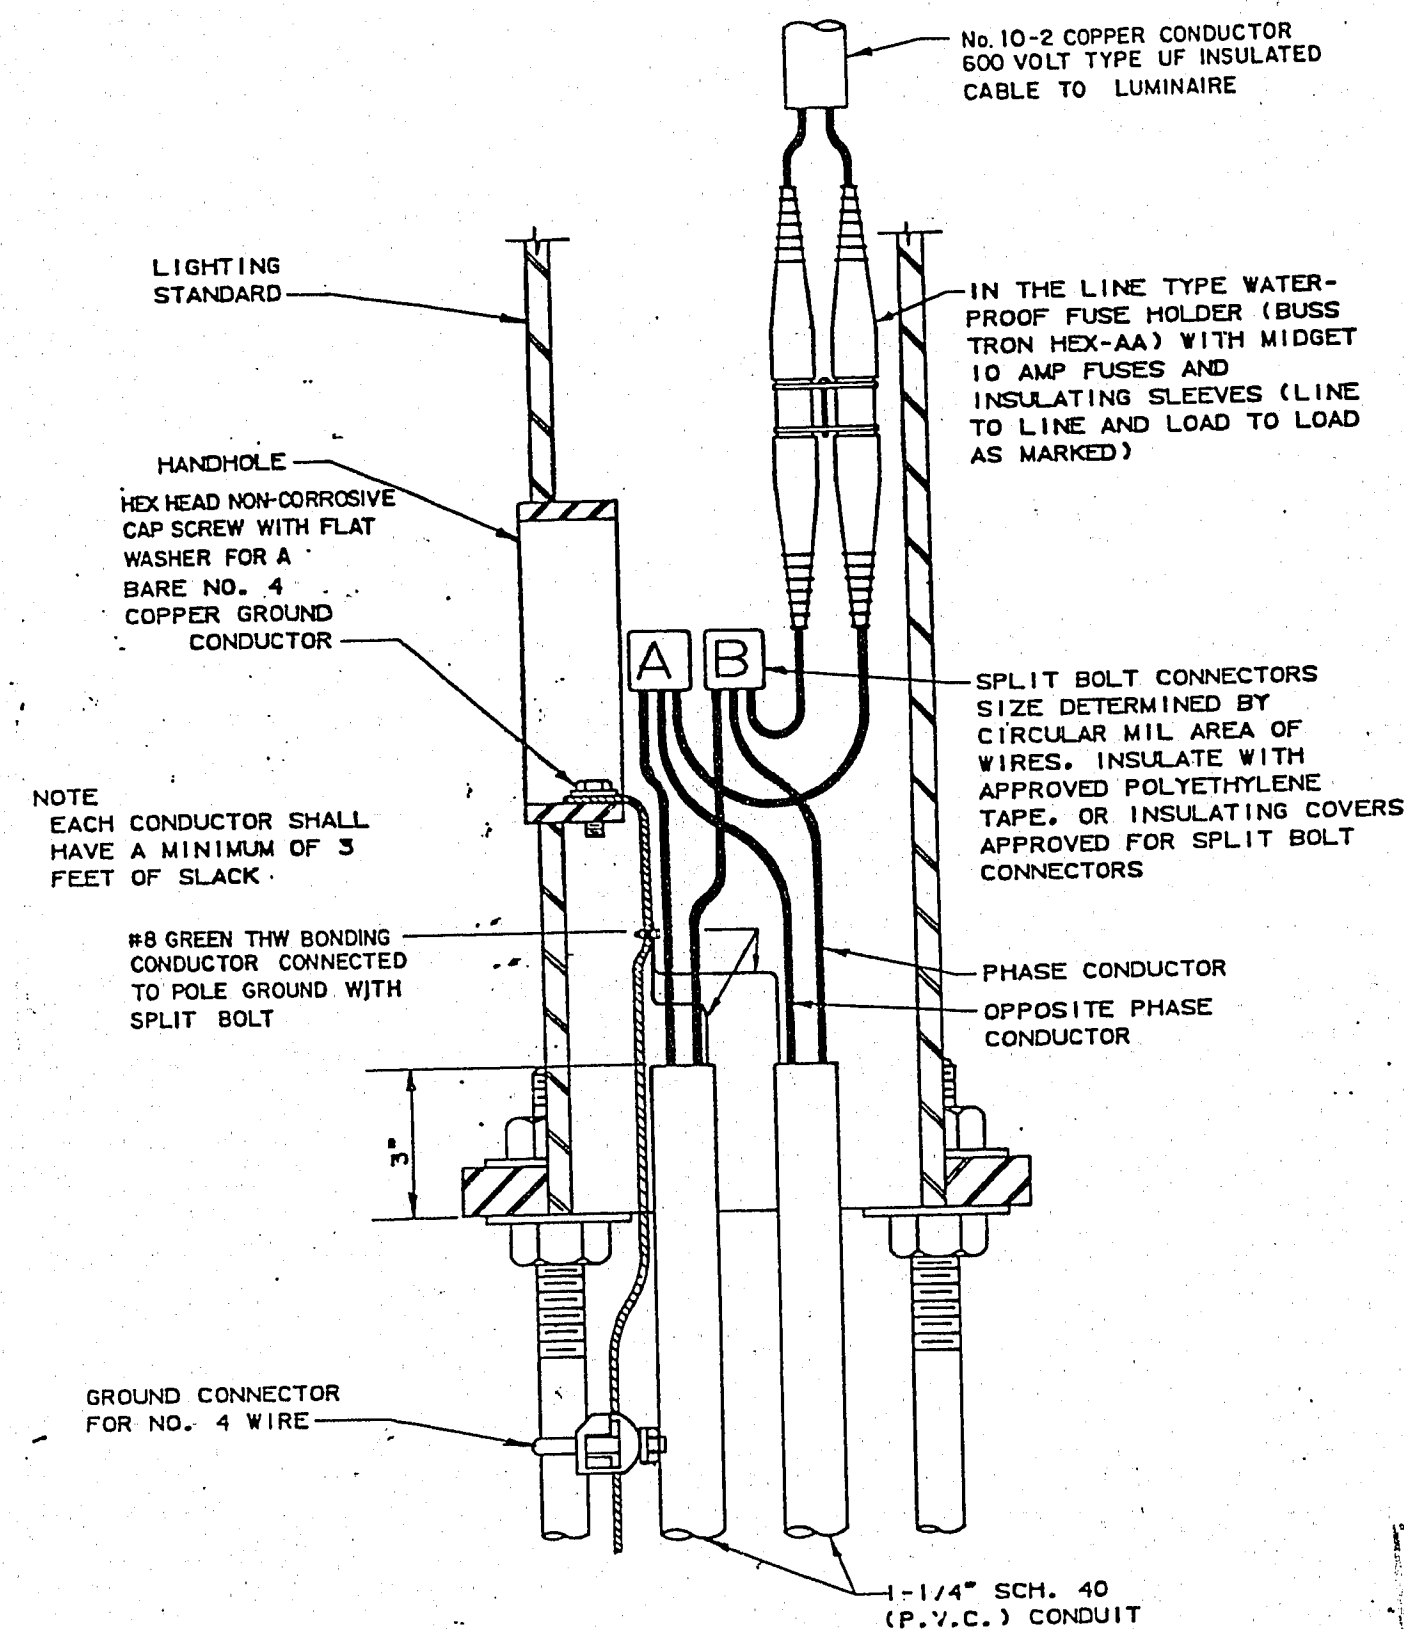

WIRING DIAGRAM FOR
SINGLE LUMINAIRE
NO SCALE

CONTRACT
DRAWING
APR 5 0 1982

EXPLANATIONS INDICATED ON THE PLANS
FOR THE CONSTRUCTION OF THE CONDUCTOR ONLY.
THE CONTRACTOR SHALL BE RESPONSIBLE FOR
THE PROPER INSTALLATION OF THE CONDUCTOR AND THE
PLANS NO LONGER VALID FOR BIDDING NOT
SHOWN ON THE PLANS OR NOT IN THE LOCATION
SHOWN ON THE PLANS.

Department of Public Services Engineering Design Division

LORENZI PARK STATE
MUSEUM PARKING LOT &
ROADWAY

ELECTRICAL DETAILS



Drawing no.
650.19-32