


GENERAL NOTES:

1. ALL CIRCUIT NUMBERS CORRESPOND TO PANEL-H4, U.N.O.
2. ALL CONDUIT IS 1-1/4" W (2)#3 & (1)#3 CU GRD., U.N.O.

KEY NOTES:

- 1 1-1/4" W (2)#2 & (1)#2 CU GRD.
- 2 1-1/4" W (2)#4 & (1)#4 CU GRD.
- 3 1-1/4" W (3)#6 & (1)#6 CU GRD.
- 4 ROUTE CONDUIT THROUGH VERTICAL STRUCTURE MEMBERS. ALL CONDUIT SHALL BE CONCEALED.
- 5 1-1/4" W (2)#6 & (1)#6 CU GRD.

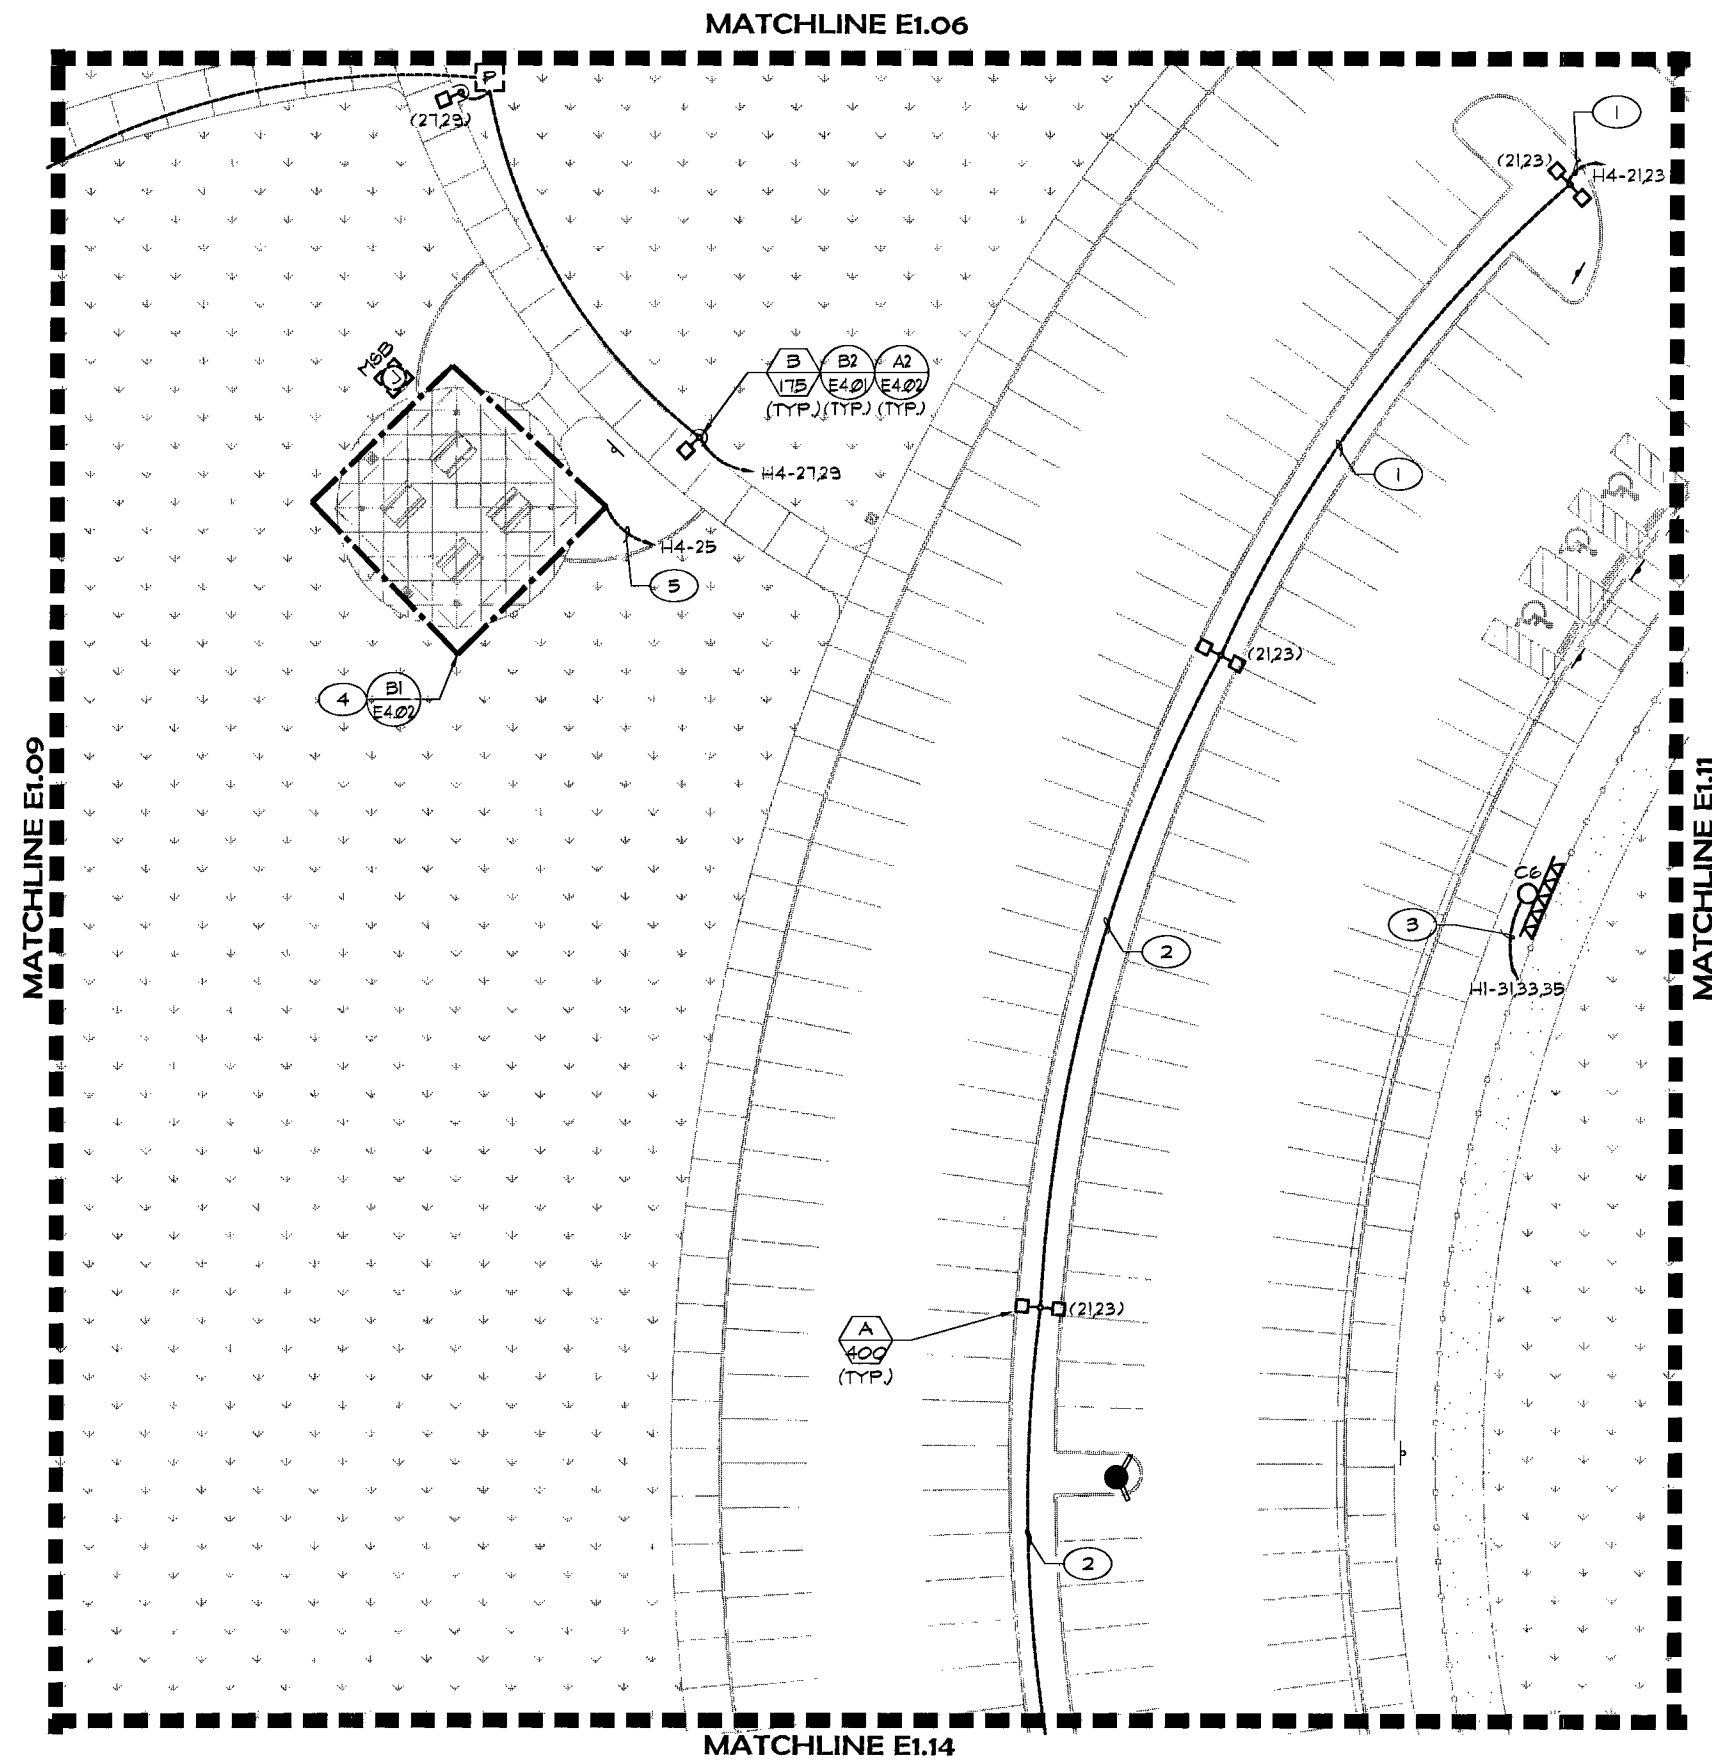


**RECORD DRAWINGS
NOT FOR CONSTRUCTION**

1. TO ALTER THESE DOCUMENTS FOR ANOTHER PROJECT BY ANYONE OTHER THAN THE ORIGINAL ARCHITECT IS A VIOLATION OF NRS 623.

2. THIS RECORD DRAWING HAS BEEN PREPARED IN PART, BASED UPON INFORMATION FURNISHED BY THE GENERAL CONTRACTOR WHILE THIS INFORMATION IS BELIEVED TO BE RELIABLE, THE DESIGN PROFESSIONAL CANNOT ASSURE ITS ACCURACY, AND THIS IS NOT RESPONSIBLE FOR THE ACCURACY OF THIS RECORD DRAWING OR FOR ANY ERRORS OR OMISSIONS WHICH MAY HAVE BEEN INCORPORATED INTO IT AS A RESULT. THE DESIGN PROFESSIONAL CANNOT AND DOES NOT WARRANT THEIR ACCURACY.

3. INFORMATION THAT MAY BE INCLUDED WOULD BE SIGNIFICANT CHANGES TO PLANTING OR IRRIGATION LAYOUT PLANS AND ASSOCIATED DRAWINGS, MINOR DIMENSION OR CONSTRUCTION DETAIL CHANGES MAY NOT BE INCLUDED.

ENGINEER OF RECORD HAS PERFORMED ALL REQUIRED VOLTAGE DROP CALCULATIONS WITHIN THE SCOPE OF THIS PROJECT.

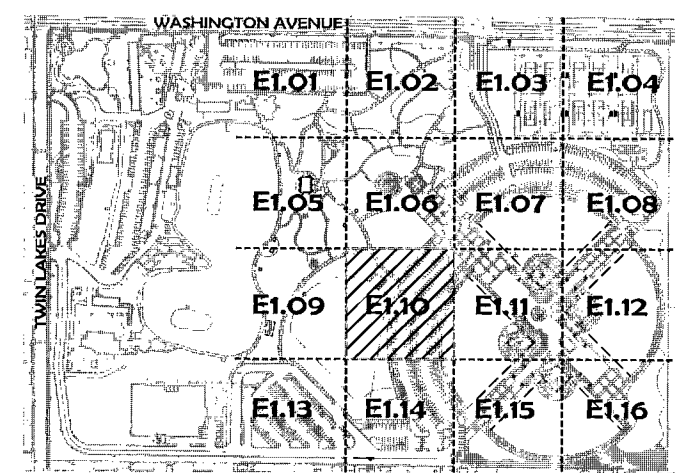

REVISIONS	7-10-09 Record Drawing
CONSULTANT	Professional Design Associates, Inc. Electrical and Mechanical Engineers 100 Main Street, Henderson, NV 89002 (702) 587-1022 Fax: (702) 587-1025 email: pda@pdacorp.com web: www.pdacorp.com
DRAWING NUMBER	PDA Project No. 2504
DATE	26-083
DATE	JUNE 2007
SCALE	AS SHOWN
SHEET NO	E1.10

Lorenzi Park Renovations
Phase I
ELECTRICAL PLAN

OWNER: CITY OF LAS VEGAS
DEPARTMENT OF PUBLIC WORKS
ARCHITECTURAL SERVICES

400 EAST STEWART AVENUE
LAS VEGAS, NEVADA 89101
PHONE: (702) 229-8533
FAX: (702) 384-8848
TDD: (702) 388-9108

119352