


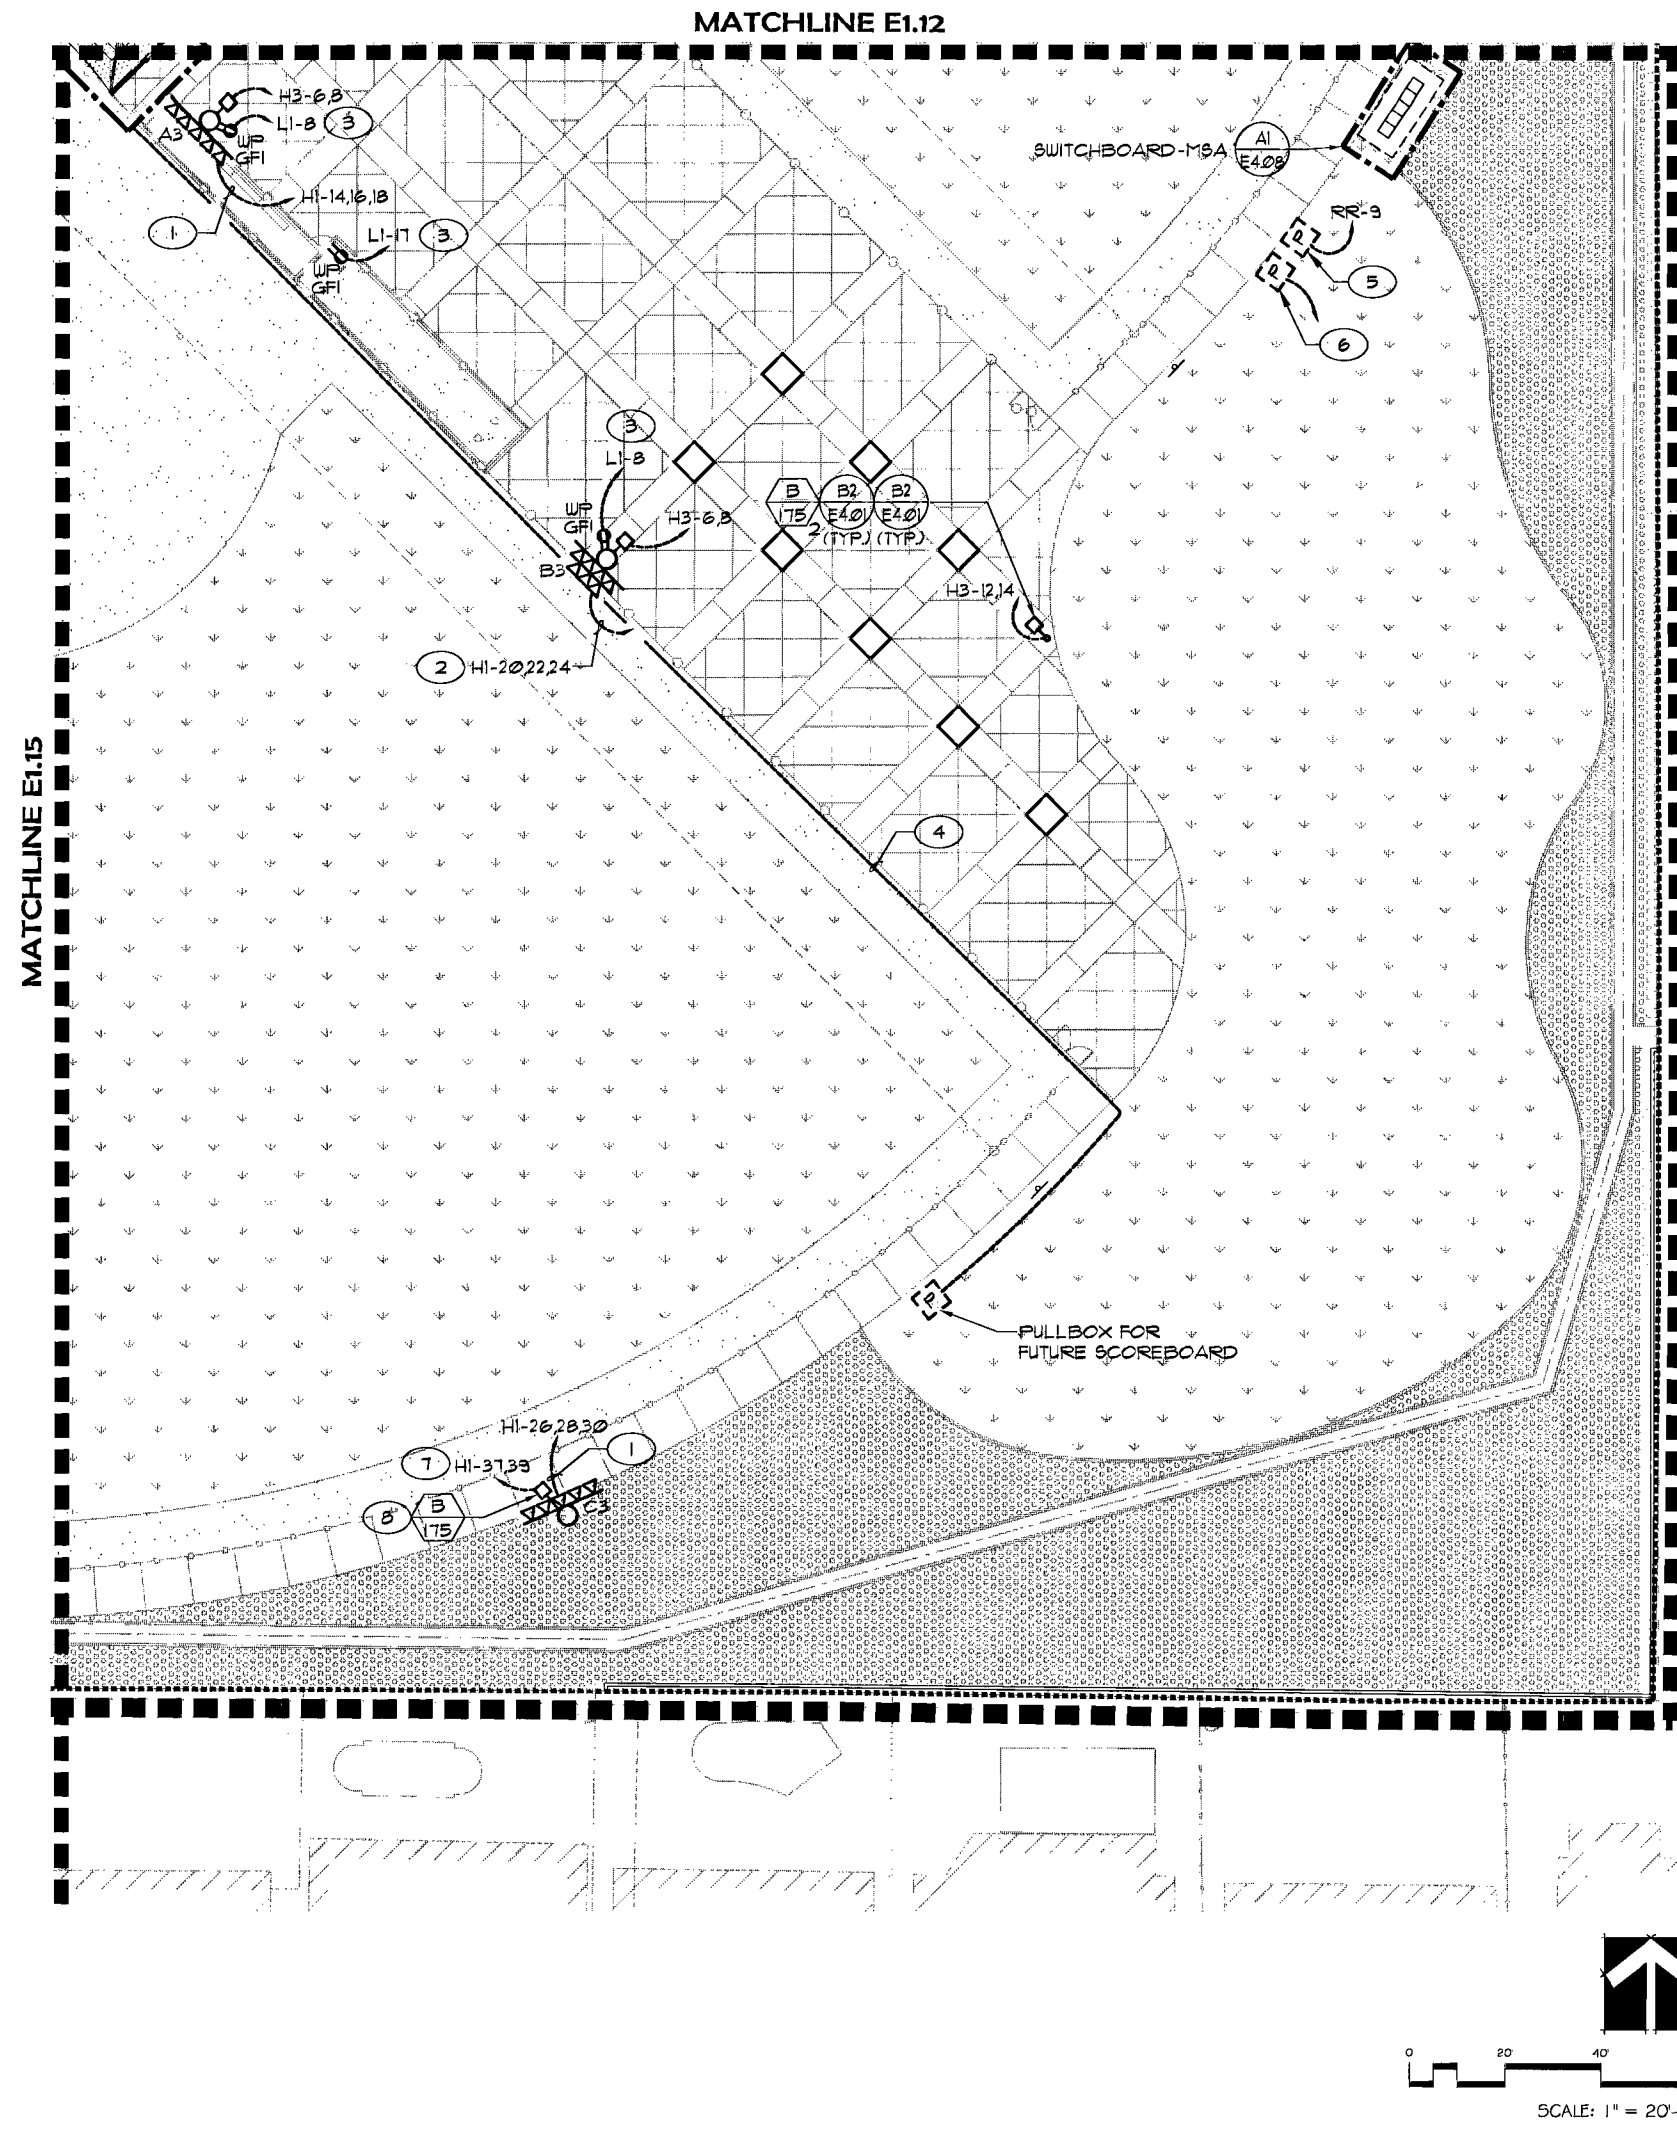

GENERAL NOTES:

- ALL CONDUIT IS 1-1/4" W (2) #10 & (1) #10 CU GRD., U.N.O.


KEY NOTES:

- 1-1/4" C W (3) #8 & (1) #8 CU GRD.
- 1-1/4" C W (3) #10 & (1) #10 CU GRD.
- 1-1/4" C W (2) #4 & (1) #4 CU GRD.
- 2" C.O. W PULLROPE FOR FUTURE SCOREBOARD. SEE DETAIL-A2 ON SHEET E4.02.
- PULLBOX FOR IRRIGATION CONTROLLERS. COORDINATE LOCATION W/ IRRIGATION CONTRACTOR.
- PULLBOX AND 2" C.O. WITH PULLROPE FOR EMBARQ TELEPHONE SERVICE. COORDINATE LOCATION WITH EMBARQ DRAWINGS.
- (2) #10 IN EXISTING 1-1/4" C.
- MOUNT FIXTURE 20 FT AF6. COORDINATE POLE MOUNTING WITH SPORTS LIGHTING MANUFACTURER. PROVIDE HOUSE SIDE SHIELD.

RECORD DRAWINGS NOT FOR CONSTRUCTION

- TO ALTER THESE DOCUMENTS FOR ANOTHER PROJECT BY ANYONE OTHER THAN THE ORIGINAL ARCHITECT IS A VIOLATION OF NRS 633.
- THIS RECORD DRAWING HAS BEEN PREPARED IN PART, BASED UPON INFORMATION FURNISHED BY THE GENERAL CONTRACTOR, WHILE THIS INFORMATION IS BELIEVED TO BE RELIABLE, THE DESIGN PROFESSIONAL CANNOT ASSURE ITS ACCURACY, AND THERE IS NOT RESPONSIBILITY FOR THE ACCURACY OF THIS RECORD DRAWING OR FOR ANY ERRORS OR OMISSIONS WHICH MAY HAVE BEEN INCORPORATED INTO IT AS A RESULT, THE DESIGN PROFESSIONAL CANNOT AND DOES NOT WARRANT THEIR ACCURACY.
- INFORMATION THAT MAY BE INCLUDED WOULD BE SIGNIFICANT CHANGES TO PLANTING OR IRRIGATION LAYOUT PLANS AND ASSOCIATED DRAWINGS, MINOR DIMENSION OR CONSTRUCTION DETAIL CHANGES MAY NOT BE INCLUDED.

ENGINEER OF RECORD HAS PERFORMED ALL REQUIRED VOLTAGE DROP CALCULATIONS WITHIN THE SCOPE OF THIS PROJECT.

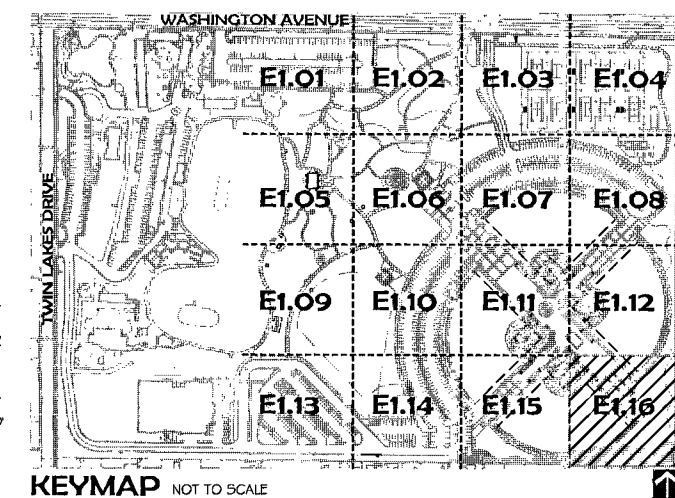

Lorenzi Park Renovations
Phase 1

ELECTRICAL PLAN

OWNER: CITY OF LAS VEGAS
DEPARTMENT OF PUBLIC WORKS
ARCHITECTURAL SERVICES

400 EAST STEWART AVENUE
LAS VEGAS, NEVADA 89101
PHONE: (702) 229-5535
FAX: (702) 384-4846
TDD: (702) 386-9108

DATE: 06-2007
SCALE: AS SHOWN
SHEET NO: E1.16

E1.16

119350