
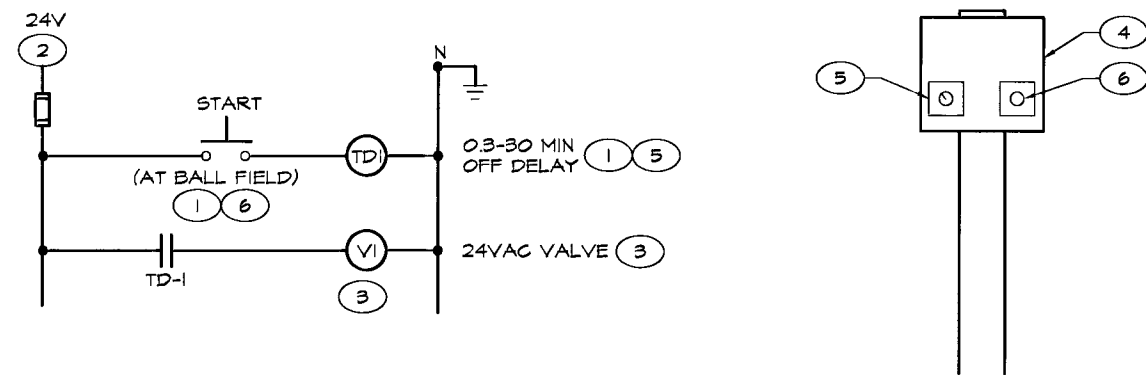


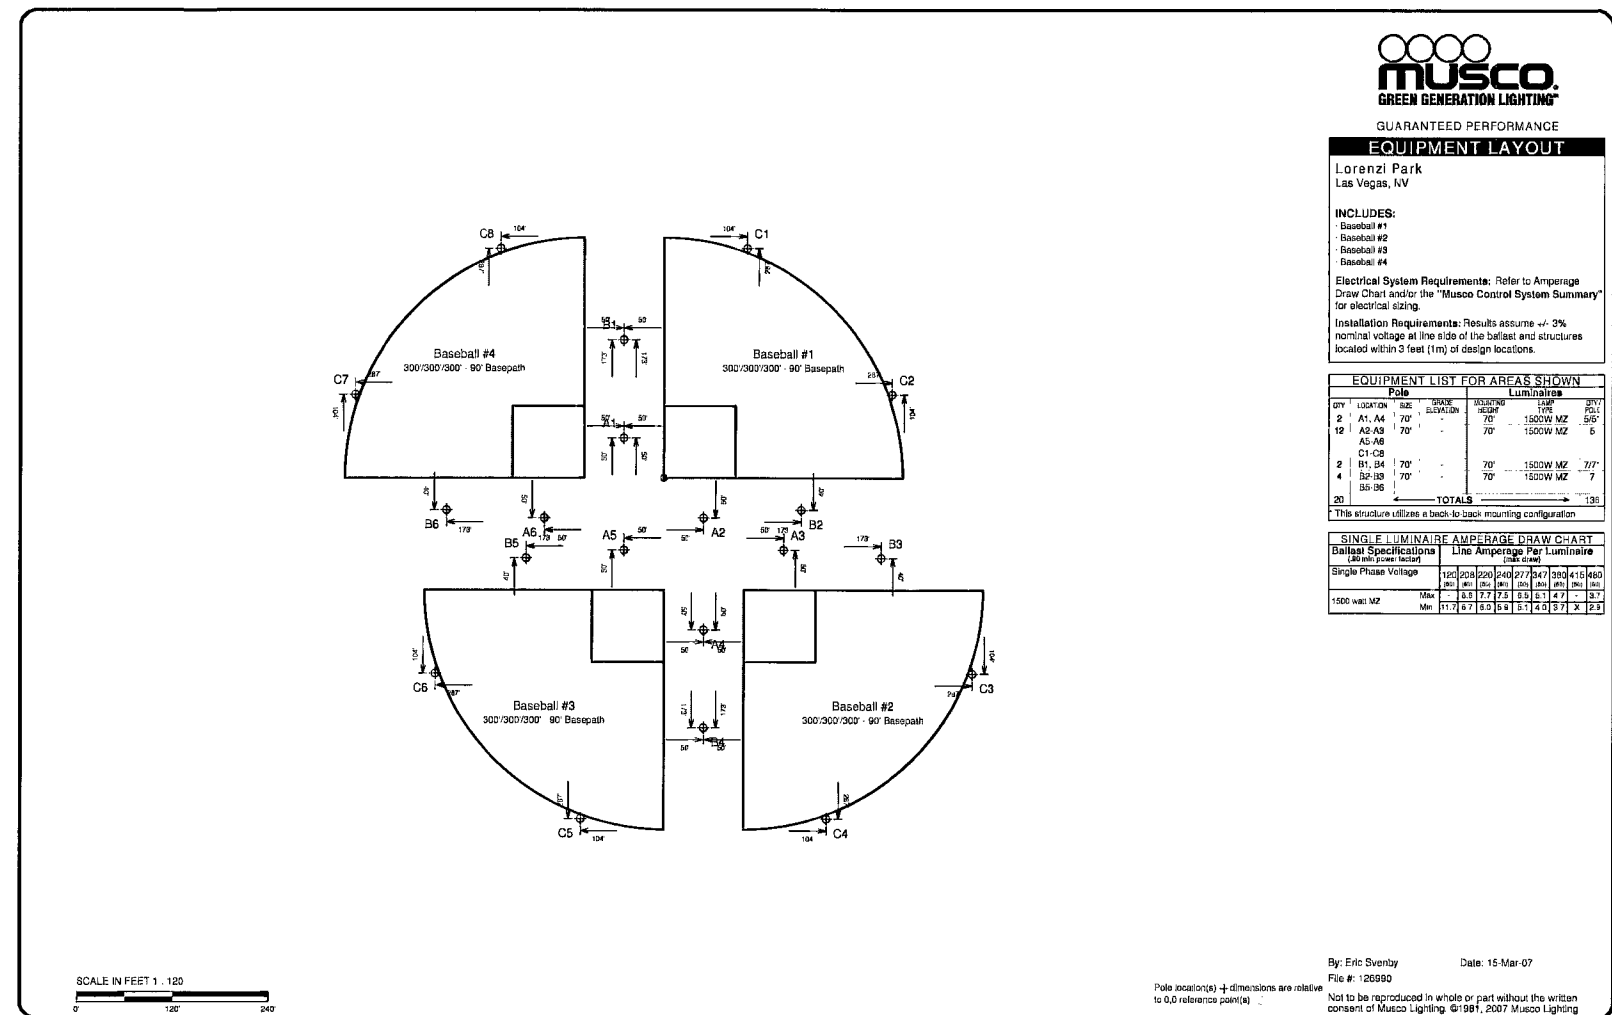

INFIELD IRRIGATION CONTROL DIAGRAM

SCALE: NONE

DETAIL NOTES:

- ① MOUNTED IN ENCLOSURE AT BALL FIELD.
- ② FROM CLOCK CONTROL TRANSFORMER IN CONCESSION STORAGE ROOM.
- ③ FIELD IRRIGATION VALVE (BY OTHERS).
- ④ WEIGMANN NEMA-3R ENCLOSURE #RHC-080806 MOUNTED ON POST IN BALL FIELD.
- ⑤ SQUARE-D #9050JCK4TV24 VARIABLE TIME DELAY RELAY MOUNTED IN ENCLOSURE.
- ⑥ SQUARE-D #900IKYI PUSH BUTTON MOUNTED IN ENCLOSURE.

RECORD DRAWINGS NOT FOR CONSTRUCTION

1. TO ALTER THESE DOCUMENTS FOR ANOTHER PROJECT BY ANYONE OTHER THAN THE ORIGINAL ARCHITECT IS A VIOLATION OF NRS 623.
2. THIS RECORD DRAWING HAS BEEN PREPARED IN PART, BASED UPON INFORMATION FURNISHED BY THE GENERAL CONTRACTOR WHILE THIS INFORMATION IS BELIEVED TO BE RELIABLE, THE DESIGN PROFESSIONAL CANNOT ASSURE ITS ACCURACY, AND THIS IS NOT RESPONSIBLE FOR THE ACCURACY OF THIS RECORD DRAWING OR FOR ANY ERRORS OR OMISSIONS WHICH MAY HAVE BEEN INCORPORATED INTO IT AS A RESULT. THE DESIGN PROFESSIONAL CANNOT AND DOES NOT WARRANT THEIR ACCURACY.
3. INFORMATION THAT MAY BE INCLUDED WOULD BE SIGNIFICANT CHANGES TO PLANTING OR IRRIGATION LAYOUT PLANS AND ASSOCIATED DRAWINGS, MINOR DIMENSION OR CONSTRUCTION DETAIL CHANGES MAY NOT BE INCLUDED.

REVISIONS
7-10-09 Record Drawing

CONSULTANT
Professional Design Associates, Inc.
Electrical and Mechanical Engineers
1300 Lake Street, Henderson, NV 89008
(702) 587-1022 Fax: (702) 587-1025
email: pda@pdacorp.com
website: www.pdacorp.com

PDAC
Project No. 200409

Lorenzi Park Renovations
Phase 1
SPORTS LIGHTING DETAILS

STAMP

OWNER: CITY OF LAS VEGAS
DEPARTMENT OF PUBLIC WORKS
ARCHITECTURAL SERVICES

400 EAST STEWART AVENUE
LAS VEGAS, NEVADA 89101
PHONE: (702) 229-5555
FAX: (702) 384-8646
TDD: (702) 386-9108

DRAWN: JCF

FILE: 06-008

DATE: JUNE 2007

SCALE: AS SHOWN

SHEET NO.

CLW DWG NO.

SHEET NO.

E4.07