


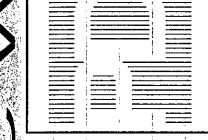

REVISIONS


CONSULTANT

Precision Design Group
108 Market St.
Henderson, NV 89015
Tel: (702) 907-0012
Fax: (702) 907-0013
email: info@pdg.com



Lorenzi Park Renovation
Phase 1
Restroom/Concession/Storage Building
MECHANICAL FLOOR PLAN

STAMP

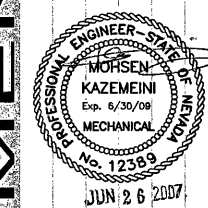

OWNER: CITY OF LAS VEGAS
DEPARTMENT OF PUBLIC WORKS
ARCHITECTURAL SERVICES


400 EAST STEWART AVENUE
LAS VEGAS, NEVADA 89101
PHONE: (702) 229-6535
FAX: (702) 386-6846
TDD: (702) 386-9108

DRAWN	AP
FILE	MECHANICAL
DATE	June 25, 2007
SCALE	1/4" = 1'-0"
DWG NO	07.15341.01
CLV/DWG NO	650.13-47
SHT NO	
DRAWN	AP
FILE	MECHANICAL
DATE	June 25, 2007
SCALE	1/4" = 1'-0"
DWG NO	07.15341.01
CLV/DWG NO	650.13-47
SHT NO	

RCS M1.01

KEYED NOTES:

- 1 2' DIAMETER LOUVER. REFER TO ARCH DRAWINGS AND SPEC. FOR MOUNTING HEIGHT, MAKE AND MODEL.
- 2 RETURN AIR BOOT. SEE DETAIL-B2.
- 3 FULL SIZE DOOR LOUVER. SEE ARCH DRAWING.
- 4 REFER TO DETAIL-B1 FOR MORE INFORMATION.
- 5 INSTALL UNIT @ 7'-6" ABOVE FINISH FLOOR.
- 6 SET THERMOSTAT AT 55°F.
- 7 CONTROL BOX FOR EVAP. COOLER, REFER TO ELECTRICAL DRAWINGS.

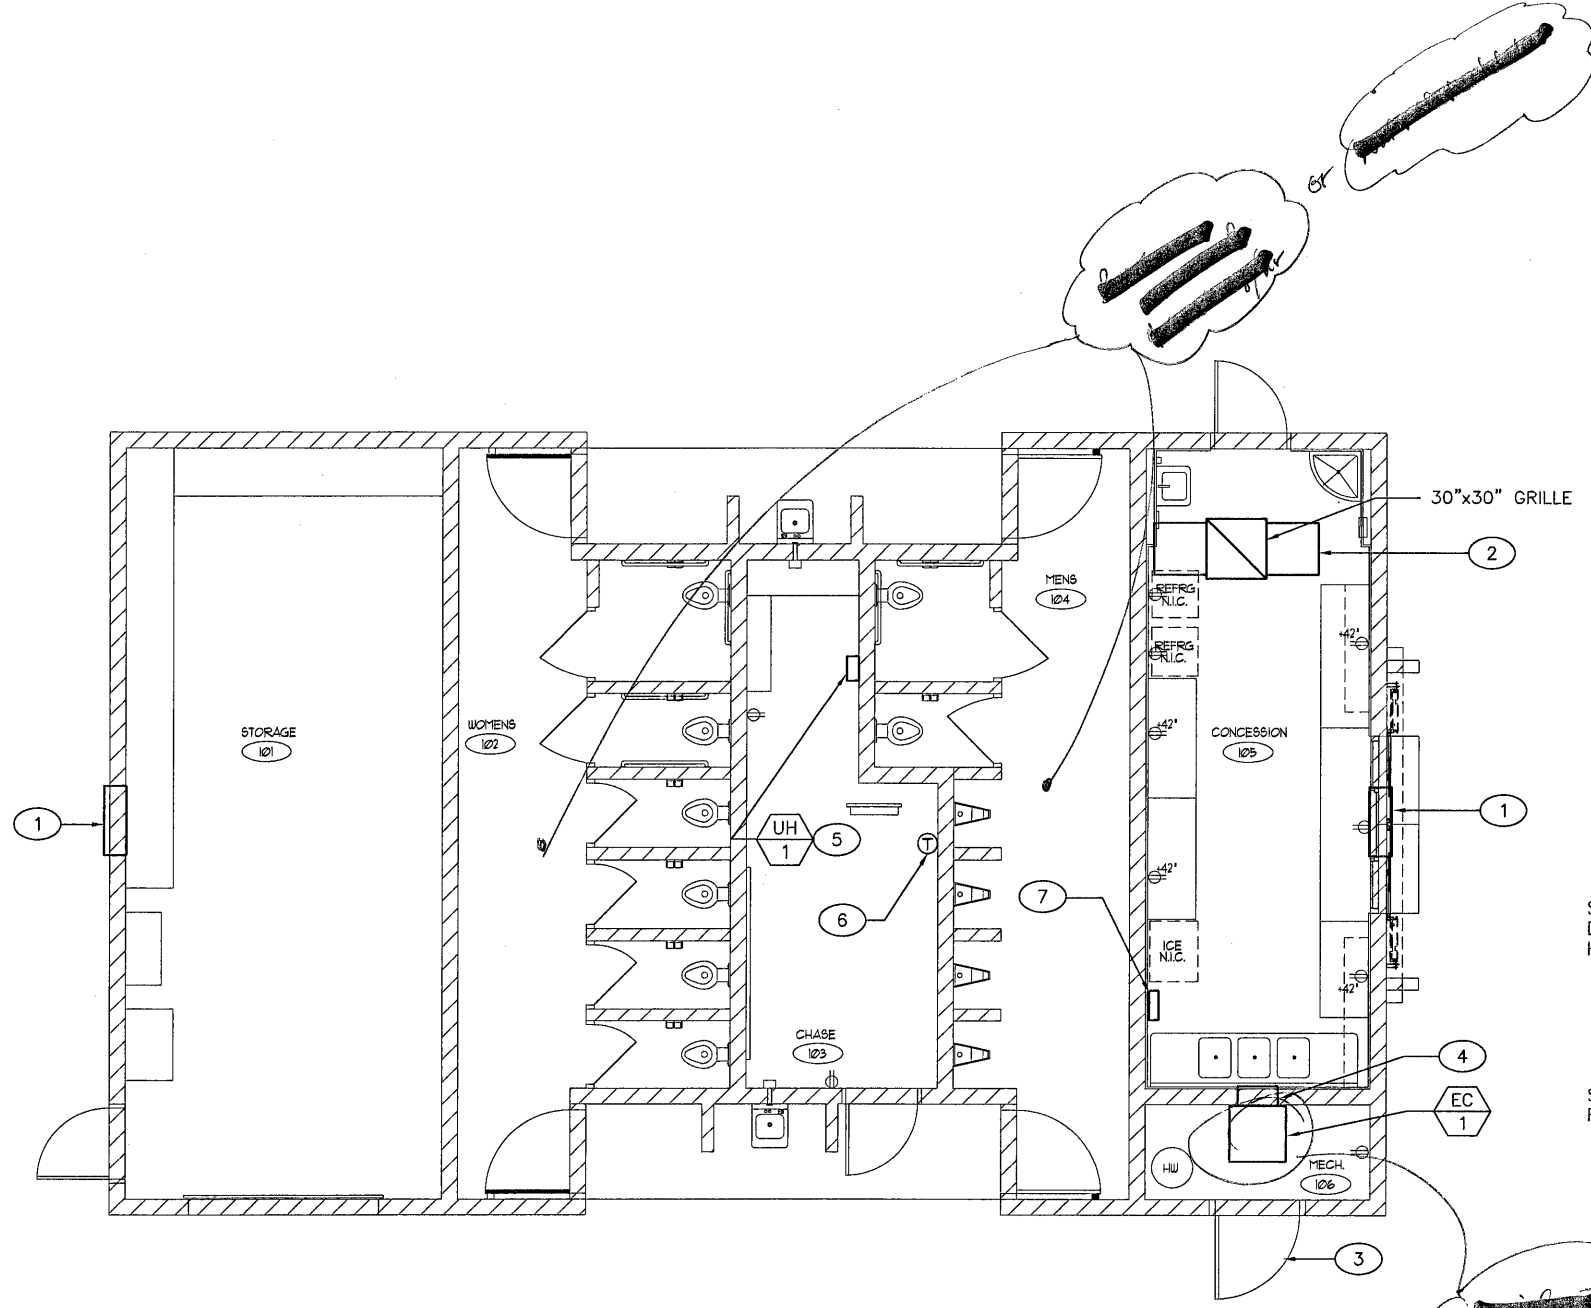

1 MECHANICAL PLAN - RESTROOM/STORAGE/CONCESSION
SCALE: 1/4" = 1'-0"

PROVIDE DUCT TRANSITION AS REQUIRED

SEE ARCHITECTURAL DRAWINGS FOR MOUNTING HEIGHT.


SEE STRUCTURAL DRAWINGS FOR DETAIL.

EC 1

16"x24" SUPPLY DIFFUSER, MADE BY TITUS, MODEL 271FL.

14"x14" UNIT OPENING.

B1 EVAP COOLER SUPPORT DETAIL
SCALE: NONE

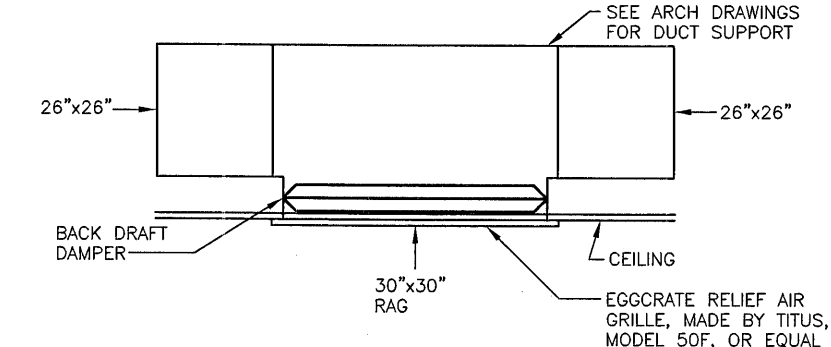

B2 RELIEF AIR BOOT DETAIL
SCALE: NONE

PLANS APPROVED
PLUMBING/MECHANICAL
Building & Safety Dept.
City of Las Vegas, Nevada

JUN 28 2007

Does Not Include Architectural, Electrical, Structural or Civil Site Improvements. Make No Change Without Approval. Plan is Not a Permit to Violate Any Ordinance.



Call before you Dig.
1-800-227-2600
UNDERGROUND SERVICE ALERT (USA)

117529