




REVISIONS
10/1/07 OWNER COMMENTS

CONSULTANT

Precision Design Group
108 Market St.
Henderson, NV 89015
Tel: (702) 307-0892
Fax: (702) 307-0893
Email: info@precisiondesign.com

Lorenzi Park Renovation
Phase I
Restroom/Concession/Storage Building
WASTE AND VENT PIPING PLAN

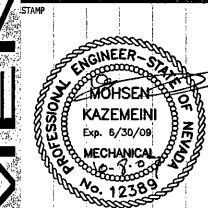

OWNER: CITY OF LAS VEGAS
DEPARTMENT OF PUBLIC WORKS
ARCHITECTURAL SERVICES

400 EAST STEWART AVENUE
LAS VEGAS, NEVADA 89103
PHONE: (702) 229-6535
FAX: (702) 384-6846
TDD: (702) 386-9108


DESIGN	AP
FILE	PLUMBING
DATE	April 28, 2007
SCALE	1/4"=1'-0"
BID NO.	071534101
CLV DWG NO.	65019-47
SHEET NO.	
RCS	P1.01

GENERAL NOTES:

1. EXTEND DRAIN FROM EVAP COOLER AND SPILL INTO FLOOR SINK WITH 1" AIR GAP
2. CONNECT SINK DRAINS AND SPILL INTO FLOOR SINK WITH 1" AIR GAP

KEYED NOTES:

- 1 4" SANITARY SEWER PIPE BELOW GRADE FOR CONTINUATION SEE CIVIL DRAWINGS
- 2 TWO-WAY CLEANOUT
- 3 4" SANITARY SEWER AND 3" VENT HEADERS
- 4 4" SANITARY SEWER TO BELOW FLOOR WITH CLEAN-OUT
- 5 4" VENT THROUGH CEILING AND ROOF
- 6 4" SANITARY SEWER BELOW FLOOR / GRADE
- 7 3" WASTE BELOW FLOOR / GRADE
- 8 2" VENT BELOW FLOOR
- 9 2" VENT BELOW ROOF
- 10 3" SANITARY SEWER AND 2" VENT HEADER
- 11 2" VENT FROM BELOW TO BELOW ROOF
- 12 3" SANITARY SEWER TO BELOW FLOOR WITH CLEAN-OUT
- 13 2" VENT ABOVE CEILING
- 14 2" VENT THROUGH ROOF
- 15 (2) 2" VENT IN FURRING FROM BELOW FLOOR, 2" VENT UP TO ABOVE CEILING
- 16 2" WASTE IN FURRING DOWN TO BELOW FLOOR, 2" VENT IN FURRING UP TO ABOVE CEILING

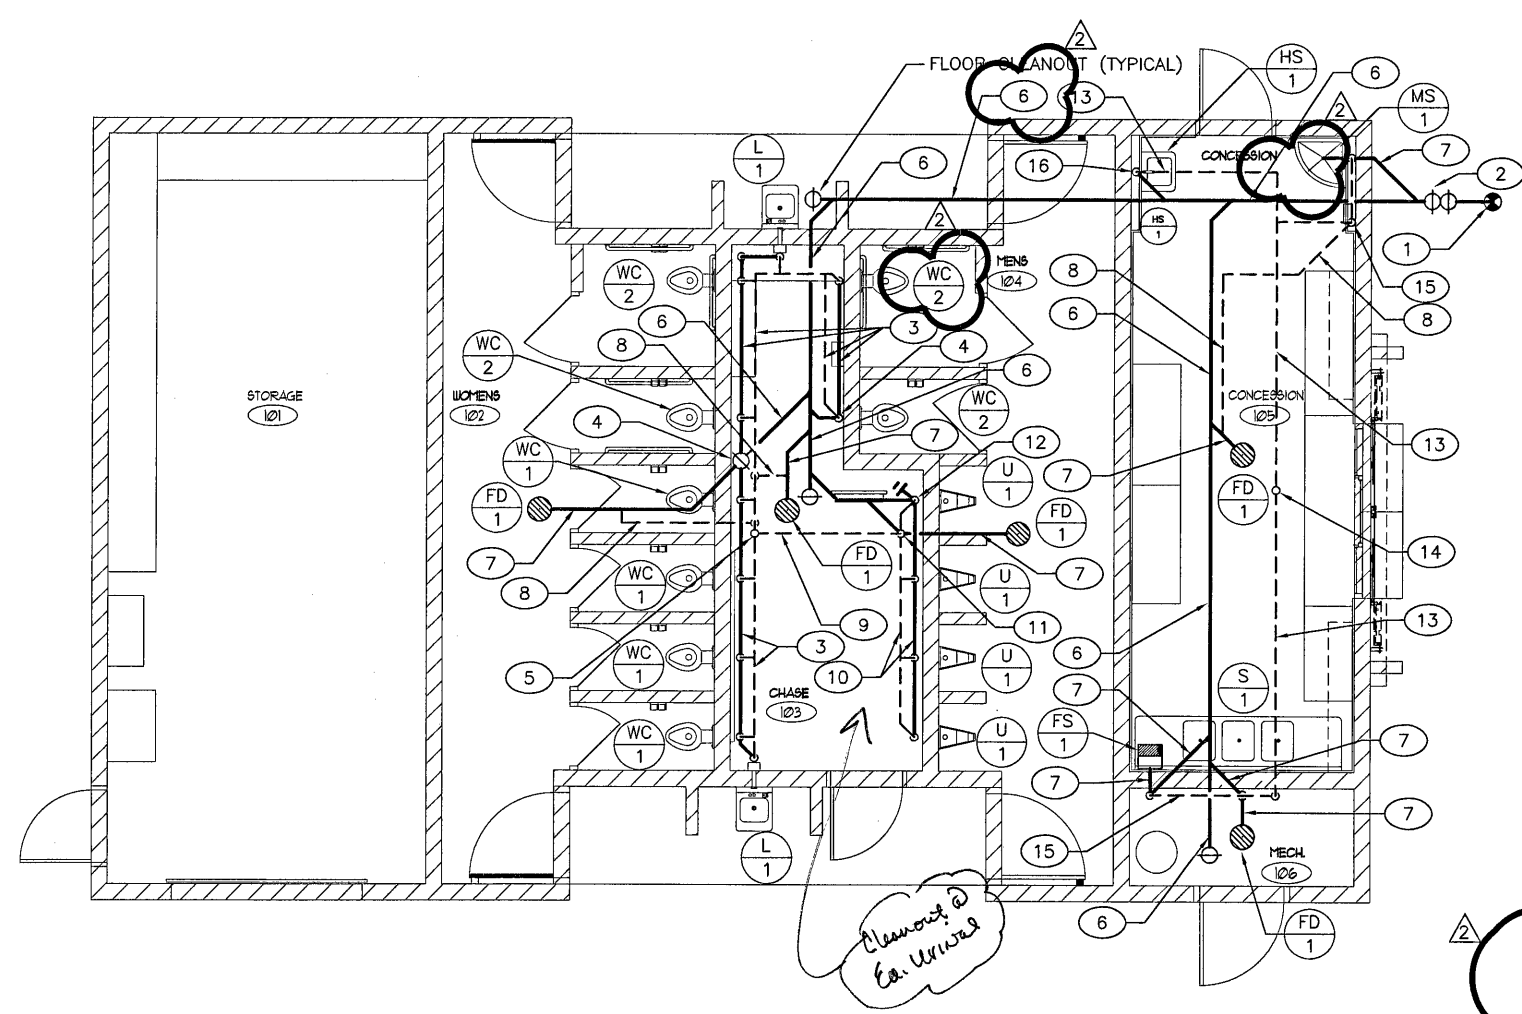

1 WASTE AND VENT PIPING PLAN — RESTROOM/STORAGE/CONCESSION
SCALE: 1/4" = 1'-0"

PLANS APPROVED
PLUMBING/MECHANICAL
Building & Safety Dept.
City of Las Vegas, Nevada

11/11 DEC 05 2007

Does Not Include Architectural, Electrical
Structural or Other
Improvements Make No Change
Without Approval Plan is
Not a Permit to Construct



Avoid cutting underground utility lines. It's costly.
Call before you Dig.
1-800-227-2600
UNDERGROUND SERVICE ALERT (USA)

11753