



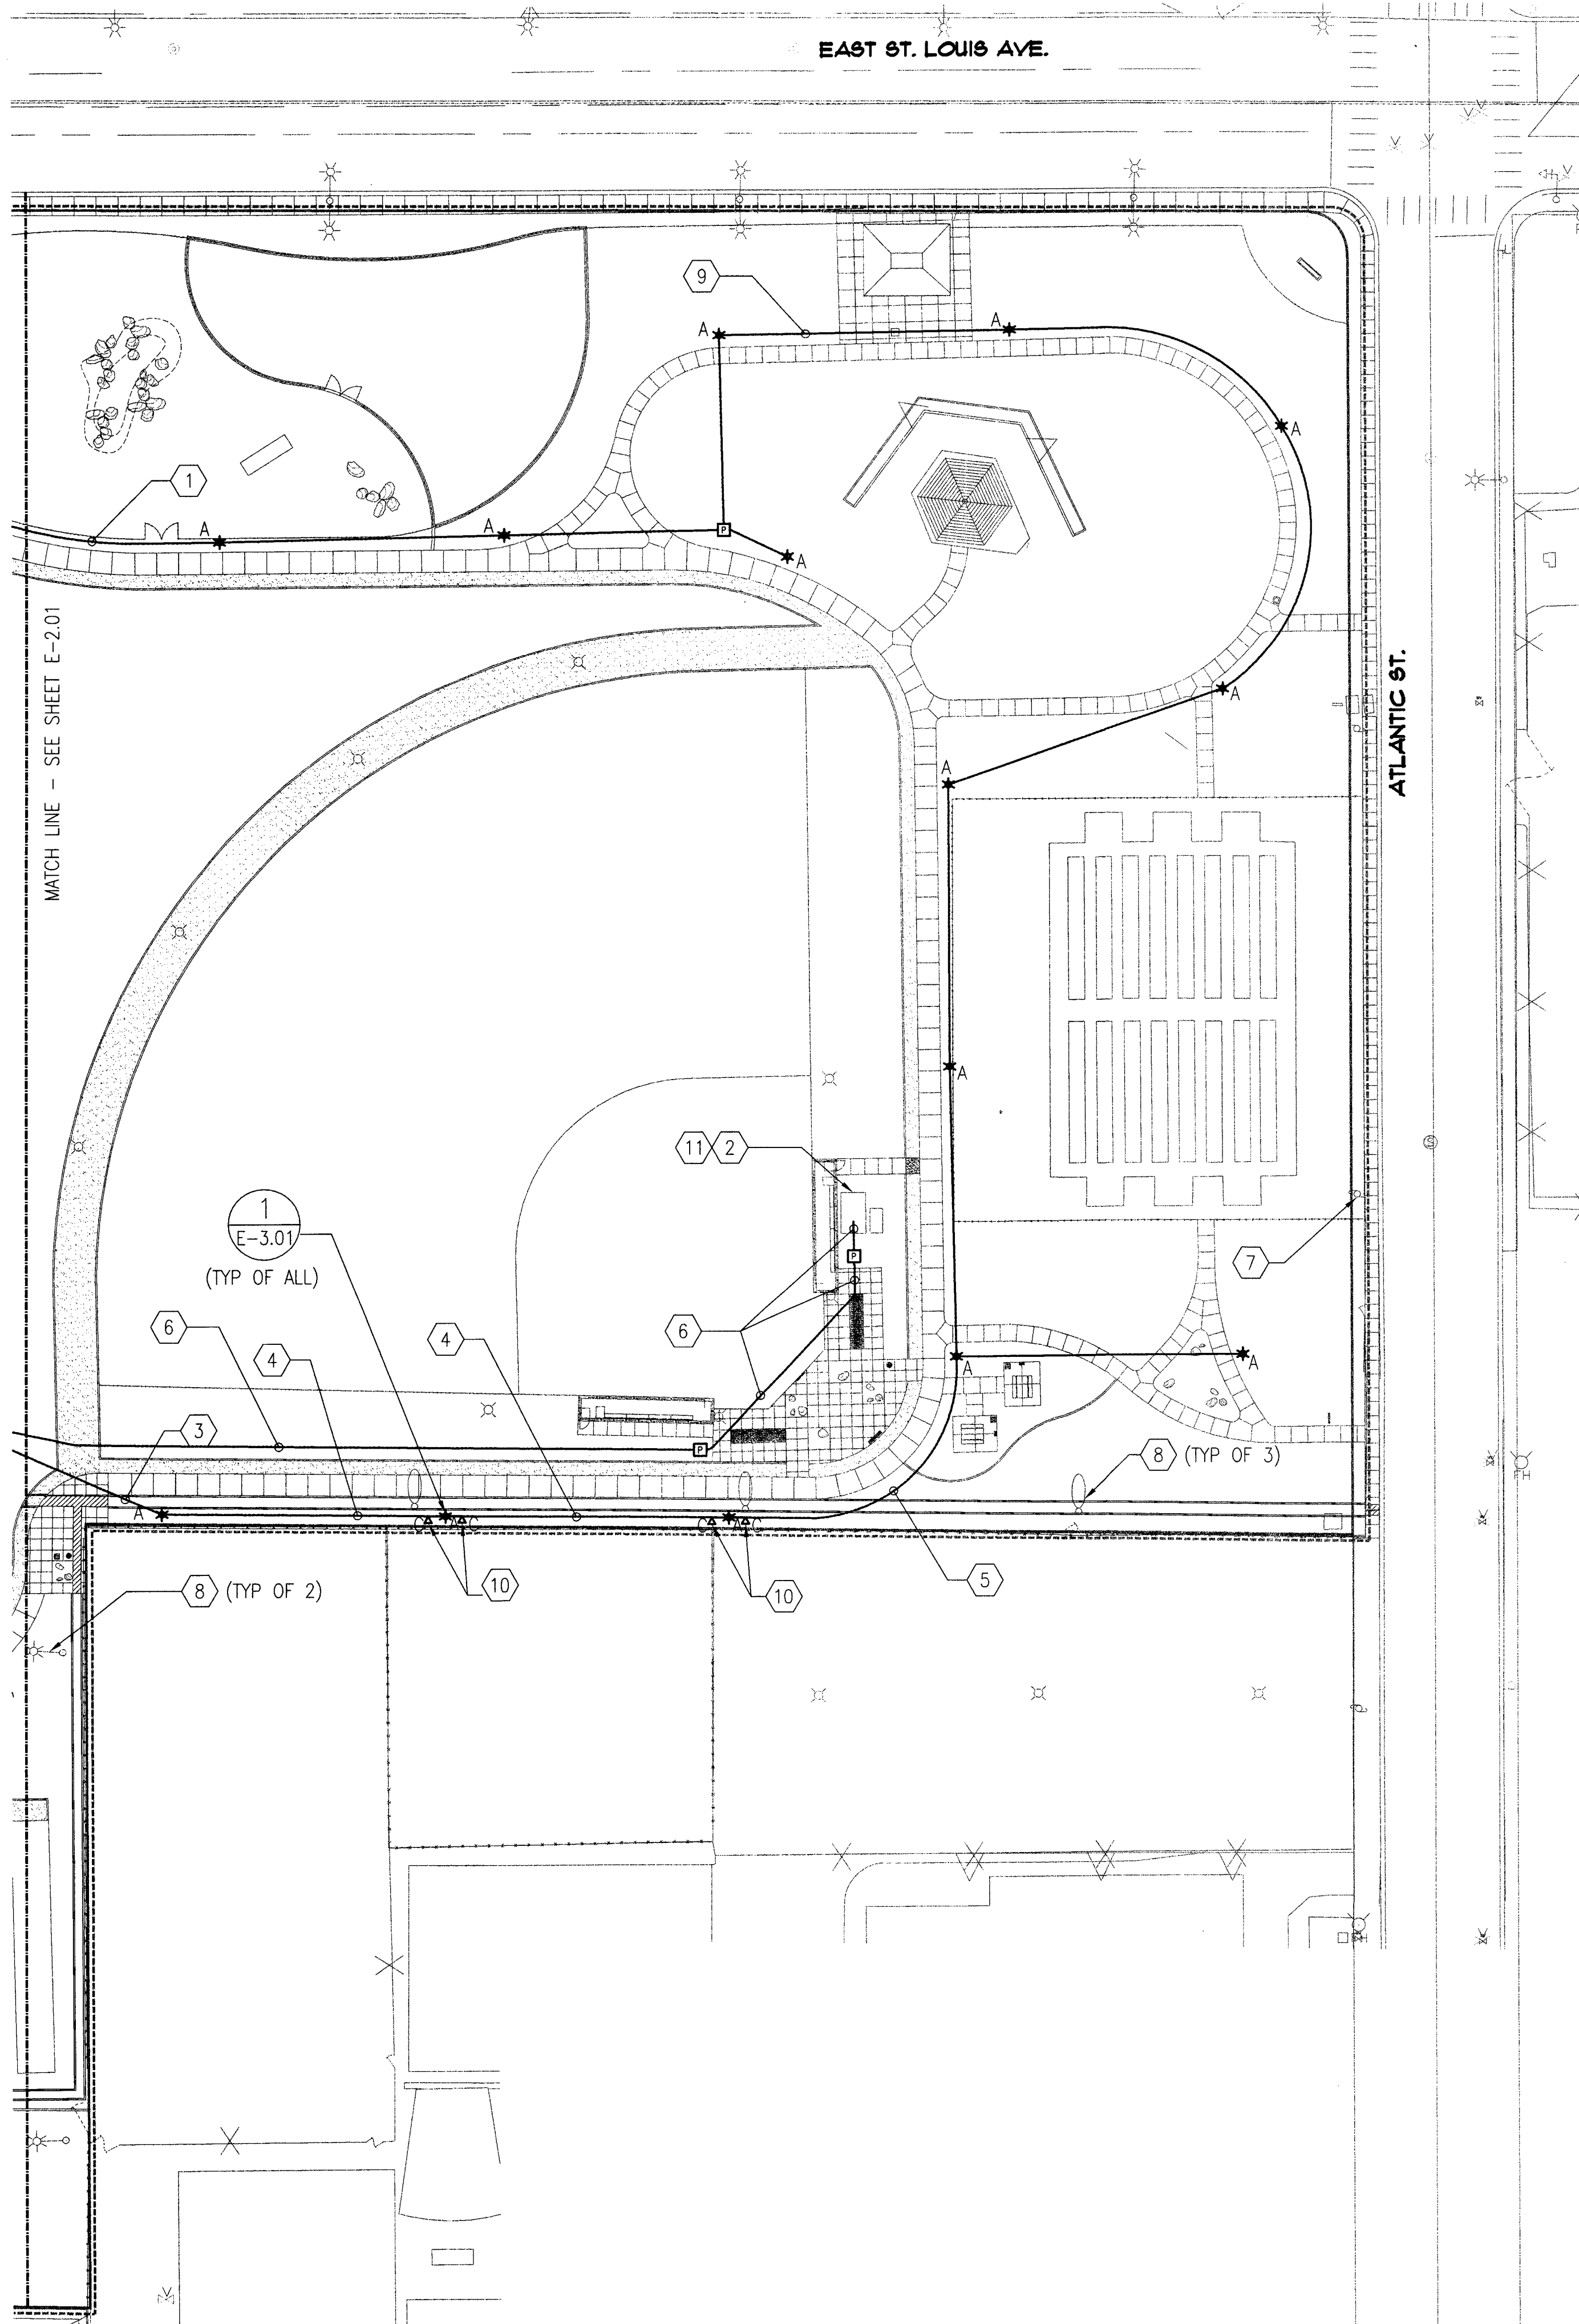

B PARTIAL ELECTRICAL SITE PLAN
E-2.02 SCALE: 1"=40'-0" REFERENCE DRAWING E-2.02

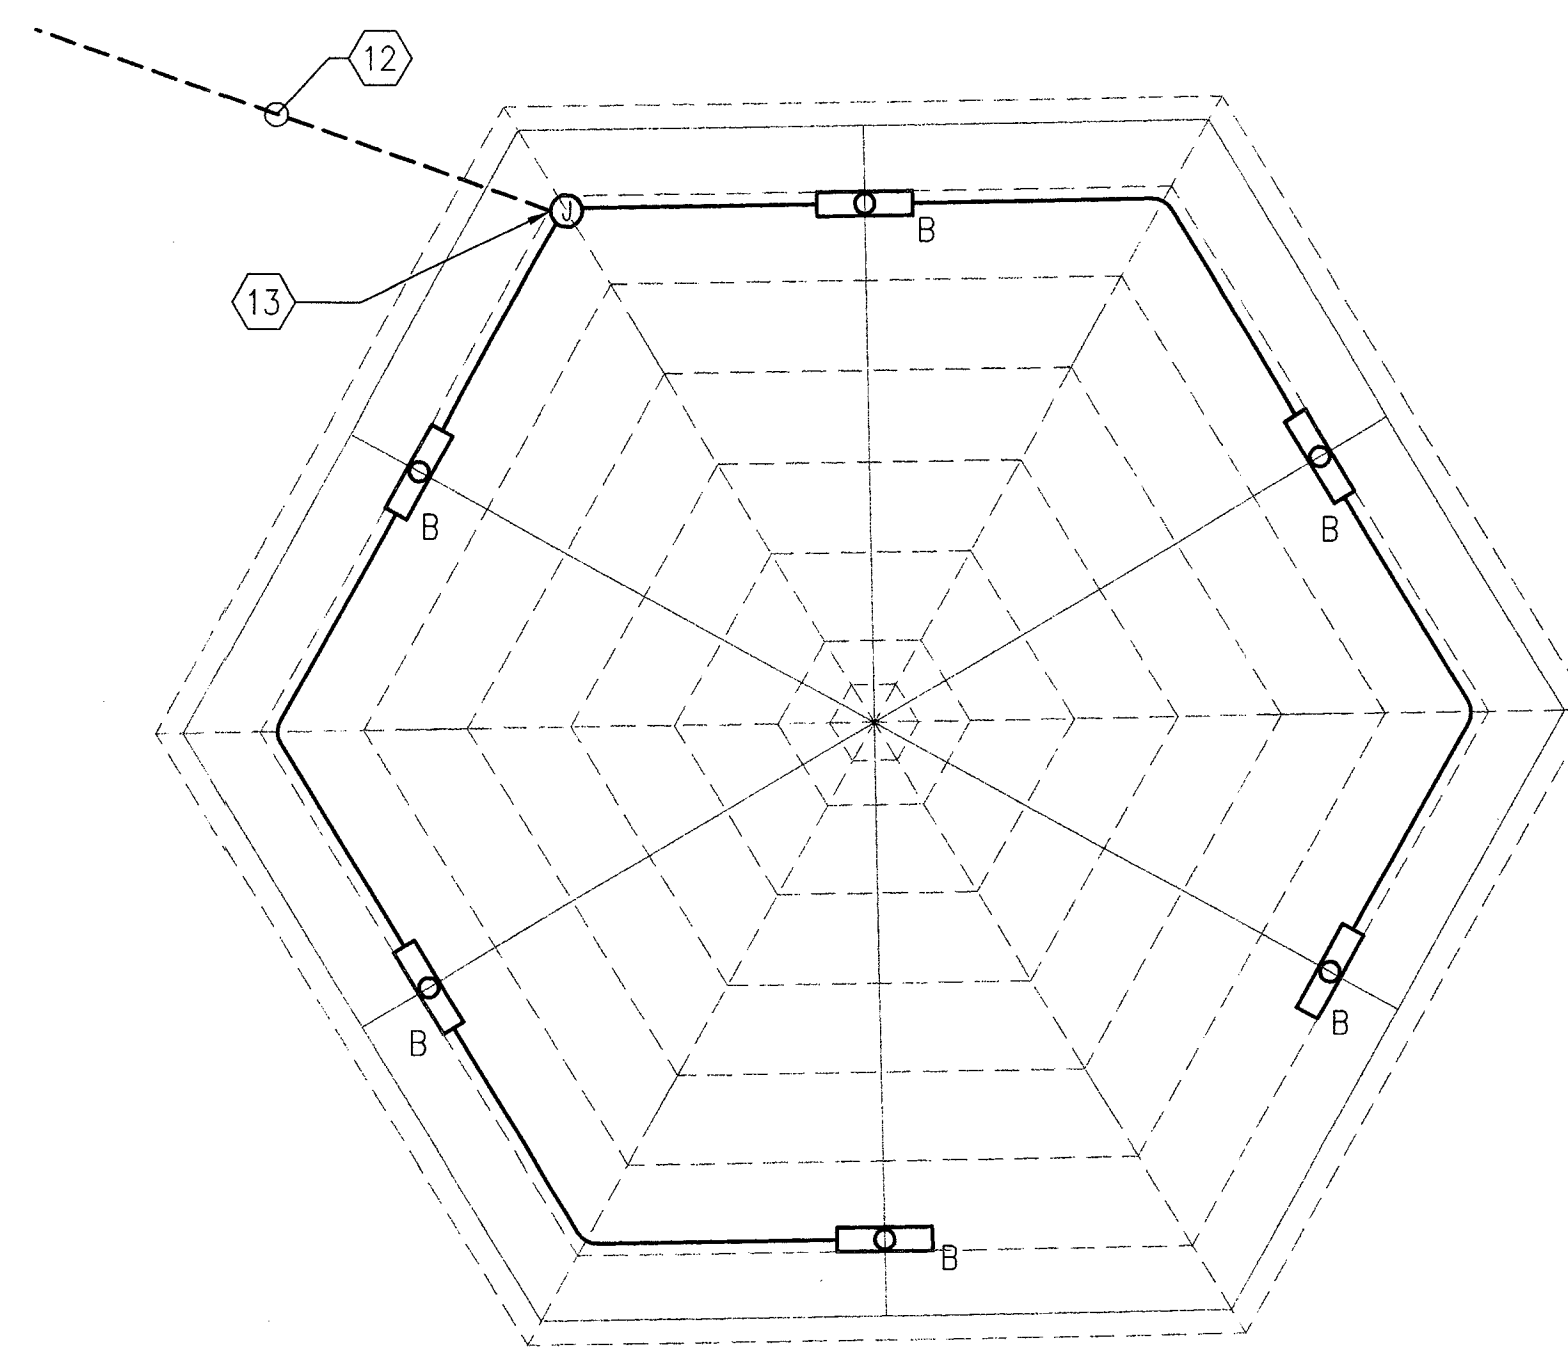

1 RAMADA ELECTRICAL PLAN
E-2.02 SCALE: 1/8"=1'-0" REFERENCE DRAWING E-2.01


PLANS APPROVED
 ELECTRICAL
 Building & Safety Dept.
 City of Las Vegas, Nevada
 JUN 22 2007
 Does Not Include Structural, Architectural,
 Plumbing/Mechanical or Off-Site
 Improvements. Make No Change
 Without Approval. Plan is
 Not a Permit to Violate Any Ordinance.

KEYNOTES

- (1) (2)#8, (1)#10G, 1-1/4" (L-6,8). SEE SHEET E-2.01 FOR CONTINUATION.
- (2) EXISTING ELECTRICAL SERVICE TO REMAIN IN PLACE AND IN SERVICE DURING CONSTRUCTION. CONTRACTOR SHALL VERIFY ROUTING OF UNDERGROUND ELECTRICAL SERVICE PRIOR TO EXCAVATING IN THIS AREA AND SHALL PROTECT EXISTING SERVICE DURING CONSTRUCTION.
- (3) (2)#4 (L-9,11), (2)#10, (L-14,16), (1)#8G, 1-1/4" (L-9,11). SEE SHEET E-2.01 FOR CONTINUATION.
- (4) (2)#8 (L-9,11), (2)#10 (L-14,16), (1)#10G, 1-1/4" (L-9,11).
- (5) (2)#8, (1)#10G, 1-1/4" (L-9,11).
- (6) (1) 1" CONDUIT WITH (4)#10, (1)#10G FROM EXISTING MUSCO CONTROLLER AT BALLFIELD TO NEW SOCCER FIELD LIGHTING. SEE SHEET E-2.01 FOR CONTINUATION TO SOCCER FIELD.
- (7) EXISTING BALLFIELD ELECTRICAL SERVICE POINT OF CONNECTION, SHOWN FOR REFERENCE ONLY.
- (8) REMOVE EXISTING LUMINAIRE AND POLE AND RETURN TO OWNER AT SITE. REMOVE WIRE AND CONDUIT AND DISCARD. REMOVE FOUNDATION AND DISCARD.
- (9) 1-1/4" CONDUIT ONLY, WITH #12 PULLSTRING.
- (10) PROVIDE OCCUPANCY SENSOR ON POLE TO CONTROL THESE TWO FIXTURES.
- (11) INSTALL NEW HAND/OFF/AUTO SWITCH IN MUSCO CONTROL-LINK PANEL FOR NEW SOCCER FIELD LIGHTING, TO BE DESIGNATED ZONE 2.
- (12) (2)#10, (1)#10G IN 3/4" RGS WRAPPED IN PVC TAPE FROM PULL BOX TO OUTLET BOX.
- (13) PROVIDE WEATHERPROOF, VANDAL-RESISTANT LOCKING SWITCH FOR RAMADA LIGHTS AND RECEPTACLE.

Jordan & Skala Engineers, Inc.
 Project Number - 0640395
 2900 S. RANCHO DR. STE. 201 LAS VEGAS, NV 89102
 PHONE (702) 362-5554
 FAX (702) 362-5554
 EMAIL: jordan@jordan-skala.com
 COPYRIGHT © 2007 JORDAN & SKALA ENGINEERS INC.

JAYCEE PARK RENOVATION
 SOUTH EAST CORNER OF EASTERN AVE.
 AND EAST SAINT LOUIS AVE.
 ELECTRICAL SITE PLAN B

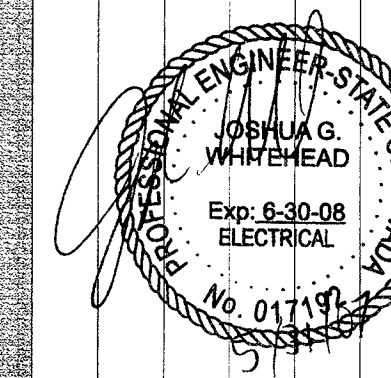

OWNER: CITY OF LAS VEGAS
 DEPARTMENT OF PUBLIC WORKS
 ARCHITECTURAL SERVICES

400 EAST STEWART AVENUE
 LAS VEGAS, NEVADA 89101
 PHONE: (702) 229-8535
 FAX: (702) 384-4846
 TDD: (702) 386-9108

DRAWN	DON
FILE	
DATE	JUNE 2007
SCALE	AS NOTED
RID NO	07.15314.02
CLV DWG NO	0506-24

SHT NO
E-2.02