




PANEL SCHEDULE									
CCT. NO.	AMPS	VOLTS	WIRE SIZE	NO. OUTLET	DESC.	LOADING			
						Φ 1	Φ 2		
1	15	115	12	3	LIGHT	300	200		
2	15	115	12	3	LIGHT				
TOTAL LOAD IN WATTS						300	200		

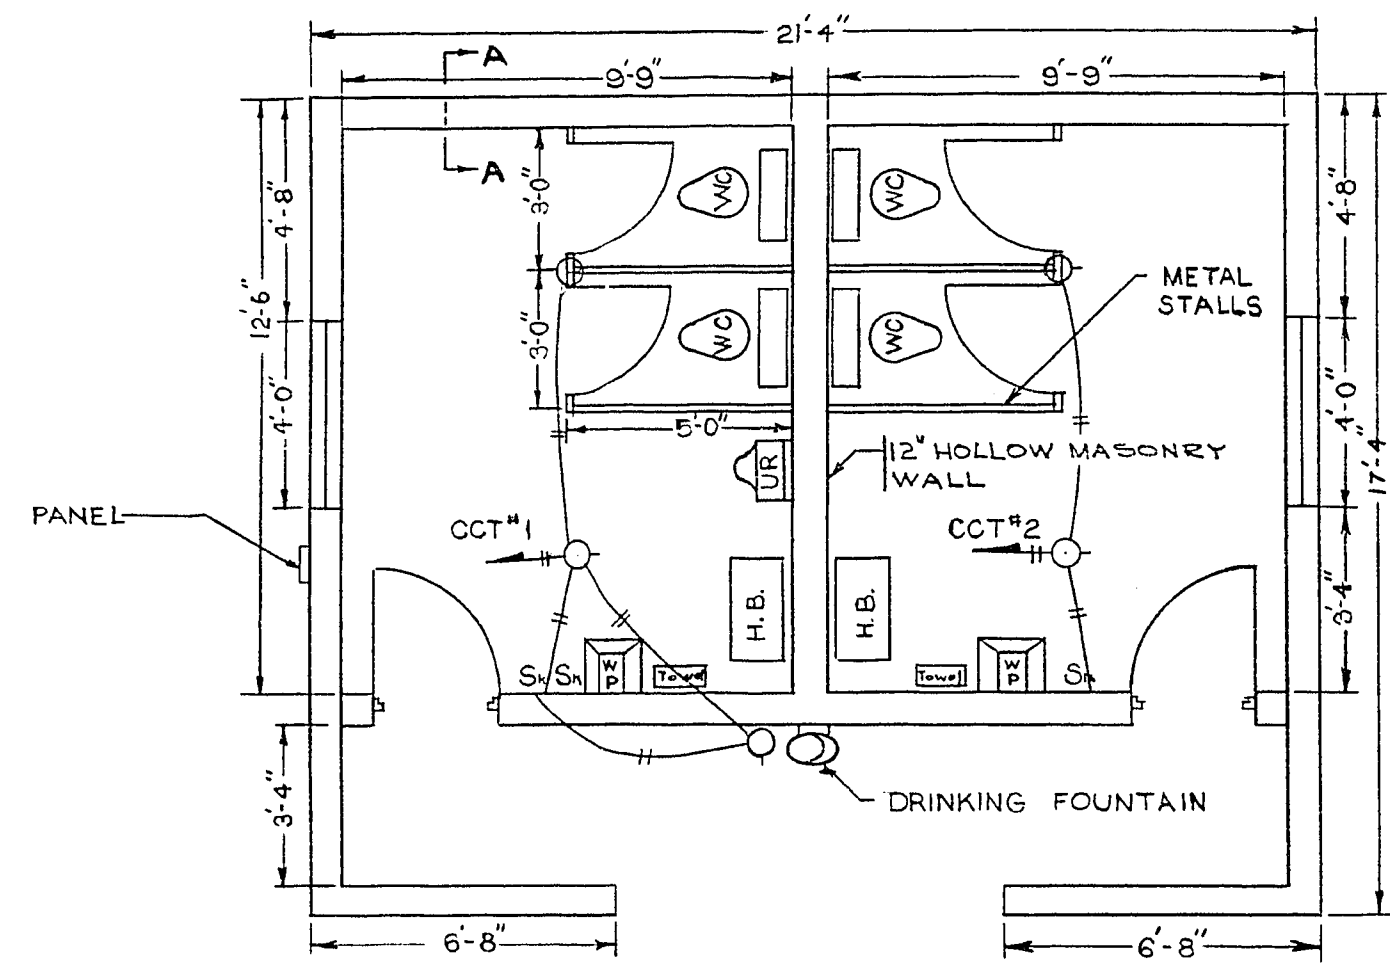


ELECTRICAL & FLOOR PLAN
SCALE - 1/4" = 1'
KEY OF SYMBOLS
○ -- ARB. SI- FORM 100 FIXTURE
⊕ -- FLUSH TUMBLER SWITCH KEY OPERATED

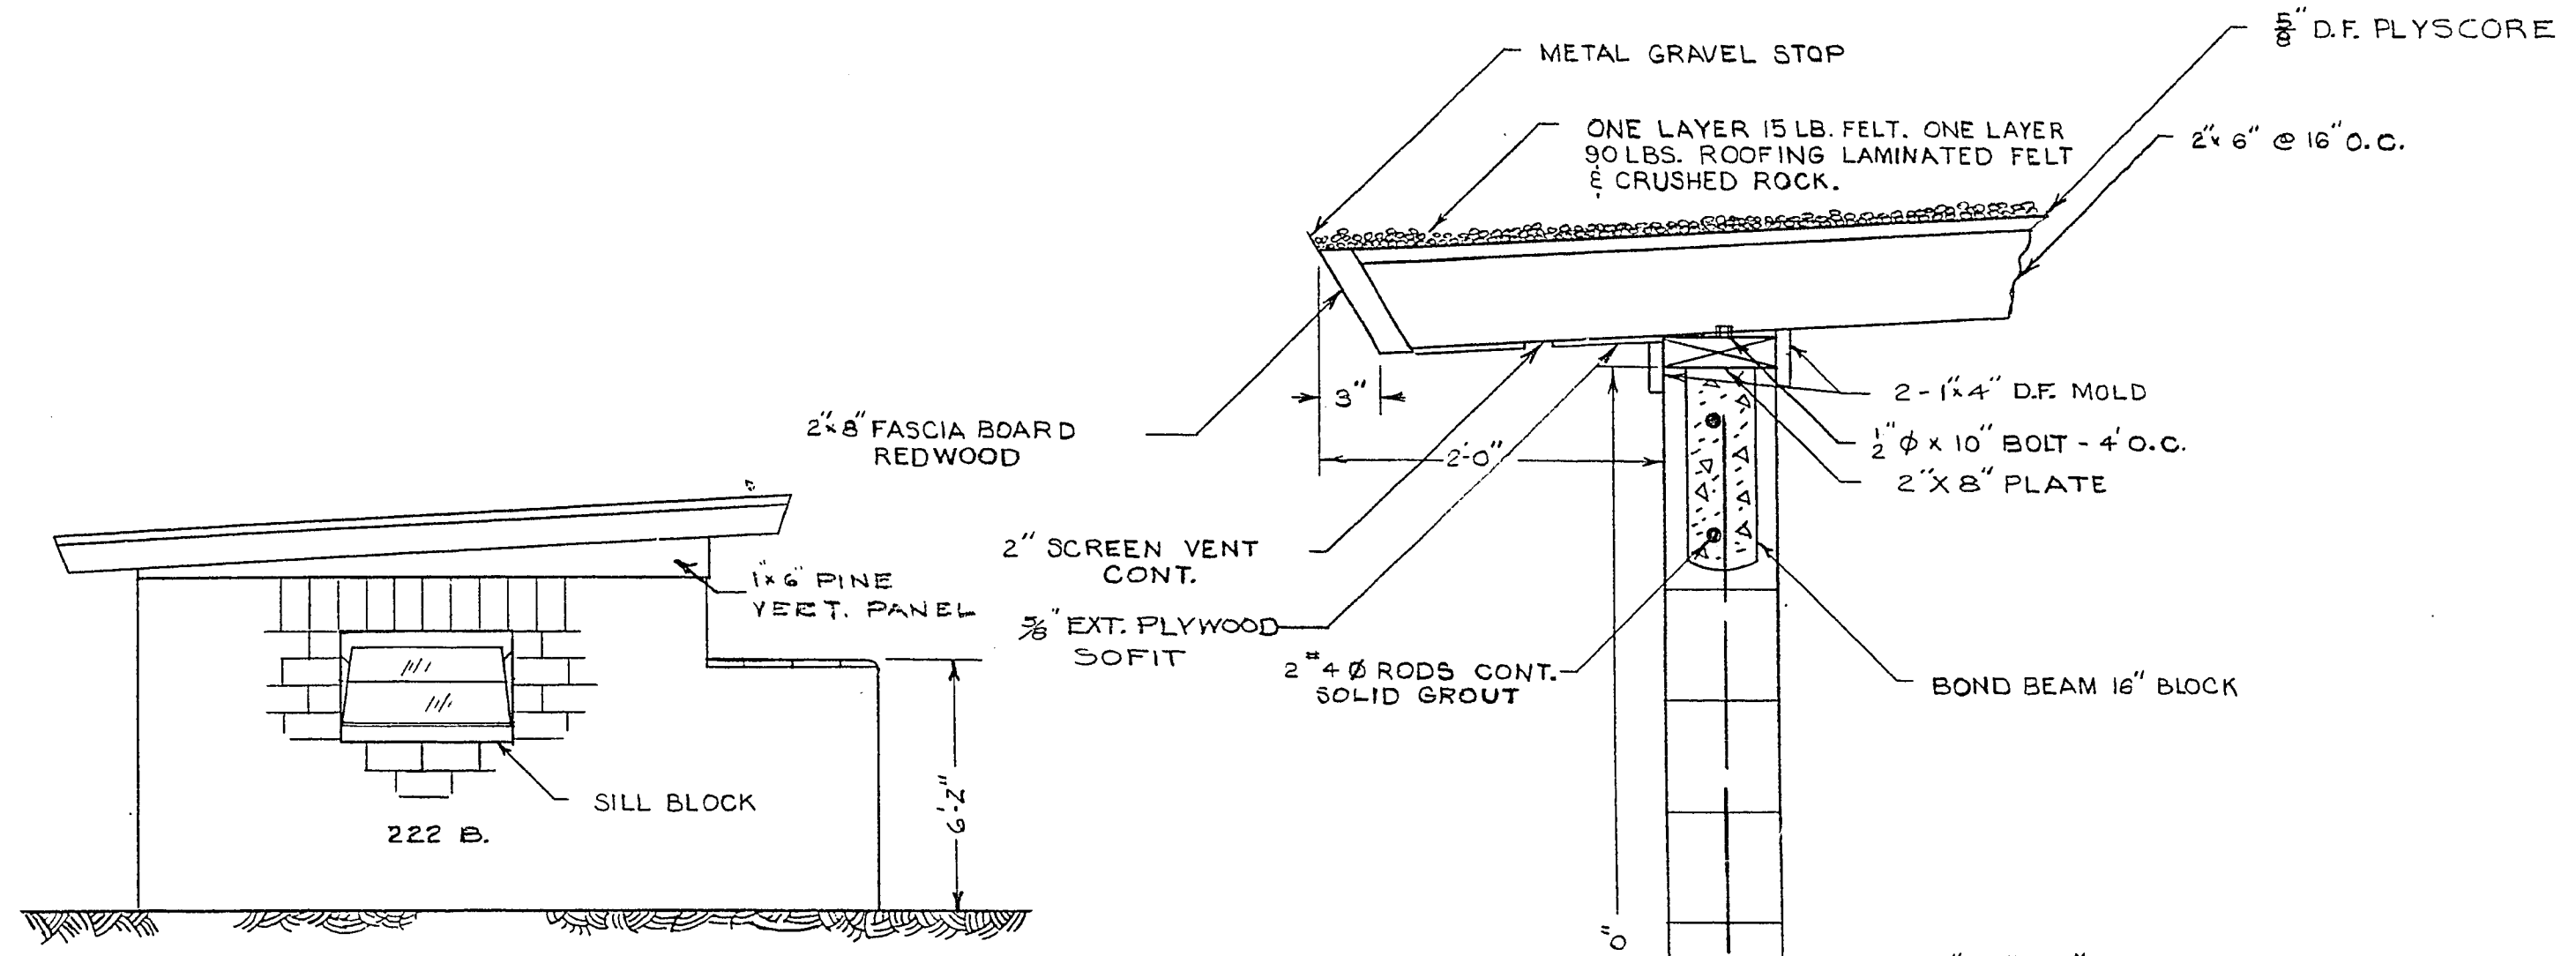


TYPICAL SIDE ELEVATION
SCALE - 1/4" = 1'

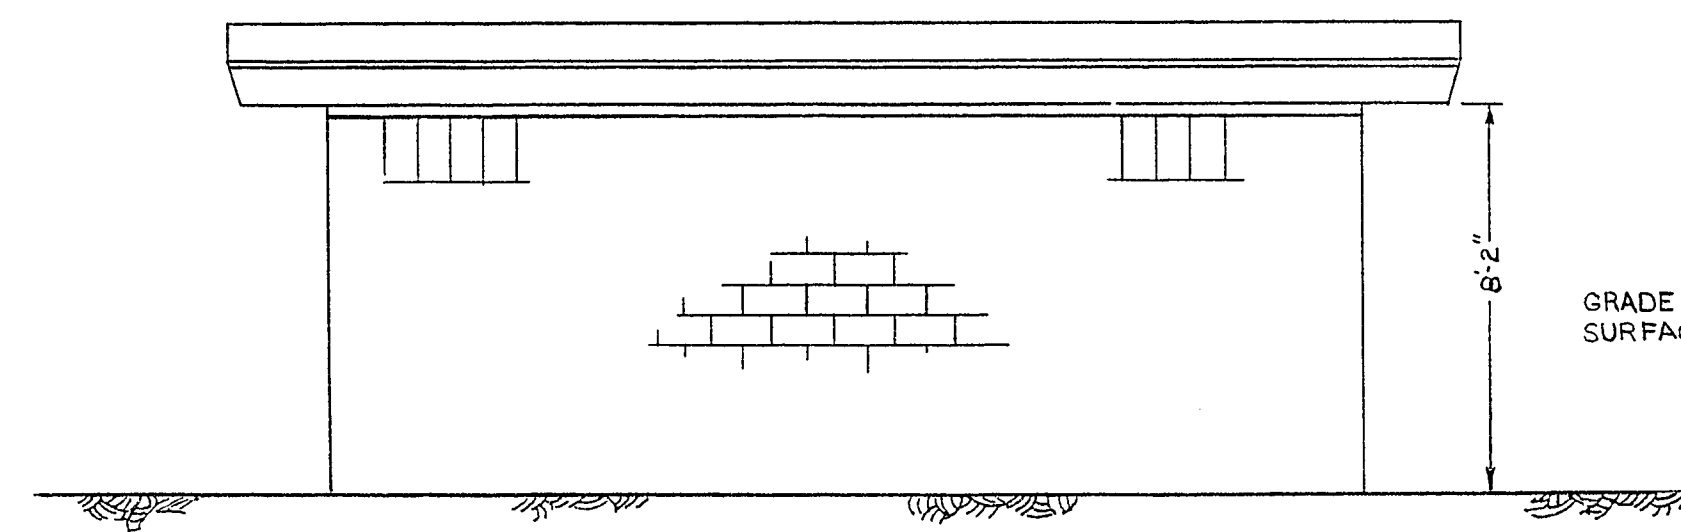


REAR ELEVATION
SCALE - 1/4" = 1'

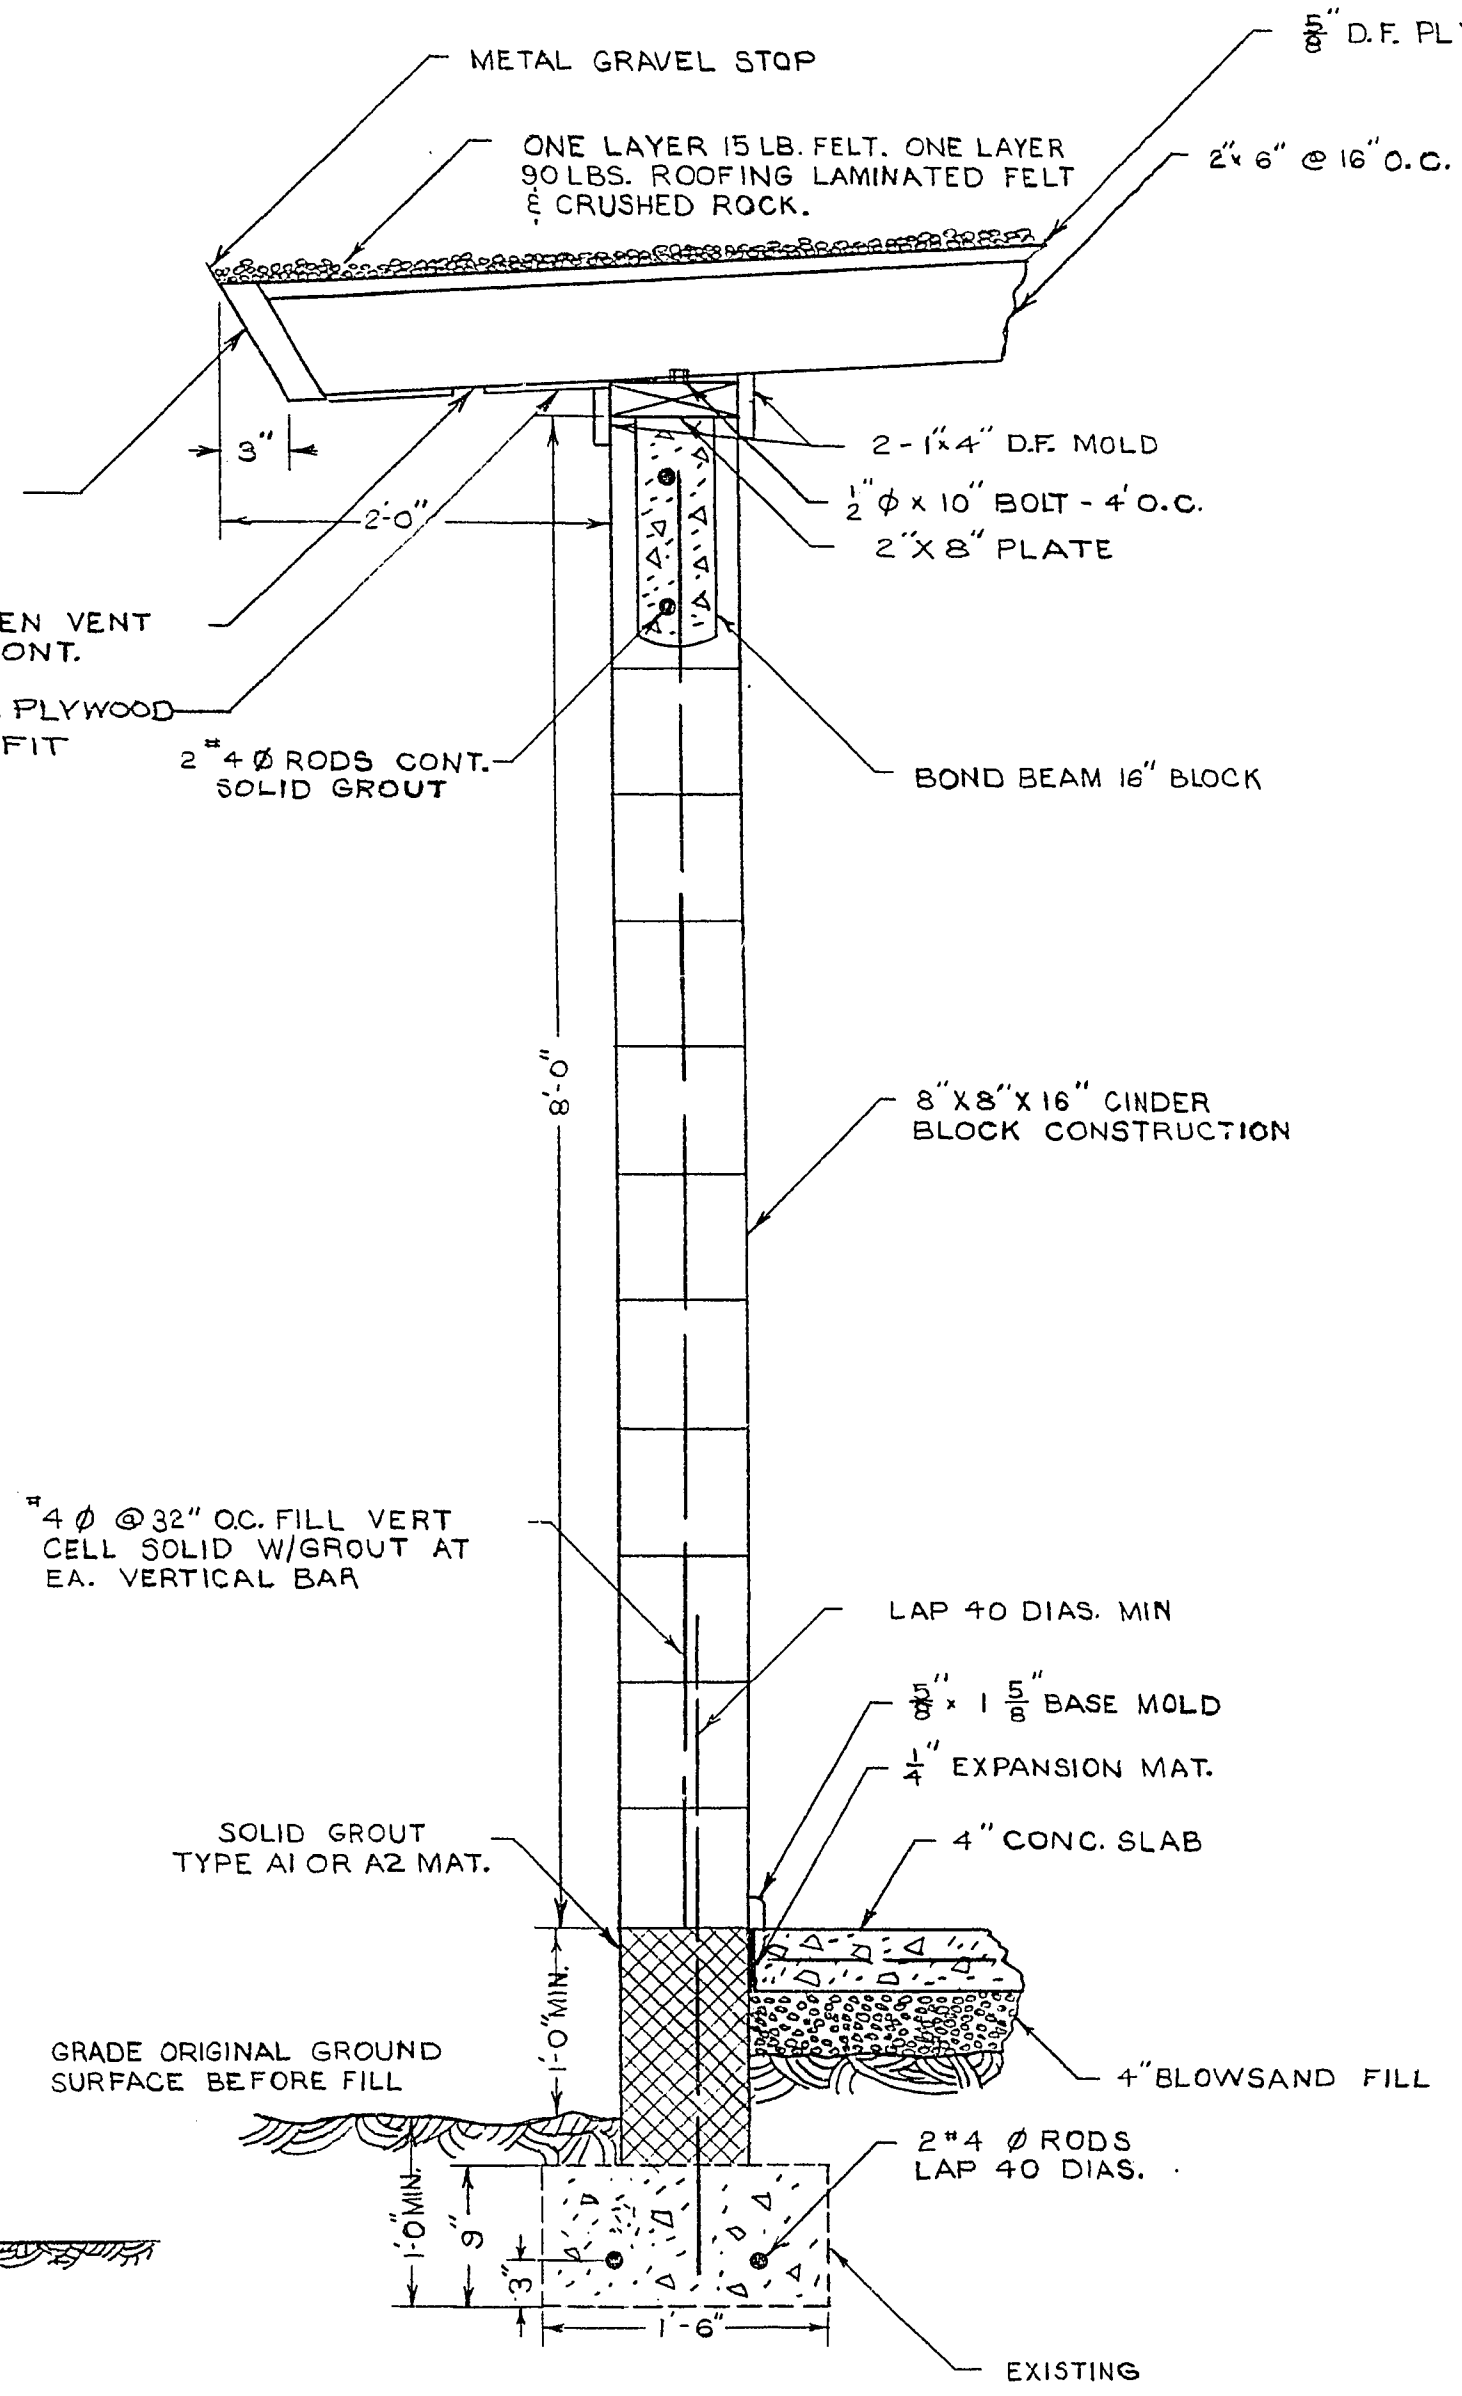

SECTION A-A
SCALE - 1" = 1'-0"


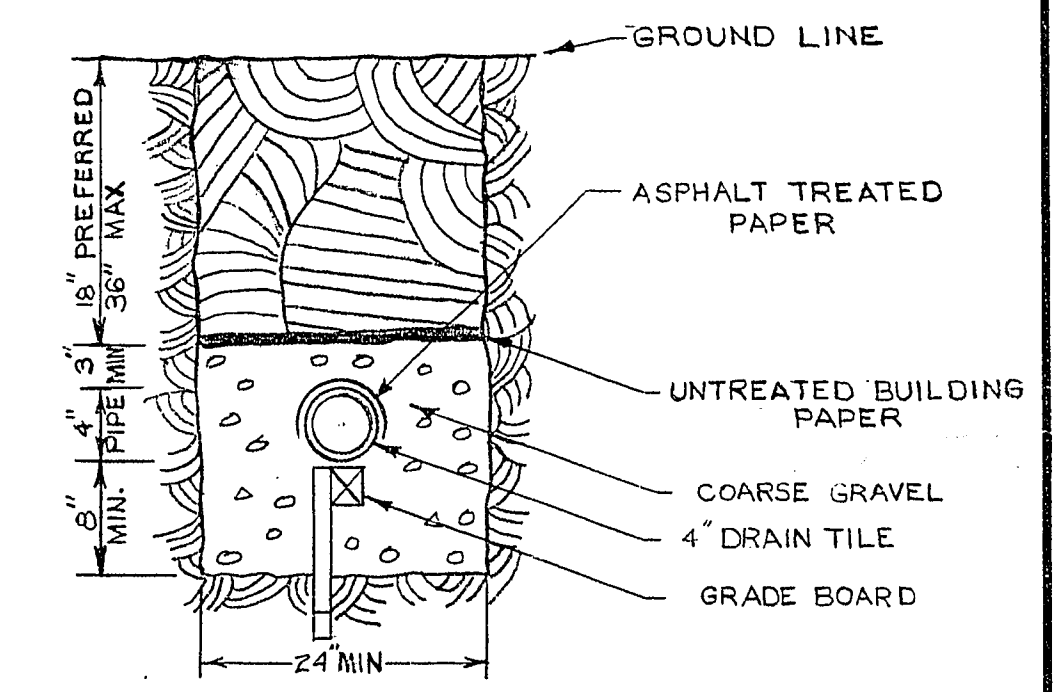


DISPOSAL TRENCH CONSTRUCTION
SCALE - 1" = 1'

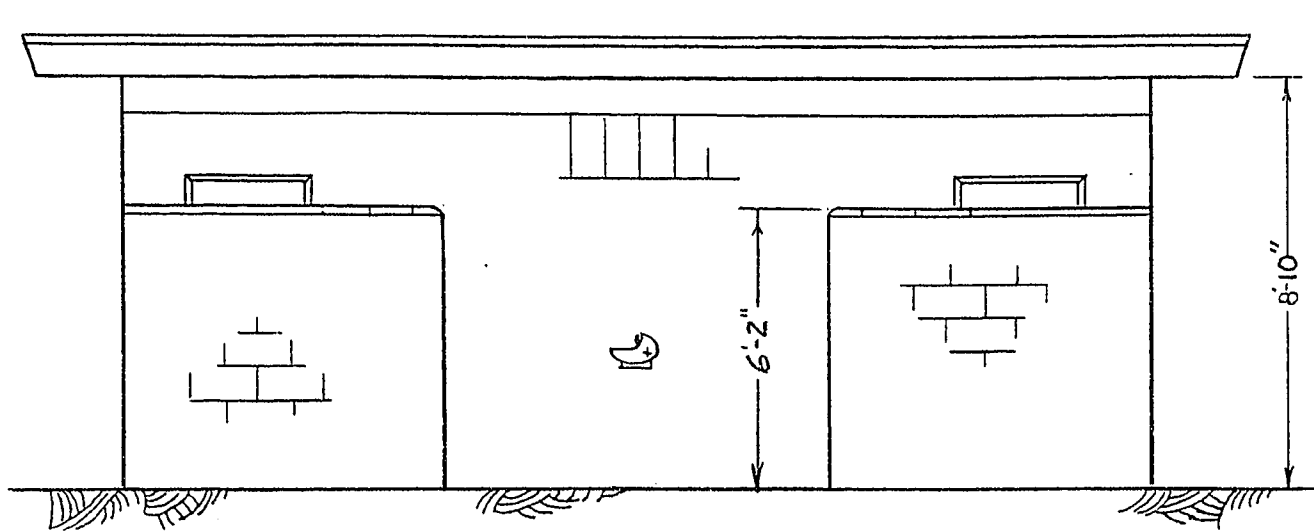

FRONT ELEVATION
SCALE - 1/4" = 1'

APPROX LOCATION PLOT
SCALE - 1" = 100'

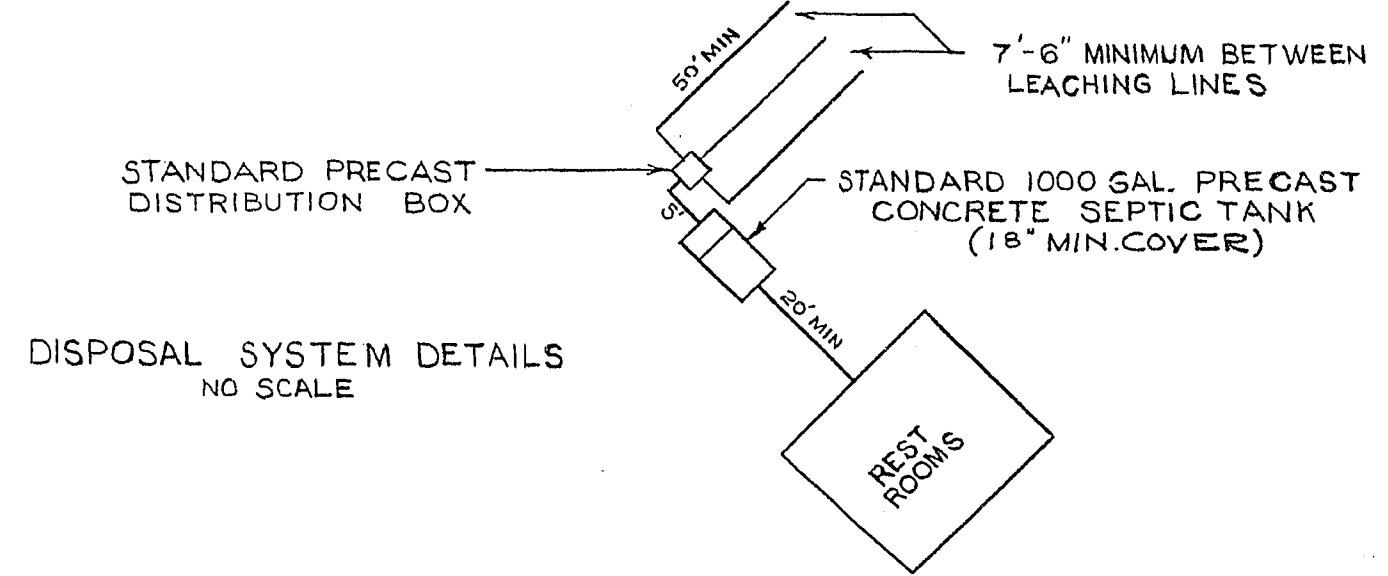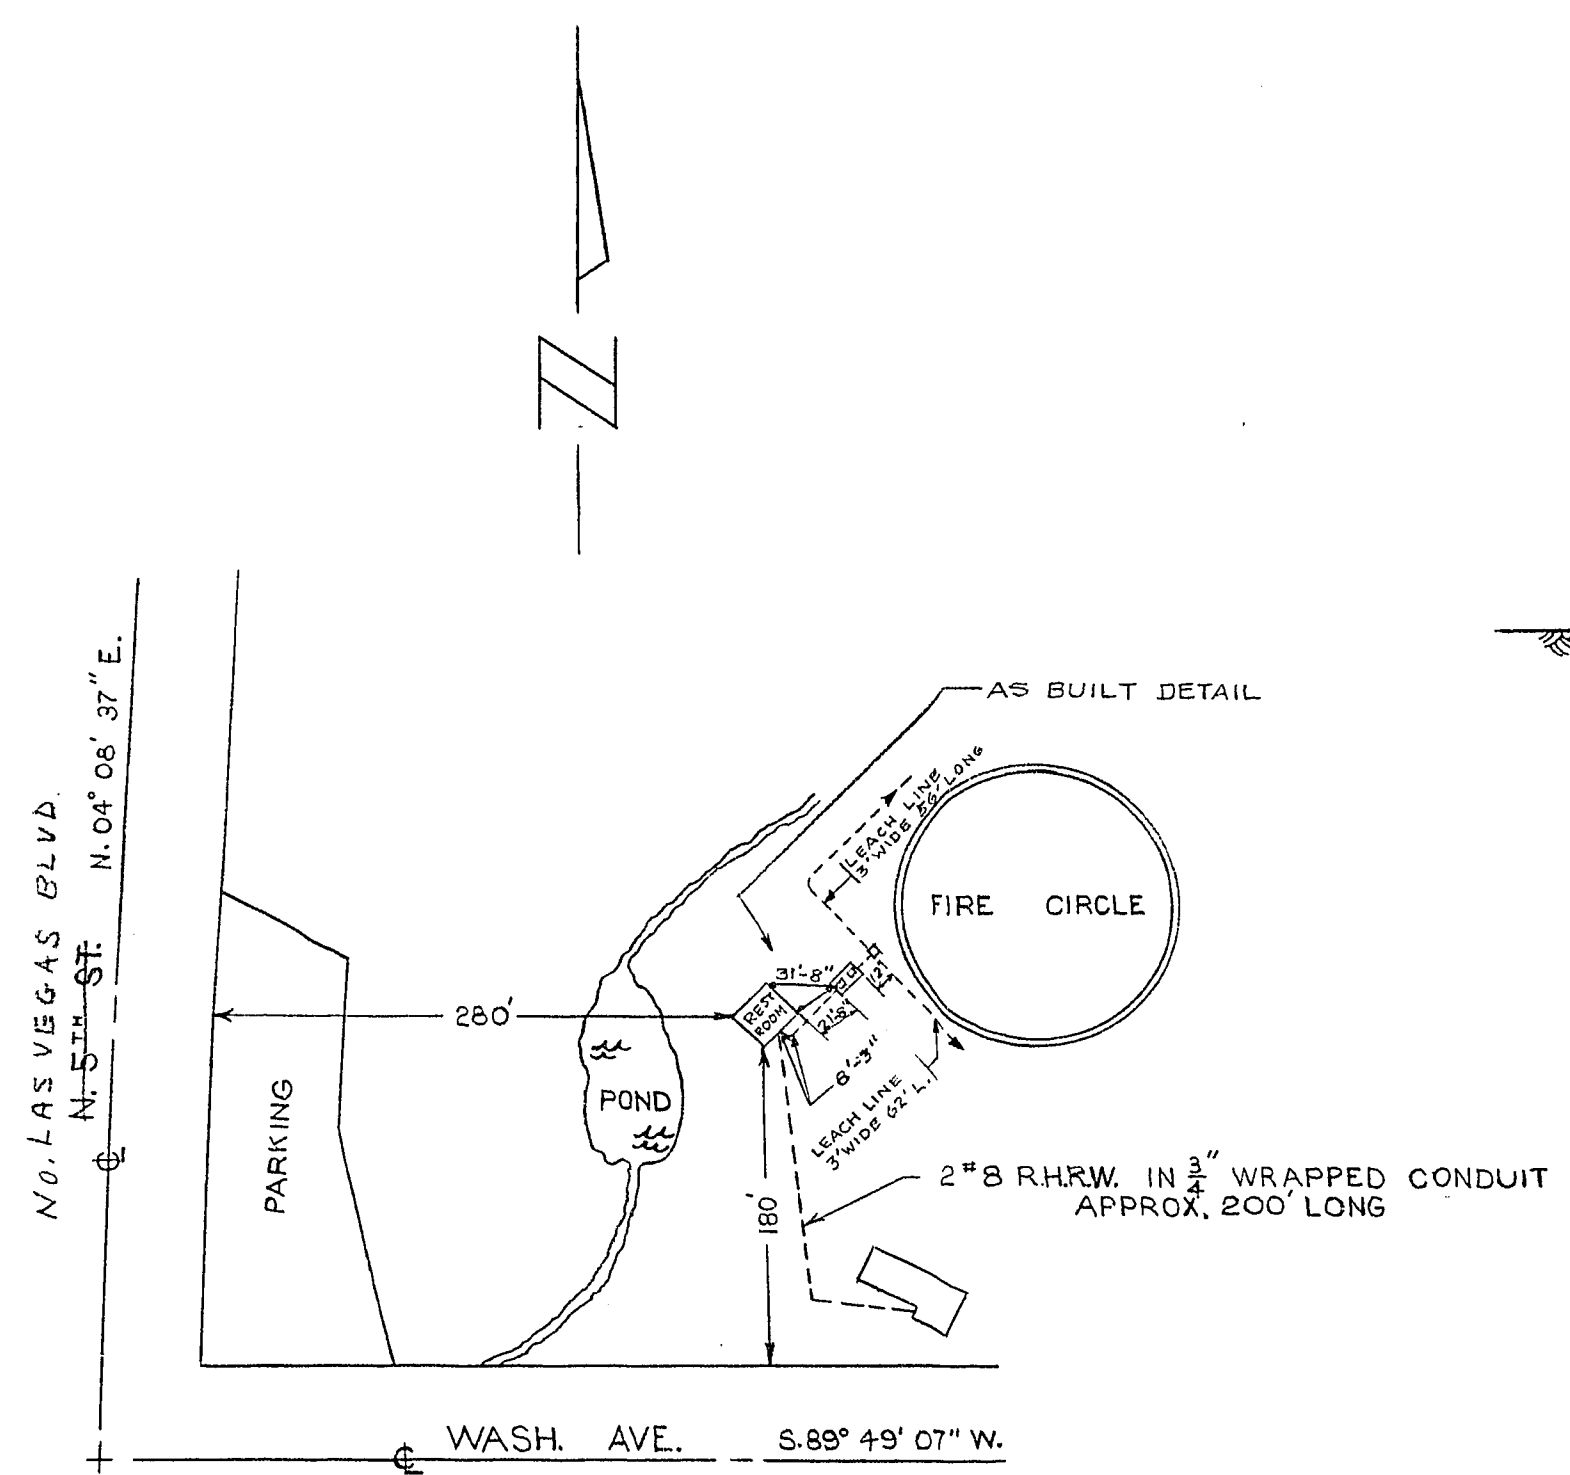

DISPOSAL SYSTEM DETAILS
NO SCALE

NOTE: ROUGH PLUMBING AND FOOTING EXISTING

REVISIONS		
NO.	BY	DESCRIPTION
1		
2		
3		
4		
5		
6		
7		
8		
9		
10		

CITY OF LAS VEGAS NEVADA ENGINEERING DEPT.			
LIONS CLUB PARK REST ROOMS			
DESIGNED BY	DATE	SCALE	AS NOTED
J. MAST			
DRAWN BY	DATE	FIELD BOOK NO.	NONE
RE.W.	9/9/57		
CHECKED BY	DATE	WORK ORDER NO.	1239
		DRAWING NO.	650.9-VI
APPROVED	DATE		
W.B. Whiting	9/17/57		
CITY ENGR.			