

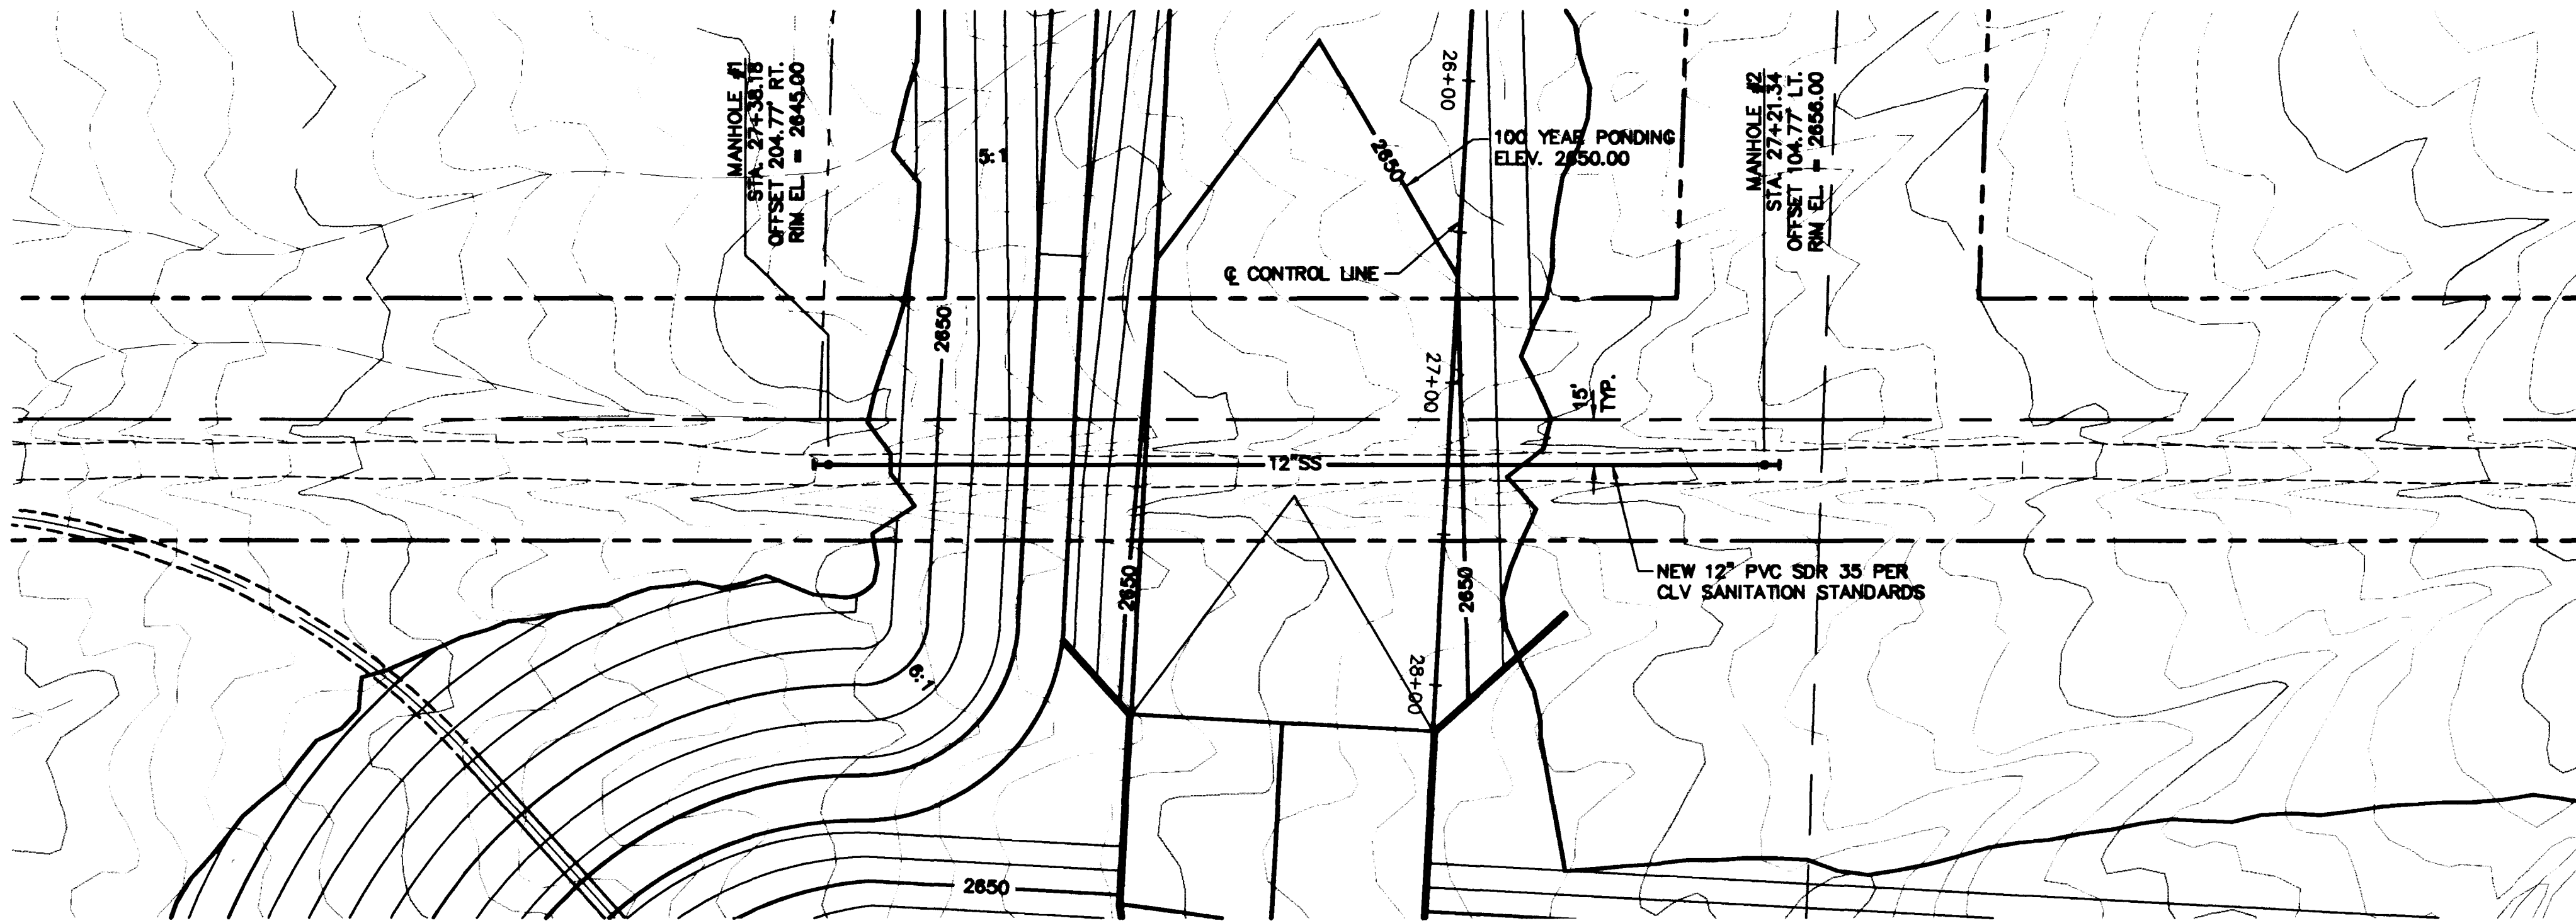


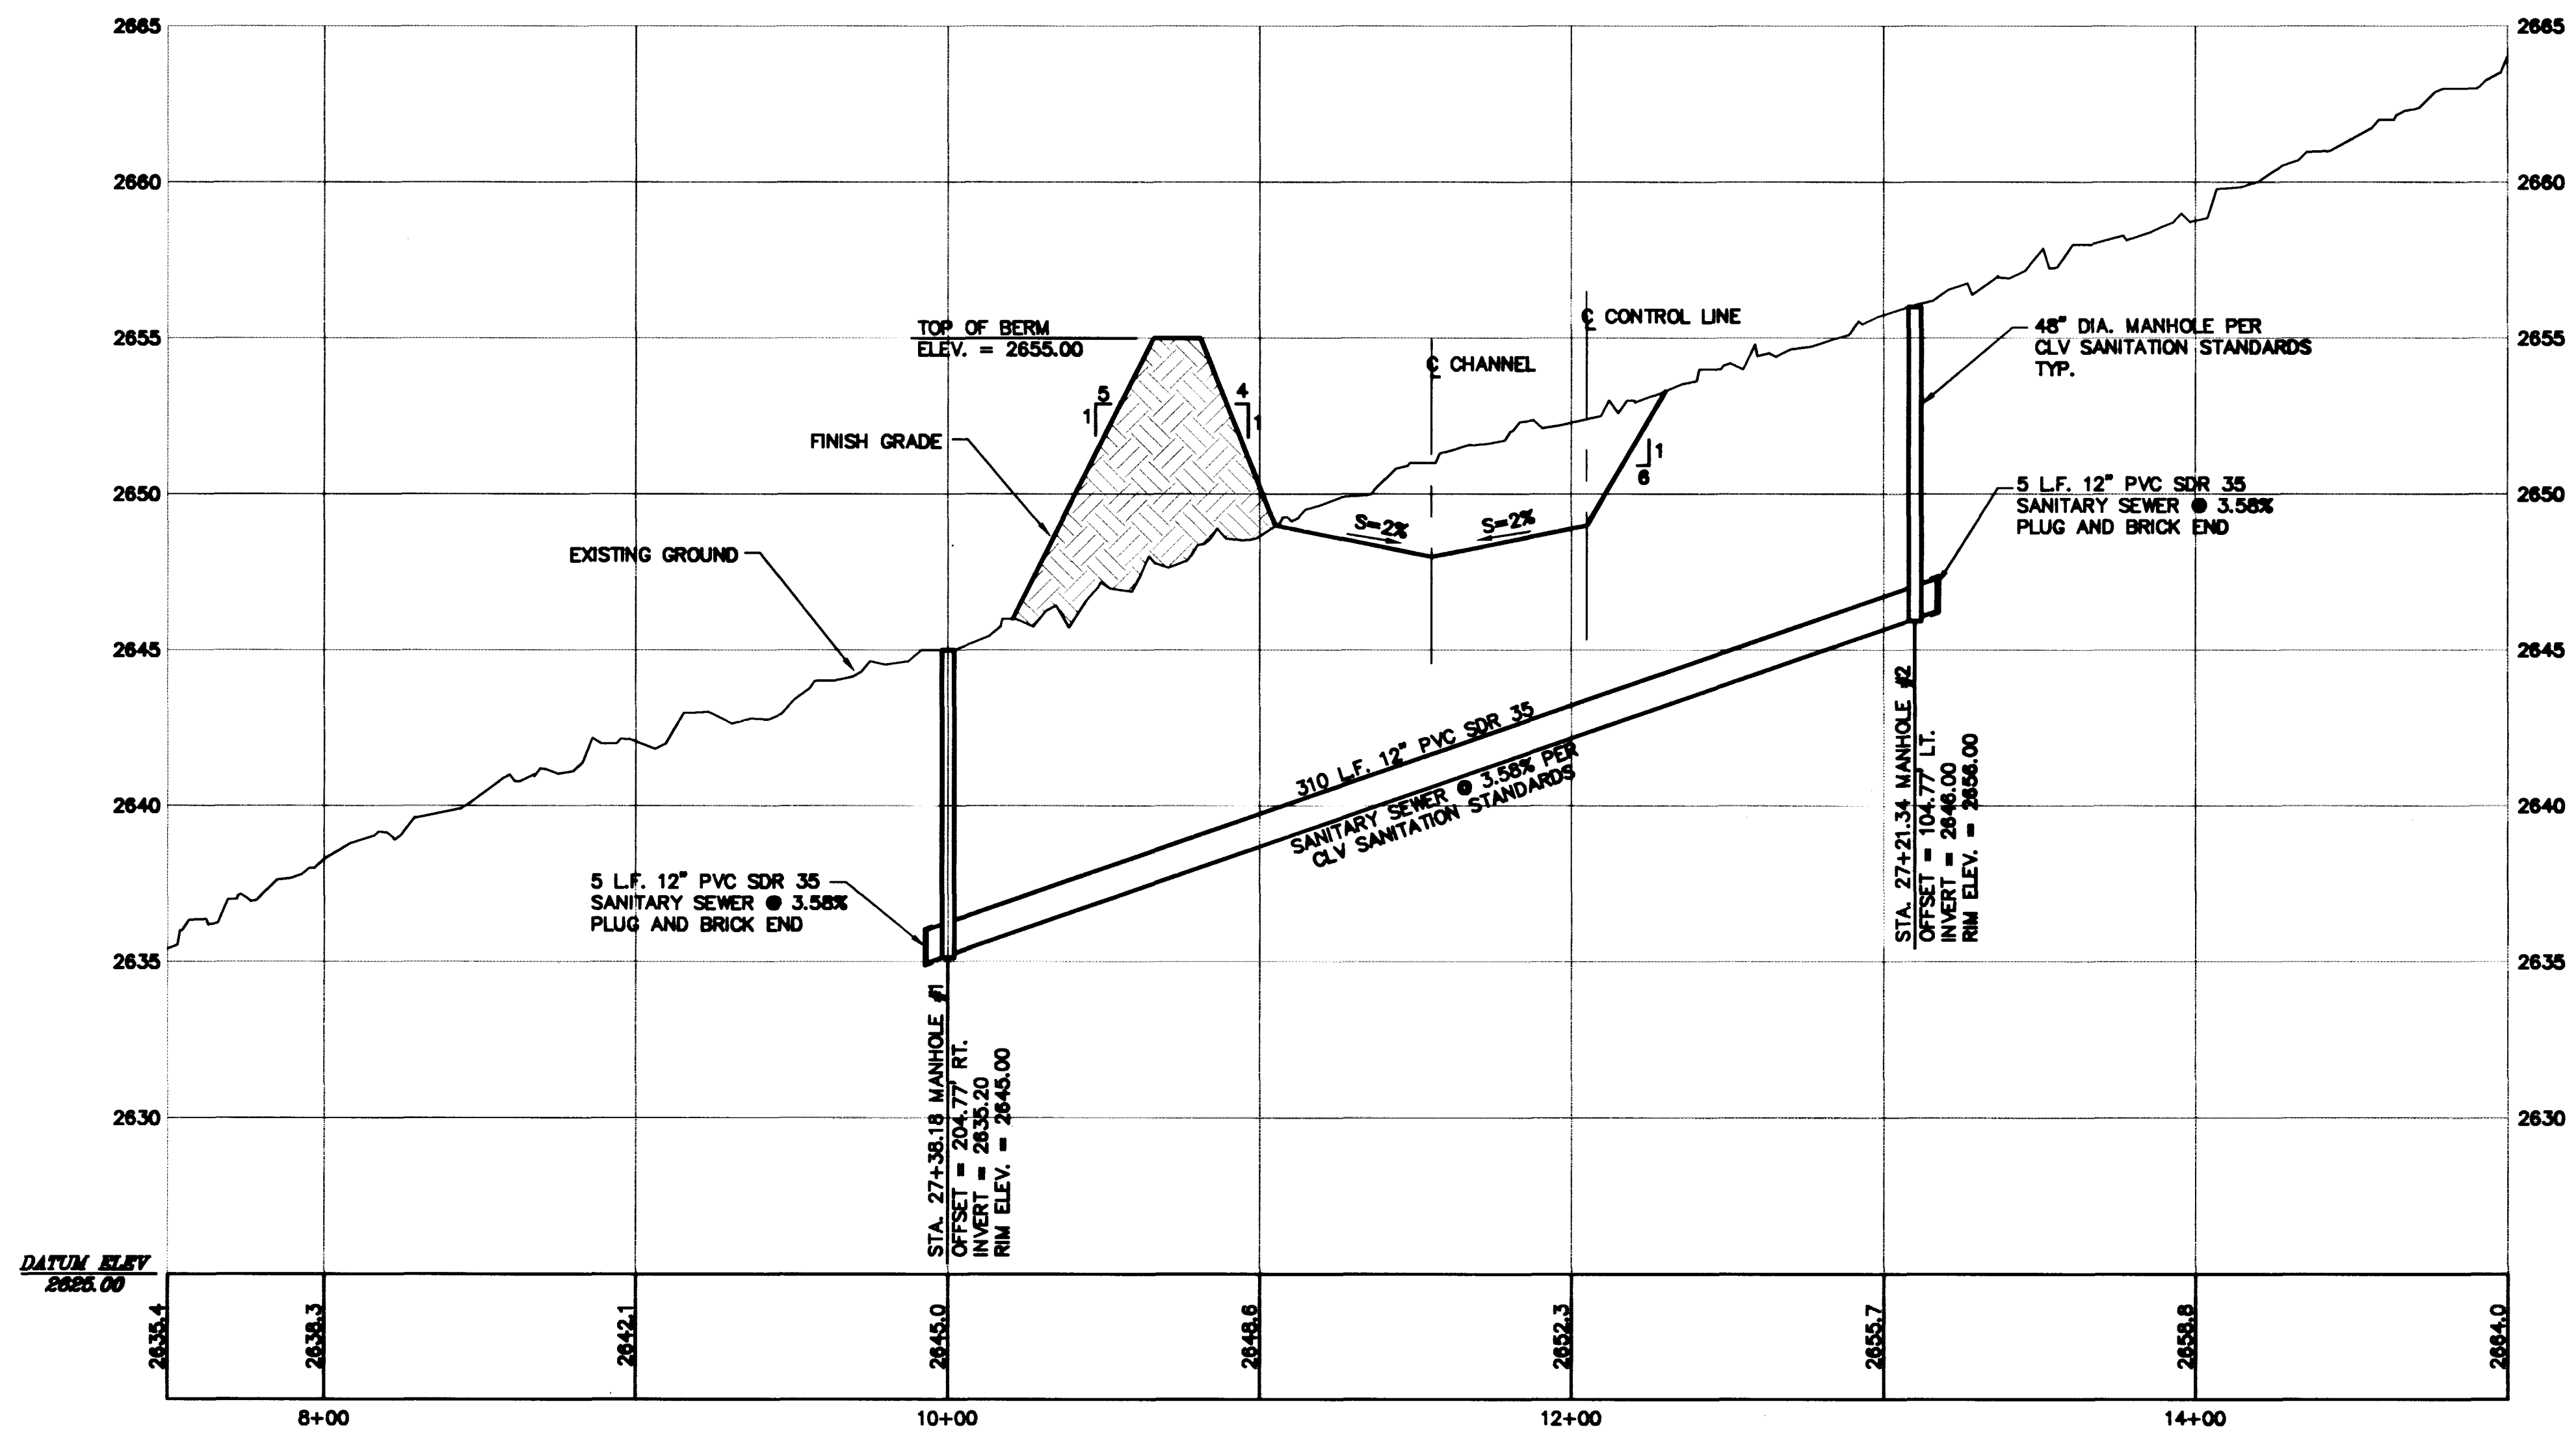


RECORD DRAWING

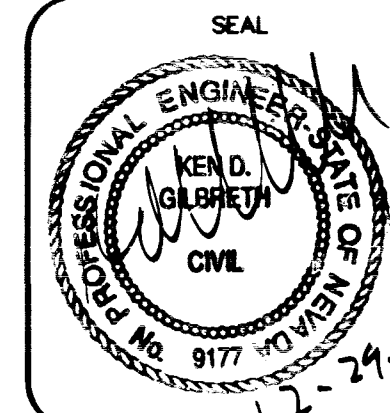

WO NO. 4340  
BY SJF  
DATE 12/27/94  
HORIZ. 1"=40'  
SCALE VERT. 1"=4'  
SHEET 12B OF 43 SHEETS



TITLE PLAN AND PROFILE  
SANITARY SEWER LINE  
PROJECT LONE MOUNTAIN DETENTION BASIN  
FLOOD CONTROL IMPROVEMENTS-PHASE 1

CITY OF LAS VEGAS  
CLARK COUNTY, NEVADA

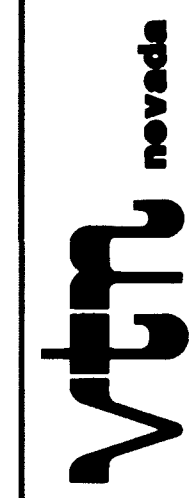

CONSULTING ENGINEERS • PLANNERS • LAND SURVEYORS  
2727 SOUTH RAINBOW BOULEVARD  
LAS VEGAS, NEVADA 89102-5148 PHONE (702) 873-7550 FAX (702) 362-2597

| REV | DATE | BY | REVISION |
|-----|------|----|----------|
| 1   |      |    |          |
| 2   |      |    |          |
| 3   |      |    |          |
| 4   |      |    |          |
| 5   |      |    |          |
| 6   |      |    |          |
| 7   |      |    |          |
| 8   |      |    |          |
| 9   |      |    |          |
| 10  |      |    |          |

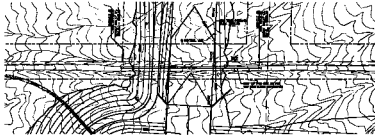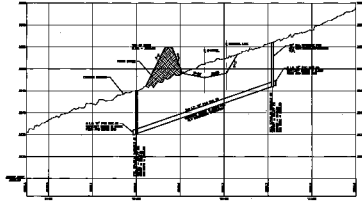

RECORD DRAWING

12B

DATE: 10/1/88  
BY: JWB  
CHECKED: JWB



PLAN AND PROFILE  
SANITARY SEWER LINE  
TOWN OF MOUNTAIN VIEW, GEORGIA  
PLANNED COMMUNITY DEVELOPMENT—PHASE 1

OFFICE OF THE ENGINEER  
PLANNED COMMUNITY DEVELOPMENT  
JWB

CONSTRUCTION: EXISTING & PROPOSED  
CONSTRUCTION: EXISTING & PROPOSED  
CONSTRUCTION: EXISTING & PROPOSED