

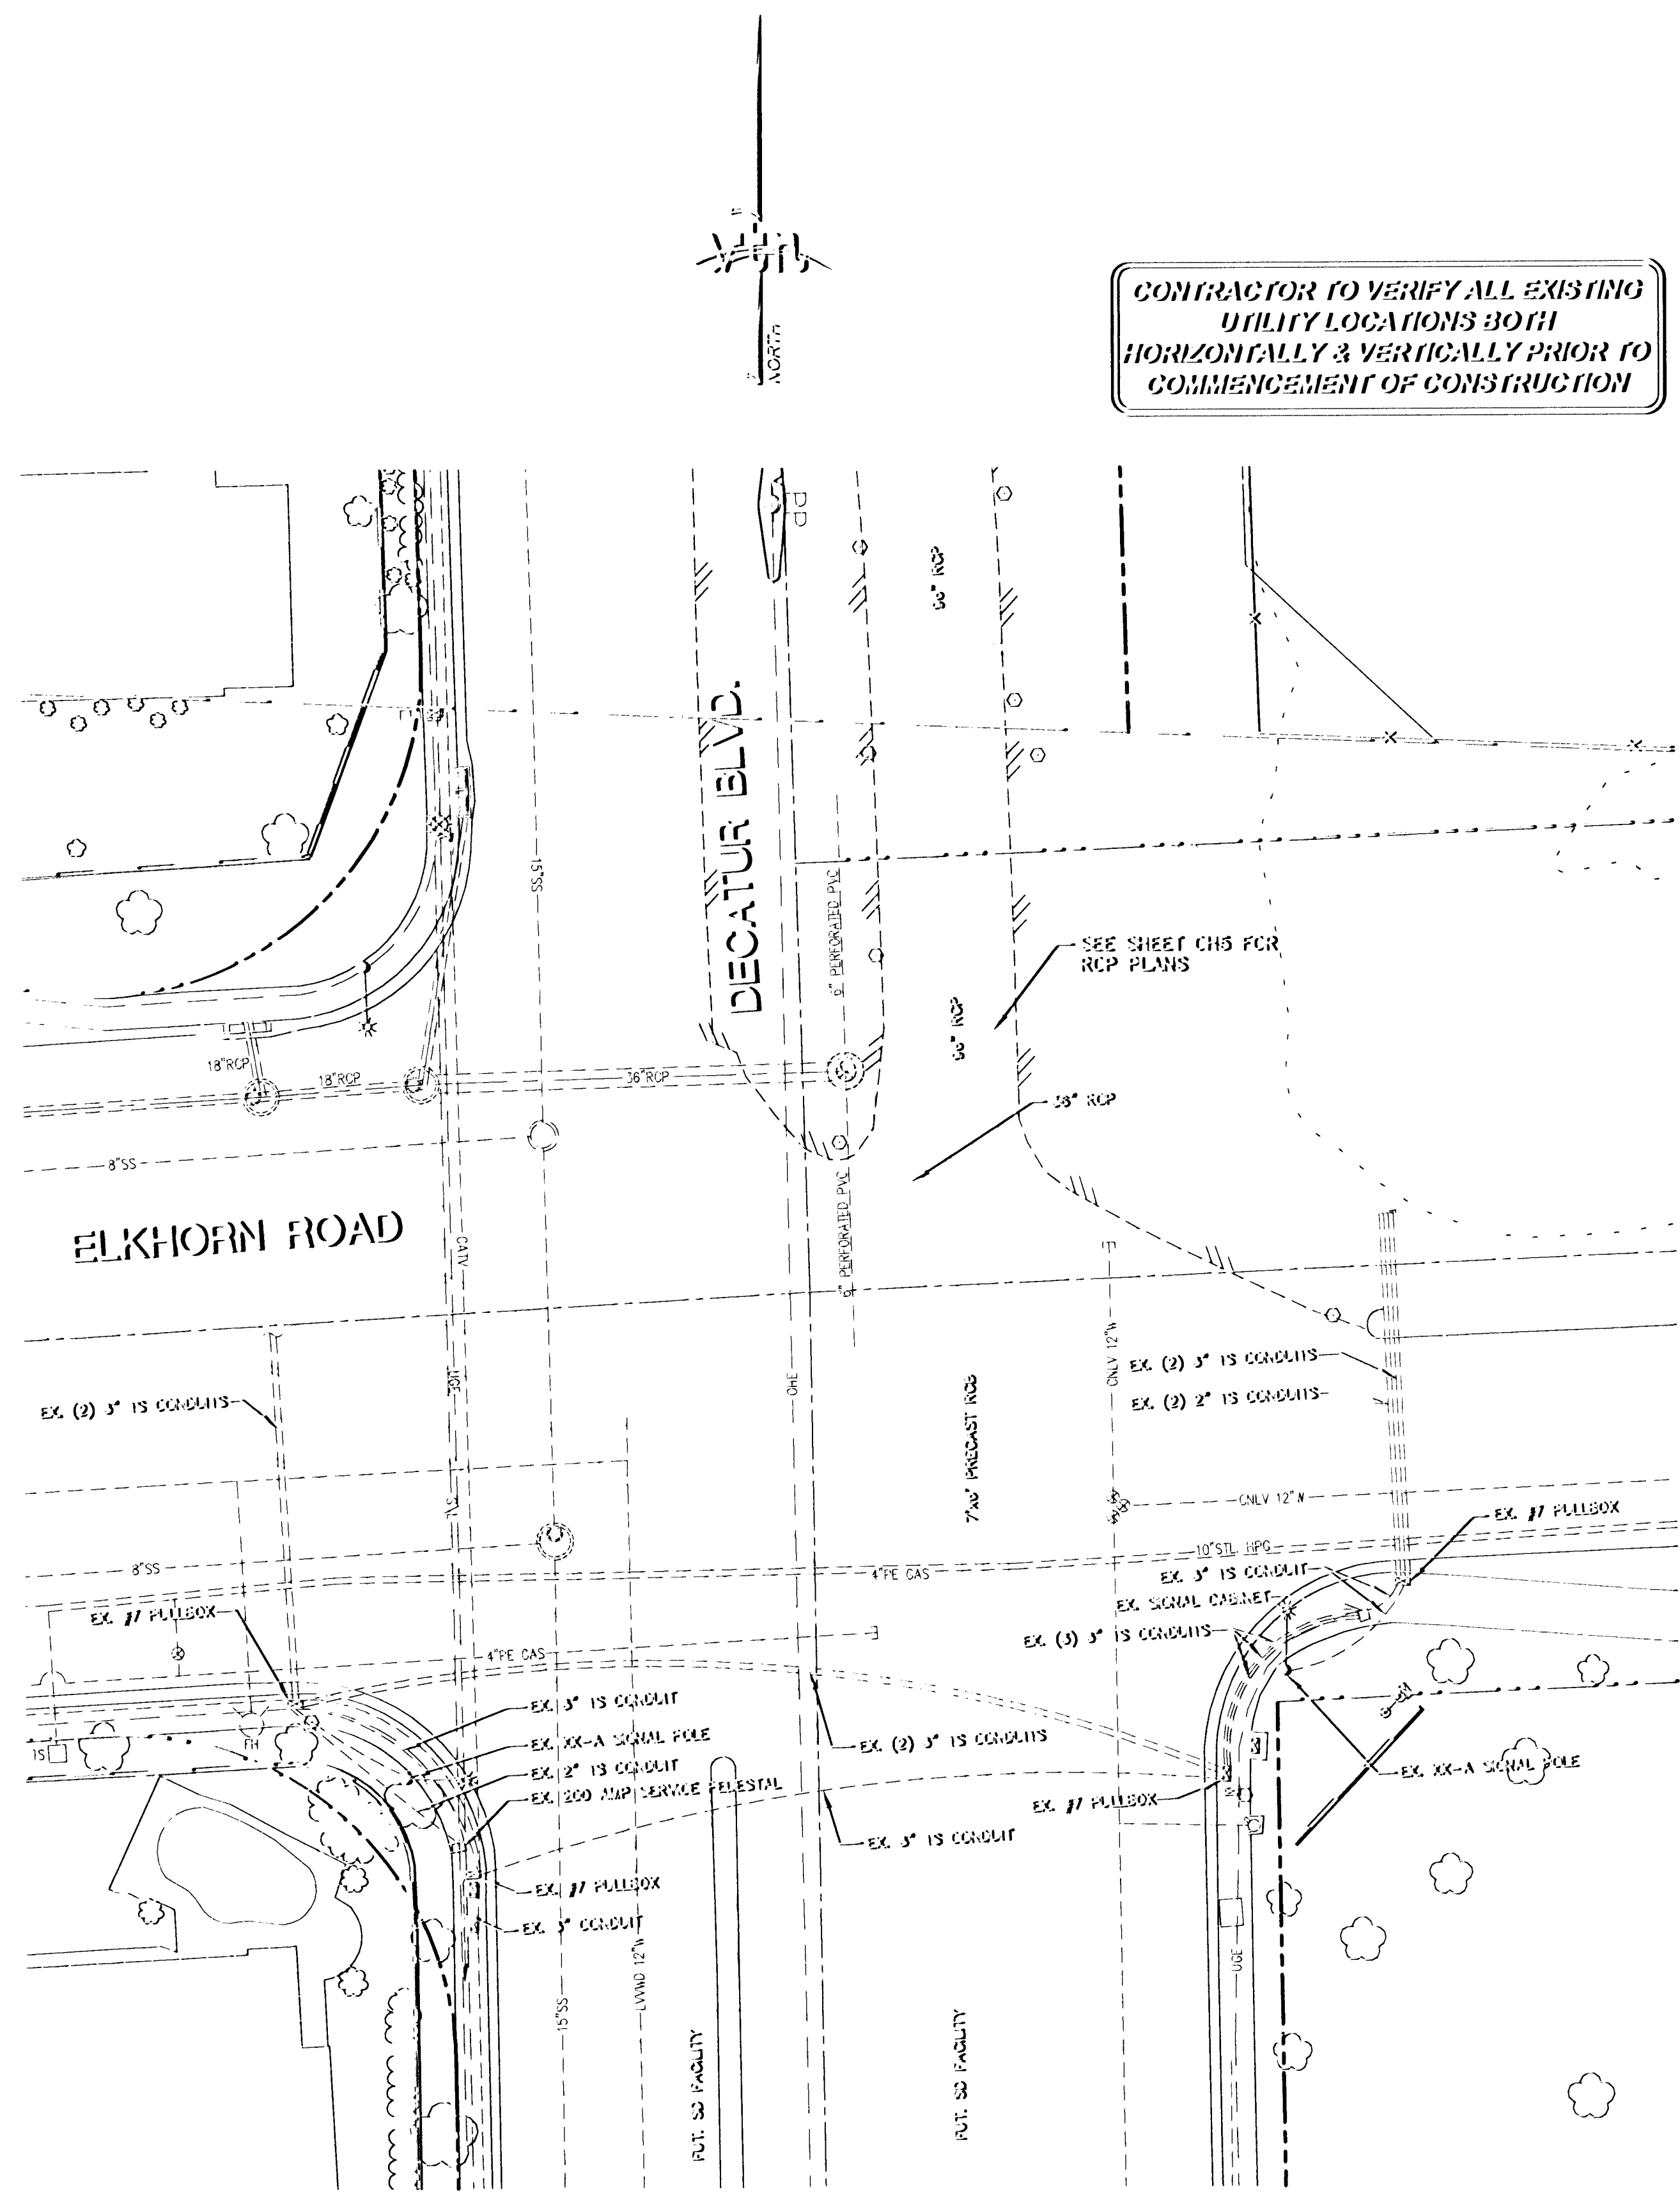


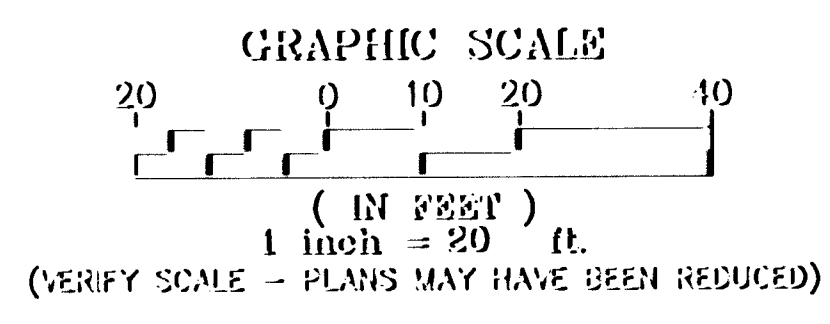

CONTRACTOR TO VERIFY ALL EXISTING UTILITY LOCATIONS BOTH HORIZONTALLY & VERTICALLY PRIOR TO COMMENCEMENT OF CONSTRUCTION

NOTE:
PROTECT EXISTING TRAFFIC SIGNAL AND INTERCONNECT CONDUITS IN PLACE. REPAIR AND/OR REPLACE CONDUITS DAMAGED DURING CONSTRUCTION.

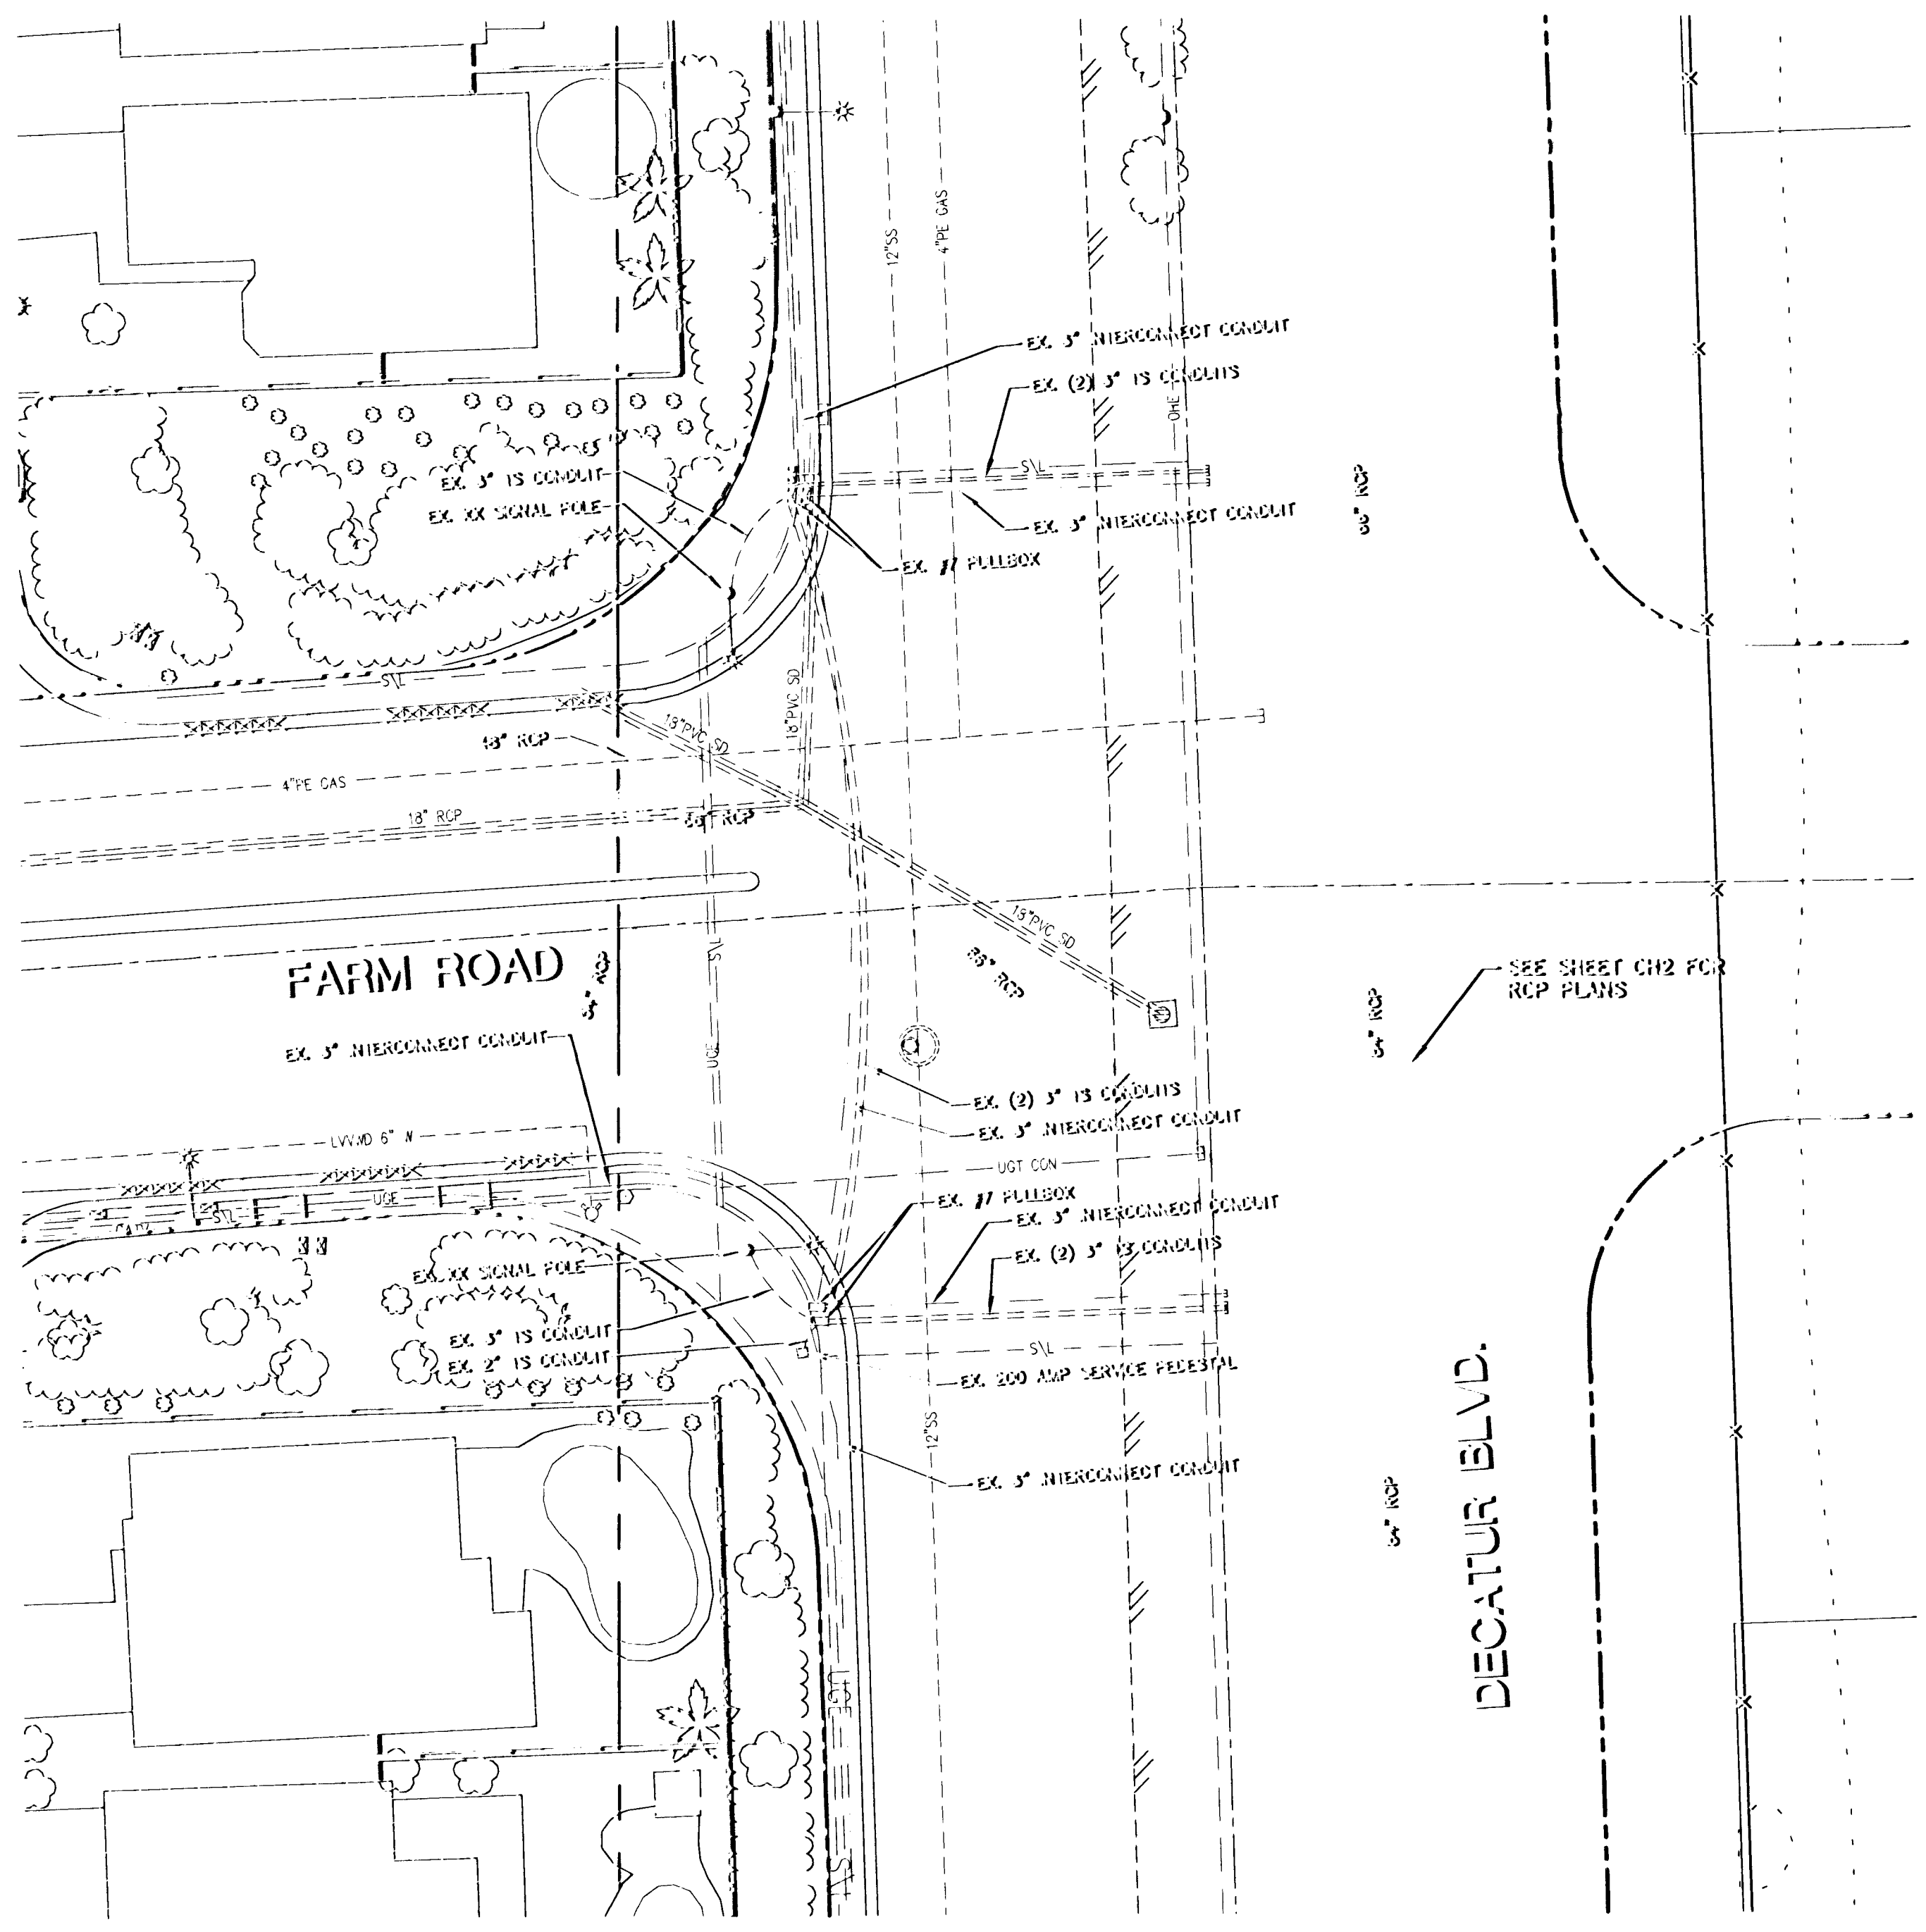

NO ONE EVER DID POWER LINE CONTACT. IT'S COSYLY

Call before you Overhead

1-702-227-2929

REPAIR OR REPLACE TO SAFETY SERVICES DEPARTMENT

ONE CALL 811

1-800-4-A-HEAD

1-800-455-4511

113766

#27037

	UTILITY PLAN		PUBLIC WORKS DEPARTMENT 2227 SOUTH HAWKINS BOULEVARD LAS VEGAS, NV 89102 TEL: 702-258-4672 FAX: 702-258-4672 WEB SITE: WWW.PWDV.NV.GOV
	LAS VEGAS WASH. MIDDLE BRANCH DECATUR BOULEVARD ELKHORN ROAD TO INTERSECTION SAUS DRIVE		REV. DATE BY _____ _____ _____
	DRAIN BY: 06/06/2006 DESIGNED BY: VLN CHECKED BY: VLN PROJECT NO: 08/09/2006 SCALE: HORIZ. 1"=40' VERT. 1"=20'	SHEET 11 OF 25 SHEETS DRAWING NO. 731-37-1	
	11/3/03		