



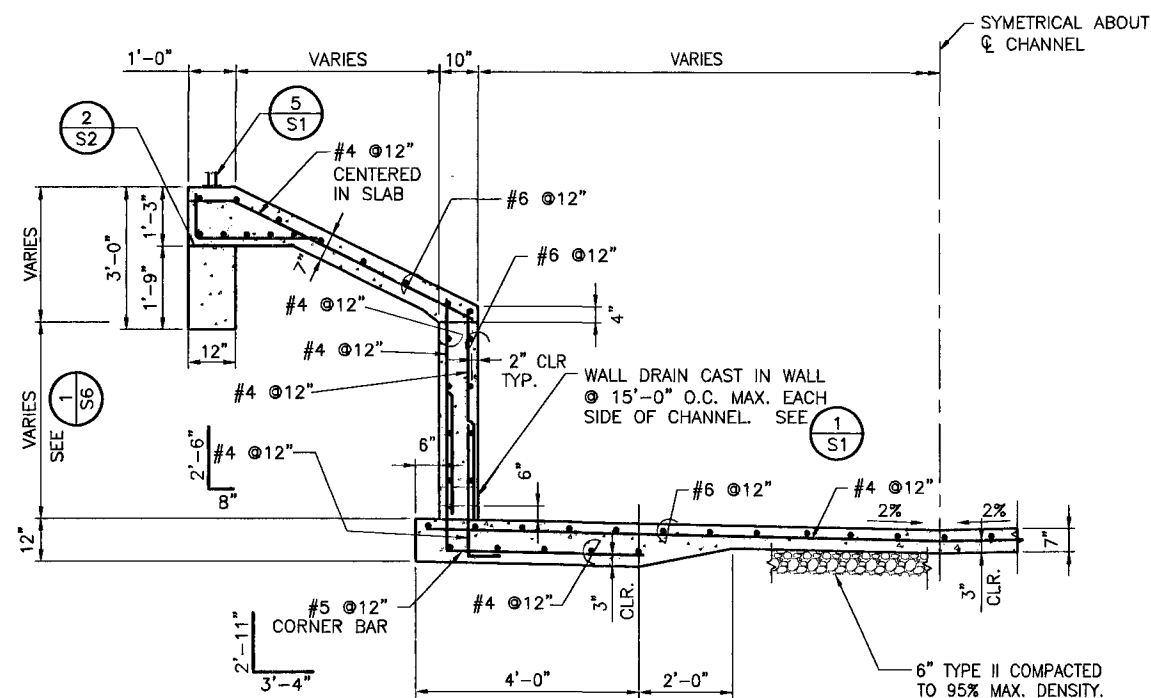

TRANSITION CHANNEL SECTION

SCALE: 1/2"=1'-0"

A
S6

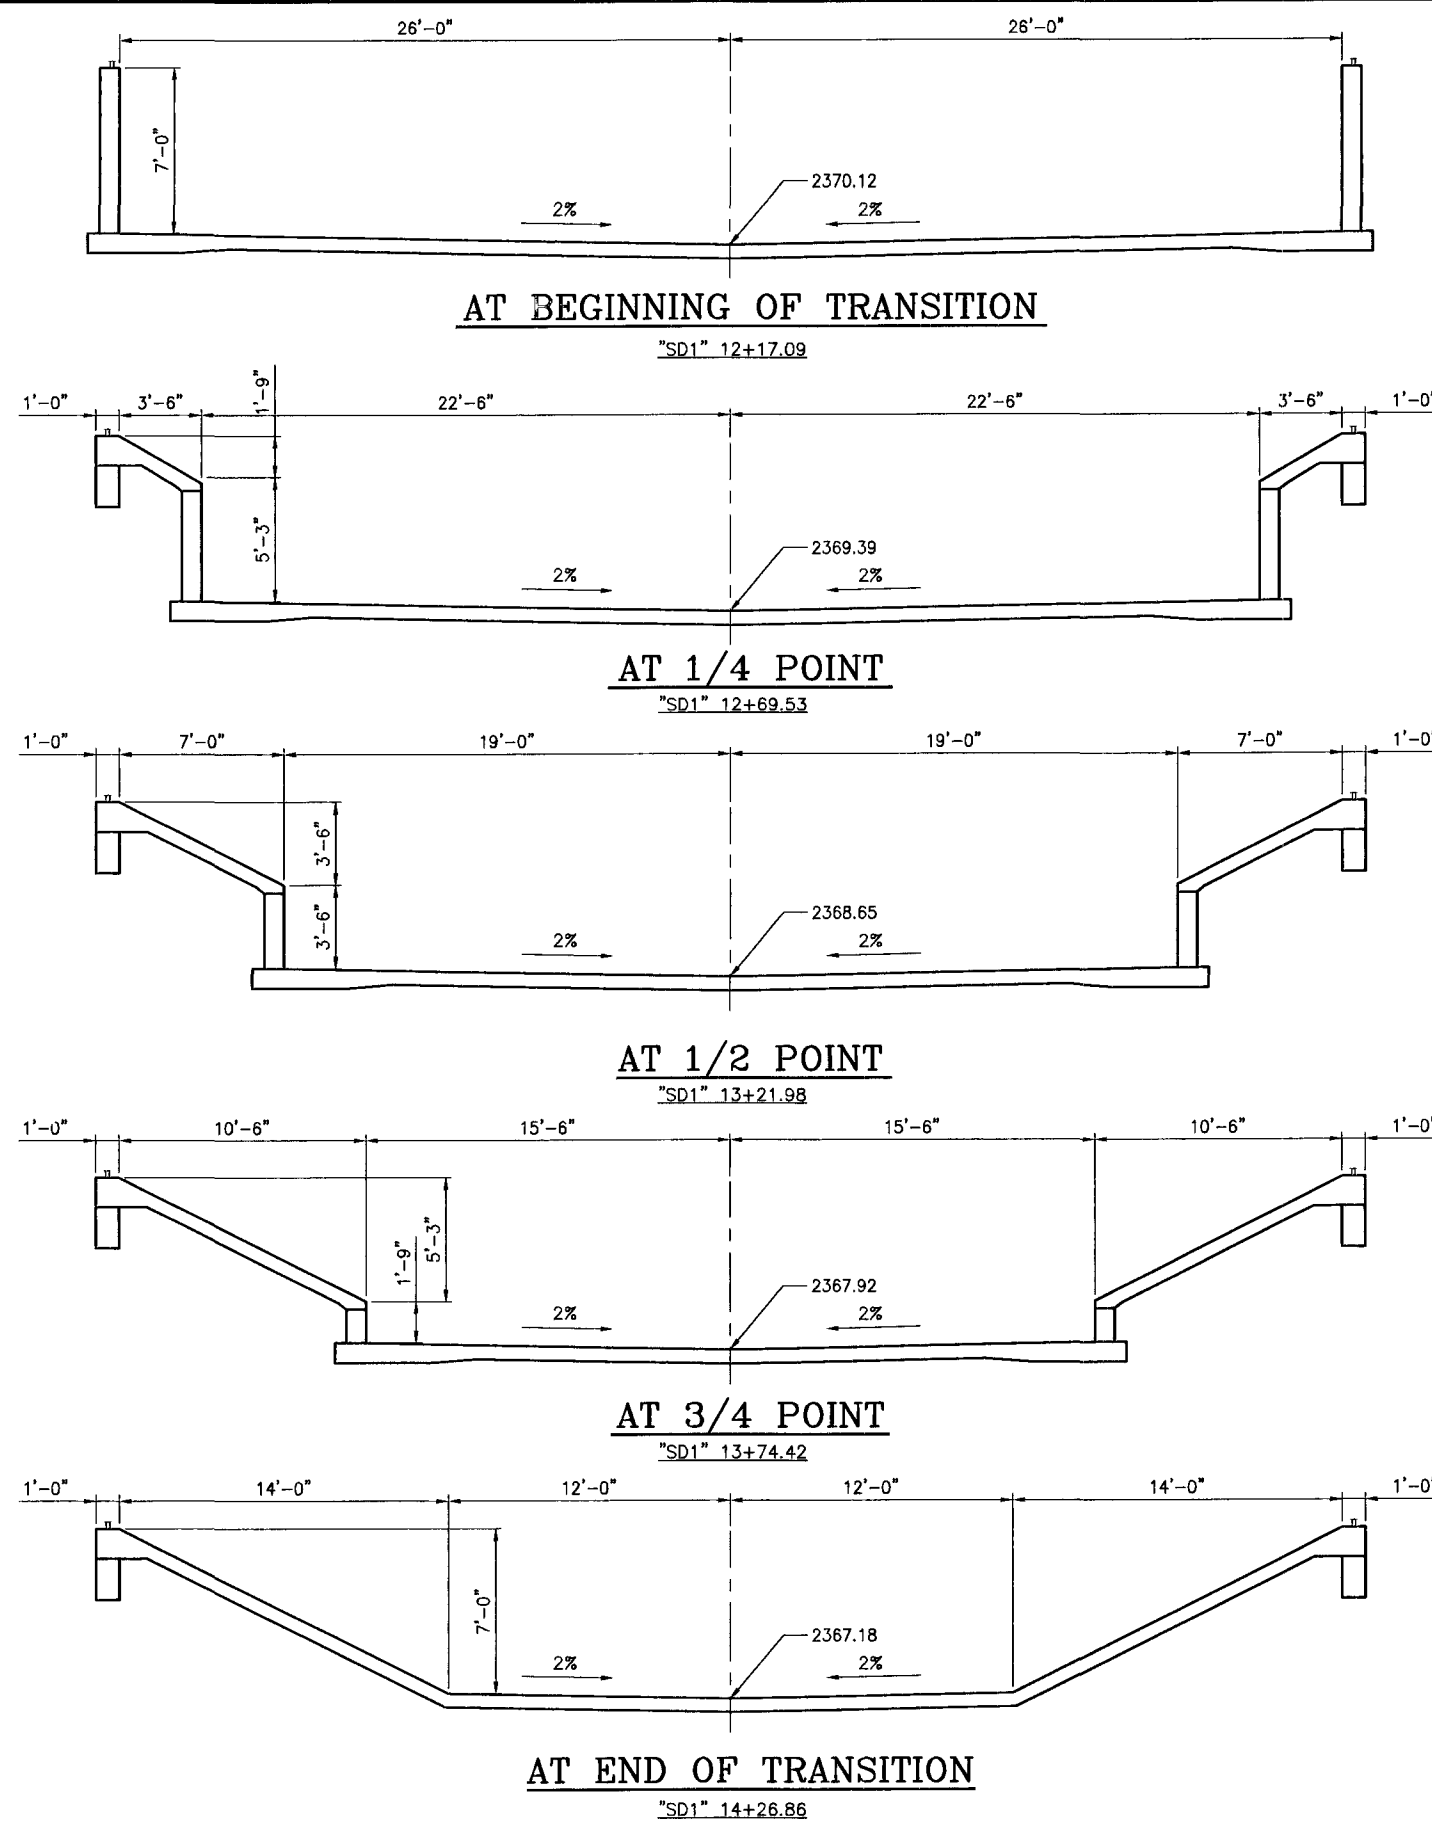

WALL SECTION AT TRANSITION CHANNEL

SCALE: 1/4"=1'-0"

1
S6

H#23161

PUBLIC WORKS DEPARTMENT		R&H ENGINEERING, INC.	
400 E. STEWART AVE. LAS VEGAS, NV 89101 702-229-8272		CONSULTING STRUCTURAL ENGINEERS 940 GRIER DRIVE SUITE 807 LAS VEGAS, NEVADA 89119 PHONE (702) 260-7000 FAX (702) 260-7010	
TRANSITION CHANNEL SECTIONS		LAS VEGAS WASH - MIDDLE BRANCH RAINBOW STORM DRAIN ELKHORN TO GRAND TETON	
DRAWN BY: ELY	DESIGNED BY: DMS	CHECKED BY: DAA	PROJECT NO: SCALE:
1/14/09	1/14/09	1/14/09	HORIZ. VERT.
5-27-09			
SHEET S6 42 OF 70 SHEETS DRAWING NO. 731-87-1			

118612