




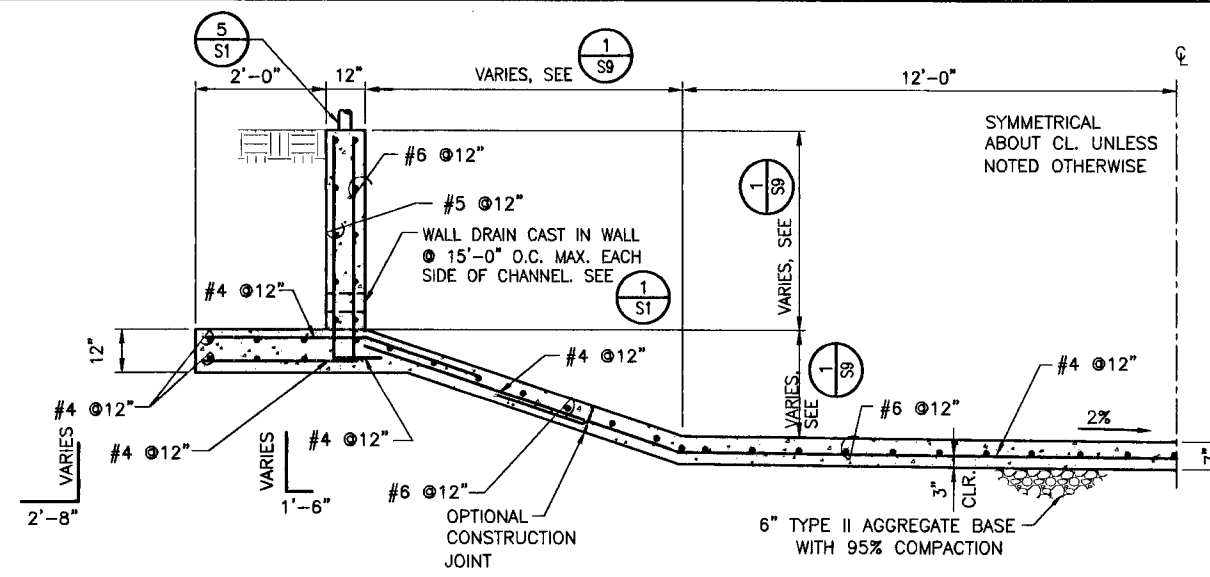






WALL SECTION A
SCALE: 1/2"=1'-0"

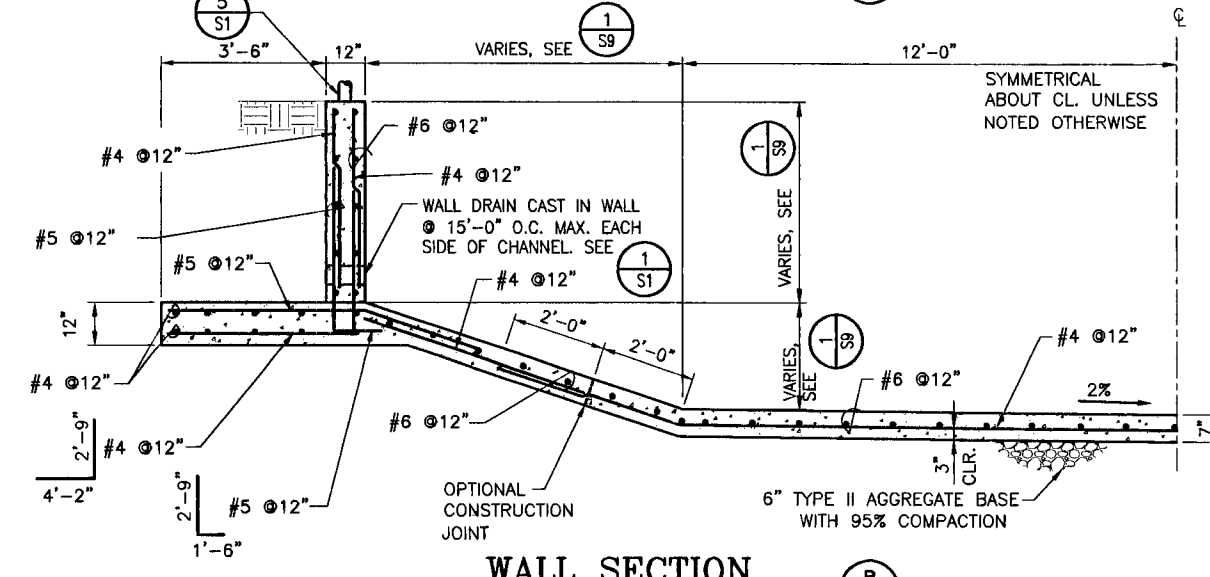

WALL SECTION B
SCALE: 1/2"=1'-0"

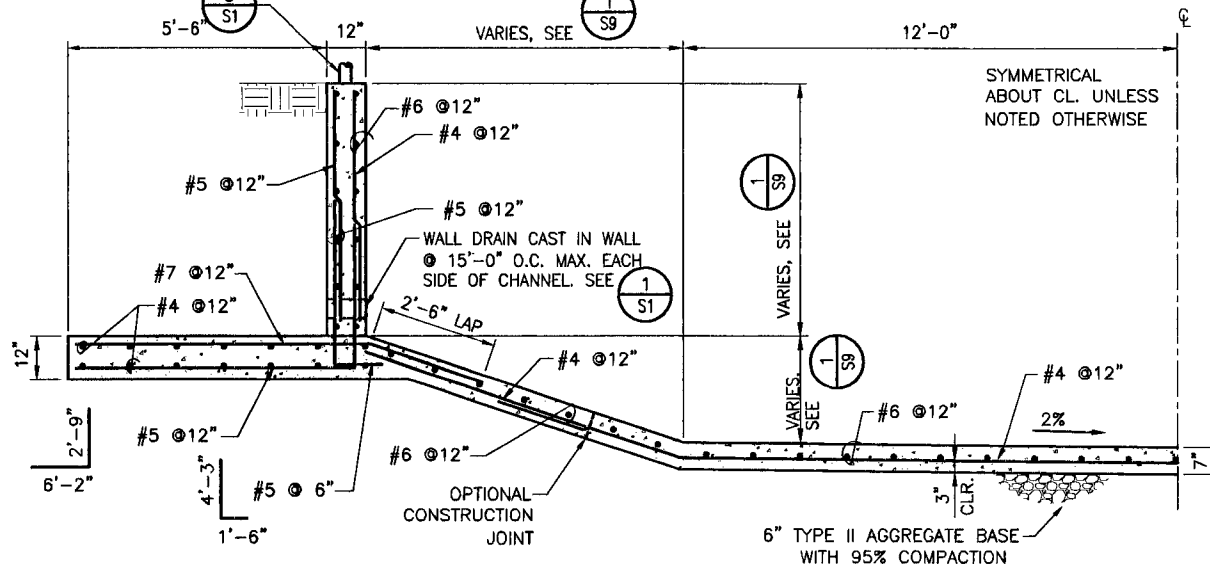

WALL SECTION C
SCALE: 1/2"=1'-0"

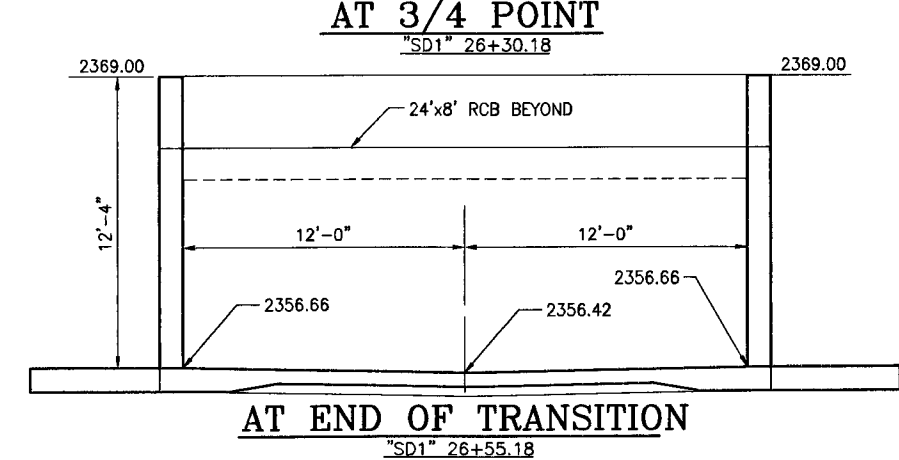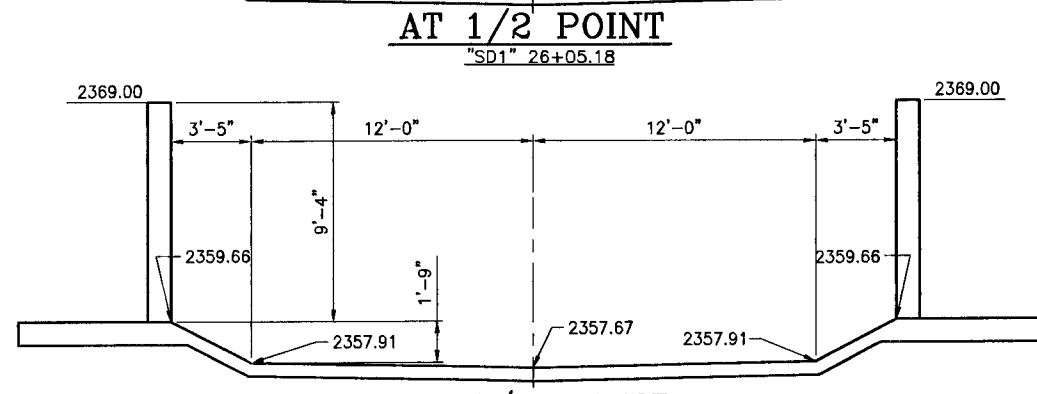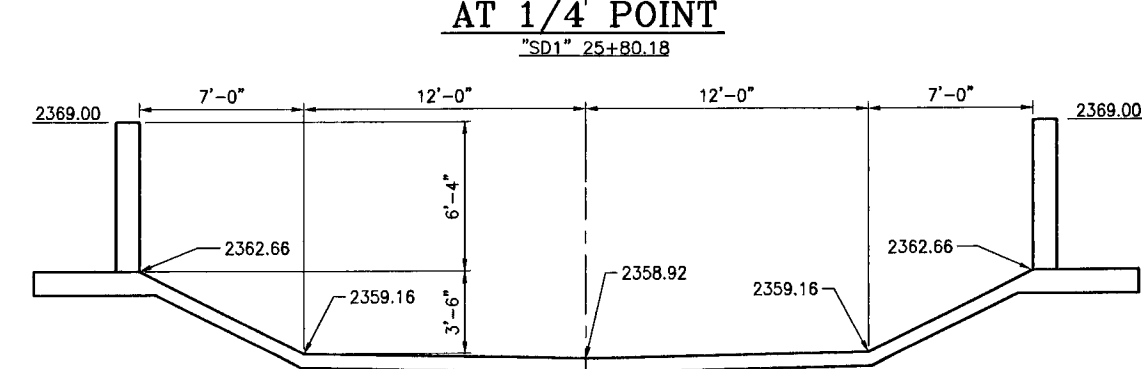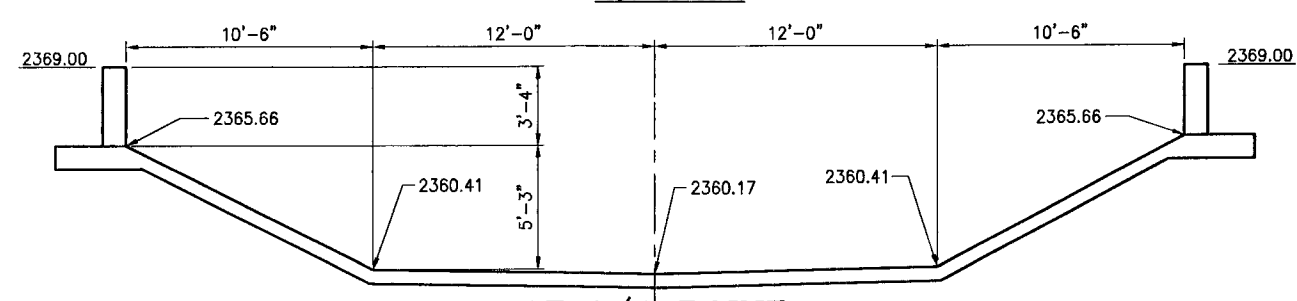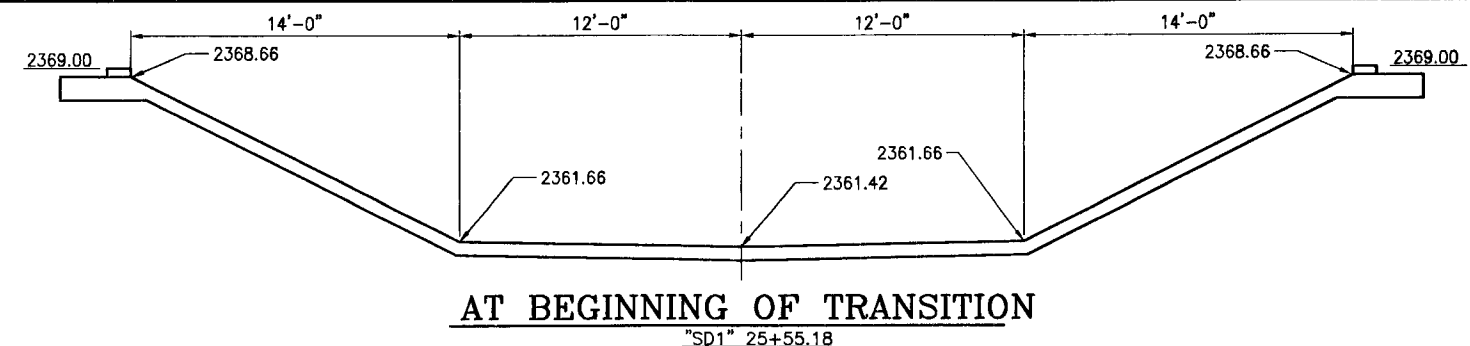

SECTIONS AT TRANSITION CHANNEL
SCALE: 1/4"=1'-0"

PUBLIC WORKS DEPARTMENT 400 E. STEWART AVE. LAS VEGAS, NV 89101 702-223-8272		R.H. ENGINEERING, INC. CONSULTING STRUCTURAL ENGINEERS 400 E. STEWART AVE., SUITE 200 LAS VEGAS, NV 89101 PHONE (702) 223-8272 FAX (702) 223-8273	
TRANSITION CHANNEL SECTIONS		LAS VEGAS WASH - MIDDLE BRANCH RAINBOW STORM DRAIN ELKHORN TO GRAND TETON	
DRAWN BY: 1/14/09 ELY	DESIGNED BY: 1/14/09 DBS	CHECKED BY: 1/14/09 DBA	PROJECT NO: SCALE: HORIZ. VERT.
SHEET S9 45 OF 70 SHEETS		DRAWING NO. 731-87-1	