




- COVER FEATURES:
- * PW - 10,400 LBS. WHEEL LOAD ON 10" X 10" PLATE.
 - * APPROX. WT. = 72 LBS.
 - * POLYMER CONCRETE
 - * ONE PIECE COVER
 - * FOUR BOLT DOWN
 - * COLOR: CONCRETE GREY
 - * NON - SKID SURFACE

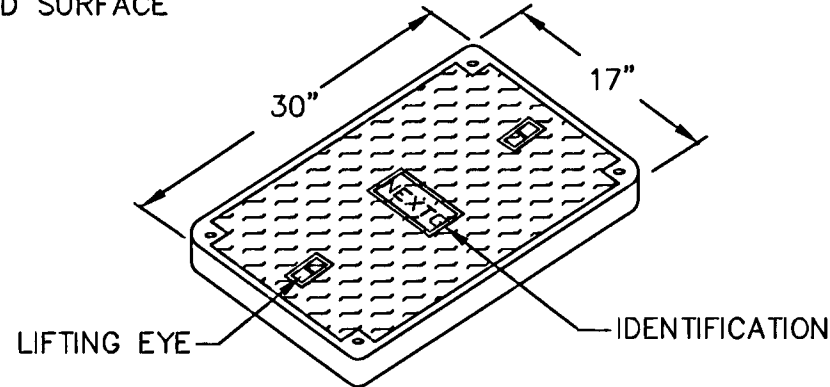


- VAULT FEATURES:
- * POLYMER CONCRETE RING AND FIBERGLASS REINFORCED POLYMER BODY
 - * COLOR OF RING: CONCRETE GREY
 - * APPROX. WT. = 123 LBS.

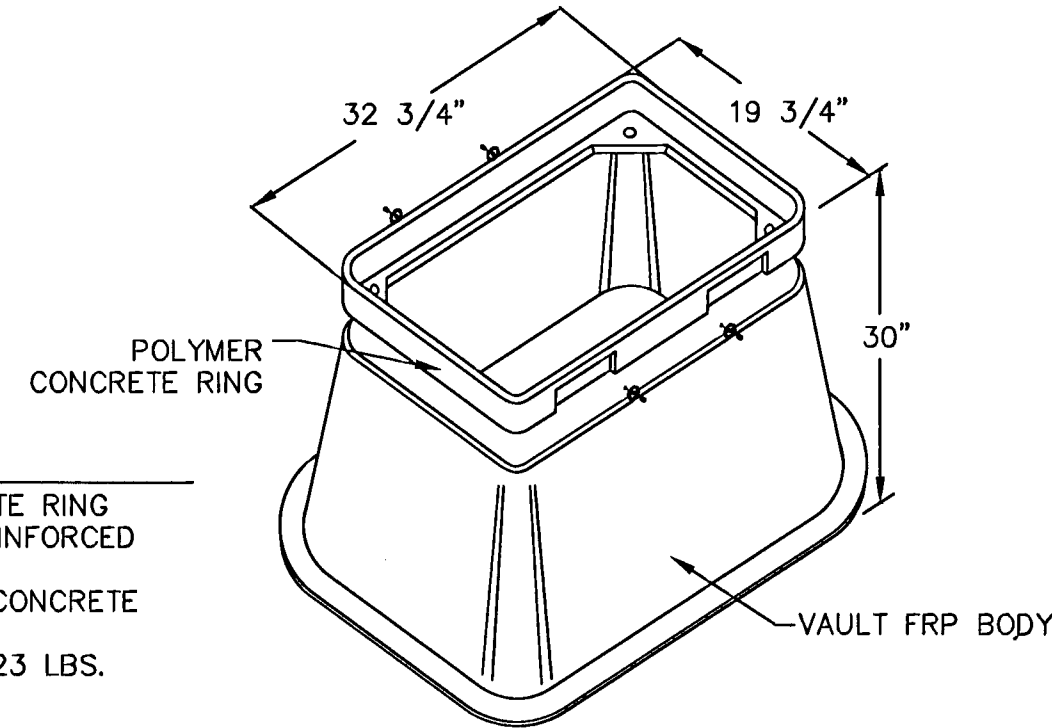


17' X 30' CONNECTOR MANHOLE
NTS

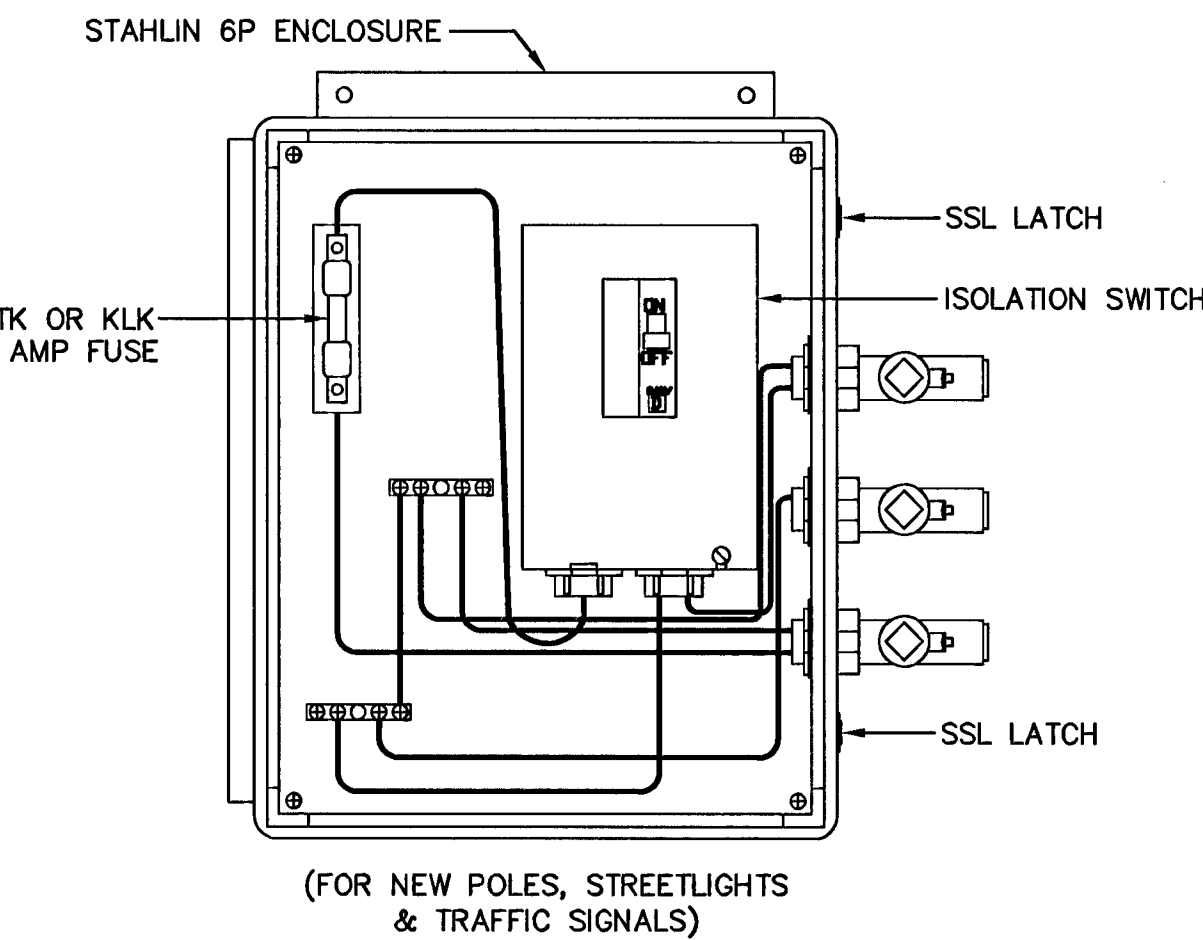


WTR FUSE BOX
NTS

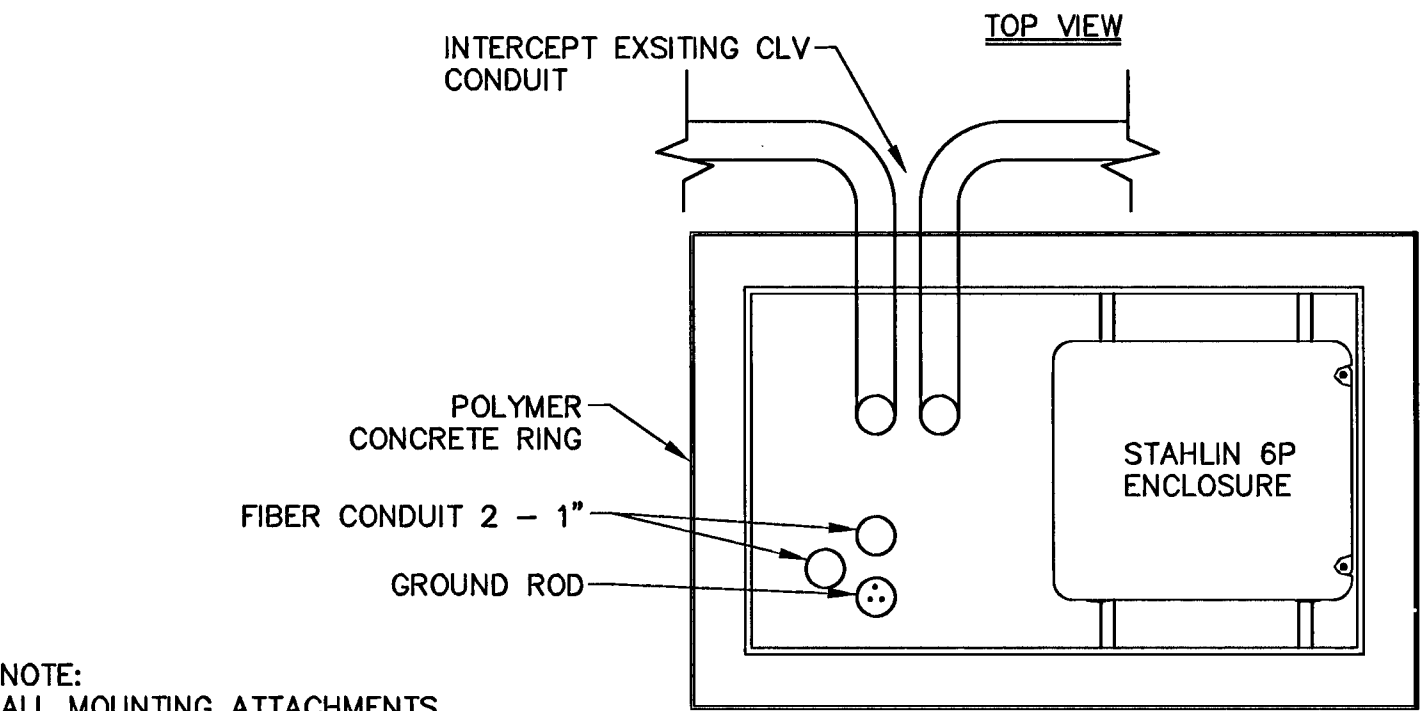


NOTE:
ALL MOUNTING ATTACHMENTS FOR THIS BOX SHALL BE THROUGH EXTERNAL MOUNTING FLANGES INTEGRAL WITH BOX.

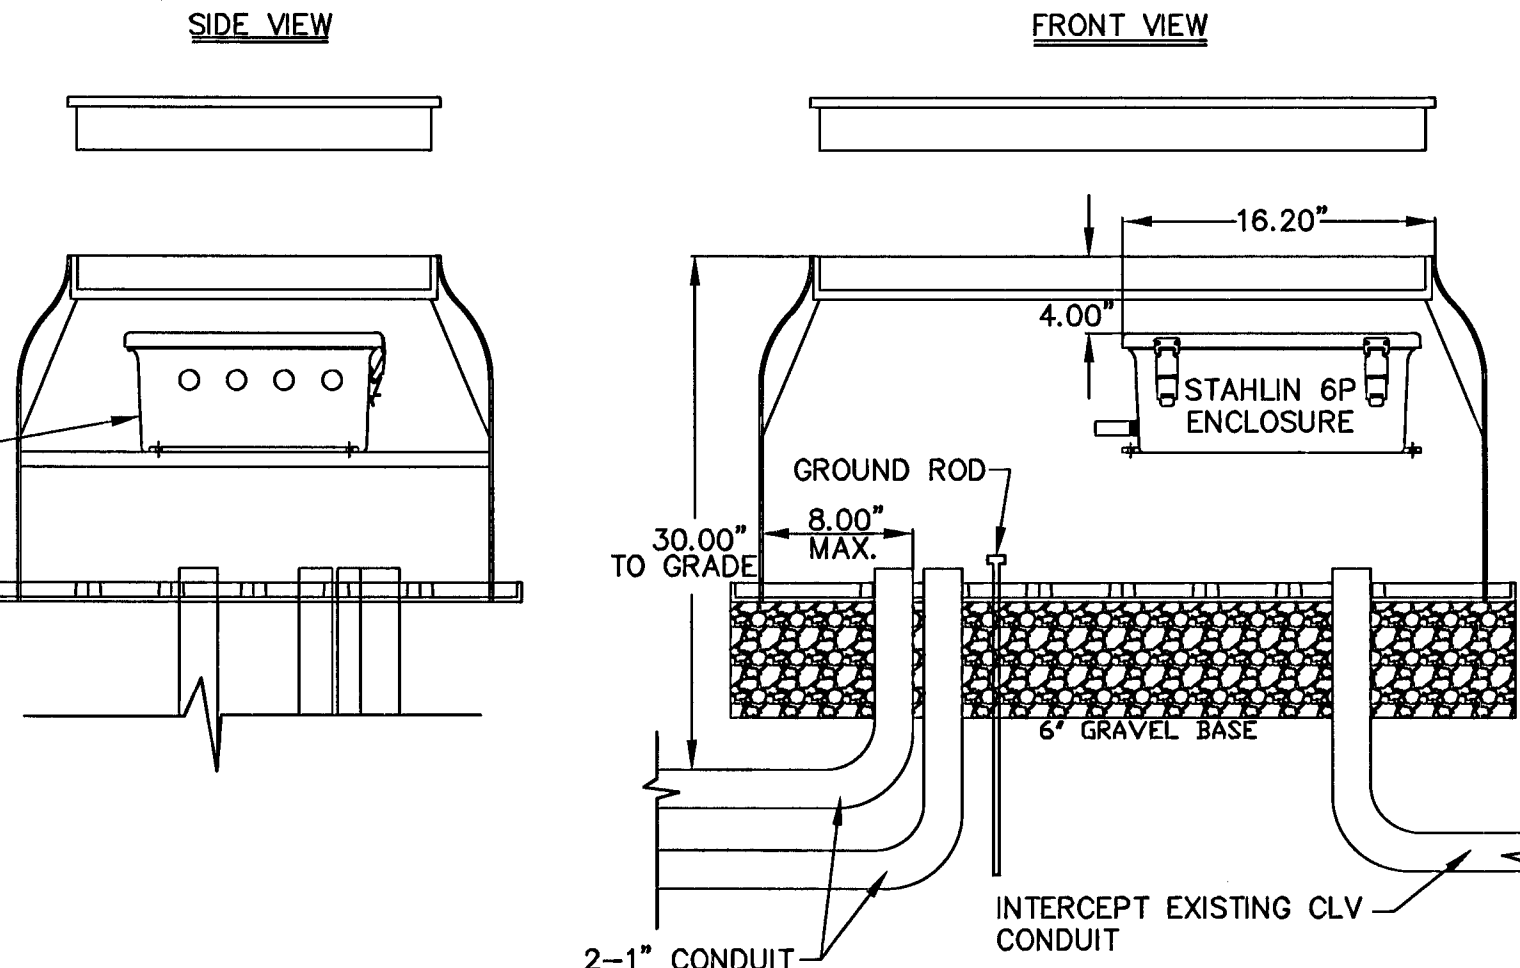

STAHLIN 6P ENCLOSURE
NTS

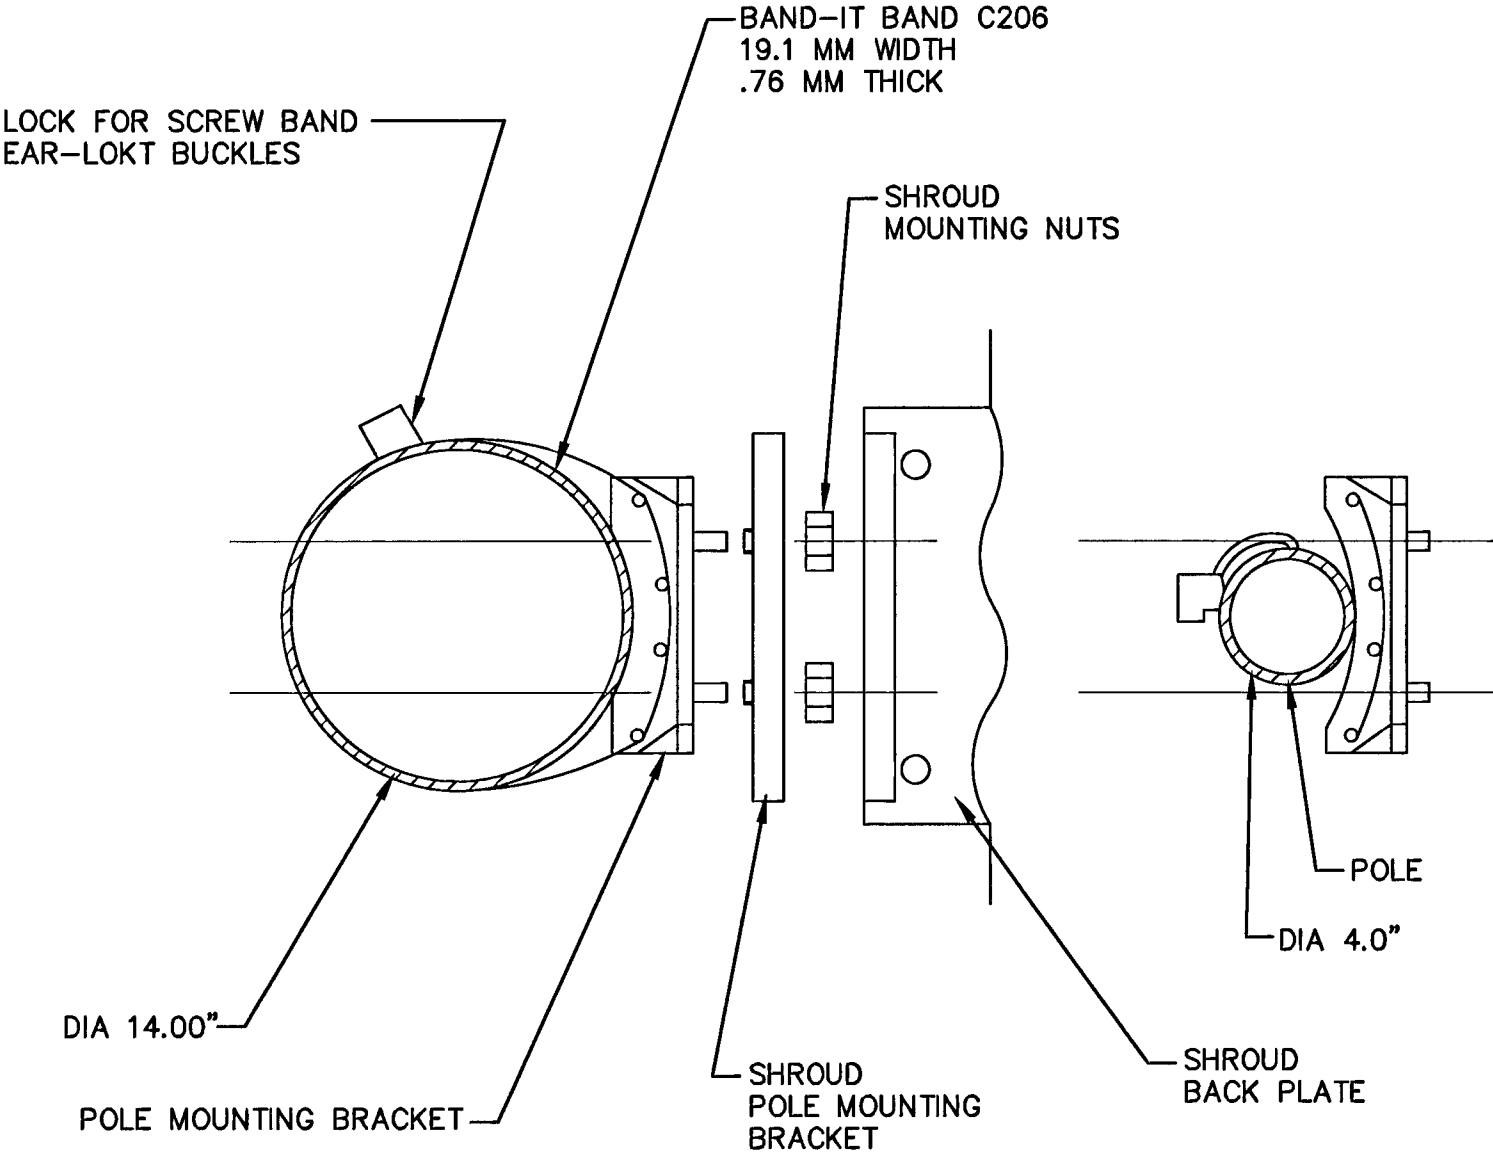

POLE MOUNTING
NTS

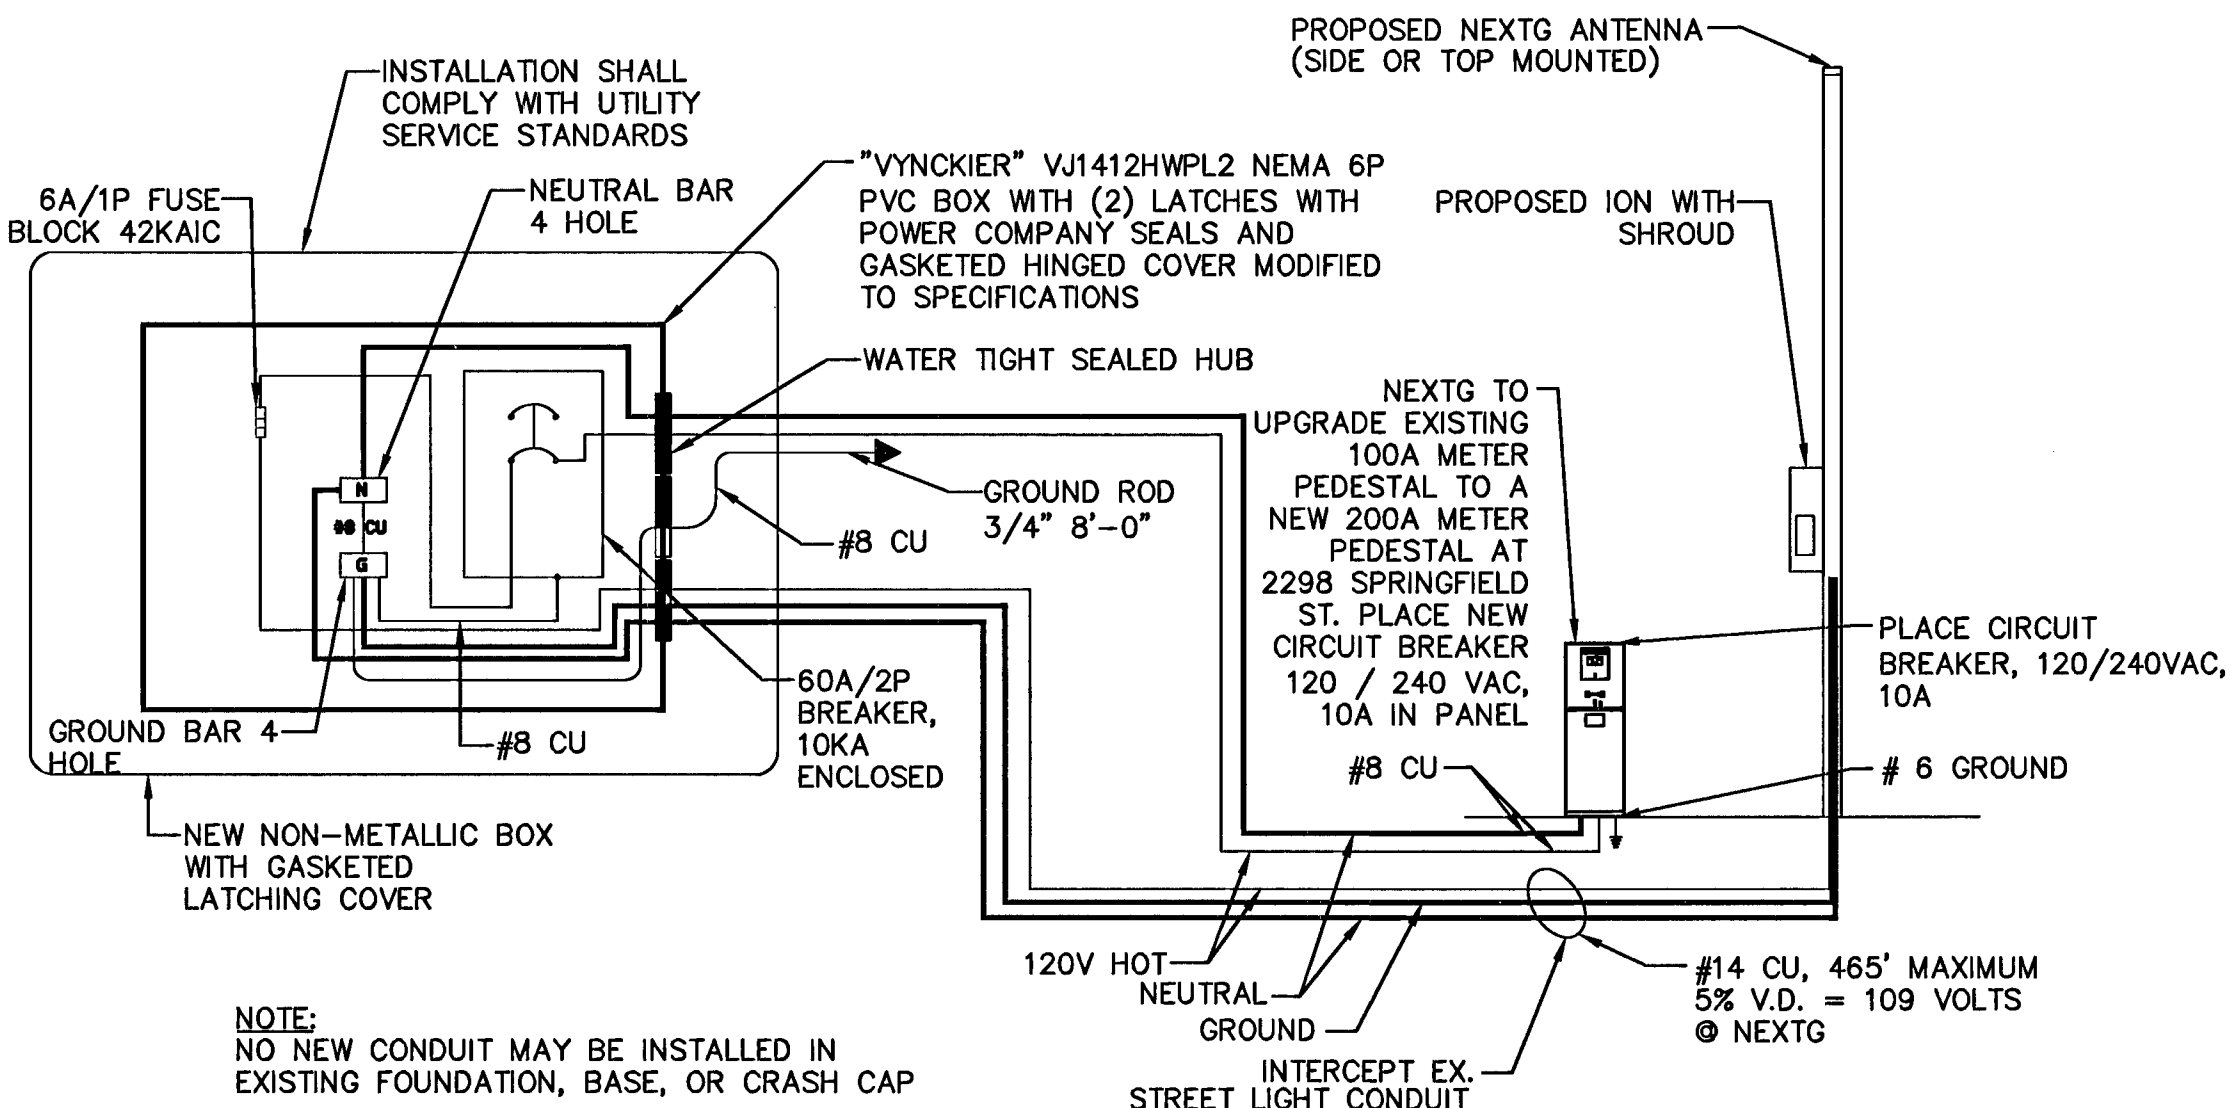


POWER SINGLE LINE DIAGRAM
NTS

REVISIONS		DESCRIPTION	REV.	APPROV BY	DATE

SPECTRUM
SPECTRUM SERVICES, INC.
8905 W. POST ROAD, SUITE 100
LAS VEGAS, NEVADA 89148
OFFICE: (702) 367-7705
FAX: (702) 367-8733

CROWN CASTLE
NG WEST, INC.
695 RIVER OAKS PARKWAY
SAN JOSE, CALIFORNIA 95134

IMPROVEMENT PLANS
FOR SUMMERLIN
DETAIL SHEET
VSUM10m1 FIBER OPTIC CABLE
IMPROVEMENTS IN SUMMERLIN
W. LAKE MEAD BLVD.
(1100 FT. NORTHWEST OF SPRINGFIELD)

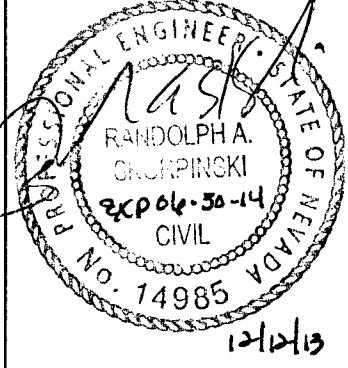

ENGINEER'S SEAL	
CONTRACTED WITH:	HP COMMUNICATIONS
PERMIT #	
DATE: 12/10/13	
JOB NO: CD13030	
DRAWN BY: NEL	
CHECKED BY: RAS	
SCALE: NONE	