
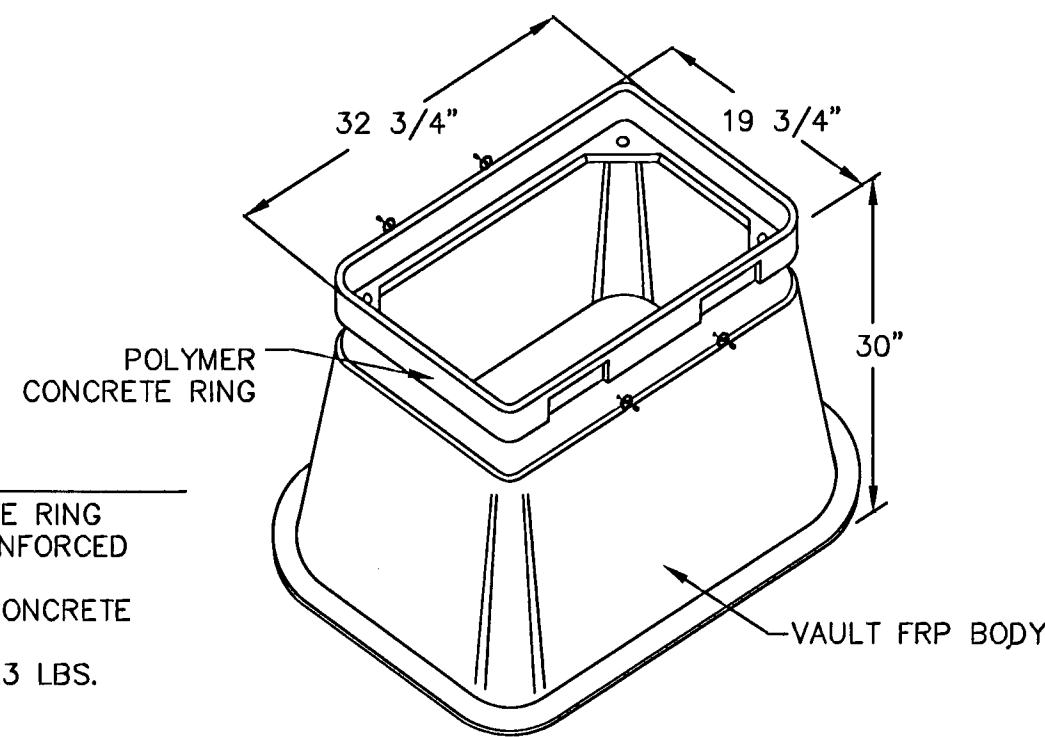


COVER FEATURES:

- * PW - 10,400 LBS. WHEEL LOAD ON 10" X 10" PLATE.
- * APPROX. WT. = 72 LBS.
- * POLYMER CONCRETE
- * ONE PIECE COVER
- * FOUR BOLT DOWN
- * COLOR: CONCRETE GREY
- * NON - SKID SURFACE

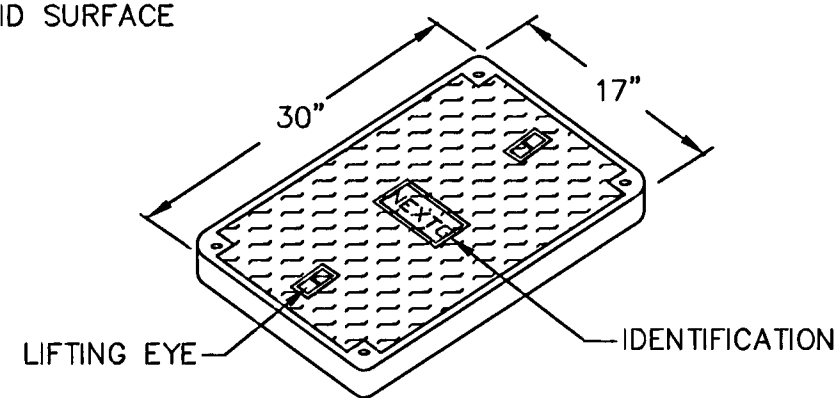


VAULT FEATURES:

- * POLYMER CONCRETE RING AND FIBERGLASS REINFORCED POLYMER BODY
- * COLOR OF RING: CONCRETE GREY
- * APPROX. WT. = 123 LBS.

17' X 30' CONNECTOR MANHOLE

NTS

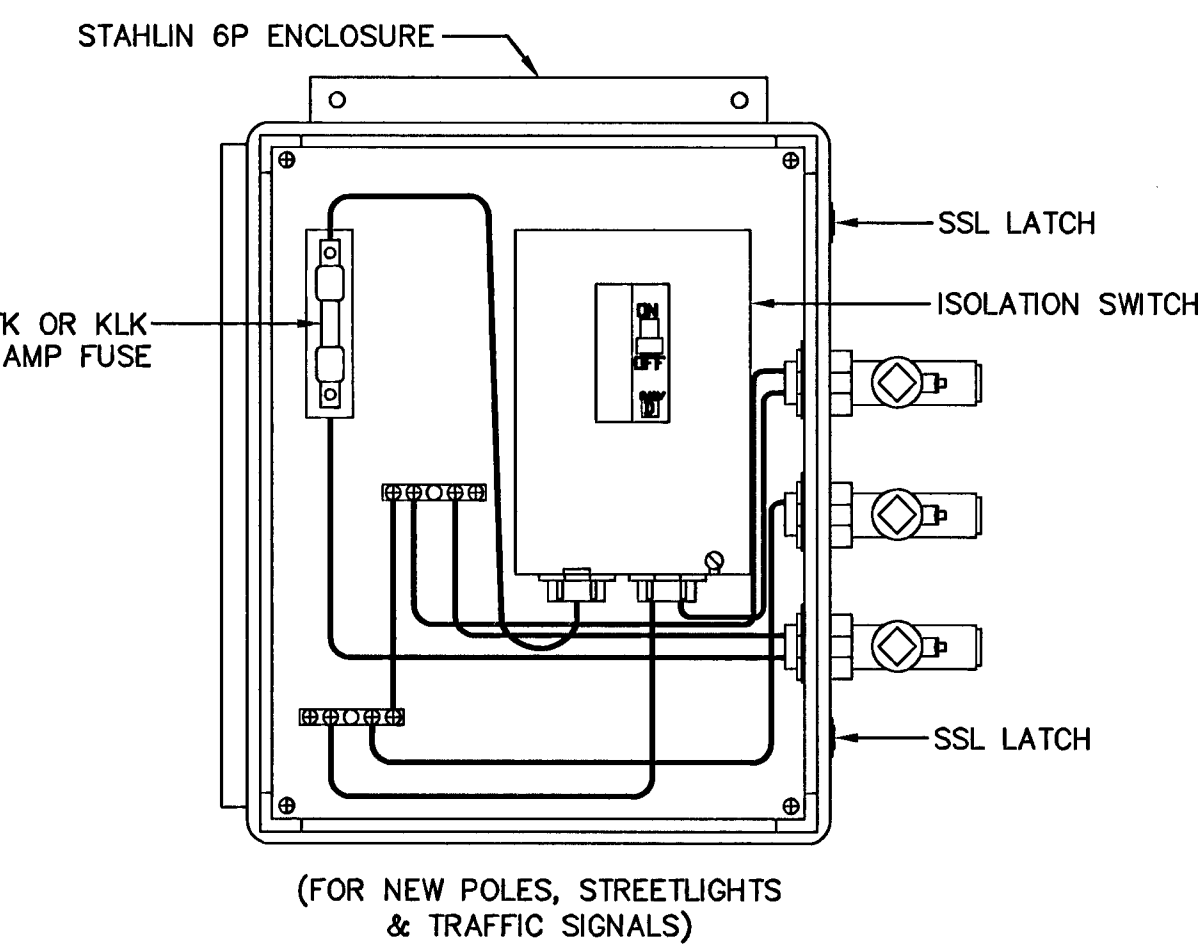


WTR FUSE BOX


NTS

STAHLIN 6P ENCLOSURE

SIDE VIEW

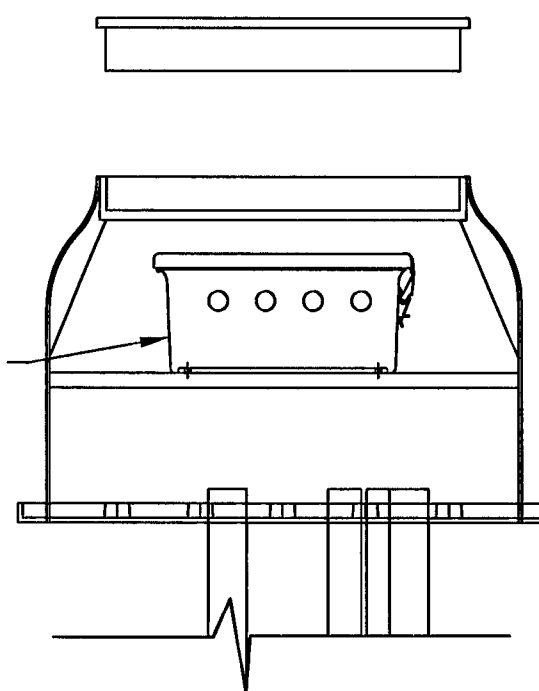


FRONT VIEW

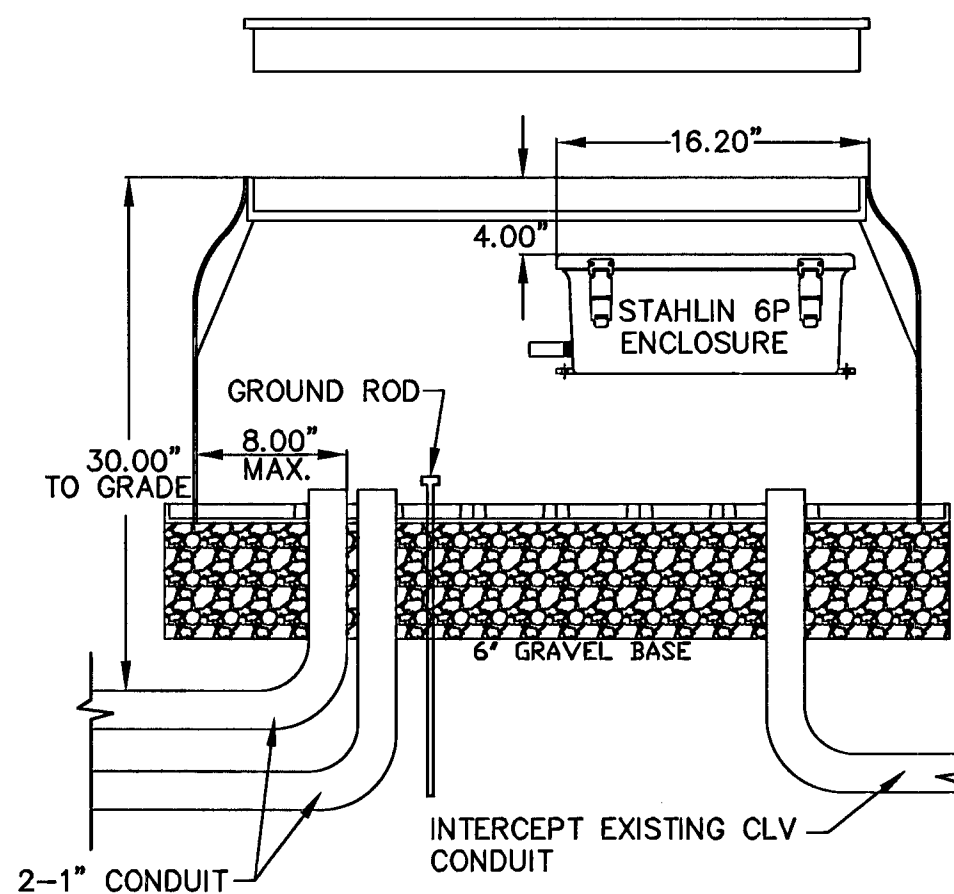


STAHLIN 6P ENCLOSURE

NTS

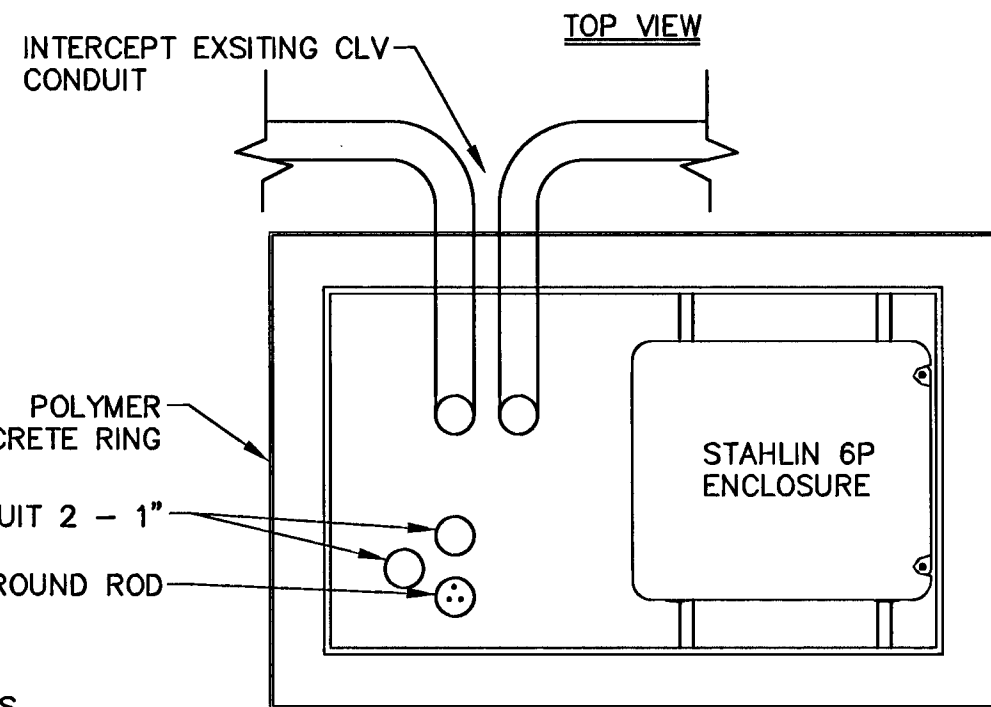


NOTE:
ALL MOUNTING ATTACHMENTS
FOR THIS BOX SHALL BE THROUGH EXTERNAL
MOUNTING FLANGES INTEGRAL WITH BOX.

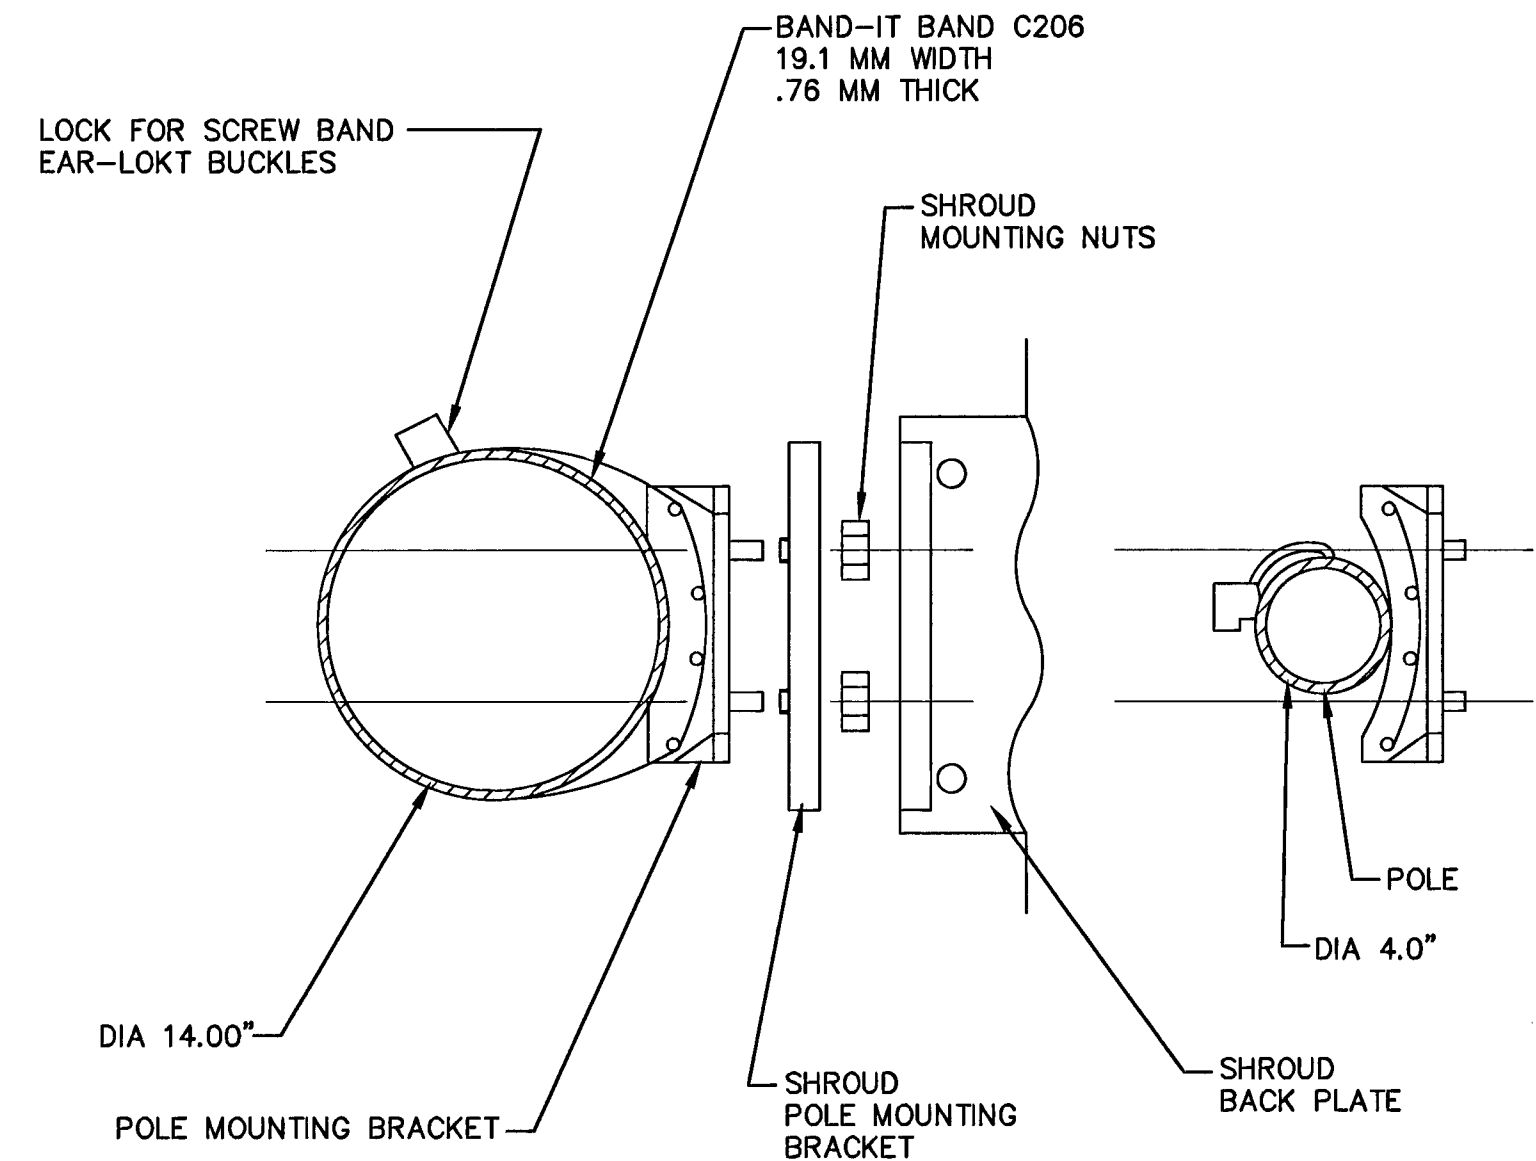

POLE MOUNTING

NTS

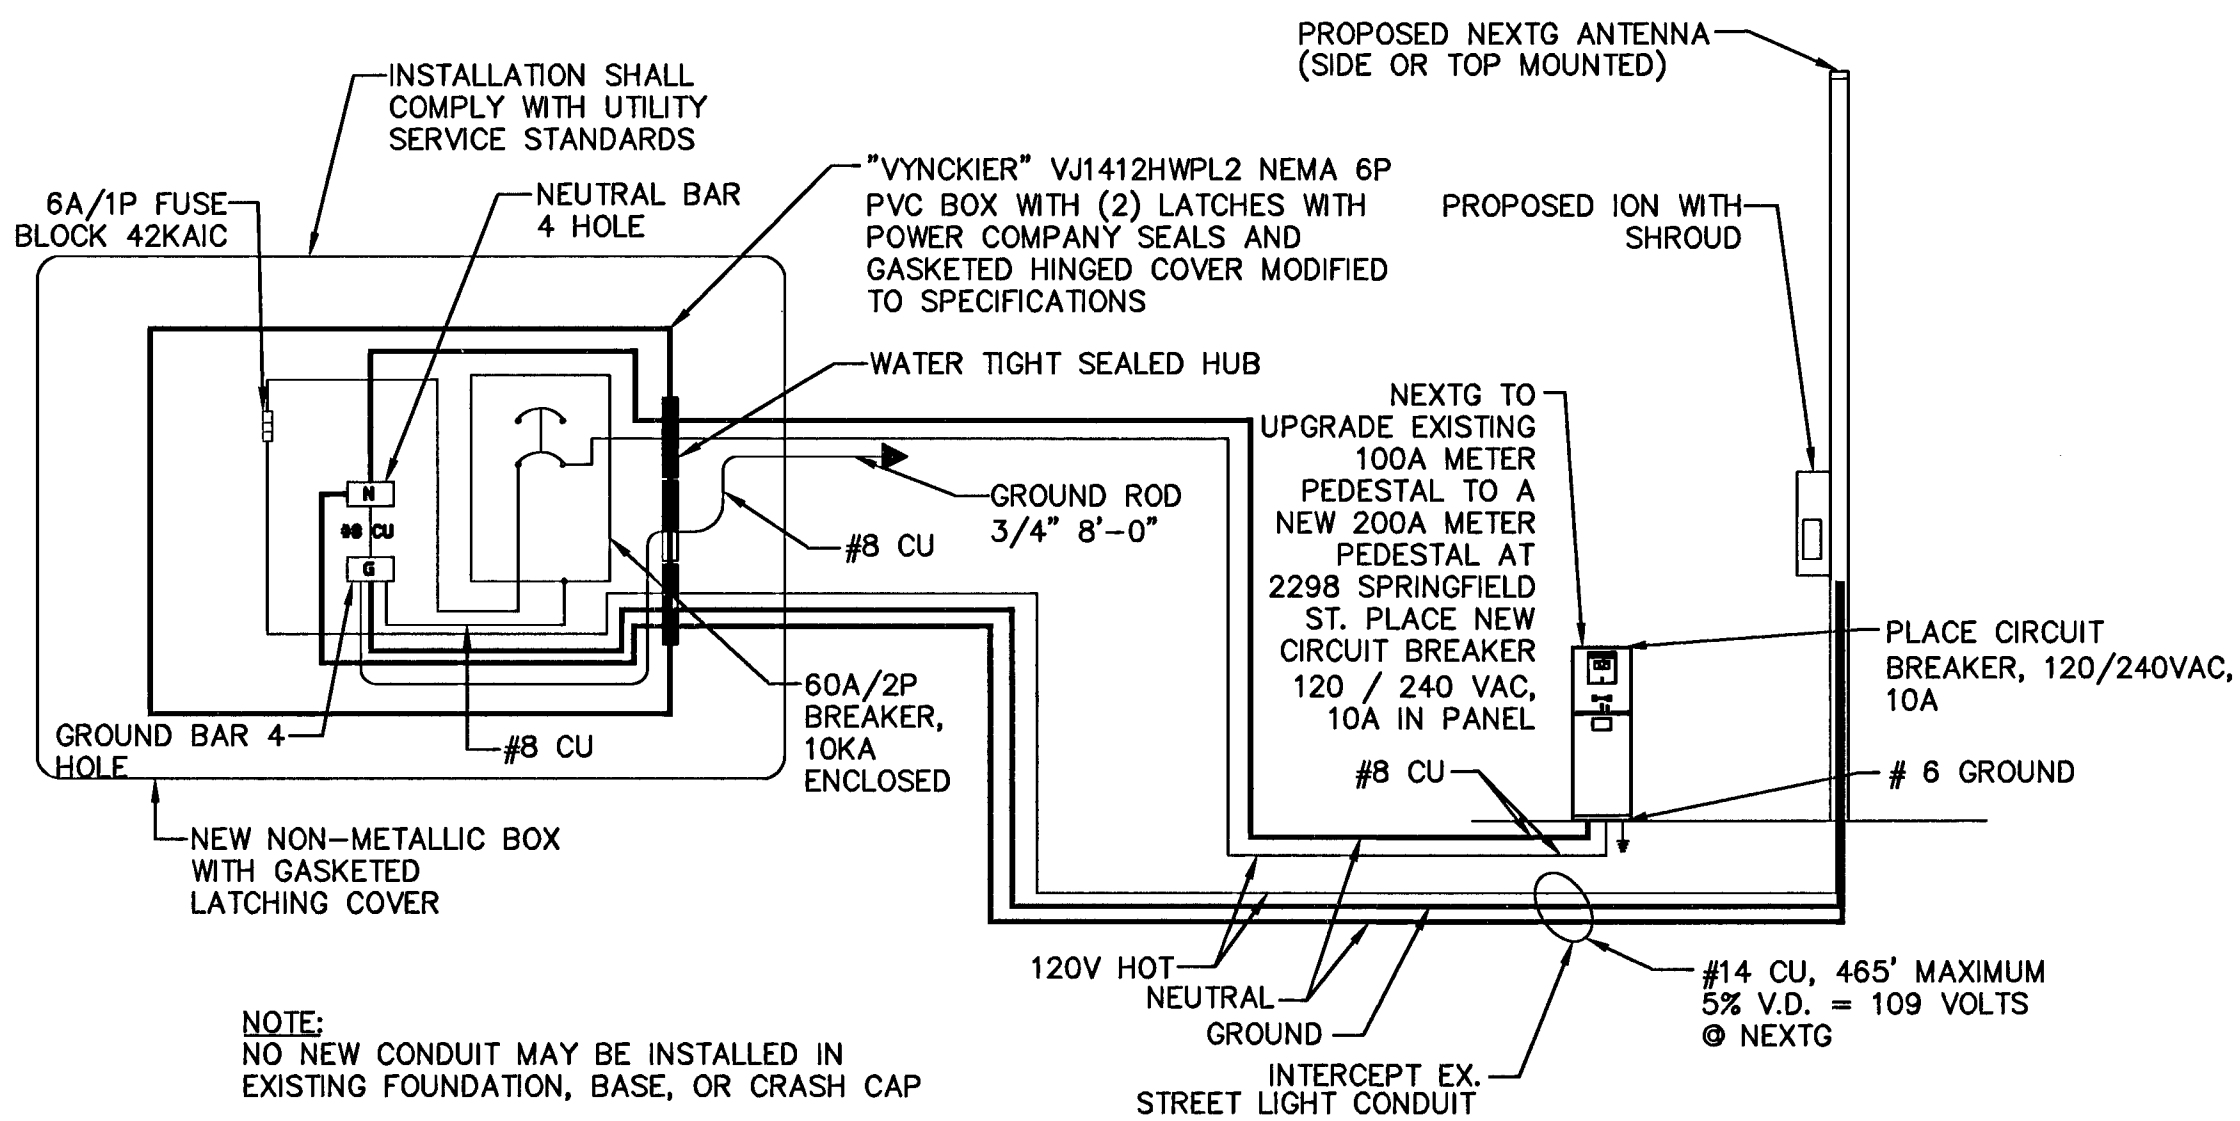

POWER SINGLE LINE DIAGRAM

NTS

REVISIONS

REV.	DESCRIPTION	APPROV BY	DATE

SPECTRUM


SPECTRUM SERVICES, INC.
8905 W. POST ROAD, SUITE 100
LAS VEGAS, NEVADA 89148
OFFICE: (702) 367-7705
FAX: (702) 367-8733

CROWN CASTLE
NG WEST, INC.

695 RIVER OAKS PARKWAY
SAN JOSE, CALIFORNIA 95134

IMPROVEMENT PLANS
FOR SUMMERLIN

DETAIL SHEET
VSUM10m1 FIBER OPTIC CABLE
IMPROVEMENTS IN SUMMERLIN
W. LAKE MEAD BLVD.
(1100 FT. NORTHWEST OF SPRINGFIELD)

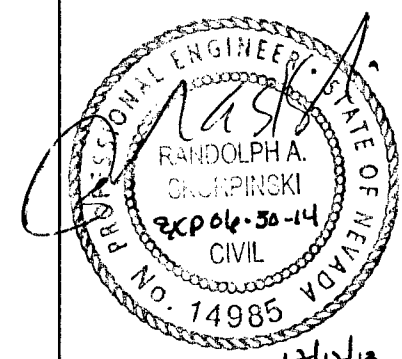

ENGINEER'S SEAL

CONTRACTED WITH:
HP COMMUNICATIONS
PERMIT #
DATE: 12/10/13
JOB NO: CD13030
DRAWN BY: NEL
CHECKED BY: RAS
SCALE: NONE

SHEET 5

OF 7