


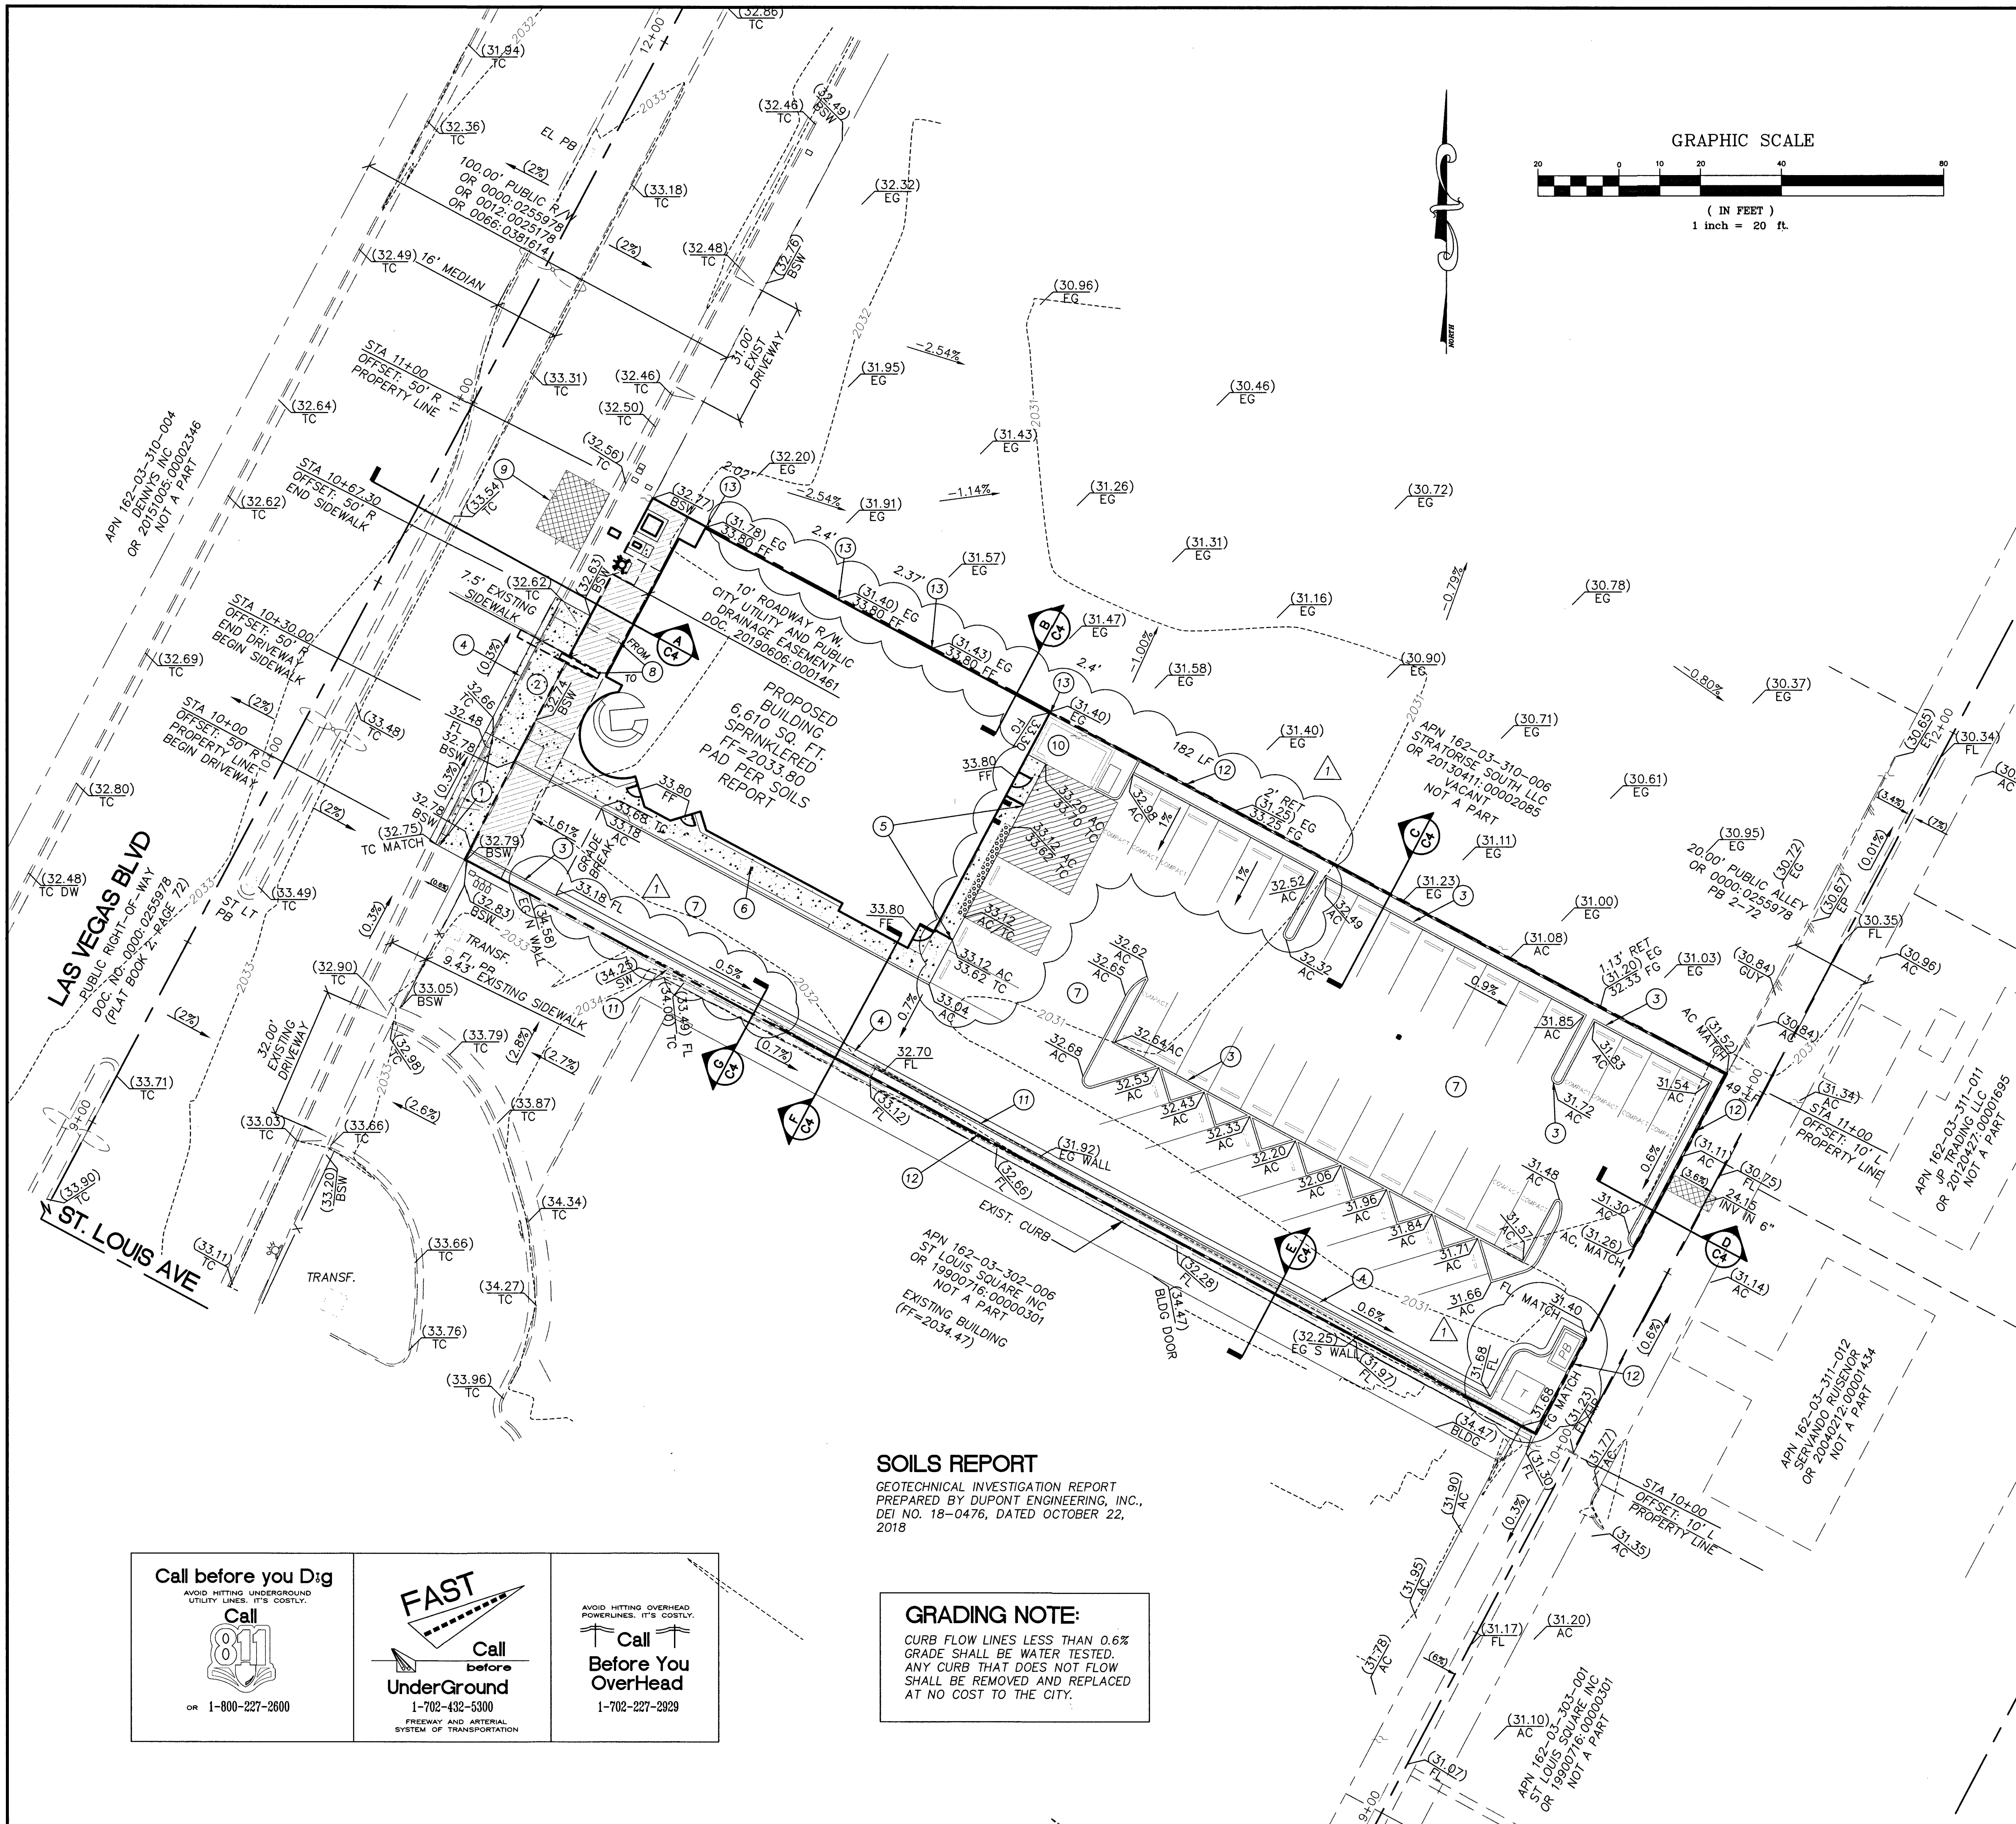

BASIS OF BEARING

NORTH 28°02'08" EAST, BEING THE BEARING OF THE CENTERLINE OF LAS VEGAS BOULEVARD BETWEEN ST. LOUIS AVENUE AND OAKLEY BOULEVARD LOCATED IN THE NORTHWEST QUARTER (NW 1/4) OF THE SOUTHWEST QUARTER (SW 1/4) OF SECTION 3, TOWNSHIP 21 SOUTH, RANGE 61 EAST, M.D.M., CITY OF LAS VEGAS, CLARK COUNTY, NEVADA, AS SHOWN BY MAP THEREOF ON FILE IN FILE 193 OF SURVEYS, PAGE 94, OFFICIAL RECORDS CLARK COUNTY, NEVADA.

BENCHMARK

CITY OF LAS VEGAS BENCHMARK "OAKLEY 5", BEING A RIVET AND PLATE IN THE TOP OF CURB AT SE CORNER OF OAKLEY BLVD & LAS VEGAS BLVD. ALSO STAMPED 8LV113W6

ELEVATION: 2030.6 (US SURVEY FEET)
618.927 (METERS)

BASED ON NORTH AMERICAN VERTICAL DATUM OF 1988 (NAVD 88).

STORM WATER MANAGEMENT NOTES

Standard Note No. 1:
The Owner, Site Developer, Contractor, and/or their authorized agents shall each day remove all sediment, mud, construction debris, or other potential pollutants that may have been discharged to, or accumulated in, the public rights of way of CLV as a result of construction activities associated with this site development or construction project. Such materials shall be prevented from entering the storm sewer system.

Standard Note No. 2:
Additional construction site discharge best management practices may be required of the owner and his or her agents due to unforeseen erosion problems or if the submitted plan does not meet the performance standards specified in the Las Vegas Valley Construction Site BMP Guidance Manual.

Standard Note No. 3:
Temporary or permanent stabilization practices will be installed on disturbed areas as soon as practicable and no later than 14 days after the construction activity in that portion of the site has temporarily or permanently ceased. Some exceptions may apply; refer to the Nevada Stormwater General Permit for Construction Activity NVR100000, Section III.A.5.

Standard Note No. 4:
At a minimum, the Contractor or his agent shall inspect all disturbed areas, areas used for storage of materials and equipment that are exposed to precipitation, vehicle entrance and exit locations, and all BMPs weekly, and within 24 hours after any rain event of 0.5 inches or more. The Contractor or his agent shall update or modify the Stormwater Pollution Prevention Plan as necessary. Some exceptions to weekly inspections may apply, such as suspension of land disturbance activities. Refer to the Nevada Stormwater General Permit for Construction Activity NVR100000, Section III.A.12.

Standard Note No. 5:
Accumulated sediment in BMPs shall be removed within seven days after a stormwater runoff event or prior to the next anticipated storm event, whichever is earlier. Sediment must be removed when BMP design capacity has been reduced by 50 percent or more.

FLOOD ZONE INFORMATION

THIS PROPERTY IS LOCATED IN A FLOOD ZONE DESIGNATED "ZONE X", DETERMINED TO BE OUTSIDE THE 0.2% ANNUAL CHANCE FLOODPLAIN PER FEMA FLOOD INSURANCE RATE MAP NO. 32003C2170F, CLARK COUNTY, NEVADA AND INCORPORATED AREAS, DATED NOVEMBER 16, 2011

CONSTRUCTION NOTES:

- 1 REMOVE EXISTING C&G, AND A PORTION OF THE SIDEWALK & INSTALL A COMMERCIAL DRIVEWAY PER CCAUSD 224
- 2 INSTALL CONCRETE SIDEWALK PER CCAUSD #234
- 3 INSTALL A-TYPE CURB PER CCAUSD #216
- 4 INSTALL L-TYPE CURB PER CCAUSD #219
- 5 INSTALL CONCRETE RAMP PER DETAIL ON SHEET C4
- 6 INSTALL CONCRETE SIDEWALK WITH TURNDOWN CURB PER DETAIL ON SHEET C4
- 7 INSTALL 3" AC/8.5" TYPE II/COMPACTED SUBGRADE AS SPECIFIED BY SOILS REPORT
- 8 ADJUST MARQUEE SIGN LOCATION PER ARCHITECTURAL SPECIFICATIONS
- 9 SAWCUT LINE
- 10 PROPOSED TRASH ENCLOSURE, REFER TO ARCHITECTURAL PLANS FOR DETAILS
- 11 REMOVE EXISTING CMU BLOCK WALL
- 12 CONSTRUCT 2-FOOT MAX RETAINING WALL WITH 6-FOOT HIGH CMU BLOCK WALL PER SNBO DWG. B-100-2 WITH ECCENTRIC FOOTING
- 13 EXPOSED STEM WALL AS NOTED

SOILS REPORT

GEOTECHNICAL INVESTIGATION REPORT
PREPARED BY DUPONT ENGINEERING, INC.,
DEI NO. 18-0476, DATED OCTOBER 22, 2018

GRADING NOTE:

CURB FLOW LINES LESS THAN 0.6% GRADE SHALL BE WATER TESTED. ANY CURB THAT DOES NOT FLOW SHALL BE REMOVED AND REPLACED AT NO COST TO THE CITY.

Call before you Dig
AVOID HITTING UNDERGROUND UTILITY LINES. IT'S COSTLY.


OR 1-800-227-2600

FAST
Call before
UnderGround
1-702-432-5300
FREEMAN AND ARTERIAL SYSTEM OF TRANSPORTATION

AVOID HITTING OVERHEAD POWERLINES. IT'S COSTLY.

Call before
OverHead
1-702-227-2929

BALOVA ENGINEERING 7495 WEST AZURE DR. # 140 LAS VEGAS, NV 89130 TEL 702-882-1706		I HOP - LAS VEGAS BOULEVARD GRADING PLAN	DESIGNED BY: PB CHECKED BY: PB DATE: 07/08/19 JOB #: 18-IHOP APN: 162-03-310-007 SECT 3 T21SR 61E SCALE: HORIZ 1" = 20'
REV: DATE: BY: REVISION: 8/1/2019 REMOVED PORTIE COCHERE RELOCATED TRASH ENCLOSURE ADJUSTED PARKING LOT			
1809 S. LAS VEGAS BOULEVARD LAS VEGAS, NV 89104		SHEET # C3 3 OF 6	

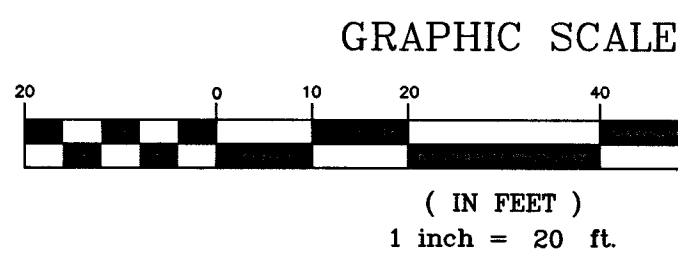

WARNING FIRE LINE

(NON-POTABLE WATER)
ALL EXISTING, RELOCATED OR
PROPOSED DCDA/RPDA
INSTALLATIONS:
TO COMPLY WITH THE FEDERAL
SAFE DRINKING WATER ACT, THE
FIRE LINE, OR ANY OF ITS
COMPONENTS, SHALL NOT BE
USED FOR POTABLE DRINKING
WATER AT ANY TIME.

EASEMENT WITH TREES, SHRUBS, DECORATIVE ROCKS, BLOCK WALL, OR FENCE

TREES, SHRUBS, OR DECORATIVE ROCKS, AND ANY BLOCK WALL OR
OTHER FENCE MATERIAL, SHALL BE DESIGNED AND CONSTRUCTED
AROUND THE EASEMENTS TO ALLOW THE DISTRICT DIRECT ACCESS
TO THE VAULT(S), BACKFLOW ASSEMBLIES, AND PIPING FROM THE
ADJACENT RIGHT-OF-WAY. MAINTAIN 2% MAX SLOPE WITHIN THE
EASEMENT.

UTILITY NOTES

- ALL EXISTING UTILITY STRUCTURES WITHIN CONSTRUCTION AREA
SHALL BE ADJUSTED TO MATCH FINISH GRADE (I.E. WV, BOX, WMH,
ANODE BOX, FH, TEL BOX, ETC.)
- ALL DIMENSIONS TO UTILITIES ARE TO CENTERLINE OF PIPE
UNLESS INDICATED OTHERWISE.
- CONTRACTOR SHALL VERIFY HORIZONTAL AND VERTICAL ALIGNMENT
OF EXISTING UTILITIES AND SHALL NOTIFY THE DESIGN ENGINEER
IMMEDIATELY ON ANY DISCREPANCIES PRIOR TO CONSTRUCTION.
- REPLACE ALL TRAFFIC AND CONTROL DEVICES, (SIGNS OR PAVEMENT
MARKINGS) UNDER CLARK COUNTY'S JURISDICTION, THAT ARE
DISTURBED, DESTROYED, MOVED OR MODIFIED BY TRENCHING
ACTIVITY TO CLARK COUNTY'S SATISFACTION. ALL MATERIAL USED
SHALL MEET CLARK COUNTY'S SPECIFICATIONS OR WILL BE AN
APPROVED EQUIVALENT.

SEWER CONTRIBUTION

8 FLOOR DRAIN	(EMERGENCY)
9 FLOOR SINK	9X2 18 FIXTURE UNITS
2 TRENCH DRAIN	2X4 8 FIXTURE UNITS
4 LAVS	4X1 4 FIXTURE UNITS
2 SINK (1-COMP)	2X2 4 FIXTURE UNITS
1 SINK (3-COMP)	1X5 5 FIXTURE UNITS
6 HANDSINK	6X1 6 FIXTURE UNITS
1 DISHWASHER	1X4 4 FIXTURE UNITS
1 ICE MACHINE	1X3 3 FIXTURE UNITS
1 MOP SINK	1X3 3 FIXTURE UNITS
1 URINAL	1X2 2 FIXTURE UNITS
5 WC	5X4 20 FIXTURE UNITS
TOTAL:	77 FIXTURE UNITS

AVERAGE: 77 FU x 0.70 ERU's x 250 gpd =
13,475 gpd = 0.0135 mgd
0.0135 gpd X 3.4 peak factor = 0.0458 mgd

RPDA (1) 6"

THE REDUCED PRESSURE DETECTOR ASSEMBLY SHALL BE INSTALLED IN ACCORDANCE WITH UDACS
PLATE 56. NO WATER SHALL BE TAKEN FROM A SERVICE REQUIRING BACKFLOW PREVENTION UNTIL
THE ASSEMBLY HAS BEEN SUCCESSFULLY TESTED BY THE LVVMD. ANY BLOCK WALL OR OTHER
FENCE MATERIAL SHALL BE DESIGNED AND CONSTRUCTED AROUND THE OUTSIDE OF EASEMENT(S),
SO AS TO ALLOW THE DISTRICT DIRECT ACCESS FROM THE ADJACENT RIGHT-OF-WAY.
EASEMENTS SHALL BE CLEARLY MARKED OR STAKED PRIOR TO THE START OF CONSTRUCTION.

RPDA (1) 1 1/2"

APPROVED REDUCED PRESSURE PRINCIPLE ASSEMBLY(S) SHALL BE INSTALLED PER THE UDACS PLATE NO.
8. NO WATER SHALL BE TAKEN FROM A SERVICE REQUIRING BACKFLOW PREVENTION UNTIL THE REDUCED
PRESSURE ASSEMBLY HAS BEEN SUCCESSFULLY TESTED BY THE LVVMD. ANY BLOCK WALL OR OTHER
FENCE MATERIAL SHALL BE DESIGNED AND CONSTRUCTED AROUND THE OUTSIDE OF THE EASEMENT(S), TO
ALLOW LVVMD DIRECT ACCESS FROM THE ADJACENT RIGHT-OF-WAY. EASEMENTS SHALL BE CLEARLY
MARKED OR STAKED PRIOR TO THE START OF CONSTRUCTION.

BASIS OF BEARING


NORTH 28°02'08" EAST, BEING THE BEARING OF THE CENTERLINE OF LAS VEGAS BOULEVARD BETWEEN ST.
LOUIS AVENUE AND OAKLEY BOULEVARD LOCATED IN THE NORTHWEST QUARTER (NW 1/4) OF THE
SOUTHWEST QUARTER (SW 1/4) OF SECTION 3, TOWNSHIP 21 SOUTH, RANGE 61 EAST, M.D.M., CITY OF
LAS VEGAS, CLARK COUNTY, NEVADA, AS SHOWN BY MAP THEREOF ON FILE IN FILE 193 OF SURVEYS,
PAGE 94, OFFICIAL RECORD'S CLARK COUNTY, NEVADA.

BENCHMARK

CITY OF LAS VEGAS BENCHMARK "OAKLEY 5", BEING A RIVET AND PLATE IN THE TOP OF CURB AT SE
CORNER OF OAKLEY BLVD & LAS VEGAS BLVD. ALSO STAMPED 8LV113W6

ELEVATION: 2030.6 US SURVEY FEET OR 618.927 METERS (NAVD 88)

Call before you Dig

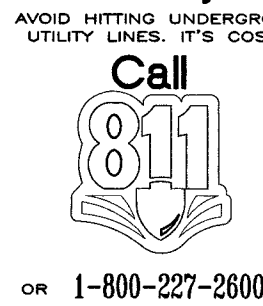

OR 1-800-227-2600



Call before UnderGround

1-702-432-5300



Call Before You OverHead

1-702-227-2929

ABANDONMENT OF EXISTING SERVICE - 2" AND SMALLER

2" METER, ACCOUNT #9700, SERIAL NUMBER 0656193

THE CONTRACTOR SHALL NOTIFY THE INSPECTION
DIVISION AT THE LVVMD (702-258-3227) 48 HOURS
PRIOR TO THE REQUESTED REMOVAL TIME TO ALLOW THE
DISTRICT TO TAKE THE FINAL METER READING. AFTER
THE FINAL READING, THE CONTRACTOR MAY THEN BEGIN
REMOVAL PROCEDURES FOR THE AFFECTED SERVICE AS
FOLLOWS:

EXISTING SERVICE LATERALS THAT ARE TO BE
ABANDONED FROM THE EXISTING WATER MAINS SHALL
HAVE THE CORPORATION STOPS TURNED OFF AT THE
MAIN, A MINIMUM OF TWELVE (12) INCHES OF THE
LATERAL CUT OUT NEAR THE CORPORATION STOPS, A
BRASS CAP INSTALLED ON THE CORPORATION STOP. IF
THE CORPORATION STOP IS DAMAGED BEYOND REPAIR
OR PULLED FROM THE EXISTING WATER MAIN, THE MAIN
SHALL BE REPAIRED AT THE CONTRACTOR'S EXPENSE, IN
A MANNER APPROVED BY THE DISTRICT. IF THE
CORPORATION STOP IS NOT WATER TIGHT, THE
CONTRACTOR SHALL NOTIFY THE LVVMD COMMUNICATION
SUPPORT CENTER AT 702-258-7171 FOR FURTHER
DIRECTION.


THE EXISTING METER SHALL BE REMOVED AND DELIVERED
TO THE DISTRICT. THE CONTRACTOR SHALL REMOVE THE
EXISTING SERVICE METER BOX AND APPURTENANCES, FILL
AND GRADE ANY AND ALL RESULTING VOIDS, AND
REPLACE OR RESTORE TO ORIGINAL CONDITIONS OR
BETTER, ALL LANDSCAPING, IRRIGATION SYSTEMS,
CONCRETE, SIDEWALKS, ASPHALT, OR ANY OTHER ITEMS
DAMAGED OR REMOVED DURING THE REMOVAL OF THE
EXISTING METER BOX.

EXISTING POWER POLE
AND OVERHEAD ELEC.
WIRE TO BE REMOVED
PER NV ENERGY PLANS

UTILITY NOTES AND QUANTITIES

THE QUANTITY ESTIMATES SHOWN HEREON ARE APPROXIMATE AND NO
ONE IS TO RELY UPON THEM FOR PAY QUANTITIES

		UNITS	PUBLIC	PRIVATE
WATER				
1	INSTALL 8"x6" TAPPING SLEEVE W/ 6" TAPPING VALVE PER UDACS 2.24.01 (A) PLATES 30, 34 AND 39	EA	2	—
2	INSTALL 6" GATE VALVE PER UDACS PLATE 30 AND 39	EA	2	—
3	INSTALL 1 1/2" WM, SERVICE SADDLE & CORP. STOP PER UDACS PLATE 4	EA	1	—
4	INSTALL 1 1/2" RPDA PER PLATE 8	EA	1	—
5	INSTALL 2" PVC WATER LATERAL	LF	—	5
6	INSTALL 1 1/2" COPPER LINE PER UDACS PLATE 4	LF	15	—
7	INSTALL 1 1/2" BRASS PIPE & FITTINGS	EA	1	—
8	INSTALL CURB STOP PER DETAIL THIS SHEET	EA	1	—
9	INSTALL 6" CHECK VALVE	EA	—	1
10	INSTALL 6" RPDA PER UDACS PLATE 56	EA	1	—
11	INSTALL 6" 90° BEND PER UDACS PLATE 31	EA	—	4
12	INSTALL 6" C-900 PRESSURE CLASS 305 WATER LINE	LF	42	303
13	INSTALL DOWNSTREAM 6" GATE VALVE WITH VALVE LOCK PER UDACS PLATE 30 AND 39	EA	1	—
14	SAWCUT, TRENCHING AND BACKFILL PER UDACS PLATE 17, CCAUUSD 503.1, PAVEMENT RESTORATION PER CCAUSD 500.5	EA	1	—
15	INSTALL FIRE HYDRANT ASSEMBLY W/ 6" GATE VALVE PER UDACS PLATE 40, 30 AND 39	EA	1	—
16	INSTALL BLUE REFLECTIVE MARKER	EA	1	—
17	FIRE DEPARTMENT CONNECTION	EA	1	—
SEWER				
A	INSTALL 6" PVC SEWER LATERAL (PRIVATE) PER SD-18, SD-22 AND SD-25	LF	—	214
B	INSTALL 6" CLEANOUT PER SD-26 WITH TRAFFIC RATED LID	EA	—	3
C	INSTALL 1500 GAL GREASE INTERCEPTOR AND A SAMPLE BOX PER BUILDING PERMIT	EA	—	1

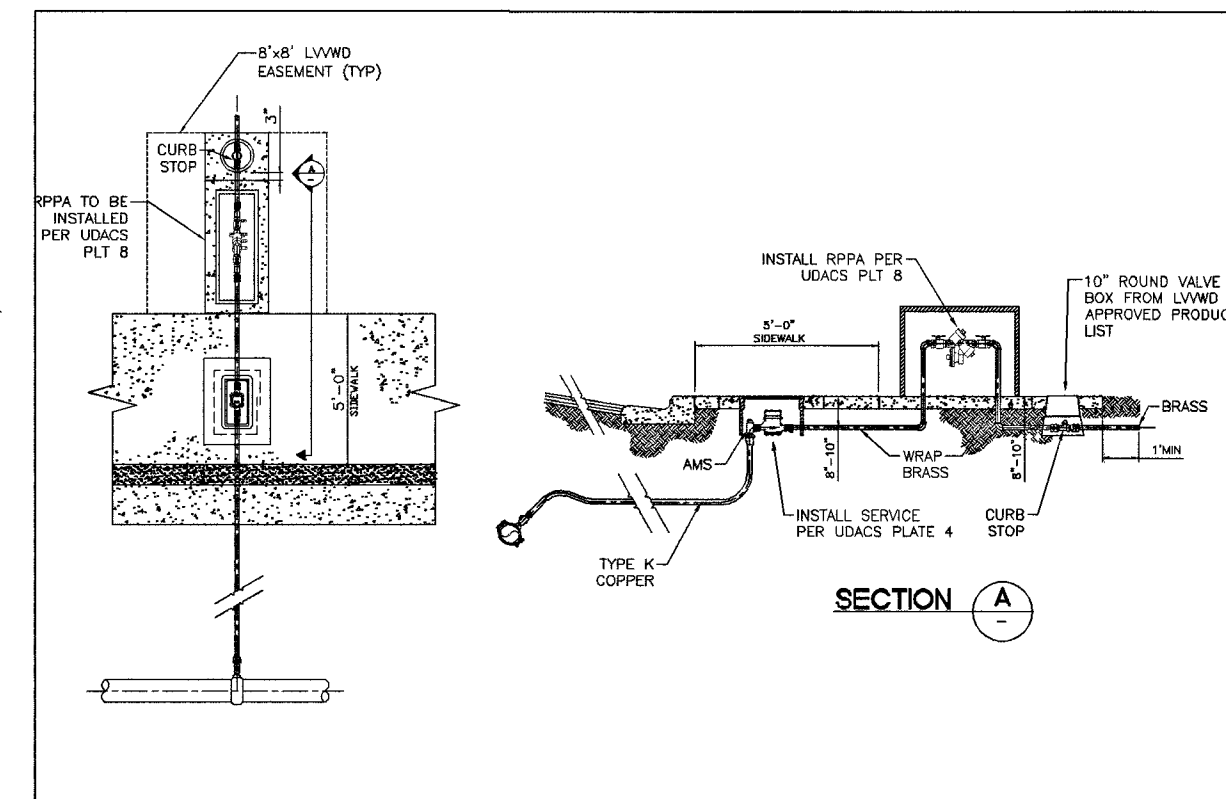

DETAIL 2
NOT TO SCALE

APPROVED FOR CONSTRUCTION:

LAS VEGAS VALLEY WATER DISTRICT ENGINEERING SERVICES

PROJECT # 136290

FIRST APPROVED DATE:

SHEETS: C1, C2, C5

LVVMD APPROVED FIRE FLOW: 1,500 GPM

FIRE SPRINKLERS: 600 GPM

SQUARE FOOTAGE = 6,610

LARGEST AREA BETWEEN 4 HOUR WALLS = 6,610

NUMBER OF STORIES INCLUDING BASEMENT = 1

MAX HEIGHT = 20 FEET

HIGH PILED STORAGE = NO


NUMBER OF HYDRANTS = 1

CITY OF LAS VEGAS FIRE AND RESCUE (C1, C2, C5) DATE

SOUTHWEST GAS CORPORATION DATE

IHOP - LAS VEGAS BOULEVARD UTILITY PLAN

DESIGNED BY: PB
CHECKED BY: PB
DATE: 07/08/19
JOB #: 18-IHOP
APN: 162-03-310-007
SHEET 3 OF 5
SCALE: HORIZ 1" = 20'

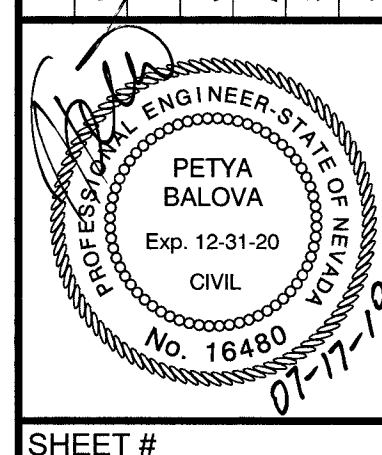

SHEET #
C5
5 OF 6

PROJ: 136290 QS: 162-03-310-007

BASIS OF BEARING

NORTH 28°02'08" EAST, BEING THE BEARING OF THE CENTERLINE OF LAS VEGAS BOULEVARD BETWEEN ST. LOUIS AVENUE AND OAKLEY BOULEVARD LOCATED IN THE NORTHWEST QUARTER (NW 1/4) OF THE SOUTHWEST QUARTER (SW 1/4) OF SECTION 3, TOWNSHIP 21 SOUTH, RANGE 61 EAST, M.D.M., CITY OF LAS VEGAS, CLARK COUNTY, NEVADA, AS SHOWN BY MAP THEREOF ON FILE IN FILE 193 OF SURVEYS, PAGE 94, OFFICIAL RECORDS CLARK COUNTY, NEVADA.


NOTES:

1. REPLACE ALL TRAFFIC CONTROL DEVICES (SIGNS OR PAVEMENT MARKINGS) UNDER THAT ARE DISTURBED, DESTROYED, MOVED OR MODIFIED BY TRENCHING ACTIVITY TO CITY OF LAS VEGAS SATISFACTION. ALL MATERIALS USED SHALL MEET CLARK COUNTY'S SPECIFICATIONS, OR WILL BE AN APPROVED EQUIVALENT.
2. NO WALLS, FENCES, TREES, SHRUBS, UTILITY APPURTENANCES OR ANY OTHER OBJECT, OTHER THAN TRAFFIC CONTROL DEVICES AND STREET LIGHT POLES, MAY BE CONSTRUCTED OR INSTALLED WITHIN THE SIGHT VISIBILITY ZONE UNLESS SAID OBJECT IS MAINTAINED AT LESS THAN 24 INCHES IN HEIGHT, MEASURED FROM TOP OF CURB, OR WHERE NO CURB EXISTS, A HEIGHT OF 27 INCHES MEASURED FROM THE TOP OF ADJACENT ASPHALT, GRAVEL OR PAVEMENT STREET SURFACE.

TRAFFIC QUANTITIES

THE QUANTITY ESTIMATES SHOWN HEREON ARE APPROXIMATE AND NO ONE IS TO RELY UPON THEM FOR PAY QUANTITIES

#	ITEM	UNIT	QNTY PUBLIC	QNTY PRIVATE
1	SIGHT VISIBILITY ZONE			
2	INSTALL HC PARKING SPACE SIGN "MIN \$250 FINE IF USED BY OTHERS NRS 484.408"			2
3	INSTALL WHEEL STOPS			2
4	INSTALL "ONE WAY" SIGN			1
5	PROPOSED MARQUEE SIGN (BY OTHERS)			1

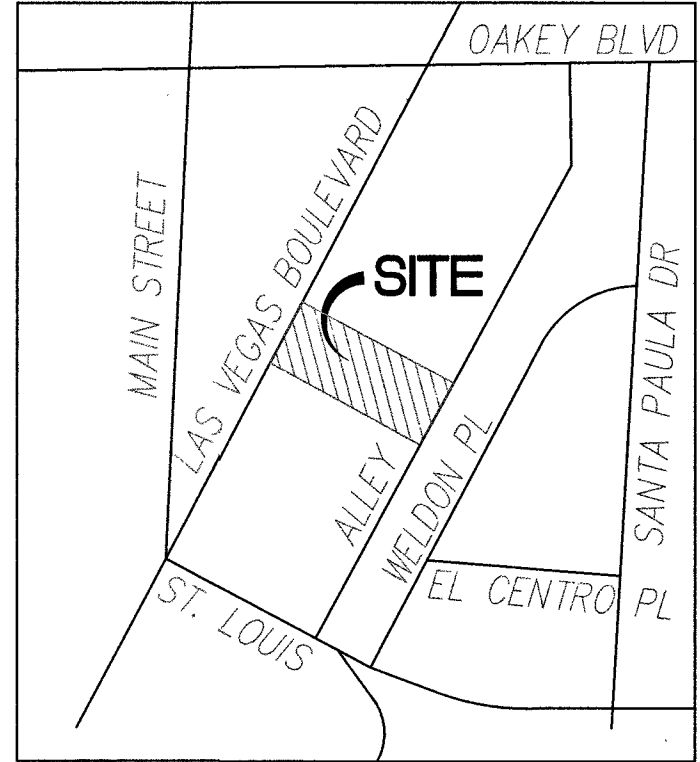

VICINITY MAP


NOT TO SCALE

LOCATED IN THE NORTH HALF OF THE SOUTHWEST QUARTER (SW 1/4) OF SECTION 3, TOWNSHIP 21 SOUTH, RANGE 61 EAST M.D.M., CLARK COUNTY, NEVADA.

IHOP - LAS VEGAS BOULEVARD
HORIZONTAL CONTROL PLAN
AND TRAFFIC CONTROL PLAN

1809 S. LAS VEGAS BOULEVARD
LAS VEGAS, NV 89104

DESIGNED BY: PB
CHECKED BY: PB
DATE: 07/08/19
JOB #: 18-IHOP
APN: 162-03-310-007
SECT 3 T21SR 61E
SCALE: HORIZ 1" = 20'

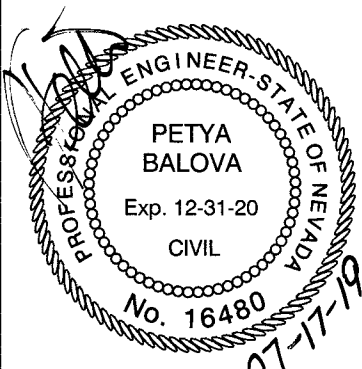

SHEET #

C6

6 OF 6


Call before you Dig
AVOID HITTING UNDERGROUND UTILITY LINES. IT'S COSTLY.

Call
811
OR 1-800-227-2600

FAST
Call before
UnderGround
1-702-432-5300
FREEWAY AND ARTERIAL SYSTEM OF TRANSPORTATION


AVOID HITTING OVERHEAD POWER LINES. IT'S COSTLY.

Call
Before You OverHead
1-702-227-2929

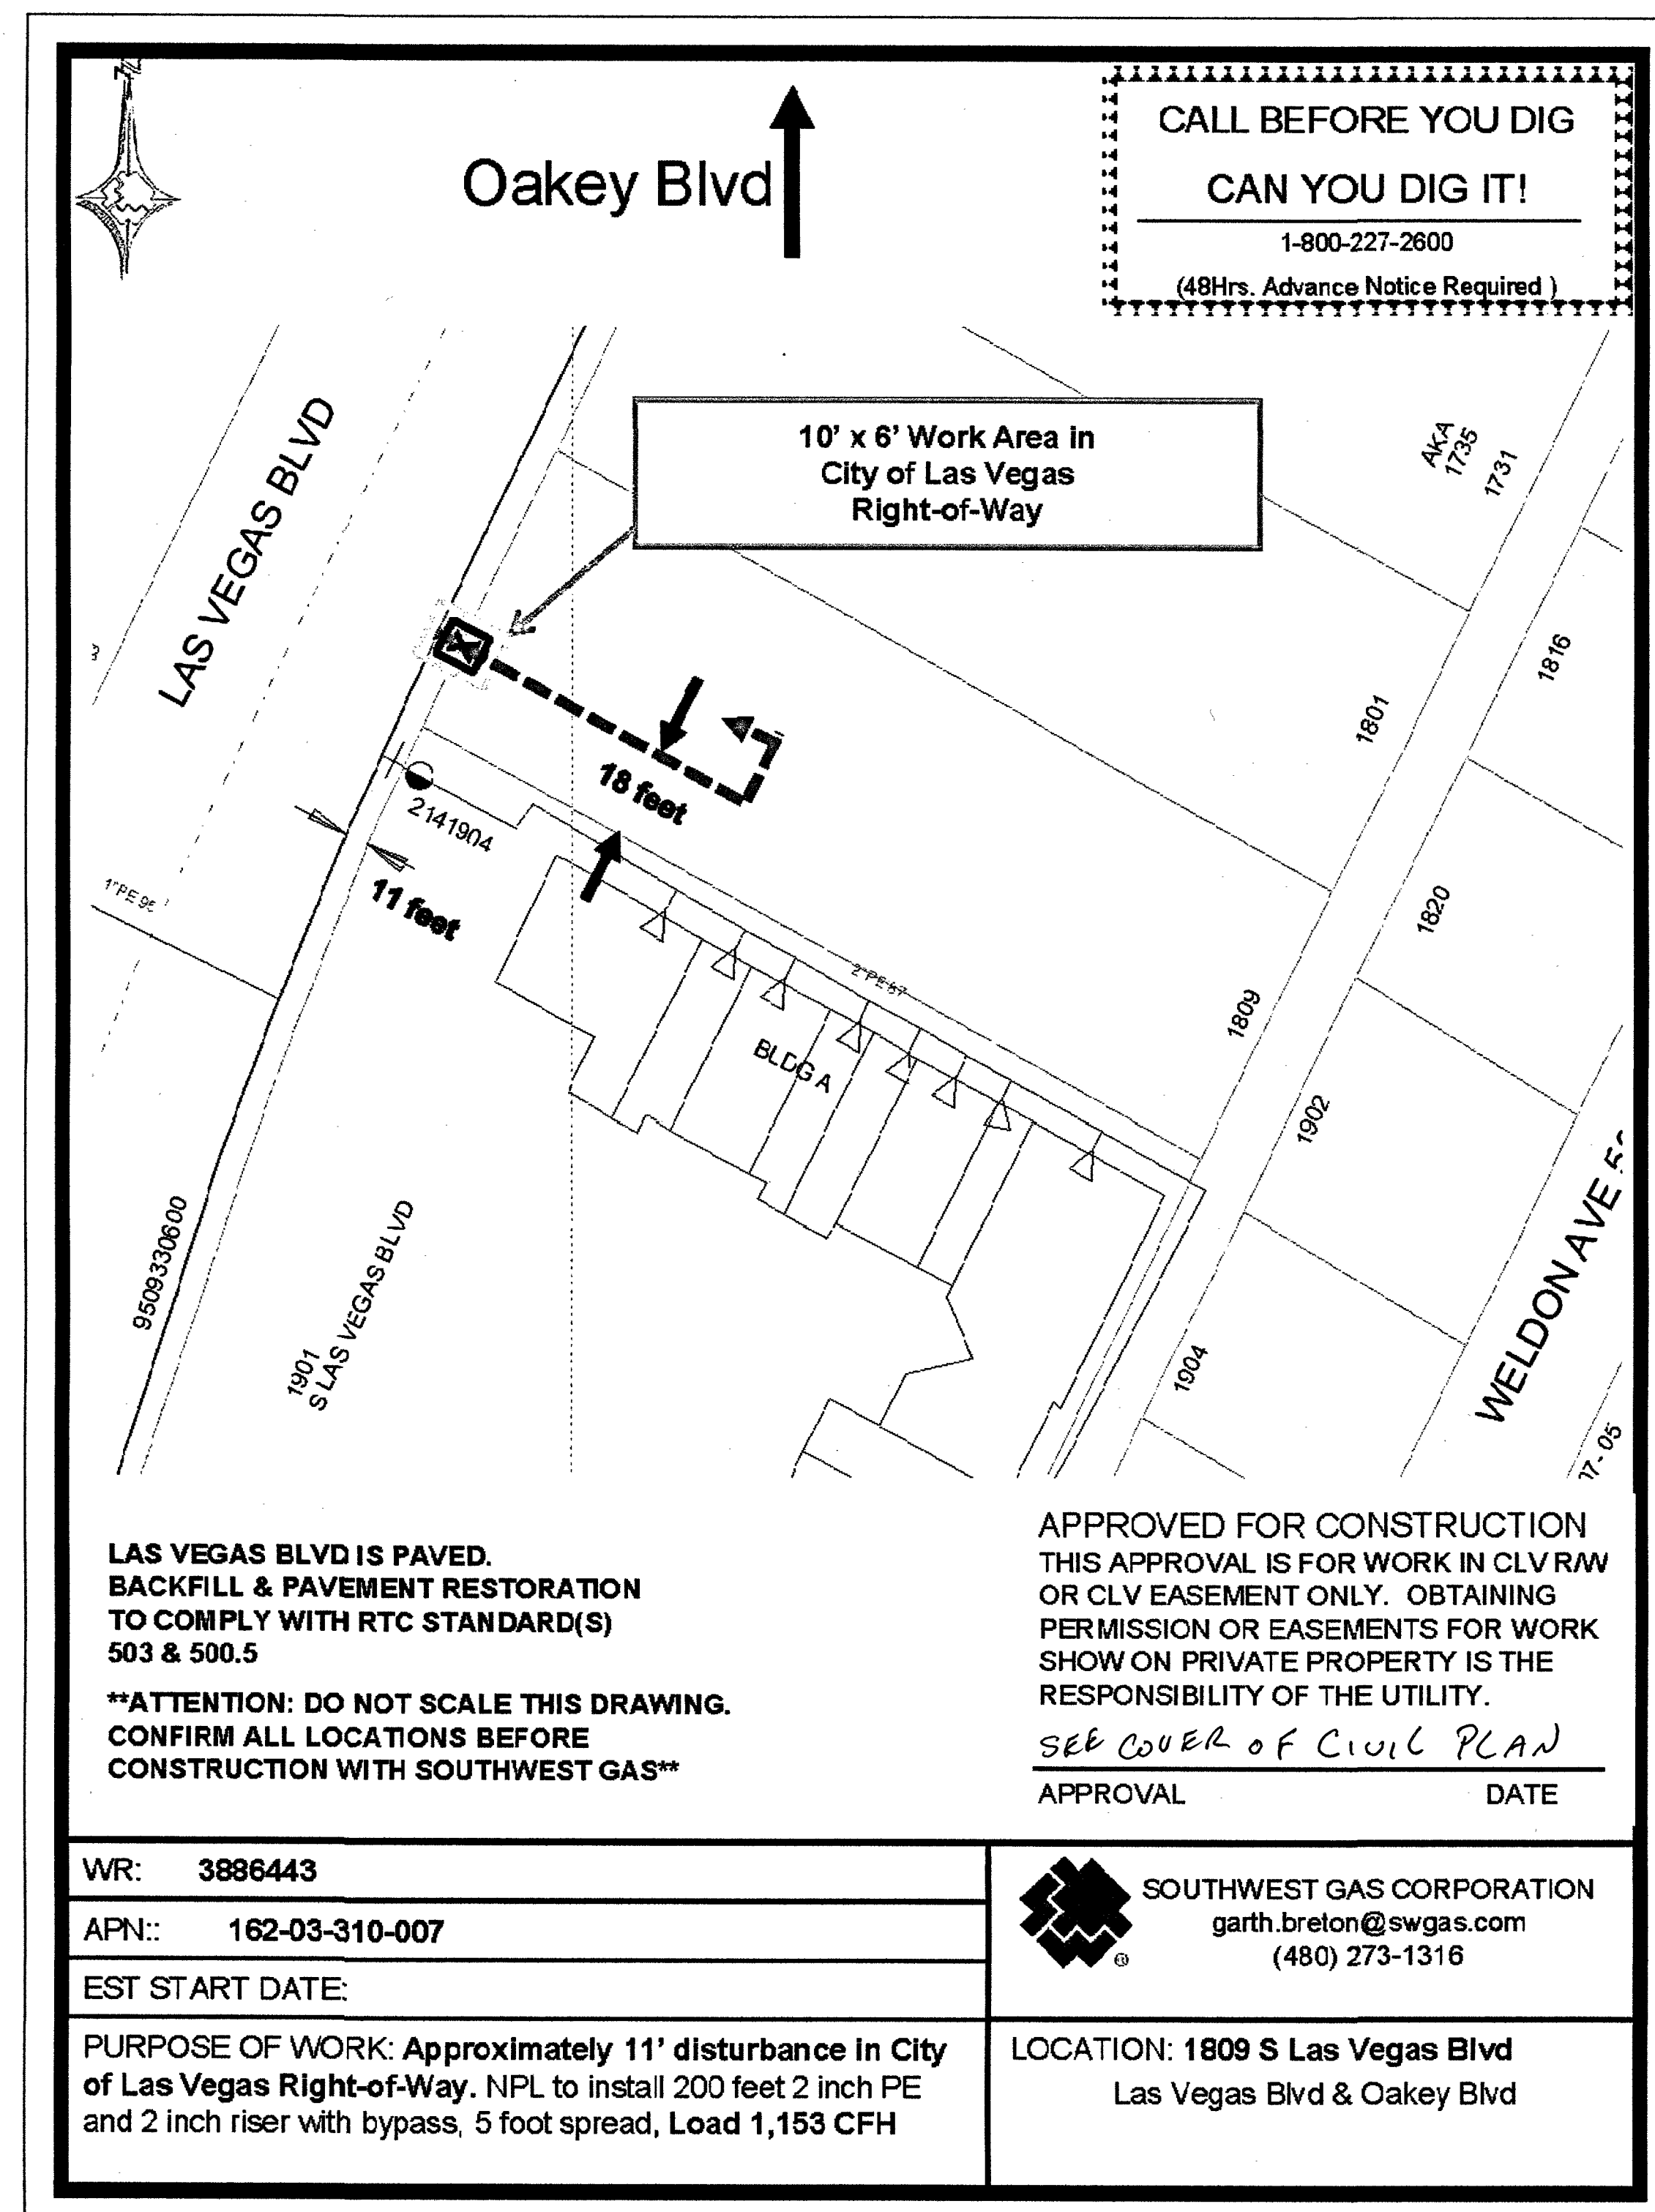


NOT TO SCALE

218-02578
 10745103

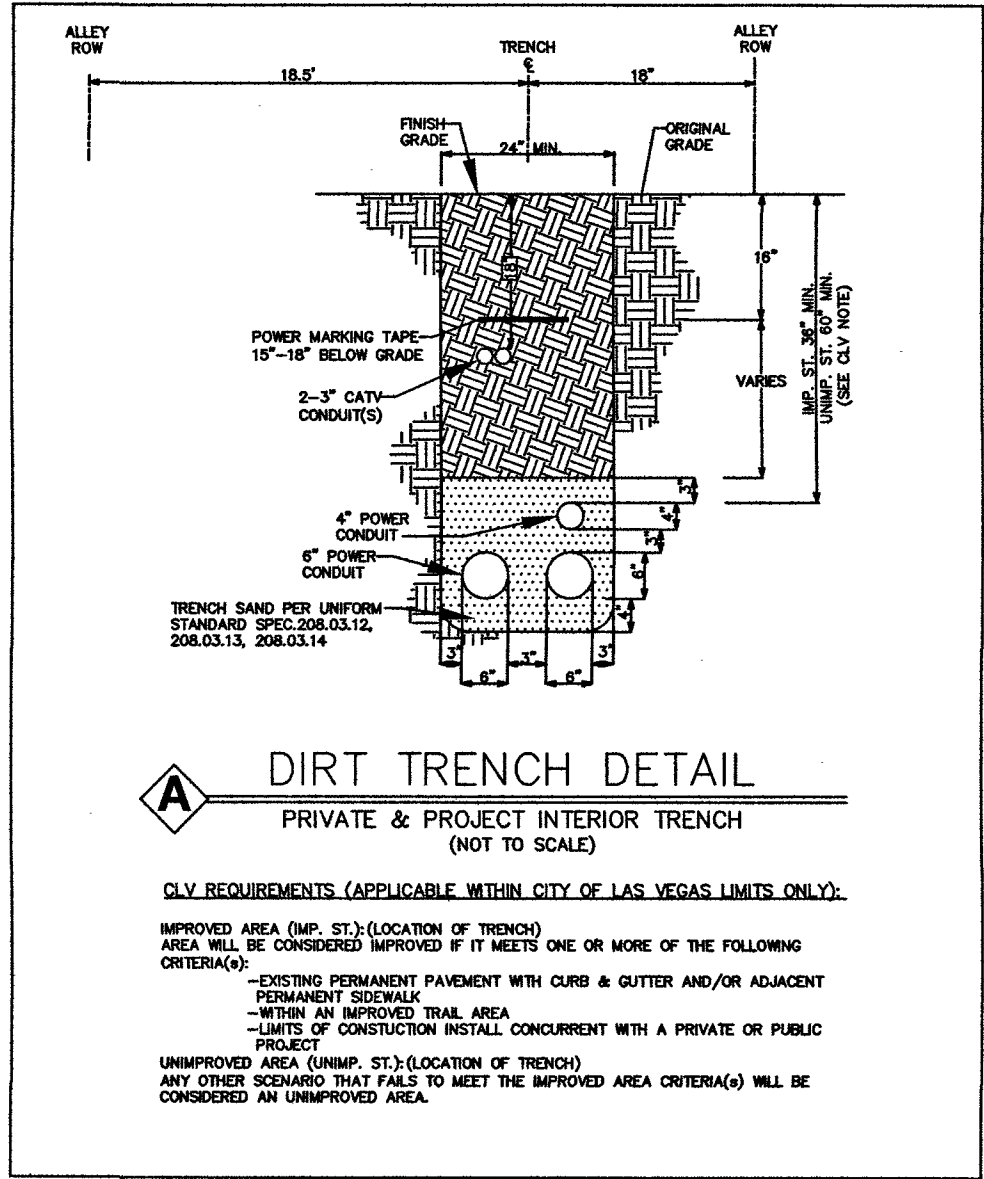

LEGEND			
1	INSTALL B-36 PULL BOX (24"x36"x24")		
2	EXISTING B-36 PULL BOX (24"x36"x24")		
3	INSTALL B-50 PULL BOX (13"x24"x24")		
4	EXISTING B-50 PULL BOX (13"x24"x24")		
5	INSTALL B-100 PULL BOX (24"x36"x24")		
6	EXISTING B-100 PULL BOX (24"x36"x24")		
7	INSTALL T-200 CATV VAULT (30"x48"x36")		
8	EXISTING T-200 CATV VAULT (30"x48"x36")		
9	INSTALL T-400 CATV VAULT (36"x60"x36")		
10	EXISTING T-400 CATV VAULT (36"x60"x36")		
11	INSTALL T-600 CATV VAULT (48"x72"x36")		
12	EXISTING T-600 CATV VAULT (48"x72"x36")		
13	INSTALL NEW CATV PEDESTAL		
14	EXISTING CATV PEDESTAL		
15	R&R S/W SLAB(S)		
16	POTHOLE		
17	SIDEWALK/DIRT TRENCH INSTALL WITH FIBER/COAX PULL		
18	ASPHALT MITIGATION/STREET TRENCH WITH FIBER/COAX PULL		
19	PROPOSED BORE WITH FIBER/COAX PULL		
20	EXISTING CATV CONDUIT(S)		
21	PROPOSED OVERHEAD FIBER OPTIC CABLE OR COAX INSTALL		
22	EXISTING OVERHEAD FIBER OPTIC CABLE OR COAX		
23	U.G. FIBER/COAX PULL THROUGH EXISTING CONDUIT		
24	RIGHT OF WAY LINE		
25	LOT/PROPERTY LINE		
26	EDGE OF PAVEMENT/ SIDEWALK/CONCRETE		
27	EXISTING NVE PULL BOX		
28	EXISTING TELCO PULL BOX		
29	EXISTING COMMUNICATION MANHOLE		
30	EXISTING TELCO POLE		
31	EXISTING NVE POLE		
32	EXISTING NVE TRANSMISSION POLE		
33	EXISTING JOINT POLE		
34	EXISTING JOINT POLE WITH TRANSFORMER		
35	POLE ANCHOR		
36	EXISTING NVE TRANSFORMER TRANSFORMER PAD		
37	SNWA TEST STATION		
38	COX POWER SUPPLY (49"x24"x52")		
39	CABINET (RHINO,ODN,OLM)		
40	RISER POLE/QUADRANT DETAIL RISER OWNERSHIP NOTED		
41	RAILROAD		
42	EXISTING MANHOLE (SS),(SD)...ECT		
43	1in CONDUIT LATERAL		
44	STORMWATER ASSETS		
45			

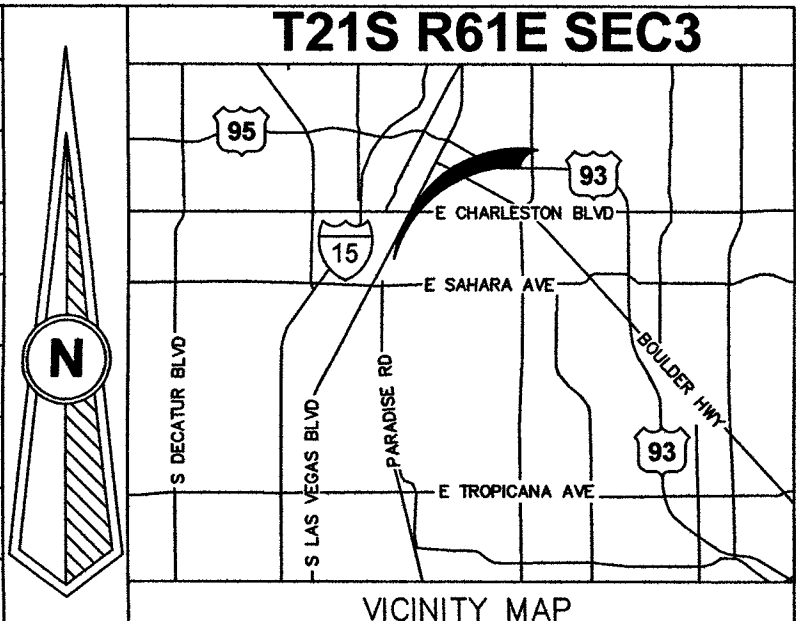

REVISIONS			
REV	DESCRIPTION	DATE	BY
0			
1			
2			
3			
4			
5			

ALL CONSTRUCTION AND MATERIALS SHALL BE IN ACCORDANCE WITH THE "UNIFORM STANDARD SPECIFICATIONS FOR PUBLIC WORKS CONSTRUCTION OFF-SITE IMPROVEMENTS, CLARK COUNTY AREA NEVADA" LATEST ISSUE; THE "UNIFORM STANDARD DRAWINGS FOR PUBLIC WORKS CONSTRUCTION, CLARK COUNTY AREA NEVADA", LATEST ISSUE; AND OTHER APPLICABLE APPROVED STANDARDS ISSUED BY THE CONTROLLING AGENCY; ALL LOCAL CITY CODES AND ORDINANCES APPLICABLE.

APPROVED FOR CONSTRUCTION
THIS APPROVAL IS FOR WORK IN CLV R/W OR CLV EASEMENT ONLY. OBTAINING PERMISSION OR EASEMENT FOR WORK SHOWN IN PRIVATE PROPERTY IS THE RESPONSIBILITY OF THE UTILITY.
SEE COVER OF CIVIL PLAN
APPROVAL _____ DATE _____

PERMIT #	N/A
DRAWN BY:	WTB
DATE:	7/15/2019
SCALE:	1" = 30'
MODE:	RO098
PROJECT #:	4052019000000TRSTRC
TECH #	702-210-7014
APPROVED BY:	GARY BAUMAN

1700 VEGAS DRIVE
LAS VEGAS, NEVADA 89106
PHONE: (702) 545-1606
FAX: (702) 545-2606

CITY OF LAS VEGAS
333 N. RANCHO DRIVE
LAS VEGAS, NEVADA 89106
(702) 229-6885

PROJECT LOCATION:
LAS VEGAS BLVD & ST LOUIS AVE

SUB-CONTRACTOR:
DBA: COX COMMUNICATIONS

ENTITY NOTES:
1/8-02470 -NONE 107V 7774

SHEET No: **1**
Sheet 1 of 1

DISCLAIMER NOTE

UTILITY LOCATIONS SHOWN HEREON ARE APPROXIMATE ONLY. IT SHALL BE THE CONTRACTOR'S RESPONSIBILITY TO DETERMINE THE EXACT HORIZONTAL AND VERTICAL LOCATION OF ALL EXISTING UNDERGROUND AND OVERHEAD UTILITIES PRIOR TO COMMENCING CONSTRUCTION. NO REPRESENTATION IS MADE THAT ALL EXISTING UTILITIES ARE SHOWN HEREON. THE ENGINEER ASSUMES NO RESPONSIBILITY FOR UTILITIES NOT SHOWN OR UTILITIES NOT SHOWN IN THEIR PROPER LOCATIONS.






BEFORE YOU DIG
OR 1-800-227-2600
UNDERGROUND SERVICE (USA)

BEFORE YOU OVERHEAD
CALL
1-702-227-2929
NEVADA POWER ENVIRONMENT AND SAFETY SERVICE DEPARTMENT

BEFORE YOU UNDERGROUND
CALL
1-702-455-7511
CLARK COUNTY TRAFFIC OPERATIONS
1-702-452-4300
LAS VEGAS AREA COMPUTERIZED SYSTEM

BEFORE YOU UNDERGROUND
CALL
1-702-455-7511
CLARK COUNTY TRAFFIC OPERATIONS
1-702-452-4300
LAS VEGAS AREA COMPUTERIZED SYSTEM

TOTAL BORE	0'
TOTAL DIRT TRENCH	0'
TOTAL ASPHALT TRENCH	0'
TOTAL TRENCH	0'
SIDEWALK REMOVAL/REPAIR	0
TOTAL S/W PANELS	0
TOTAL LINEAR FOOTAGE	0'

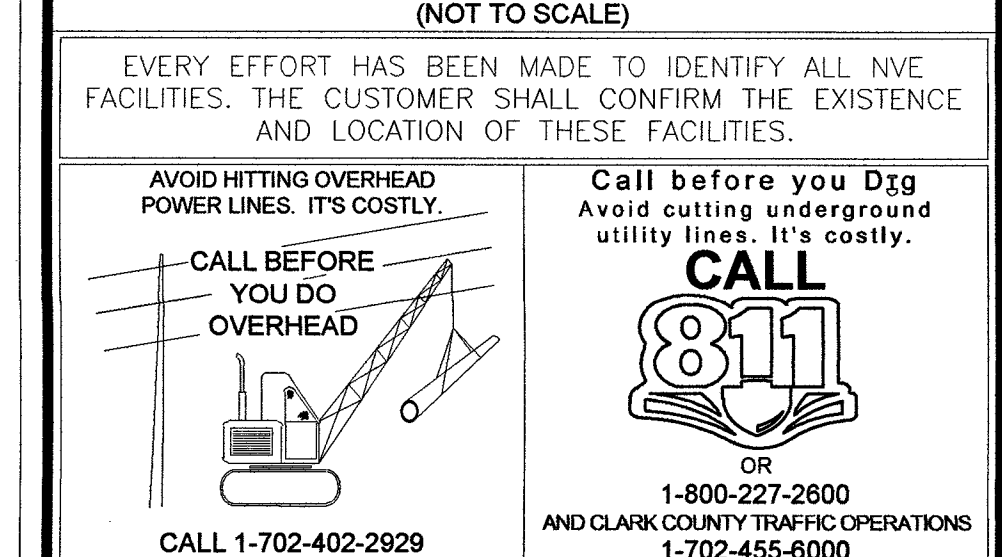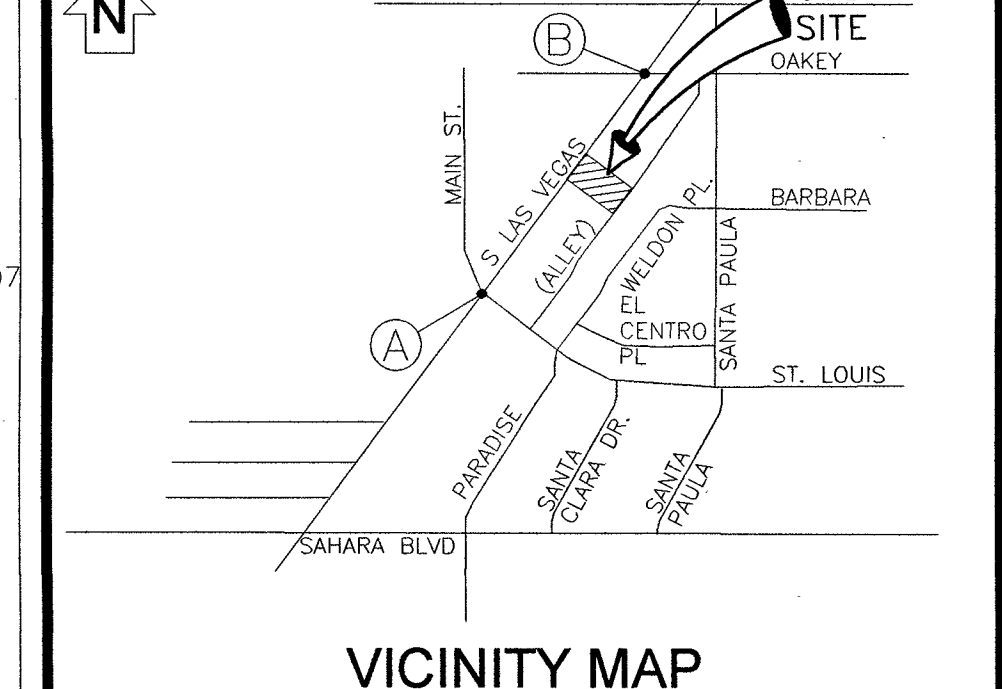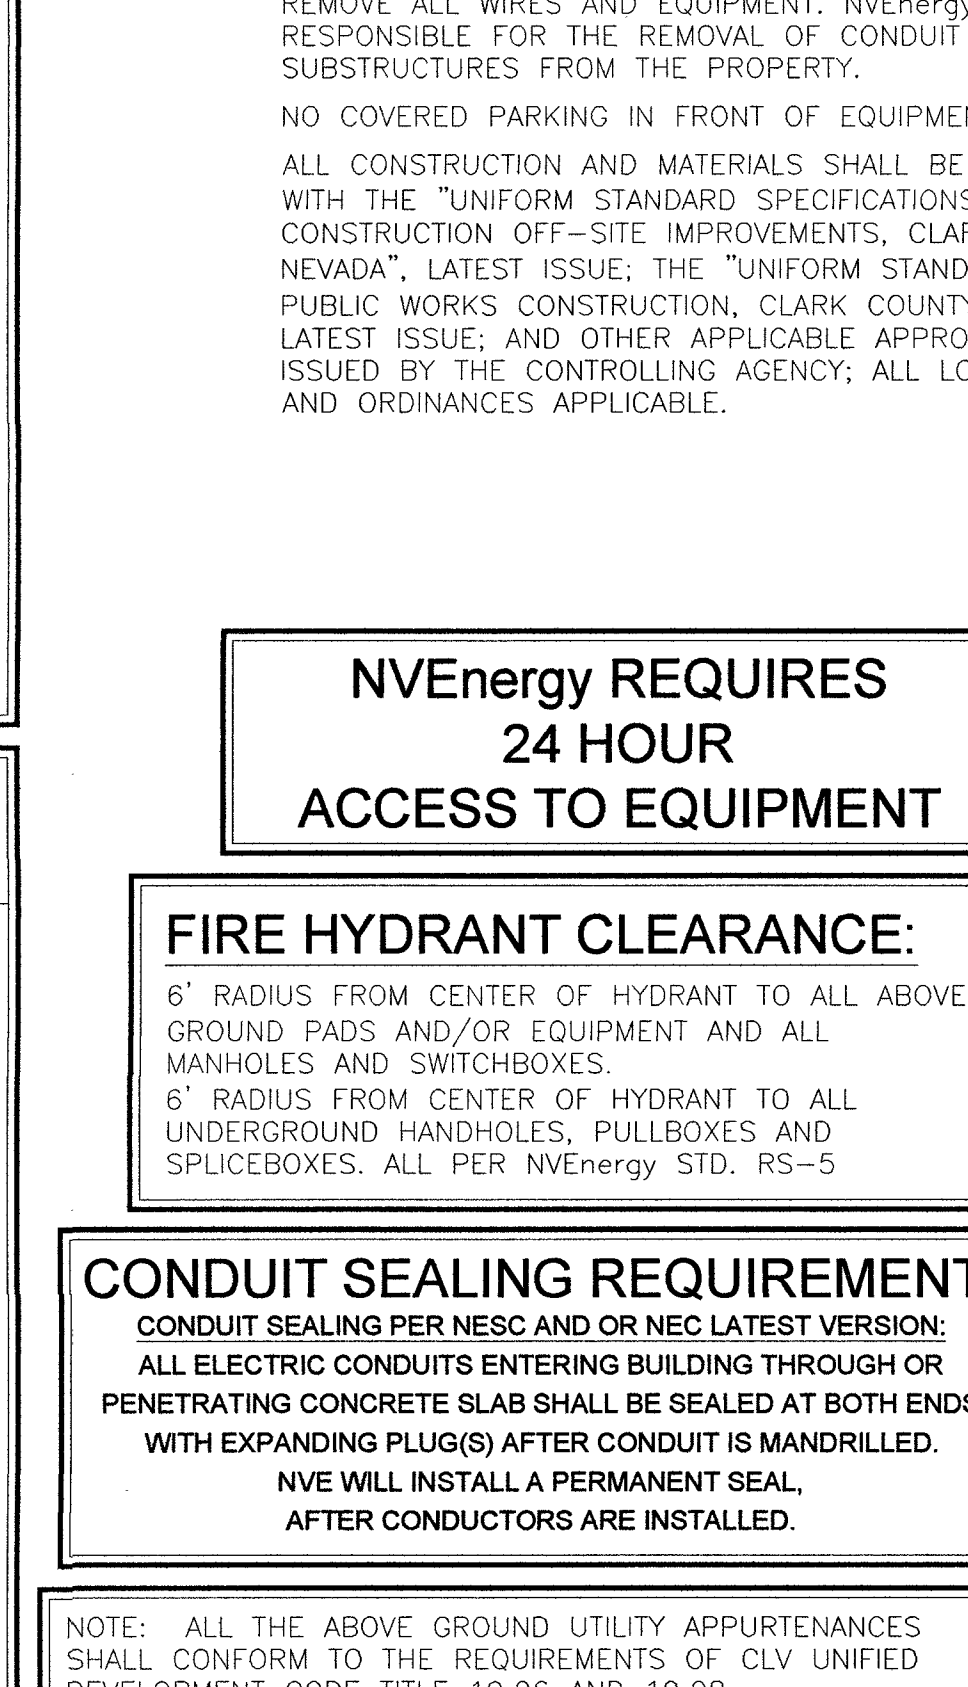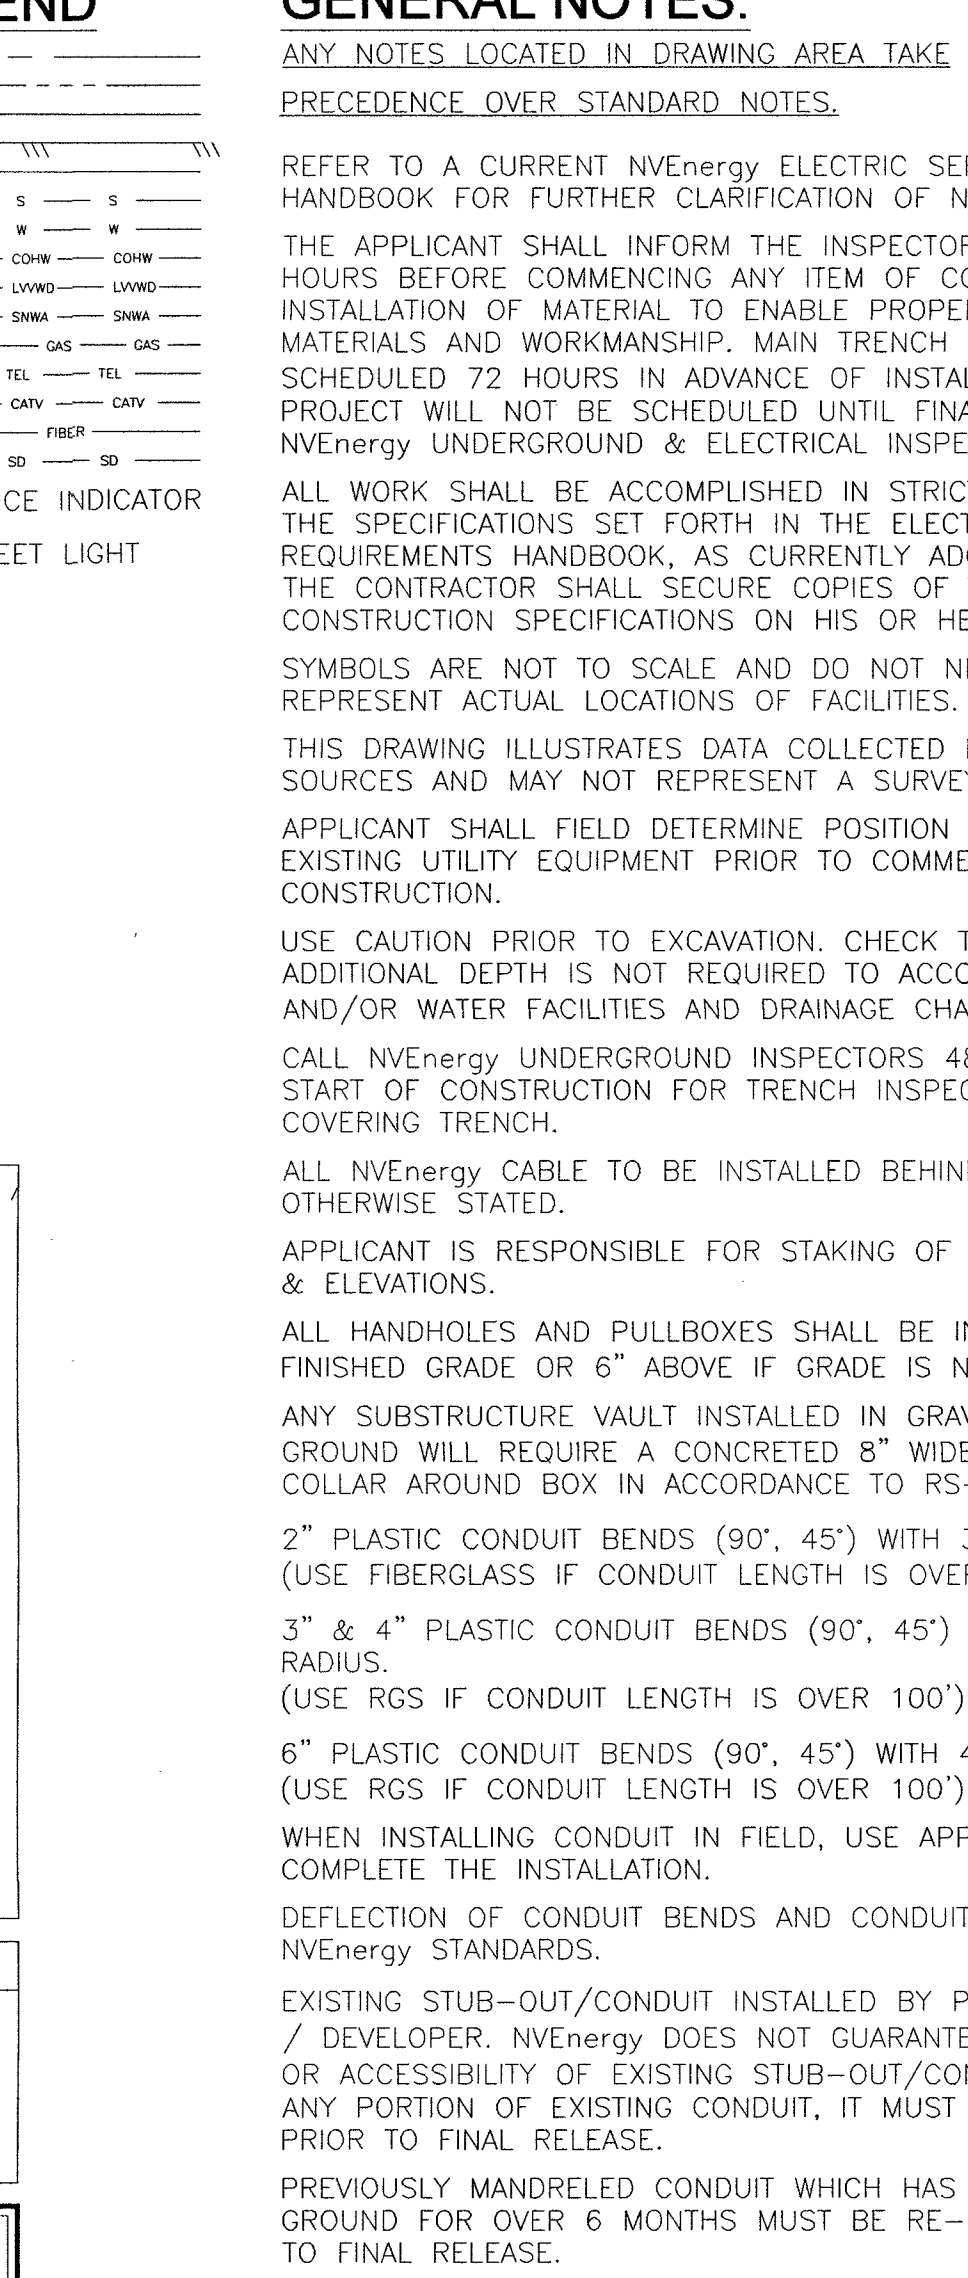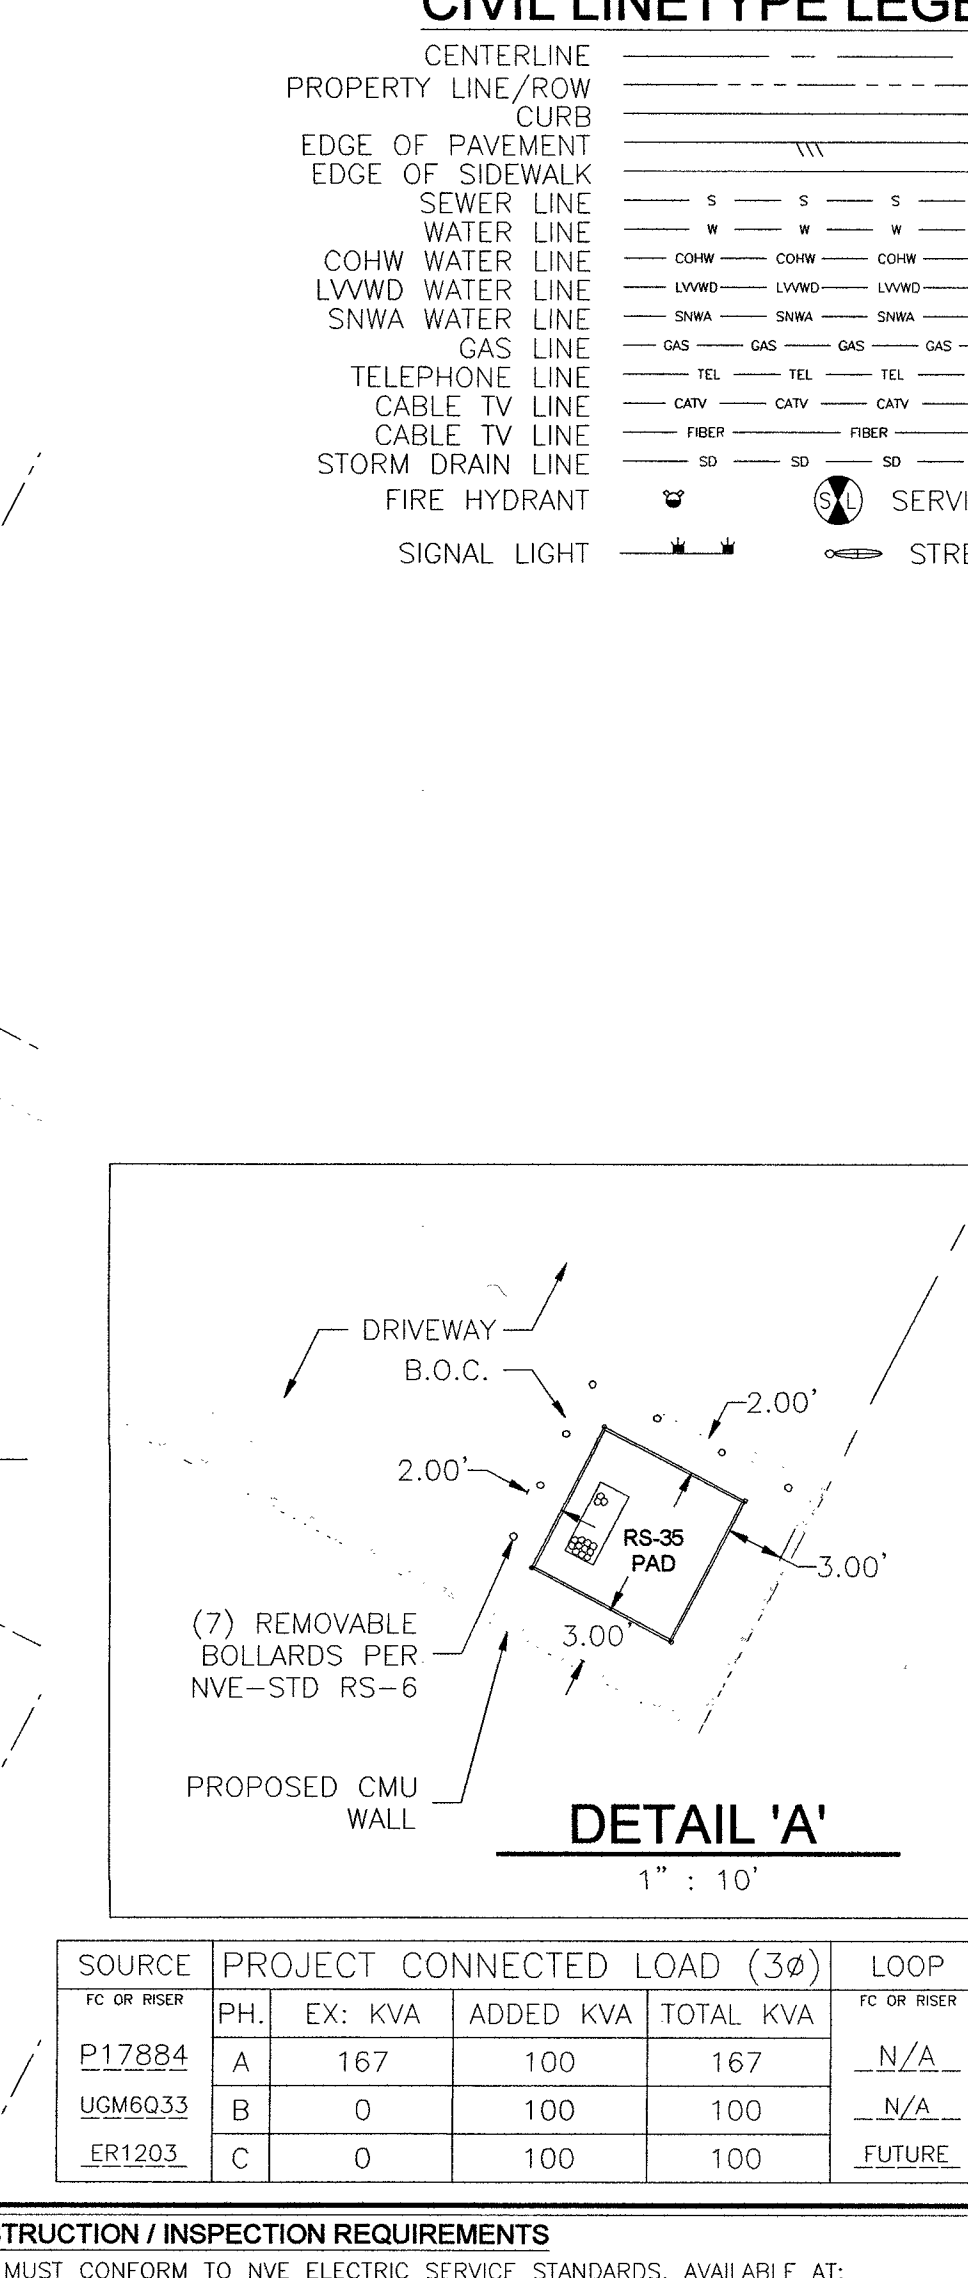[illegible]

STANDARD

PROJECT PURPOSE:

TO PROVIDE 3 ϕ 120/208v SERVICE TO (1) NEW 800 AMP
PANEL FOR NEW STAND ALONE RESTAURANT.

EXHIBIT 'A'

NvEnergy INFORMATION:
COORDINATOR: GRAY, PATRICE
PHONE: (702)402-6828 D.F. CC
DESIGNER: MITCHELL, ARTHUR
DCA: N/A
INSPECTOR: 702-402-3008 OR UGI@NVENERGY.COM
STAND BY: (702) 402-4450, 4150, 4114, 4117, 4118
DISTRICT: LVN
JPA INFORMATION:
JPA ADMIN PHONE: (702) 595-2551 JPA#: P201216621
CUSTOMER INFORMATION:
APPLICANT: SS&D NEVADA PROPERTIES LLC
APPLICANT CONTACT: ASHOORI, SEAN
CONTACT: SEGLER, KRISTOFER ** 702-685-0136
APPROVAL DATE: 10/15/2019
GOVERNMENT INFORMATION:
AGENCY: CLV
APPROVAL DATE: _____

FOR EACH SERVICE POINT (POINT OF DELIVERY), ENERGY FOR
TENANT SPACE WILL BE MEASURED THROUGH ONE
METER. ENERGY FOR ALL NON-TENANT SPACE WILL
GO THROUGH ONE WATTHOUR METER. CONTACT NVE
FOR MULTIPLE RATE CLASS INSTALLATIONS.

NV Energy

IHOP AT LAS VEGAS BLVD

218-02470 107V7774

LAS VEGAS BLVD / OAKEY

PROJ #3002904967	SCALE: 1"=30'
SHEET # 1 OF 1	DATE: 6/17/2019

CENTERLINE STATION TABLE							
#	STREET INTERSECTION					STA	HEADED
(A)	EAST ST LOUIS AVENUE					0+00.00	EAST
	SOUTH LAS VEGAS BOULEVARD					10+00.00	NORTH
(B)	EAST LAS VEGAS BOULEVARD					00+00.00	EAST
	SOUTH LAS VEGAS BOULEVARD					21+62.35	NORTH
STATION TABLE							
MAXIMO STATION	CORNER	CENTER LINE STATION	SIDE	OFFSET CL TO BROW	OFFSET CL TO ROW	OFFSET CL TO GROUND F2CL OF ROW	SUBSTRUCTURE INFORMATION
0000	SOUTH	14+95.32 FIELD NOTES	RT	335.79'	50.00'	337.79'	RS-35 - 8.25' X 8.25'
							PAGE NUMBER: PM204096
	NORTH	15+03.57 FIELD NOTES	RT	335.79'	50.00'	337.79'	EASEMENT NUMBER: FUTURE
							TYP. EASEMENT LAYOUT: FUTURE

NV ENERGY SCHEDULING NOTE: DAY (LANE BLOCKS)
THIS PROJECT WAS ESTIMATED WITH THE ASSUMPTION THAT ALL THE WORK BEING PERFORMED ON THIS PROJECT BY NV ENERGY CREWS CAN BE DONE DURING THE DAYTIME AND WILL REQUIRE TRAFFIC CONTROL.

GOVERNMENT APPROVAL OF THESE DRAWINGS DOES NOT INDICATE APPROVAL OF TRAFFIC CONTROL. PLEASE REFER TO THE BARRICADE PLAN FOR APPROVED TRAFFIC CONTROL REQUIREMENTS.



(NON-POTABLE WATER)
ALL EXISTING, RELOCATED OR
PROPOSED DCDA/RPDA
INSTALLATIONS:
TO COMPLY WITH THE FEDERAL
SAFE DRINKING WATER ACT, THE
FIRE LINE, OR ANY OF IT'S
COMPONENTS, SHALL NOT BE
USED FOR POTABLE DRINKING
WATER AT ANY TIME.

TREES, SHRUBS, OR DECORATIVE ROCKS, AND ANY BLOCK WALL OR OTHER FENCE MATERIAL, SHALL BE DESIGNED AND CONSTRUCTED AROUND THE EASEMENTS TO ALLOW THE DISTRICT DIRECT ACCESS TO THE VAULT(S), BACKFLOW ASSEMBLIES, AND PIPING FROM THE ADJACENT RIGHT-OF-WAY. MAINTAIN 2% MAX SLOPE WITHIN THE EASEMENT.

1. ALL EXISTING UTILITY STRUCTURES WITHIN CONSTRUCTION AREA SHALL BE ADJUSTED TO MATCH FINISH GRADE (I.E. WV, BOX, WMH, ANODE BOX, FH, TEL BOX, ETC.)
2. ALL DIMENSIONS TO UTILITIES ARE TO CENTERLINE OF PIPE UNLESS INDICATED OTHERWISE.
3. CONTRACTOR SHALL VERIFY HORIZONTAL AND VERTICAL ALIGNMENT OF EXISTING UTILITIES AND SHALL NOTIFY THE DESIGN ENGINEER IMMEDIATELY ON ANY DISCREPANCIES PRIOR TO CONSTRUCTION.
4. REPLACE ALL TRAFFIC AND CONTROL DEVICES, (SIGNS OR PAVEMENT MARKINGS) UNDER CLARK COUNTY'S JURISDICTION, THAT ARE DISTURBED, DESTROYED, MOVED OR MODIFIED BY TRENCHING ACTIVITY TO CLARK COUNTY'S SATISFACTION. ALL MATERIAL USED SHALL MEET CLARK COUNTY'S SPECIFICATIONS OR WILL BE AN APPROVED EQUIVALENT.

8 FLOOR DRAIN	(EMERGENCY)
9 FLOOR SINK	9X2 18 FIXTURE UNIT
2 TRENCH DRAIN	2X2 8 FIXTURE UNIT
4 LAYS	4X1 4 FIXTURE UNIT
2 SINK (1-COMP)	2X2 4 FIXTURE UNIT
1 SINK (3-COMP)	1X5 5 FIXTURE UNIT
6 HANDSINK	6X1 6 FIXTURE UNIT
1 DISHWASHER	1X4 4 FIXTURE UNIT
1 ICE MACHINE	1X3 3 FIXTURE UNIT
1 MOP SINK	1X3 3 FIXTURE UNIT
1 URINAL	1X2 2 FIXTURE UNIT
5 WC	5X4 20 FIXTURE UNIT
TOTAL	77 FIXTURE UNIT

AVERAGE: 77 FU x 0.70 ERU's x 250 gpd
13,475 gpd = 0.0135 mgd
0.0135 gpd X 3.4 peak factor = 0.0458

THE REDUCED PRESSURE DETECTOR ASSEMBLY SHALL BE INSTALLED IN ACCORDANCE WITH UDAI PLATE 56. NO WATER SHALL BE TAKEN FROM A SERVICE REQUIRING BACKFLOW PREVENTION UNLESS THE ASSEMBLY HAS BEEN SUCCESSFULLY TESTED BY THE LVWD. ANY BLOCK WALL OR OTHER FENCE MATERIAL SHALL BE DESIGNED AND CONSTRUCTED AROUND THE OUTSIDE OF EASEMENT(S) SO AS TO ALLOW THE DISTRICT DIRECT ACCESS FROM THE ADJACENT RIGHT-OF-WAY. EASEMENTS SHALL BE CLEARLY MARKED OR STAKED PRIOR TO THE START OF CONSTRUCTION.

APPROVED REDUCED PRESSURE PRINCIPLE ASSEMBLY(S) SHALL BE INSTALLED PER THE UDACS P. 8. NO WATER SHALL BE TAKEN FROM A SERVICE REQUIRING BACKFLOW PREVENTION UNTIL THE PRESSURE ASSEMBLY HAS BEEN SUCCESSFULLY TESTED BY THE LVVWD. ANY BLOCK WALL OR OTHER FENCE MATERIAL SHALL BE DESIGNED AND CONSTRUCTED AROUND THE OUTSIDE OF THE EASEMENT. ALLOW LVVWD DIRECT ACCESS FROM THE ADJACENT RIGHT-OF-WAY. EASEMENTS SHALL BE CLEARLY MARKED OR STAKED PRIOR TO THE START OF CONSTRUCTION.

NORTH 28°02'08" EAST BEING THE BEARING OF THE CENTERLINE OF LAS VEGAS BOULEVARD BETWEEN LOUIS AVENUE AND OAKLEY BOULEVARD LOCATED IN THE NORTHWEST QUARTER (NW 1/4) OF THE SOUTHWEST QUARTER (SW 1/4) OF SECTION 3, TOWNSHIP 21 SOUTH, RANGE 61 EAST, M.D.M., OF LAS VEGAS, CLARK COUNTY, NEVADA, AS SHOWN BY MAP THEREOF ON FILE IN FILE 193 OF SURVEY 94, OFFICIAL RECORD'S CLARK COUNTY, NEVADA.

CITY OF LAS VEGAS BENCHMARK "OAKLEY 5", BEING A RIVET AND PLATE IN THE TOP OF CURB A
CORNER OF OAKLEY BLVD & LAS VEGAS BLVD. ALSO STAMPED 8LV113W6

ELEVATION: 2030.6 US SURVEY FEET OR 618.927 METERS (NAVD 88)

Call
811

1-800-227-2600

FAST

Call
before
UnderGround
1-702-432-5300
FREWAY AND ARTERIAL
EXPRESSWAY TRANSPORTATION

AVOID HITTING OVERHEAD
POWERLINES. IT'S COSTLY.

 Call 

**Before You
OverHead**

1-702-227-2929

ABANDONMENT OF EXISTING SERVICE - 2" AND SMALLER

2" METER, ACCOUNT #9700, SERIAL NUMBER 0656193

THE CONTRACTOR SHALL NOTIFY THE INSPECTION DIVISION AT THE LUVWD (702-258-3227) 48 HOURS PRIOR TO THE REQUESTED REMOVAL TIME TO ALLOW THE DISTRICT TO TAKE THE FINAL METER READING. AFTER THE FINAL READING, THE CONTRACTOR MAY THEN BEGIN REMOVAL PROCEDURES FOR THE AFFECTED SERVICE AS FOLLOWS:

EXISTING SERVICE LATERALS THAT ARE TO BE
ABANDONED FROM THE EXISTING WATER MAINS SHALL
HAVE THE CORROSION STOPS TURNED OFF AT THE
MAIN, A MINIMUM OF TWELVE (12) INCHES OF THE
LATERAL CUT OUT NEAR THE CORROSION STOPS, A
BRASS CAP INSTALLED ON THE CORROSION STOP IF
THE CORROSION STOP IS TO BE REPAIRED, OR
PULLED FROM THE EXISTING WATER MAIN, THE MAIN
SHALL BE REPAIRED AT THE CONTRACTOR'S EXPENSE, IN
A MANNER APPROVED BY THE DISTRICT. IF THE
CORROSION STOP IS NOT WATER TIGHT, THE
CONTRACTOR SHALL NOTIFY THE LVVWD COMMUNICATIONS
SUPERVISOR AT CENTER AT 702-258-7171 FOR FURTHER
DIRECTION.

THE EXISTING METER SHALL BE REMOVED AND DELIVERED TO THE DISTRICT. THE CONTRACTOR SHALL REMOVE THE EXISTING SERVICE METER BOX AND APPURTENANCES, FILL AND GRADE ANY AND ALL RESULTING VOIDS, AND REPLACE OR RESTORE TO ORIGINAL CONDITIONS OR BETTER, ALL LANDSCAPING, IRRIGATION SYSTEMS, CONCRETE, SIDEWALKS, ASPHALT, OR ANY OTHER ITEMS DAMAGED OR REMOVED DURING THE REMOVAL OF THE EXISTING METER BOX.

EXISTING POWER POLE
AND OVERHEAD ELEC.
WIRE TO BE REMOVED
PER NV ENERGY PLAN

UTILITY NOTES AND QUANTITIES

THE QUANTITY ESTIMATES SHOWN HEREON ARE APPROXIMATE AND NO ONE IS TO RELY UPON THEM FOR PAY QUANTITIES


		UNITS	PUBLIC	PRIVATE
	<u>WATER</u>			
[1]	INSTALL 8"x6" TAPPING SLEEVE W/ 6" TAPPING VALVE PER UDACS 2.24.01 (A) PLATES 30, 34 AND 39	EA	2	—
[2]	INSTALL 6" GATE VALVE PER UDACS PLATE 30 AND 39	EA	2	—
[3]	INSTALL 1 1/2" WM, SERVICE SADDLE & CORP. STOP PER UDACS PLATE 4	EA	1	—
[4]	INSTALL 1 1/2" RPPA PER PLATE 8	EA	1	—
[5]	INSTALL 2" PVC WATER LATERAL	LF	—	5
[6]	INSTALL 1 1/2" COPPER LINE PER UDACS PLATE 4	LF	15	—
[7]	INSTALL 1 1/2" BRASS PIPE & FITTINGS			
[8]	INSTALL CURB STOP PER DETAIL THIS SHEET	EA	1	—
[9]	INSTALL 6" CHECK VALVE	EA	—	1
[10]	INSTALL 6" RPDA PER UDACS PLATE 56	EA	1	—
[11]	INSTALL 6" 90° BEND PER UDACS PLATE 31	EA	—	4
[12]	INSTALL 6" C-900 PRESSURE CLASS 305 WATER LINE	LF	42	30
[13]	INSTALL DOWNSTREAM 6" GATE VALVE WITH VALVE LOCK PER UDACS PLATE 30 AND 39	EA	1	—
[14]	SAWCUT, TRENCHING AND BACKFILL PER UDACS PLATE 17, CCAUSD 503.1, PAVEMENT RESTORATION PER CCAUSD 500.5			
[15]	INSTALL FIRE HYDRANT ASSEMBLY W/ 6" GATE VALVE PER UDACS PLATE 40, 30 AND 39	EA	1	—
[16]	INSTALL BLUE REFLECTIVE MARKER	EA	1	—
[17]	FIRE DEPARTMENT CONNECTION			
	<u>SEWER</u>			
[A]	INSTALL 6" PVC SEWER LATERAL (PRIVATE) PER SD-18, SD-22 AND SD-25	LF	—	21
[B]	INSTALL 6" CLEANOUT PER SD-26 WITH TRAFFIC RATED LID	EA	—	3
[C]	INSTALL 1500 GAL GREASE INTERCEPTOR AND A SAMPLE BOX PER BUILDING PERMIT	EA	—	1

REVIEWED FOR CODE COMPLIANCE

LS AUG 05 2019

CITY OF LAS VEGAS
BUILDING AND SAFETY

APPROVAL IS FOR CLOUDED
AREAS OR LATEST REVISIONS
ONLY. SEE ORIGINALS FOR
OTHER REQUIREMENTS

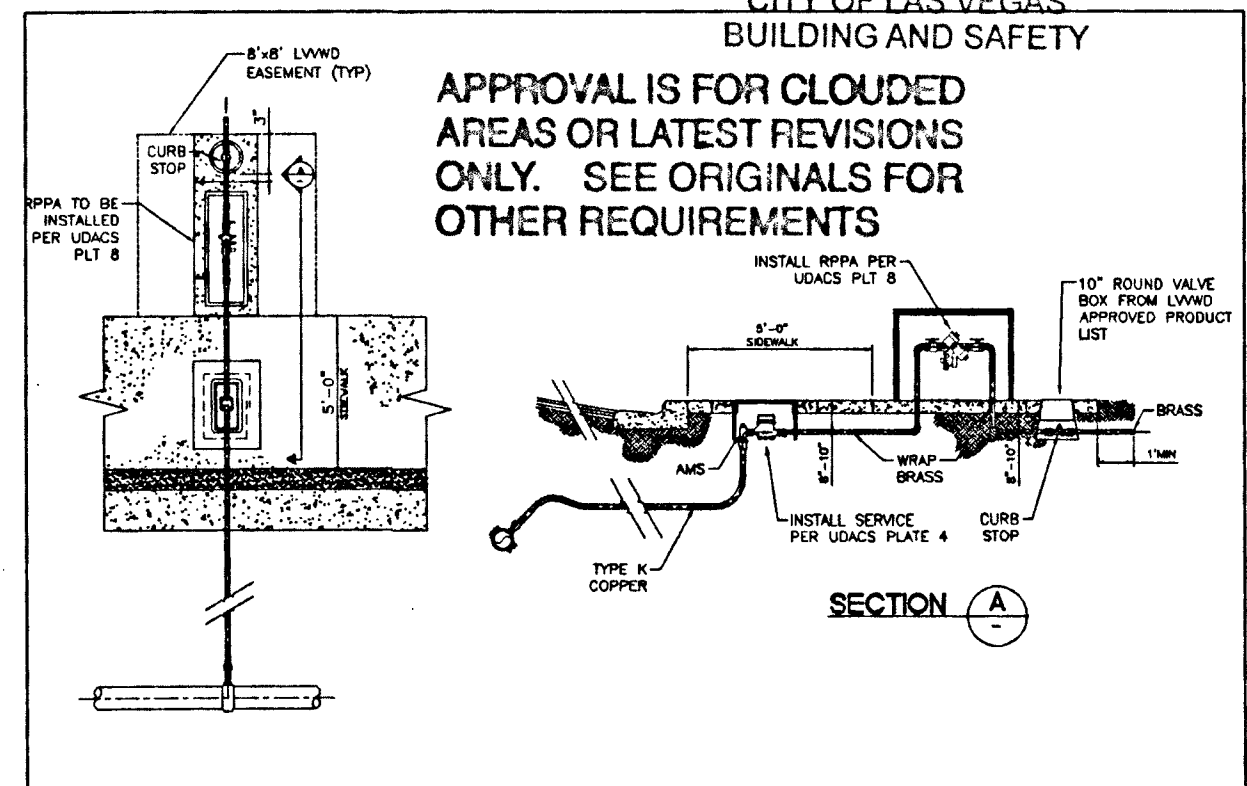

AS BUILT

APPROVED FOR CONSTRUCTION:

LAS VEGAS VALLEY WATER DISTRICT ENGINEERING SERVICES

PROJECT # 136290 FIRST APPROVED DATE: 6/5/2018
SHEETS: C1 C2 C5

LVVWD APPROVED FIRE FLOW: 1,500 GPM / ONSITE: 0 GPM

FIRE SPRINKLERS: 600 GPM

CITY OF LAS VEGAS FIRE AND RESCUE (C1, C2, C5) DATE

7/25/19

SOUTHWEST GAS CORPORATION DATE

IHOP - LAS VEGAS BOULEVARD

UTILITY PLAN

1809 S. LAS VEGAS BOULEVARD
LAS VEGAS, NV 89104

DESIGNED BY: PB
CHECKED BY: PB

DATE: 07/08/19

JOB #: 18-1HOP
APN: 162-03-310-0
SECT 3 T 21SR 61E
SCALE: HORIZ 1" =

SHEET #

C5

OF