
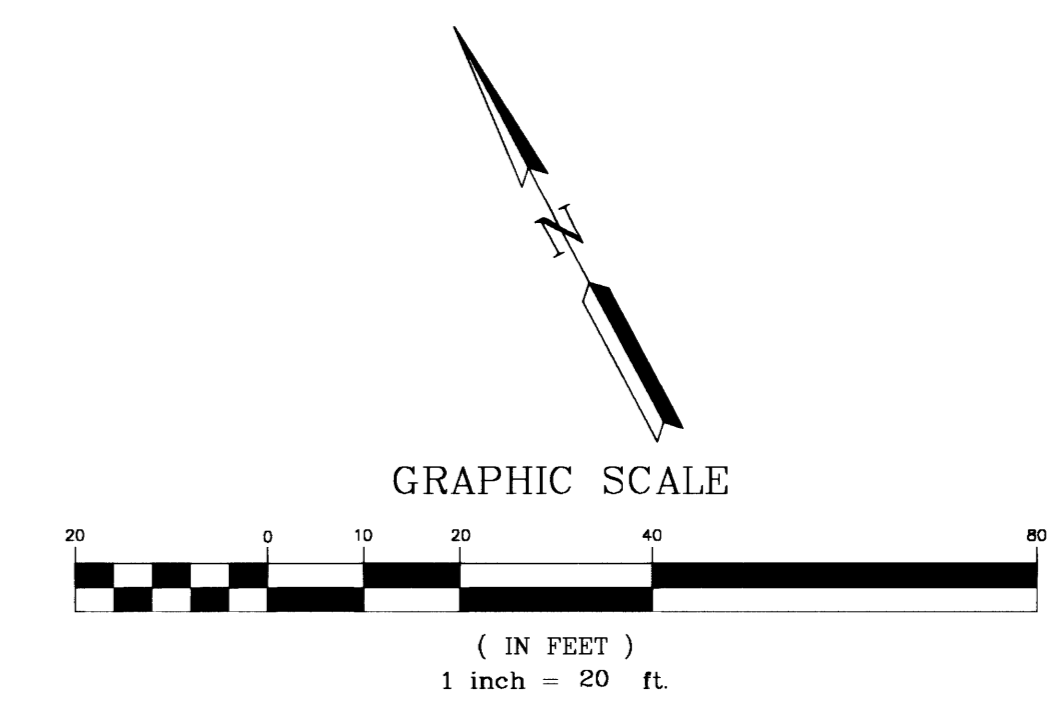


MATCH LINE FOR CONTINUATION SEE SHEET C4

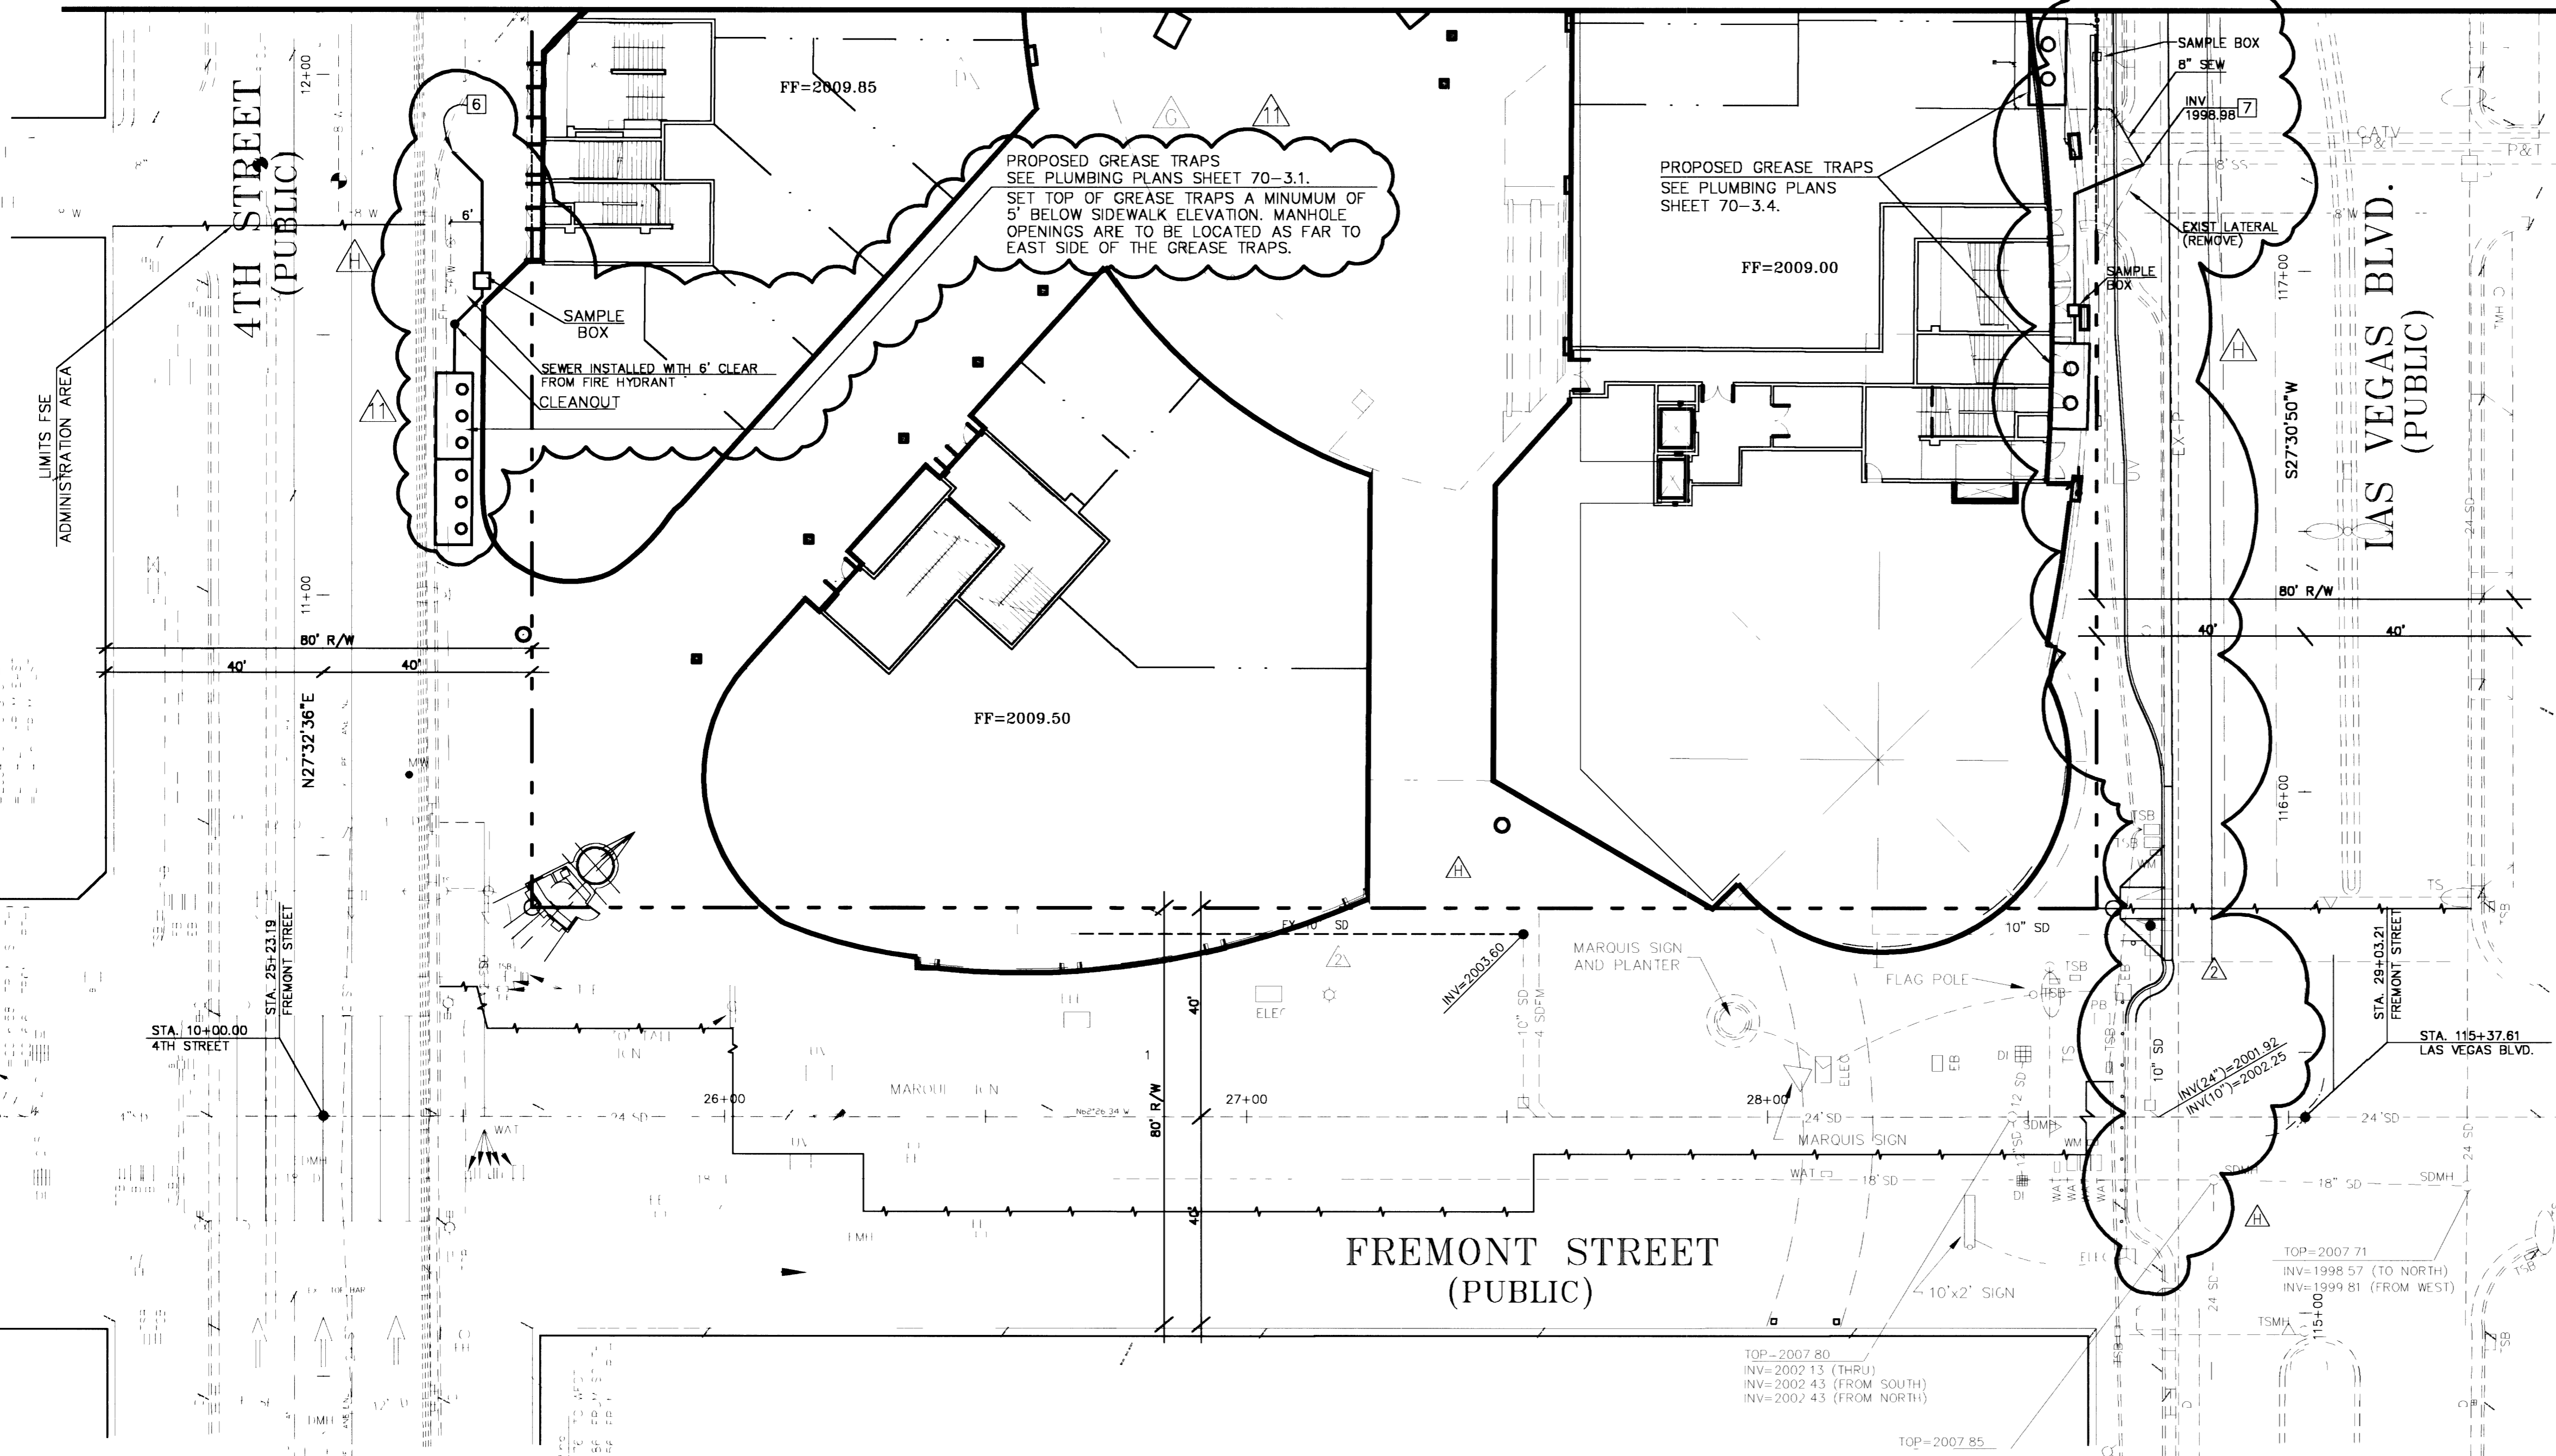

BENCHMARK
FREMONT 5 - RIVET AND PLATE IN TOP OF CURB, NE RETURN FREMONT STREET AND LAS VEGAS BOULEVARD.
ELEVATION = 611.8322 METERS = 2007.32 FEET
NAVD 88

NOTE:
FOR STREETLIGHT AND STREETLIGHT CONDUIT CONSTRUCTION INFORMATION,
SEE SHEETS T51 AND T52.

- SEWER NOTES**
- 1 CONSTRUCT WYE LATERAL CONNECTION PER DACS SD-17.
 - 2 INSTALL GREASE TRAP AND SAMPLE BOX. SEE PLUMBING PLANS.
 - 3 CONNECT TO BUILDING PLUMBING. SEE PLUMBING PLANS.
 - 4 INSTALL 6" SDR 35 SANITARY SEWER LINE PER DACS SD-11.
 - 5 INSTALL SANITARY SEWER CLEAN OUT PER DETAIL 9/S6.
 - 6 CONNECT TO EXISTING STUB.
 - 7 REMOVE EXISTING 8"x 6" WYE AND LATERAL AND INSTALL 8"x 8" WYE AND SEWER LATERAL PER DACS SD-17. CONNECT TO BUILDING PLUMBING.
 - 8 CONNECT TO EXISTING 6" SS. REMOVE PORTIONS OF 6" SS CONFLICTING WITH SAMPLING BOX AND NEW 6" WASTE LINES.

WATER NOTES


AVOID CUTTING UNDERGROUND UTILITY LINES IT'S COSTLY.
Call before you Dig—
1-800-227-2600
UNDERGROUND SERVICE ALERT (USA)

AVOID OVERHEAD POWER LINE CONTACT
Call before you OVERHEAD
1-702-593-6111
NEVADA POWER ENVIRONMENT AND SAFETY SERVICES DEPARTMENT

MARTIN & MARTIN ASSUMES NO RESPONSIBILITY FOR EXISTING UTILITY LOCATIONS AND ELEVATIONS. THE UTILITIES SHOWN ON THIS DRAWING HAVE BEEN PLOTTED FROM THE BEST AVAILABLE INFORMATION. IT IS, HOWEVER, THE CONTRACTOR'S RESPONSIBILITY TO FIELD VERIFY THE LOCATION AND ELEVATION OF ALL UTILITIES PRIOR TO THE COMMENCEMENT OF ANY CONSTRUCTION. CONTRACTOR TO FIELD VERIFY ALL EXISTING SITE CONDITIONS PRIOR TO CONSTRUCTION. IF A CONFLICT EXISTS BETWEEN WHAT IS SHOWN ON THESE DRAWINGS AND WHAT EXISTS IN THE FIELD, THE CONTRACTOR IS TO NOTIFY THE ARCHITECT OR ENGINEER IMMEDIATELY.

APPROVED FOR CONSTRUCTION
David H. Malpass 12/13/01 DATE
LAS VEGAS VALLEY WATER DISTRICT

John M. Smith 12/13/01 DATE
CITY OF LAS VEGAS FIRE DEPARTMENT

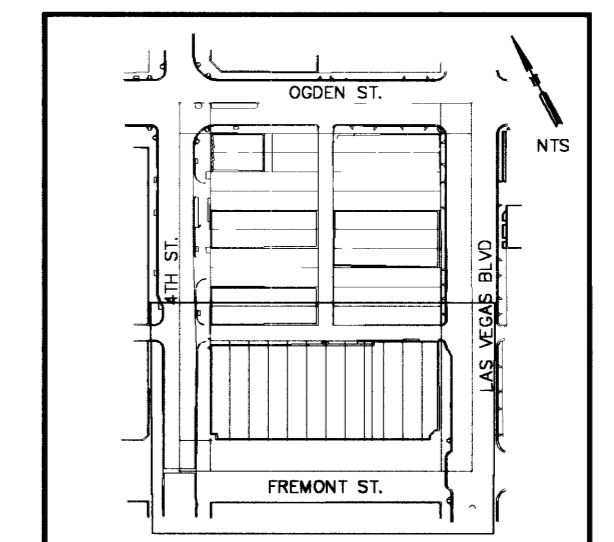

ISSUED VALUE ENGINEERING AND GENERAL REVISIONS 6/25/99
SUBMITTED FOR PLAN CHECK 3/26/99

no	description of revisions	date	name
1	PLAN CHECK REVISION	3-31-99	JB
2	REVISE STORM DRAIN ON FREMONT	8-26-99	JB
3	RELOCATED COURT YARD, ADDED GREASE IN.	DHM	DHM
4	RELOCATED F.H., ADDED WATER AND SEWER NOTES.	DHM	DHM
5	SHOWED STORM DRAIN AS EXISTING	08-31-01	DHM
6	BULLETIN #1 RELOCATED GREASE TRAP	08-31-01	DHM
7	ADDED BUS TURN OUT, ADDED LVWD/FIRE APPROVAL BLOCK		
8	SHOWED GREASE TRAP SEWER LINE AS-BUILT LOCATION		
9	DELETED WATER NOTE		


WBC WORLD ENTERTAINMENT CENTERS
LAS VEGAS INC.
233 SOUTH FOURTH STREET, SUITE 201
LAS VEGAS, NEVADA 89101
PHONE (702) 477-0470

MARTIN & MARTIN
CIVIL ENGINEERS
2101 SOUTH JONES BLVD., SUITE A
LAS VEGAS, NEVADA 89146
PHONE (702) 248-8000

sheet 10-2-00
MASTER UTILITY PLAN ~ SOUTH

title
DESIGNED BY J. BETTENCOURT
DRAWN BY V. WINFORD
CHECKED BY D. MALPASS, P.E.

DATE 10-2-00
JOB NUMBER 1671-00
DESIGN BY J. BETTENCOURT
DRAWN BY V. WINFORD
CHECKED BY D. MALPASS, P.E.

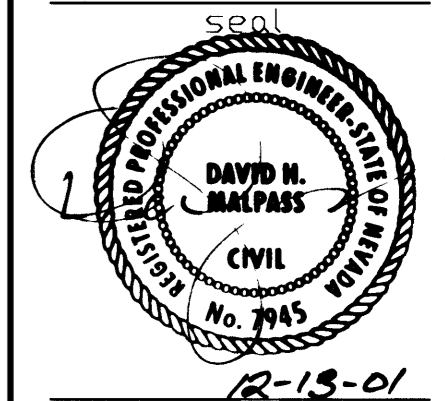

C5
SHEET 5 OF 16
drawing number
107-43130