


CENTENNIAL PARKWAY

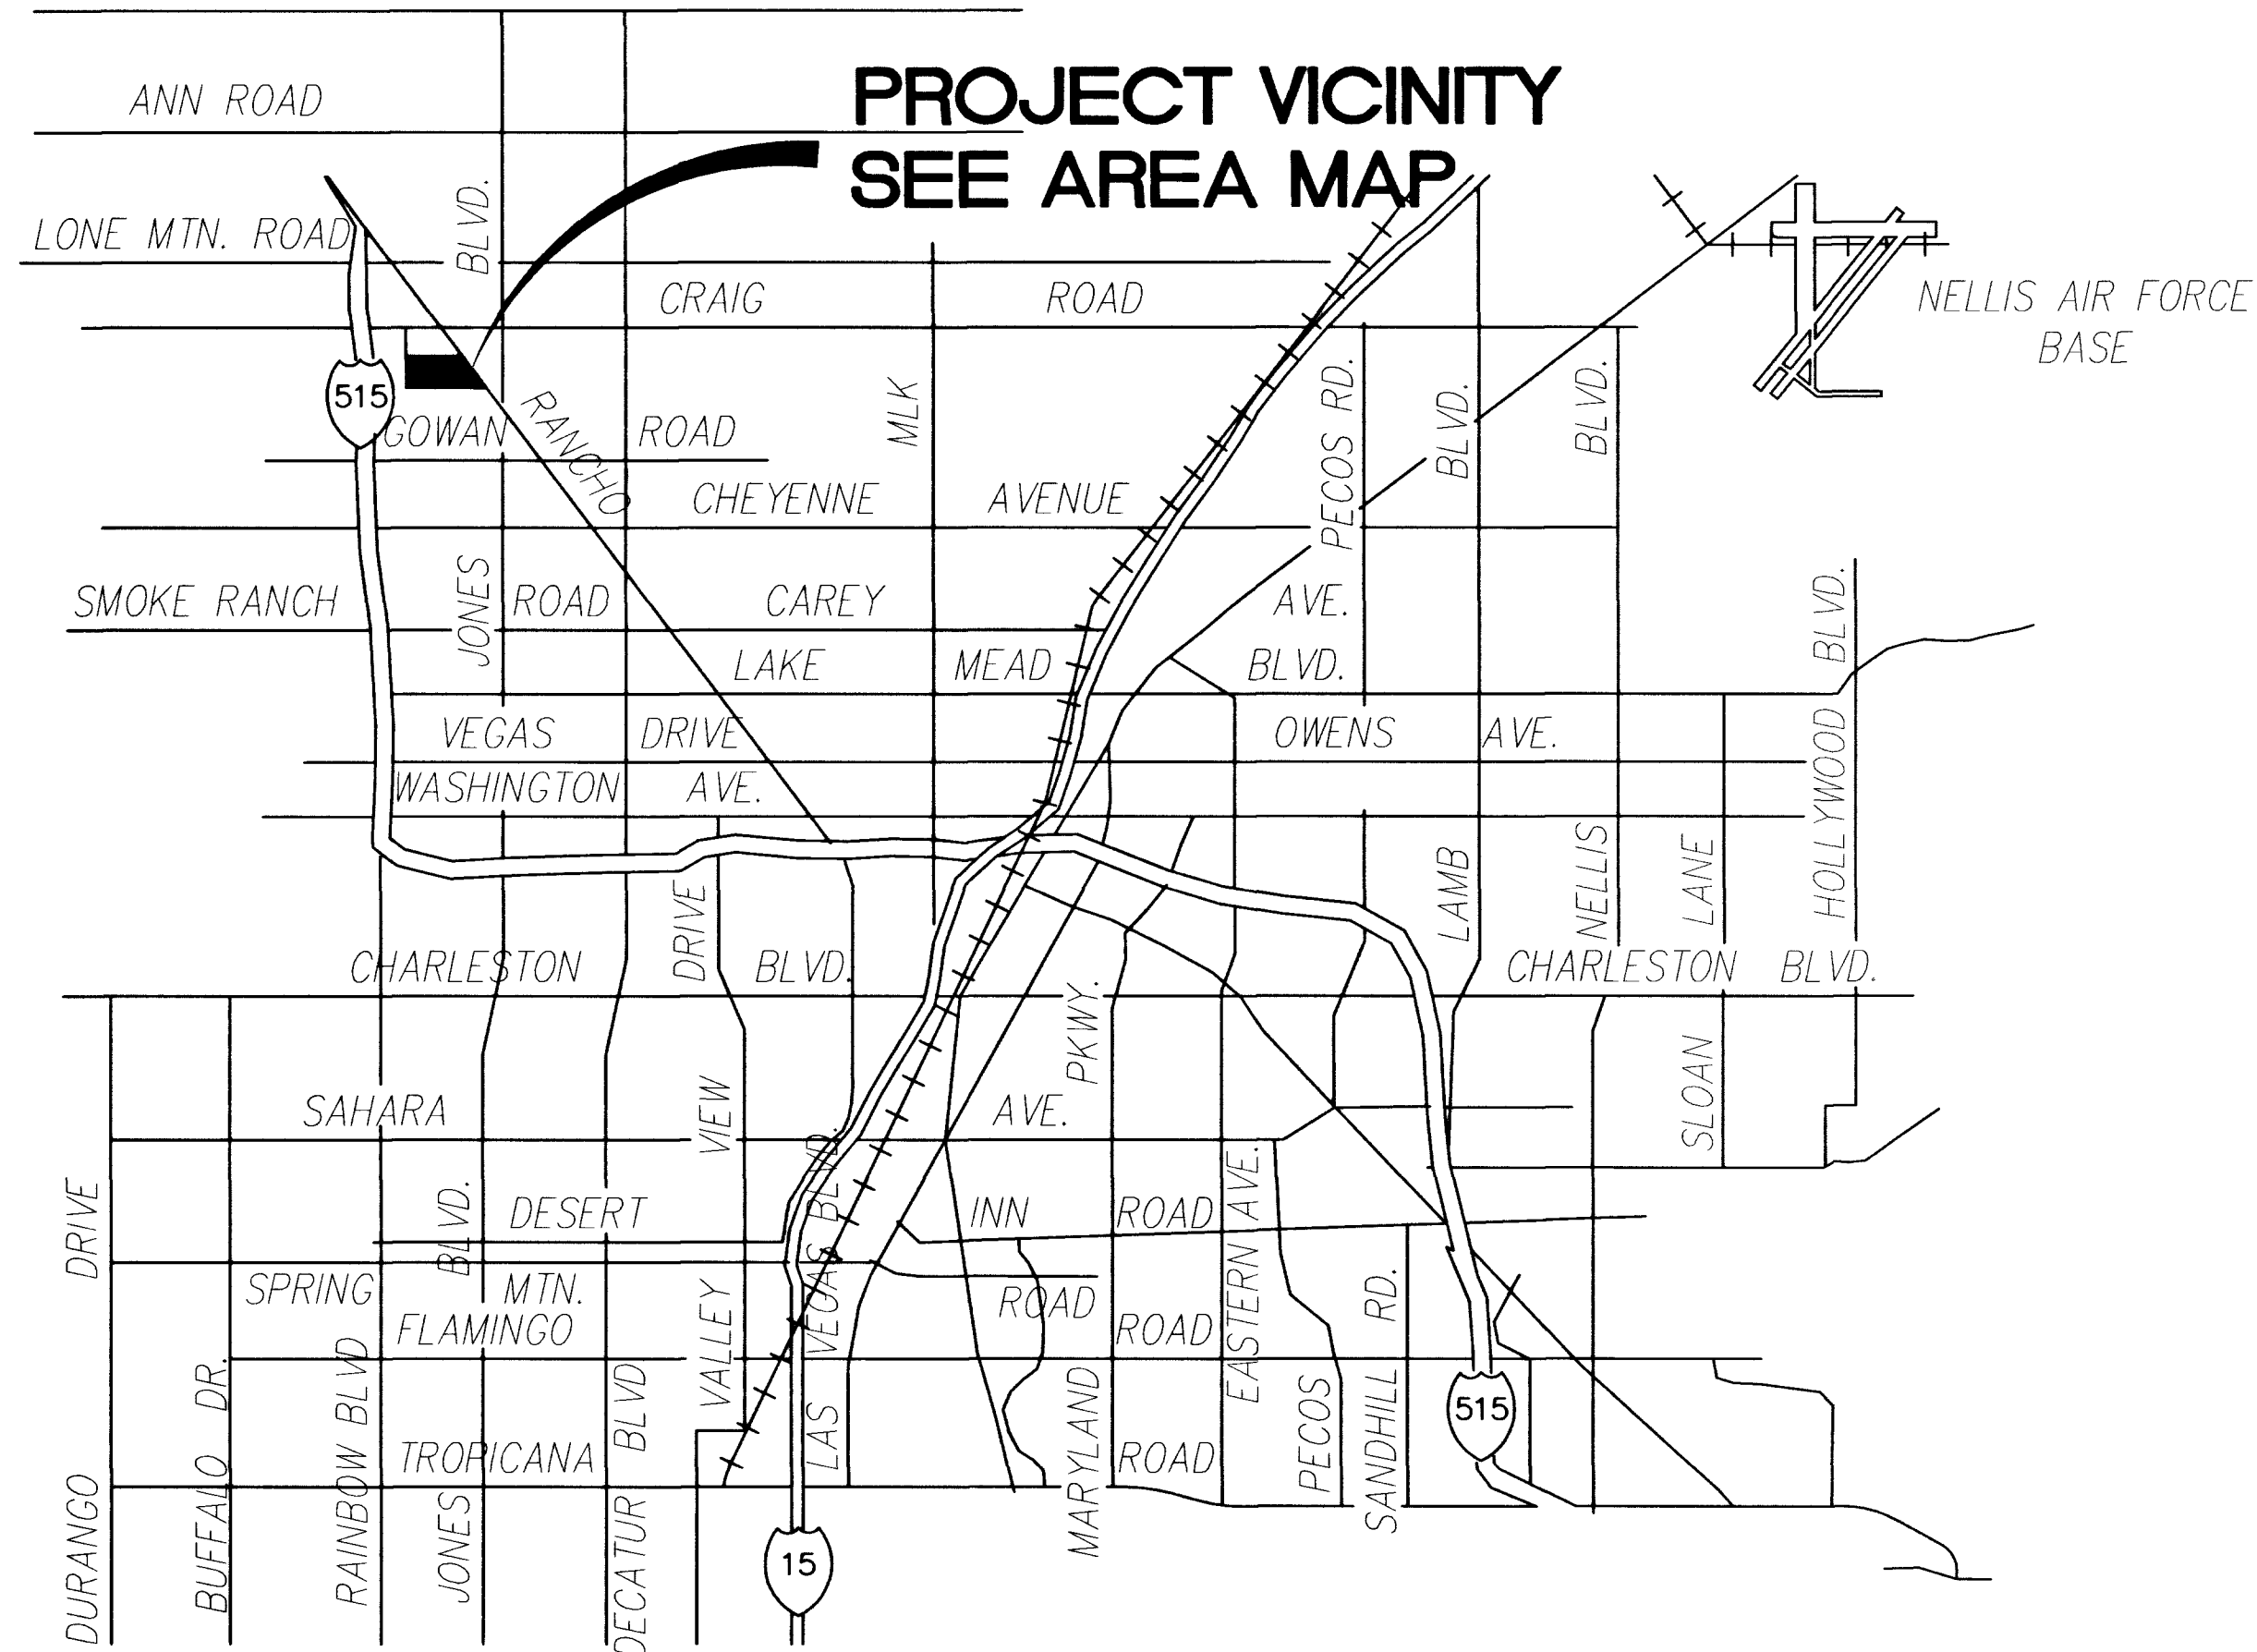

VICINITY MAP

N.T.S.


LEGEND

NEW	EXISTING	DESCRIPTION
---	---	CENTERLINE
---	---	PROPERTY/RIGHT-OF-WAY LINE
---	---	"L" CURB & GUTTER
---	---	"A" CURB & GUTTER
---	---	WATER LINE
---	---	SEWER LINE
---	---	FLOW LINE
---	---	CONCRETE BLOCK WALL
xx.xx xx	xxxxx xx	GRADES
xx.xx xx	xxxxx xx	GRADES PROPOSED BY OTHERS
---	---	5 FOOT CONTOURS
---	---	1 FOOT CONTOURS
---	---	FIRE HYDRANT
---	---	STREETLIGHT
○	○	MANHOLE
⊗	⊗	WATER VALVE
□ ABBRV.	□ ABBR.	ELECTRIC VAULTS, WATER METER, ETC. (PER ABBREVIATION)
---	---	FLOOD ZONE AE
---	---	HANDICAP ACCESS ROUTE
---	---	AC PAVEMENT
---	---	CONCRETE AREA
---	---	GRASS COVER

ABBREVIATIONS

AC	- ASPHALT	INV	- INVERT
ACP	- ASBESTOS CEMENT PIPE	LF	- LINEAR FEET
AP	- ANGLE POINT	LS	- LANDSCAPE
AVE	- AVENUE	MAX	- MAXIMUM
BC	- BACK OF CURB	MH	- MANHOLE
BVC	- BEGINNING OF VERTICAL CURVE	MIN	- MINIMUM
BM	- BENCHMARK	NTS	- NOT TO SCALE
BW	- BACK OF WALK	OC	- ON CENTER
CBW	- CONCRETE BLOCK WALL	PC	- POINT OF CURVE
CL	- CENTERLINE	PI	- POINT OF INTERSECTION
CLF	- CHAIN LINK FENCE	PP	- POWER POLE
CNLV	- CITY OF NORTH LAS VEGAS	PT	- POINT OF TANGENCY
CC	- CLARK COUNTY	PB	- PULL BOX
CCSD	- CLARK COUNTY SANITATION DISTRICT	PL	- PROPERTY LINE
CO	- CLEANOUT (SEWER)	PUE	- PUBLIC UTILITY EASEMENT
CONC	- CONCRETE	RCP	- REINFORCED CONCRETE PIPE
OMP	- CORRUGATED METAL PIPE	R	- RADIUS
QIP	- CAST IRON PIPE	RP	- RADIUS POINT
DIA	- DIAMETER	R/W	- RIGHT OF WAY
EIA	- DROP INLET	SD	- STORM DRAIN
ELEV	- ELEVATION	SL	- STREETLIGHT
ELEV	- ELEVATION	STA	- STATION
EV	- END OF VERTICAL CURVE	SSMH	- SEWER MANHOLE
EX	- EXISTING	SW	- SIDEWALK
FF	- FINISHED FLOOR	TC	- TOP OF CURB
FL	- FEET OR FOOT	TYP	- TYPICAL
FG	- FINISHED GRADE	TEL	- TELEPHONE
FH	- FIRE HYDRANT	TOW	- TOP OF WALL
GB	- GRADE BREAK	WM	- WATER METER
GM	- GAS METER	WV	- WATER VALVE
GV	- GATE VALVE	Δ	- DELTA
HP	- HIGH POINT		

PROJECT SITE

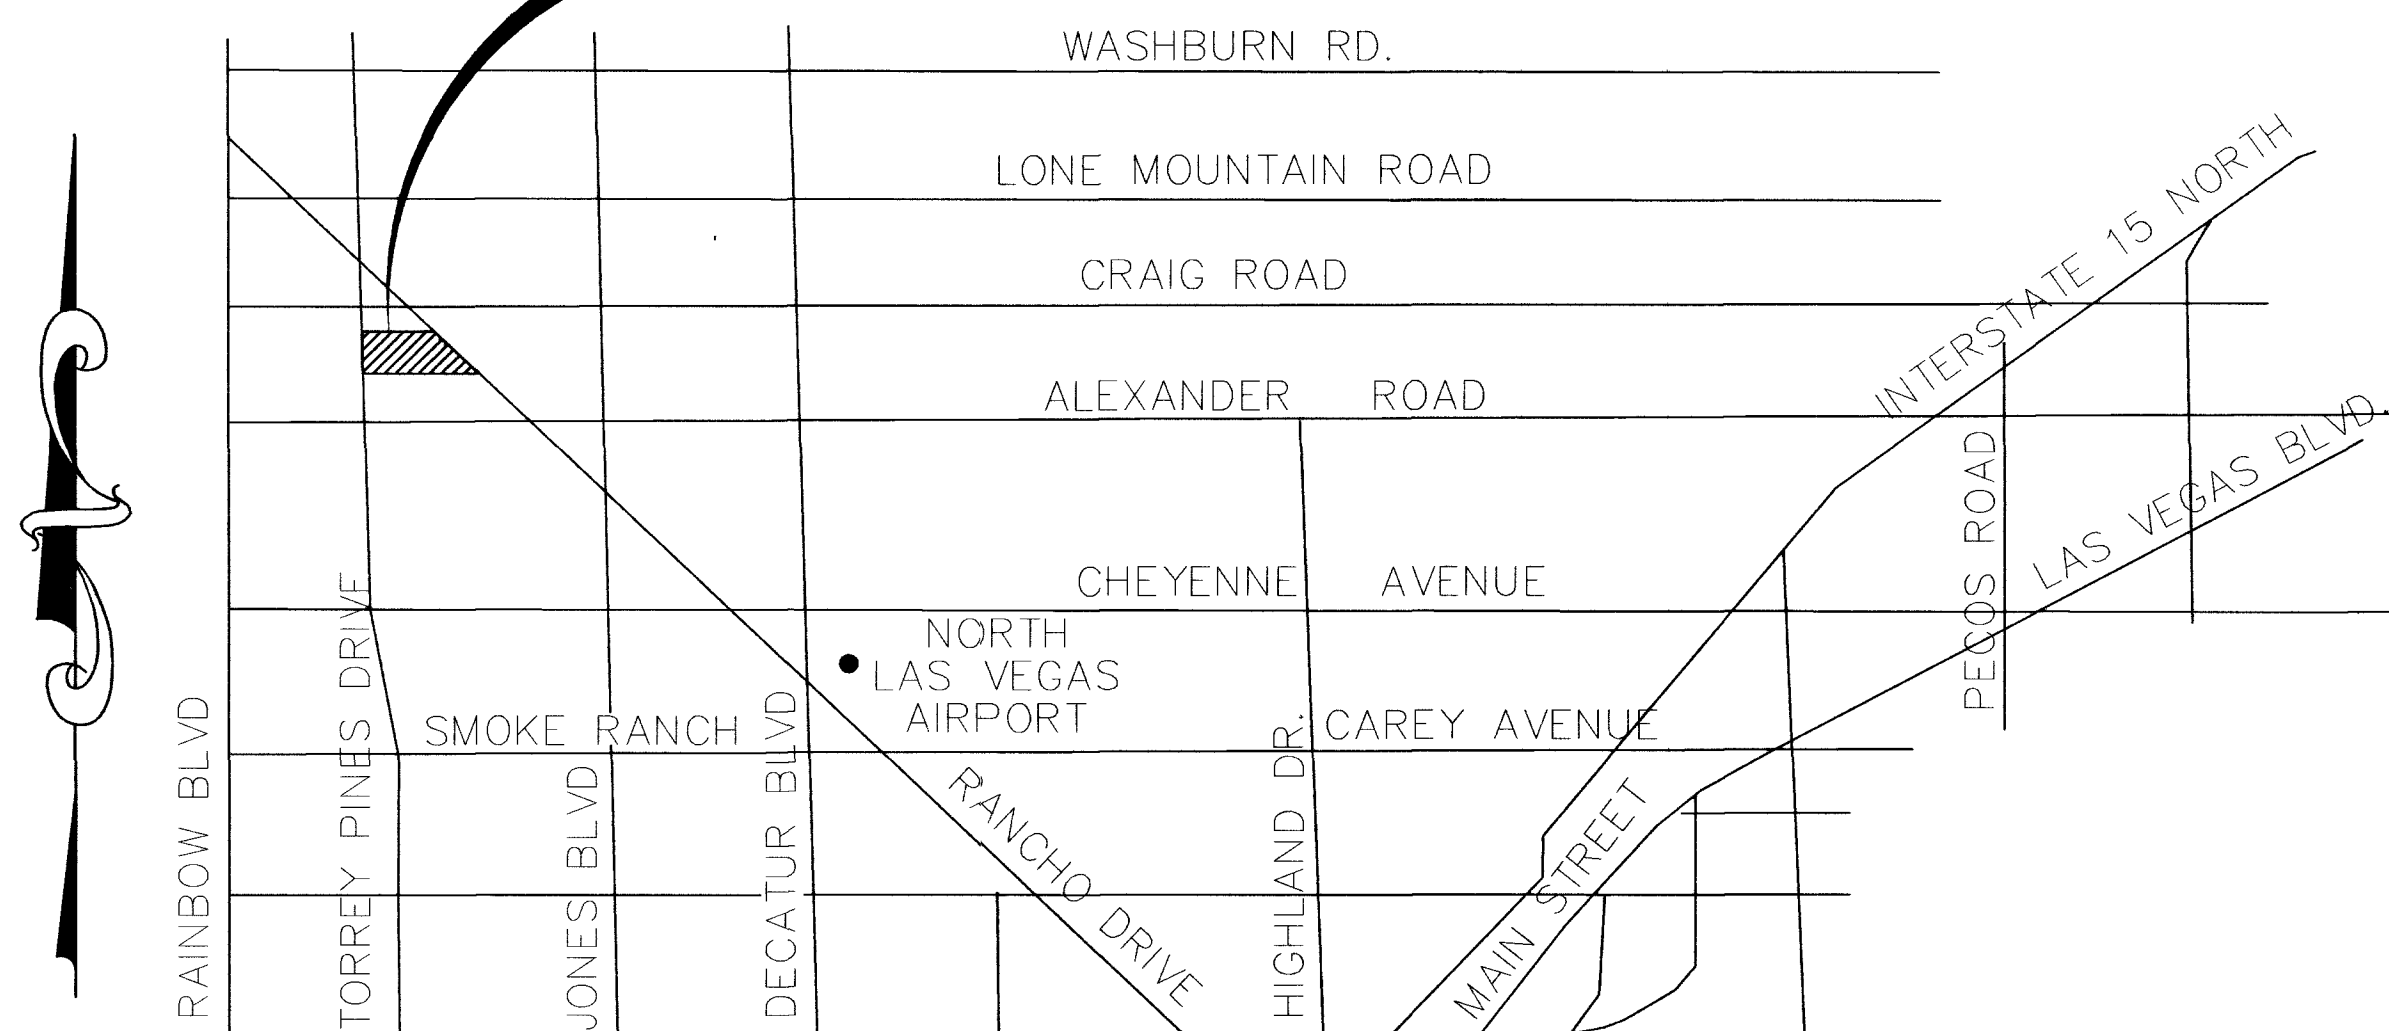

AREA MAP

N.T.S.

SHEET INDEX

SHEET 1 OF 11	-	C1 - COVER SHEET
SHEET 2 OF 11	-	C2 - VICINITY MAP
SHEET 3 OF 11	-	C3 - GENERAL NOTES
SHEET 4 OF 11	-	C4 - HORIZONTAL CONTROL, STREETLIGHTING AND TRAFFIC PLAN
SHEET 5 OF 11	-	C5 - GRADING PLAN - WEST HALF
SHEET 6 OF 11	-	C6 - GRADING PLAN - EAST HALF
SHEET 7 OF 11	-	C7 - TYPICAL SECTIONS AND DETAILS
SHEET 8 OF 11	-	C8 - TYPICAL SECTIONS AND DETAILS
SHEET 9 OF 11	-	C9 - RANCHO DRIVE - PLAN AND PROFILE
SHEET 10 OF 11	-	C10 - UTILITY PLAN
SHEET 11 OF 11	-	C11 - UTILITY DETAILS

CALL
BEFORE YOU
Dig

1-800-227-2600
UNDERGROUND SERVICE (USA)

NOTICE !

EXISTING UTILITIES ARE LOCATED ON THE PLANS FOR THE CONVENIENCE OF THE CONTRACTOR ONLY. THE ENGINEER BEARS NO RESPONSIBILITY FOR THE LOCATION OF UTILITIES SHOWN OR NOT SHOWN ON THE PLANS. THE CONTRACTOR SHALL NOTIFY ALL UTILITY COMPANIES BEFORE STARTING CONSTRUCTION AND IT SHALL BE THE RESPONSIBILITY OF THE CONTRACTOR TO VERIFY THE LOCATION OF ALL UTILITIES WITH THE UTILITY COMPANIES.

CALL
BEFORE YOU
OVERHEAD

1-702-593-6111
NEVADA POWER ENVIRONMENT AND SAFETY SERVICES DEPT.

NORTHBROOKE
A BUSINESS CENTER

VICINITY MAP

4339 RANCHO DRIVE

CITY OF LAS VEGAS, NEVADA

DRAWN BY : PB

DESIGNED BY : PB

CHECKED BY : WDC


DATE : 04/25/03

JOB # : 22125

APN : 138-02-701-009

SBCT 2 : T 20S R 80E

SCALE : HORIZ 1" = 30' VERT 1" = N/A

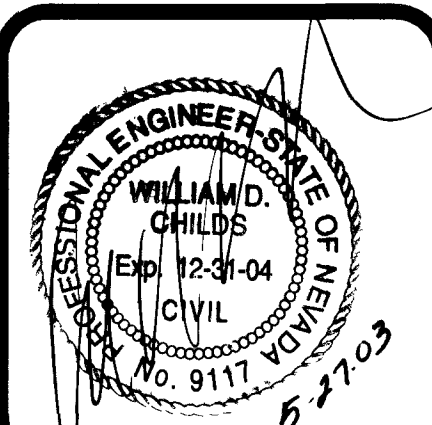

SHEET #

C2

2 OF 11

107V3721

Las Vegas Valley Water District

Date: 8/9/03

APPROVED FOR CONSTRUCTION