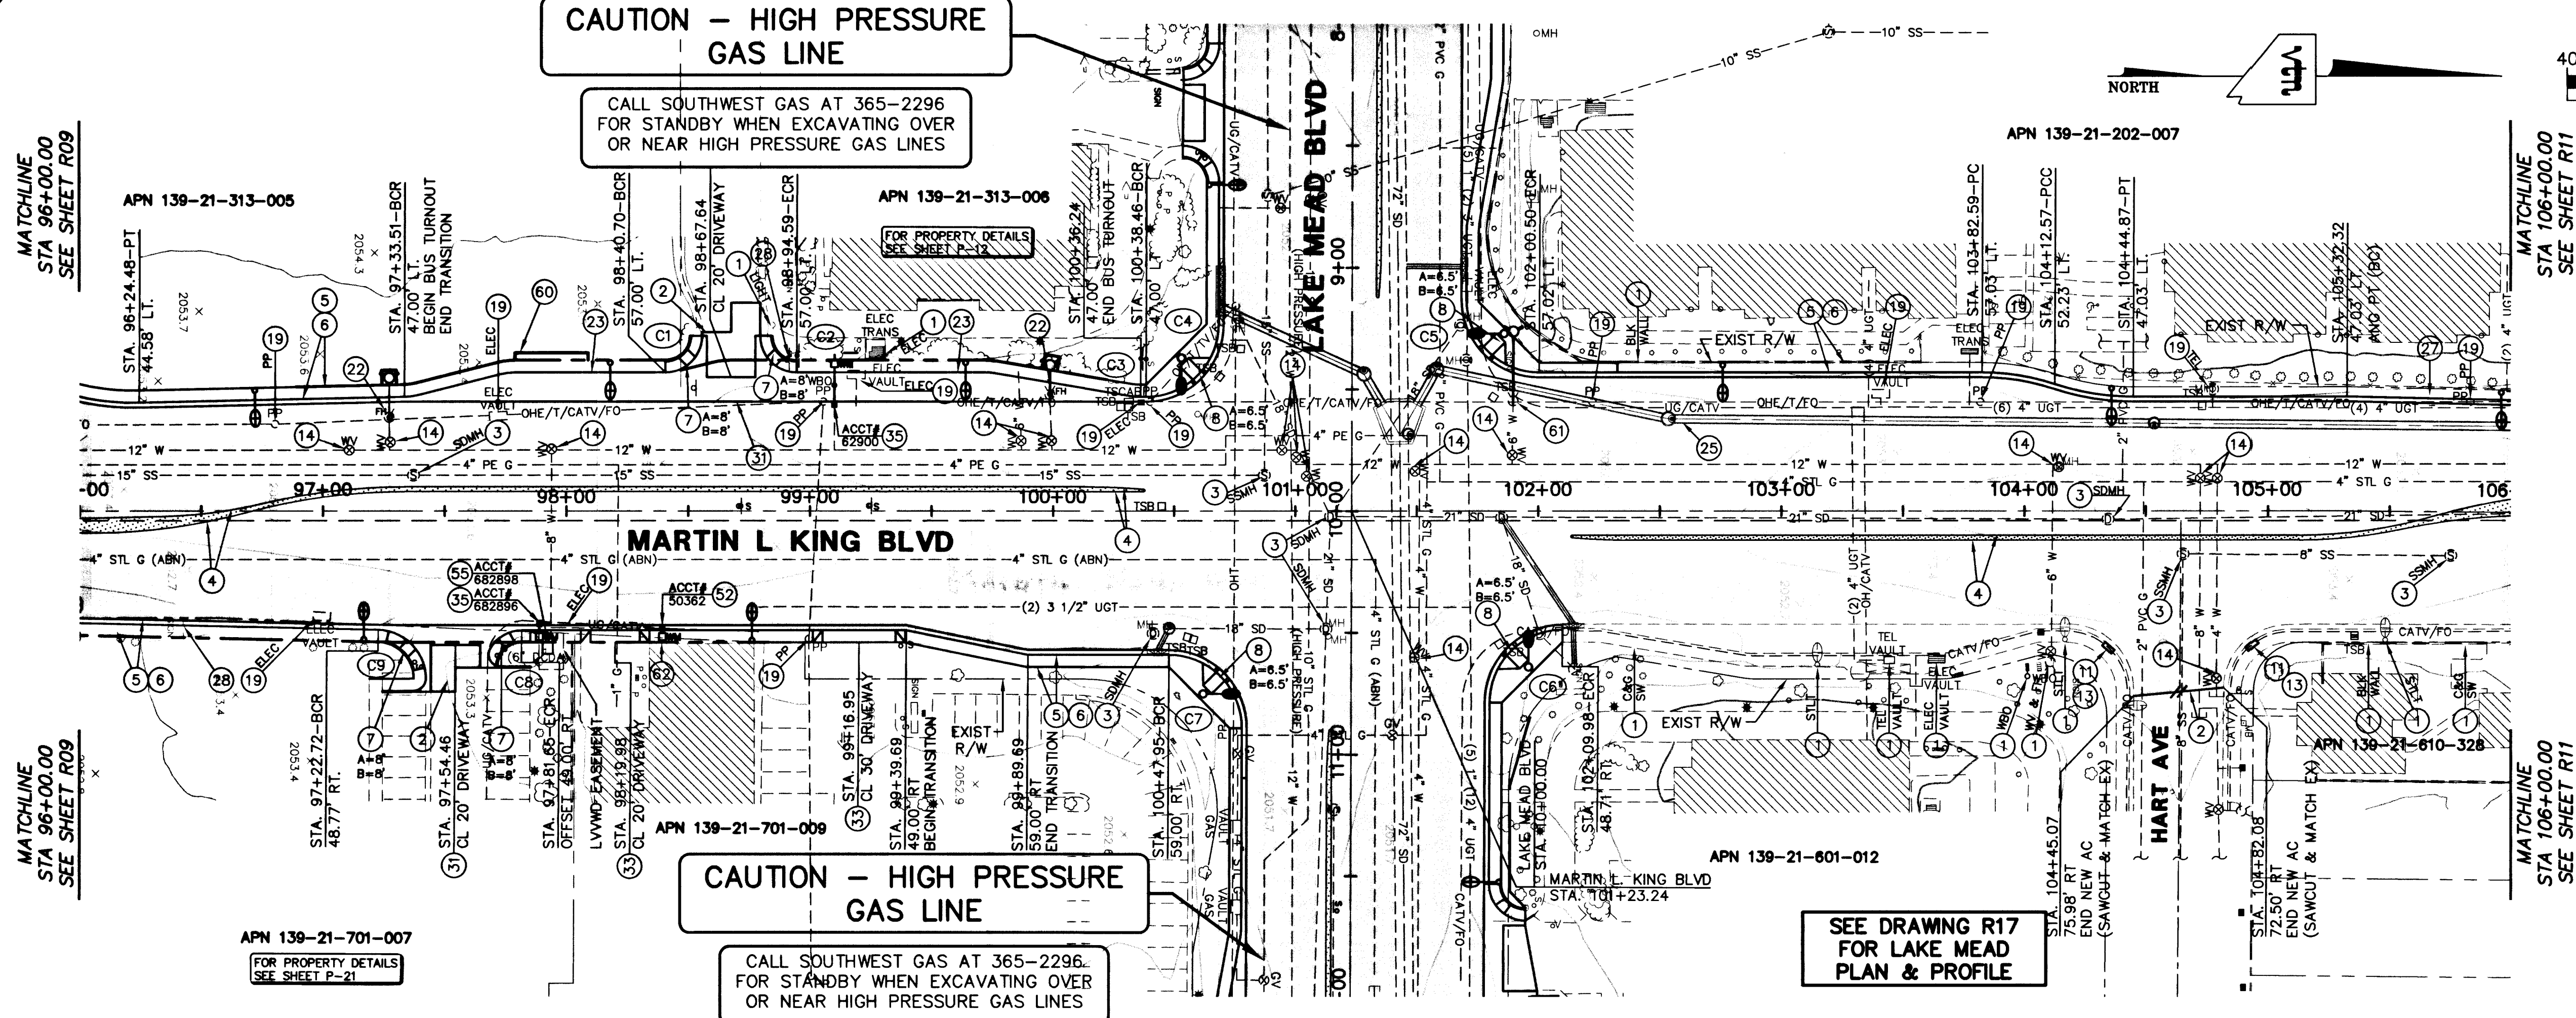


LEGEND

NEW AC PAVEMENT
(SEE TYPICAL X-SECTIONS)

NEW CONCRETE MEDIAN

BACK OF CURB CURVE TABLE

CURVE	RADIUS	DELTA	LENGTH TANGENT
C1	15.00'	90°00'00"	23.56'
C2	15.00'	90°00'00"	23.56'
C3	25.00'	92°27'44"	4.13'
C4	30.00'	89°50'04"	47.04'
C5	30.00'	90°10'25"	47.21'
C6	30.00'	89°49'19"	47.03'
C7	30.00'	90°10'12"	47.21'
C8	15.00'	59°08'36"	15.48'
C9	20.00'	88°43'37"	30.97'

CONSTRUCTION NOTES:

- (1) PROTECT IN PLACE
- (2) SAWCUT & MATCH EX
- (3) ADJUST TO PROPOSED GRADE
- (4) CONSTRUCT TACK ON MEDIAN ISLAND PER USD NO. 221, SEE DWG R19 THRU R30
- (5) CONSTRUCT SIDEWALK PER USD NO. 234
- (6) CONSTRUCT "L" TYPE CURB AND GUTTER PER USD NO. 216
- (7) CONSTRUCT SIDEWALK RAMP CASE I PER USD NO. 235
- (8) CONSTRUCT SIDEWALK RAMP CASE II PER USD NO. 235
- (11) CONSTRUCT TRUNCATED DOMES PER USD NO. 235
- (13) GRIND HANDICAP RAMP TO ZERO LIP
- (14) ADJUST WATER VALVE PER UDACS STANDARD PLATE #8 (VALVES MUST BE ACCESSIBLE AT ALL TIMES)
- (19) RELOCATE BY OTHERS, SEE NOTE 2 ON DWG 12
- (22) REMOVE AND RELOCATE FH PER UDACS PLATE #7 CONDITION G
- (23) CONSTRUCT BUS TURNOUT PER USD NO. 234.1
- (27) CONSTRUCT SIDEWALK DRAIN PER USD NO. 236 SEE PROPERTY DETAILS P1 THRU P25 FOR NEW LOCATION
- (28) RELOCATE PRIVATE SIGN, SEE PROPERTY DETAILS P1 THRU P25 FOR NEW LOCATION
- (31) CONSTRUCT COMMERCIAL DRIVEWAY PER USD NOS. 222A AND 225
- (33) CONSTRUCT RESIDENTIAL DRIVEWAY PER USD NOS. 222 AND 223
- (35) RELOCATE WATER METER AND RPPA PER UDACS PLATE #1D AND #11A, SEE PROPERTY DETAILS P1 THRU P25 FOR NEW LOCATION
- (39) RELOCATE PRIVATE STREETLIGHT, SEE PROPERTY DETAILS P1 THRU P25 FOR NEW LOCATION
- (52) RELOCATE WATER METER PER UDACS PLATE #1D, SEE PROPERTY DETAILS P1 THRU P25 FOR NEW LOCATION
- (55) RELOCATE DCDA PER UDACS PLATE NO. 11C (SEE PROPERTY DETAILS DRAWING P1-P25 FOR NEW LOCATION)
- (60) CONSTRUCT 3'x30' BUS PAD PER USD NO. 234.2
- (61) REMOVE AND RELOCATE FH PER UDACS PLATE #7 CONDITION C
- (62) CONSTRUCT BOLLARDS, SEE PROPERTY DETAILS FOR PLACEMENT. SEE DRAWING D4 FOR DETAILS.

Avoid cutting underground utility lines. It's costly.

2 working days

Call before you Dig

1-800-227-2600

Underground Service Alert (U.S.A.)

Avoid overhead power line contact.

2 working days

Call before you Overhead

1-702-227-2929

Nevada Power Environment and Safety Services Department

APPROVED

Robert Morgan

LAS VEGAS VALLEY WATER DISTRICT

DATE: 7/3/07

CONSULTING ENGINEERS • PLANNERS • LAND SURVEYORS

2727 SOUTH RAINBOW BOULEVARD

LAS VEGAS, NEVADA 89146-5148 PHONE (702) 873-7550 FAX (702) 362-2597

DEPARTMENT OF PUBLIC WORKS

CITY OF LAS VEGAS


vtm nevada

ROADWAY PLAN AND PROFILE

STA. 96+00.00 TO STA. 106+00.00

MARTIN L. KING BLVD IMPROVEMENTS

ALTA DR TO CAREY AVE

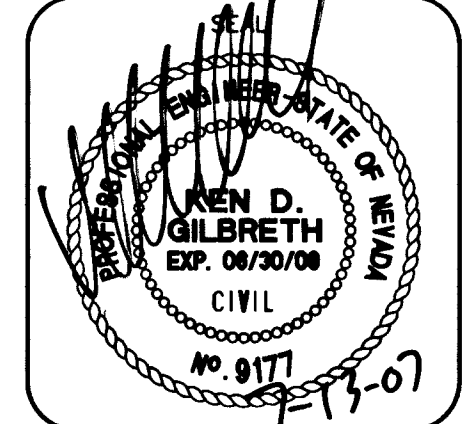

NO. NO. 6224

DESIGNED BY LMW

DRAWN BY LMW

DATE 4/2/07

SCALE HORIZ. 1"=40'

VERT. 1"=4'

DRAWING R10

SHEET 237

SHEETS

