



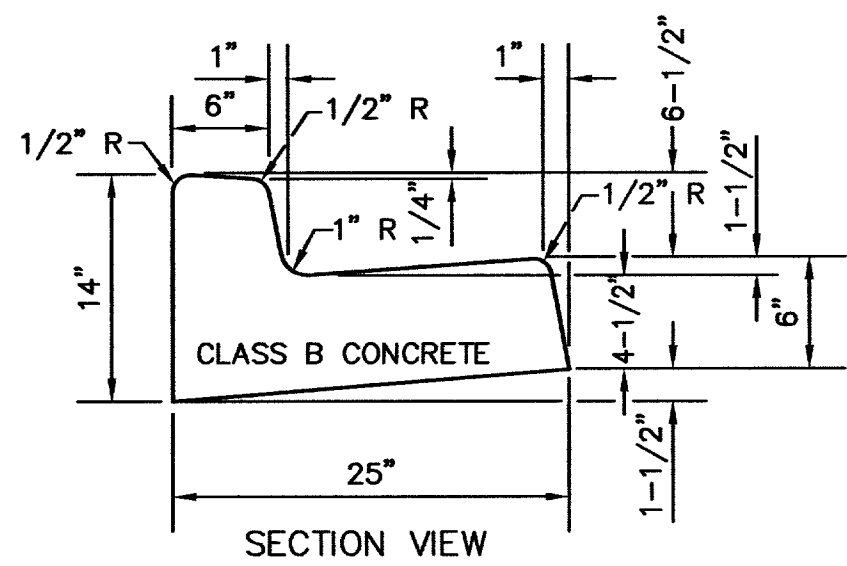


1/2" EXPANSION JOINT AT ALL COLD JOINTS, AT BEGINNING & END OF RETURN AND AT 300' MAX. INTERVALS FOR EXTRUDED CURB AND 30' MAX. INTERVALS FOR FORMED CURB. FOR JOINT DETAIL, SEE DWG. NO. 119 C.C. STDS.

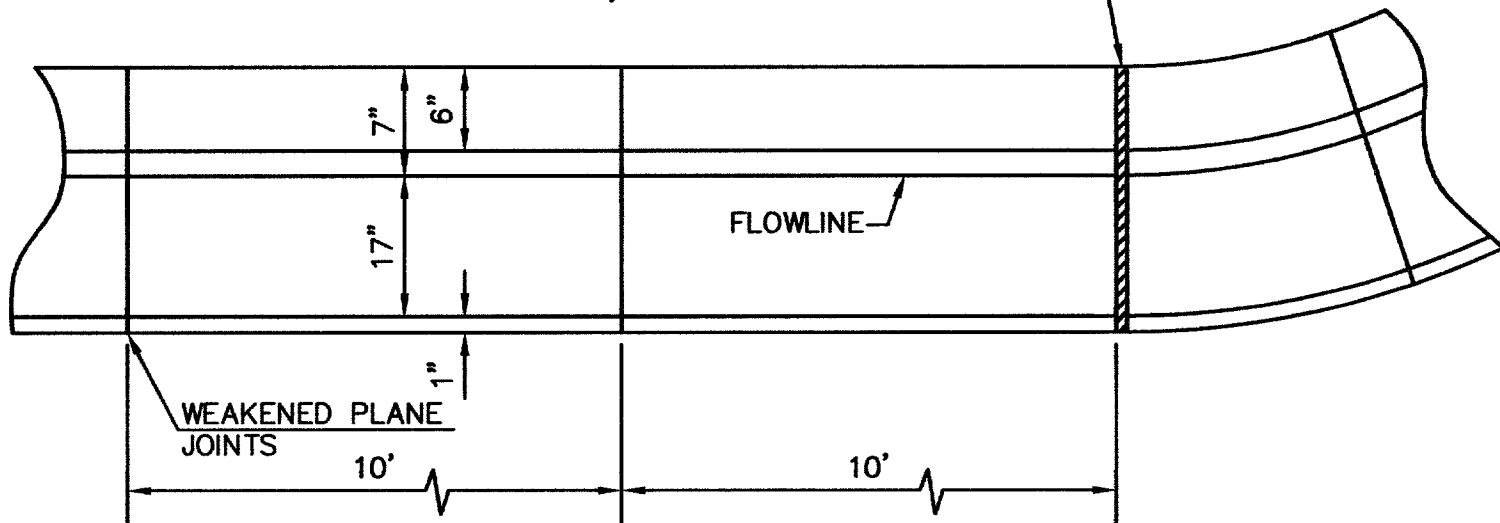

8' 'L' TYPE CURB & GUTTER

NOT TO SCALE


1

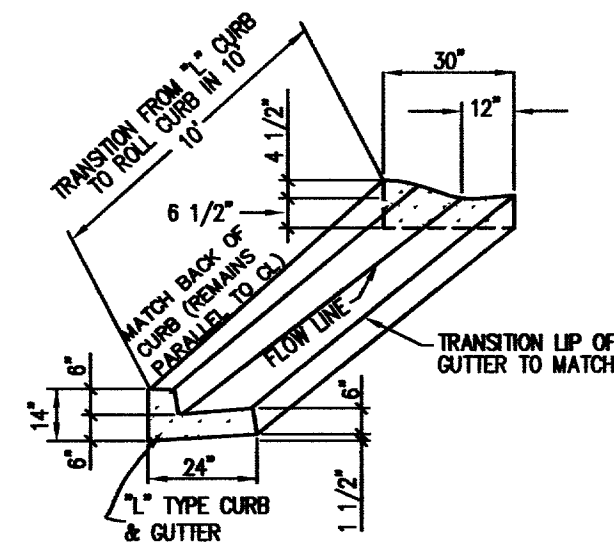

30' ROLL TYPE CURB & GUTTER TRANSITION TO 'L' TYPE CURB & GUTTER

NOT TO SCALE

2

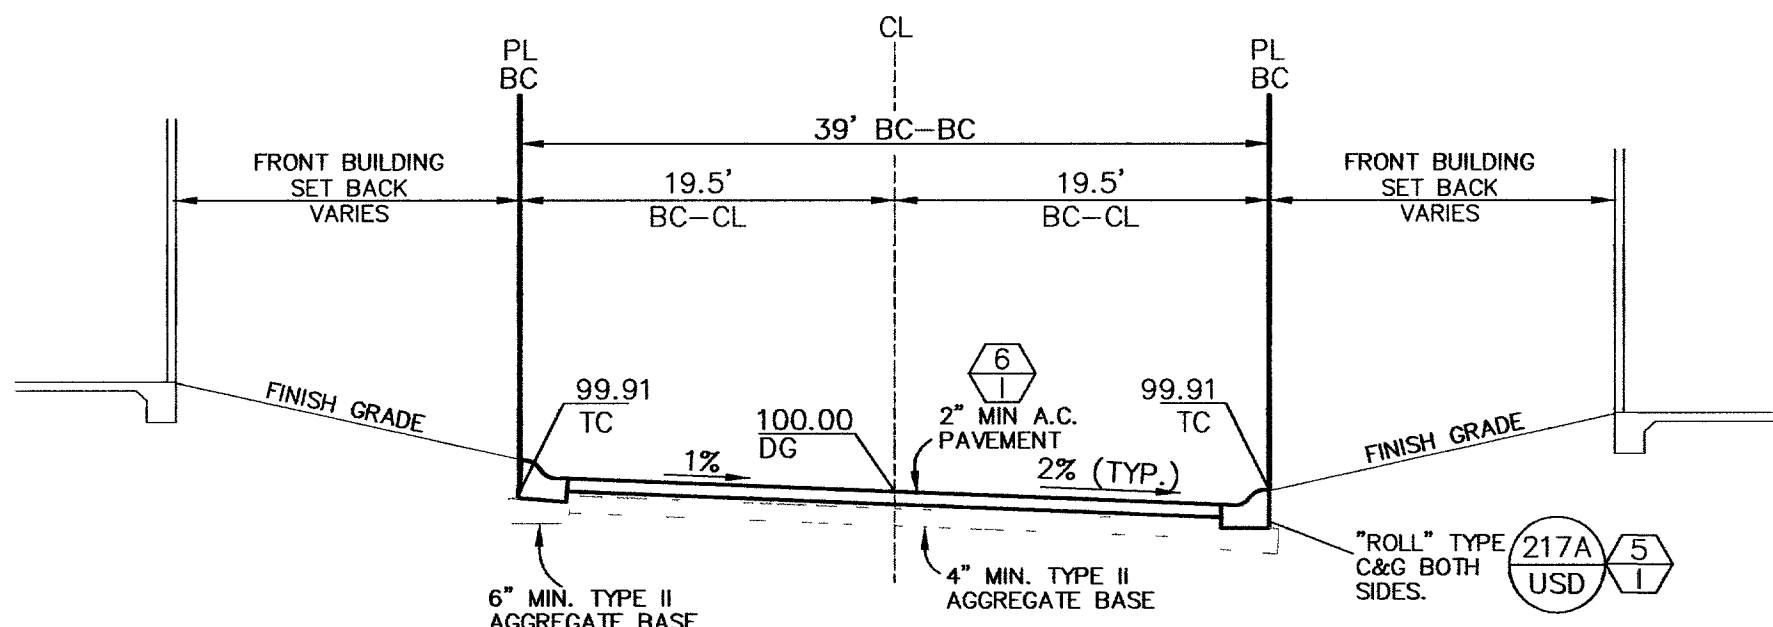


OFFSET CROWN SECTION

SCALE: HORIZ. 1" = 10'
VERT. 1" = 4'

SUGARLOAF PEAK STREET
STA. 17+71.81 TO STA. 17+38.67


3

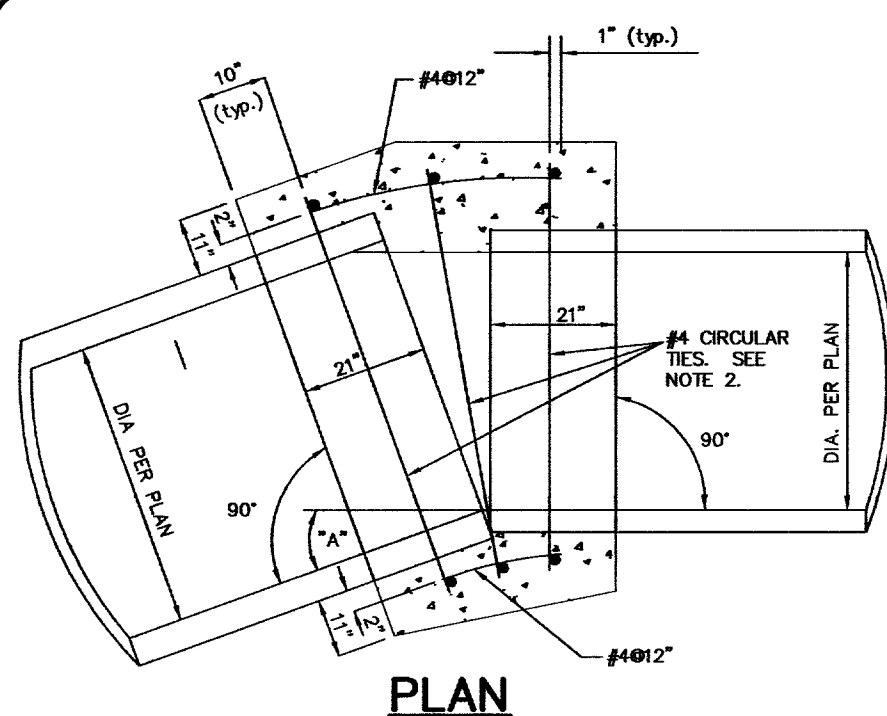

PLAN

CONCRETE COLLAR DETAIL
NOT TO SCALE

4

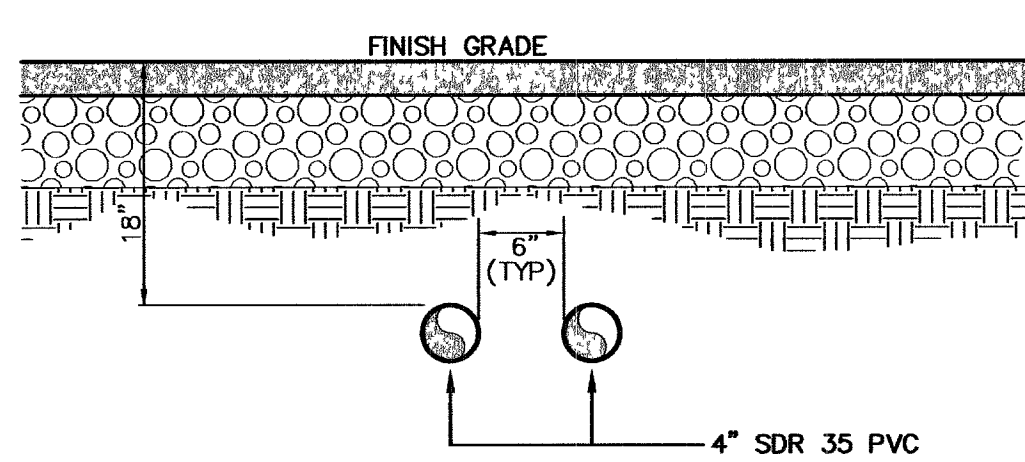


NOTES:

1. CONTRACTOR TO EXTEND SLEEVES 1' (12") BEHIND BACK OF CURB, TYP.
2. IRRIGATION SLEEVES MUST BE INSTALLED PER UDACS 2.19.02.3(C).

IRRIGATION SLEEVES - BANK "A"

NOT TO SCALE


6

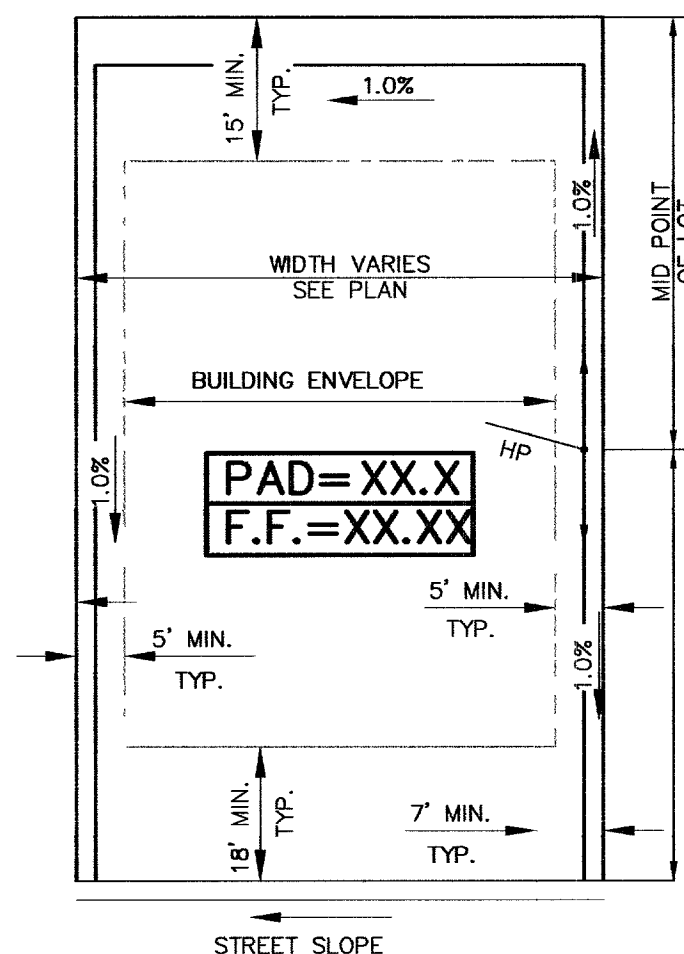

NOTE: SEE GRADING PLAN FOR RETAINING WALL LOCATIONS.

TYPICAL LOT GRADING
FROM SIDE OF LOT

NOT TO SCALE

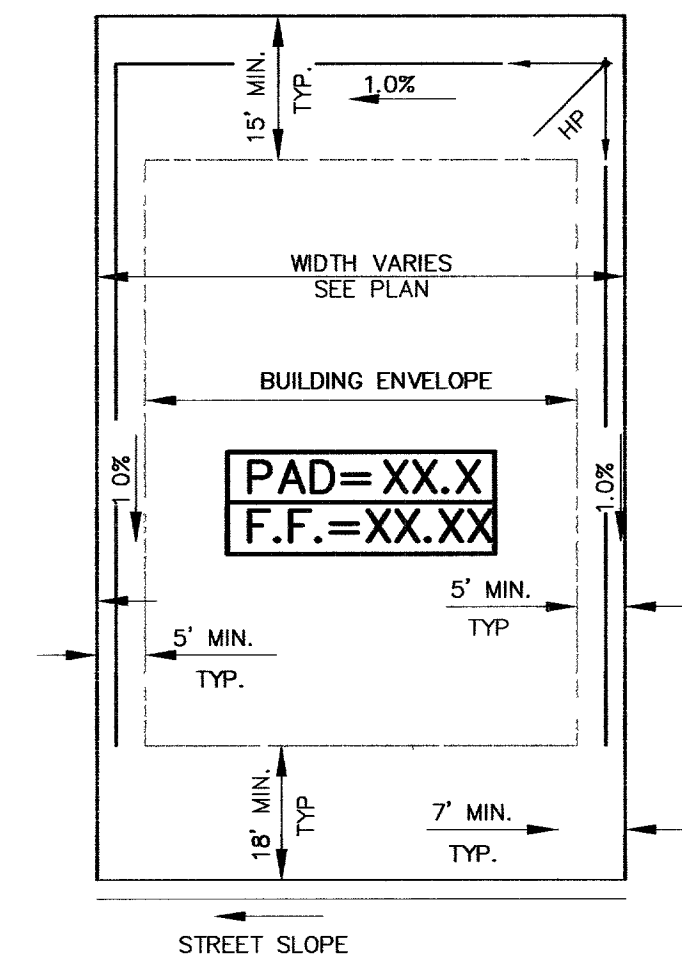

NOTE: SEE GRADING PLAN FOR RETAINING WALL LOCATIONS.

TYPICAL LOT GRADING

NOT TO SCALE

WATER QUANTITIES (PUBLIC)

8" PVC WATER PIPE	3230	LF
8" DIP WATER PIPE	7	LF
8" GATE VALVE	9	EA
FIRE HYDRANT ASSEMBLY	6	EA
CAP W/ 2" BLOWOFF	1	EA
8"x8" TEE	6	EA
8" BENDS	14	EA
1" TYPE "K" COPPER WATER	1956	LF
3/4" METER	86	EA
6" PVC WATER PIPE	110	LF
8"x6" REDUCER	1	EA

SEWER QUANTITIES (PUBLIC)

8" SDR 35	2980	LF
48" SANITARY MANHOLE	14	EA

SEWER QUANTITIES (PRIVATE)

4" PVC	2440	LF
--------	------	----

STORM DRAIN QUANTITIES (PUBLIC)

24" STORM DRAIN CLASS III RCP	38	LF
42" STORM DRAIN CLASS III RCP	40	LF
STORM DRAIN MANHOLE TYPE III	2	EA
7.5" TYPE "CM" DROP INLET	1	EA
CONCRETE COLLAR	1	EA

ROADWAY (PRIVATE)

2" ASPHALTIC CONCRETE PAVEMENT	12522	SY
4" TYPE II BASE	1644	CY
6" TYPE "L" CURB AND GUTTER	143	LF
TYPE "A" ISLAND CURB	136	LF
30" ROLL CURB	6057	LF
HANDICAP RAMP DEPRESSION	2	EA
STREET LANDSCAPING	1300	SY
PARK	1258	SY
8' CONCRETE CROSS GUTTER	3	EA
STREET LIGHTS	24	EA

LEGEND & ABBREVIATION


- 1 DETAIL DRAWING NUMBER
- 1 DRAWING NUMBER FOR DETAIL DRAWN ON SAME SHEET
- 1 DRAWING NUMBER FOR DETAIL WITH REFERENCE TO THE SHEET IT IS DRAWN ON
- 01,02, S DRAWING NUMBER(S) FOR DETAIL(S) PER STANDARDS IN ABBREVIATION TABLE
- 1 INDICATES CONSTRUCTION NOTE
- A 1 INDICATES REMOVAL NOTE
- 1 INDICATES CURVE NUMBER
- INDICATES SEWER MANHOLE IN PROFILE
- INDICATES STORM DRAIN MANHOLE IN PROFILE
- (60.5) EXIST. SPOT ELEVATION
- END PIPE & PLUG
- CONCRETE ENCASUREMENT
- FUTURE PROPERTY LINE
- FUTURE BACK OF CURB (ROW)
- FUTURE CENTERLINE

EMBANKMENT

- TOP PROPOSED
- BOTTOM BY SEPARATE CONTRACT
- EXISTING

ABBREVIATION

- I = IMPROVEMENTS
- W = WATER
- S = SEWER
- SD = STORM DRAIN
- IR = IRRIGATION
- T = TELECOMMUNICATION
- SL = STREET LIGHTING
- SIG = TRAFFIC SIGNAL
- SMH = SEWER MANHOLE
- SDMH = STORM DRAIN MANHOLE
- CLV = CITY OF LAS VEGAS
- LVVWD = LAS VEGAS VALLEY WATER DISTRICT
- LSCP = LANDSCAPE PANEL / PROPERTY LINE
- NDOT = NEVADA DEPT. OF TRANSPORTATION
- BVC = BEGIN VERTICAL CURVE
- EVC = END VERTICAL CURVE
- BCT = BEGIN CROSSFALL TRANSITION
- ECT = END CROSSFALL TRANSITION
- UDS = UNIFORM DESIGN AND CONSTRUCTION STANDARDS (UDACS)
- USD = UNIFORM STANDARD DWGS. (CLARK COUNTY)
- DCSWCS = DESIGN AND CONSTRUCTION STANDARDS FOR WASTEWATER COLLECTION SYSTEMS

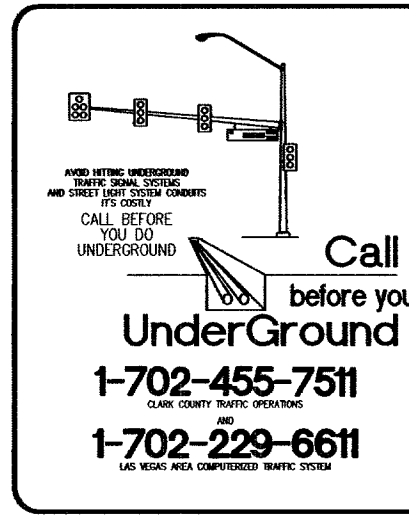

BENCHMARK		
DESC.	NAVD 88 DATUM	NAVD 88 DATUM
BLV99 13E4 RIVET AND PLATE IN CONCRETE CYLINDER AT THE NORTHWEST CORNER OF HUALAPAI WAY AND FARM ROAD.	2860.79 (FEET)	871.971 (METERS)

BASIS OF BEARINGS
N 88°21'18" E BEING THE SOUTH LINE OF THE SOUTHWEST QUARTER (SW 1/4) OF THE NORTHEAST QUARTER (NE 1/4) OF SECTION 13, T19S, R98E, M.D.M., AS SHOWN BY RECORD OF SURVEY ON FILE IN THE CLARK COUNTY, NEVADA RECORDER'S OFFICE IN FILE 124 OF SURVEYS AT PAGE 94.

APPROVAL	LVVWD NO. 111715
LAS VEGAS VALLEY WATER DISTRICT	DATE

CLV DRAWING NO. 107Y4891-8

ENGINEER - STATE OF NEVADA
CLARK COUNTY
PROFESSIONAL
No. 1576
DATE: 5/8/06

DESIGN: _____
DRAWN: _____
CHECK: _____
ISSUE DATE: _____
ISSUE EDITOR: _____
PLOT DATE: 05-04-08
PLOT TIME: 10:28:51
m.ding

MERITAGE CORPORATION
NORTHERN TERRACE - UNIT 8
QUANTITY, NOTES, AND
MISCELLANEOUS DETAILS SHEET
SHEET
C-3
3 OF 15 SHTS

JOB NO. 85002X15