


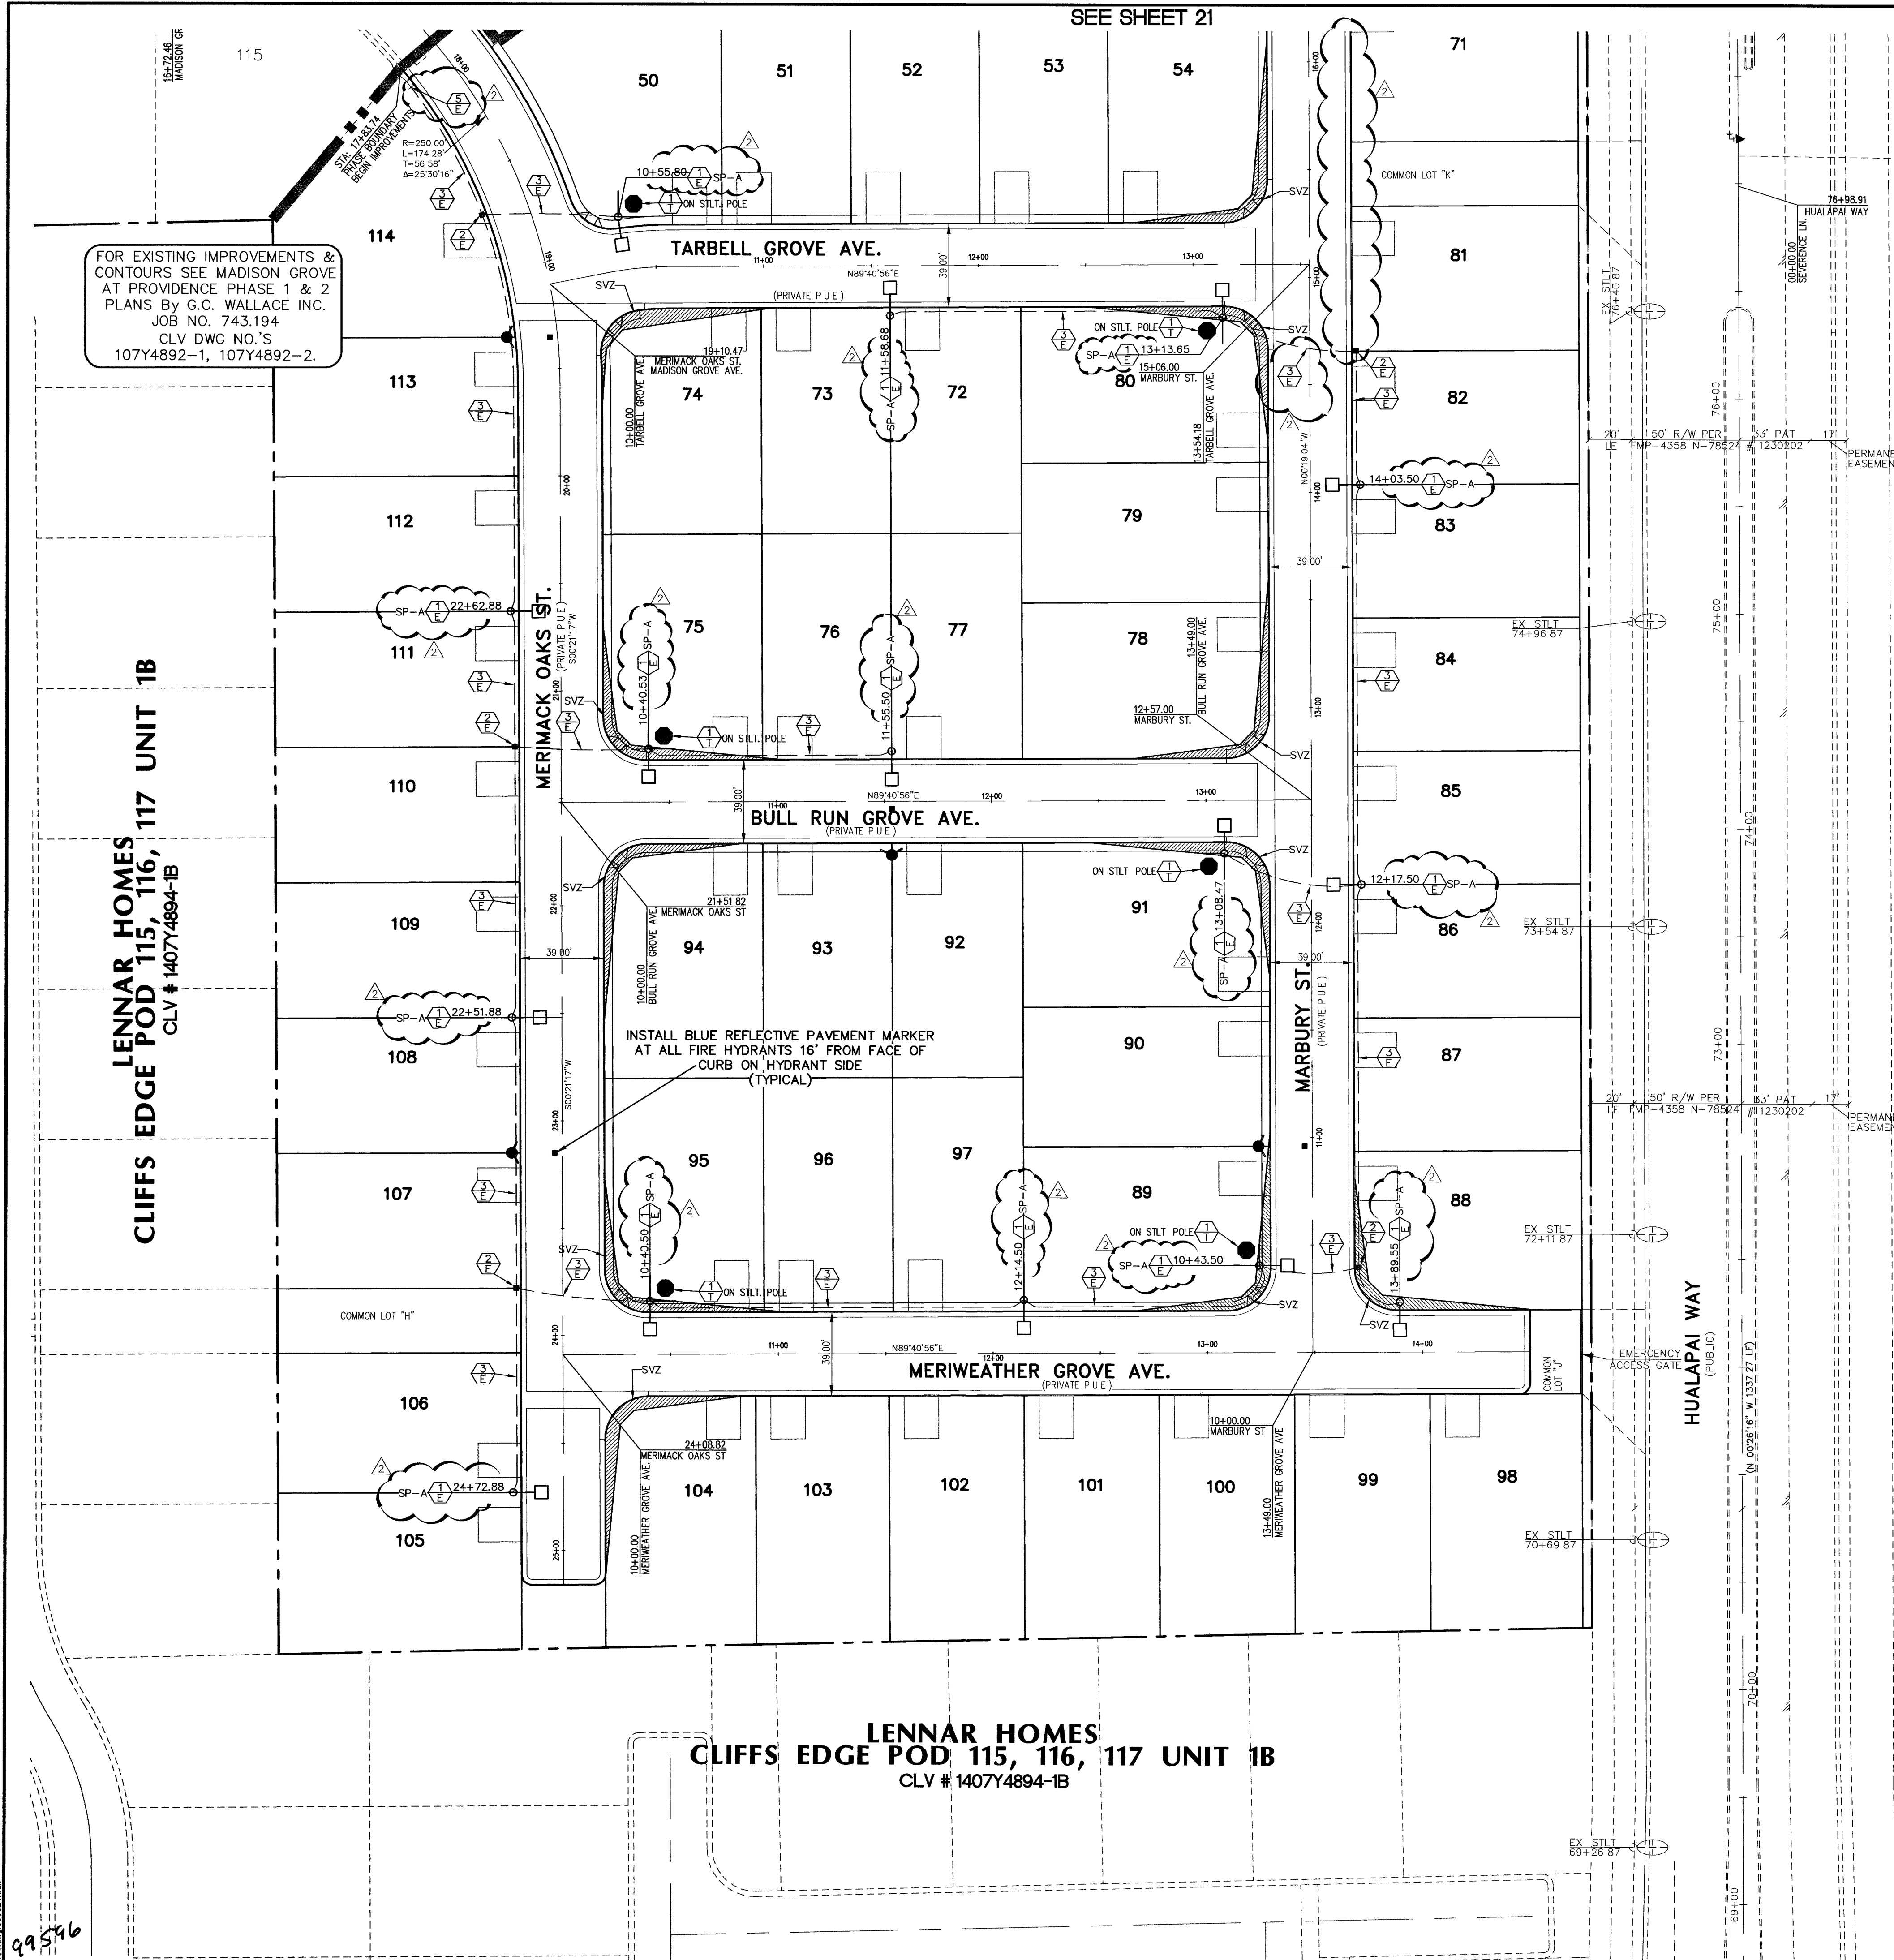

FOR EXISTING IMPROVEMENTS & CONTOURS SEE MADISON GROVE AT PROVIDENCE PHASE 1 & 2 PLANS BY G.C. WALLACE INC. JOB NO. 743.194 CLV DWG NO.'S 107Y4892-1, 107Y4892-2.


LENNAR HOMES
CLIFFS EDGE POD 115, 116, 117 UNIT 1B
CLV # 1407Y4894-1B

LENNAR HOMES
CLIFFS EDGE POD 115, 116, 117 UNIT 1B
CLV # 1407Y4894-1B

SEVERENCE LN.

FOR EXISTING HUALAPAI WAY IMPROVEMENT PLANS SEE PLANS BY VTN JOB NO. # 5969 CLV DWG NO. 107Y4816-HWY

BOOTH FELICIA CATHERINE REV TR
125-18-401-001

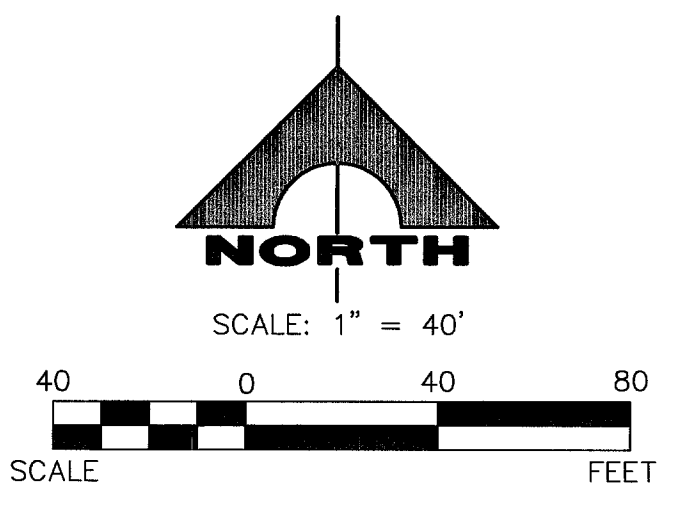


CALCULATION NOTE.
1. THE DESIGN PROFESSIONAL HAS PERFORMED ALL THE REQUIRED VOLTAGE DROP CALCULATIONS FOR ALL BRANCH CIRCUITS AND FEEDERS PER 2002 NATIONAL ELECTRICAL CODE ARTICLE 210.19(A)(1) FPN No. 4.

- STREETLIGHT CONSTRUCTION NOTES**
- 1 STREET LIGHTING LUMINAIRE 240V, 100W HPS, TYPE III DISTRIB. AS MANUFACTURED BY DYNAMIC LTC. INC.
 - 2 NO. 3-1/2 PULLBOX PER USD NO. 326
 - 3 1-1/4" C, 2 #4, 1 #8 GND
 - 4 STUB AND CAP 10' BEYOND LIMIT OF CONSTRUCTION.
 - 5 CONNECT TO EXISTING CONDUIT STUB.
 - 6 PROPOSED 75 KVA N.P.CO TRANSFORMER /200A SERVICE PEDESTAL.


- TRAFFIC CONSTRUCTION NOTES**
- 1 INSTALL 2'-9" STREET NAME SIGNS (D3-WHITE LETTERS W/BROWN BACKGROUND-PRIVATELY MAINTAINED) PER USD 250 & 30" STOP SIGN (R1-1)
 - 2 INSTALL 2'-9" STREET NAME SIGNS (D3-WHITE LETTERS W/BROWN BACKGROUND-PRIVATELY MAINTAINED) PER USD 250
 - 3 INSTALL 25 MPH SPEED LIMIT SIGN (R2-1)
 - 4 INSTALL "NO PARKING" SIGN (R7-1APR)
 - 5 INSTALL TYPE III-A BARRICADE PER USD #601

NOTE
1. ALL PRIVATE STREETS ARE P.U.E., PUBLIC SEWER EASEMENTS, AND PUBLIC DRAINAGE EASEMENTS TO BE PRIVATELY MAINTAINED BY THE HOMEOWNERS ASSOCIATION.
2. ALL PUBLIC DRAINAGE EASEMENTS TO BE PRIVATELY MAINTAINED BY THE HOMEOWNERS ASSOCIATION.
3. FOR CONSTRUCTION NOTES SEE SHEET 2.
4. FOR THE MASTER UTILITY PLAN SEE SHEET 4.

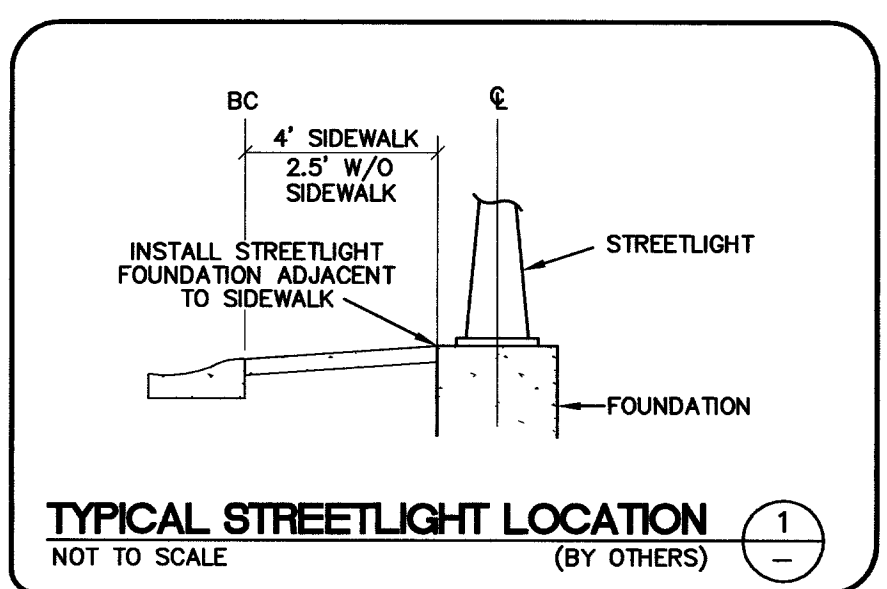


- LEGEND**
- NEW STREETLIGHT CONDUIT
 - EX. STREETLIGHT CONDUIT
 - NEW STREETLIGHT SERVICE PEDESTAL
 - EX. STREETLIGHT SERVICE PEDESTAL
 - PROPOSED SINGLE STREETLIGHT
 - PROPOSED DOUBLE STREETLIGHT
 - EXISTING STREETLIGHT
 - FUTURE STREETLIGHT
 - PROPOSED PULL BOX
 - EXISTING PULL BOX
 - SIGHT VISIBILITY ZONE
 - 2'-9" STREET NAME SIGNS (D3-WHITE LETTERS W/BROWN BACKGROUND-PRIVATELY MAINTAINED) PER USD 250 & 30" STOP SIGN (R1-1) (PER PRIVATE STREET STANDARDS)
 - 2'-9" STREET NAME SIGNS (D3-WHITE LETTERS W/BROWN BACKGROUND-PRIVATELY MAINTAINED) PER USD 250 (PER PRIVATE STREET STANDARDS)
 - SP-X "X" SPECIFIES THE SERVICE PEDESTAL CIRCUIT
 - R1-1 (30")
 - R7-1APR (18"x24")
 - R2-1 (18"x18")

Call before you UnderGround.
1-702-455-7511
1-702-229-6611
LAS VEGAS AREA COMPUTERIZED TRAFFIC SYSTEM

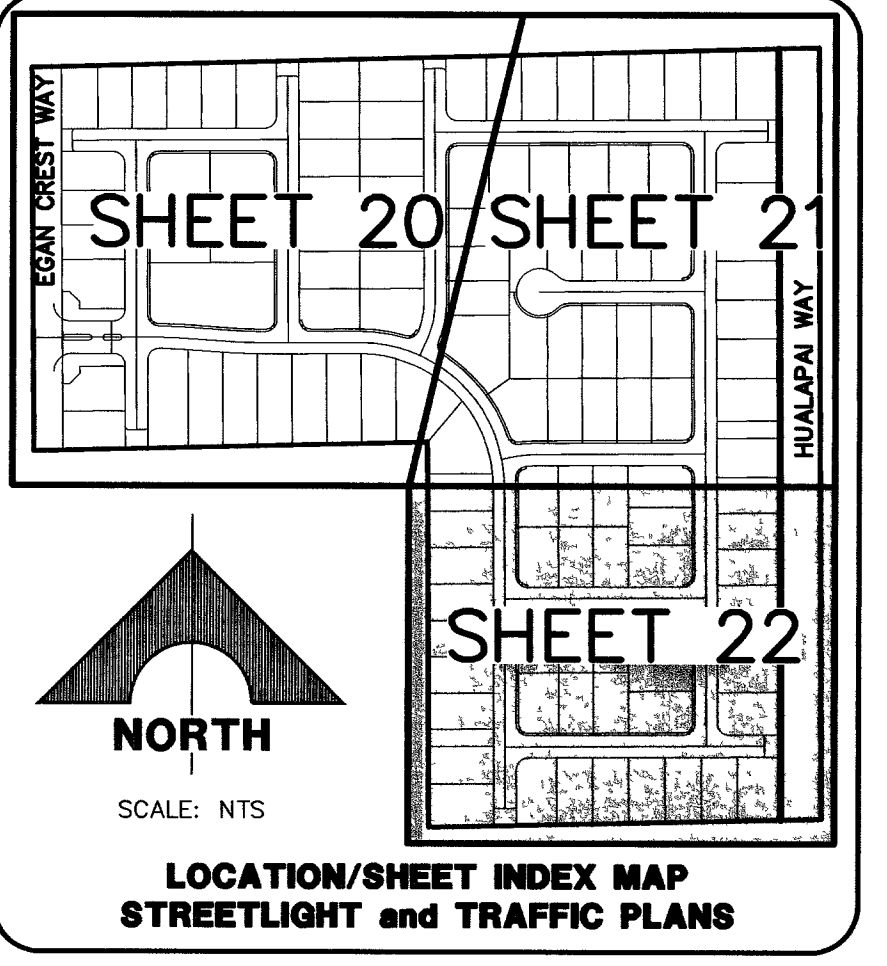

CLV DRAWING NO. 107Y4892-3

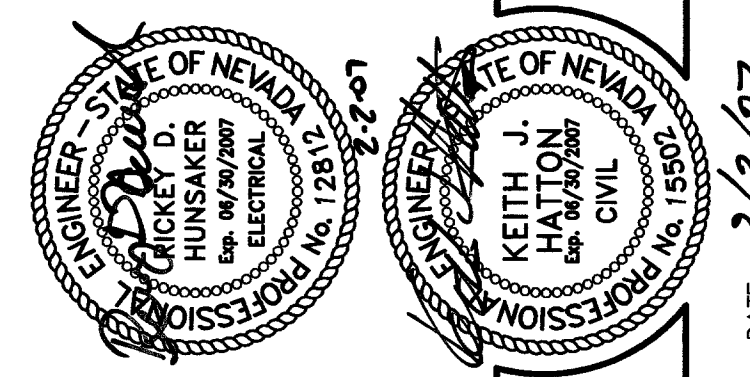

G.C. WALLACE, INC.
Engineers/Planners/Surveyors
1555 SOUTH RAINBOW BLVD./LAS VEGAS, NEVADA 89146
TELEPHONE: (702) 804-2000 • FAX: (702) 804-2299
E: 7431941@wallaceinc.com

ISSUED FOR:

REV.	DATE	DESCRIPTION
1	12/2/07	ISSUED FOR

ISSUE DATE: 12/2/07

DRAWING NO. 743194

JOB NO. 743194