



LIMIT OF CONSTRUCTION

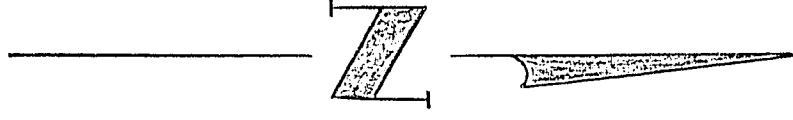

AS BUILT
5-2-83 P. LEE

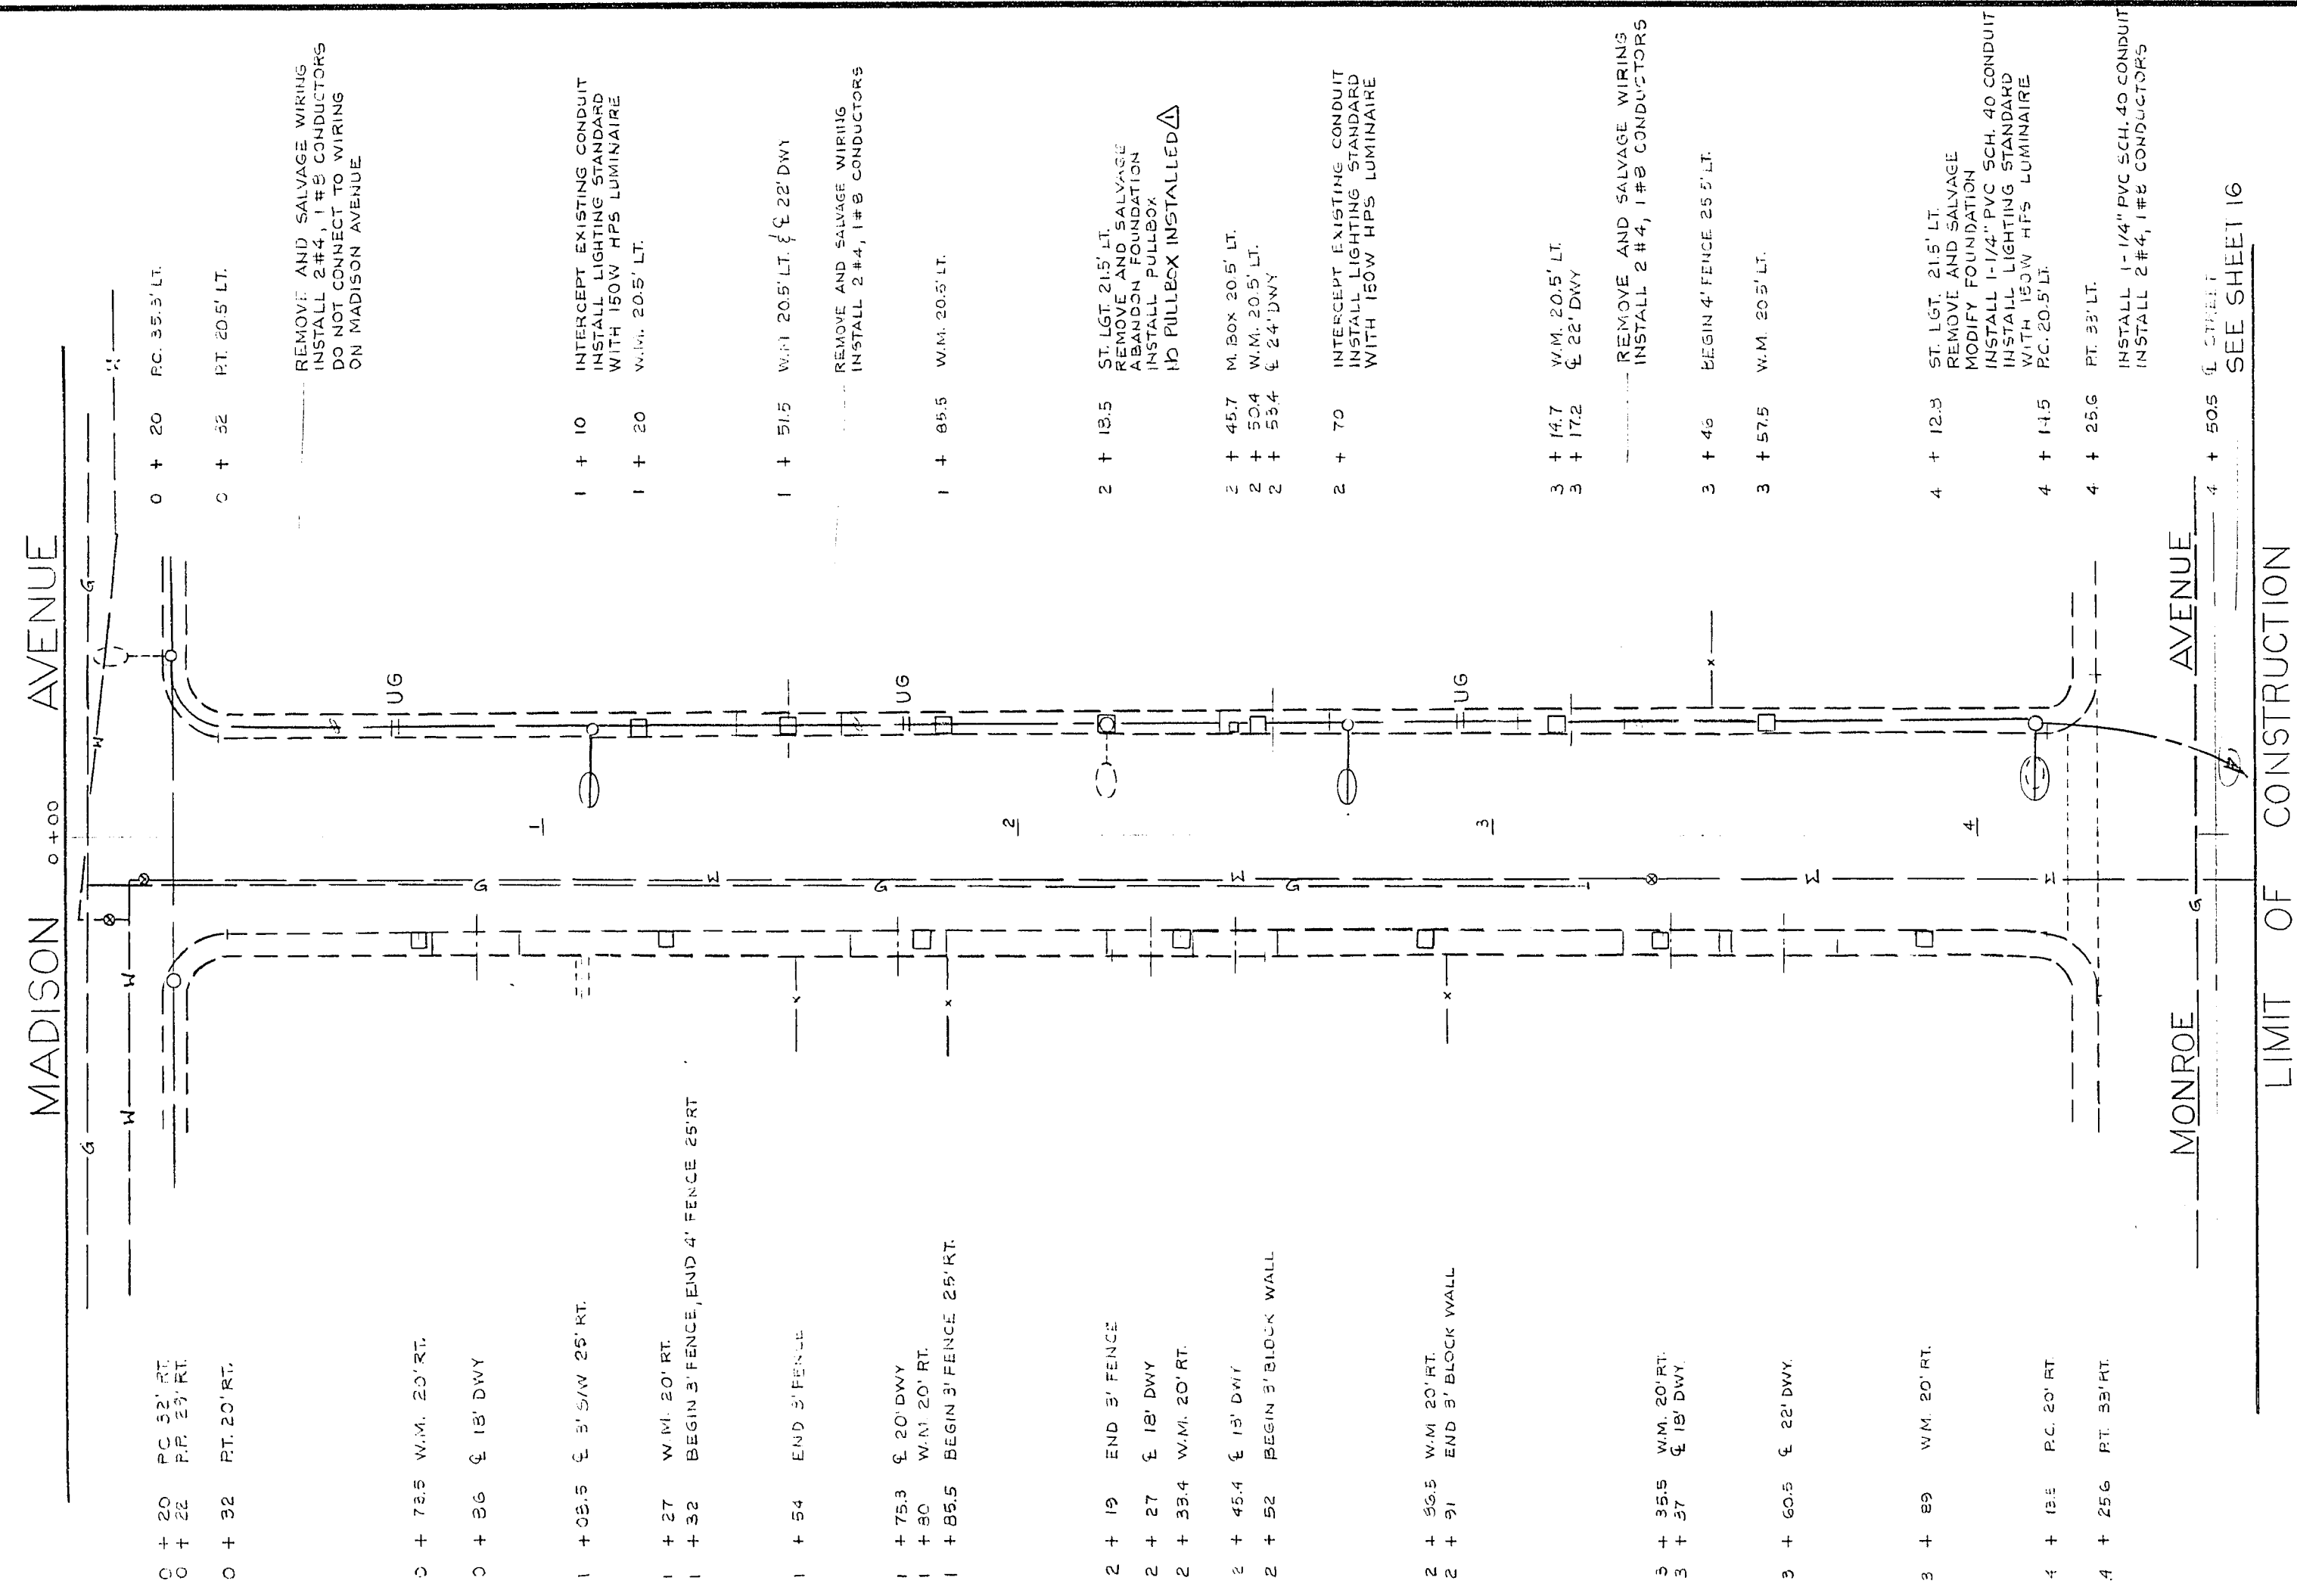

Department of Public Services
Engineering Design Division

N.S.A. II

IVY STREET
LIGHTING PLAN

Drawing no.
207 V - 2 2 9

$$\frac{10}{20}$$

Scale (h) ^{1st} = 30'	Scale (v) _____	W.A. 2115	AS-BUILT CONST. NOTED PAGE	1985
Fld. bk. no.	Date SEPT, 1991			
Design by M. GOODMAN	Drawn by NORMA GOMEZ			
			Revisions	Date

Revisions	Date
-----------	------