


NOTE:
CONTRACTOR SHALL BE RESPONSIBLE FOR REPLACING TRAFFIC LOOP AS REQUIRED IN THE INTERSECTION OF JONES BLVD AND LONE MOUNTAIN RD.



TEMPORARY BENCHMARK
CITY OF LAS VEGAS BM LV00 22NEGL RIVET & PLATE IN TOP OF CURB. SW RETURN OF LONE MOUNTAIN RD & BANNISTER LN EL 2282.09

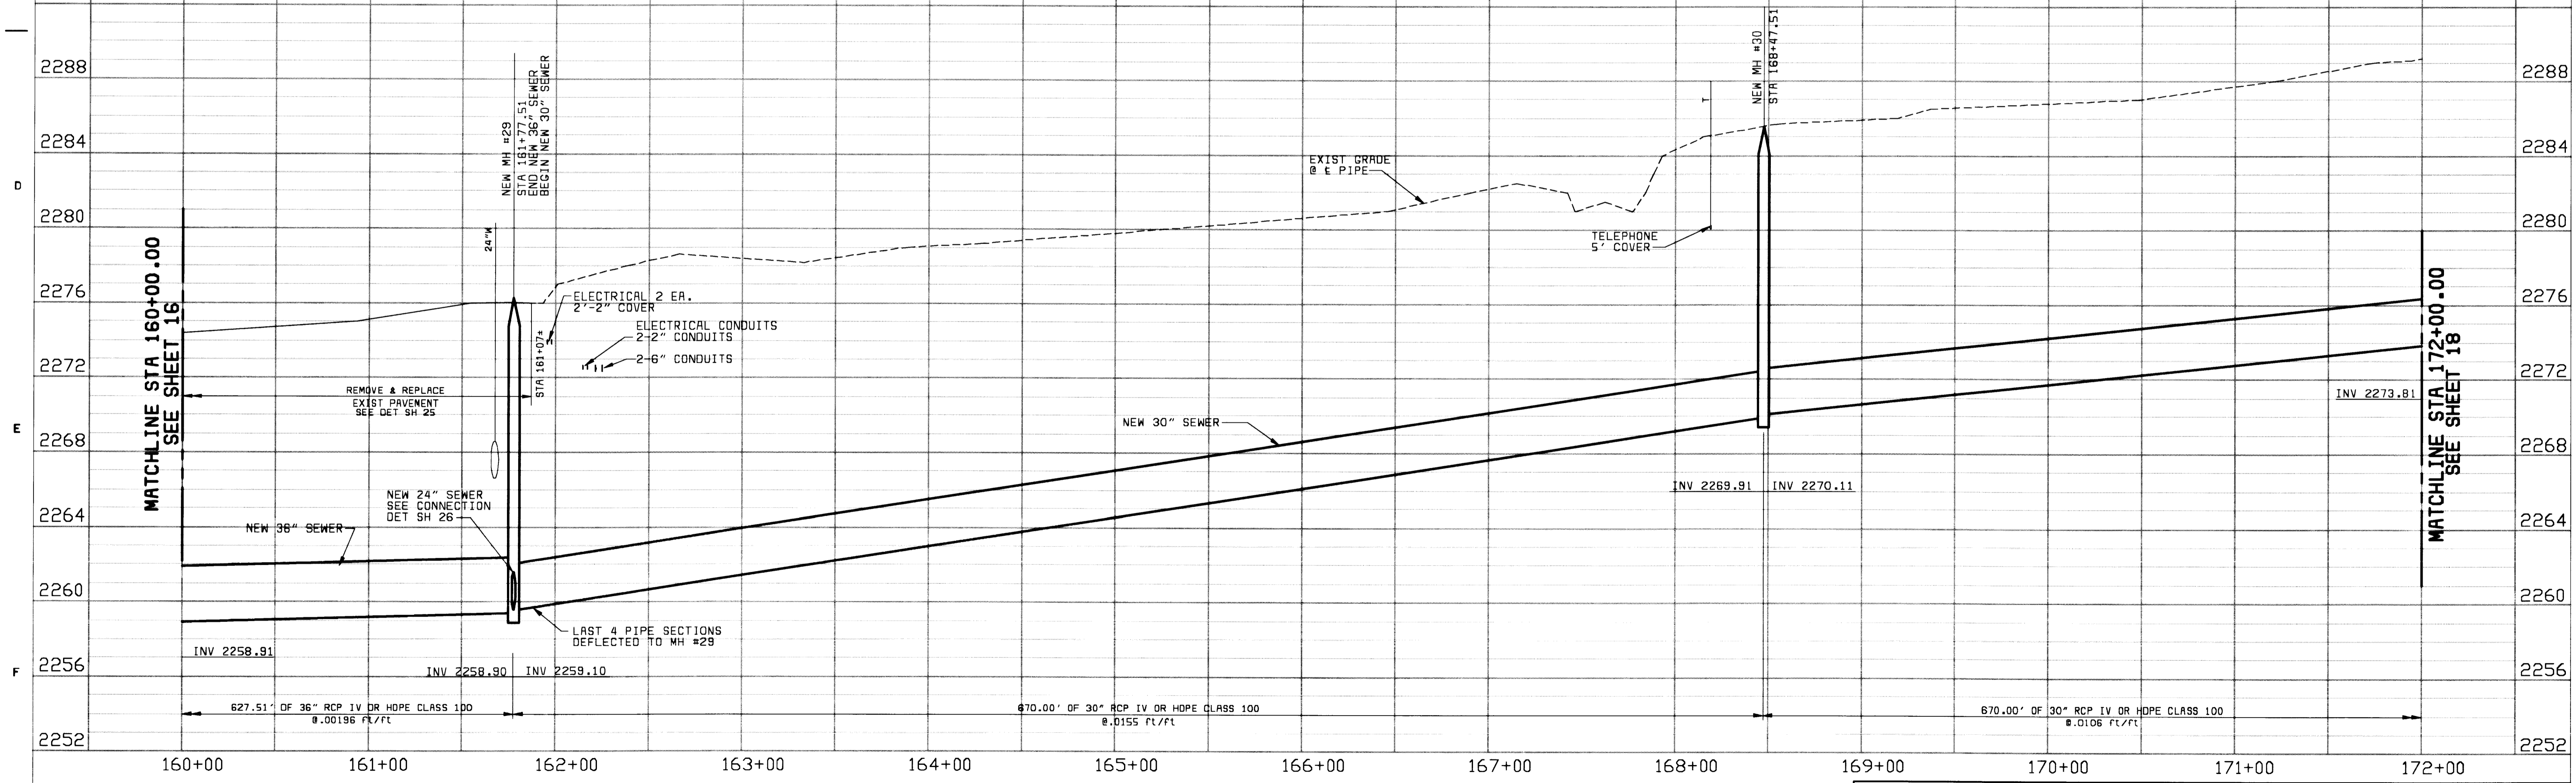

59-1073
08000000
F0300000

DATE	10/13/97	CONFORMS TO CONSTRUCTION RECORD	ACC	BMC
REVISIONS AND RECORD OF ISSUE				
NO.	BY	CK	APP	

DESIGNED PAT
 DETAILED PAT
 CHECKED P.R./J.B.W.
 APPROVED
 DATE





CITY OF LAS VEGAS
DEPARTMENT OF PUBLIC WORKS
MONTE CRISTO/CHEYENNE SEWER INTERCEPTOR

PLAN AND PROFILE
STA 160+00.00 TO STA 172+00.00

RECORD DRAWING
THESE RECORD DRAWINGS HAVE BEEN PREPARED BASED ON INFORMATION PROVIDED BY OTHERS. THE ENGINEER HAS NOT VERIFIED THE ACCURACY OF SUCH INFORMATION AND SHALL NOT BE RESPONSIBLE FOR ANY ERRORS OR OMISSIONS WHICH MAY BE INCORPORATED HEREIN AS A RESULT. THE DOCUMENTS WERE SEALED ON 10/16/95 BY PATRICK J. ROGAN UNDER LICENSE NO. 11845

DRAWING NO. **307-V739**
SHEET 17 OF 26

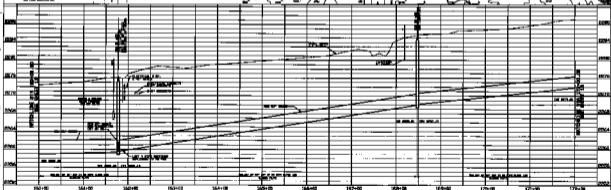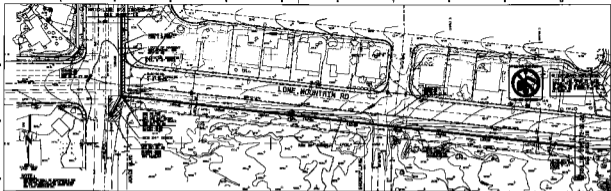

PROJECT NUMBER: 150-03-00 SHEET NUMBER: 17 OF 26		DATE: 10/10/00 DRAWN BY: J. L. WOOD CHECKED BY: J. L. WOOD	 Radianc Technology Las Vegas, Nevada	CITY OF LAS VEGAS DEPARTMENT OF PUBLIC WORKS NORTH OROVING/SHENANDO RIVER INTERSECTION PLAN AND PROFILE STA 150+00.00 TO STA 178+00.00	SHEET NO. 150-03-00 17 OF 26
---	--	--	---	--	------------------------------------