


TEMPORARY BENCHMARK
ALUM CAP @ INTERSECTION OF
LONE MOUNTAIN RD & GOLFRIDGE
DR.
EL. 2294.63

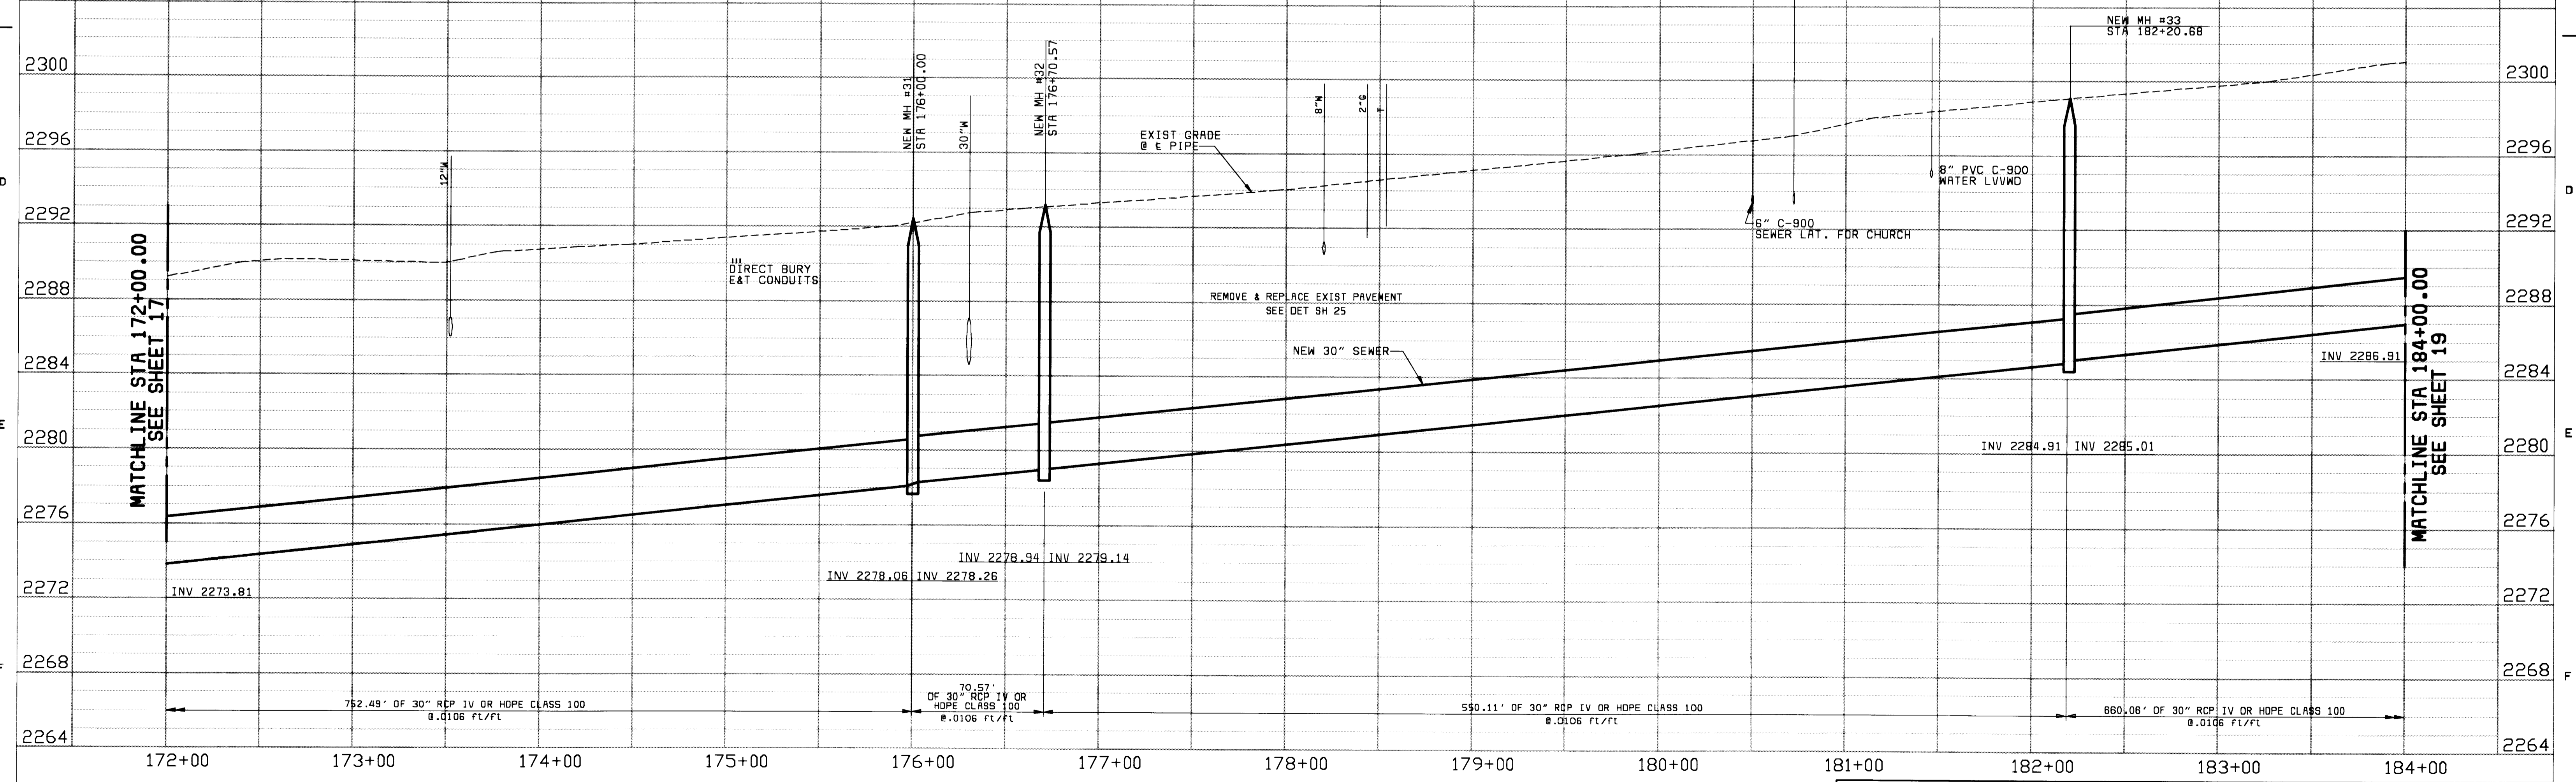

59-1073
CBC00000
F0800000

DATE	REVISIONS AND RECORD OF ISSUE	NO.	BY	CK	APP
5/14/96	REVISED ALIGNMENT		PAT	PJR	
10/13/97	CONFORMS TO CONSTRUCTION RECORD		ACC	BMC	

DESIGNED: PAT
 DETAILED: PAT
 CHECKED: PJR/JBW
 APPROVED: _____
 DATE: _____





CITY OF LAS VEGAS
 DEPARTMENT OF PUBLIC WORKS
 MONTE CRISTO/CHEYENNE SEWER INTERCEPTOR
 PLAN AND PROFILE
 STA 172+00.00 TO STA 184+00.00

RECORD DRAWING
 THESE RECORD DRAWINGS HAVE BEEN PREPARED BASED ON INFORMATION PROVIDED BY OTHERS. THE ENGINEER HAS NOT VERIFIED THE ACCURACY OF SUCH INFORMATION AND SHALL NOT BE RESPONSIBLE FOR ANY ERRORS OR OMISSIONS WHICH MAY BE INCORPORATED HEREIN AS A RESULT OF THE DOCUMENTS WERE SEALED ON 07/16/95 BY PATRICK J. ROMAN UNDER LICENSE NO. 11545

DRAWING NO.
307-V739
 SHEET
 18 OF 26

2079

CCS - DWG - NO: 0016

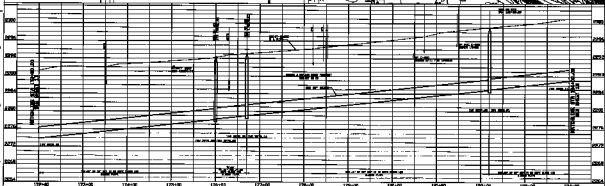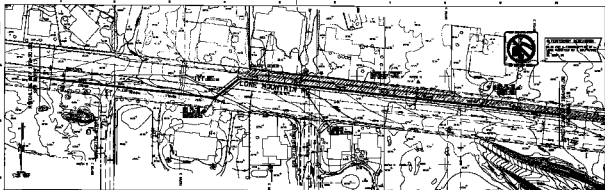

<p>DATE: 08/15/2011 TIME: 10:00 AM DRAWN BY: [Signature]</p>	<p>PROJECT: [Project Name] SHEET: [Sheet Number]</p>	<p>SCALE: [Scale] TITLE: [Title]</p>	<p>DESIGNED BY: [Name] CHECKED BY: [Name] APPROVED BY: [Name]</p>	<p>DATE: [Date] TIME: [Time] DRAWN BY: [Signature]</p>	<p>PROJECT: [Project Name] SHEET: [Sheet Number]</p>	<p>SCALE: [Scale] TITLE: [Title]</p>	<p>DESIGNED BY: [Name] CHECKED BY: [Name] APPROVED BY: [Name]</p>
--	---	---	---	--	---	---	---

Black & Veatch
 Las Vegas, Nevada

CITY OF LAS VEGAS
 DEPARTMENT OF PUBLIC WORKS
 WATER DISTRIBUTION SYSTEMS DIVISION

PLAN AND PROFILE
 STA 172+00.00 TO STA 184+00.00

PROJECT NO. 603-0700
 SHEET 13 OF 26