

NOTES:

1. CONTRACTOR MAY INSTALL SEWER BETWEEN STA 11+00.00 AND STA 69+09.65 BY MICROTUNNELING OR CONVENTIONAL OPEN CUT TRENCHING METHODS. PIPE OPTIONS SHOWN BETWEEN STA 11+00.00 AND STA 69+09.65 ARE FOR MICROTUNNELING ALTERNATIVES. PIPE OPTIONS FOR THE OPEN CUT TRENCHING ALTERNATIVE SHALL BE RCP CLASS 150 OR RCP V.
2. FOR TUNNELING AND TRENCH DETAILS SEE SHEET 25.
3. THE CONTRACTOR SHALL SELECT THE LOCATIONS OF SENDING AND RECEIVING SHAFTS AS CONTRACTOR DEEMS NECESSARY.
4. PAVEMENT REPLACEMENT FOR ACTUAL TUNNELING SHALL BE AROUND SENDING AND RECEIVING SHAFTS. PAVEMENT REPLACEMENT FOR OPEN CUT TRENCHING ALTERNATIVE SHALL BE AS SHOWN ON THE DRAWING.
5. MANHOLE DETAILS ARE SHOWN ON SHEET 24.

MATCHLINE STA 33+00.00
SEE SHEET 5

SCALE:
1"=50' HORIZ
1"=4' VERT

N11007.28
E31603.84
SEE SH 2, PT 7B

LIMITS OF
NEW PAVING

NEW MH #8
STA 33+36.40
N10795.6233
E31614.9103

THOM BLVD

NEW 36" SEWER

MATCHLINE STA 42+00.00
SEE SHEET 7

GOWAN RD


THOM BLVD

NEW MH #9
STA 40+43.57
N11502.7810
E31610.6703

12" STUBOUT
SEE DROP MH
12"-18" Y INSTALLED
ON INTERIOR OF MH
18" PVC PIPE BOLTED TO MH
BARREL (INT) W/ S.S. STRAP
AND BOLTS



TEMPORARY BENCHMARK
PK NAIL @ INTERSECTION OF
THOM BOULEVARD AND GOWAN
ROAD
EL 2241.36

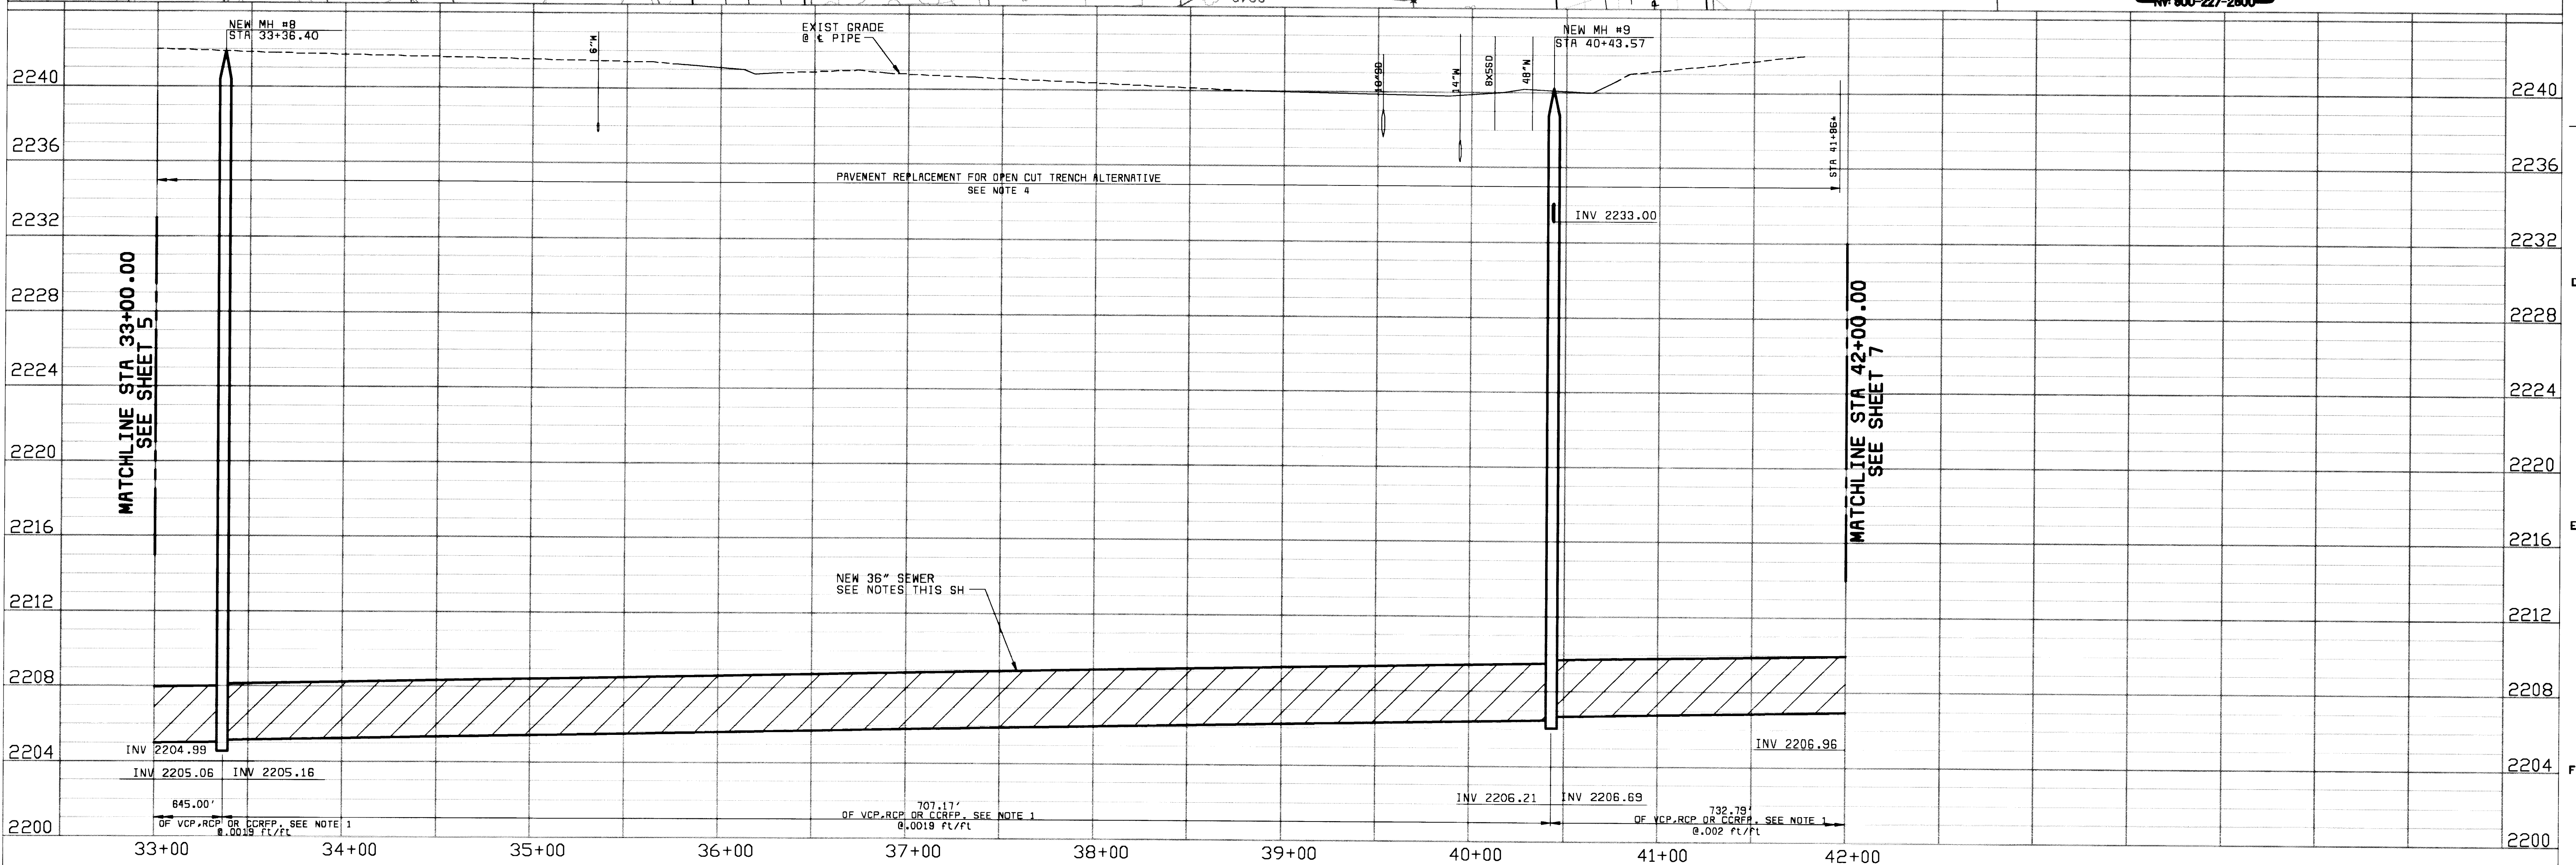

1-11-86 ADJUST NEW MH #9		PT PR 5/14/86 10/13/97	REVISED ALIGNMENT CONFORMS TO CONSTRUCTION RECORD	PAT/PJR ABC/BMC	DESIGNED PAT DETAILED PAT CHECKED PJR/JBW APPROVED DATE		CITY OF LAS VEGAS DEPARTMENT OF PUBLIC WORKS MONTE CRISTO/CHEYENNE SEWER INTERCEPTOR PLAN AND PROFILE STA 33+00.00 TO STA 42+00.00	RECORD DRAWING THESE RECORD DRAWINGS HAVE BEEN PREPARED BASED ON INFORMATION PROVIDED BY OTHERS. THE ENGINEER HAS NOT VERIFIED THE ACCURACY OF SUCH INFORMATION AND SHALL NOT BE RESPONSIBLE FOR ANY ERRORS OR OMISSIONS WHICH MAY BE INCORPORATED HEREIN AS A RESULT. THE DOCUMENTS WERE SEALED ON 10/16/97 BY PATRICK J. ROMAN UNDER LICENSE NO. 11545	DRAWING NO. 307-V739 SHEET 6 OF 26
--------------------------	--	------------------------------	--	--------------------	---	--	--	---	--

