

PIPE MATERIAL CONSTRUCTION LIST

UNLESS OTHERWISE NOTED ON THE PLANS, ALL PIPE MATERIALS USED SHALL BE AS FOLLOWS:

WATER SYSTEM


ALL PIPES GREATER THAN OR EQUAL TO 4" IN DIAMETER SHALL BE CONSTRUCTED USING PVC C-900
ALL PIPES LESS THAN 4" IN DIAMETER SHALL BE CONSTRUCTED USING PVC SCH 40 (PRIVATE)

SEWER SYSTEM

ALL PIPES SHALL BE CONSTRUCTED USING SDR-35

STORM DRAIN SYSTEM

ALL PIPES SHALL BE CONSTRUCTED USING MATERIALS AS NOTED ON PLANS

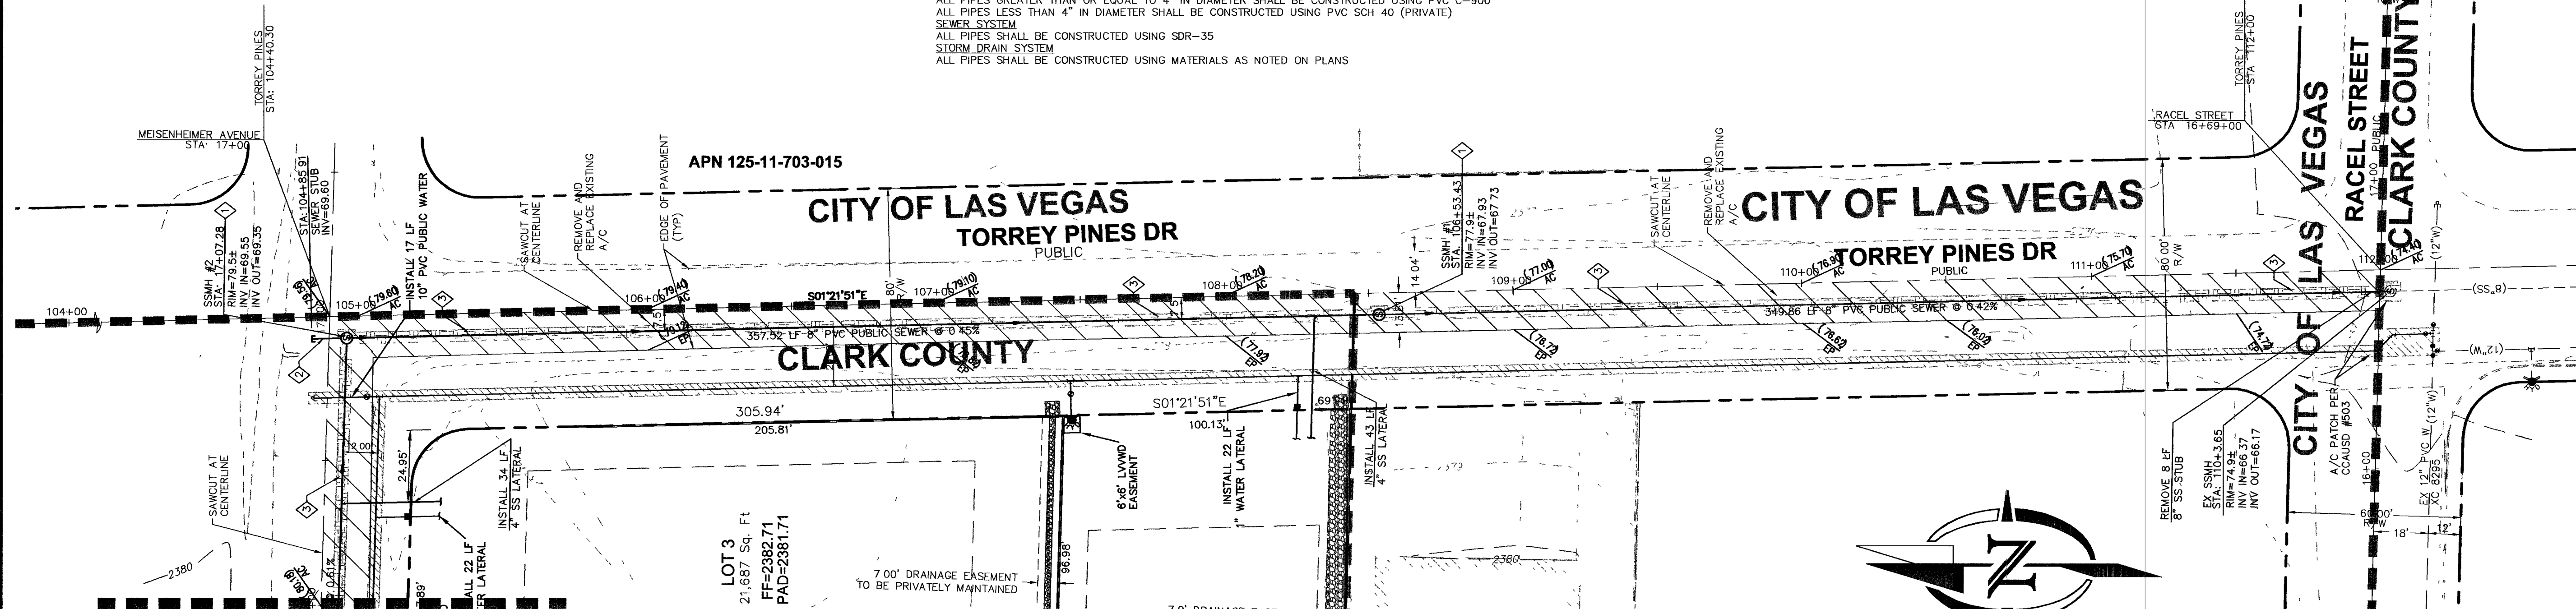

SEE SHEET C4.03
FOR CONTINUATION


Call
before you
Dig.
1-800-227-2600
UNDERGROUND SERVICE (USA)

Call
before you
CRANE
1-702-227-2929


Call
before you
UnderGround
1-702-455-7511
CLARK COUNTY TRAFFIC OPERATIONS
1-702-229-6611
FREEWAY AND AIRPORT SYSTEMS OF TRANSPORTATION

SEWER CONSTRUCTION NOTES:

- CONSTRUCT 48" MANHOLE PER CCWRD STD DWG SD-1.
 - INSTALL 8" PVC STUB.
 - TRENCH & BACKFILL PER APPLICABLE CCAUSD #503 AND #504
- THE CONTRACTOR IS REQUIRED TO PULL PERMIT FROM LAND DEVELOPMENT, CITY OF LAS VEGAS FOR INSTALLATION OF SEWER SYSTEM.

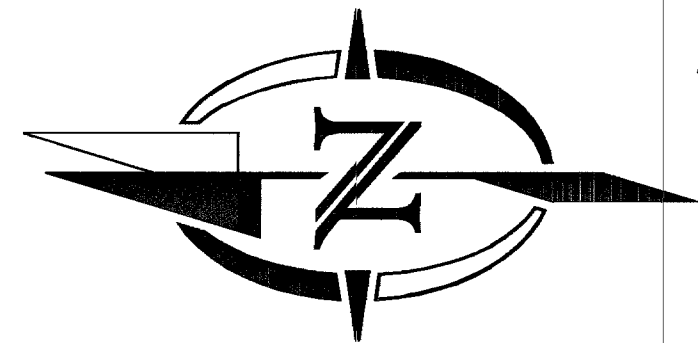


GRAPHIC SCALE

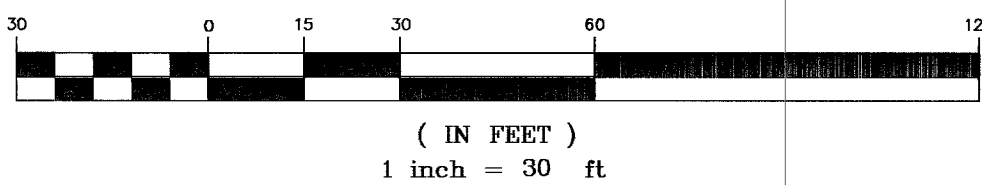

RECORD DRAWING
These Record Drawings have been prepared based on information provided by others. The Engineer has not verified the accuracy of such information and shall not be responsible for any errors or omissions which may be incorporated herein as a result.

PLAN VIEW
HORIZONTAL: 1" = 30'
VERTICAL: NONE

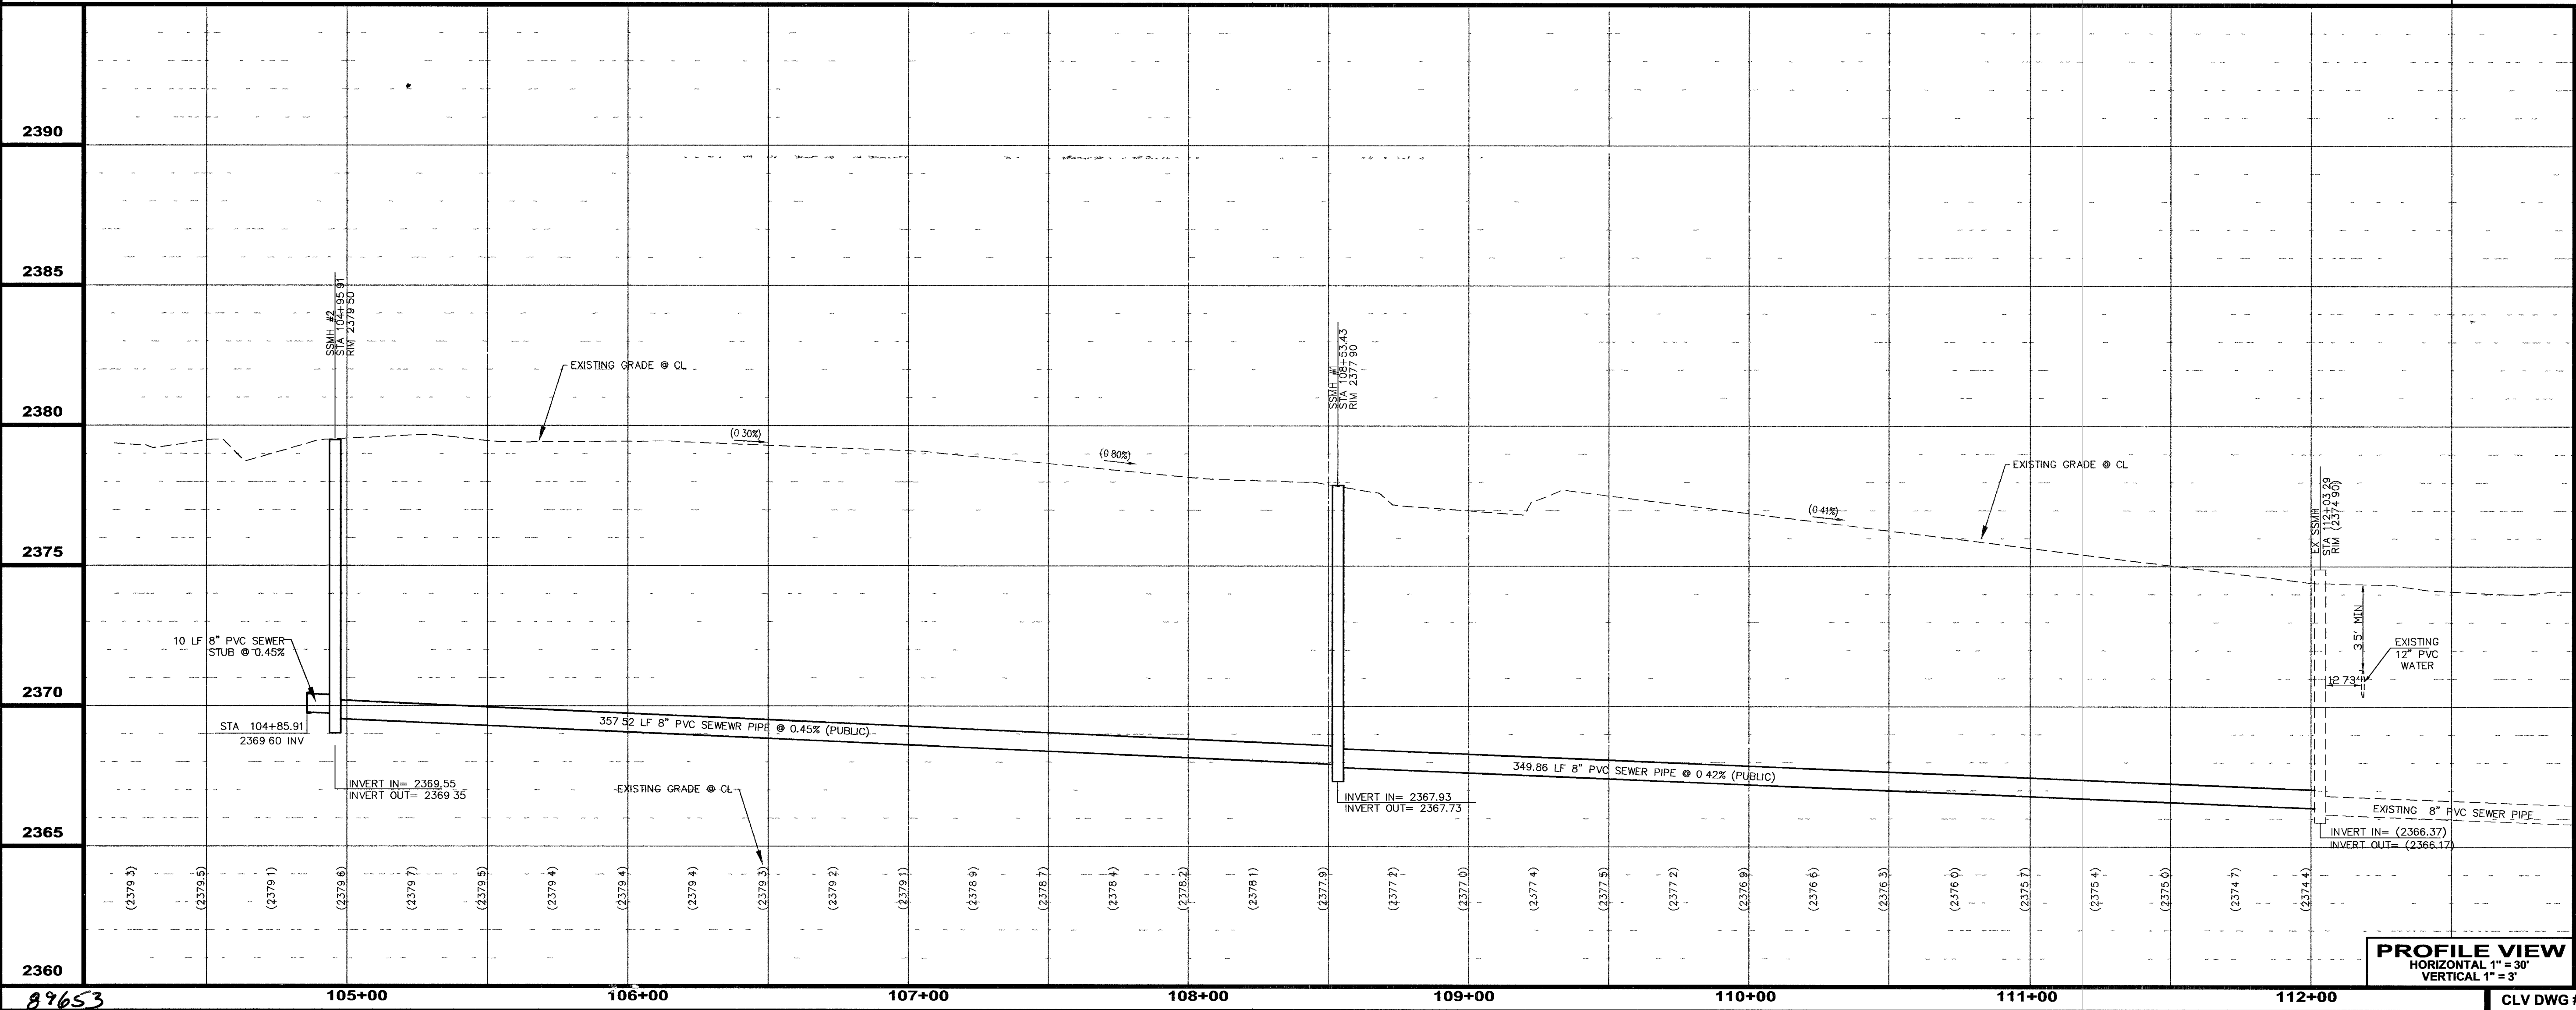

PROFILE VIEW
HORIZONTAL 1" = 30'
VERTICAL 1" = 3'

RICHARD J. AND THERESA M. YACH
7308 BUSH GARDEN AVENUE
LAS VEGAS, NV 89129
(702) 656-7476

MEISENHEIMER & TORREY PINES (SW)
YACH PARCEL MAP - MSM-0007-04

SEWER PLAN AND PROFILE
TORREY PINES DRIVE

SHEET
C4.02

5 OF 7 SHEETS

DRAWING NO.

HTE # 04-46525

SCALE: 1"=30'

DRAWN BY: CAG

DESIGNED BY: CAG

CHECKED BY: RJ

SUBMITTAL DATE:

REV. # DATE

APP

REVISION APPROVAL BLOCK