


KEY PLAN

NTS



NOTES:

1. ALL DUCT DIMENSIONS ARE OVERALL DIMENSIONS. PROVIDE 1" ACCOUSTICAL LINING WHERE INDICATED.

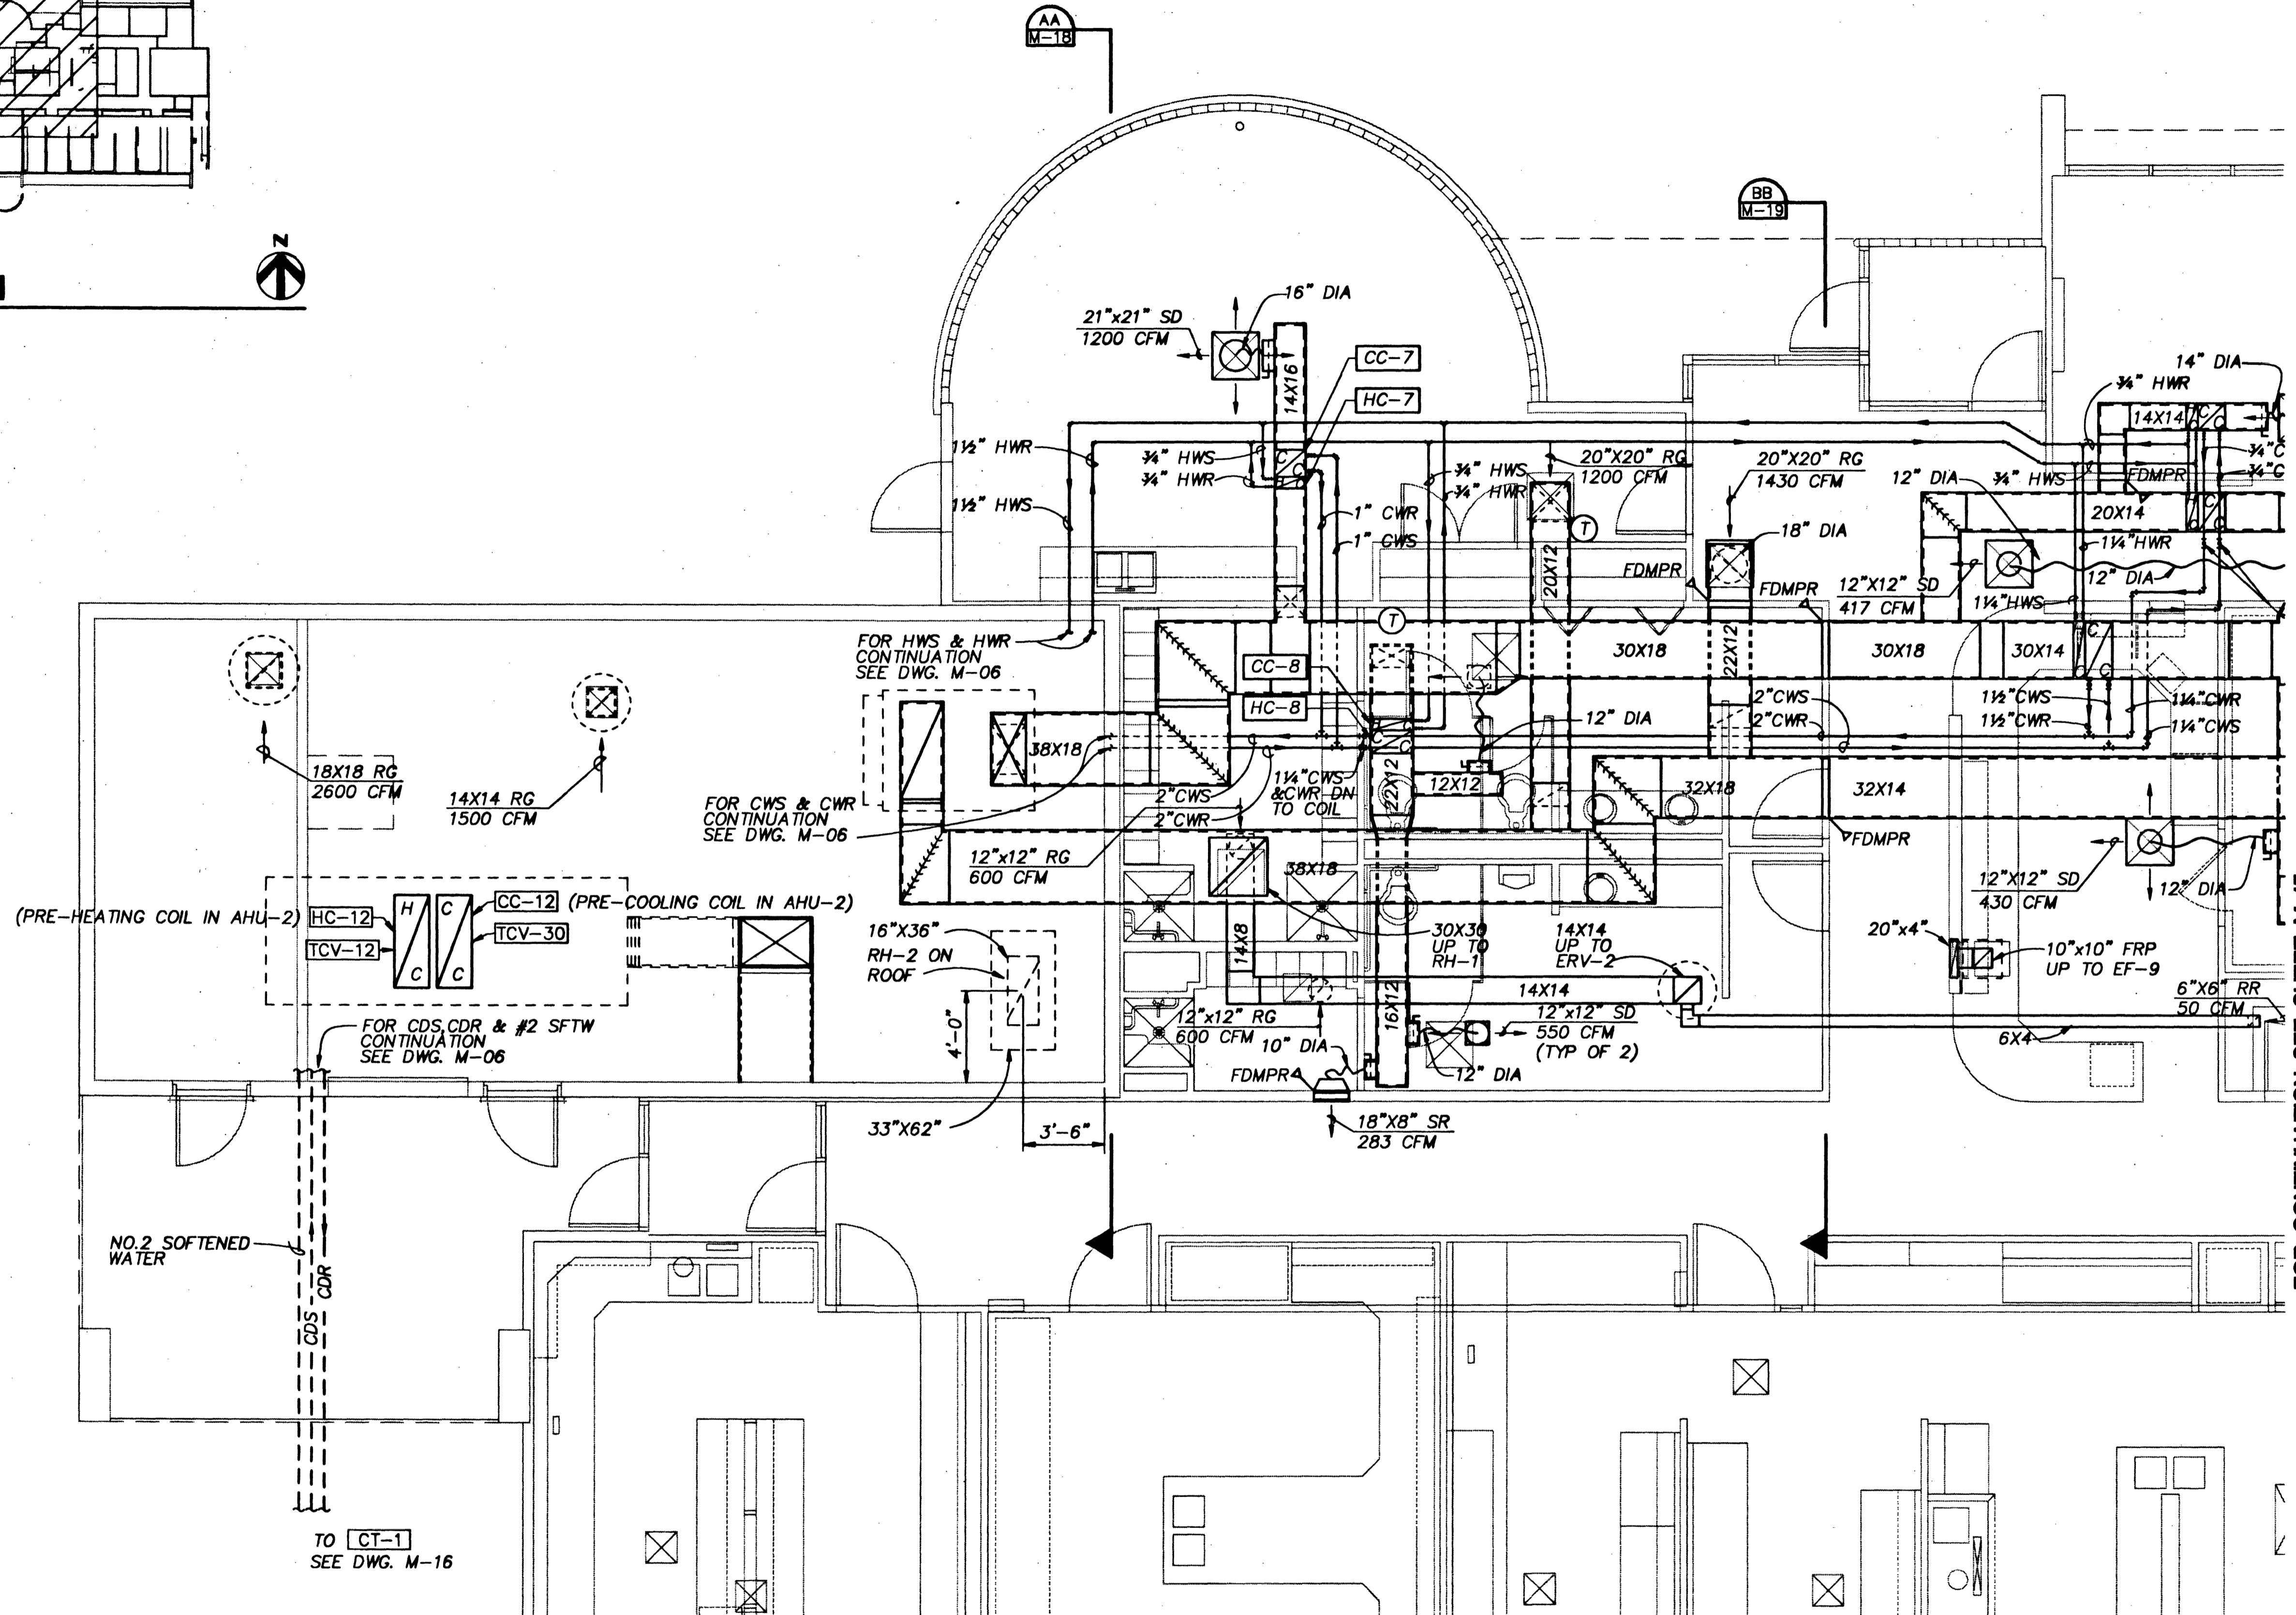

FOR CONTINUATION SEE SHEET M-15

FOR CONTINUATION SEE SHEET M-16

HVAC PLAN

1/4"=1'-0"



HDR Engineering, Inc.

Issue No.	Description	Date	Drawn	Checked	Responsible Eng.	Project Mgr.
7	ISSUED FOR CONSTRUCTION	11/27/91	MWB	MJH	PSC	DAP
1	ADDENDUM	6/19/91	BAD	MJH	GPC	DAP

Project Manager	DAVID A. PIVETTI
Architect	
City	Mechanical
Electrical	TK/PSC/HJG
Structural	
Drawn By	M. BOYLE

City of Las Vegas
**Water Pollution Control Facility
 Nitrification / Filtration Facilities**
 Contract 14
 LABORATORY

**LABORATORY
 PARTIAL HVAC PLAN**

Date	AUGUST 1991	Project No.	00120-081-141	Drawing No.	M-14	Issue	7
Scale	NOTED				3/1.45		

30699

96/

