

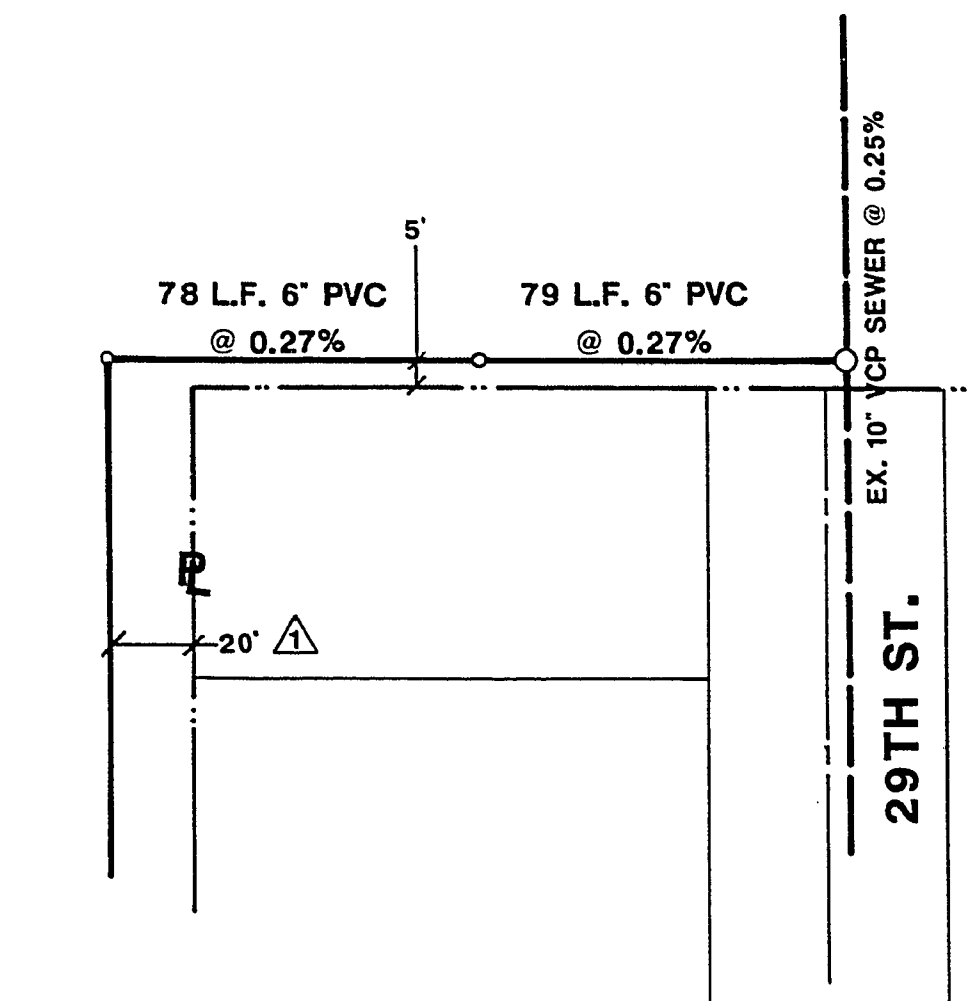
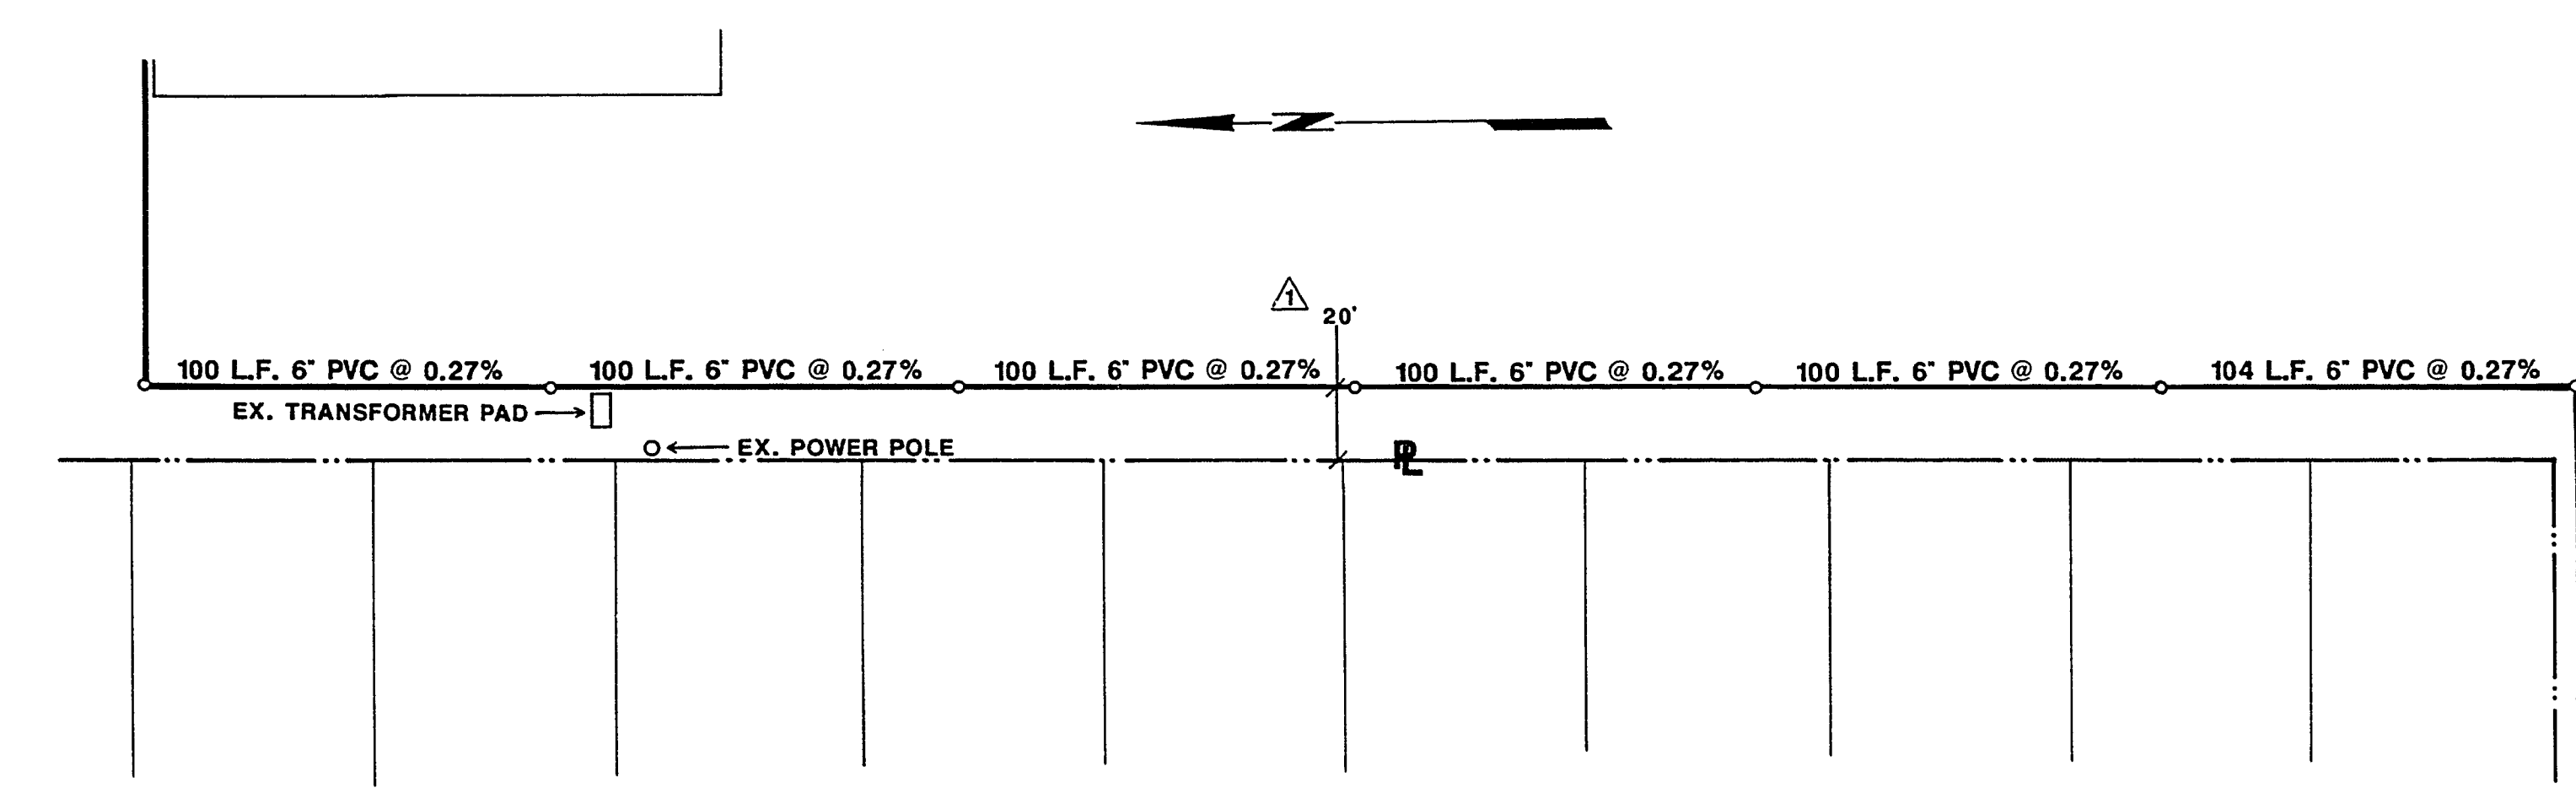


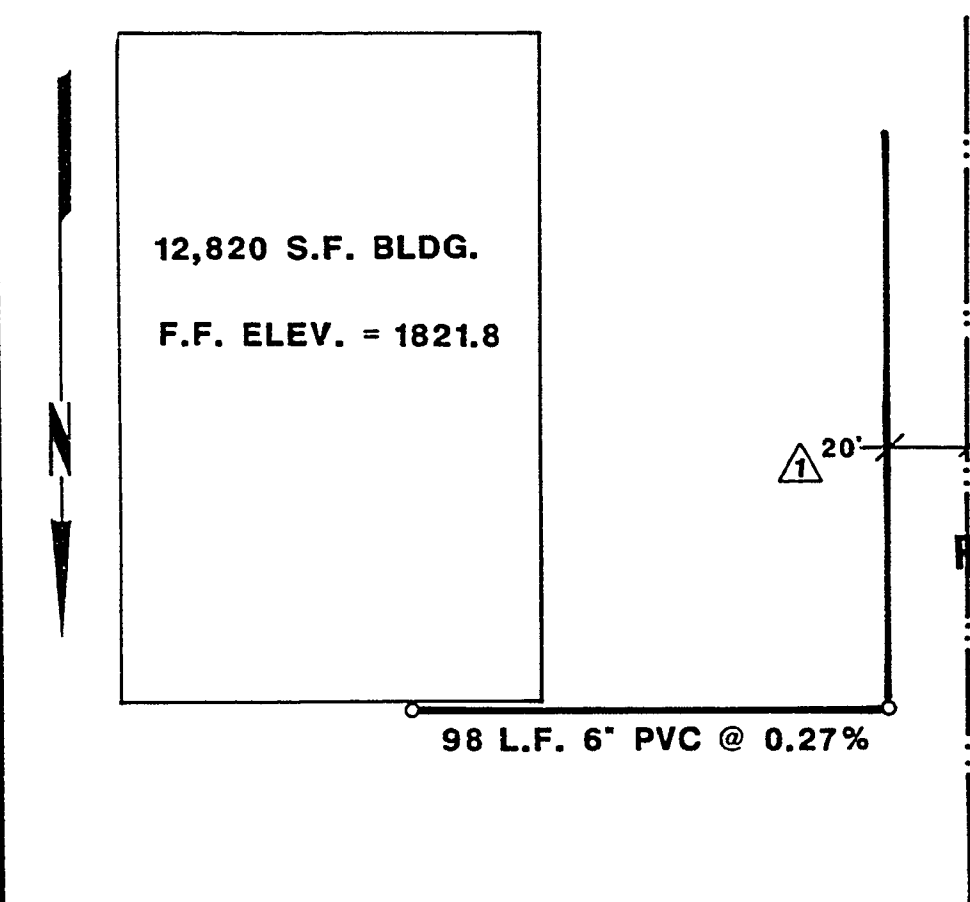

- STA. 0 + 00
EX. CLEAN-OUT
- STA. 1 + 00
CLEAN-OUT
- STA. 1 + 00
CLEAN-OUT
- STA. 2 + 00
CLEAN-OUT
- STA. 3 + 00
CLEAN-OUT
- STA. 4 + 00
CLEAN-OUT
- STA. 5 + 00
CLEAN-OUT
- STA. 6 + 00
CLEAN-OUT
- STA. 7 + 04
CLEAN-OUT
- STA. 7 + 04
CLEAN-OUT
- STA. 7 + 80
CLEAN-OUT
- STA. 8 + 59
NEW MANHOLE

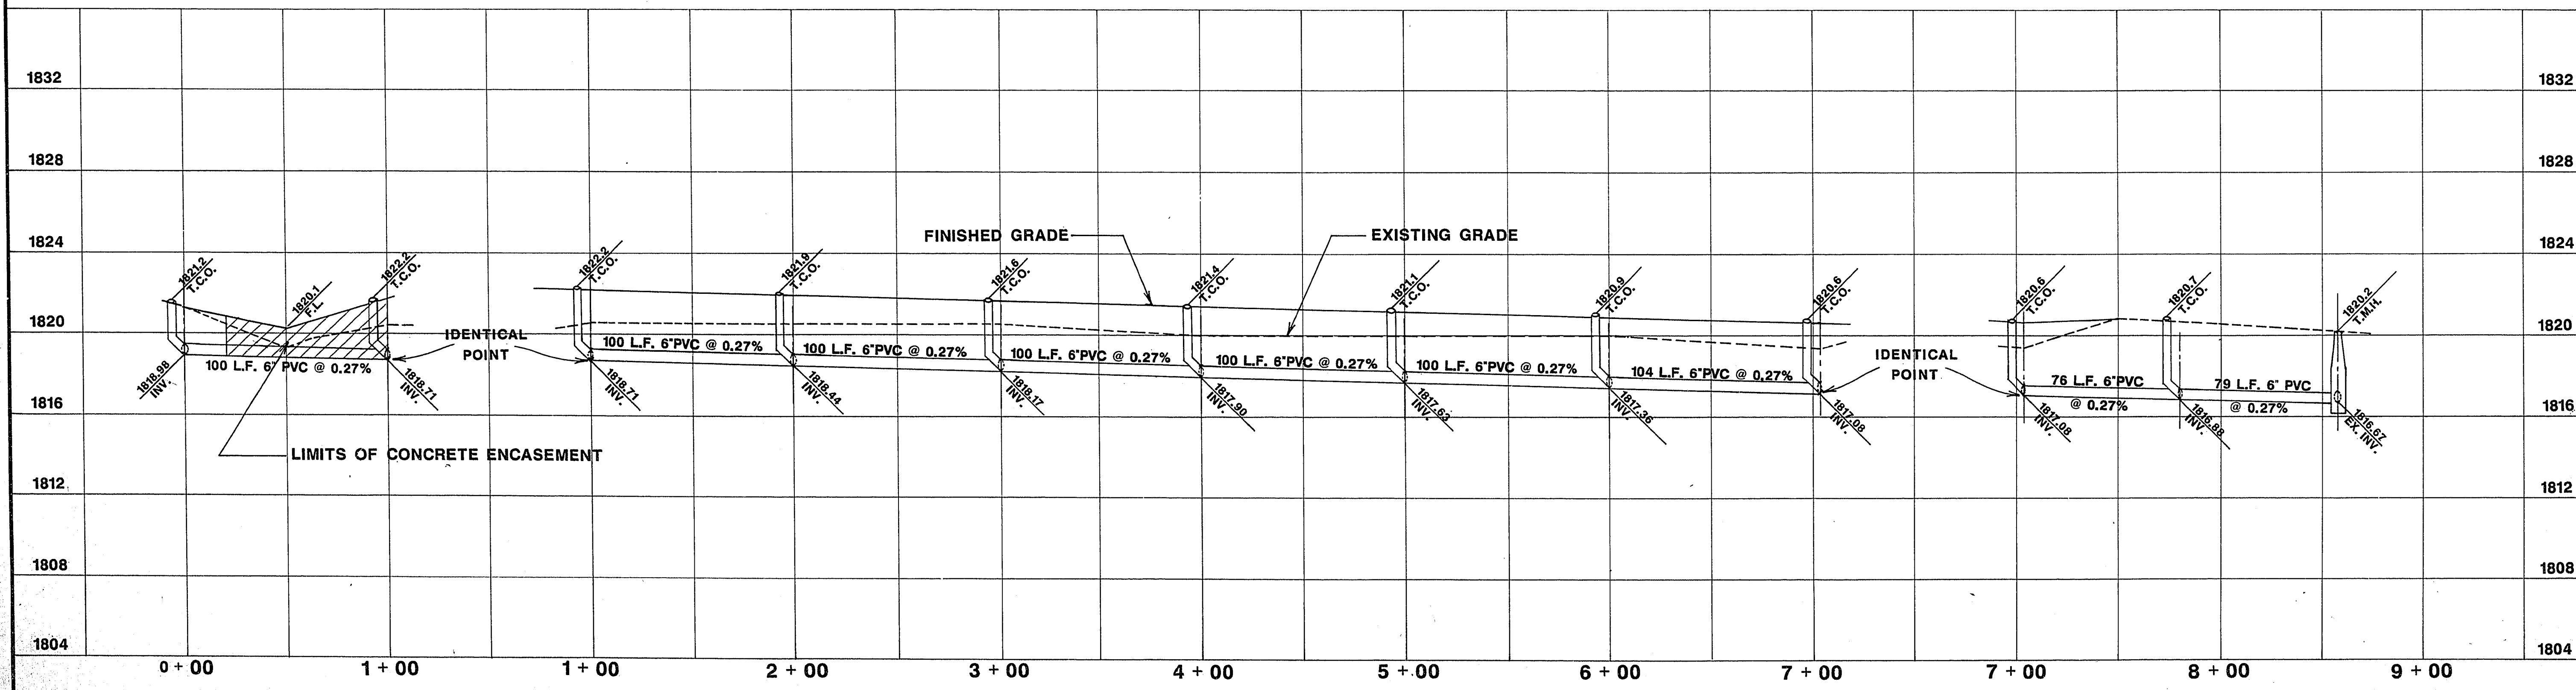

1-27-28
City Engineer
Date

Director of Public Works
Date

		Scale (H) 1" = 40'	Scale (V) 1" = 4'	W.A.	SEWER OFFSET	Date 2-12-98
		Fid. bk. no.	Date 1/88	Drawn by B. BROWN	Revisions	Date
Department of Public Works METRO TRAINING CENTER SEWER SERVICE WASHINGTON / MOJAVE		SEWER PLAN AND PROFILE				
		Drawing no. 640-V46E				

5-94