




1 HEX 16 SHELTER LIGHTING DETAIL
49 SCALE: 1/4"=1'-0"

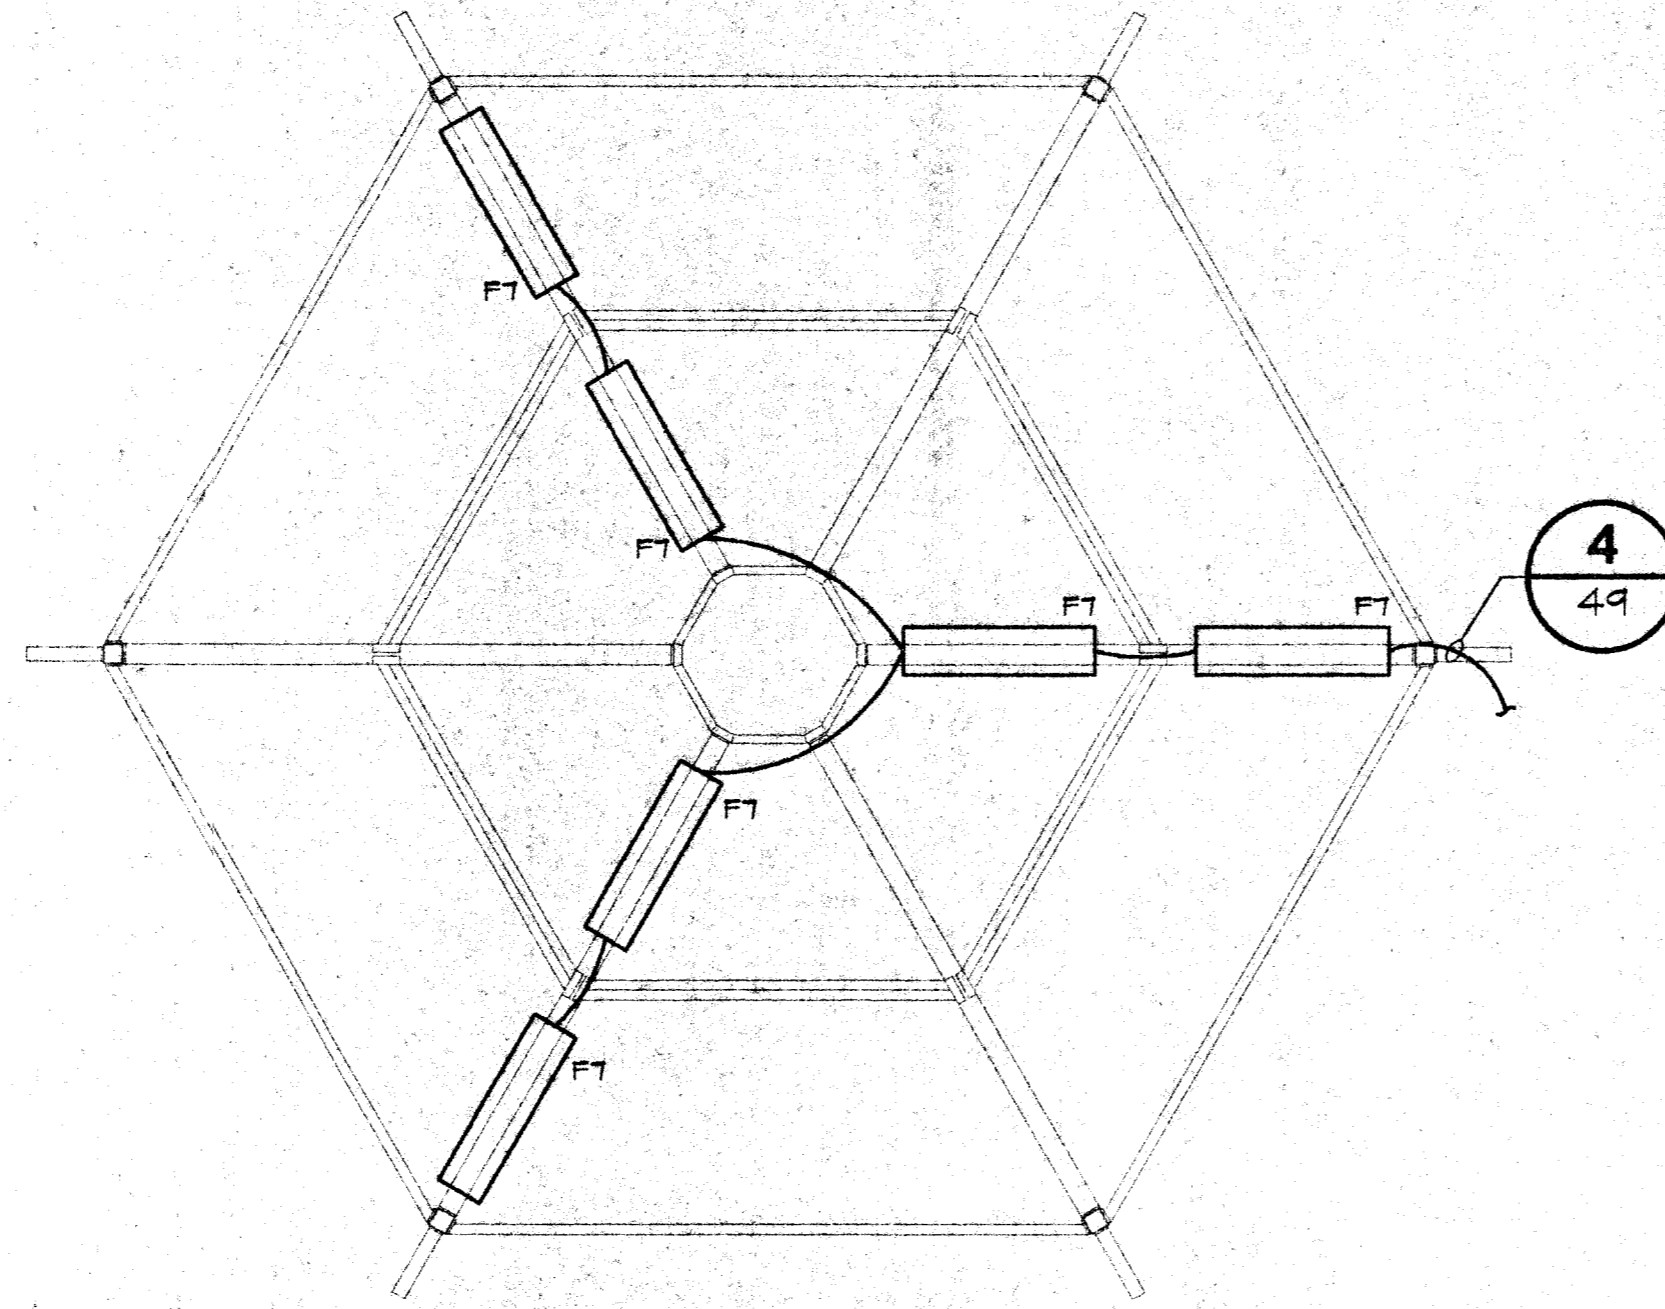

2 HEX 28 SHELTER LIGHTING DETAIL
49 SCALE: 1/4"=1'-0"

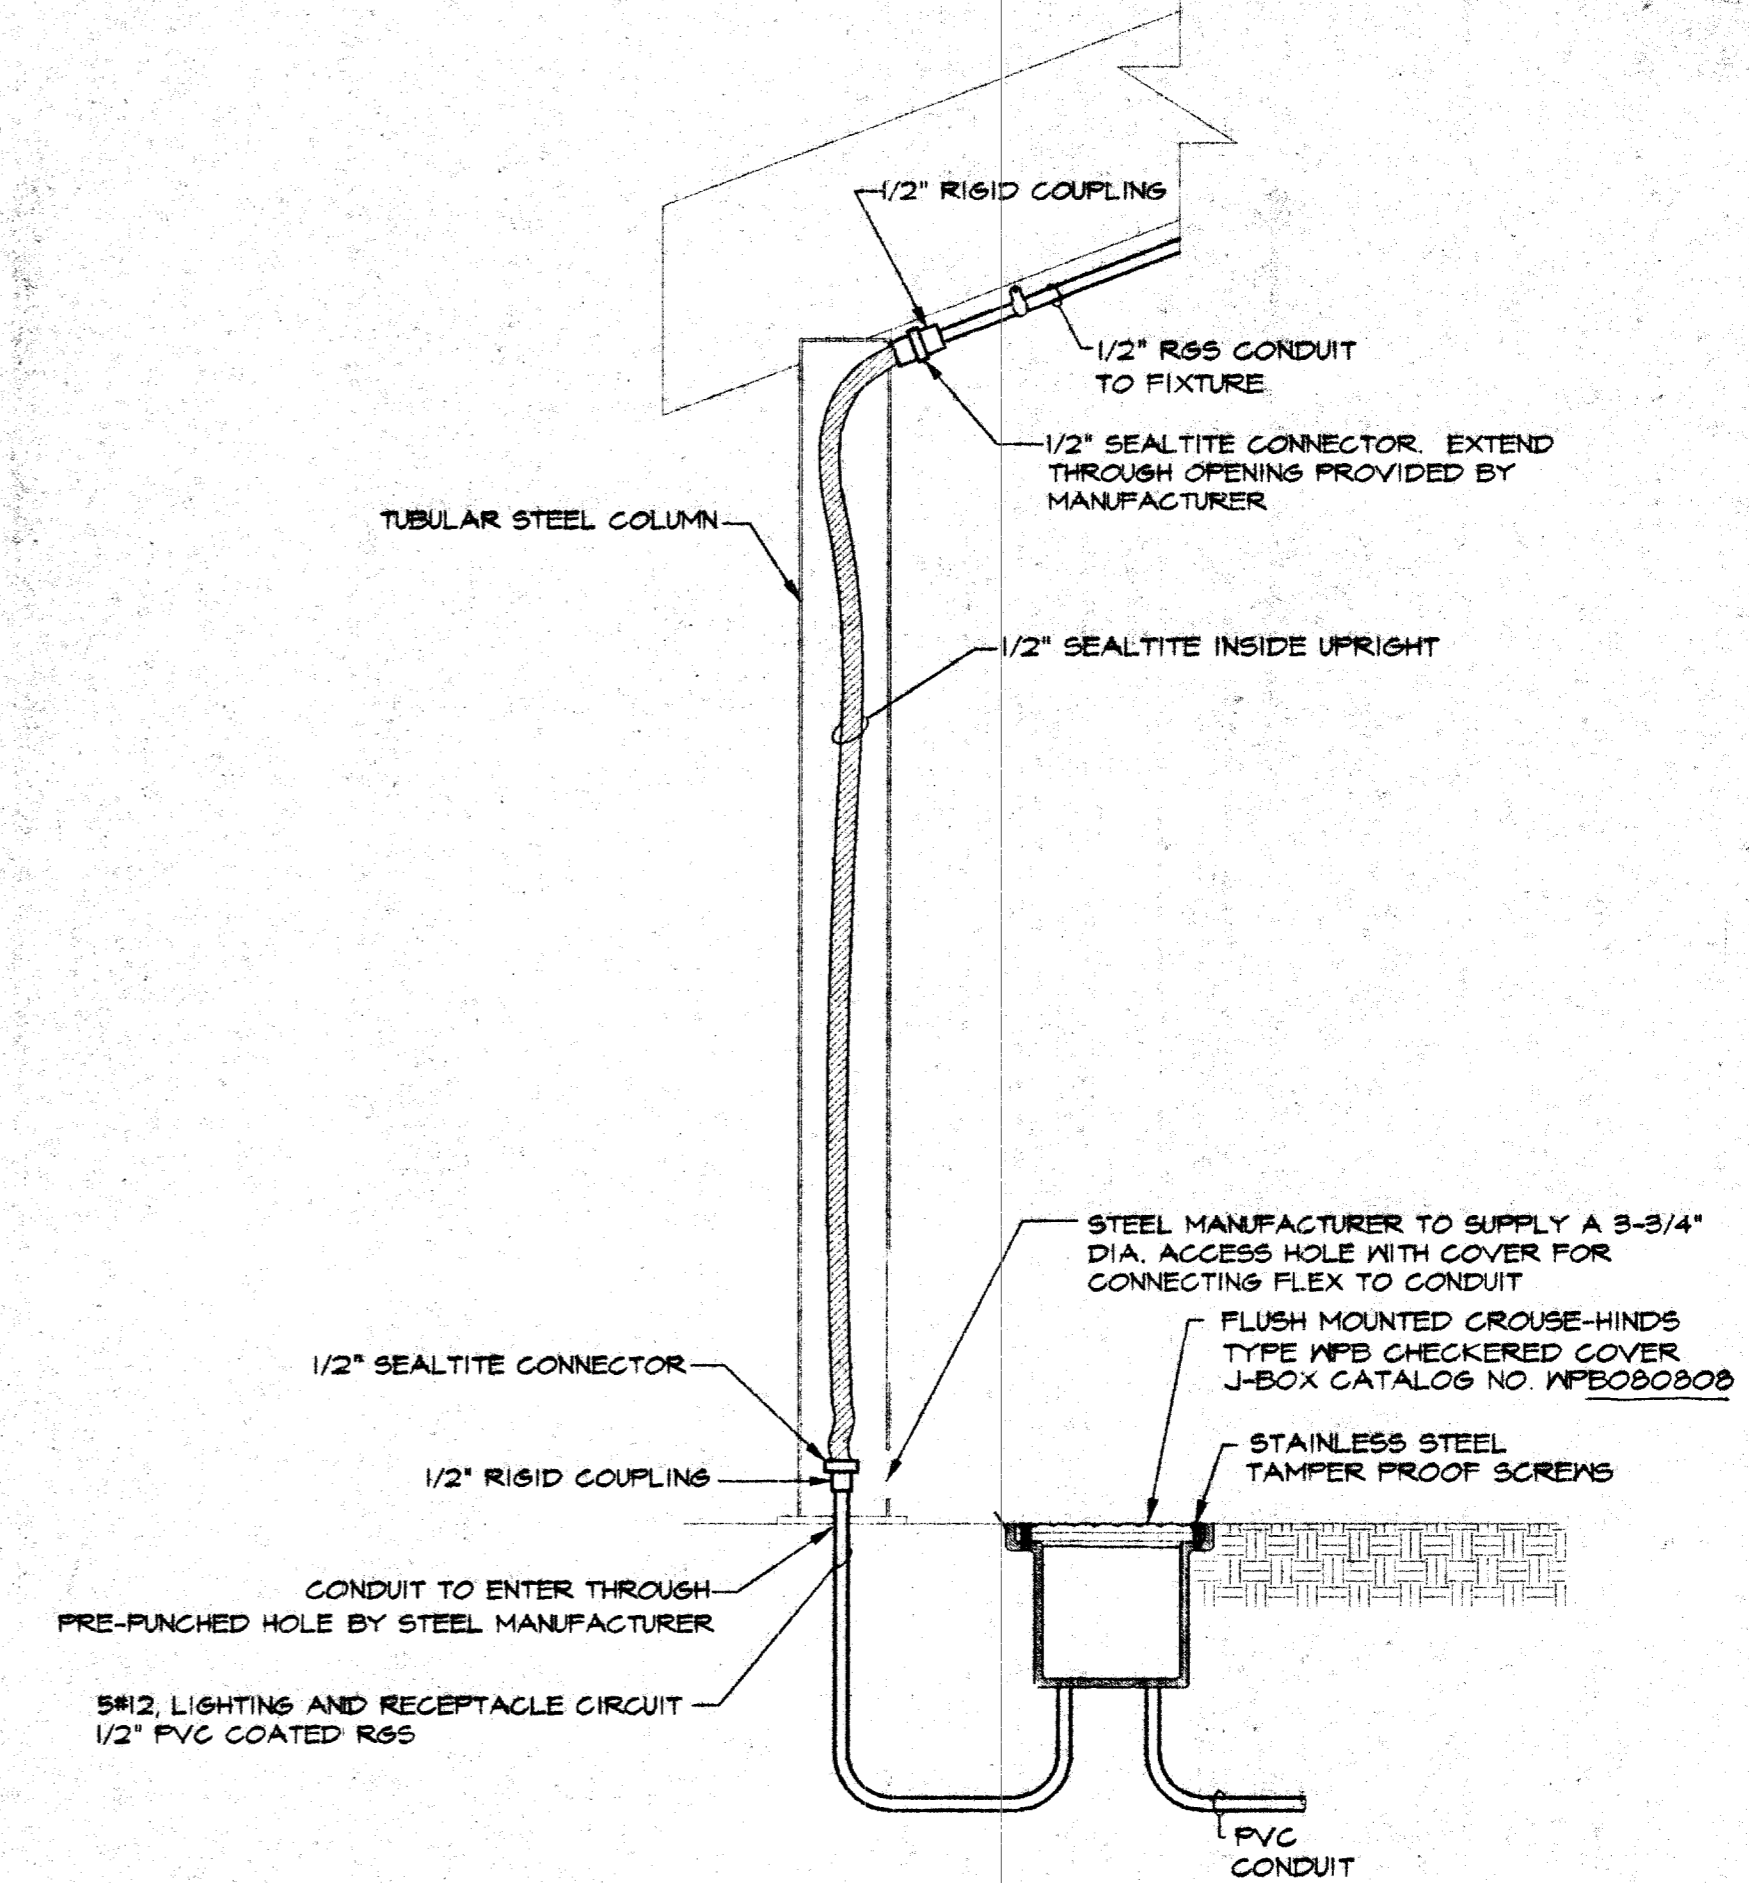


3 SHELTER CONDUIT MOUNTING DETAIL
49 NOT TO SCALE

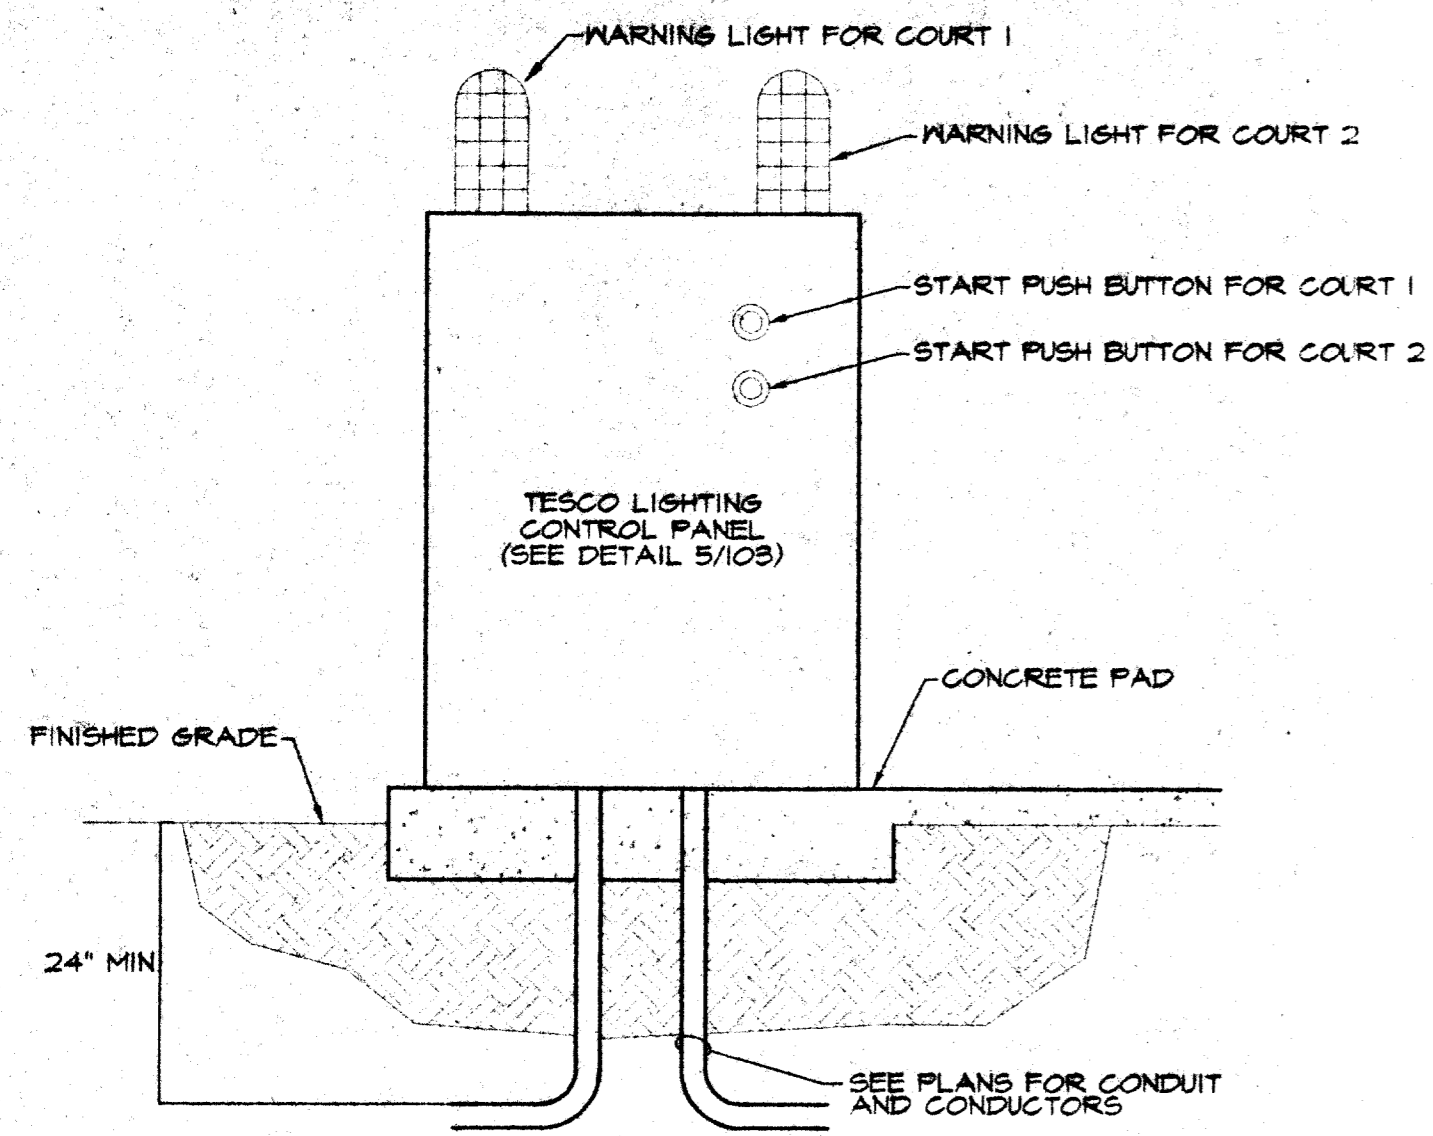


4 COURT LIGHTING CONTROL PANEL
49 NOT TO SCALE
(TENNIS, BASKETBALL, ROLLER HOCKEY, AND SKATE PARK)


- NOTE:**
- FACE PUSH BUTTON AWAY FROM COURT.
 - PROVIDE ONLY (1) BUTTON AND (1) WARNING LIGHT AT SINGLE USE COURTS.

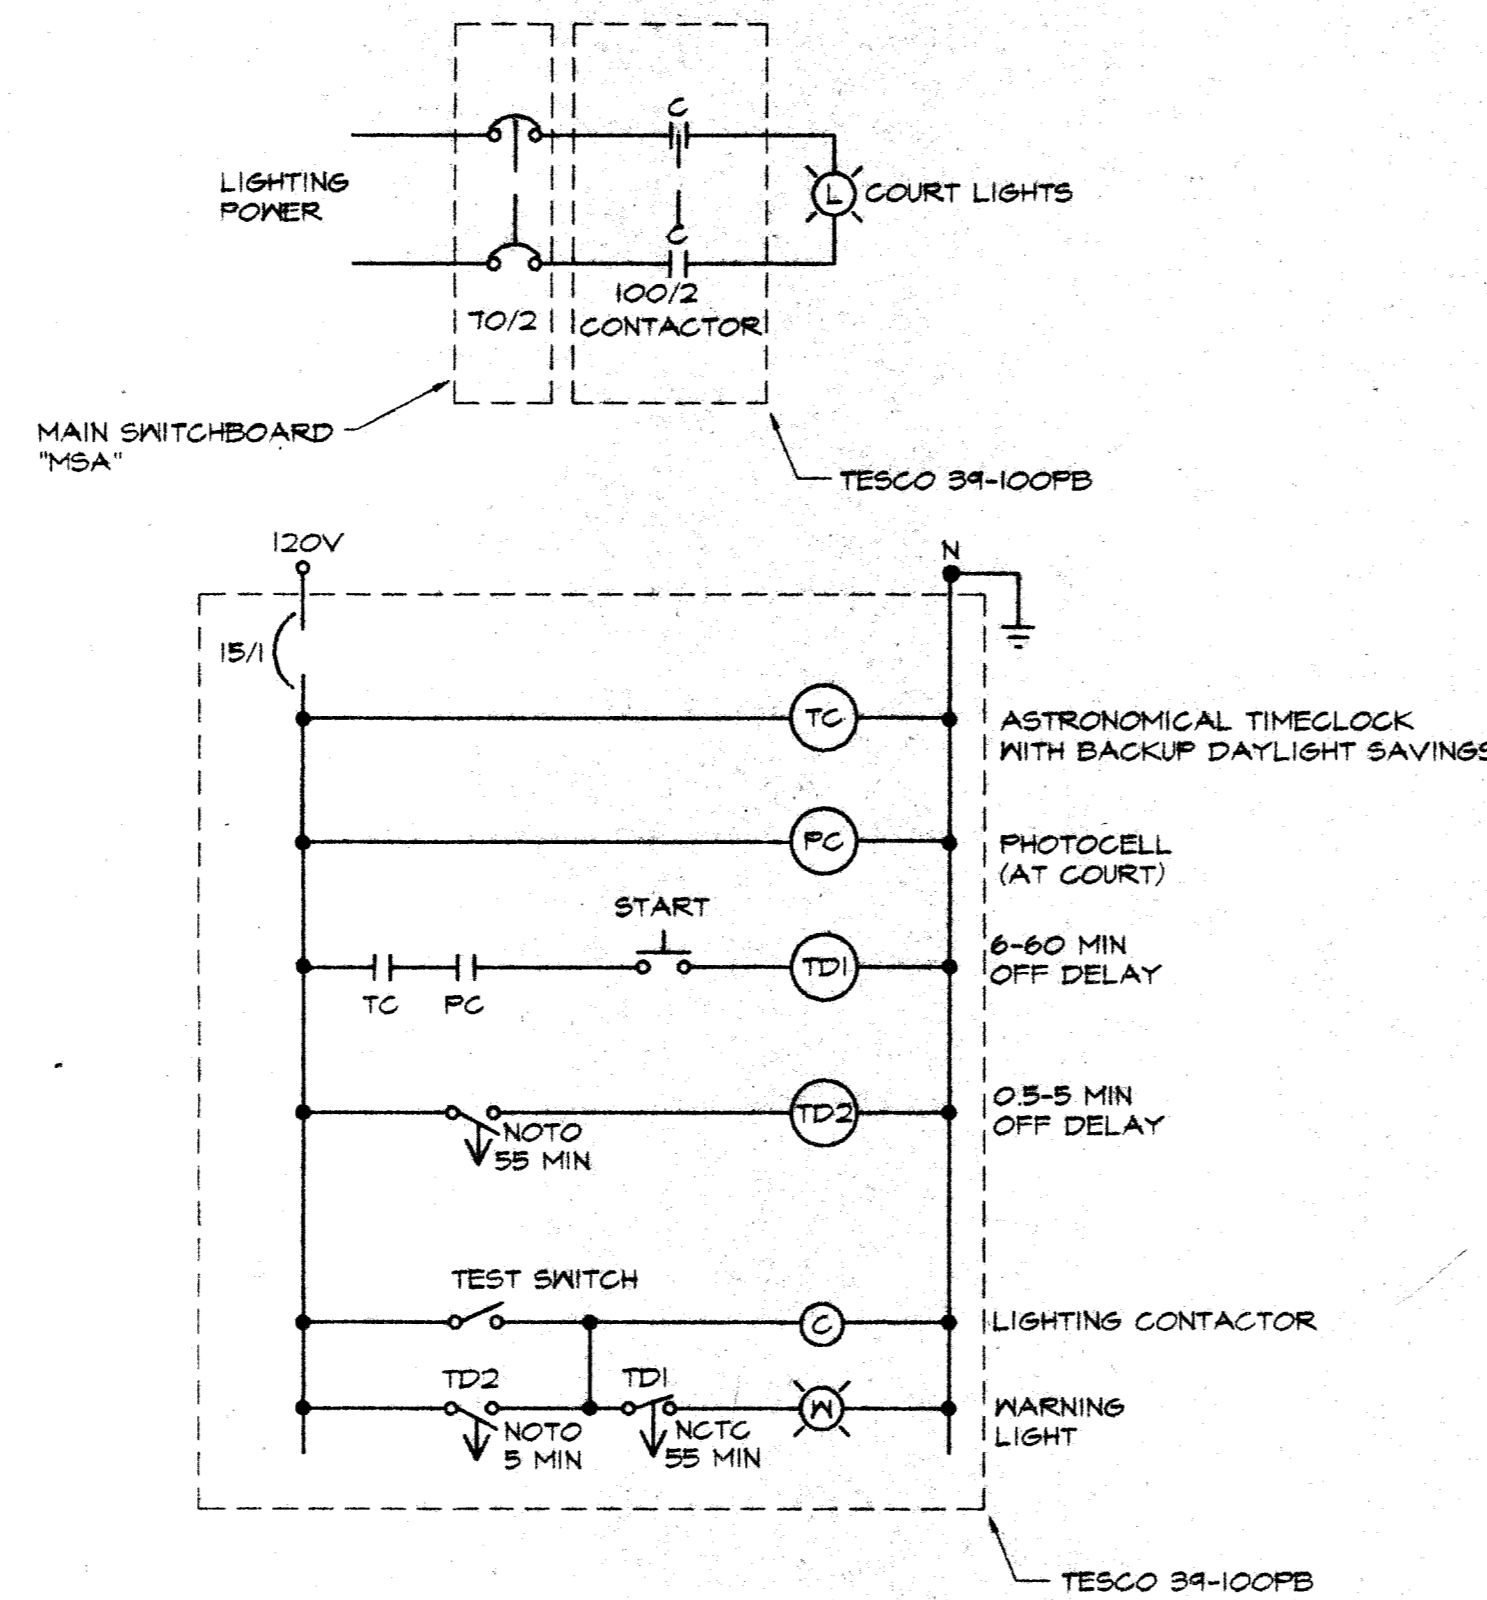

5 COURT LIGHTING CONTROL DIAGRAM
49 NOT TO SCALE

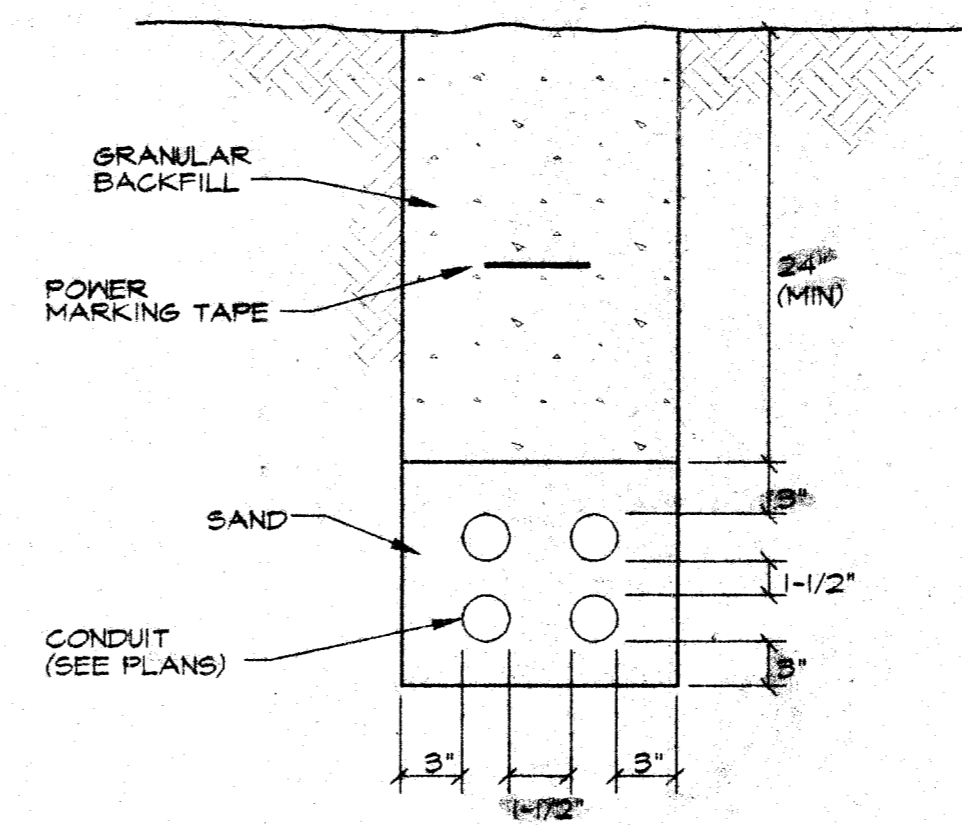


6 TRENCH DETAIL
49 NOT TO SCALE

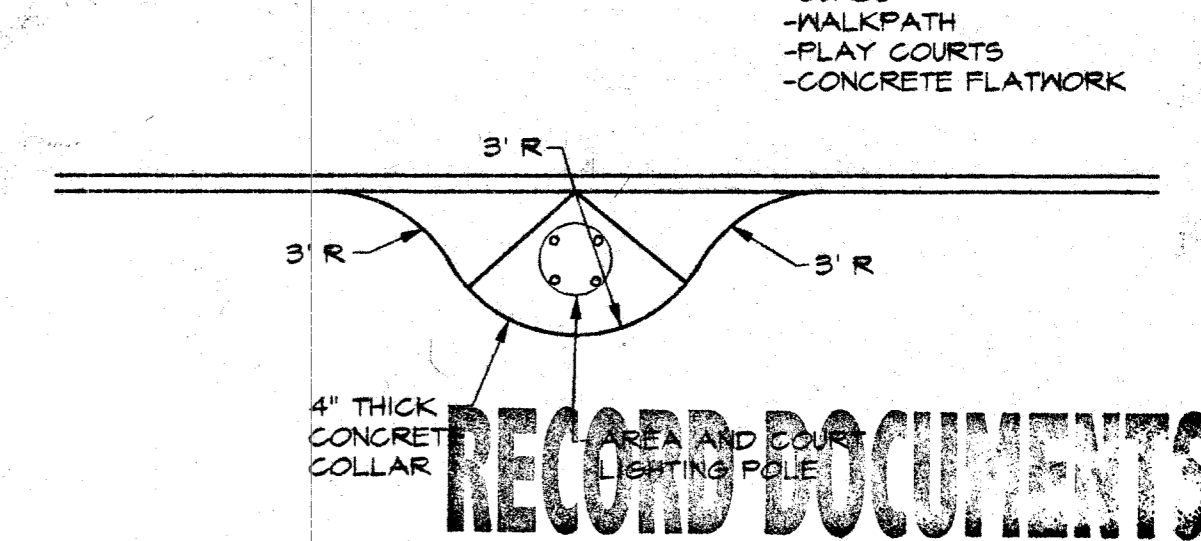


7 POLE FOUNDATION LOCATION
49 NOT TO SCALE

- NOTE:**
- WHERE FOUNDATION IS ADJACENT TO PAVING, CONNECT FOUNDATION EDGE WITH PAVING AS SHOWN, MATCH GRADE, ELEVATION AND FINISH. SEE CIVIL PLANS FOR LAYOUT.

67593

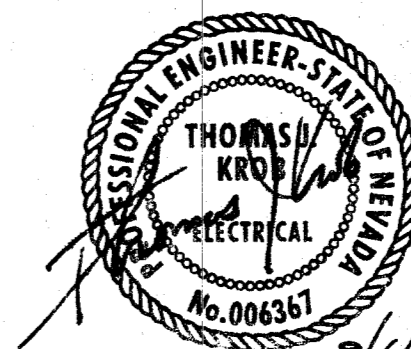

TJ KROB CONSULTING ENGINEERS, INC.
7151 CASCADE VALLEY COURT SUITE 200
LAS VEGAS, NEVADA 89128
(702) 871-3621
ELECTRICAL ENGINEERING

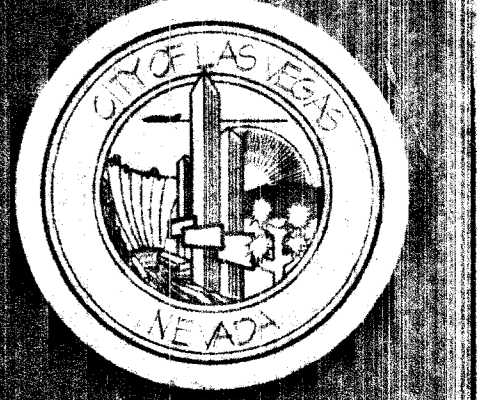

PBSJ
Sgt. N. Owen Valley Rev. Jr.
Professional Engineer, Nevada License No. 8094
Professional Surveyor, Nevada License No. 2775
Fax: (702) 263-1200
**ENGINEERING - PLANNING - SURVEYING
CONSTRUCTION SERVICES**

DEPARTMENT OF PUBLIC WORKS
CITY OF LAS VEGAS
METRO PARK
3250 ACADEMY WAY
LAS VEGAS, NEVADA 89129
ELECTRICAL SITE DETAILS

PLANS APPROVED
ELECTRICAL
Building & Safety Dept.
City of Las Vegas, Nevada
EDS SEP 13 2000
Does Not Include Structural, Architectural,
Plumbing/Mechanical or Civil Site
Improvements Made to Contract
Without Approval Plan is
Not a Permit to Violate Any Ordinance
-COURT
-WALKPATH
-PLAY COURTS
-CONCRETE PLATWORK

DEPARTMENT OF PUBLIC WORKS
ARCHITECTURAL SERVICES
400 EAST STEWART AVENUE
LAS VEGAS, NEVADA 89101
PHONE: (702) 229-6533
FAX: (702) 382-3232
TDD: (702) 316-9108

PROJECT MANAGER
CLAIR M. LEWIS, ASLA
DRAWN
JDI
FILE 00016/DETAILS
DATE 9-1-00
SCALE VARIES
PROJECT METRO PARK
SHEET NO. 49
22 OF 64