
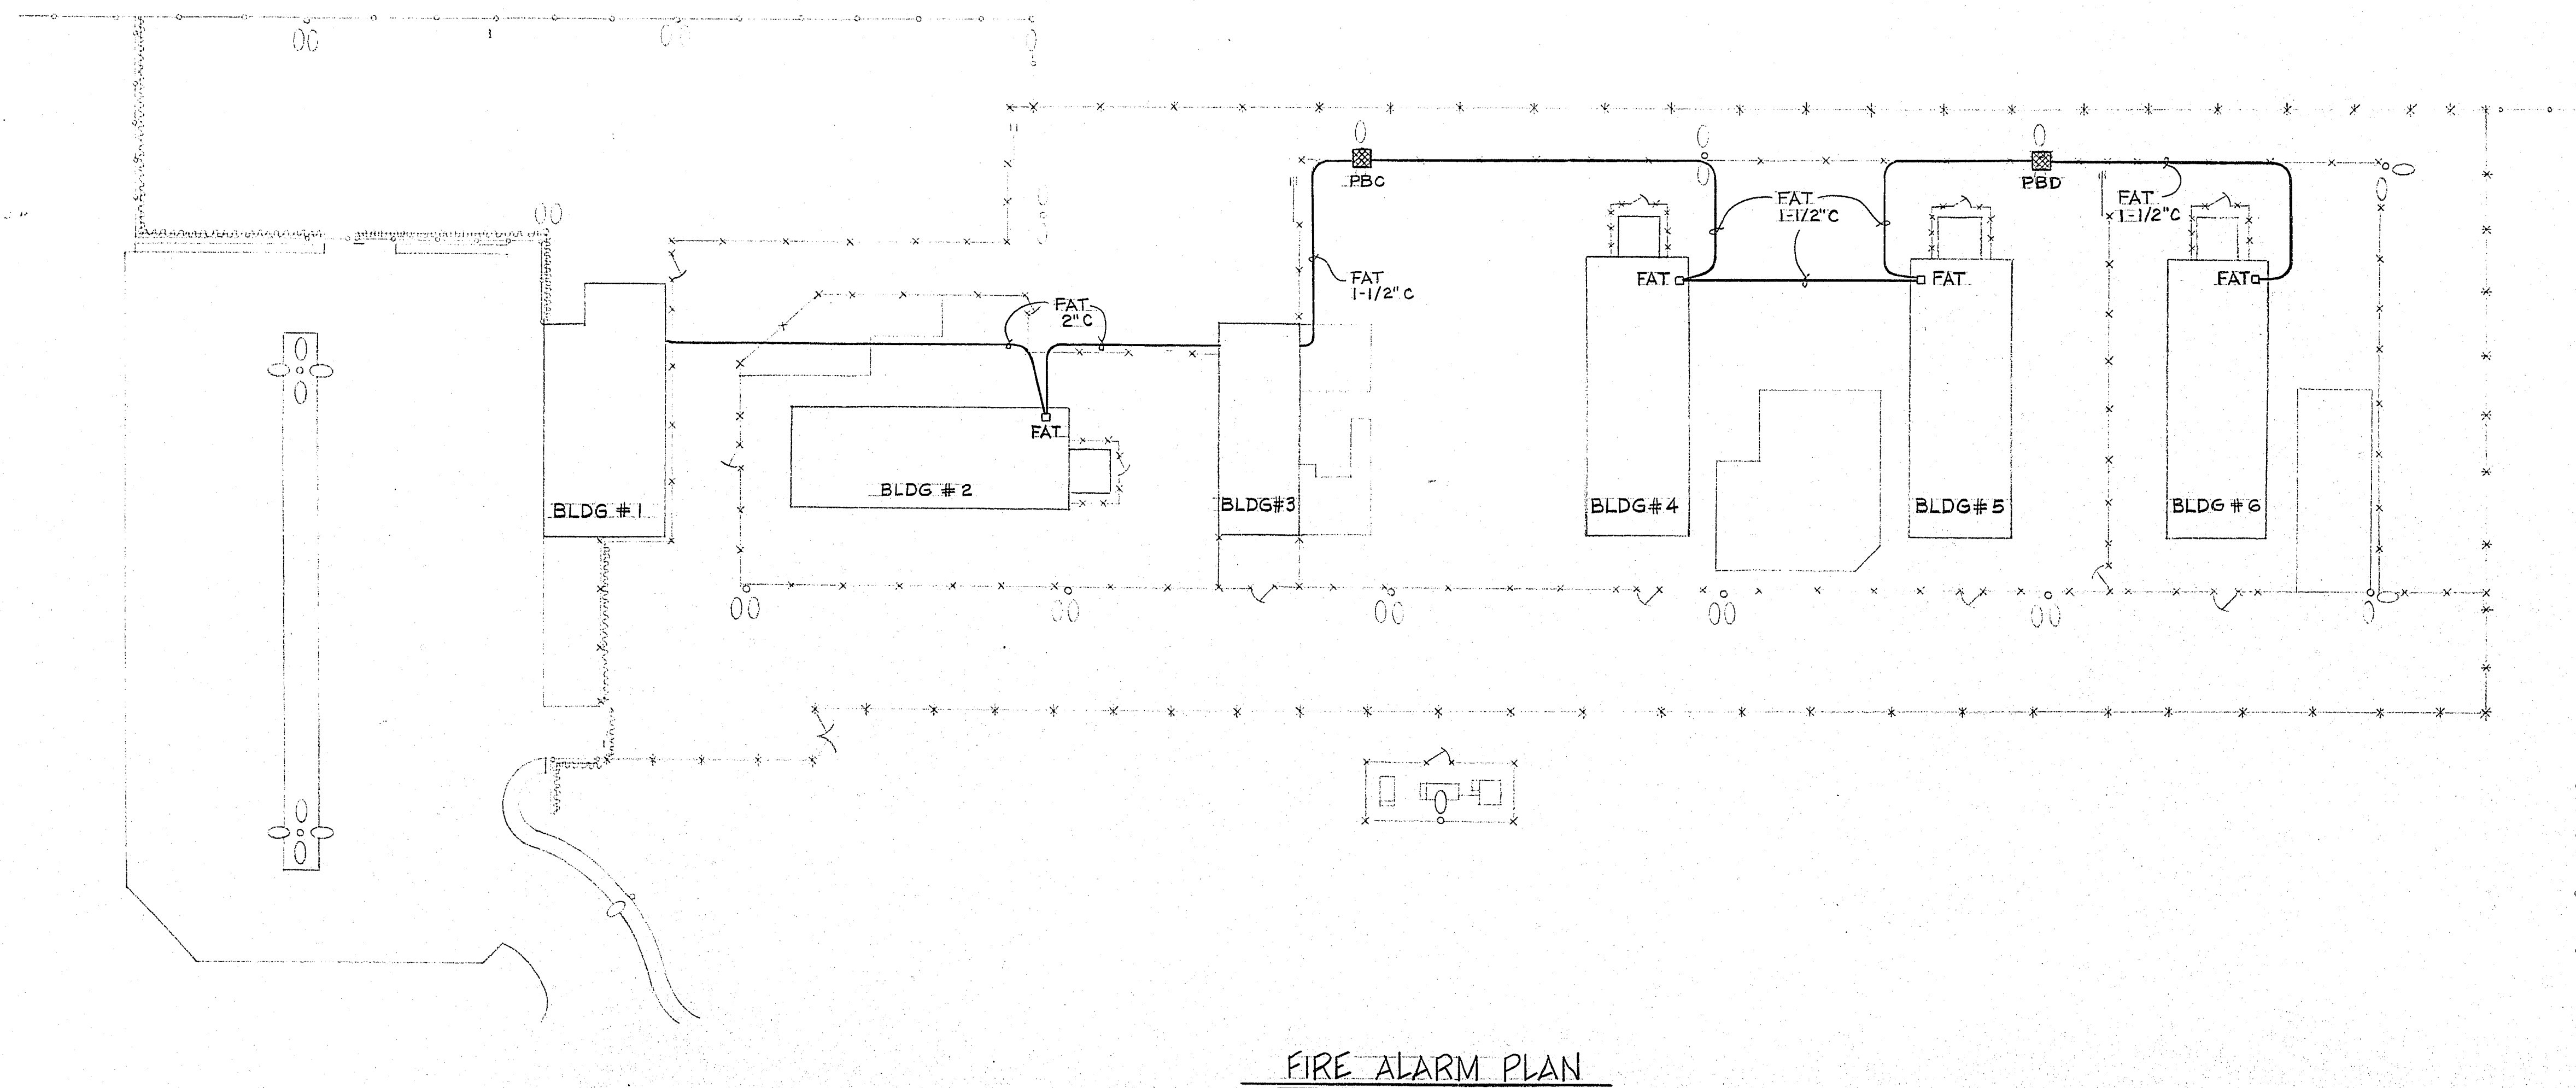


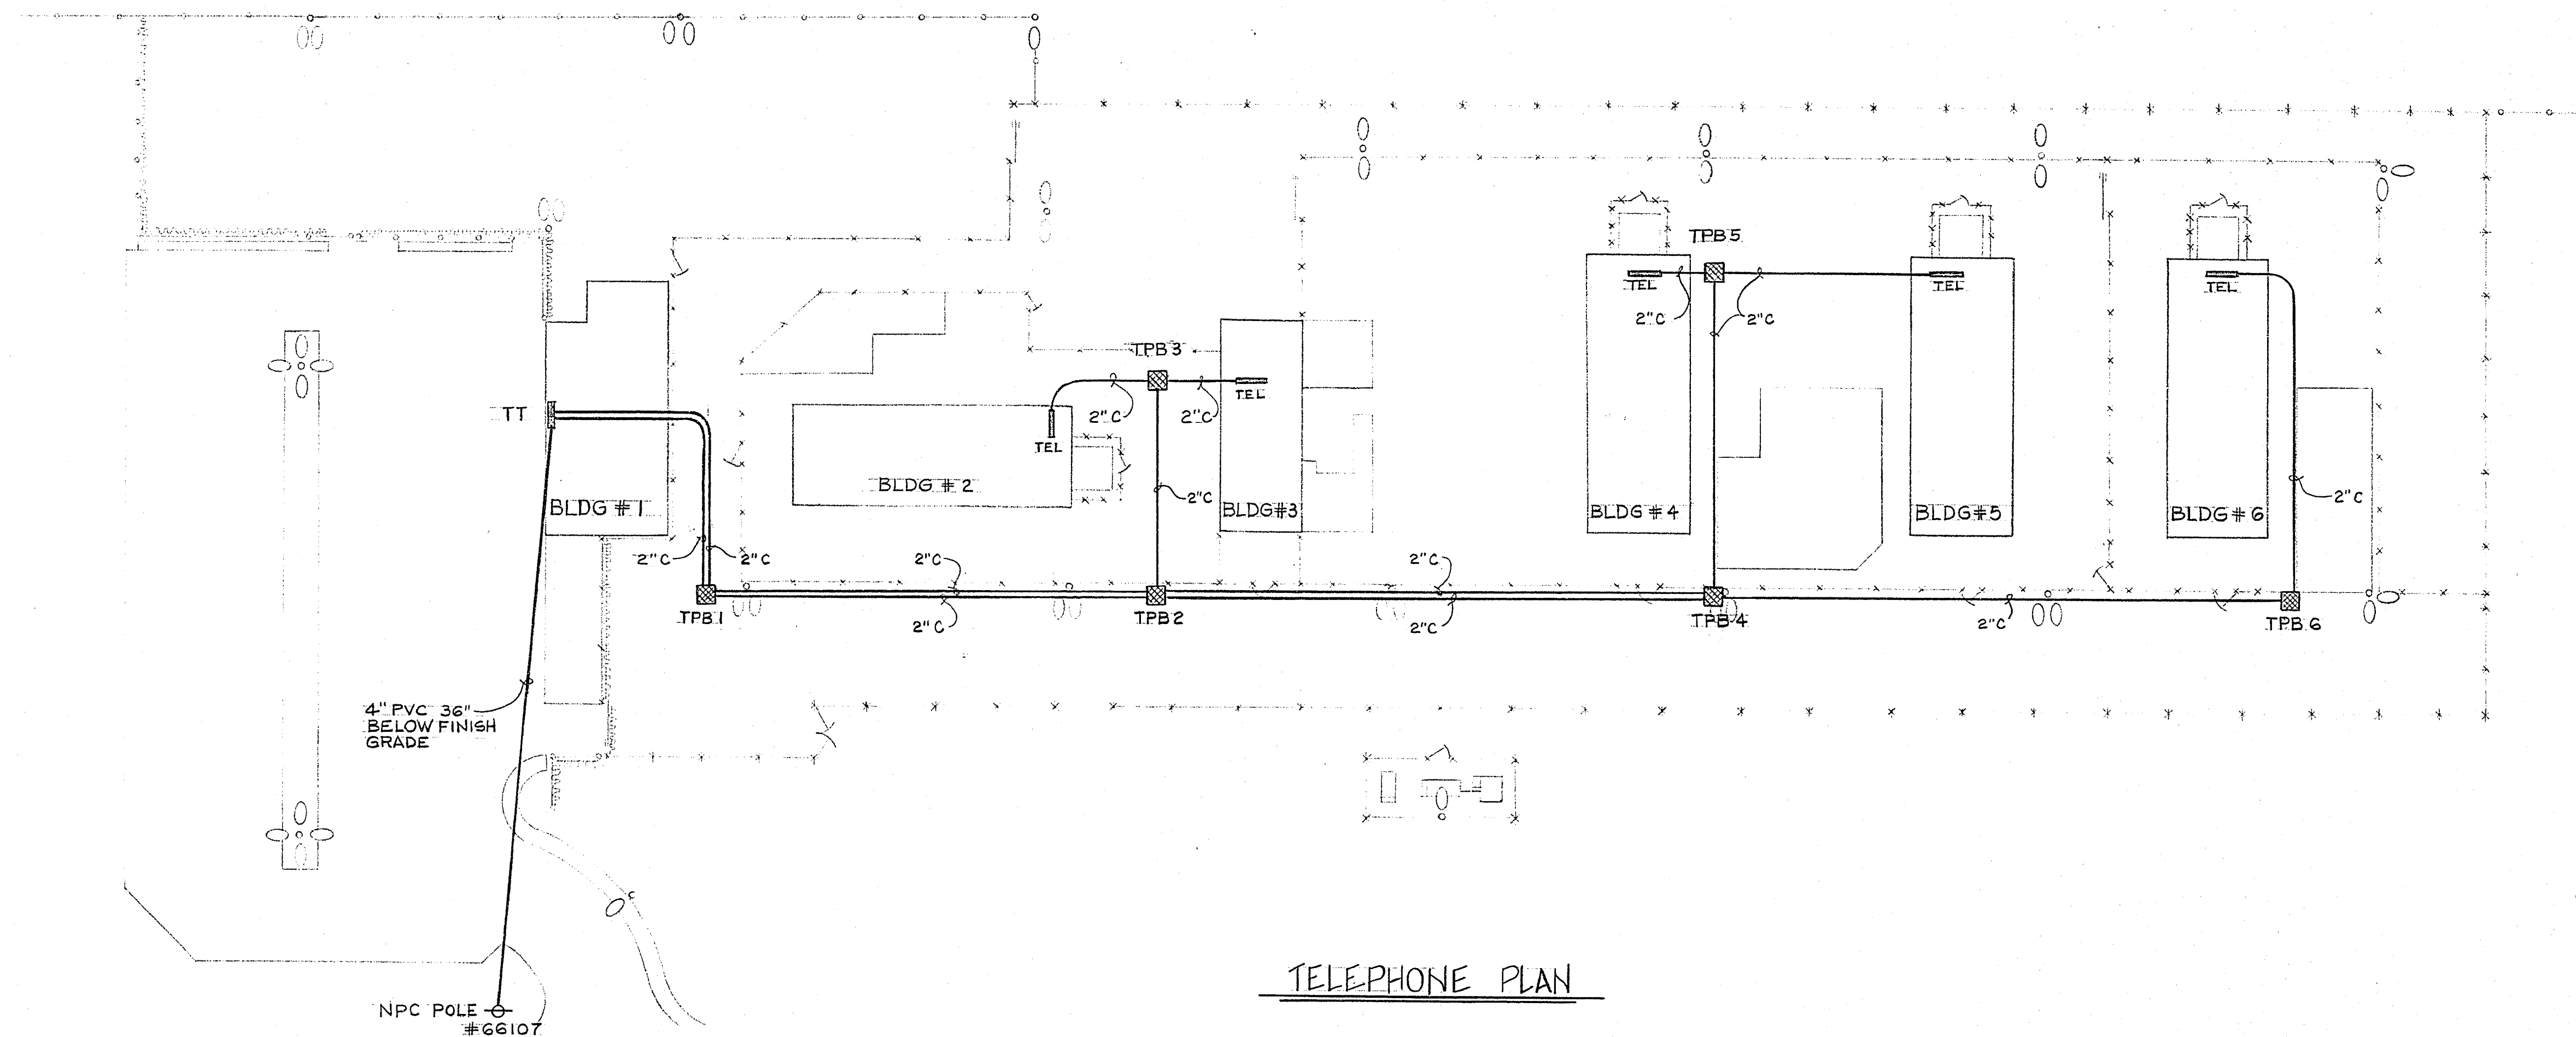

Drawing no.
513-55-0

Department of Public Services
MISDEMEANANT DETENTION FACILITY

Engineering Design Division
AS BUILT SITE TELEPHONE AND FIRE ALARM PLAN

Scale (h) 1" = 30'
Fid. bk. no.
Design by M. GOODMAN
INFORMATION SUPPLIED BY:
DESERT CONST.
USC ELECT.

Scale (v) W.
Date DEC. 1992
Drawn by NORMA GOMEZ

Revisions	Date

9/1