




BAR LENGTH ON ORIGINAL
DRAWING EQUALS ONE INCH

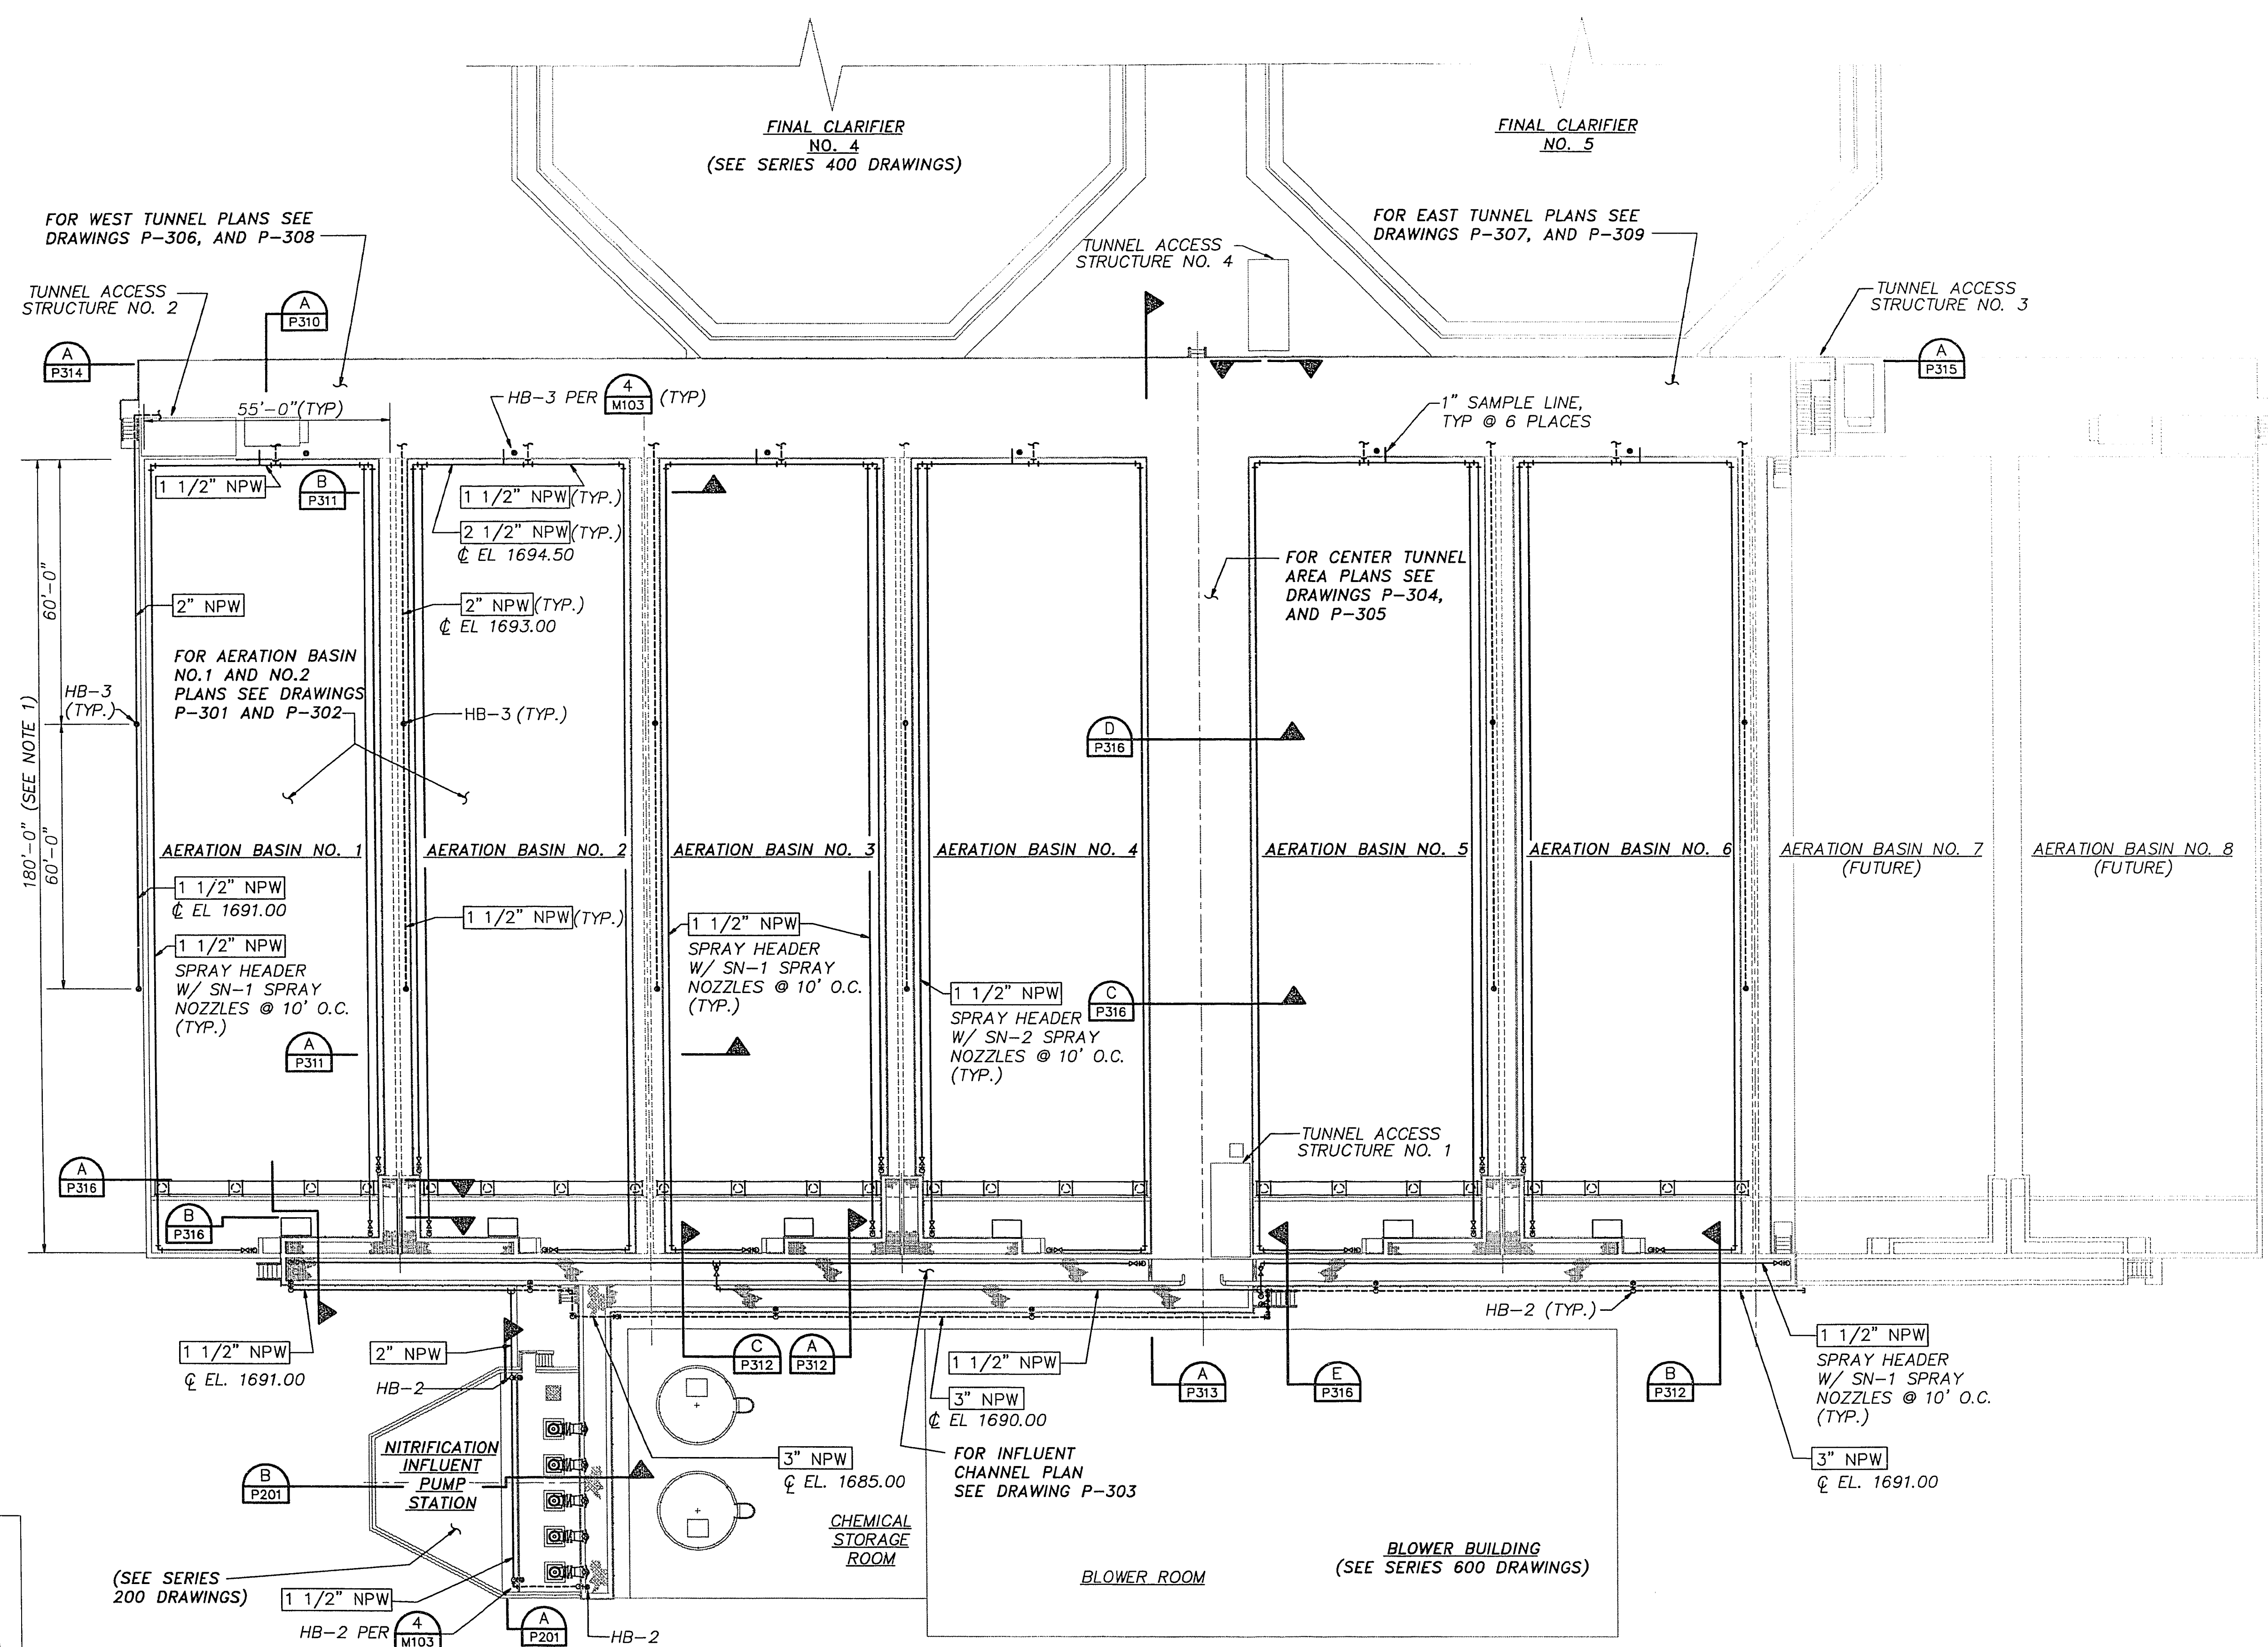

NOTE:
1. DIMENSIONS SHOWN AT INSIDE
TOP OF STRUCTURE WALLS (TYP.)

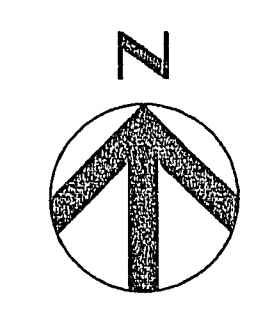

PLAN
SCALE: 1" = 20'-0"

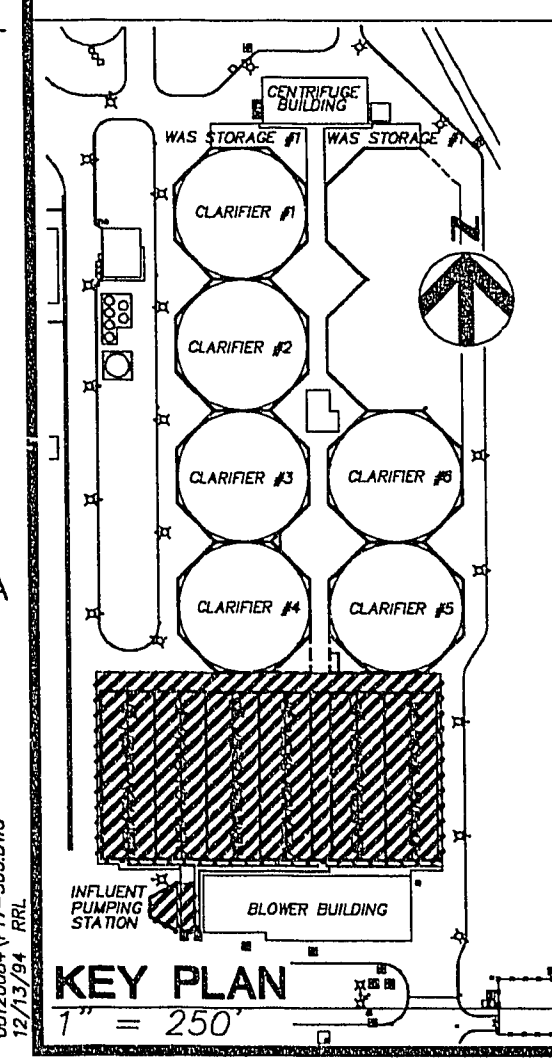

HDR Engineering, Inc.

1	CORRECTED ACCORDING TO CONSTRUCTION RECORD	1/95	RRL	EFH	MJH	JJC
A	ISSUED FOR BID	4/20/92	PHS	GWJ	JJC	
Issue No.	Description	Date	Drawn	Checked	Prepared	Project Mgr.

Project Manager	JOHN J. CHUEH
Architect	R. ATTANASIO
Civil	
Mechanical	
Electrical	
Structural	
Drawn By	P. SAUNDERS

City of Las Vegas
**Water Pollution Control Facility
Nitrification / Filtration Facilities**
Contract 17
NITRIFICATION COMPLEX

**AERATION BASINS
BASE AND PLUMBING PLAN**

Date	APRIL 1992	Project No.	00120-084-141	Drawing No.	P-300	Issue	1
Scale	1" = 20'-0"						