



DRAWING BY: COLUMBIA RIVER CADD 07-007 3535 SE 52ND AVE PORTLAND, OR 97206 503-777-6949
437 W. IMPERIAL HIGHWAY SUITE H-425 BREX, CA 92611 714-357-1283


126636

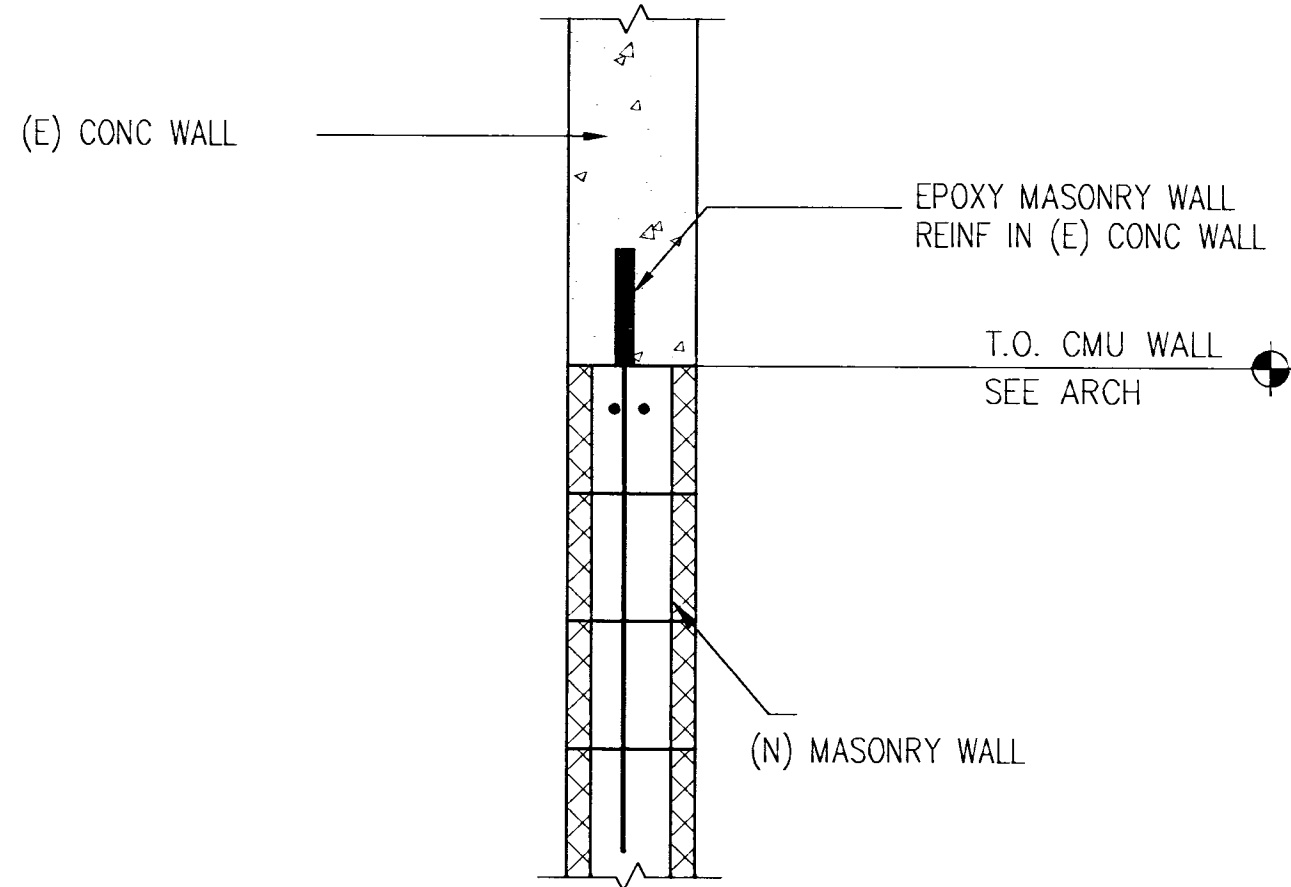


9 WALL DETAIL
1"=1'-0"

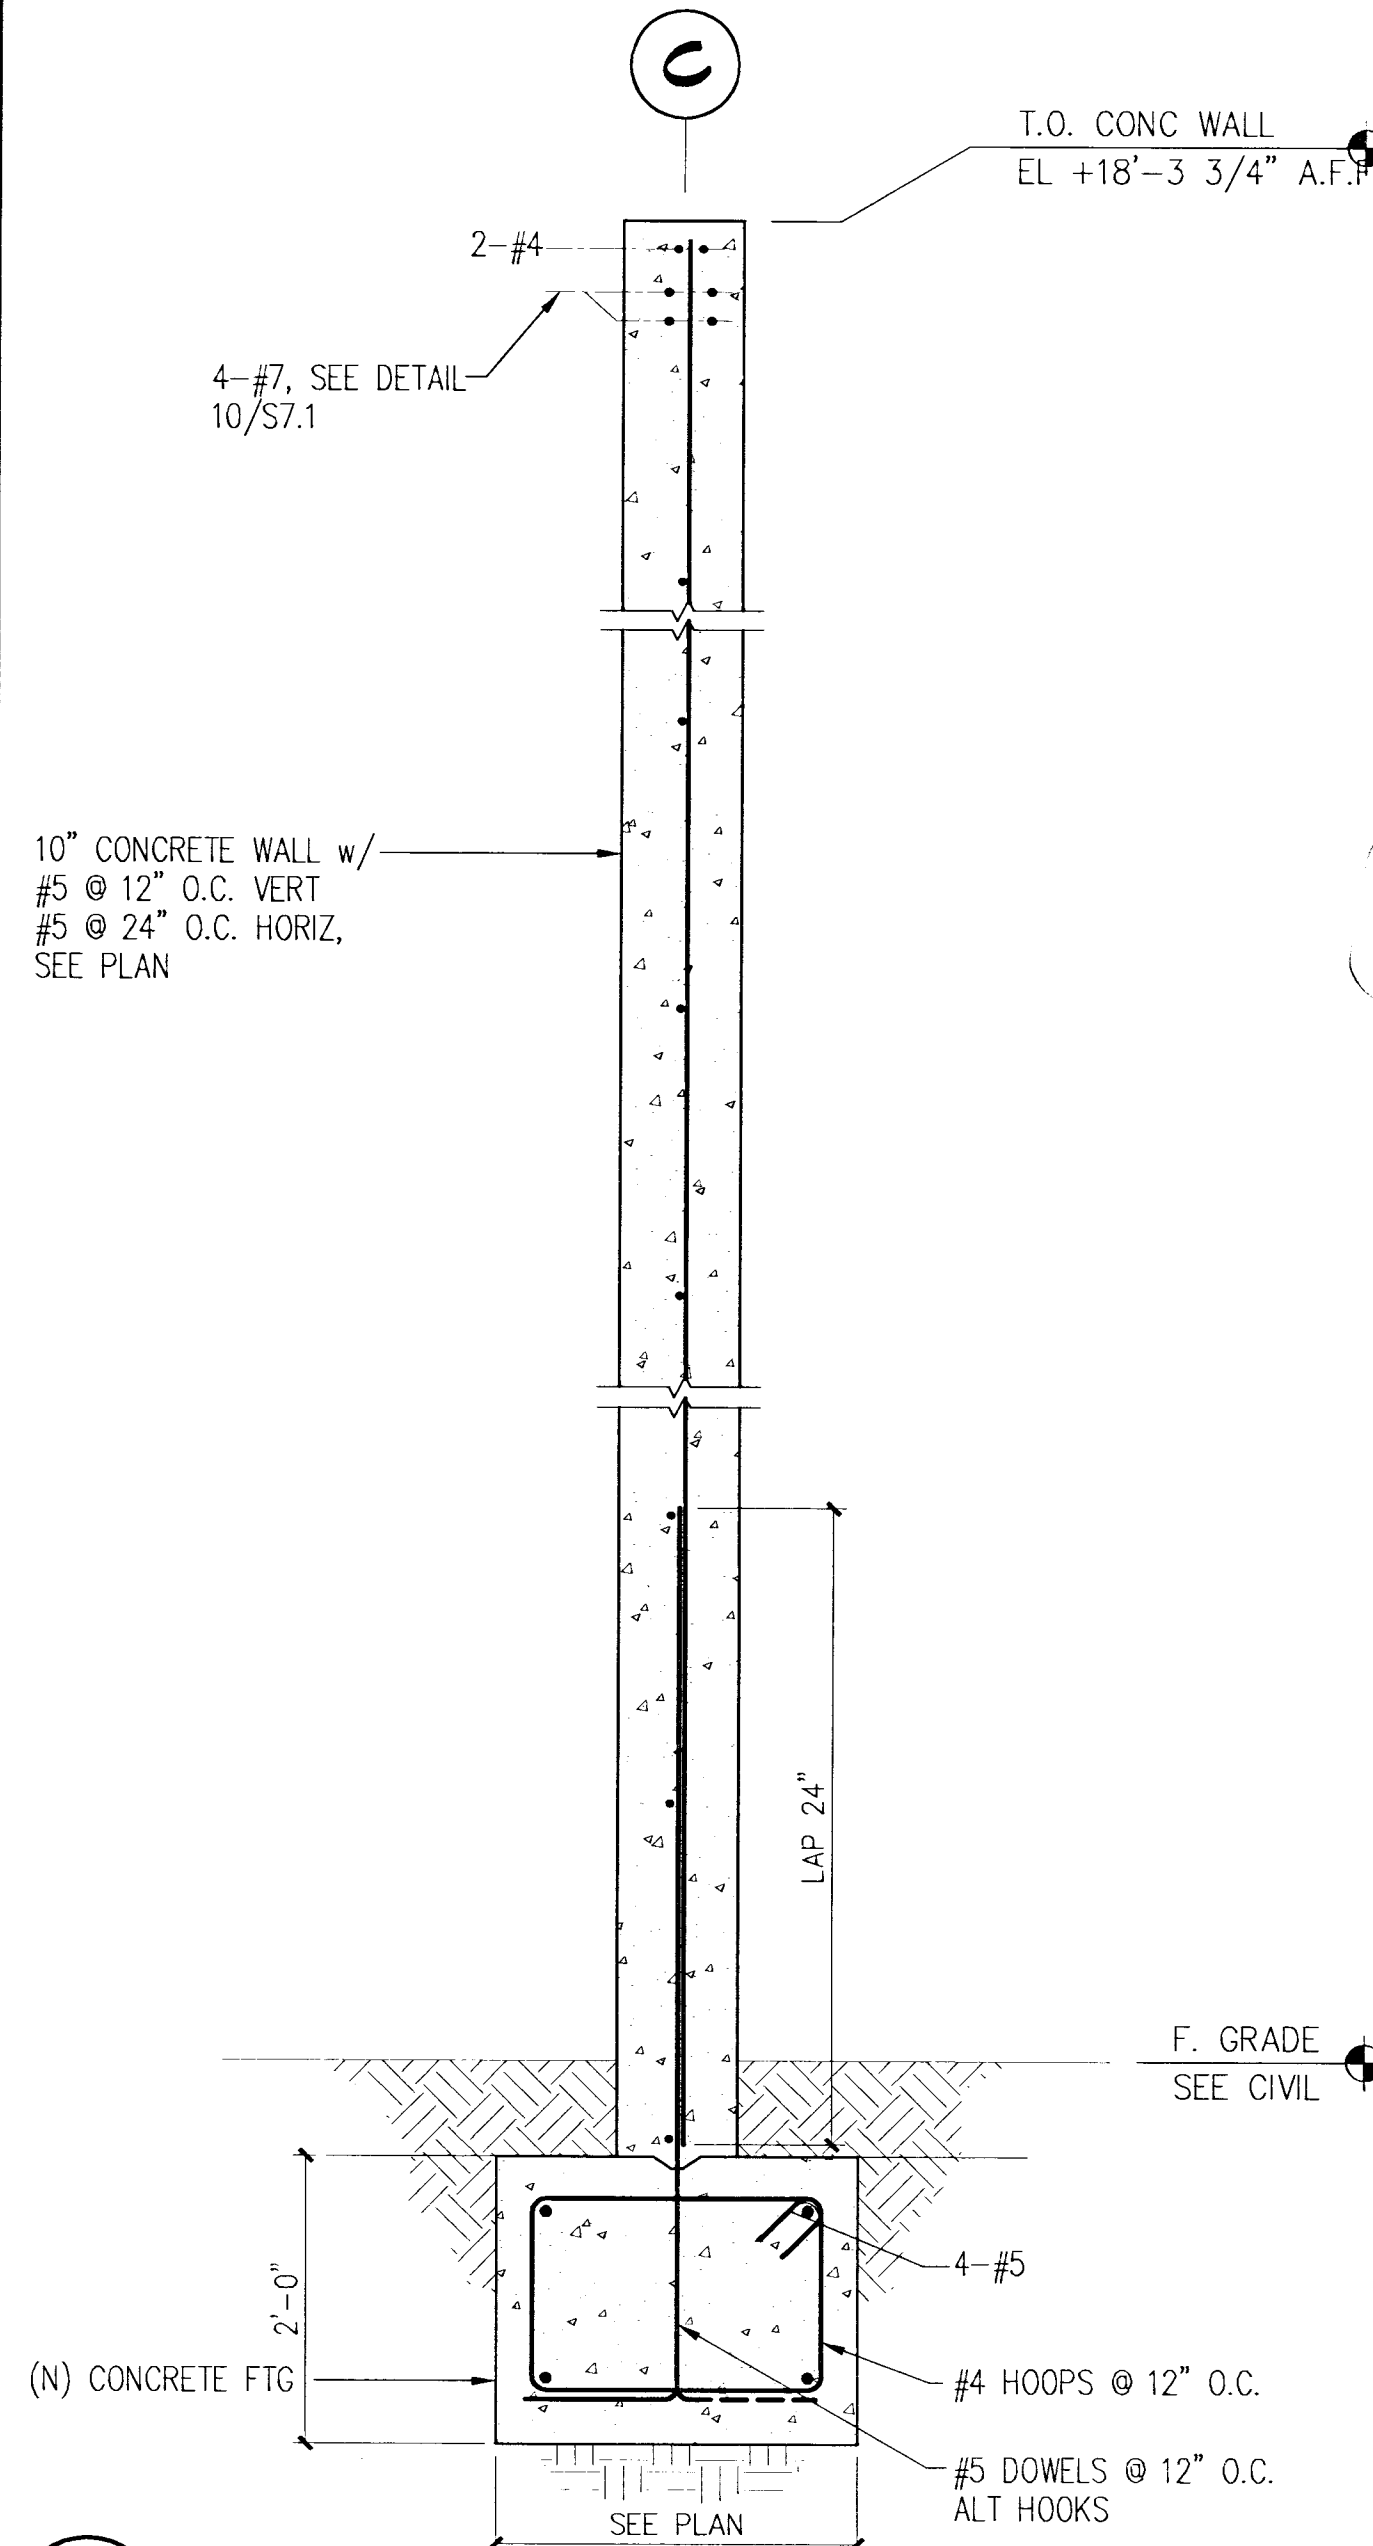


6 WALL SECTION
3/4"=1'-0"

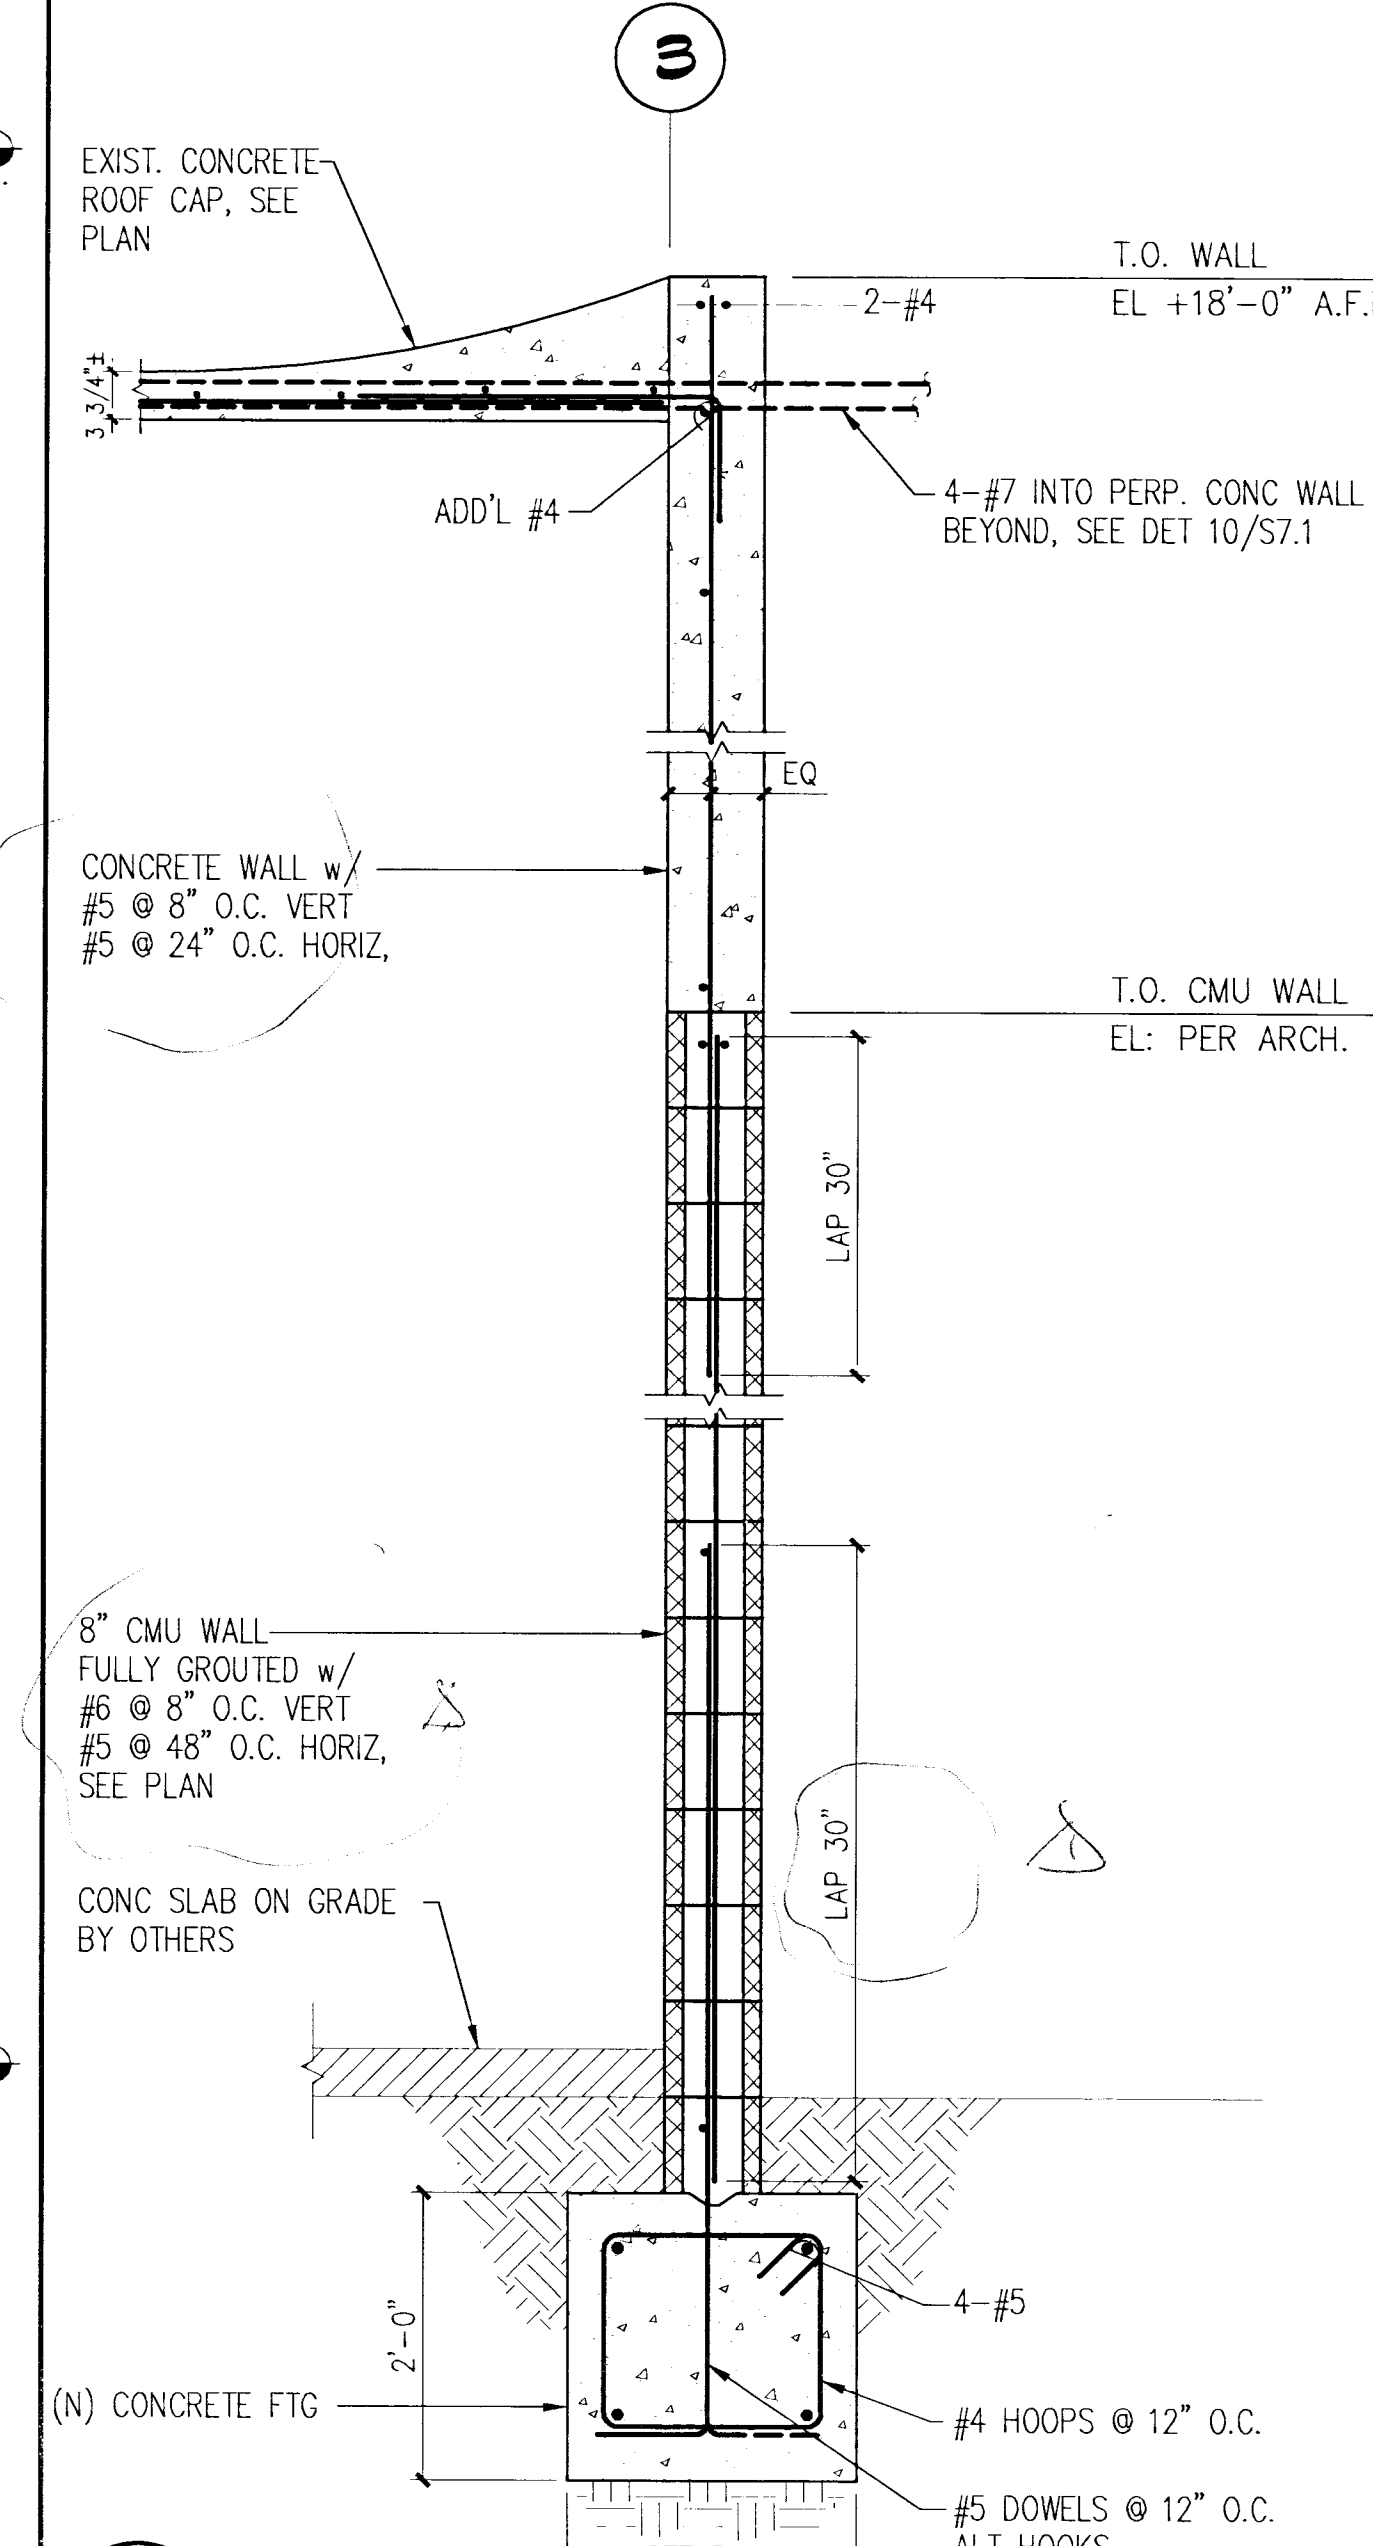


2 WALL SECTION
3/4"=1'-0"

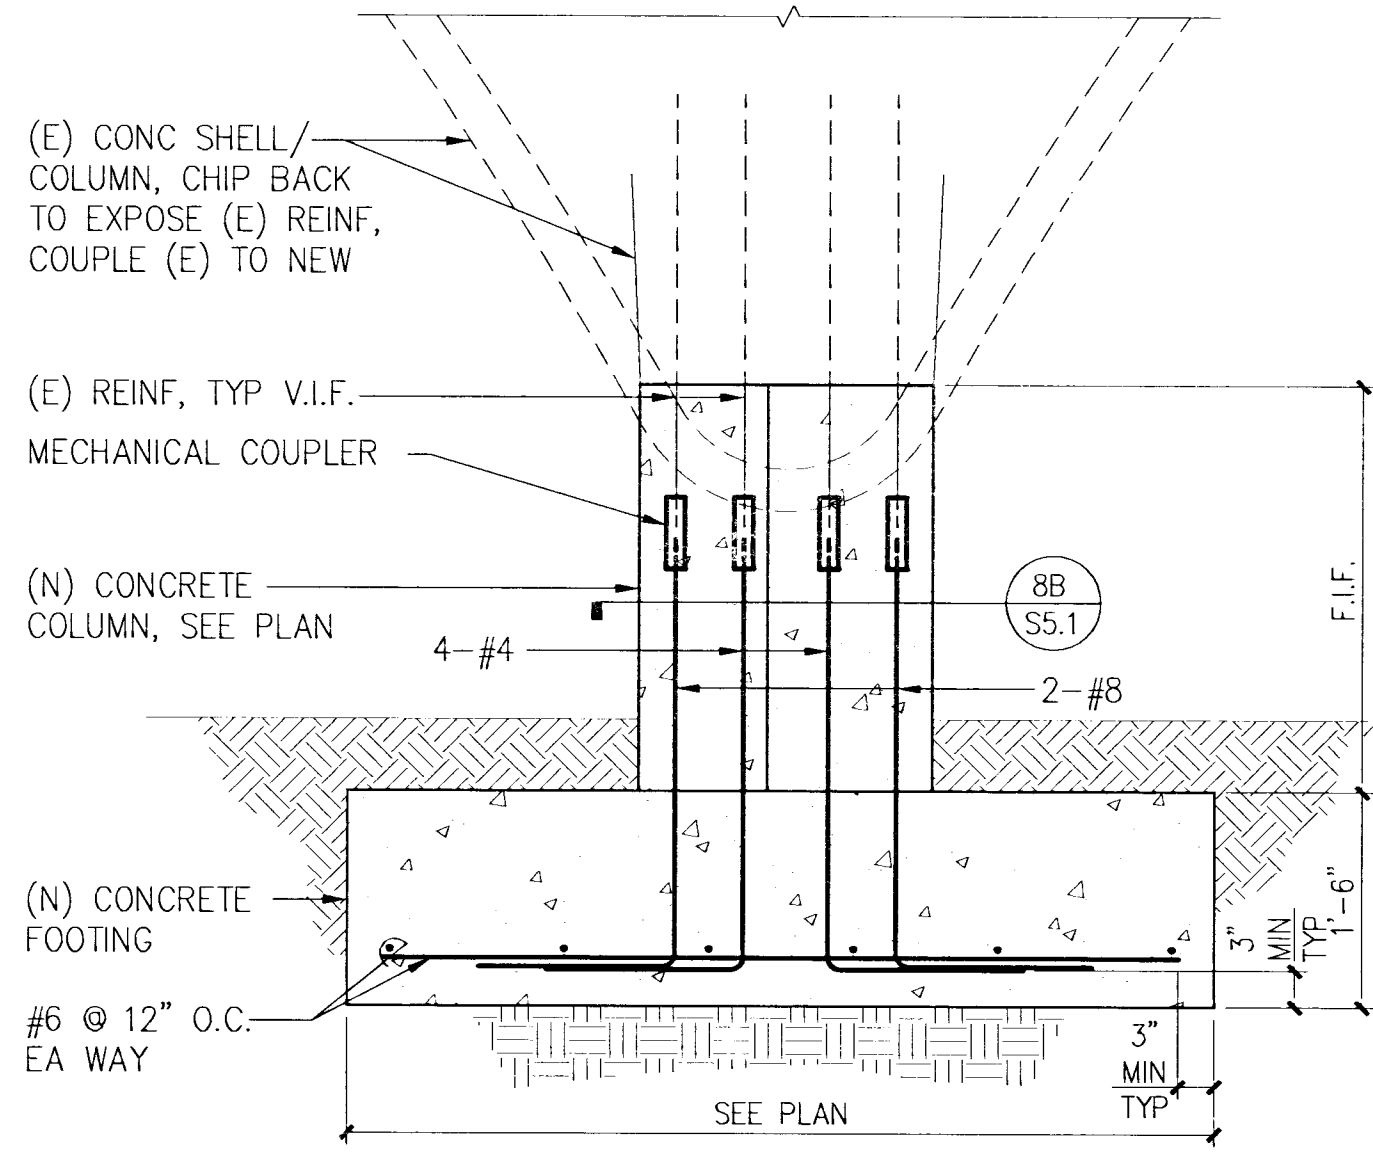


7 DETAIL
3/4"=1'-0"

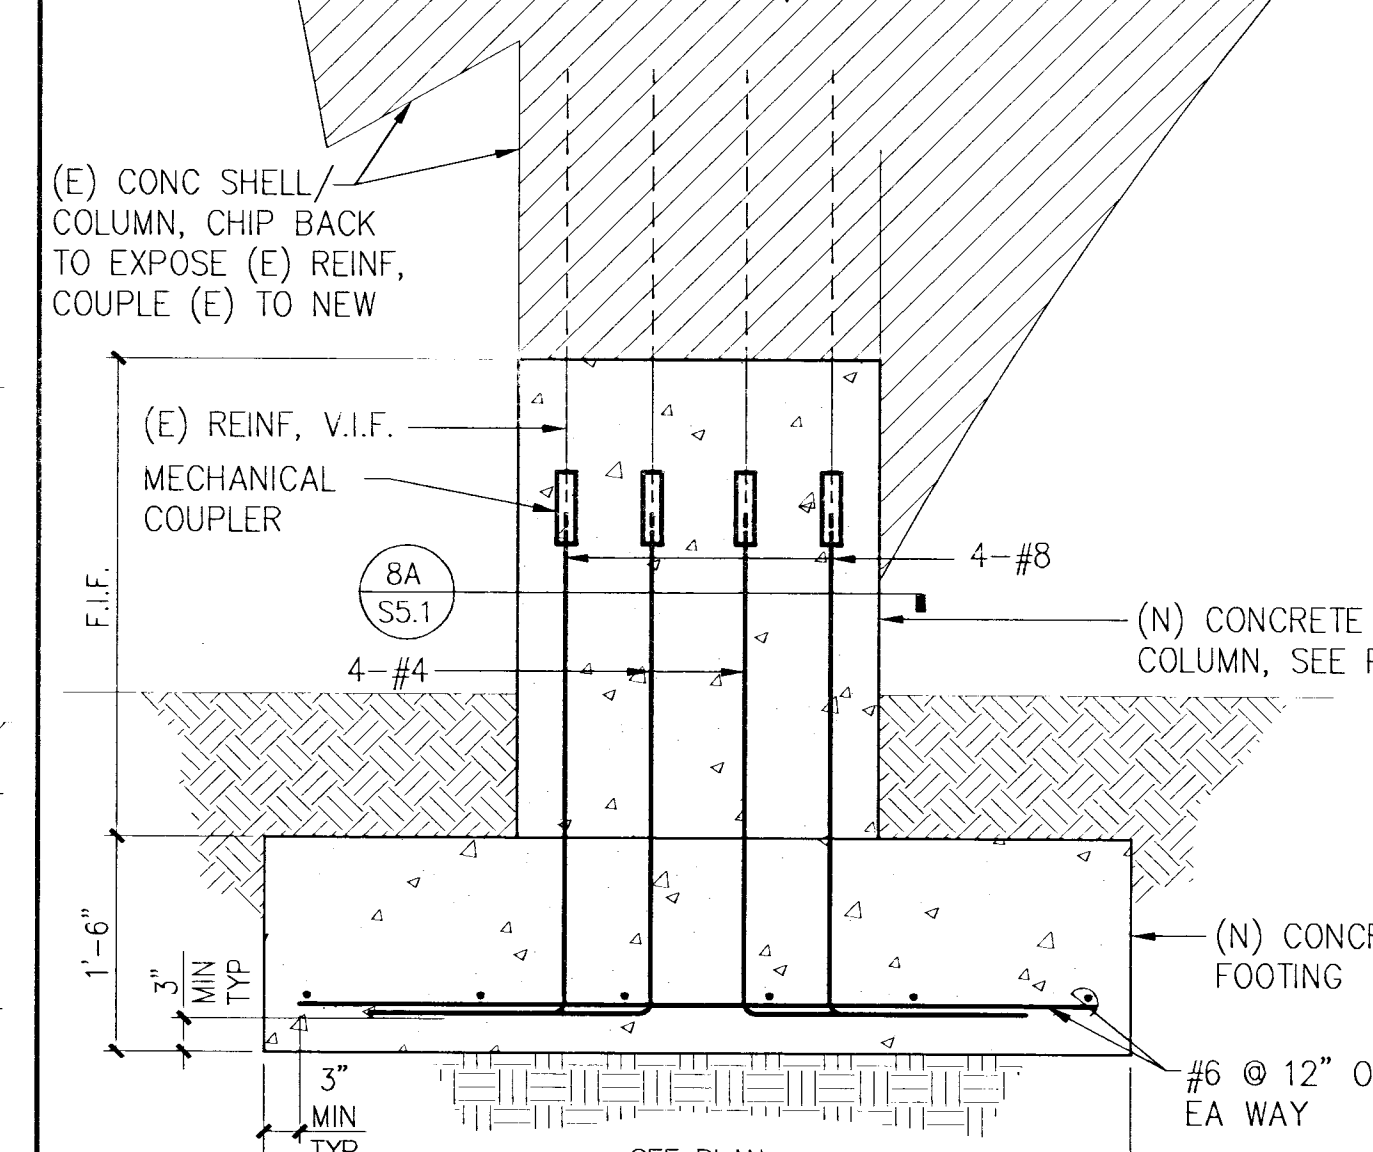

3 DETAIL
3/4"=1'-0"

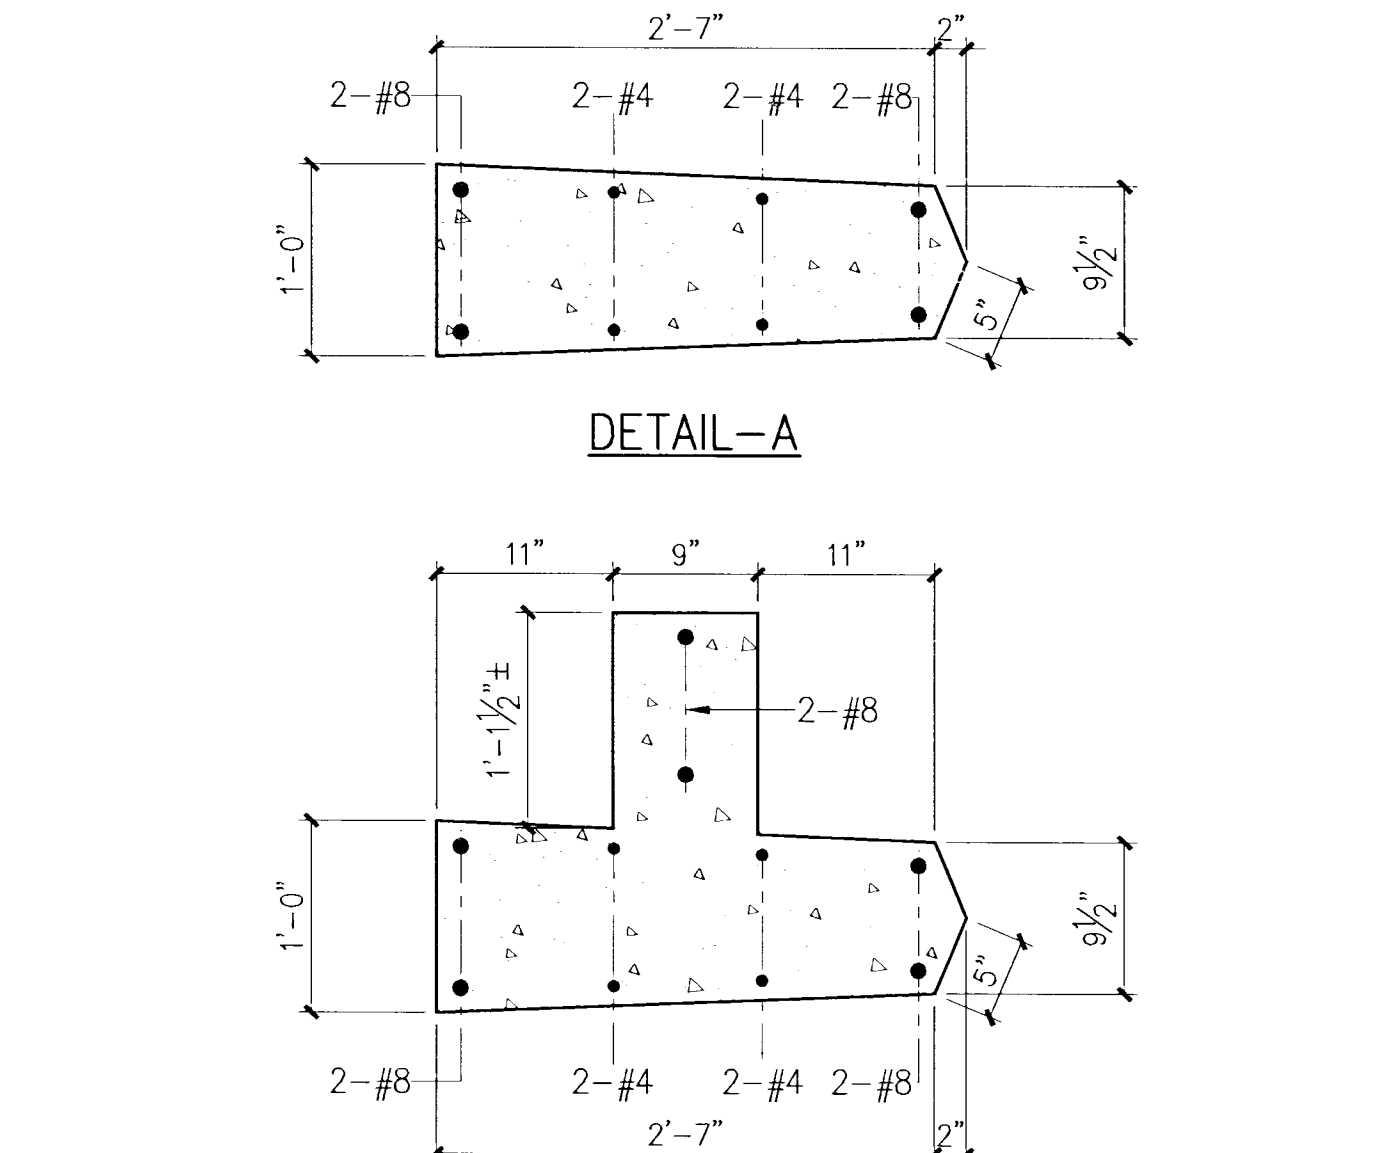


8 DETAIL
1"=1'-0"

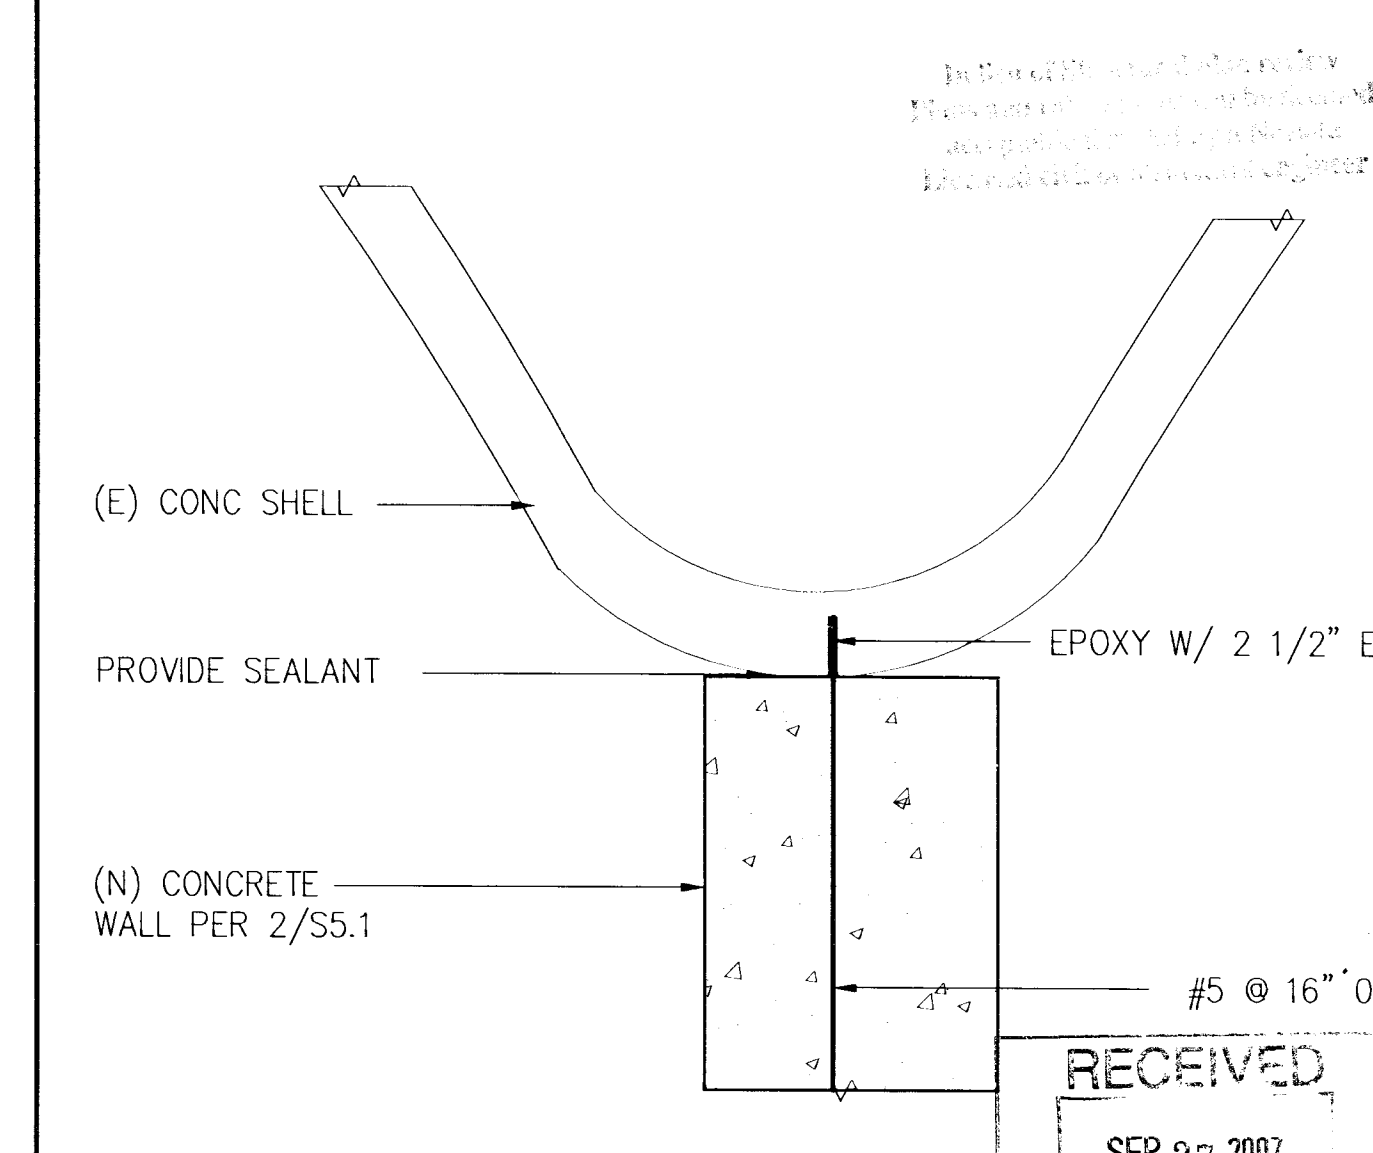

4 DETAIL
3/4"=1'-0"

DATE	DESCRIPTION
SEP 27 2007	Plan Check Rev

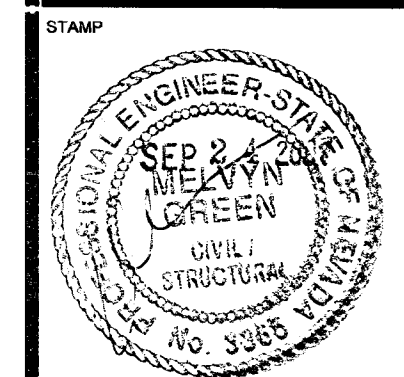

CONSULTANT
Marty Green & Associates, Inc.
Professional Engineer License No. 5088
Portland, Oregon 97205
Fax: (503) 792-8602
martygreen@earthlink.net

PROJECT NAME
NEON MUSEUM and BONEYARD
770 NORTH LAS VEGAS BLVD.
LAS VEGAS, NEVADA 89101

DRAWN BY
DAVB
CHECKED BY
MG
DATE
06/20/07
JOB NUMBER
2005127
SHEET NAME
SECTIONS
AND
DETAILS
SHEET NUMBER
S5.1