


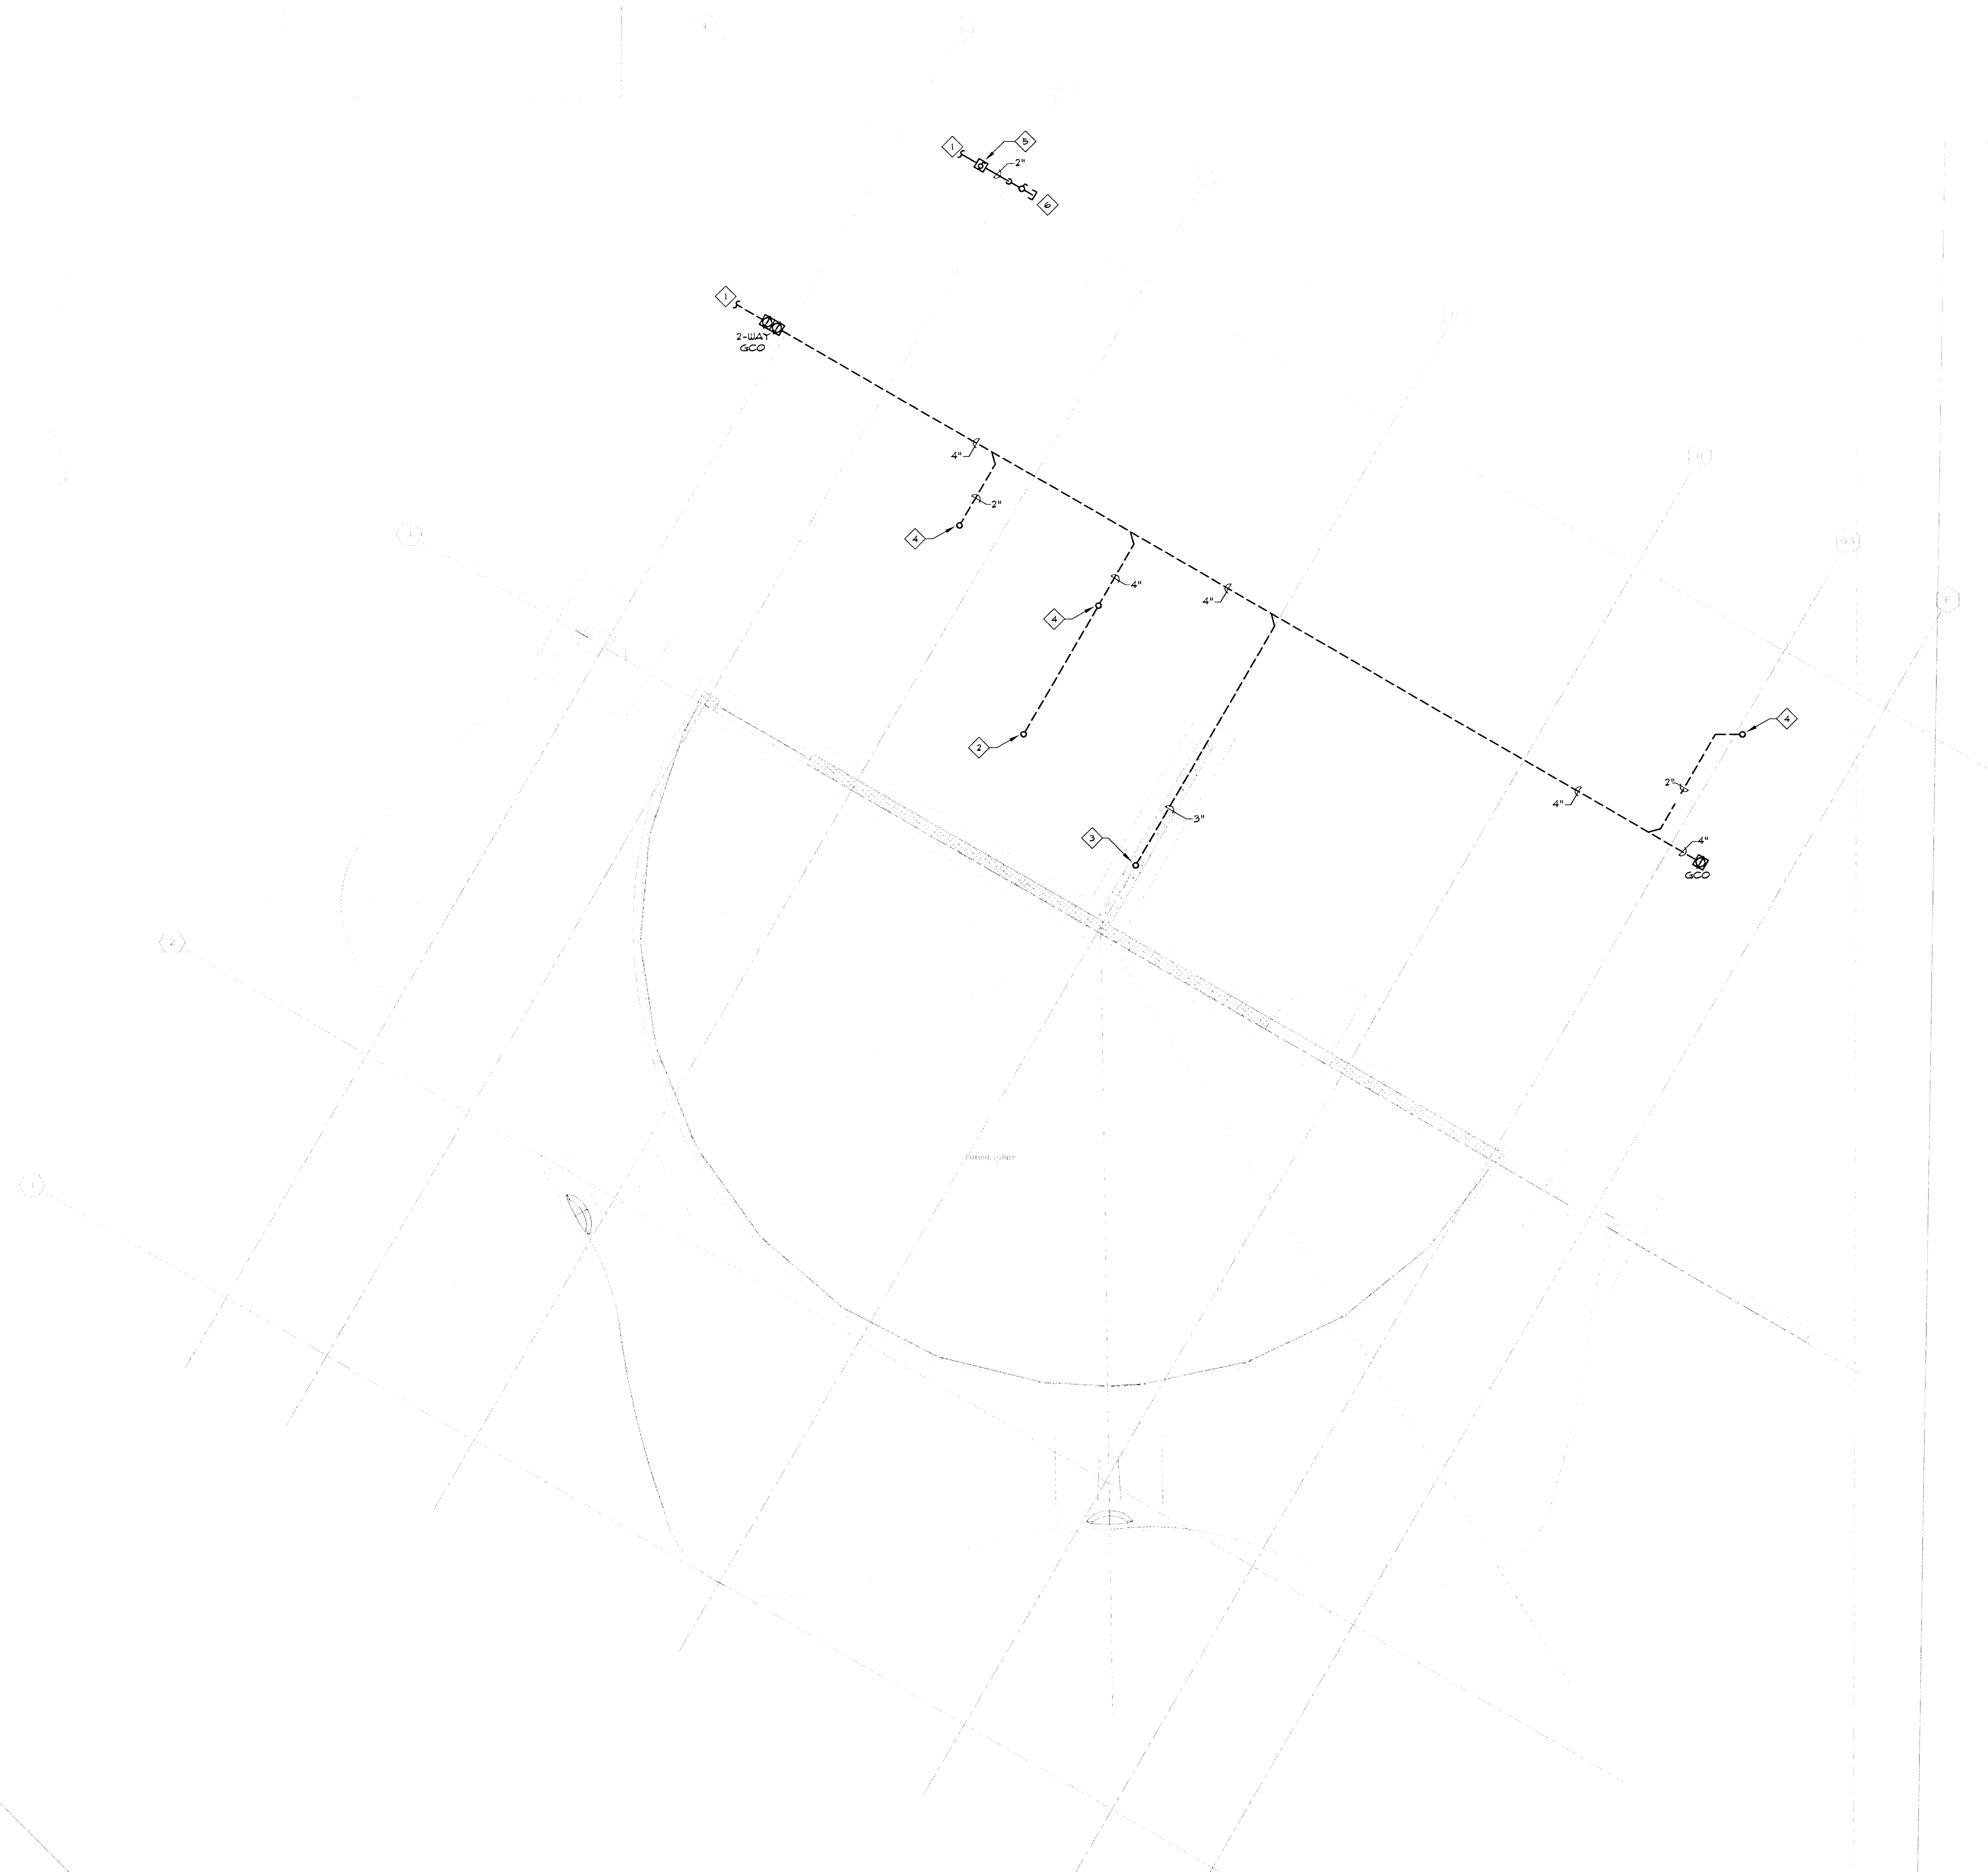

GENERAL NOTES:

1. ALL WATER PIPING SHALL BE INSTALLED ON THE INTERIOR SIDE OF THE BUILDING.
2. THE CUTTING, NOTCHING AND BORING OF HOLES IN FLOOR JOIST AND WALL STUDS SHALL BE IN ACCORDANCE WITH THE LATEST APPROVED EDITION OF THE INTERNATIONAL BUILDING CODE.
3. CONTRACTOR SHALL BE RESPONSIBLE FOR THE COORDINATION OF ALL PLUMBING ROUGH-IN LOCATIONS. REFER TO ARCHITECTURAL DRAWINGS FOR FIXTURES AND EQUIPMENT LOCATIONS.
4. CONTRACTOR SHALL BE RESPONSIBLE FOR ALL CUTTING AND PATCHING AS REQUIRED TO ACCOMMODATE HIS WORK.
5. ALL SANITARY DRAINAGE PIPING SHALL BE SLOPED AT 1/4" PER FOOT.
6. PLUMBING CONTRACTOR SHALL COORDINATE ROUTING OF PIPING WITH ALL OTHER TRADES PRIOR TO COMMENCING WORK.
7. PRIOR TO INSTALLATION OF SEWER AND WATER PIPING BELOW GRADE COORDINATE EXACT LOCATIONS AND DEPTHS OF BURIAL WITH CIVIL AND FOUNDATION DRAWINGS AND CORRESPONDING ENGINEERS.
8. REFER TO THE PLUMBING DETAILS THAT APPLY TO THE WORK ON THIS DRAWING. THESE DETAILS PROVIDE GUIDANCE AS TO INSTALLATION INTENT AND DO NOT NECESSARILY SHOW ALL COMPONENTS REQUIRED.



SHEET NOTES:

1. REFER TO CIVIL DRAWINGS FOR CONTINUATION.
2. 4" WASTE UP FOR FUTURE USE.
3. 3" WASTE UP FOR FUTURE USE.
4. 2" WASTE UP FOR FUTURE USE.
5. SHUT-OFF VALVE IN YARD BOX.
6. 2" COLD WATER WITH BALL VALVE.



PLANS APPROVED
PLUMBING/MECHANICAL
Building & Safety Dept.
City of Las Vegas, Nevada

MC OCT 14, 2007

Does Not Include Architectural, Electrical, Structural or Life-Safe Improvements. Make No Change Without Approval. Plan is Not a Permit to Violate Any Ordinance.

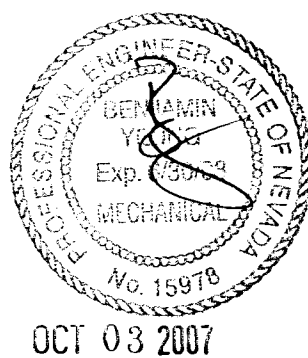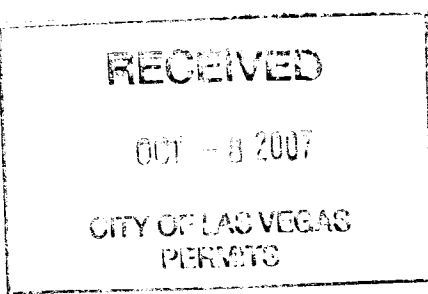

REVISIONS	BY

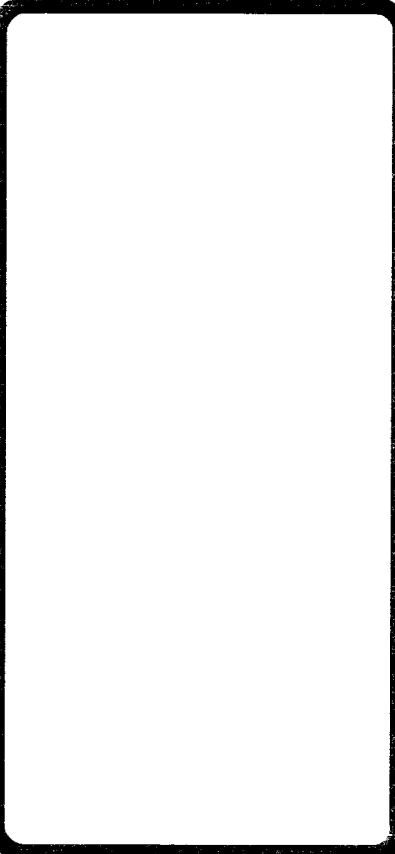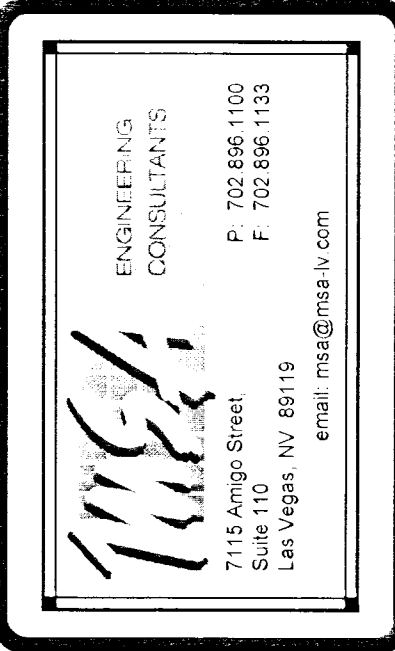

PROJECT: THE NEON MUSEUM LAS VEGAS, NEVADA

SHEET TITLE: PLUMBING PLAN

DRAWN MSA
CHECKED BY
DATE 10/03/2007
SCALE NOTED
JOB NO. LO1333
SHEET

