




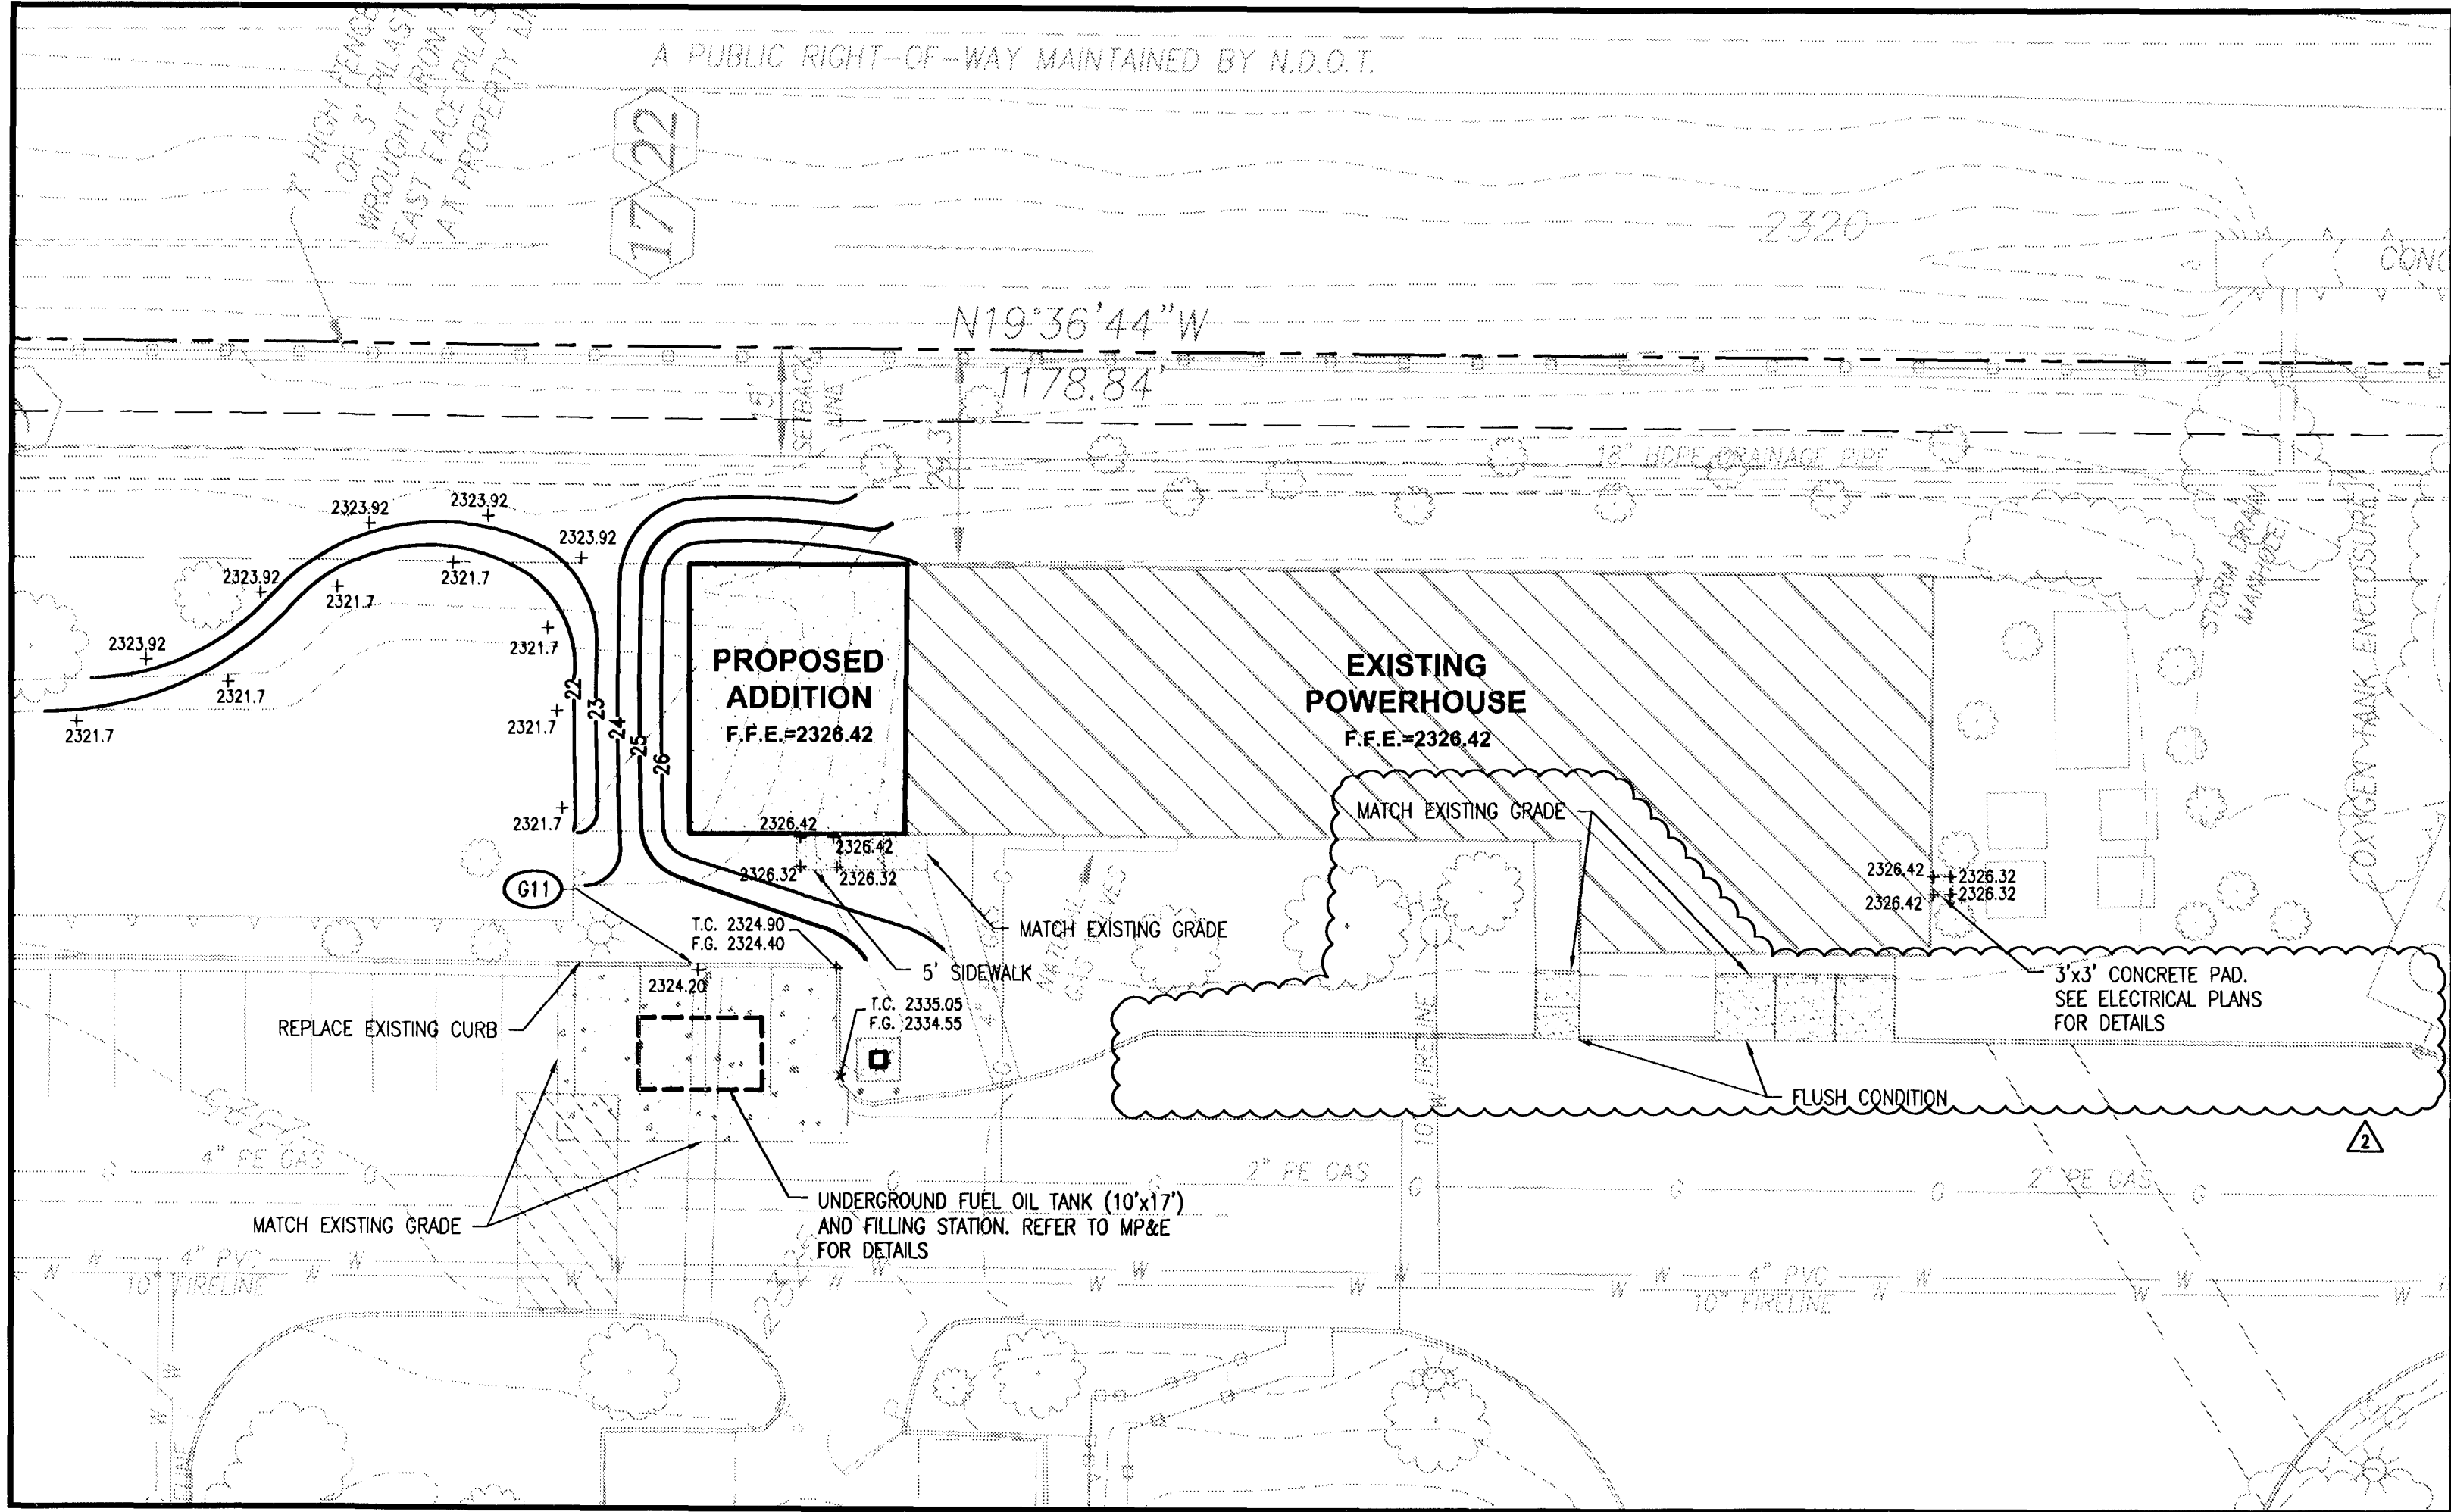

POWER HOUSE

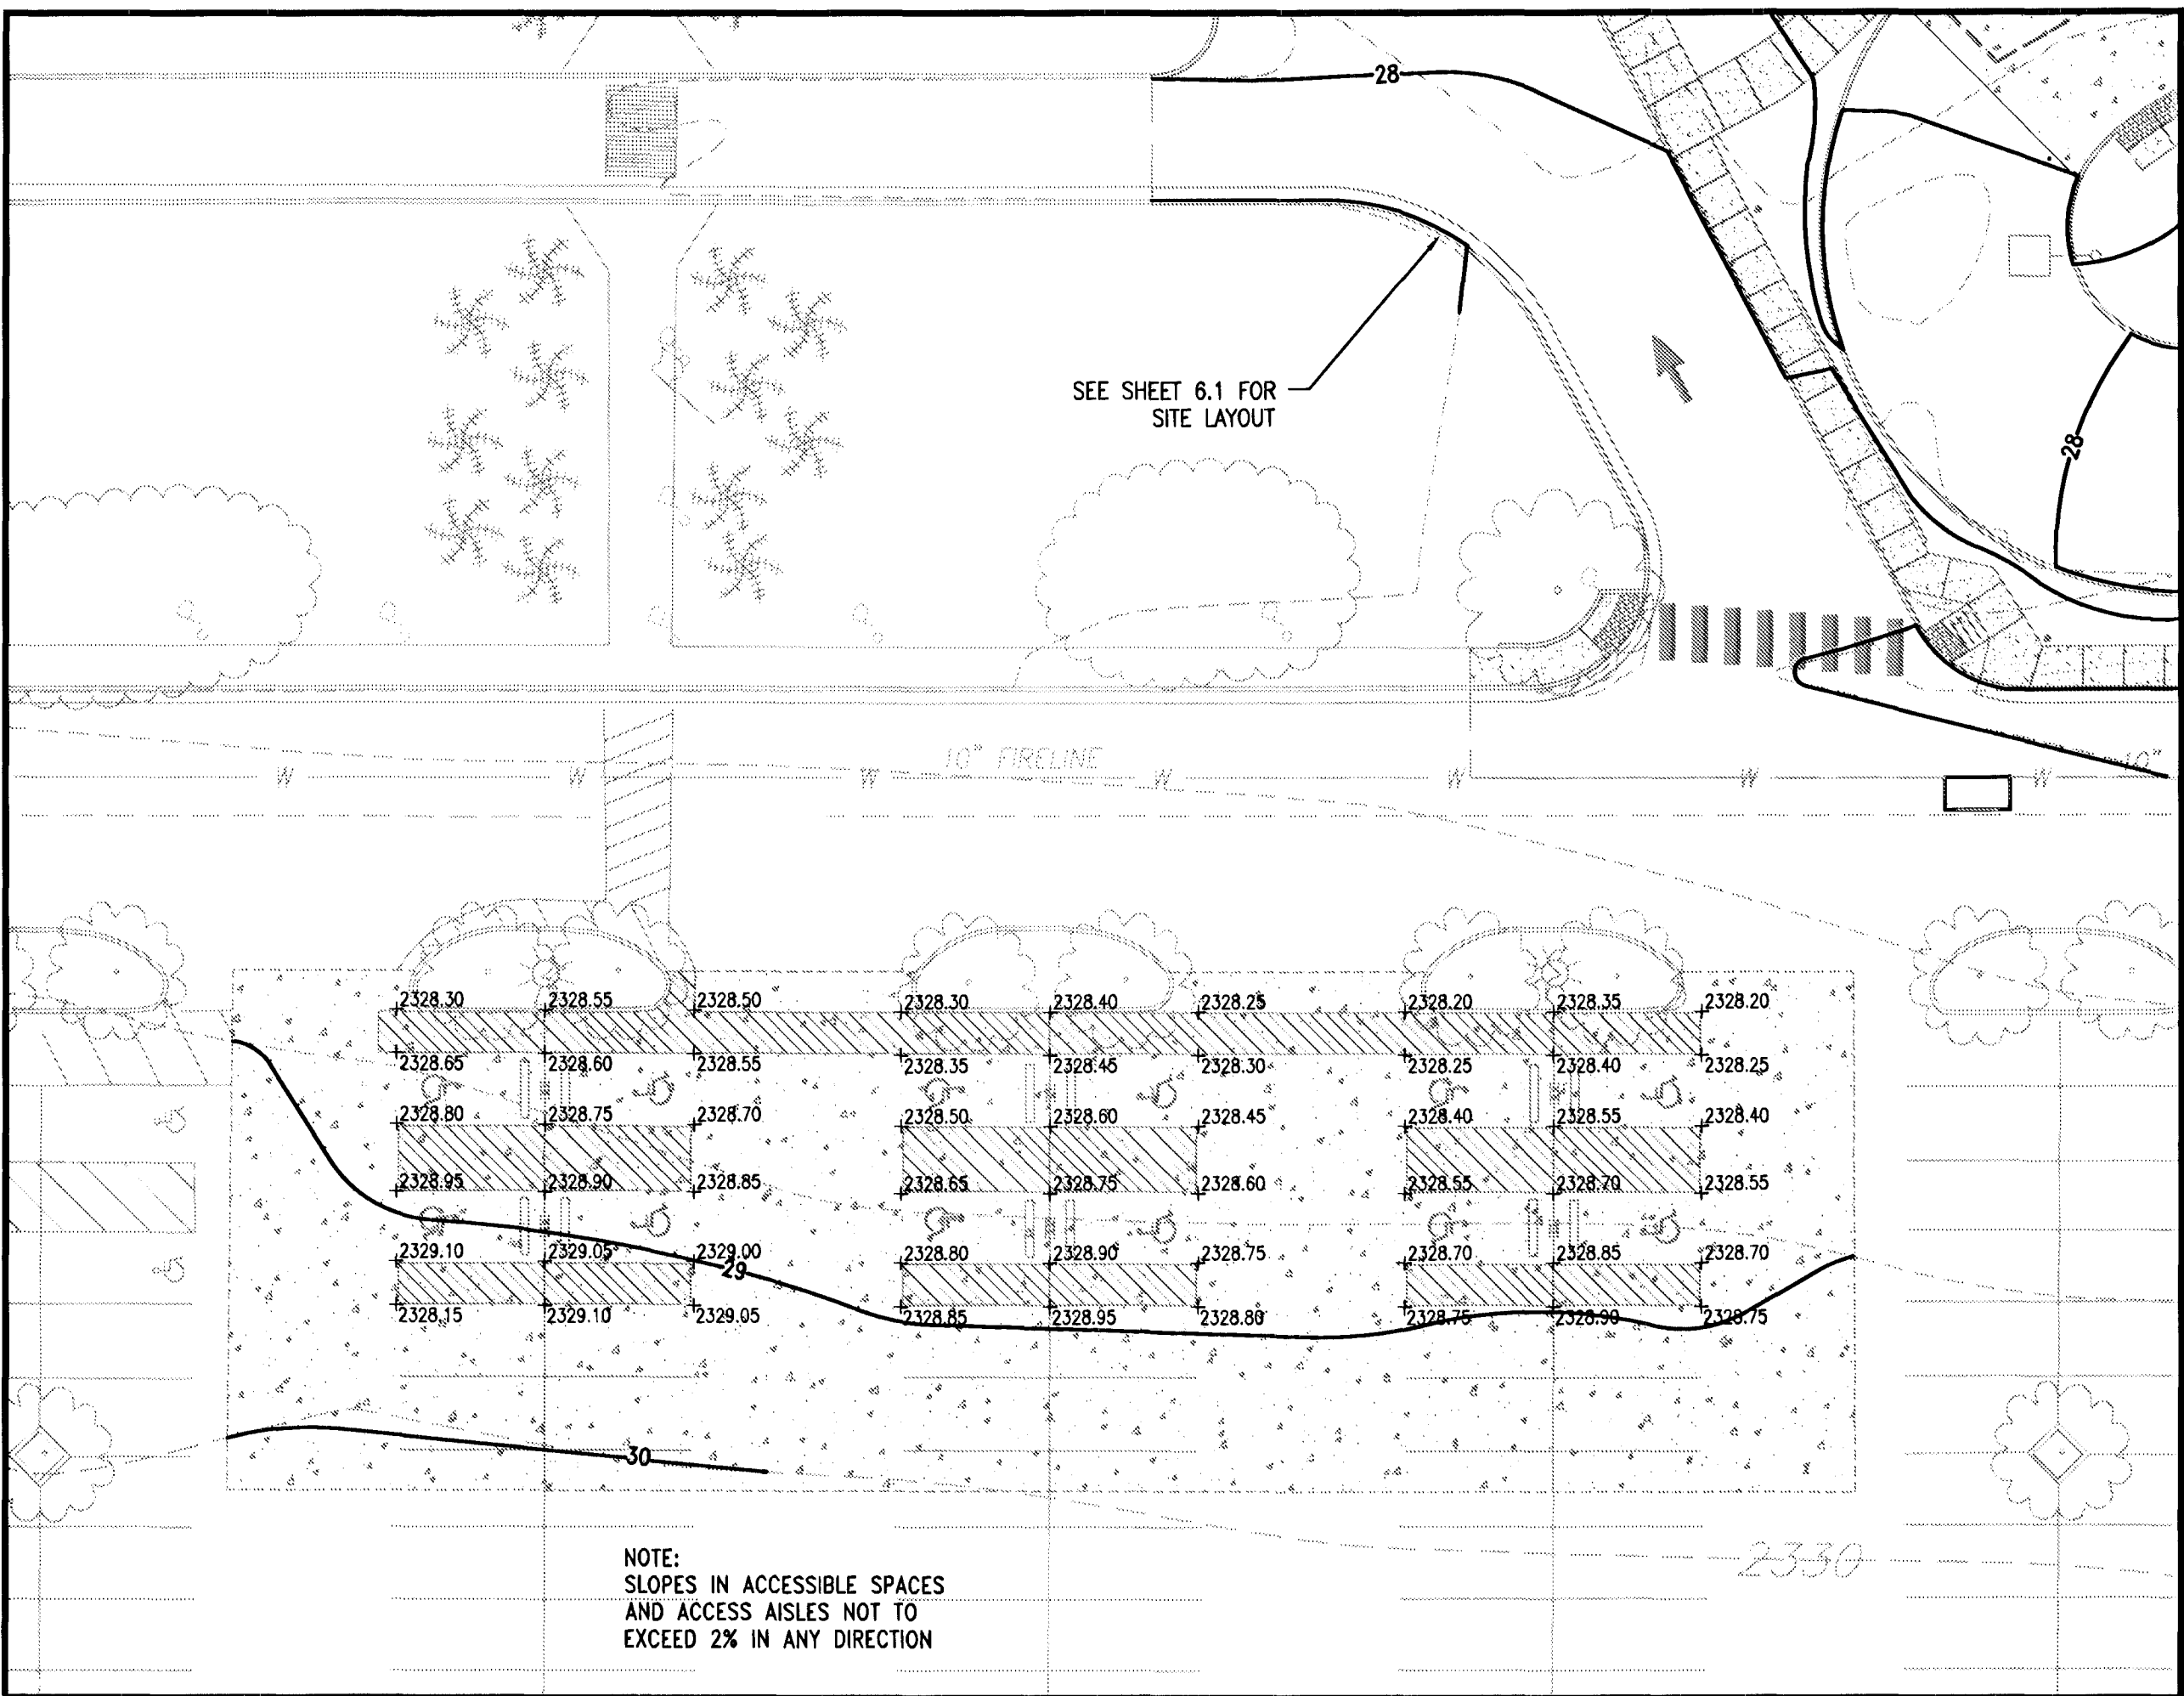

WEST ENTRANCE ACCESSIBLE PARKING

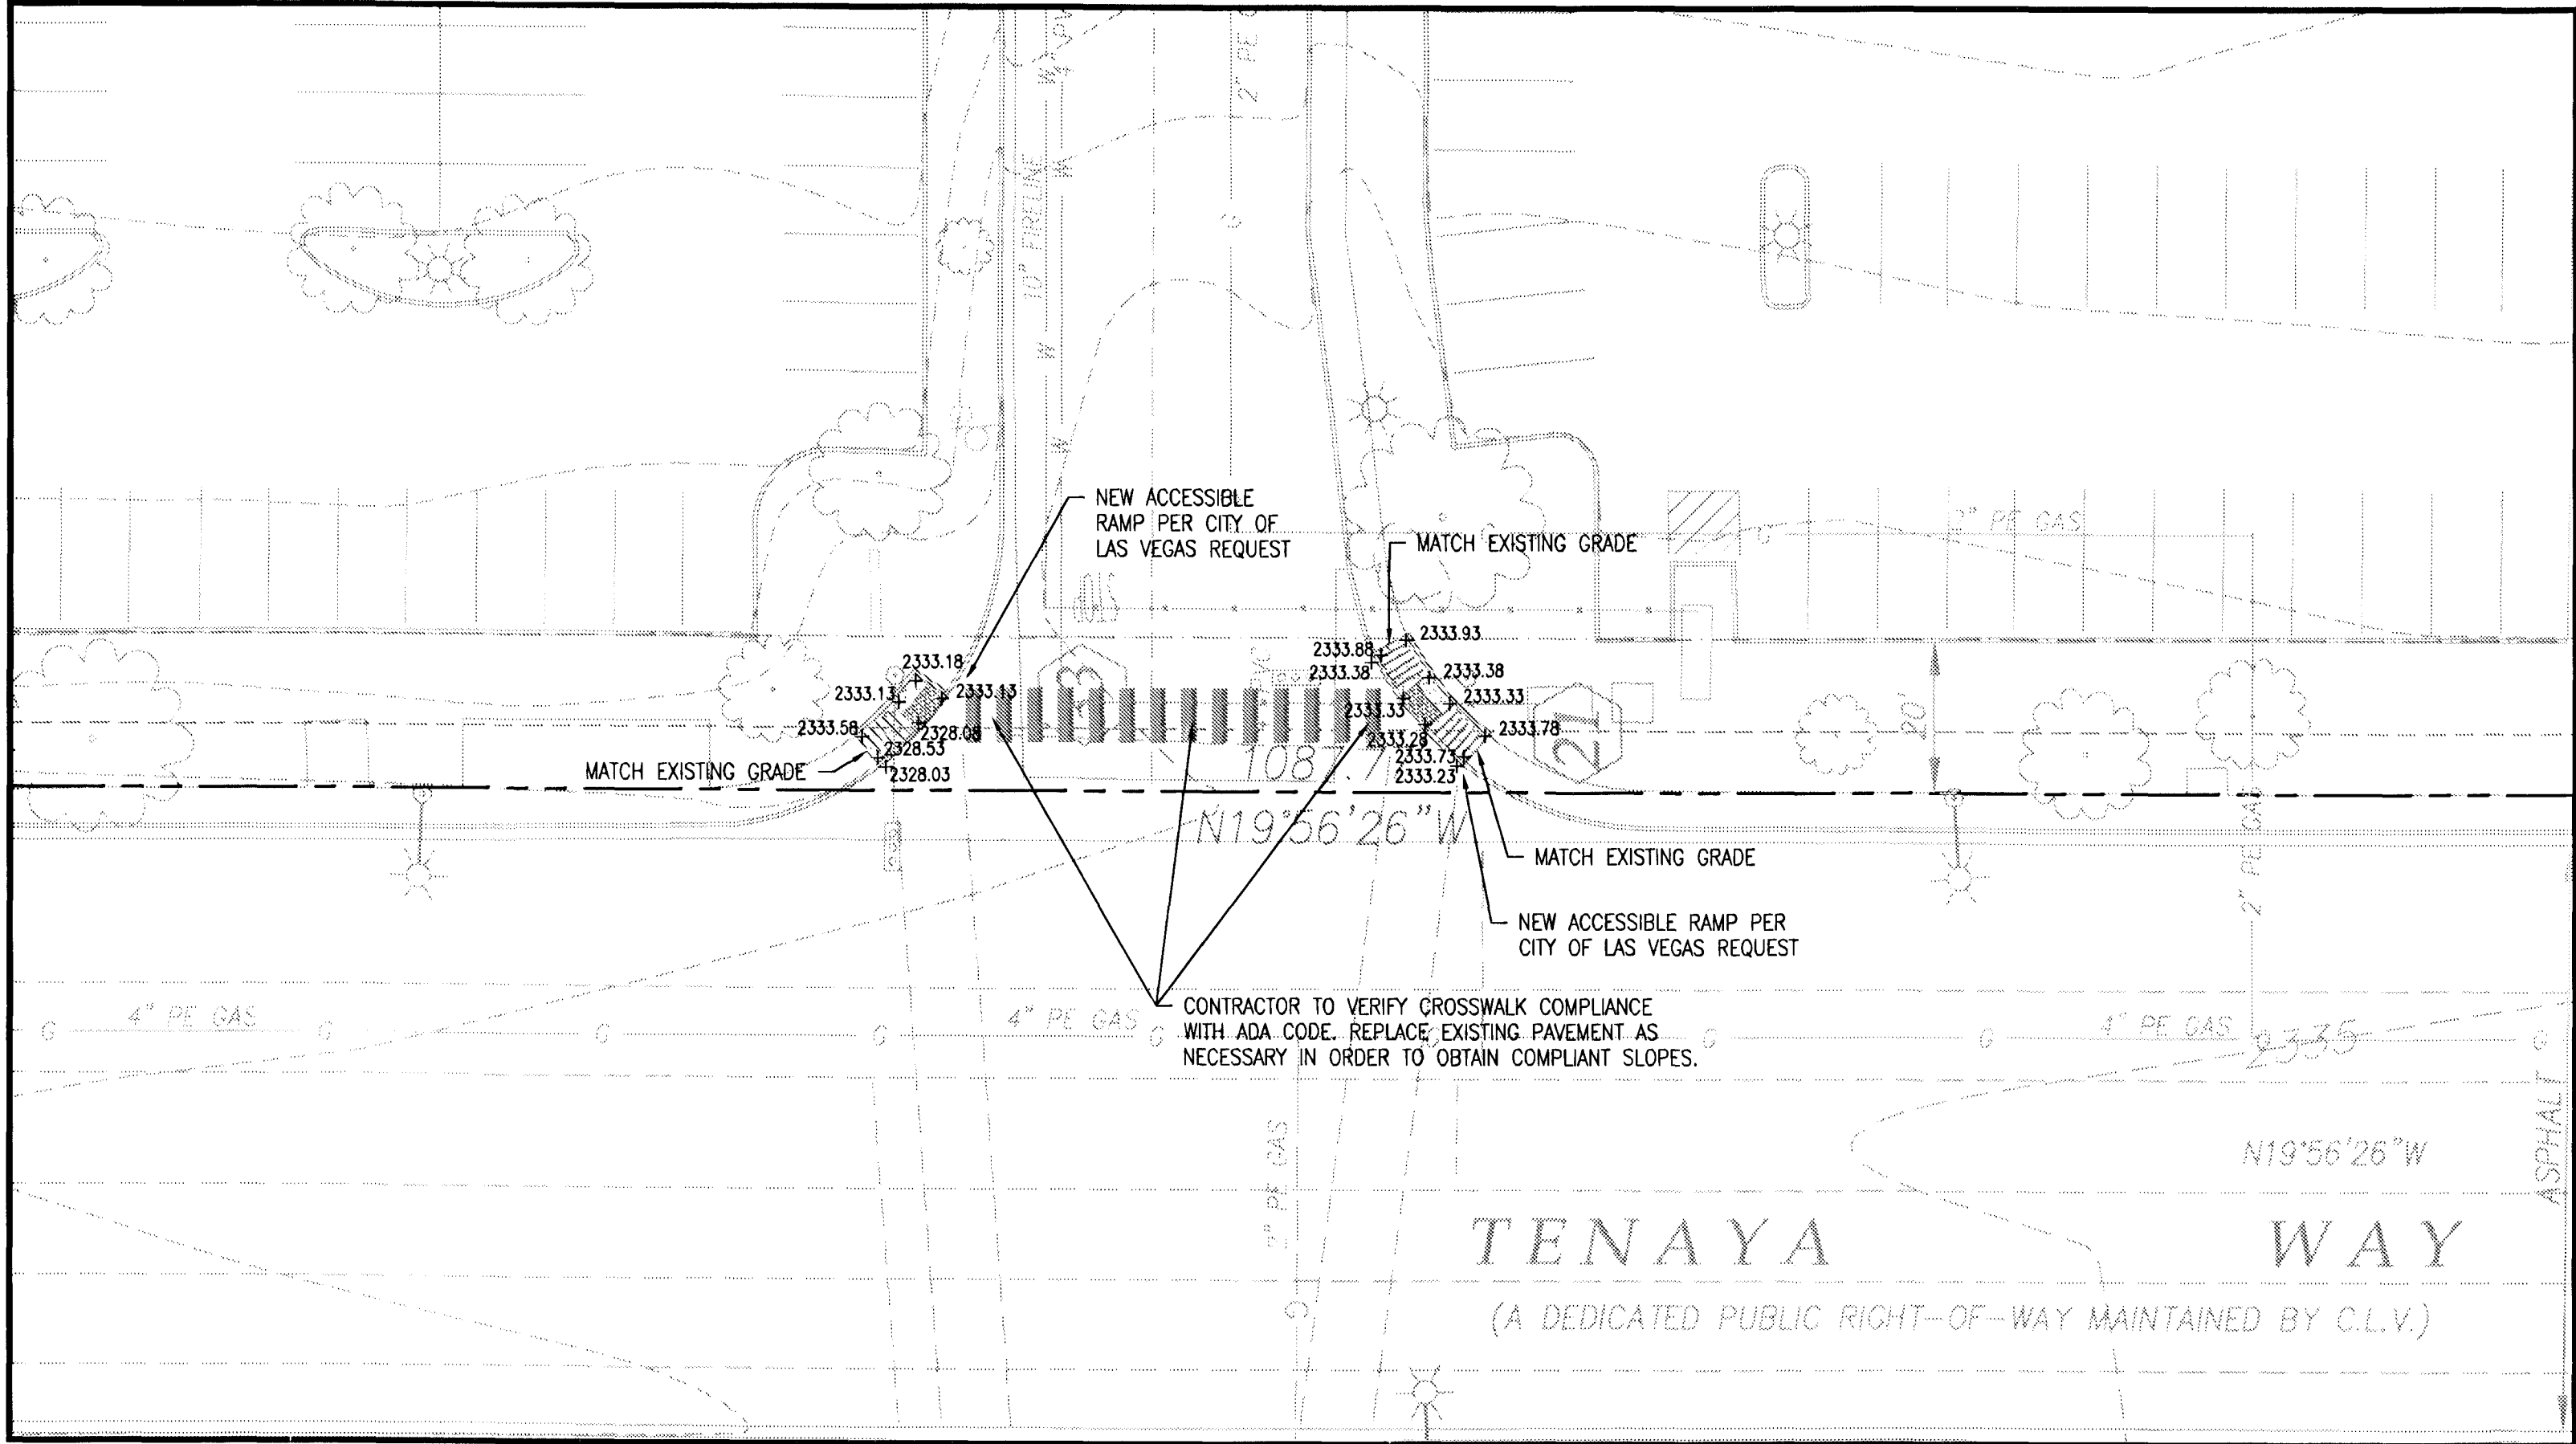

SOUTHWEST ENTRANCE

811 CALL 811 NATIONWIDE

Know what's below. Call before you dig.

IT IS THE CONTRACTOR'S RESPONSIBILITY TO CONTACT UTILITY COMPANIES TWO (2) BUSINESS DAYS PRIOR TO ANY CONSTRUCTION. THE LOCATION OF UTILITIES SHOWN ON THESE PLANS ARE APPROXIMATE AND POSSIBLY INCOMPLETE. THEREFORE CERTIFICATION TO THE LOCATION OF ALL UNDERGROUND UTILITIES IS WITHHELD.

GRADING & DRAINAGE KEY NOTE		
CODE	DESCRIPTION	DETAIL REF.
G2a	SINGLE CATCH BASIN	3-CB.1
G3	JUNCTION MANHOLE	5-CB.1
G6b	CONCRETE HEADWALL	4-CB.2
G11	2' CURB CUT	7-CB.2
G15b	TRANSITION FROM FLUSH CONDITIONS TO 6" CURB OVER 15 FEET	6-CB.2

SITE GRADING NOTES

- SEE SHEET C2.0 FOR GRADING NOTES.
- SEE SHEET C2.1 FOR CITY OF LAS VEGAS GRADING NOTES.
- ALL ONSITE STORM DRAIN SYSTEMS AND ASSOCIATED FACILITIES ARE PRIVATELY OWNED AND TO BE PRIVATELY MAINTAINED.
- ALL PROPOSED CATCH BASINS TO BE JENSEN PRECAST MODEL D12424 (24"x24" GRATE) OR APPROVED EQUAL.
- PROPOSED JUNCTION MANHOLE TO BE JENSEN PRECAST MODEL MAG 520 (48" INNER DIAMETER) OR APPROVED EQUAL.
- PROPOSED HEADWALL TO BE JENSEN PRECAST MODEL MAG 501-1 (30" INSIDE PIPE DIAMETER) OR APPROVED EQUAL.
- SEE SHEET C6.0 FOR BENCHMARK


PROPOSED FEATURES LEGEND:

- 5221 PROPOSED CONTOURS
- SETBACKS AND EASEMENTS
- WATER LINE

THE GRADING PLAN CONFORMS WITH APPROVED DRAINAGE STUDY DS-4520.

JIM LITTLEJOHN P.E.
LITTLEJOHN ENGINEERING ASSOCIATES

DATE

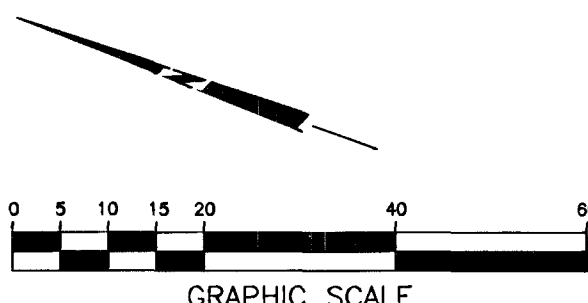

GRADING PLAN

RELOT


41394 100N 3043-A

MOUNTAIN VIEW HOSPITAL
EMERGENCY & ICU DEPARTMENT ADDITIONS
and INTERIOR RENOVATIONS

OWNER / DEVELOPER
SUNRISE MOUNTAINVIEW HOSPITAL
3100 N TENAYA WAY
LAS VEGAS, NV 89128
P: (702) 225-5065

LITTLEJOHN
ENGINEERING
ASSOCIATES

1993 21ST AVENUE SOUTH, NASHVILLE, TENNESSEE 37213
T: 615-385-1144 F: 615-385-4020 WWW.LEJANCO.COM

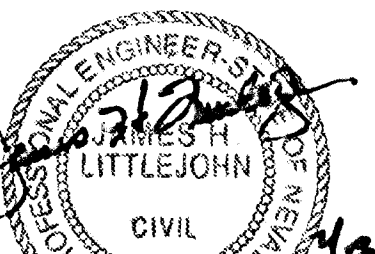

EXPIRATION DATE: 12/31/2013

LEA PROJECT
IDENTIFICATION # 29187
Sheet Number

C6.3
SHEET 22 OF 33