




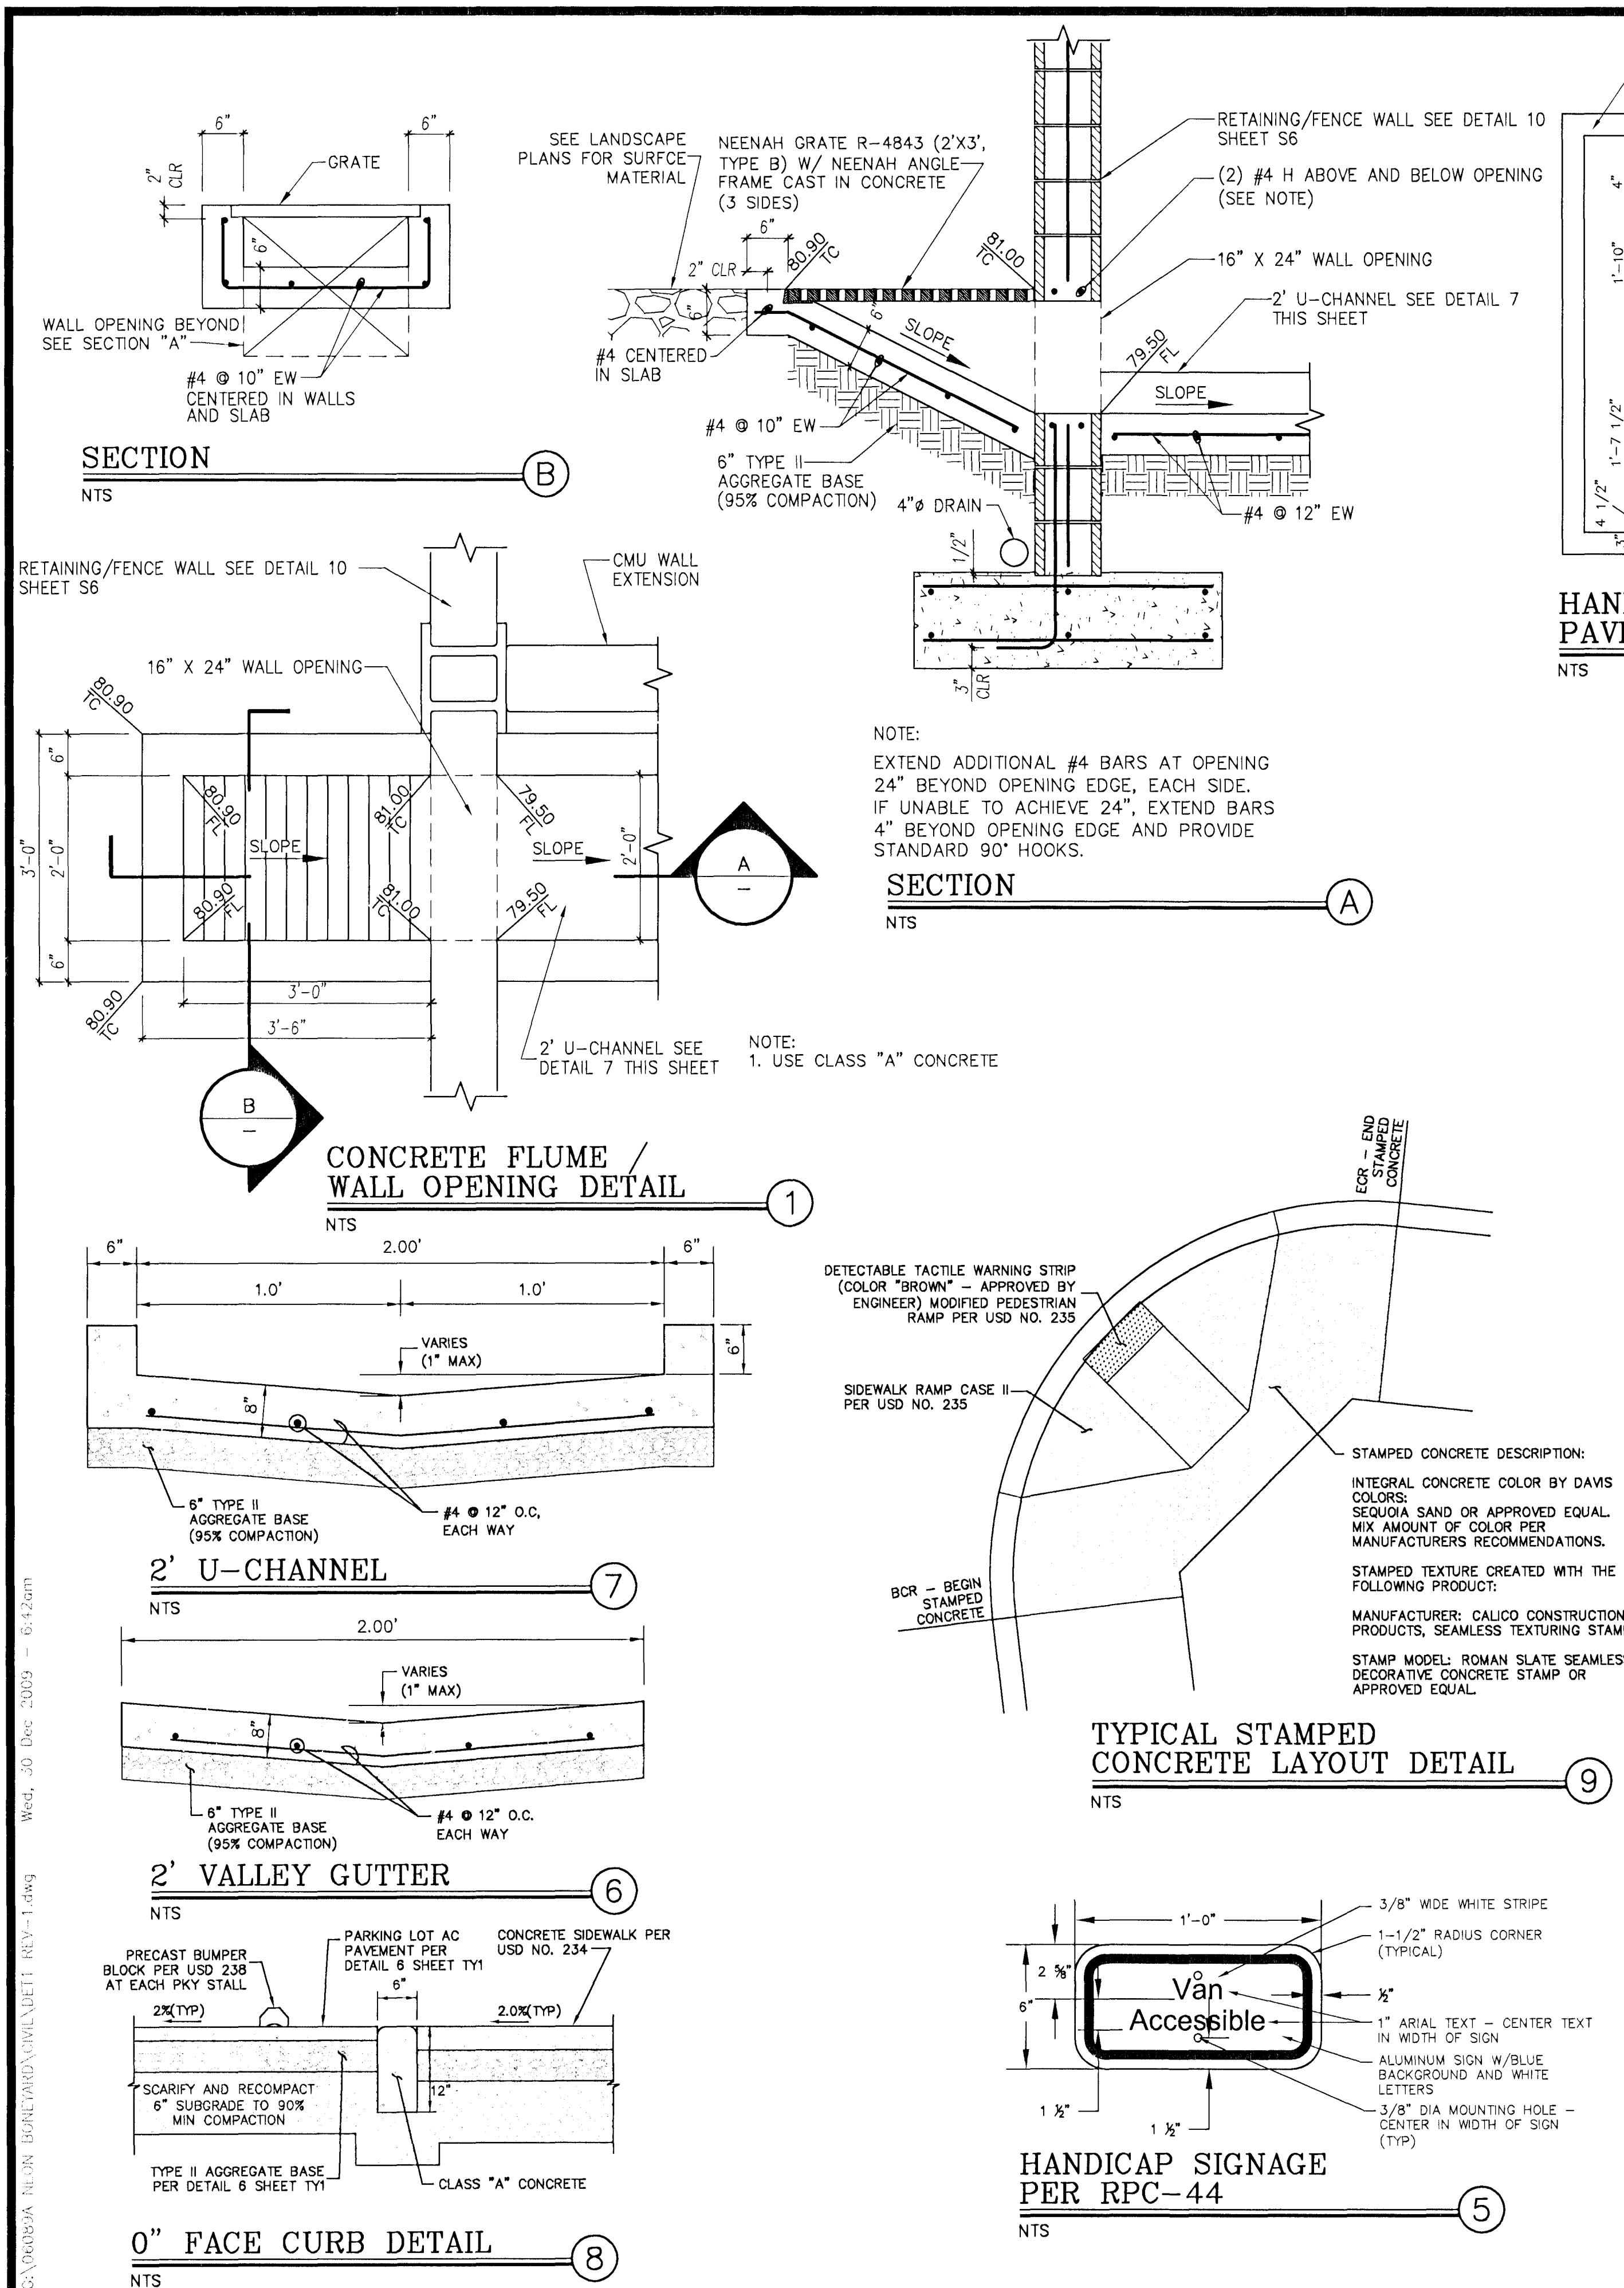



HANDICAP SYMBOL PAVEMENT MARKINGS
NTS

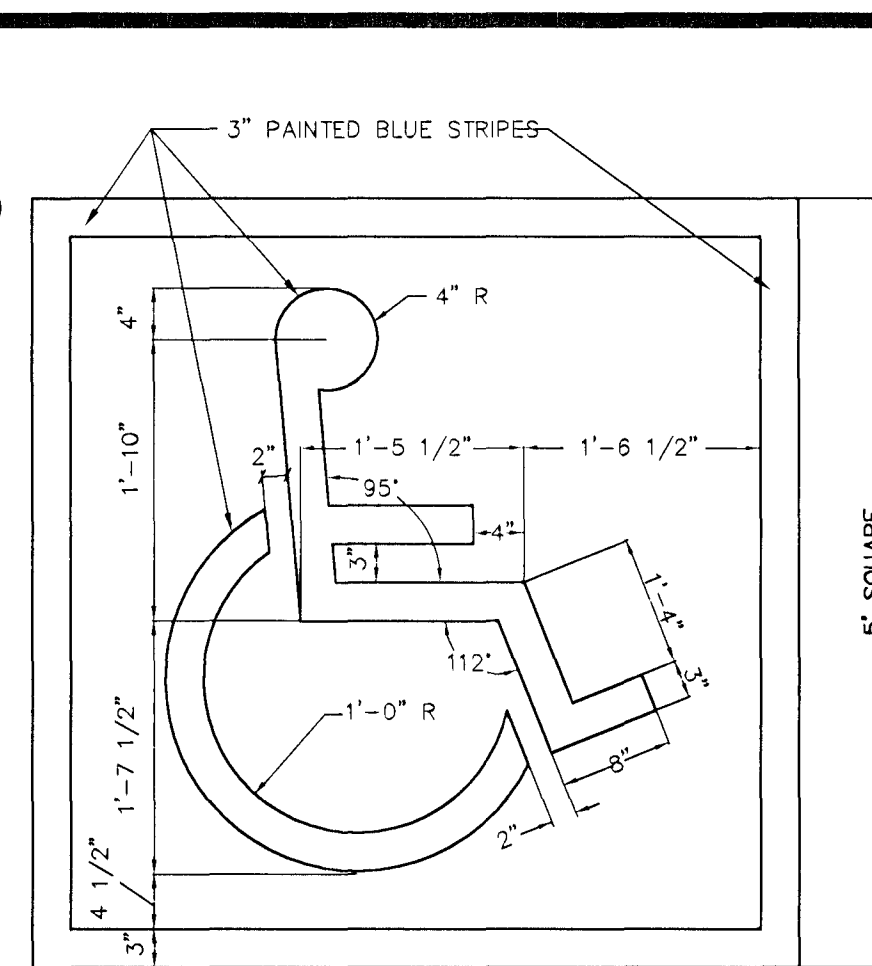

HANDICAP PARKING SIGNAGE
NTS

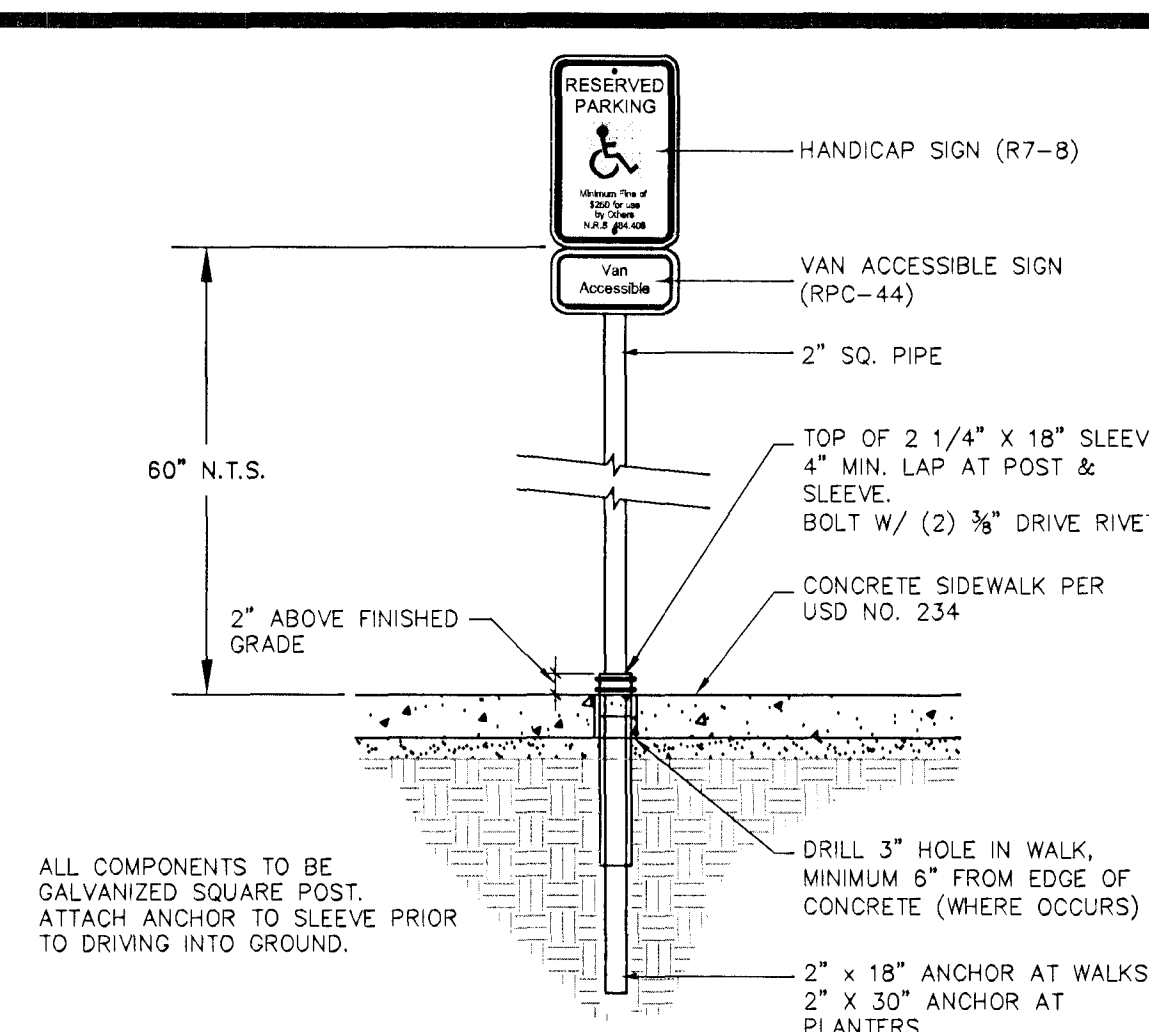

HANDICAP SIGNAGE R7-8
NTS

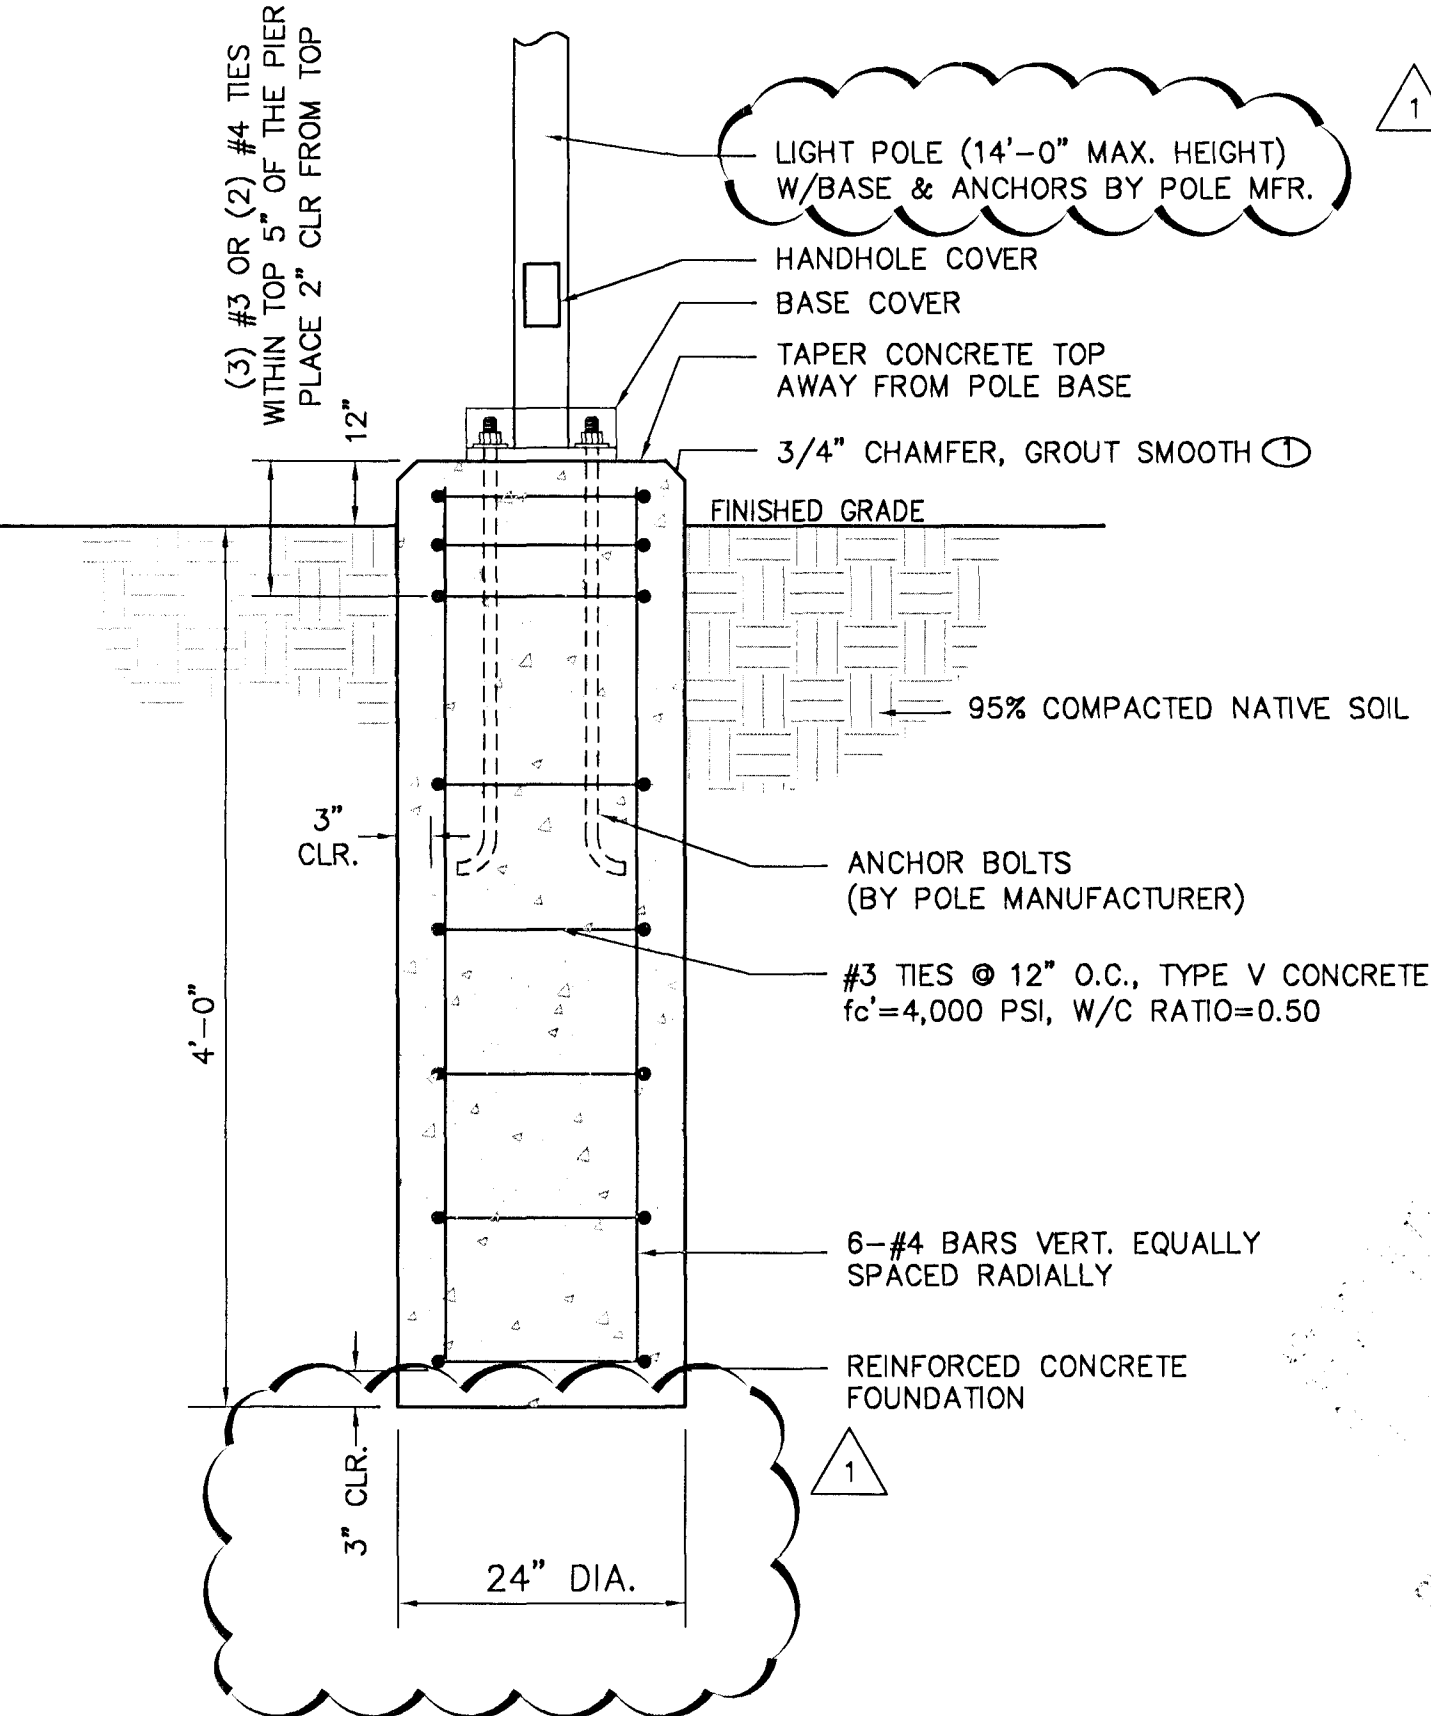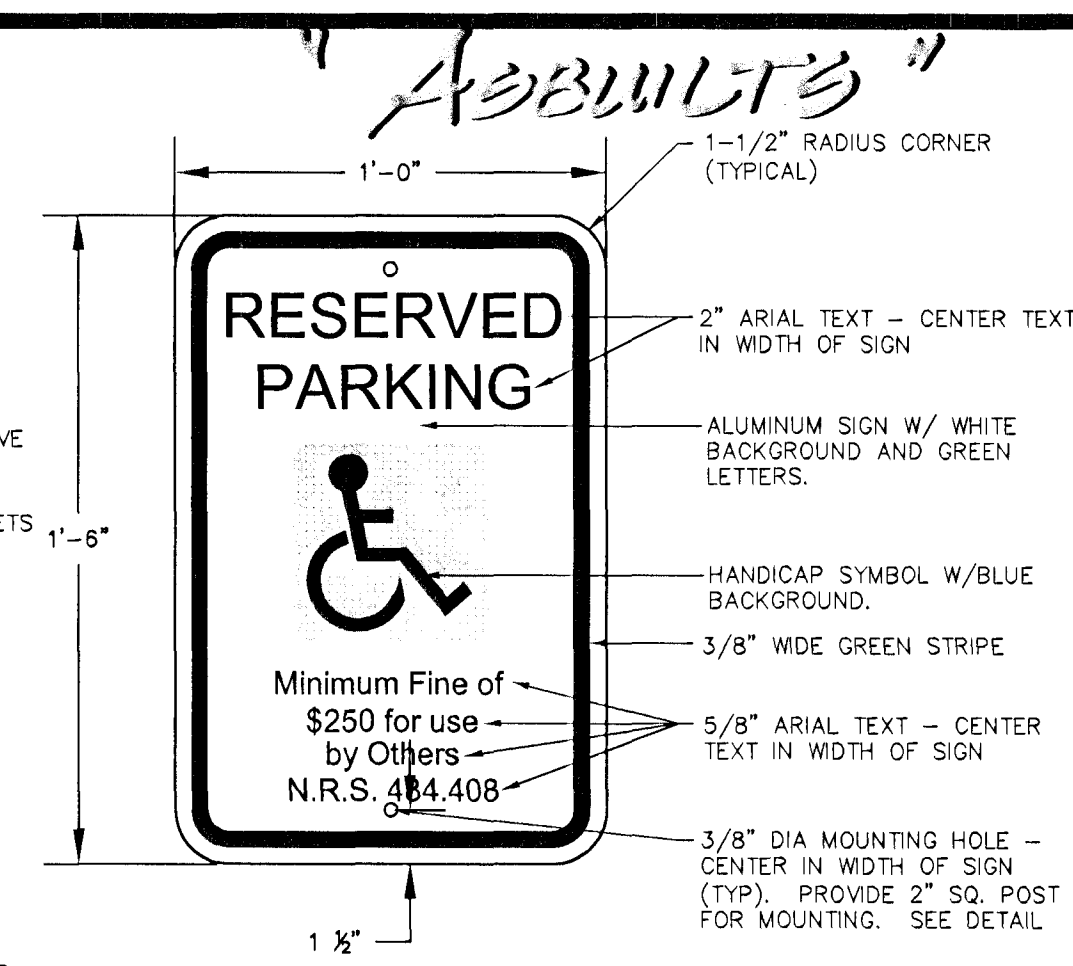


- NOTE:
- POUR ENTIRE BASE IN ONE POUR TO BASE PLATE AND SLOPE TOP AWAY FROM POLE. STRIP SONOTUBE FORMS OFF WHILE CONCRETE IS STILL GREEN (APPROXIMATELY FOUR HOURS AFTER POUR) AND STONE RUB TO PROVIDE A SMOOTH, SEAMLESS SURFACE APPEARANCE, AND THEN A LIGHT BROOM FINISH. WET CURE BASE FOR SEVEN DAYS.
 - REFER TO THE CITY OF LAS VEGAS POLE BASE STANDARDS PRIOR TO INSTALLATION. REFER TO CIVIL PLANS FOR POLE LOCATIONS.
 - REFER TO ELECTRICAL PLANS FOR ELECTRICAL FEATURES.

LIGHT POLE FOUNDATION - PARK AREA
NTS




- NOTE:
- POUR ENTIRE BASE IN ONE POUR TO BASE PLATE AND SLOPE TOP AWAY FROM POLE. STRIP SONOTUBE FORMS OFF WHILE CONCRETE IS STILL GREEN (APPROXIMATELY FOUR HOURS AFTER POUR) AND STONE RUB TO PROVIDE A SMOOTH, SEAMLESS SURFACE APPEARANCE, AND THEN A LIGHT BROOM FINISH. WET CURE BASE FOR SEVEN DAYS.
 - REFER TO THE CITY OF LAS VEGAS POLE BASE STANDARDS PRIOR TO INSTALLATION. REFER TO CIVIL PLANS FOR POLE LOCATIONS.
 - REFER TO ELECTRICAL PLANS FOR ELECTRICAL FEATURES.

LIGHT POLE FOUNDATION - PARKING LOT
NTS

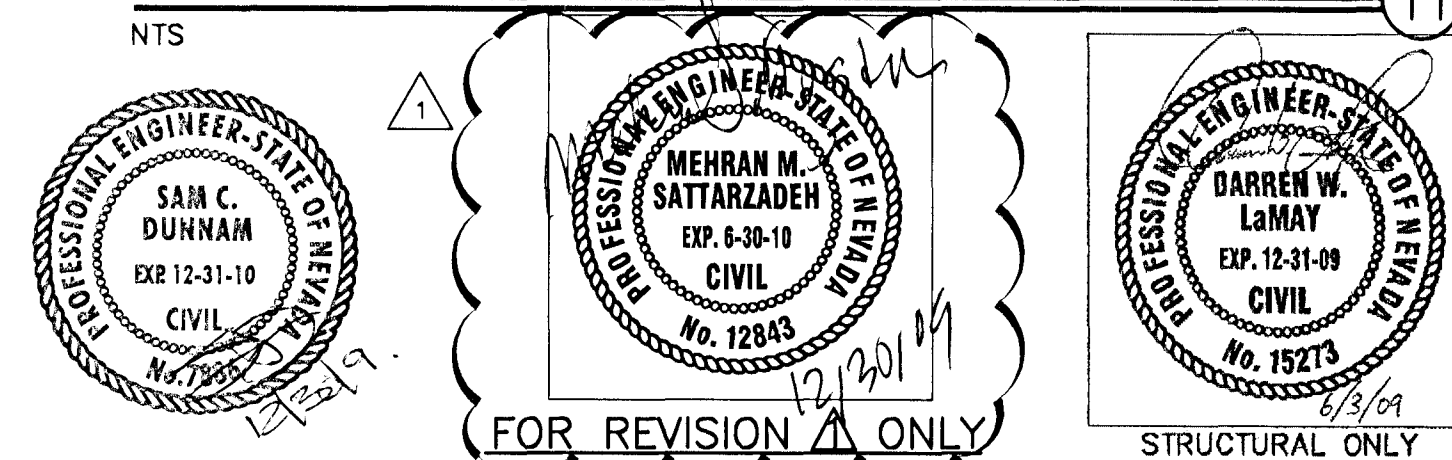

TITLE: NEON BONEYARD PARK CITY OF LAS VEGAS

DRAWN BY: BMR/BKB/BAM 5/4/09
DESIGNED BY: BMR/BKB/BAM 5/4/09
CHECKED BY: WK/SCD 5/4/09
PROJECT NO: 06089C
SCALE: N.T.S.

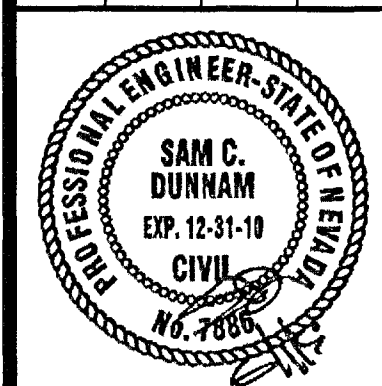

Sheet DT1
11 of 37
CLV DRAWING NO. 676-12

REVISIONS	NO.	DATE	DESCRIPTION	APP'D
	1	10/13/09	REVISED DETAIL 10 & 11	

DEPARTMENT OF PUBLIC WORKS
400 EAST STEWART
LAS VEGAS, NEVADA 89101
(702) 229-6276

poggemeyer
design group, inc.
6965 S. Rasmussen #110 • Las Vegas, NV 89128 • P: 702.226.8109 • F: 702.226.8379

DETAIL SHEET