
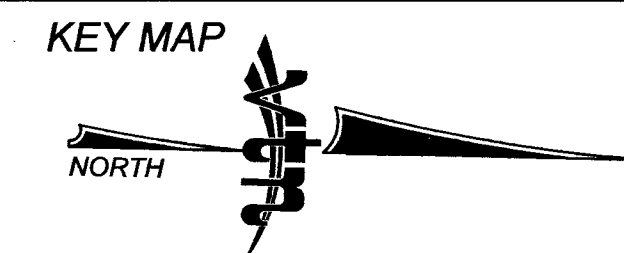


LVVWD NOTES LVVWD PROJECT NO. 114809


- ALL WATER SERVICES TO BE PROTECTED IN PLACE. IN THE EVENT A SERVICE IS DAMAGED REFER TO NOTE 2 FOR RECONNECTING. ALL SERVICES SHALL HAVE 18" CLEARANCE FROM TOP OF STORM DRAIN WHILE MAINTAINING EXISTING COVER (30" MIN.). ANY EXCEPTIONS WILL REQUIRE THE SERVICE BE PLACED IN A 2" SCH 40 PVC SLEEVE WITH A MINIMUM OF 12" COVER. ANY SERVICES PLACED IN A PVC SLEEVE MUST BE UNDAMAGED COPPER INSTALLED PER NOTE 2.
- ALL SERVICE LATERALS TWO (2) INCHES AND SMALLER THAT ARE CUT OR DAMAGED MAY BE RECONNECTED PROVIDED THE FOLLOWING CRITERIA ARE MET:
 - IF THE LATERAL IS COPPER, THE LATERAL MAY BE CUT AND SPLICED NOT MORE THAN ONCE IN A MANNER APPROVED BY THE DISTRICT.
 - IF THE LATERAL IS NOT COPPER, THE LATERAL MUST BE ABANDONED FROM THE EXISTING WATER MAIN, HAVE THE CORPORATION STOP TURNED OFF AT THE MAIN, AND A MINIMUM OF TWELVE (12) INCHES OF THE LATERAL CUT OUT NEAR THE CORPORATION STOP AND A BRASS CAP INSTALLED ON THE CORPORATION STOP. IF THE CORPORATION STOP IS DAMAGED BEYOND REPAIR OR PULLED FROM THE EXISTING WATER MAIN, THE MAIN SHALL BE REPAIRED AT THE CONTRACTOR'S EXPENSE, IN A MANNER APPROVED BY THE LVVWD. IF THE CORPORATION STOP IS NOT WATER TIGHT THE CONTRACTOR SHALL NOTIFY LVVWD COMMUNICATIONS SUPPORT CENTER (702-258-7171) FOR FURTHER DIRECTION.

- THE CONTRACTOR SHALL INSTALL A NEW SERVICE OF LIKE SIZE ADJACENT TO THE DAMAGED SERVICE IN ACCORDANCE WITH UDACS PLATE NO. 18 OR 1D.
- WHEREVER A WATERLINE IS ABOVE A STORM DRAIN OR SEWER WHERE COMPACTION REQUIREMENTS UNDER A WATERLINE CANNOT BE MET (30" OR LESS SEPARATION) BACKFILL TRENCH WITH CLASS 1 / CLASS II CONTROLLED LOW STRENGTH MATERIAL (CLSM) WITH BOND BREAKER TO THE SPRINGLINE OF THE WATERLINE. THIS REQUIREMENT IS FOR STRUCTURAL SUPPORT ONLY. ADDITIONAL HEALTH REGULATIONS MAY APPLY PER UDACS 2.19.
- CONTRACTOR MUST SUBMIT SHOP DRAWINGS TO LVVWD BEFORE CONSTRUCTION TO SHOW HOW WATERLINES SPANNING A TRENCH WILL BE SUPPORTED DURING EXCAVATION & BACKFILL. DRAWINGS WILL INCLUDE ALL LOCATIONS WHERE WATERLINES SPAN A TRENCH GREATER THAN FOUR (4) FEET WIDE.
- DISPOSAL OF ASBESTOS CEMENT PIPE SHALL BE IN ACCORDANCE WITH AWWA, LOCAL, STATE, AND FEDERAL REGULATIONS.
- ADJUST ALL WATER VALVE BOXES TO FINISHED GRADE PER UDACS PLATE NO. 8. ALL VALVES SHALL BE ACCESSIBLE AT ALL TIMES.

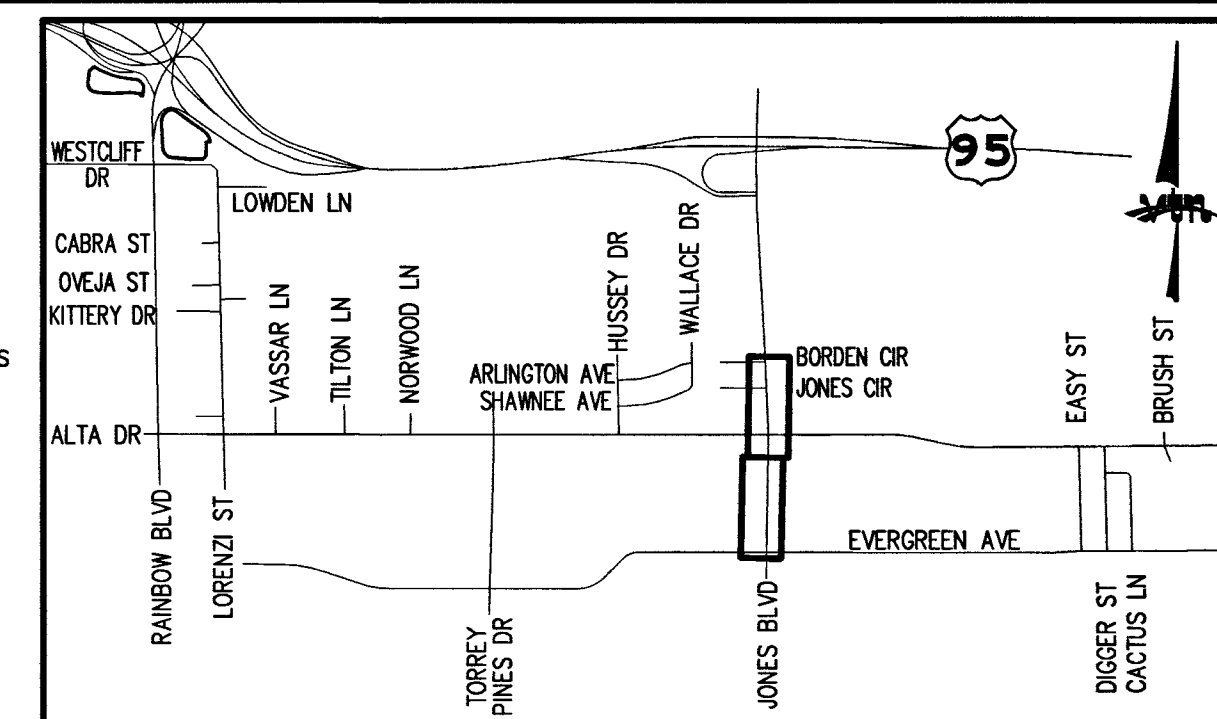

CONSTRUCTION NOTES



- PROTECT IN PLACE
- SAWCUT AND MATCH EXISTING
- CONSTRUCT PAVEMENT STRUCTURAL SECTION NO. 3, SEE SHEET T4
- ADJUST WATER VALVE TO FINISHED GRADE PER UDACS STD PLATE NO. 8
- ADJUST SEWER MANHOLE TO FINISHED GRADE PER DCSWCS STD DWG NO. SD-6
- INSTALL 48" SANITARY SEWER MANHOLE (SEE SHEET SS4 FOR RELOCATION PLAN & PROFILE)
- INSTALL 8" SANITARY SEWER MAIN (SEE SHEET SS4 FOR RELOCATION PLAN & PROFILE)
- RELOCATE EXISTING 250W STREETLIGHT W/BASE PLATE ADAPTER TO NEW FOUNDATION AT "JB" 10+37.13, 40.50' LT. CONSTRUCT TYPE "H" FOUNDATION PER USDCCA STD DWG NO. 404.208 INTERCEPT EXISTING STLT CONDUIT AND CONNECT TO EX. STLT CIRCUIT
- RELOCATE EXISTING 14" WATERLINE PER UDACS STANDARDS, SPECIAL PROVISIONS AND PLAN & PROFILE ON SHEET W1
- RELOCATE EXISTING 6" WATERLINE PER UDACS STANDARDS, SPECIAL PROVISIONS AND PLAN & PROFILE ON SHEET W2
- ADJUST STORM DRAIN MANHOLE TO GRADE PER USDCCA STD DWG. NO. 408.
- REPLACE EXISTING 12" ACP WATERLINE WITH 12" DUCTILE IRON PIPE WATERLINE ACROSS RCP TRENCH SECTION PER UDACS STANDARDS AND SPECIAL PROVISIONS SEE PROFILE ON SHEET W2
- REPLACE EXISTING 14" ACP WATERLINE WITH 14" DUCTILE IRON PIPE WATERLINE ACROSS RCP TRENCH SECTION PER UDACS STANDARDS AND SPECIAL PROVISIONS SEE PROFILE ON SHEET W2, W4 & W5
- INSTALL 14" GATE VALVE PER UDACS STD PLATE NO'S 3 & 8

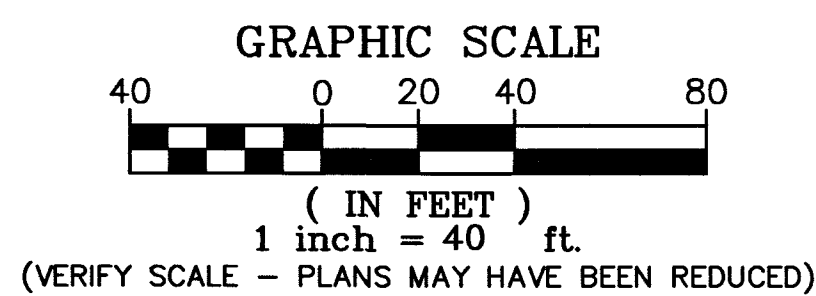

SHEET NOTES

- REFER TO SHEET T2 FOR ADDITIONAL LAS VEGAS VALLEY WATER DISTRICT NOTES.
- REFER TO SHEETS T1 THRU T4 FOR TYPICAL ROADWAY SECTIONS

NOTE:
ALL PROPOSED SHUTDOWNS TO BE PERFORMED SEPARATELY.

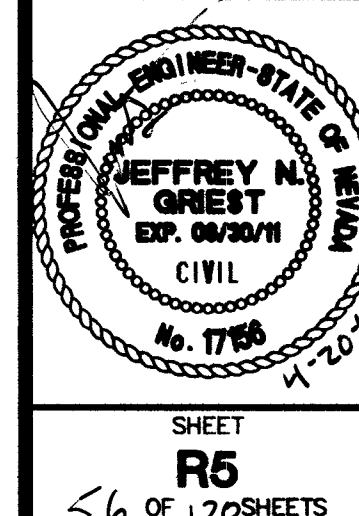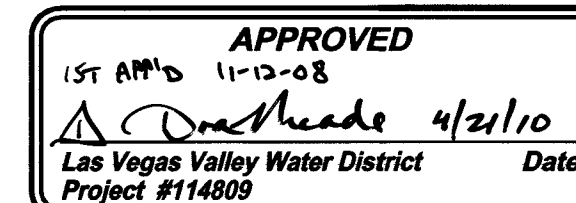

DEPARTMENT OF PUBLIC WORKS



ROADWAY & UTILITY PLAN
JONES BOULEVARD
"JB" 9+60.00 TO "JB" 29+60.00
MEADOWS ALTA PARALLEL PROJECT
PHASE II

DRAWN BY: NOV 10, 2008
DESIGNED BY: NOV 10, 2008
CHECKED BY: NOV 10, 2008
PROJECT NO: SCALE: HORIZ. 1"=40'
VERT. NONE

2727 SOUTH RAINBOW BOULEVARD
LAS VEGAS, NEVADA 89146-5148
400 E. STEWART AVE.
LAS VEGAS, NV 89101
TEL: 702-258-7550
FAX: 702-258-7550
WEB SITE: WWW.VTNV.COM

108120wvDESIGN6812 Road Design.dwg 2010-04-20 1:42pm