


SITE PLAN SUBMITTAL
FOR
**MOUNTAINVIEW HOSPITAL
EXPANSION & RENOVATIONS**
TO BE CONSTRUCTED AT
3100 N TENAYA WAY, LAS VEGAS, NEVADA
MAY 2016

Allen Pavelka 10-26-16
ALLEN PAVELKA, PE #9029 D: TE
CITY ENGINEER
APPROVAL OF THESE PLANS BY THE CITY ENGINEER IS LIMITED TO THOSE IMPROVEMENTS CONSTRUCTED IN THE DEDICATED RIGHT-OF-WAY, AND/OR CONSTRUCTION OF ANY IMPROVEMENTS THAT DEVIATE FROM ADOPTED STANDARDS AND/OR SPECIFICATIONS EXCEPT THOSE SPECIALLY LISTED UNDER DEVIATIONS FROM STANDARDS. THE ENGINEER SHALL RESOLVE ANY DEVIATION OTHER THAN THOSE LISTED IN DEVIATIONS FROM STANDARDS IN FAVOR OF UNIFORM STANDARD DRAWINGS AND SPECIFICATIONS CLARK COUNTY AREA NEVADA.
Chris Knight 10-26-16
CHRIS KNIGHT

SHEET INDEX

	SHEET NO.	SHEET TITLE
1 of 20	C0.0	Cover
2 of 20	C1.0	Existing Conditions
3 of 20	C2.0	Notes
4 of 20	C2.1	Notes
5 of 20	C3.0	Erosion Control Plans
6 of 20	C3.1	Erosion Control Plan
7 of 20	C3.2	Erosion Control Details
8 of 20	C4.0	Demolition Plan
9 of 20	C4.1	Demolition Plan
10 of 20	C5.0	Site Layout Plan
11 of 20	C5.1	Site Layout Plan
12 of 20	C5.2	Site Layout Plan
13 of 20	C6.0	Drainage Plan
14 of 20	C6.1	Grading & Utility Plan
15 of 20	C6.2	Grading & Utility Plan
16 of 20	C7.0	Details
17 of 20	C7.1	Details
18 of 20	L1.0	Site Landscape Plan
19 of 20	L1.1	Site Landscape Plan
20 of 20	L2.0	Landscape Details

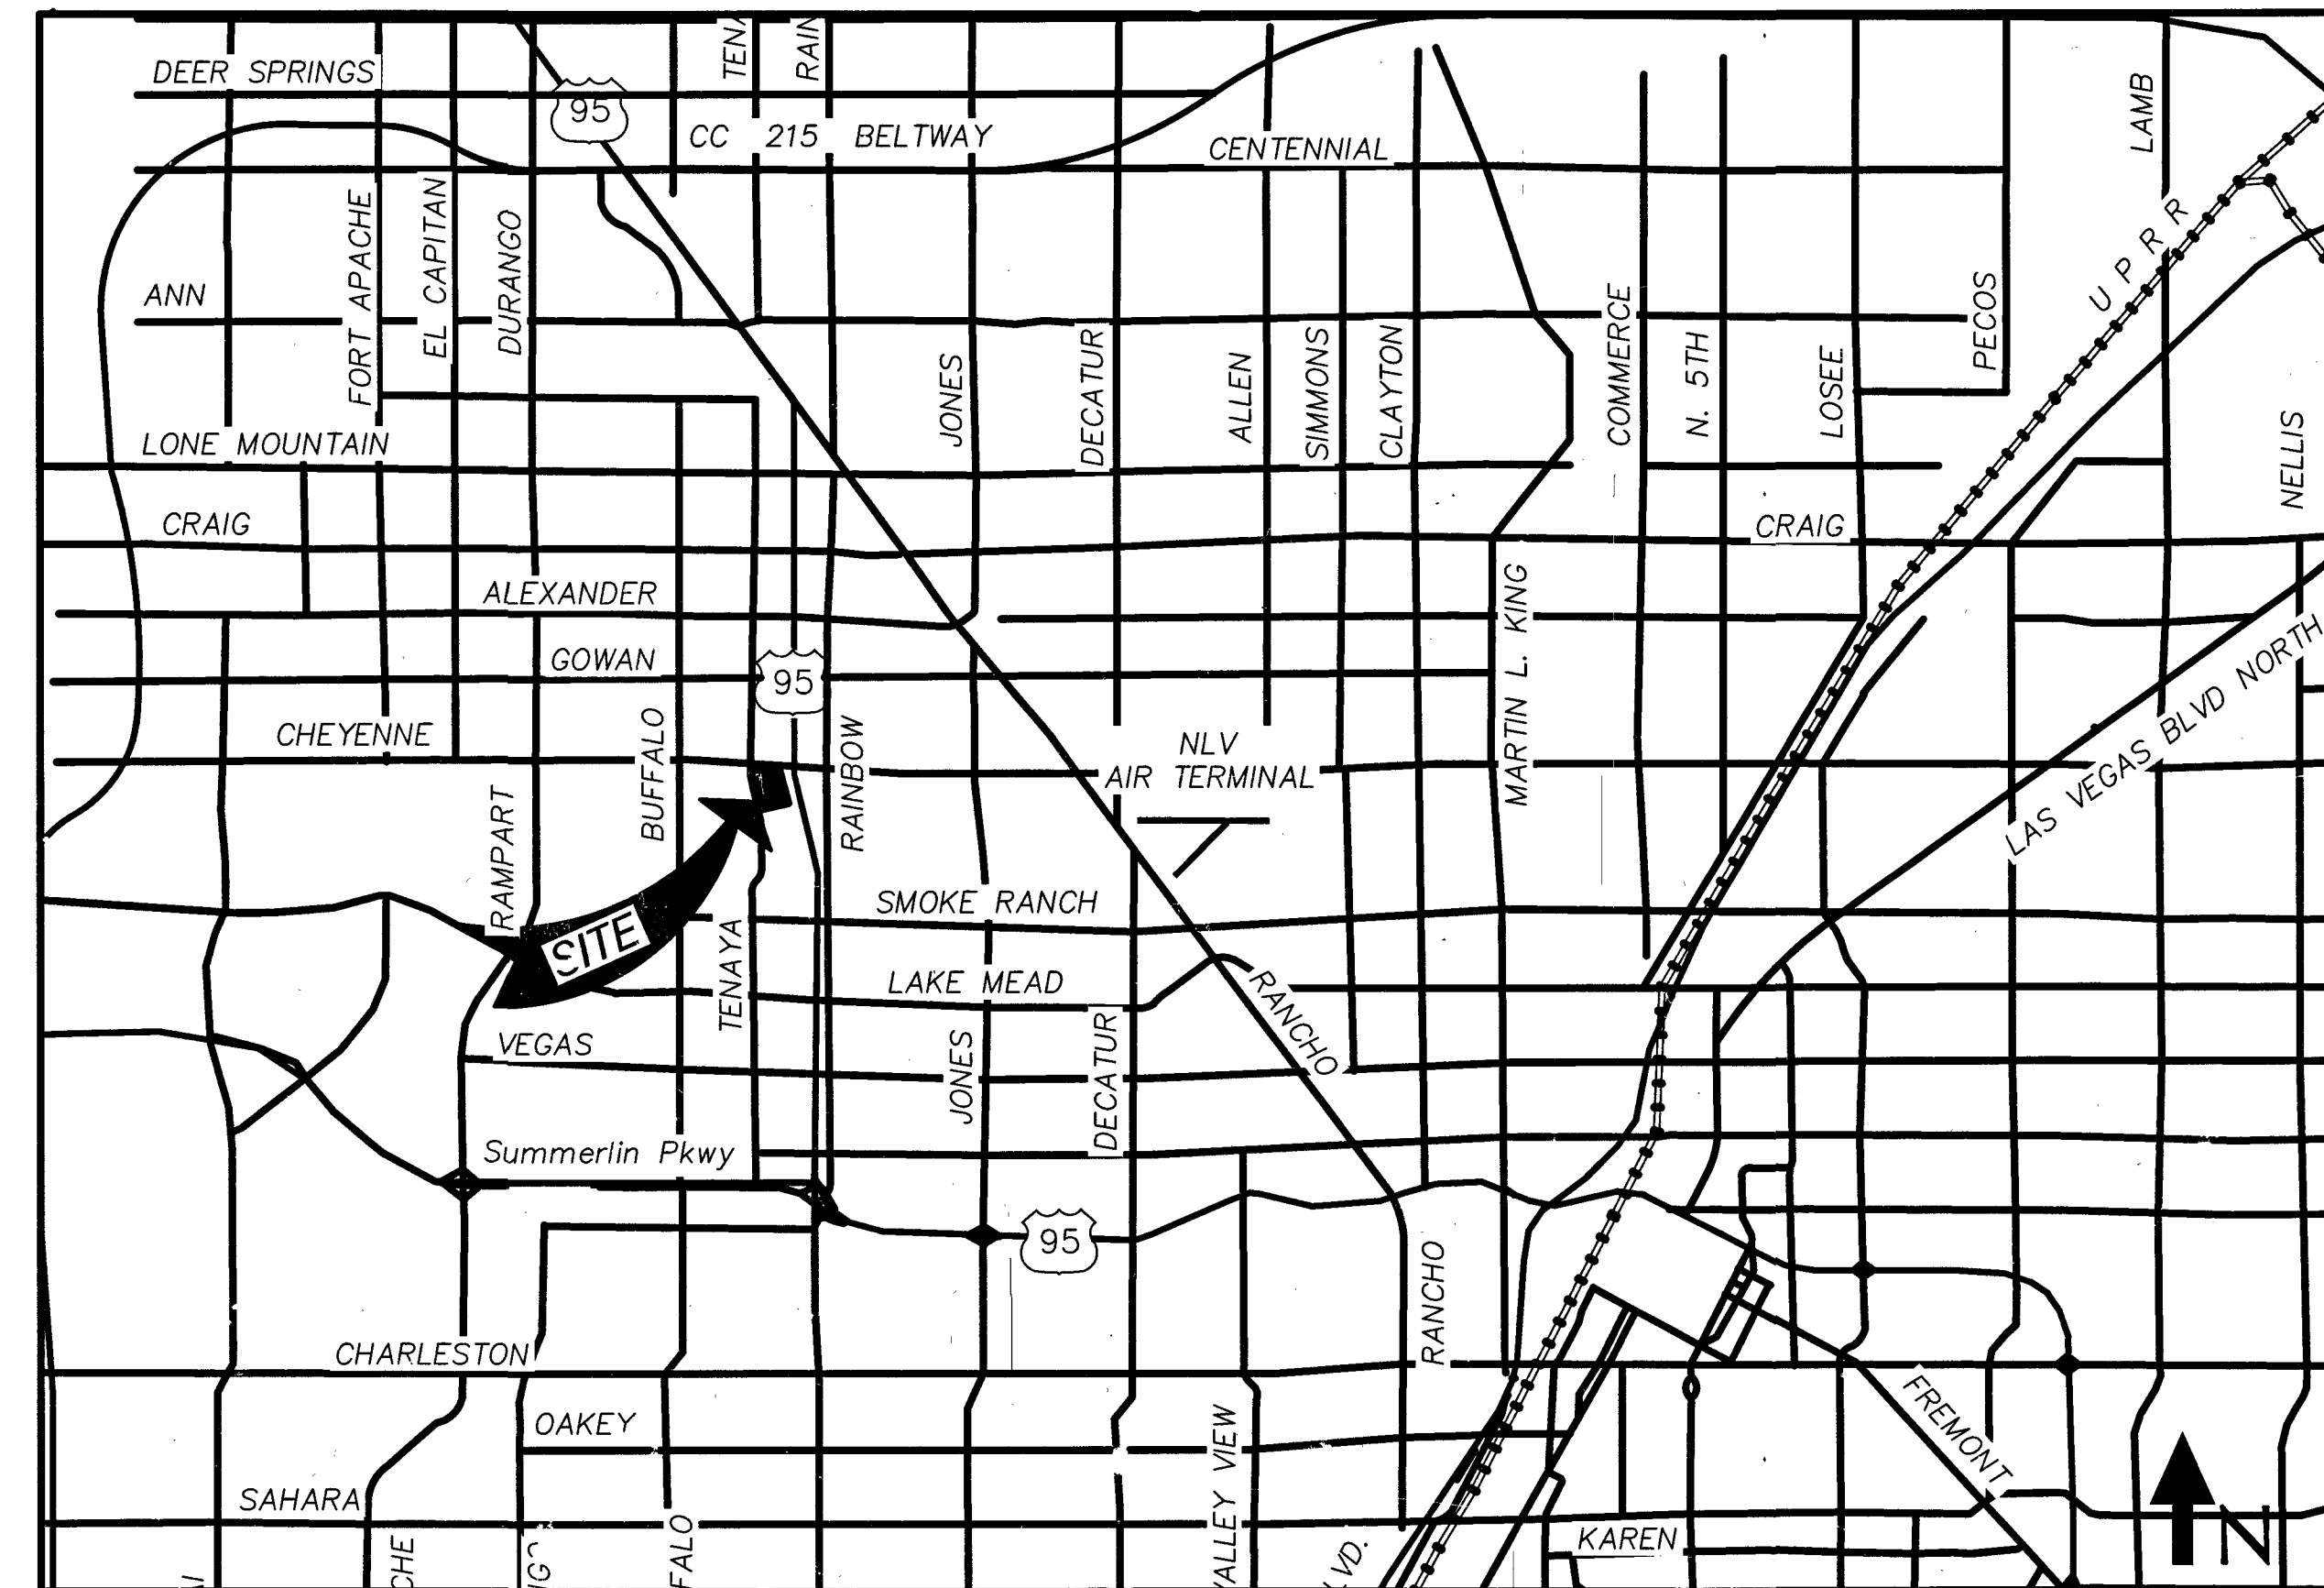

VICINITY MAP
NOT TO SCALE

PREPARED BY:

Littlejohn
An S&ME Company

1935 21st Avenue South, NASHVILLE, TENNESSEE 37212
T 615.385.4144 F 615.385.4020 www.leajoinc.com

OWNER / DEVELOPER
SUNRISE MOUNTAINVIEW HOSPITAL
3100 N TENAYA WAY
LAS VEGAS, NV 89128
P: (702) 225-5065

ASSESSORS PARCEL NUMBER
138-15-510-005

**City of Las Vegas
Plans Library Slip**

Proj. Number: 64607	Project Name: MOUNTAINVIEW HOSPITAL EXPANSION
CLV Drawing No.: 107V6732	Print Date: 10/26/16
Engineering Firm: LITTLEJOHN ENGINEERING ASSOCIATES	
Planchecker: LUIS MORALES	

New Plan

- ☒ File original
☐ One (1) Copy to Off-site Inspection and Testing
☐ Print Distribution

Sets of Prints to _____
Sets of Prints to _____

Revised Plan

- ☐ File original
☐ One (1) Copy to Off-site Inspection and Testing
☐ Print Distribution



Sets of Prints to _____
Sets of Prints to _____

Other

LEGEND

SYMBOLS	DESCRIPTIONS
	CACTUS
	FLAG
	GRID TICK
	AERIAL PANELS
	PALM TREE
	SINGLE TREE
	PEDESTRIAN SIGNAL
	CULVERT
	POST-MISC
	SPOT ELEVATION
	BILLBOARD
	TRANSMISSION
	BRIDGE SIGNS
	CATCH BASIN
	FIRE HYDRANT
	METER / UTILITY
	MANHOLE
	STREET LIGHT
	LIGHT POLE
	UTILITY POLE
	SIGNS
	SIGNS
	TV DISH
	STREET SIGN
	GATE
	TRAFFIC SIGNAL
	VALVE
	ARROW / STRAIGHT
	ARROW / TURNS
	SUBDIVISION BOUNDARY
	LOT LINE
	SECTION LINE
	STREET CENTERLINE
	EXISTING PROPERTY LINES
	EASEMENT LINE
	RIGHT-OF-WAY LINE
	ADJOINING PROPERTY LINE
	CURVE NUMBER
	LINE NUMBER
	WATER LINE
	UNDERGROUND POWER LINE
	NATURAL GAS LINE
	SANITARY SEWER LINE
	SANITARY SEWER MANHOLE
	STORM DRAIN LINE
	STORM DRAIN MANHOLE

Page 1 of 1

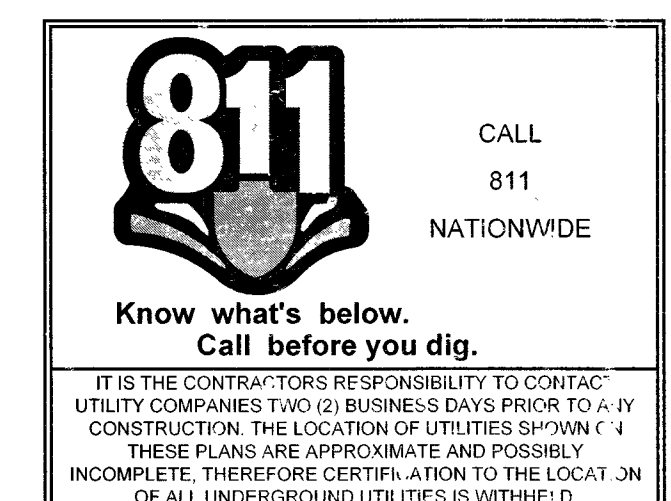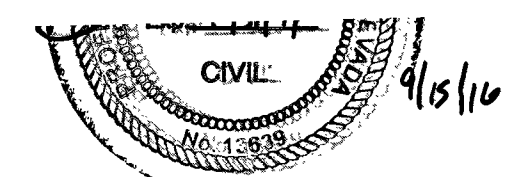

LEA PROJECT IDENTIFICATION # 20151197

COVER

107V6732 H#64607 SHEET 1 OF 20

C0.0