




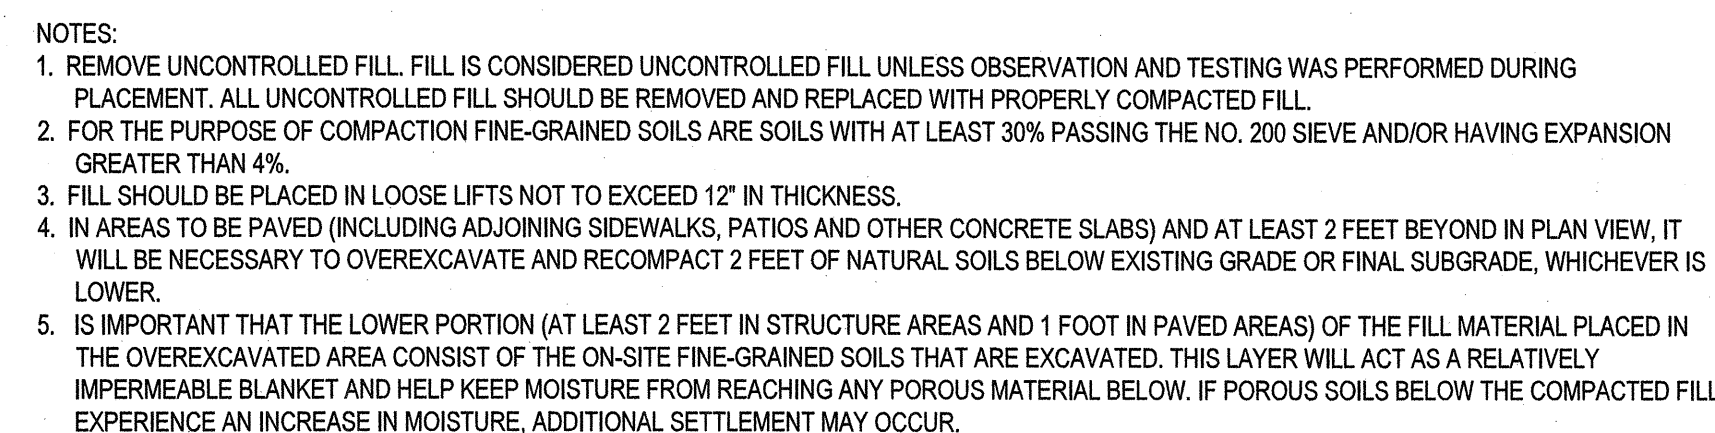


NOT TO SCALE

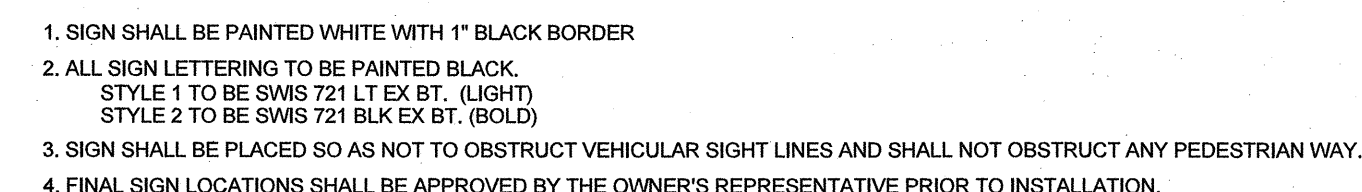


NOT TO SCALE

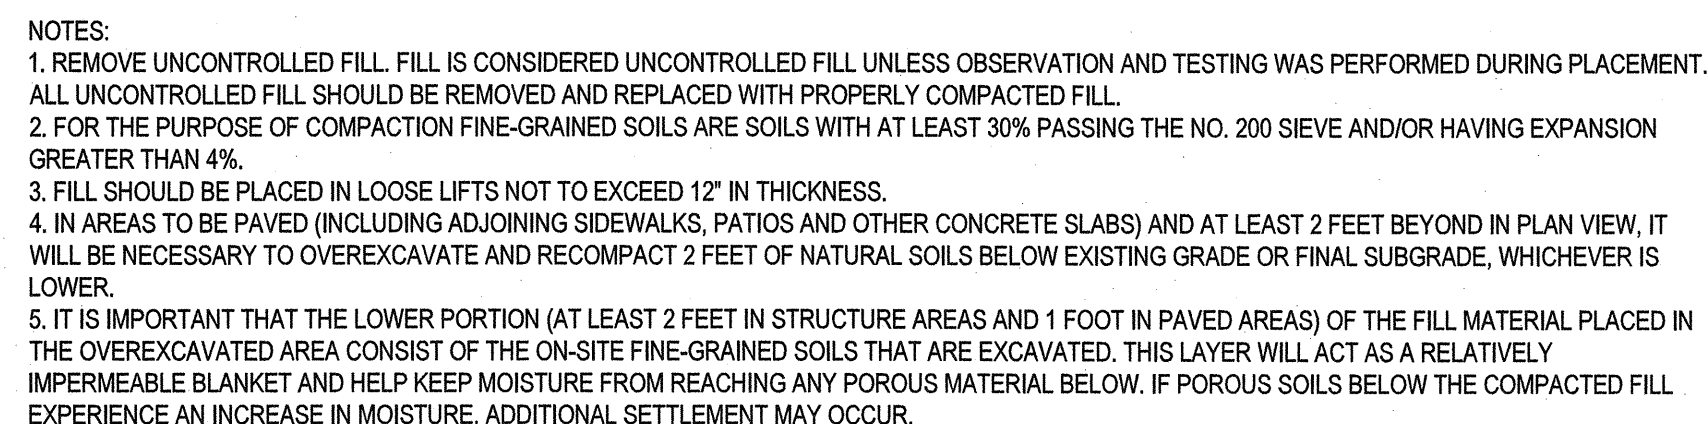


NOT TO SCALE

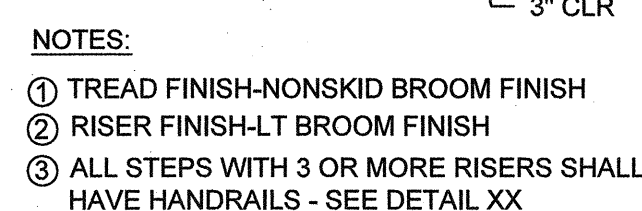

NOT TO SCALE

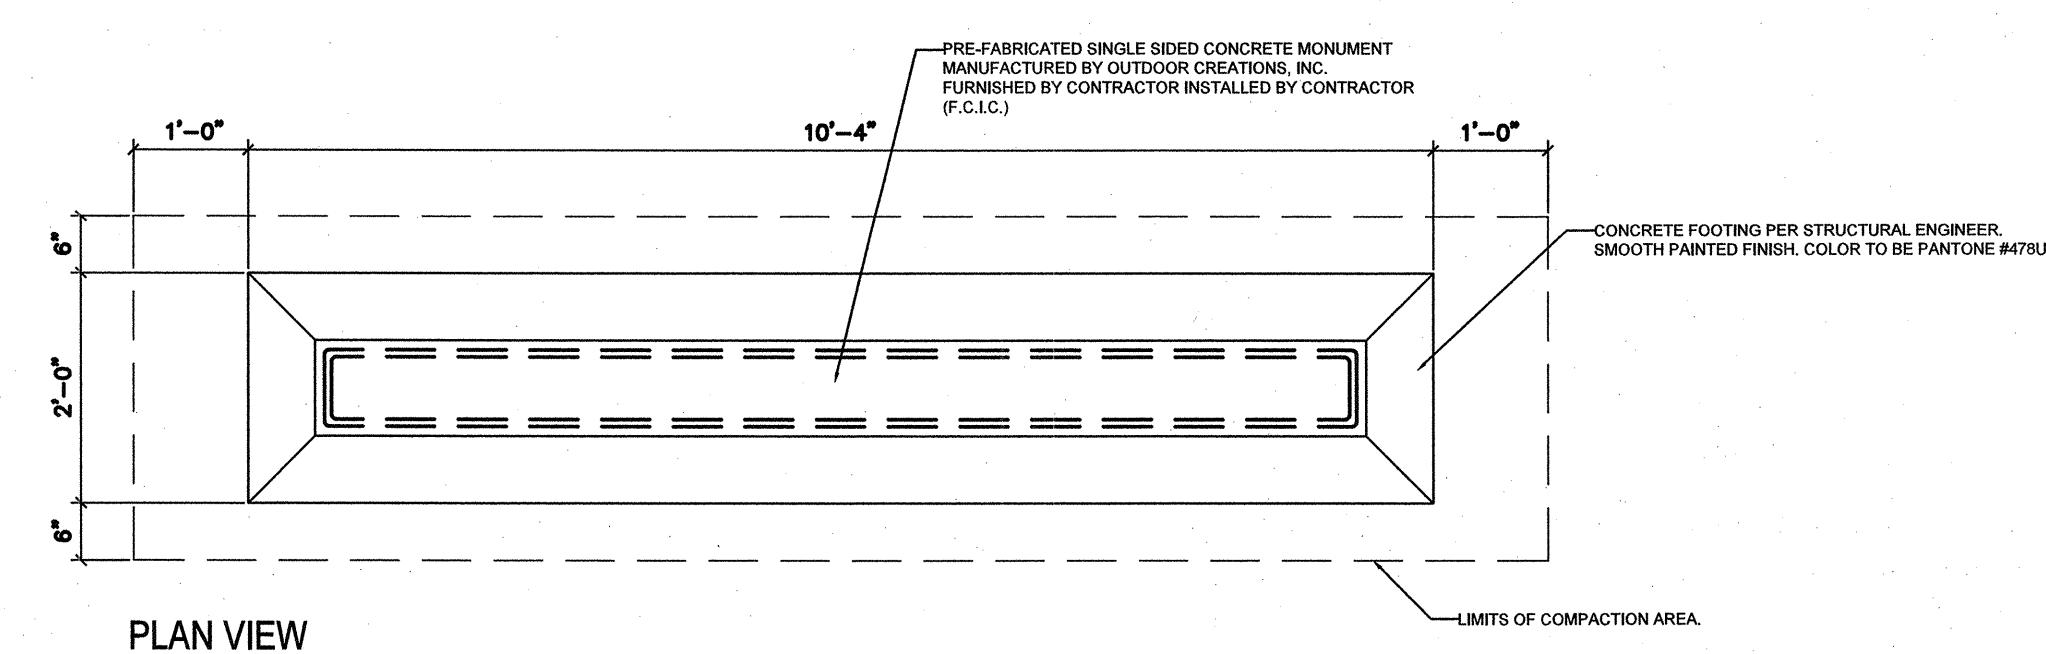


NOT TO SCALE

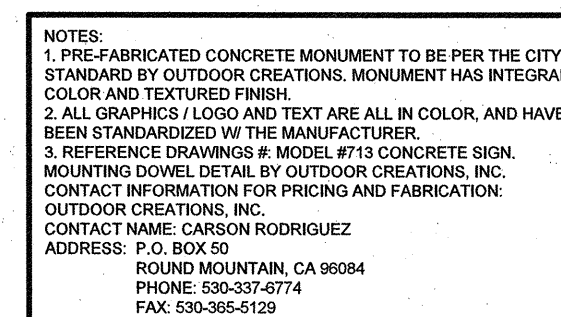

Concrete Sign Mounting Dowel Detail

MAYFAIR PLACE PARK

DETAILS

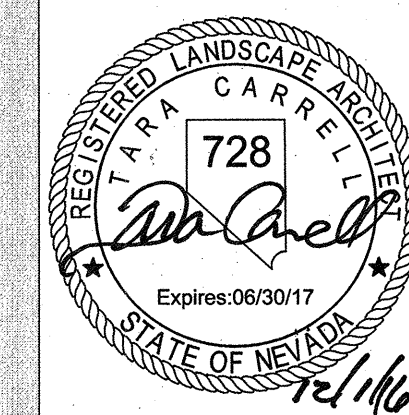

OWNER: CITY OF LAS VEGAS
DEPARTMENT OF PUBLIC WORKS

400 EAST STEWART AVENUE
LAS VEGAS, NEVADA 89101
PHONE: (702) 229-6535
FAX: (702) 382-3232
TDD: (702) 386-9108

DRAWN	TCC
FILE	1000 CD DETAILS 1 1 01 1 06 DWG

DATE 2016-11-30

SCALE	N/A
-------	-----

BID NO	15.5981
--------	---------

CLV DWG NO	650.111
------------	---------

11" 00004


11# 0002-4

L.1.01


REVISÉ 8/27/03




6 DOG WALKER SIGN NOT TO SCALE

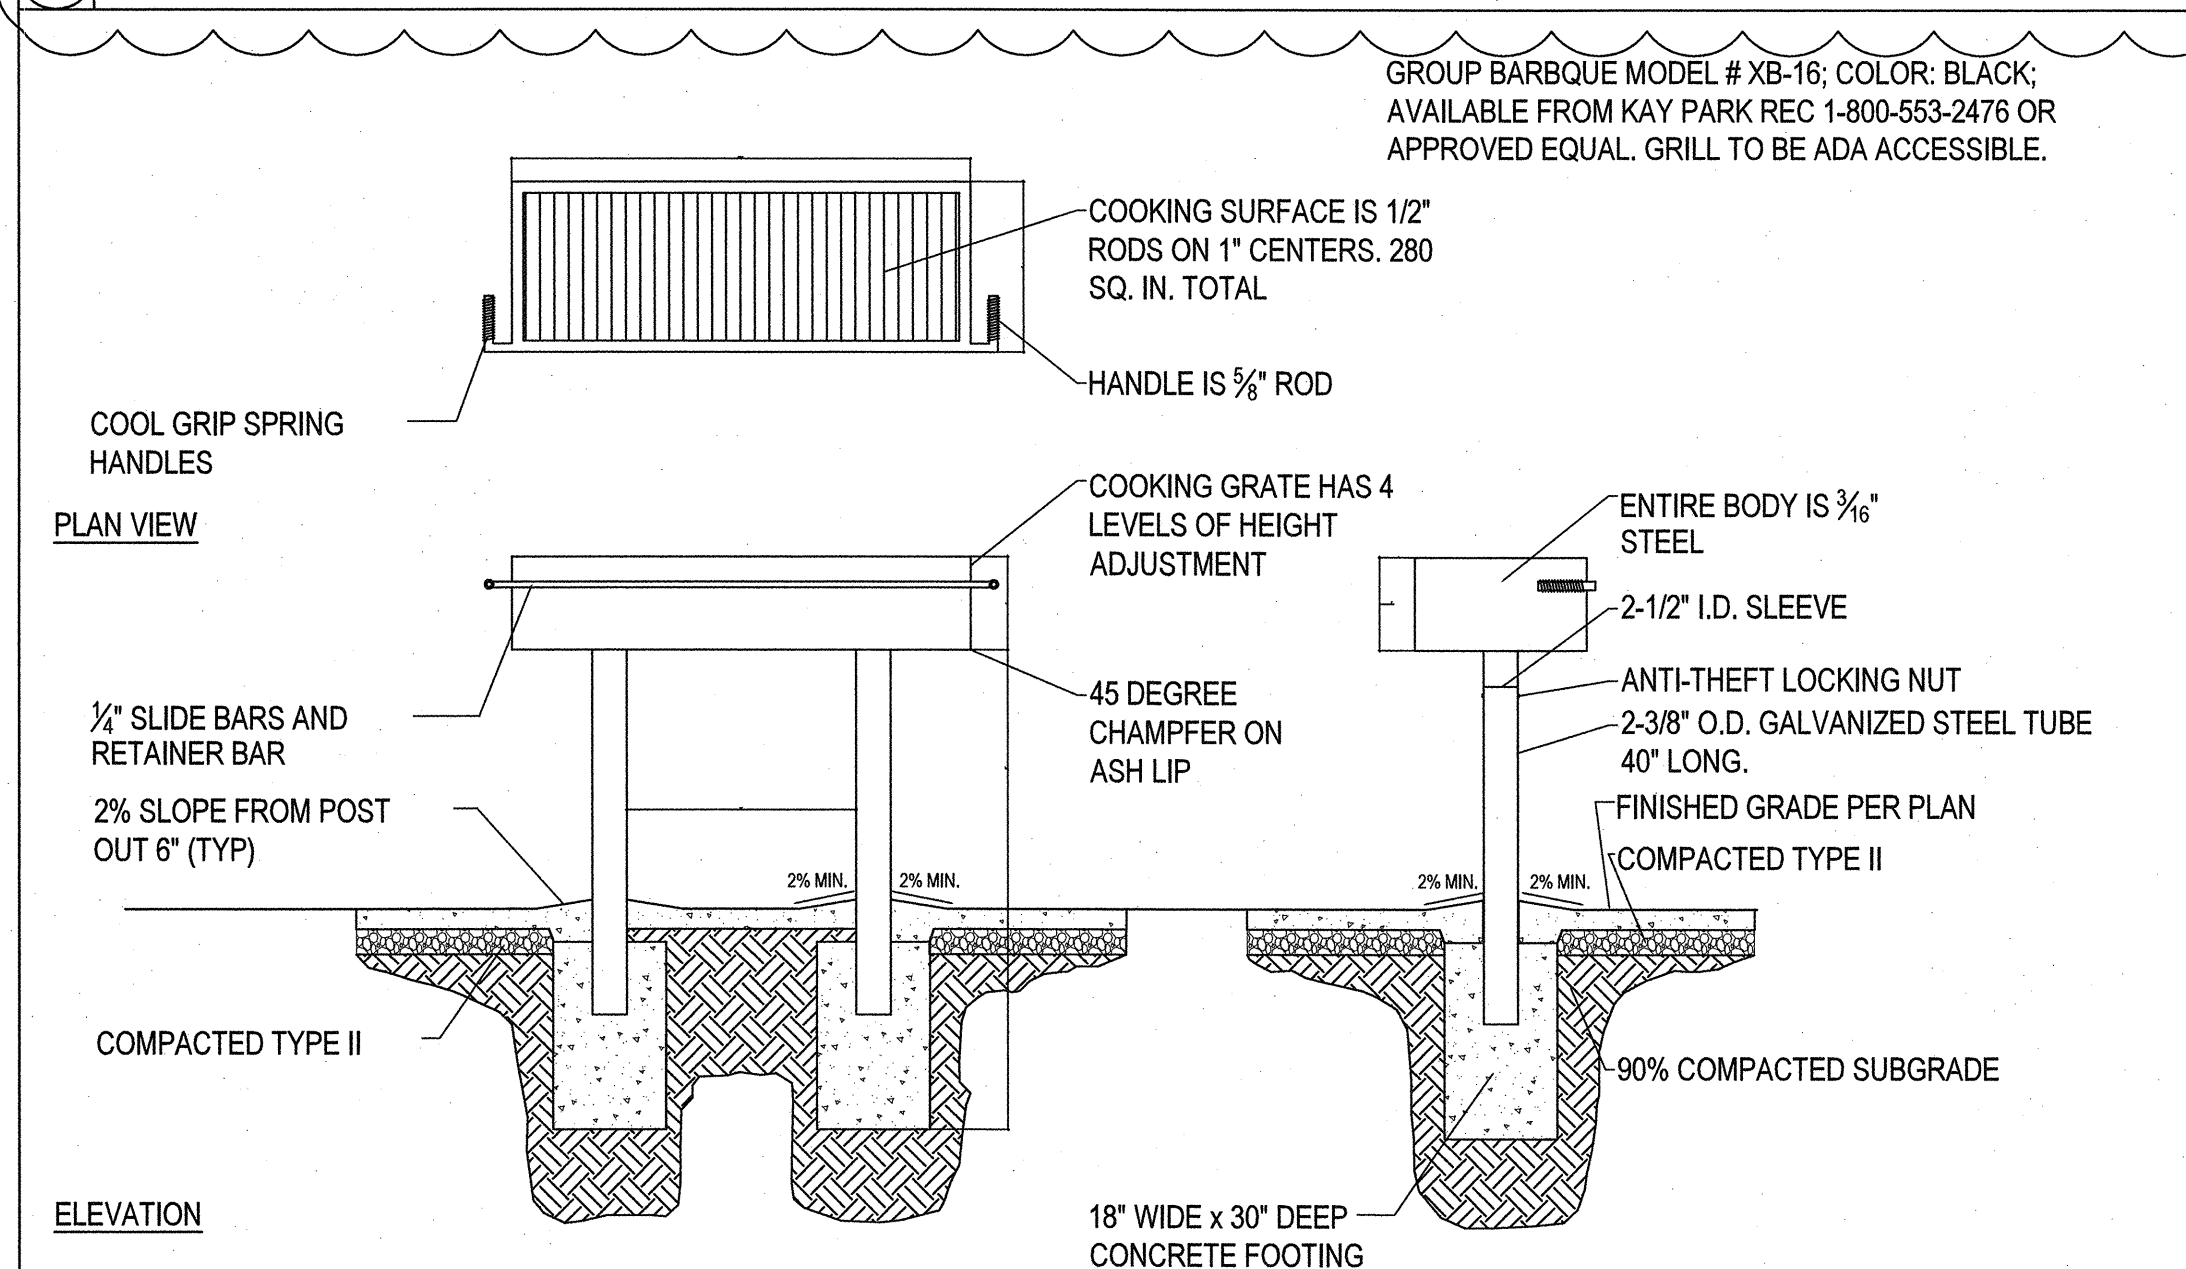


7 GROUP BARBQUE NOT TO SCALE

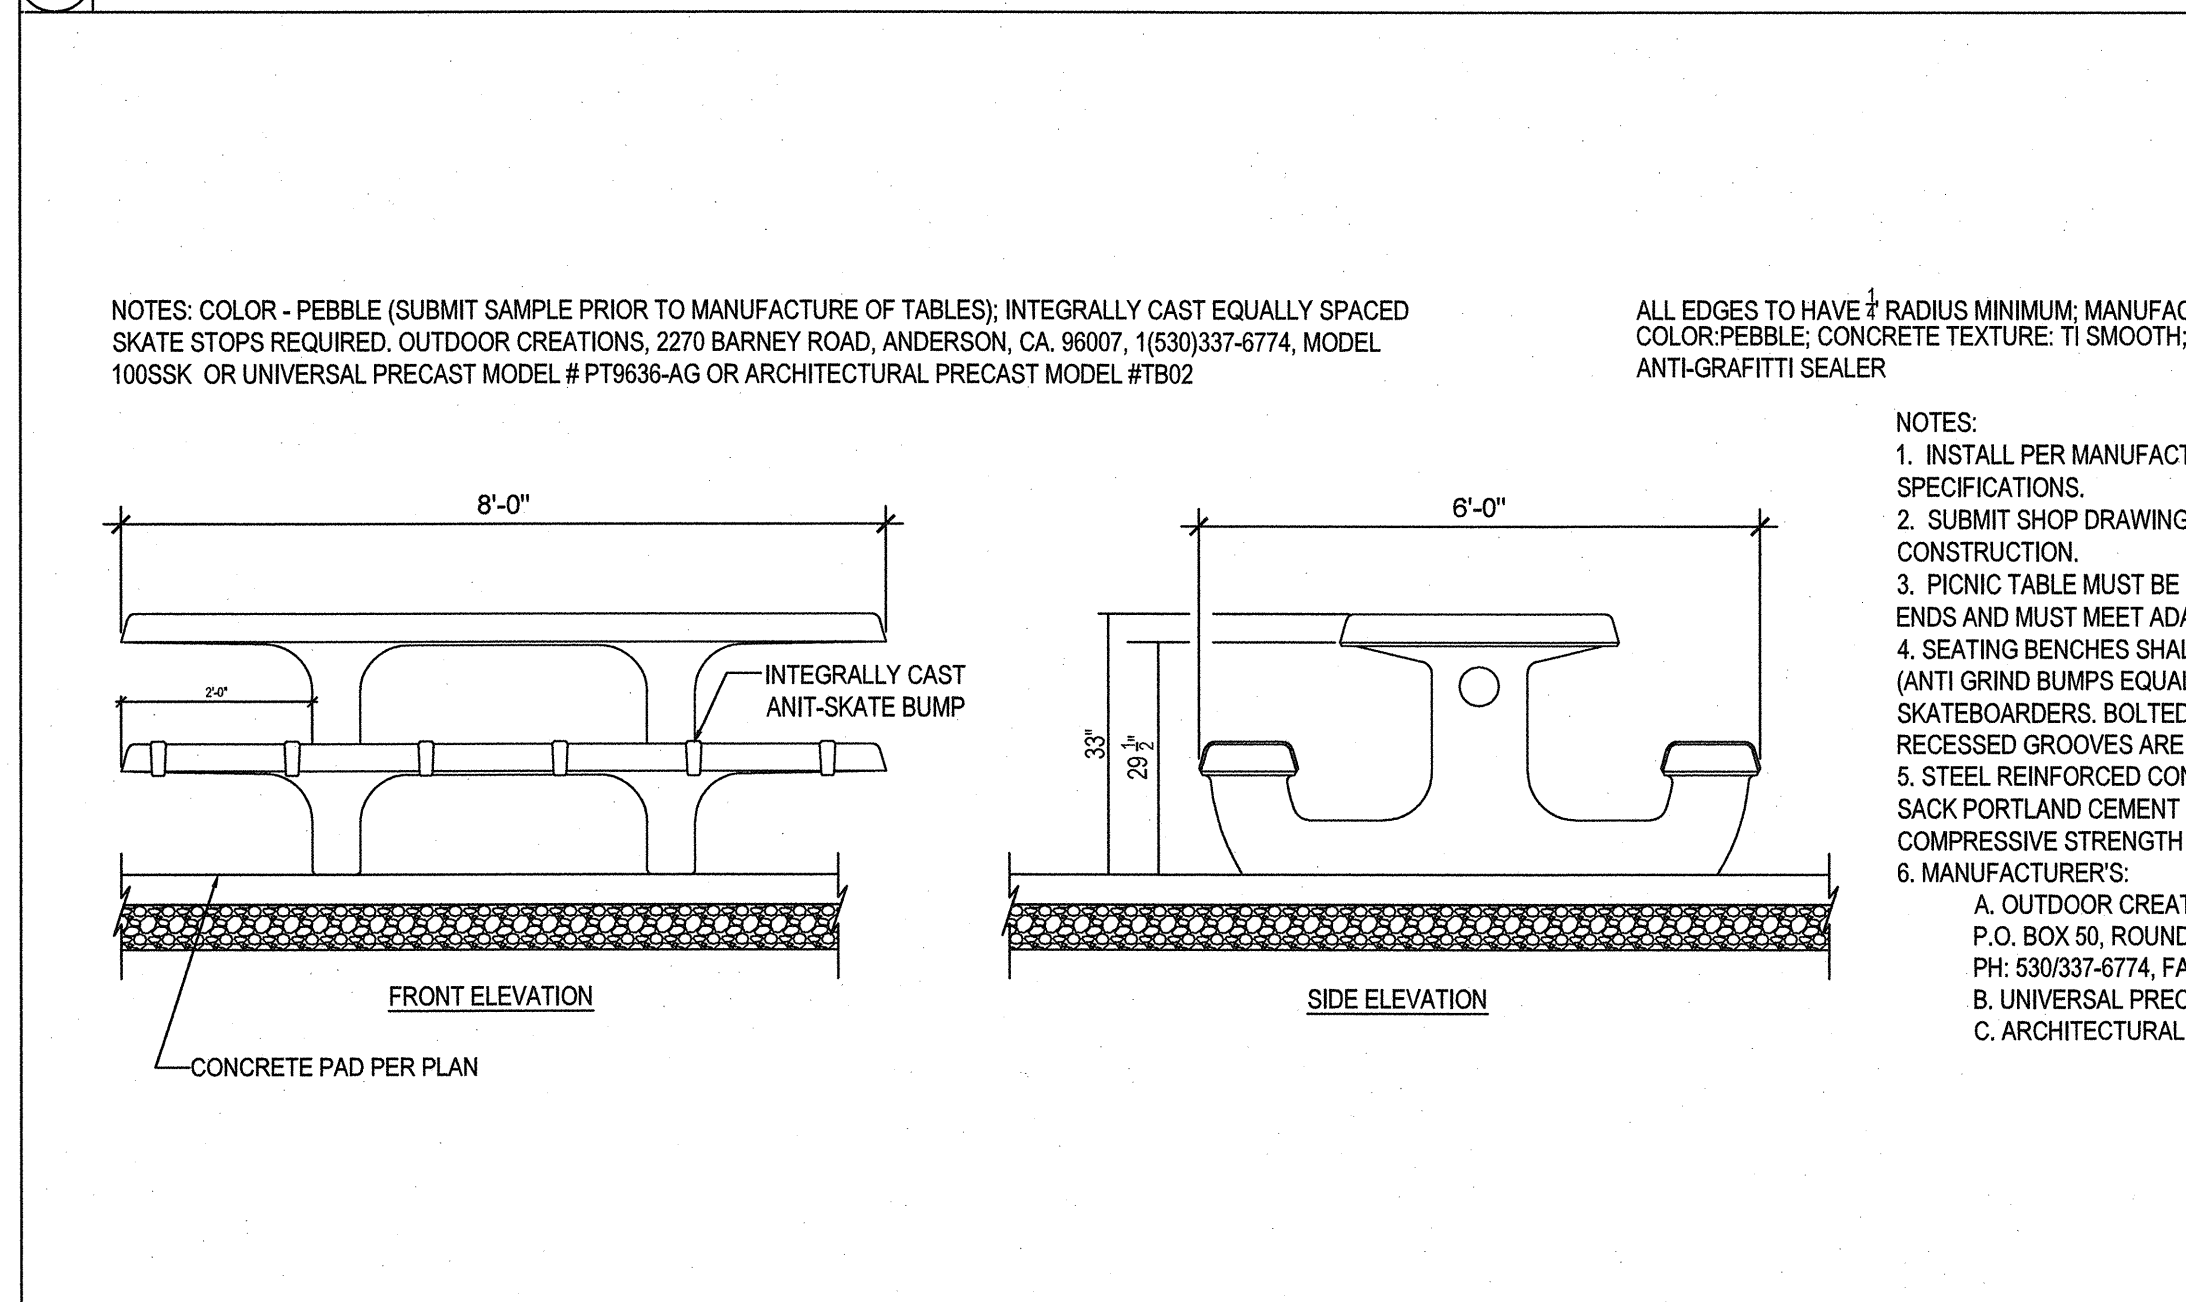


8 PICNIC TABLE DETAIL NOT TO SCALE

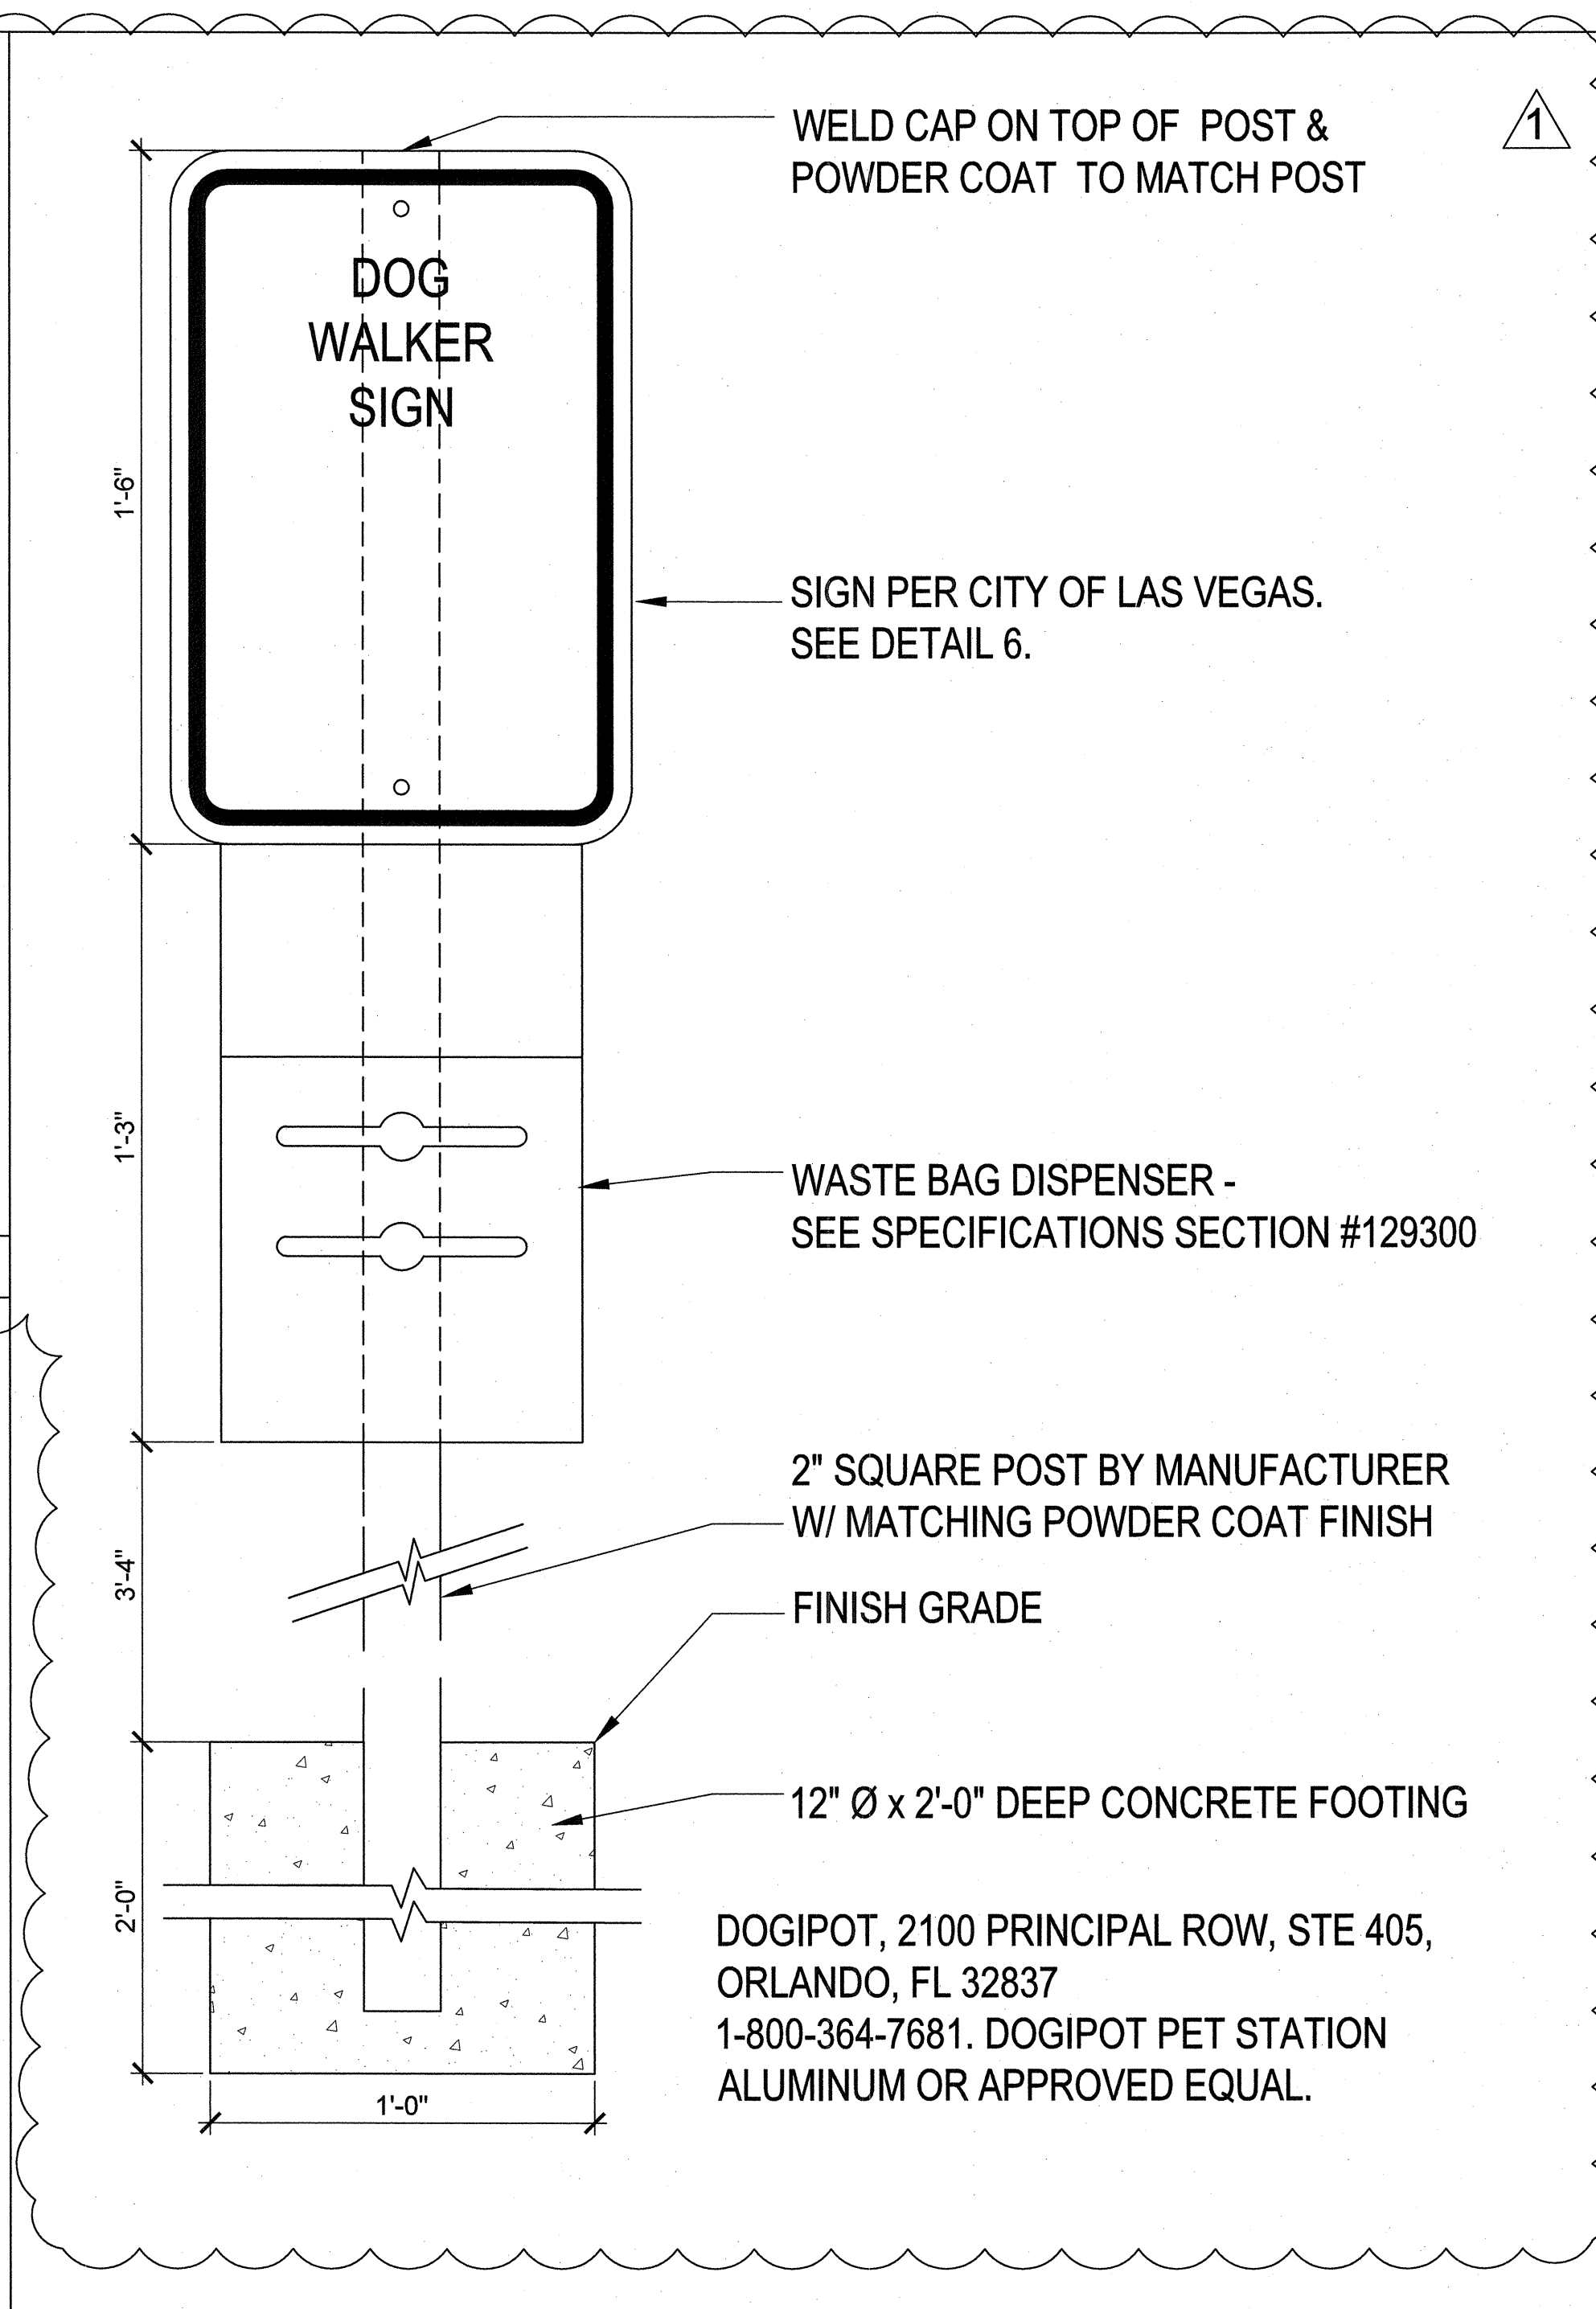


4 DOGIPOT NOT TO SCALE

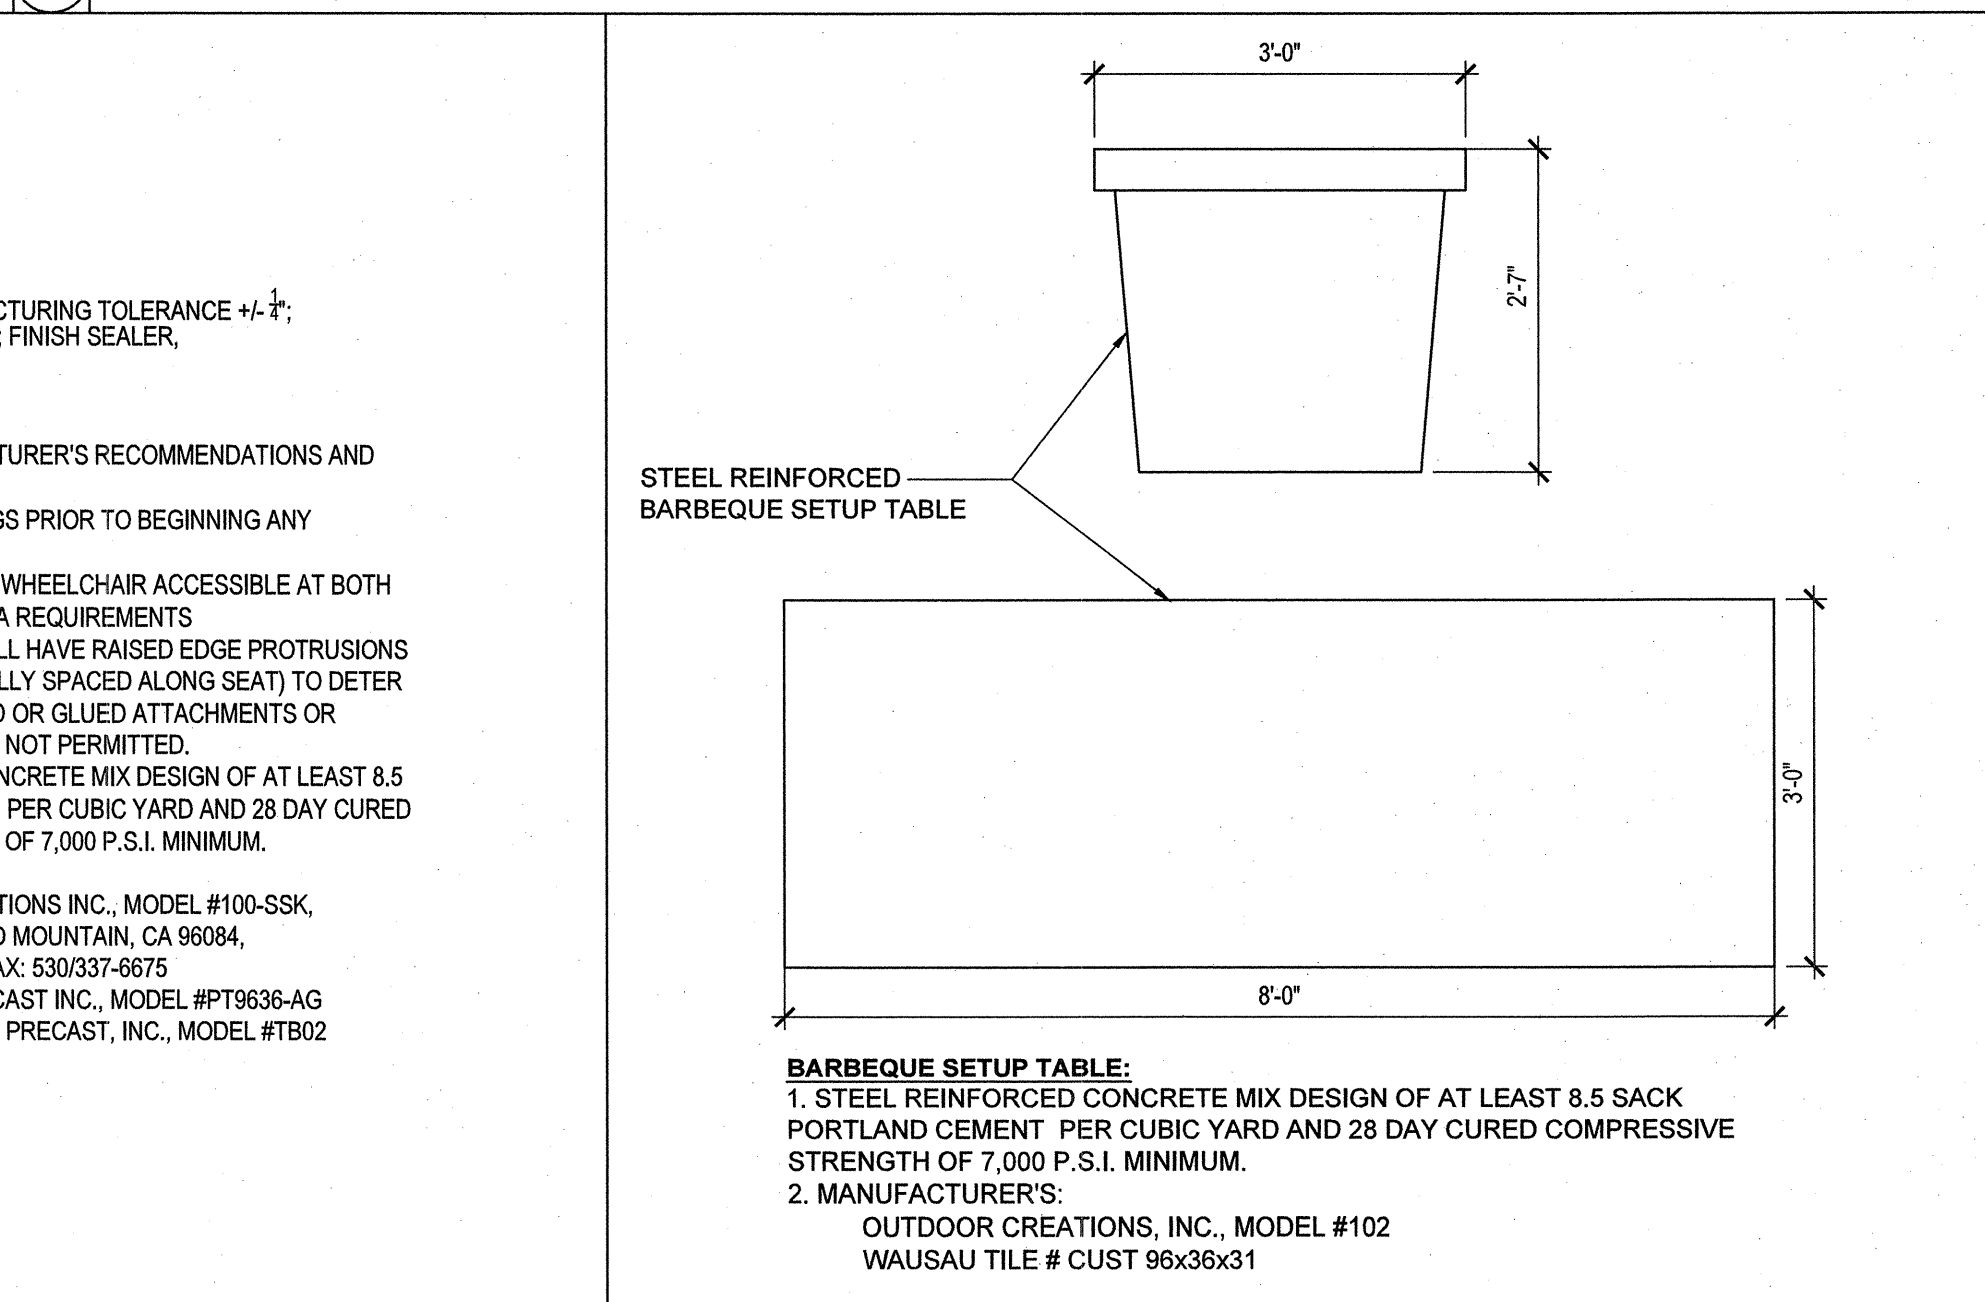


5 PREP TABLE NOT TO SCALE

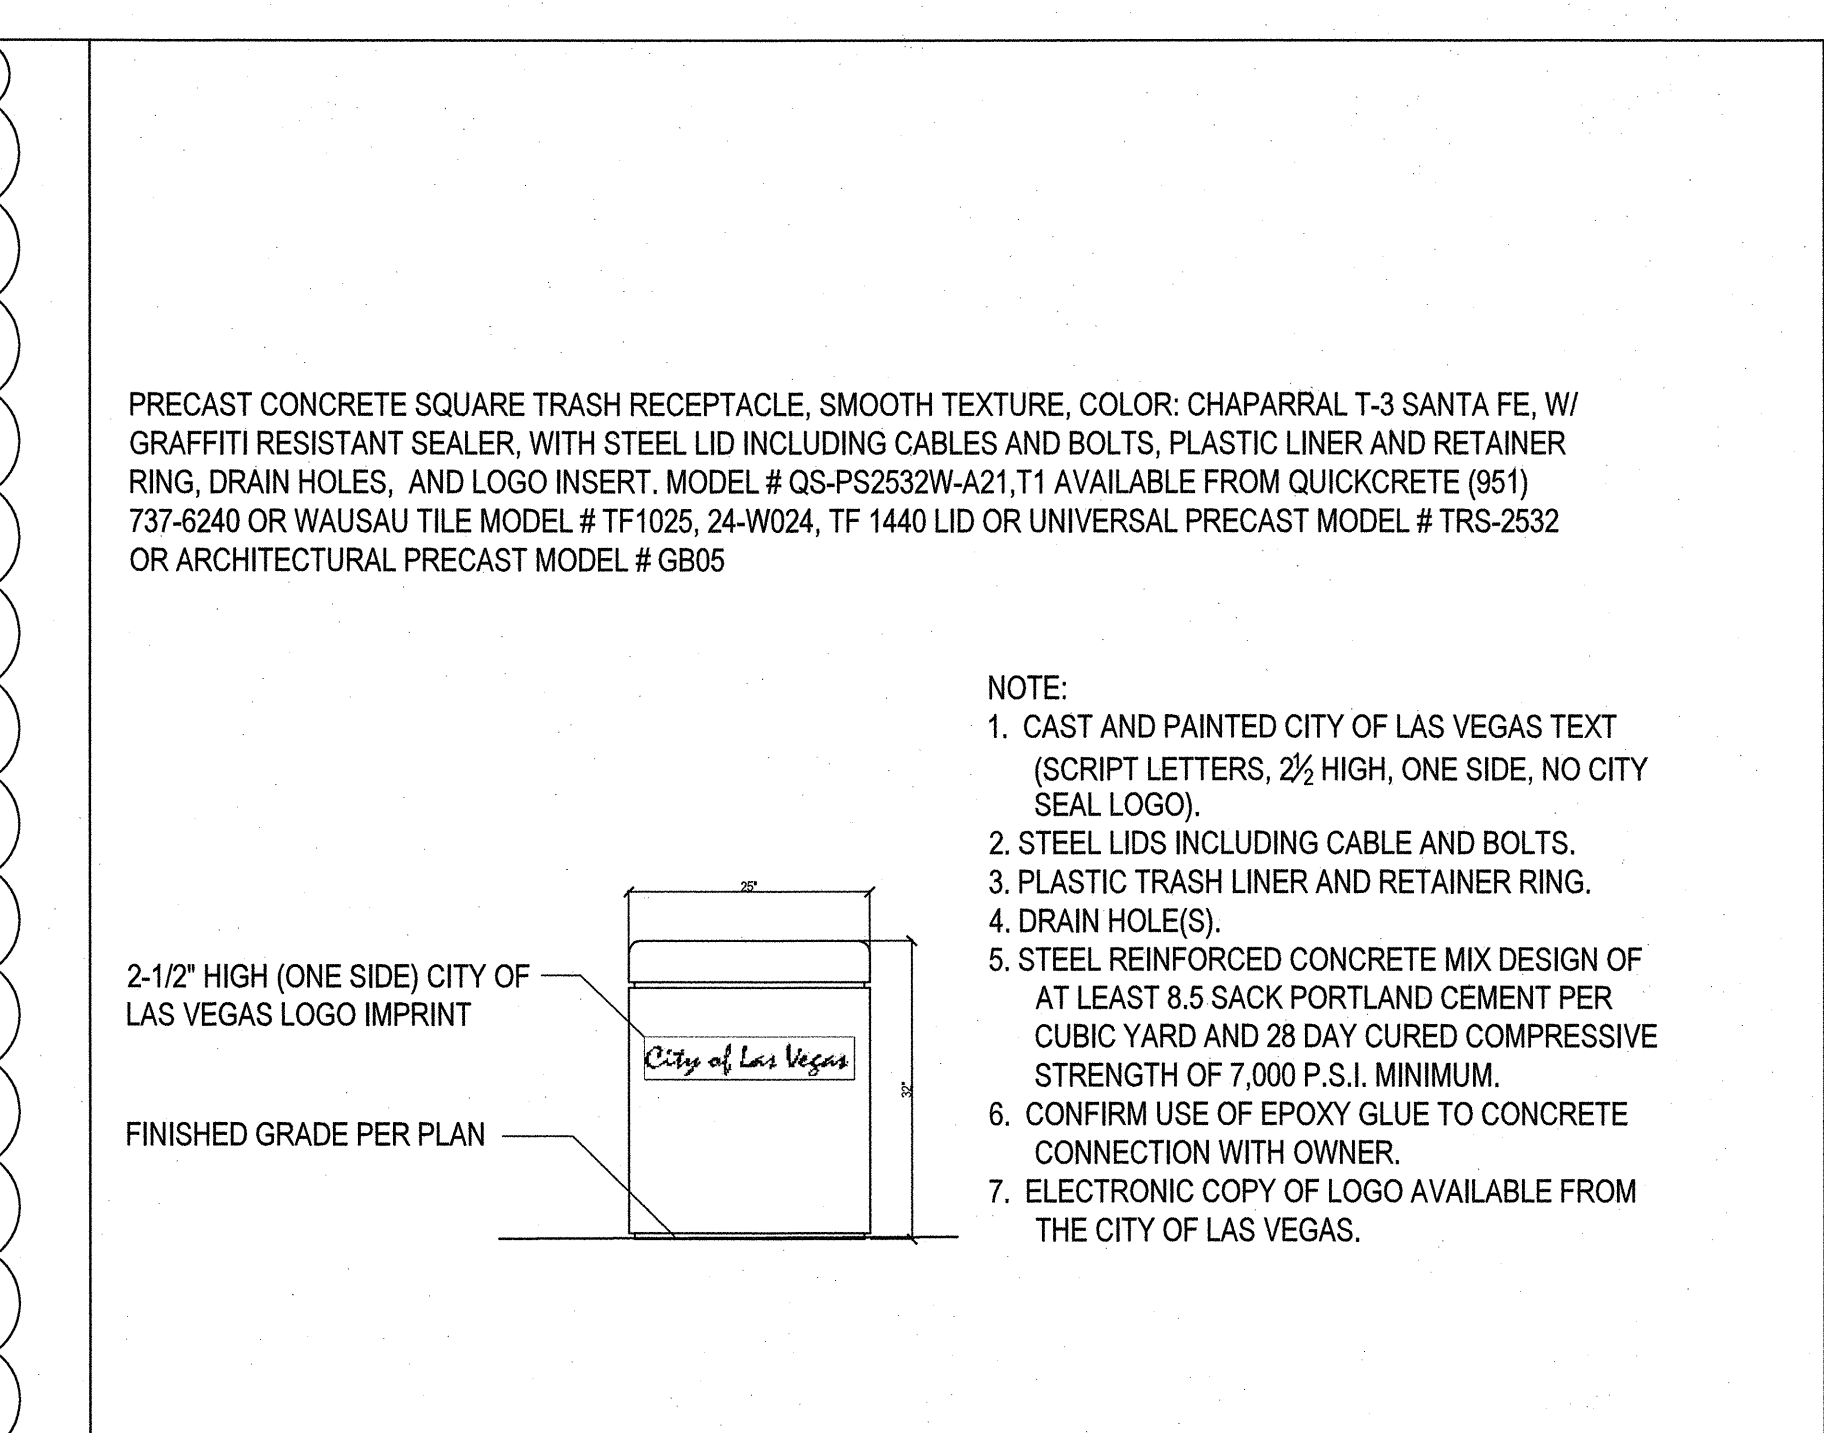

1 TRASH RECEPTACLE NOT TO SCALE

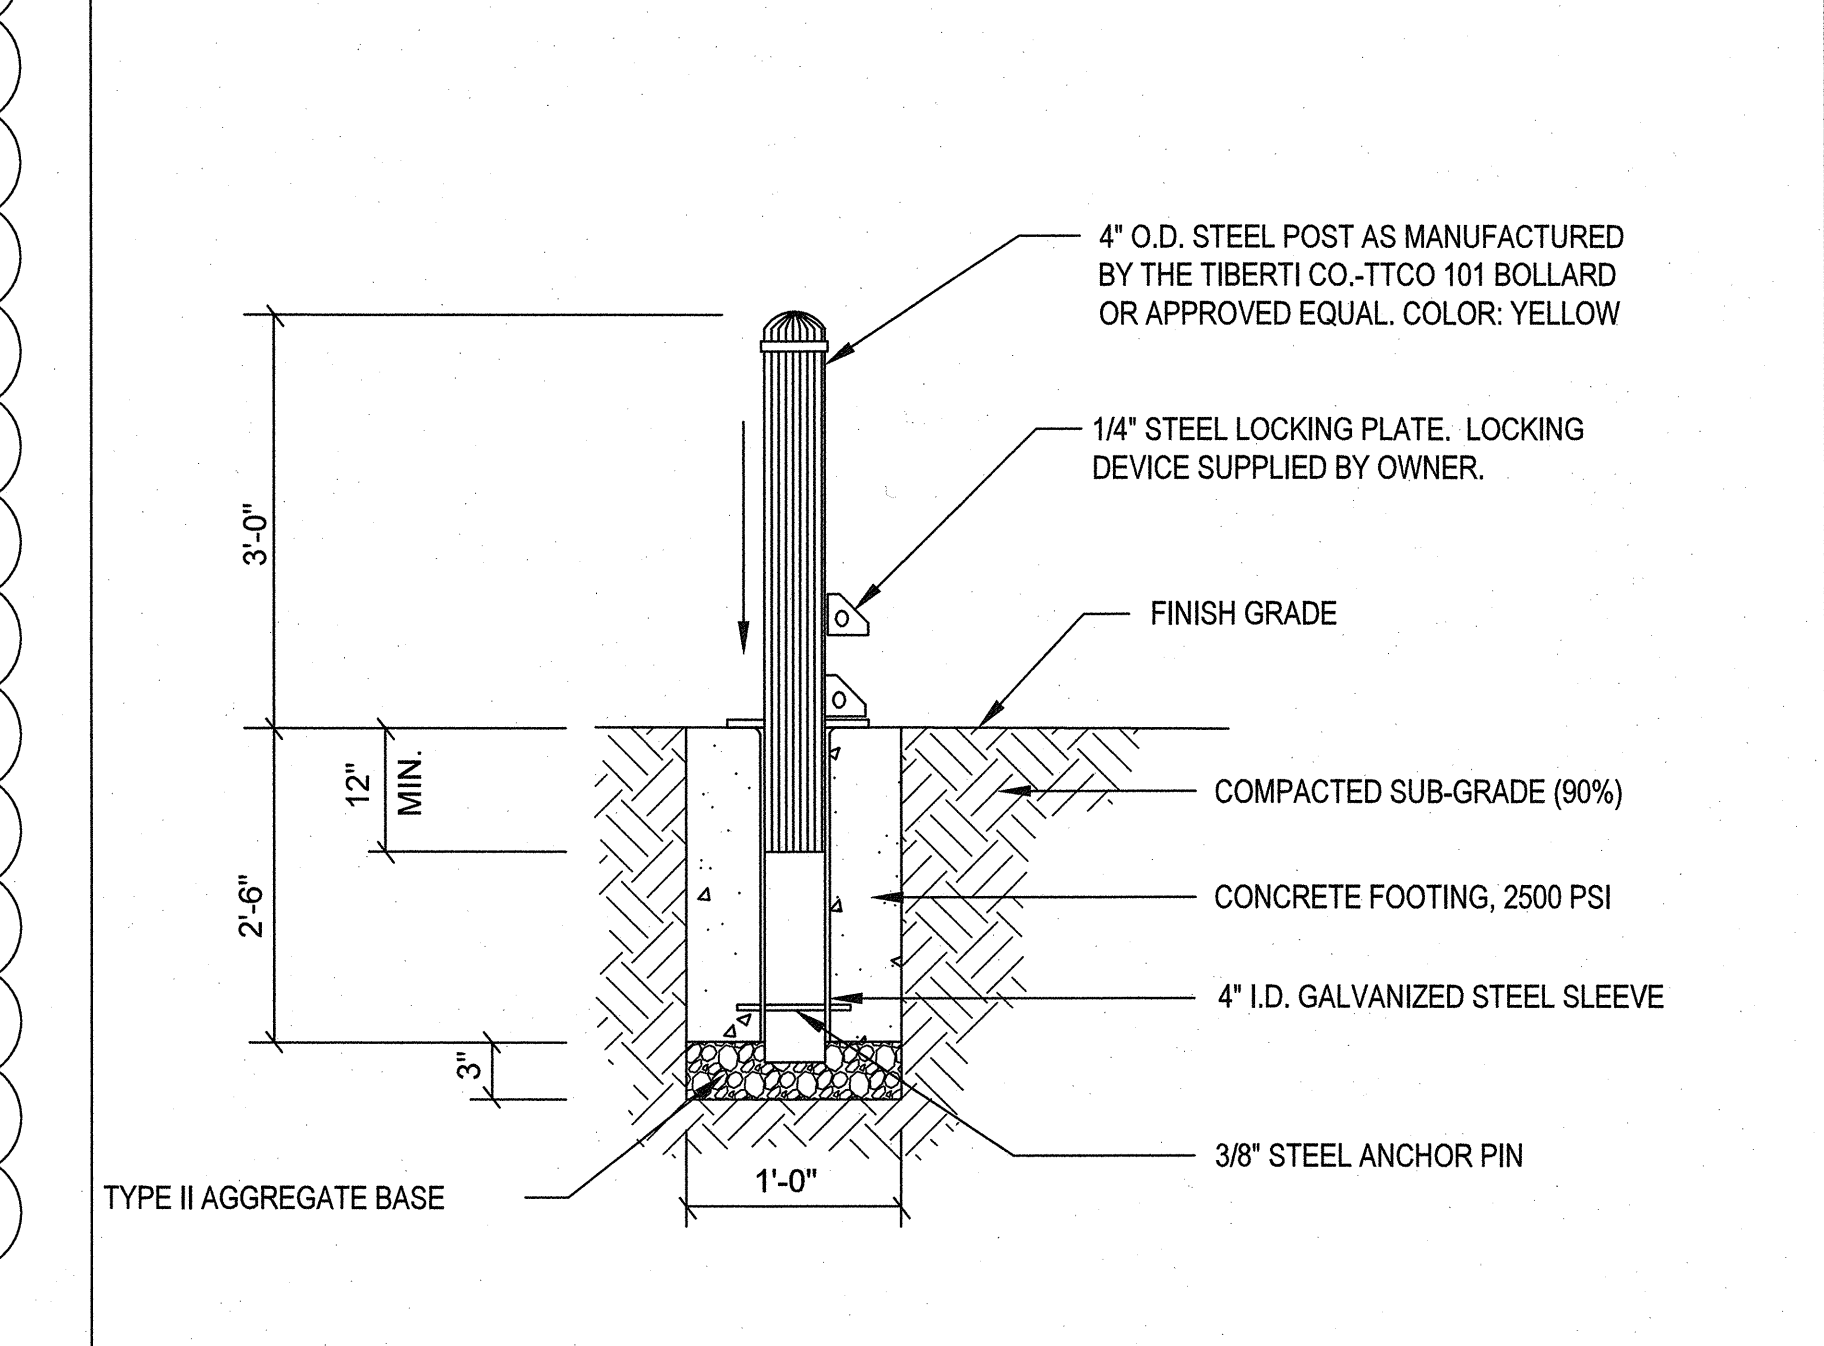

2 REMOVABLE BOLLARD NOT TO SCALE

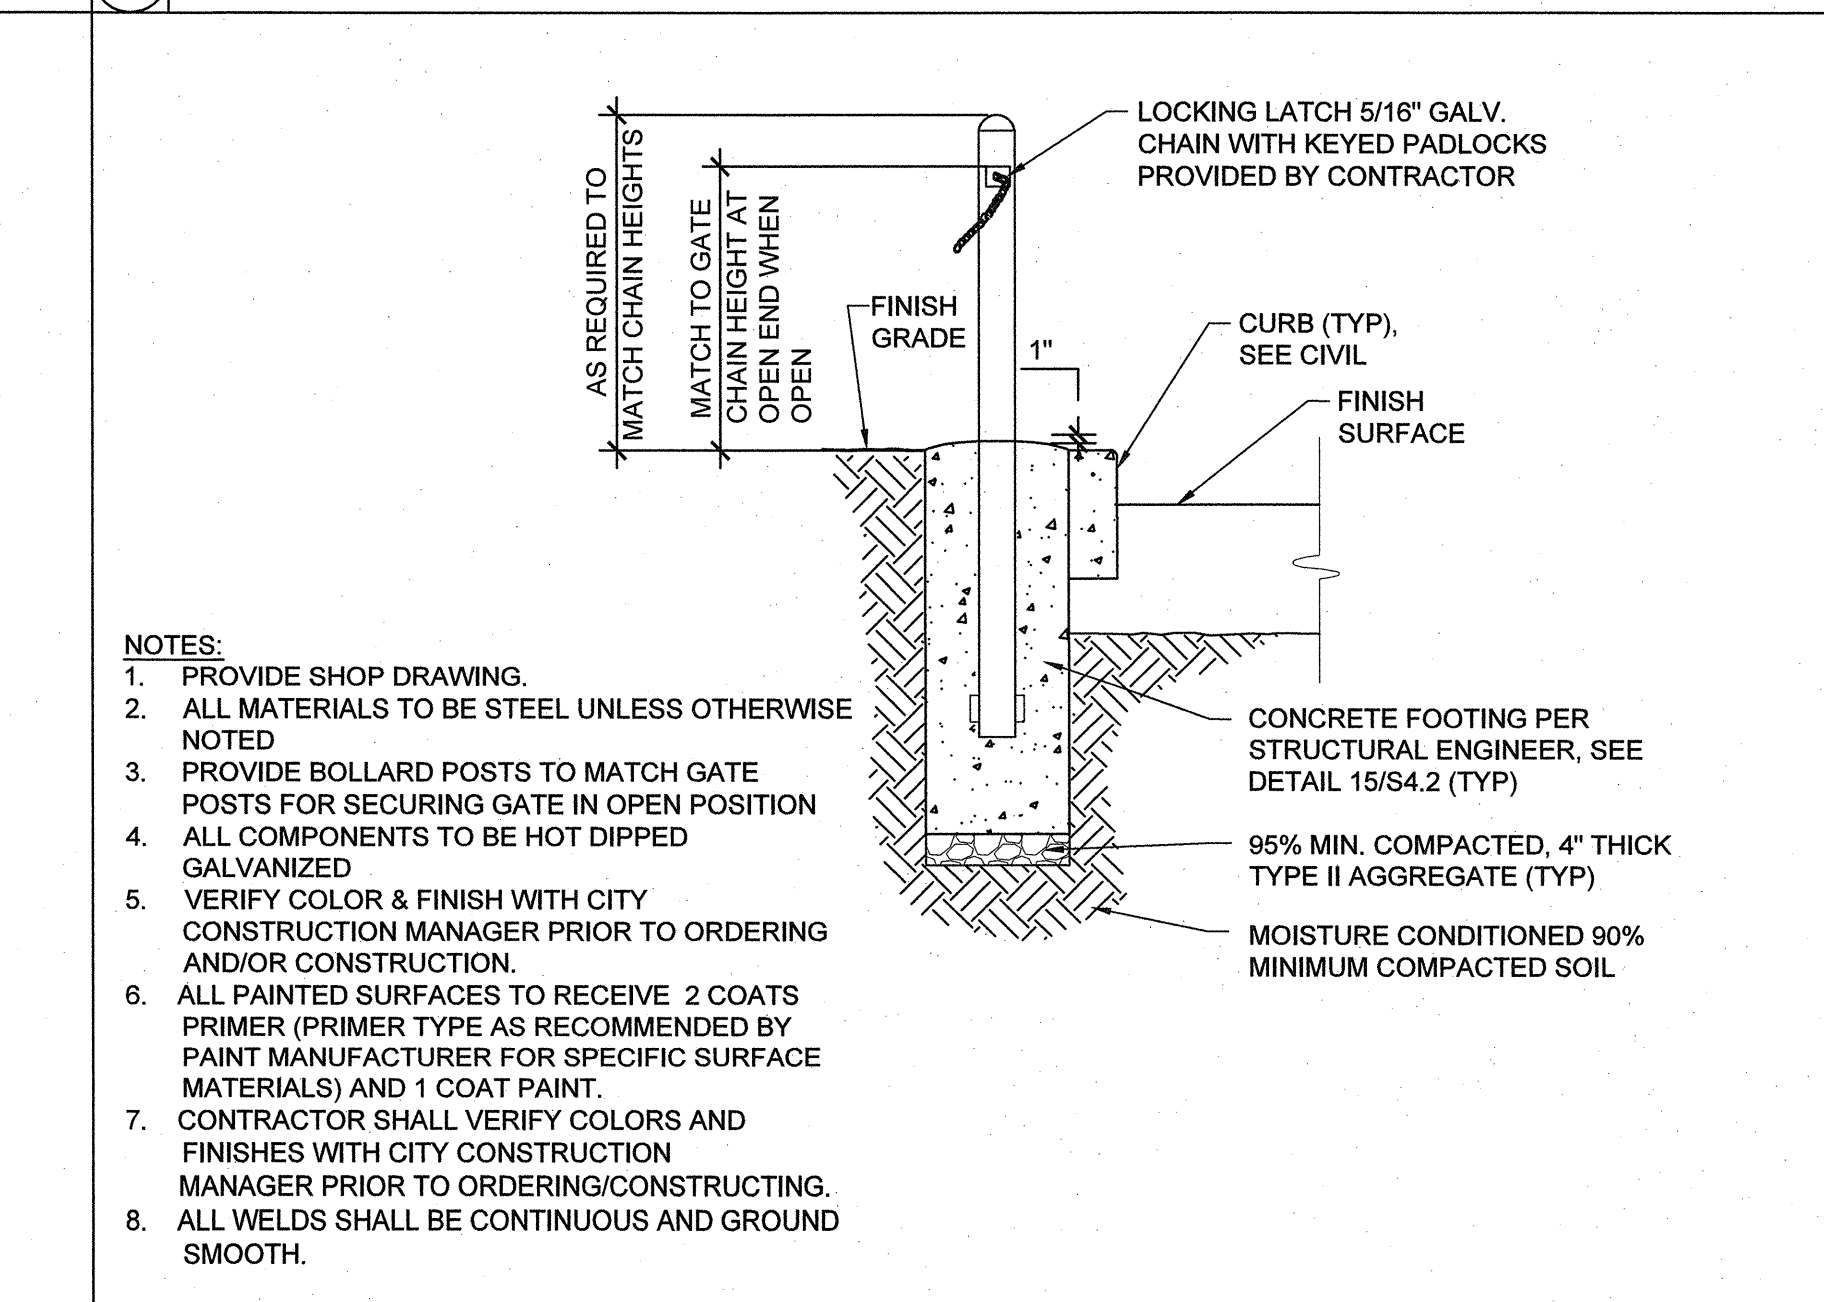

3 6" STEEL BOLLARD NOT TO SCALE

REVISIONS
REV/PLAN CHECK 10/19/16

CONSULTANT

Cardno
Shaping the Future

LAS VEGAS
7115 AMIGO STREET, STE 100, LAS VEGAS, NV 89119
TEL: (702) 990-9300 FAX: (702) 990-9305 www.cardno.com

MAYFAIR PLACE PARK
SITE DETAILS

STAMP
REGISTERED LANDSCAPE ARCHITECT
TARA CARELLI
728
Expires: 06/30/17
STATE OF NEVADA

OWNER: CITY OF LAS VEGAS
DEPARTMENT OF PUBLIC WORKS

400 EAST STEWART AVENUE
LAS VEGAS, NEVADA 89101
PHONE: (702) 229-6535
FAX: (702) 382-3232
TDD: (702) 386-9108

DRAWN
TCC

DATE
2016-11-30

SCALE
N/A







BID NO
15.59812

CLV DWG NO
650.111

H#
66624

SHT NO
L.1.02

REVISED 8/27/03

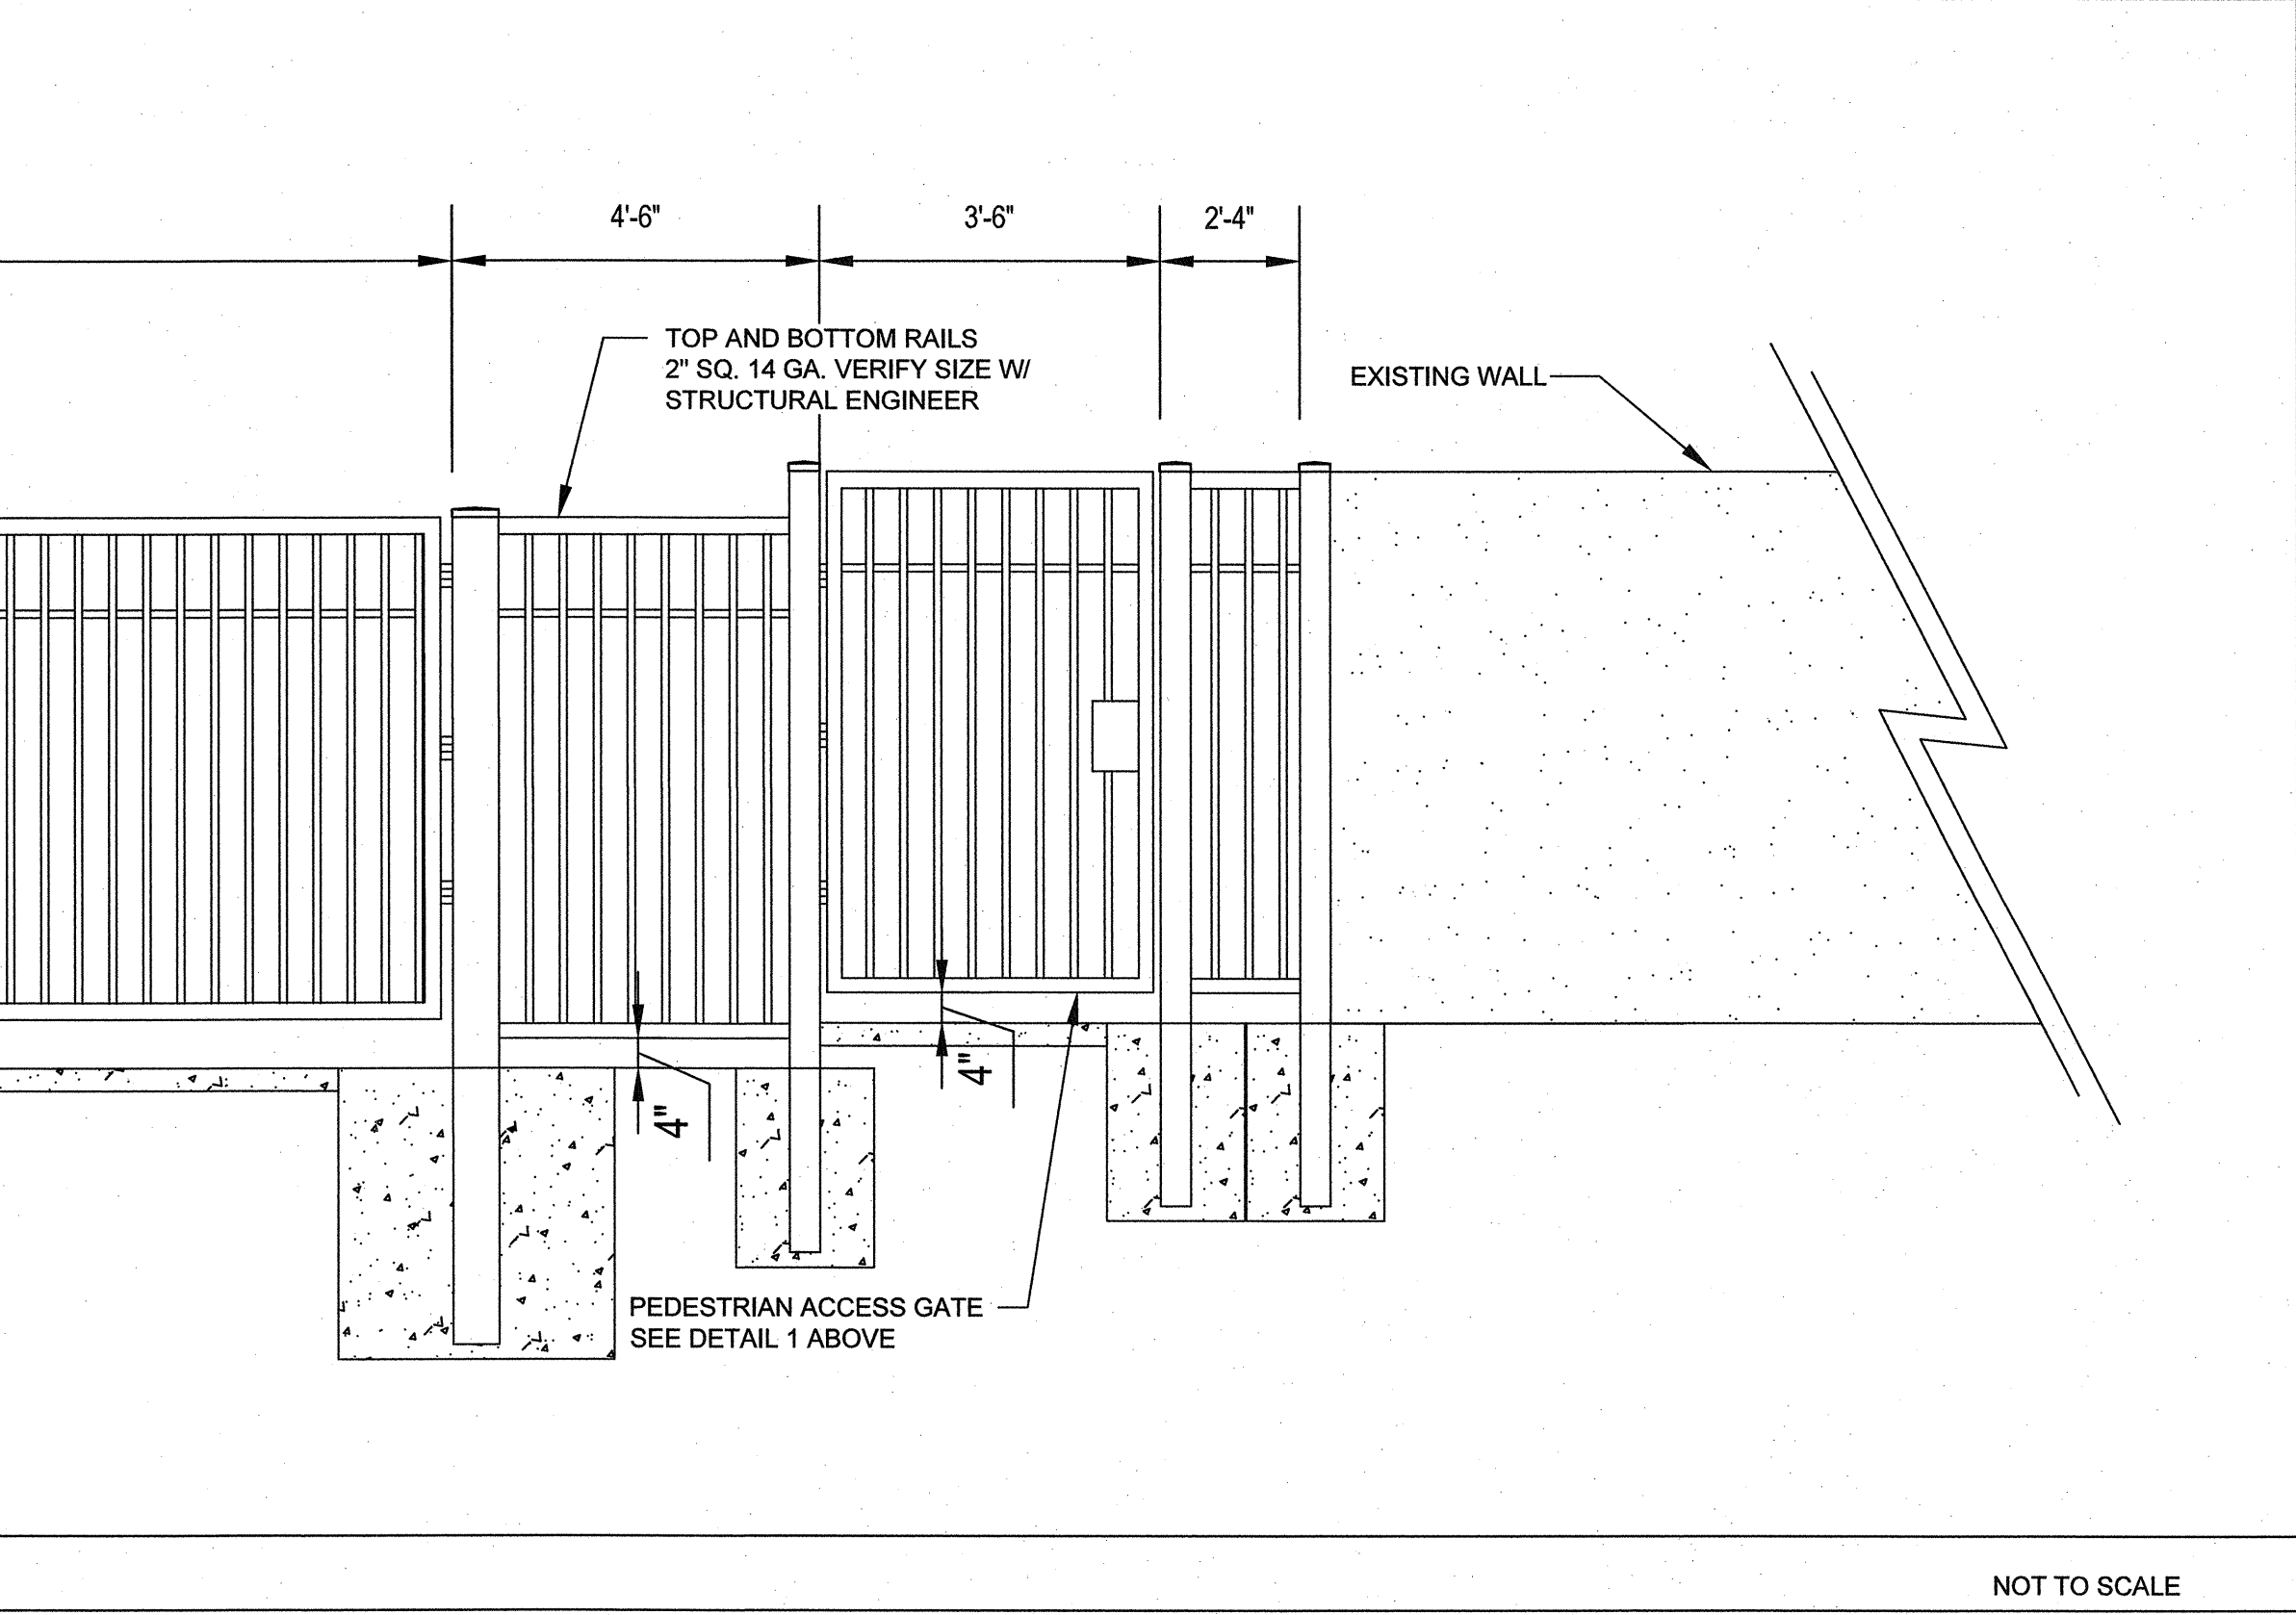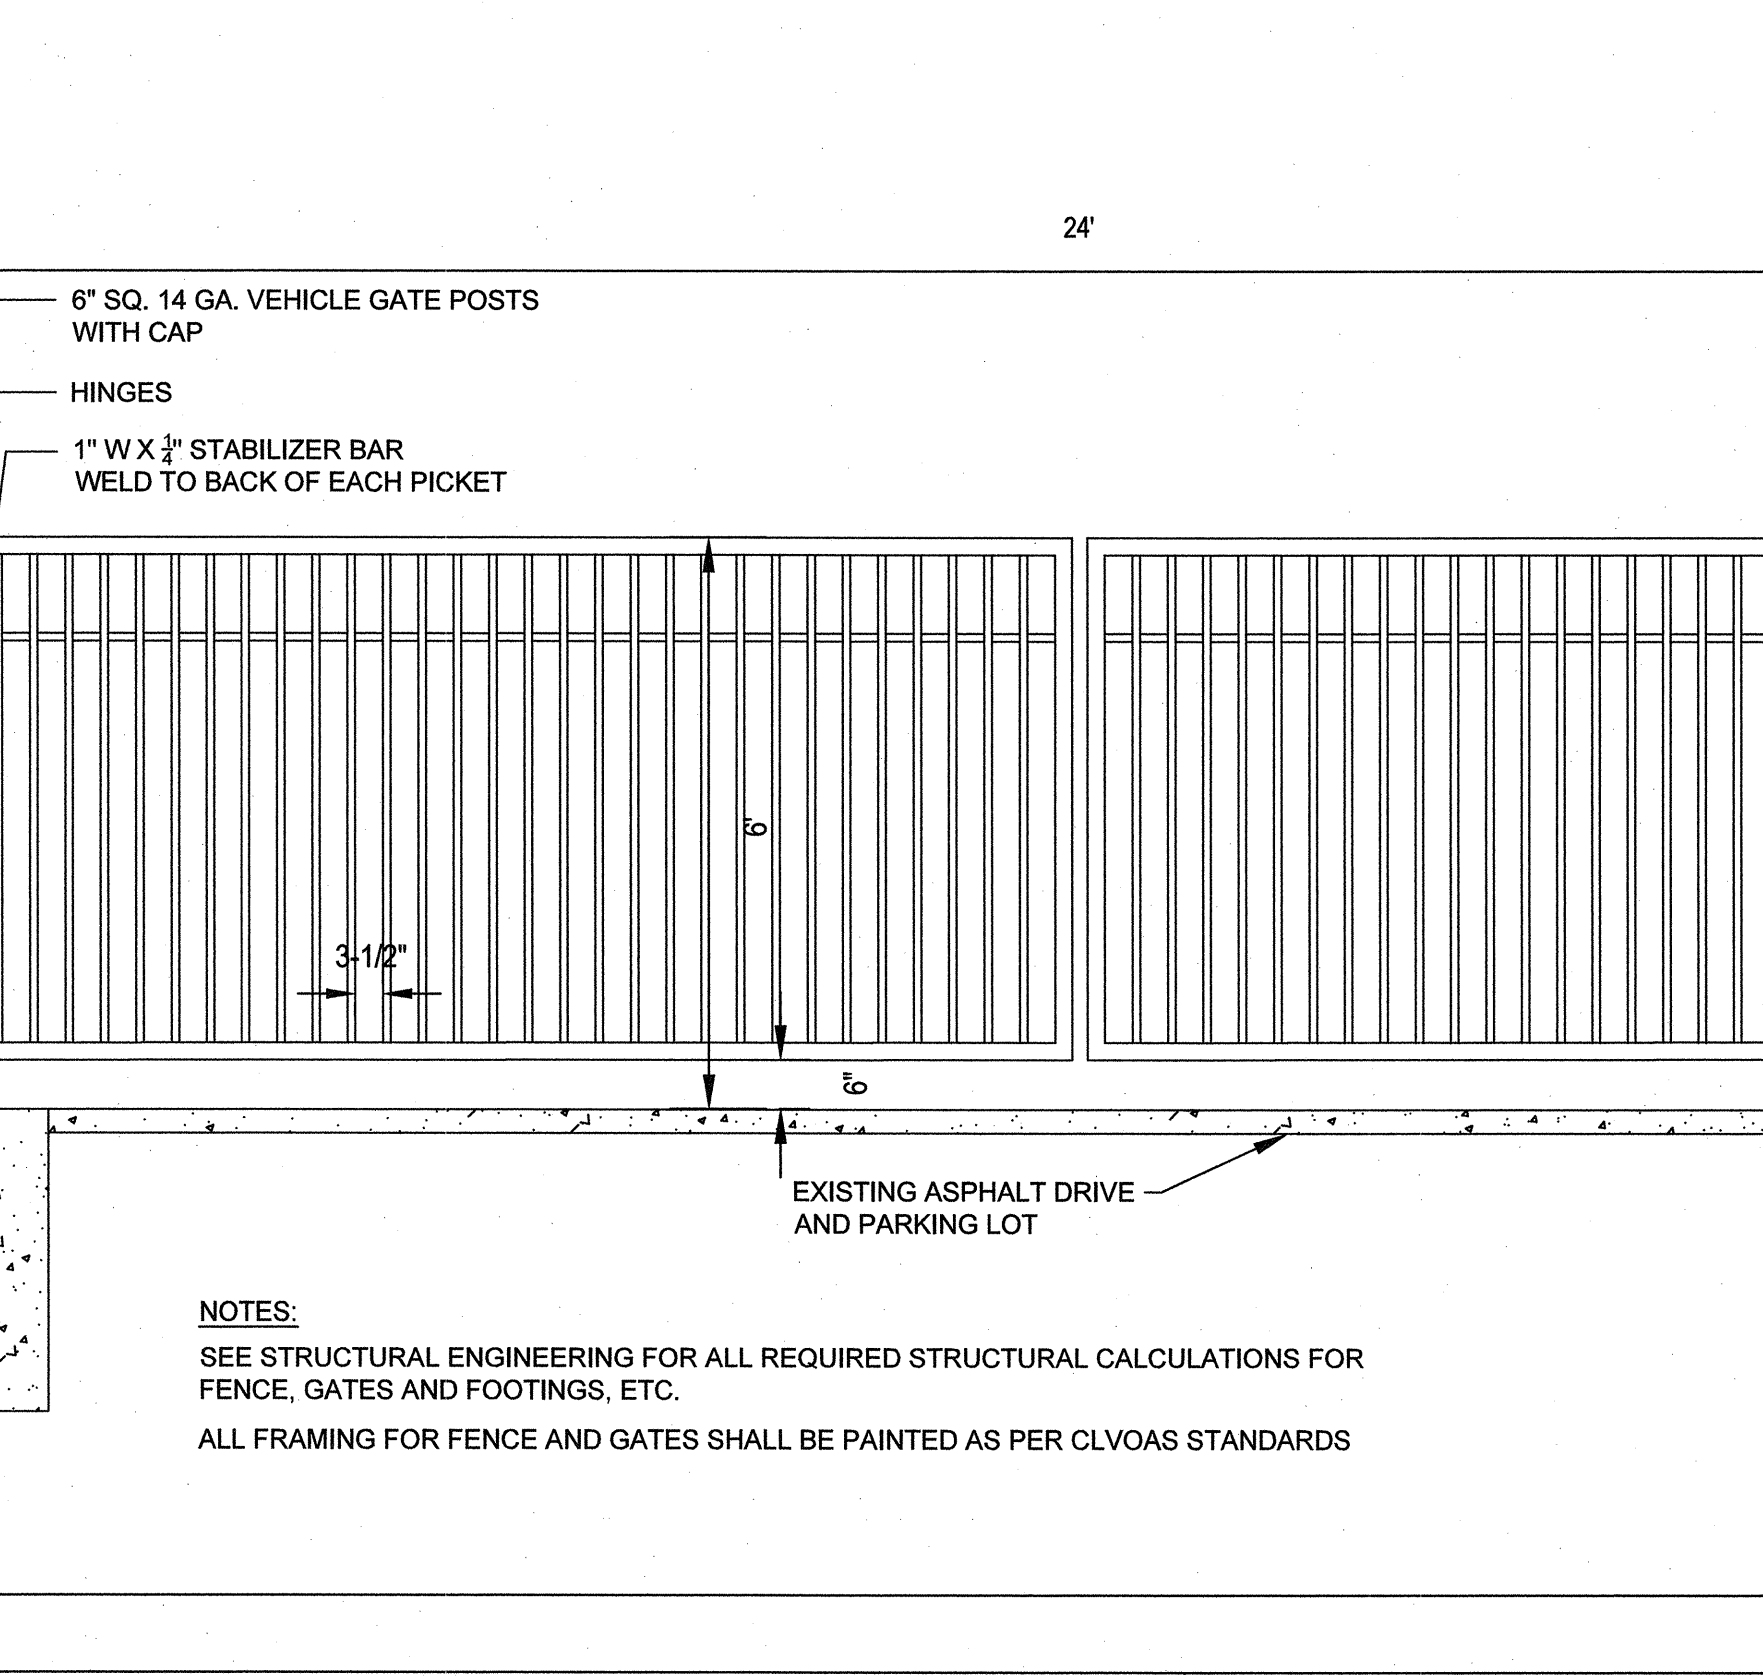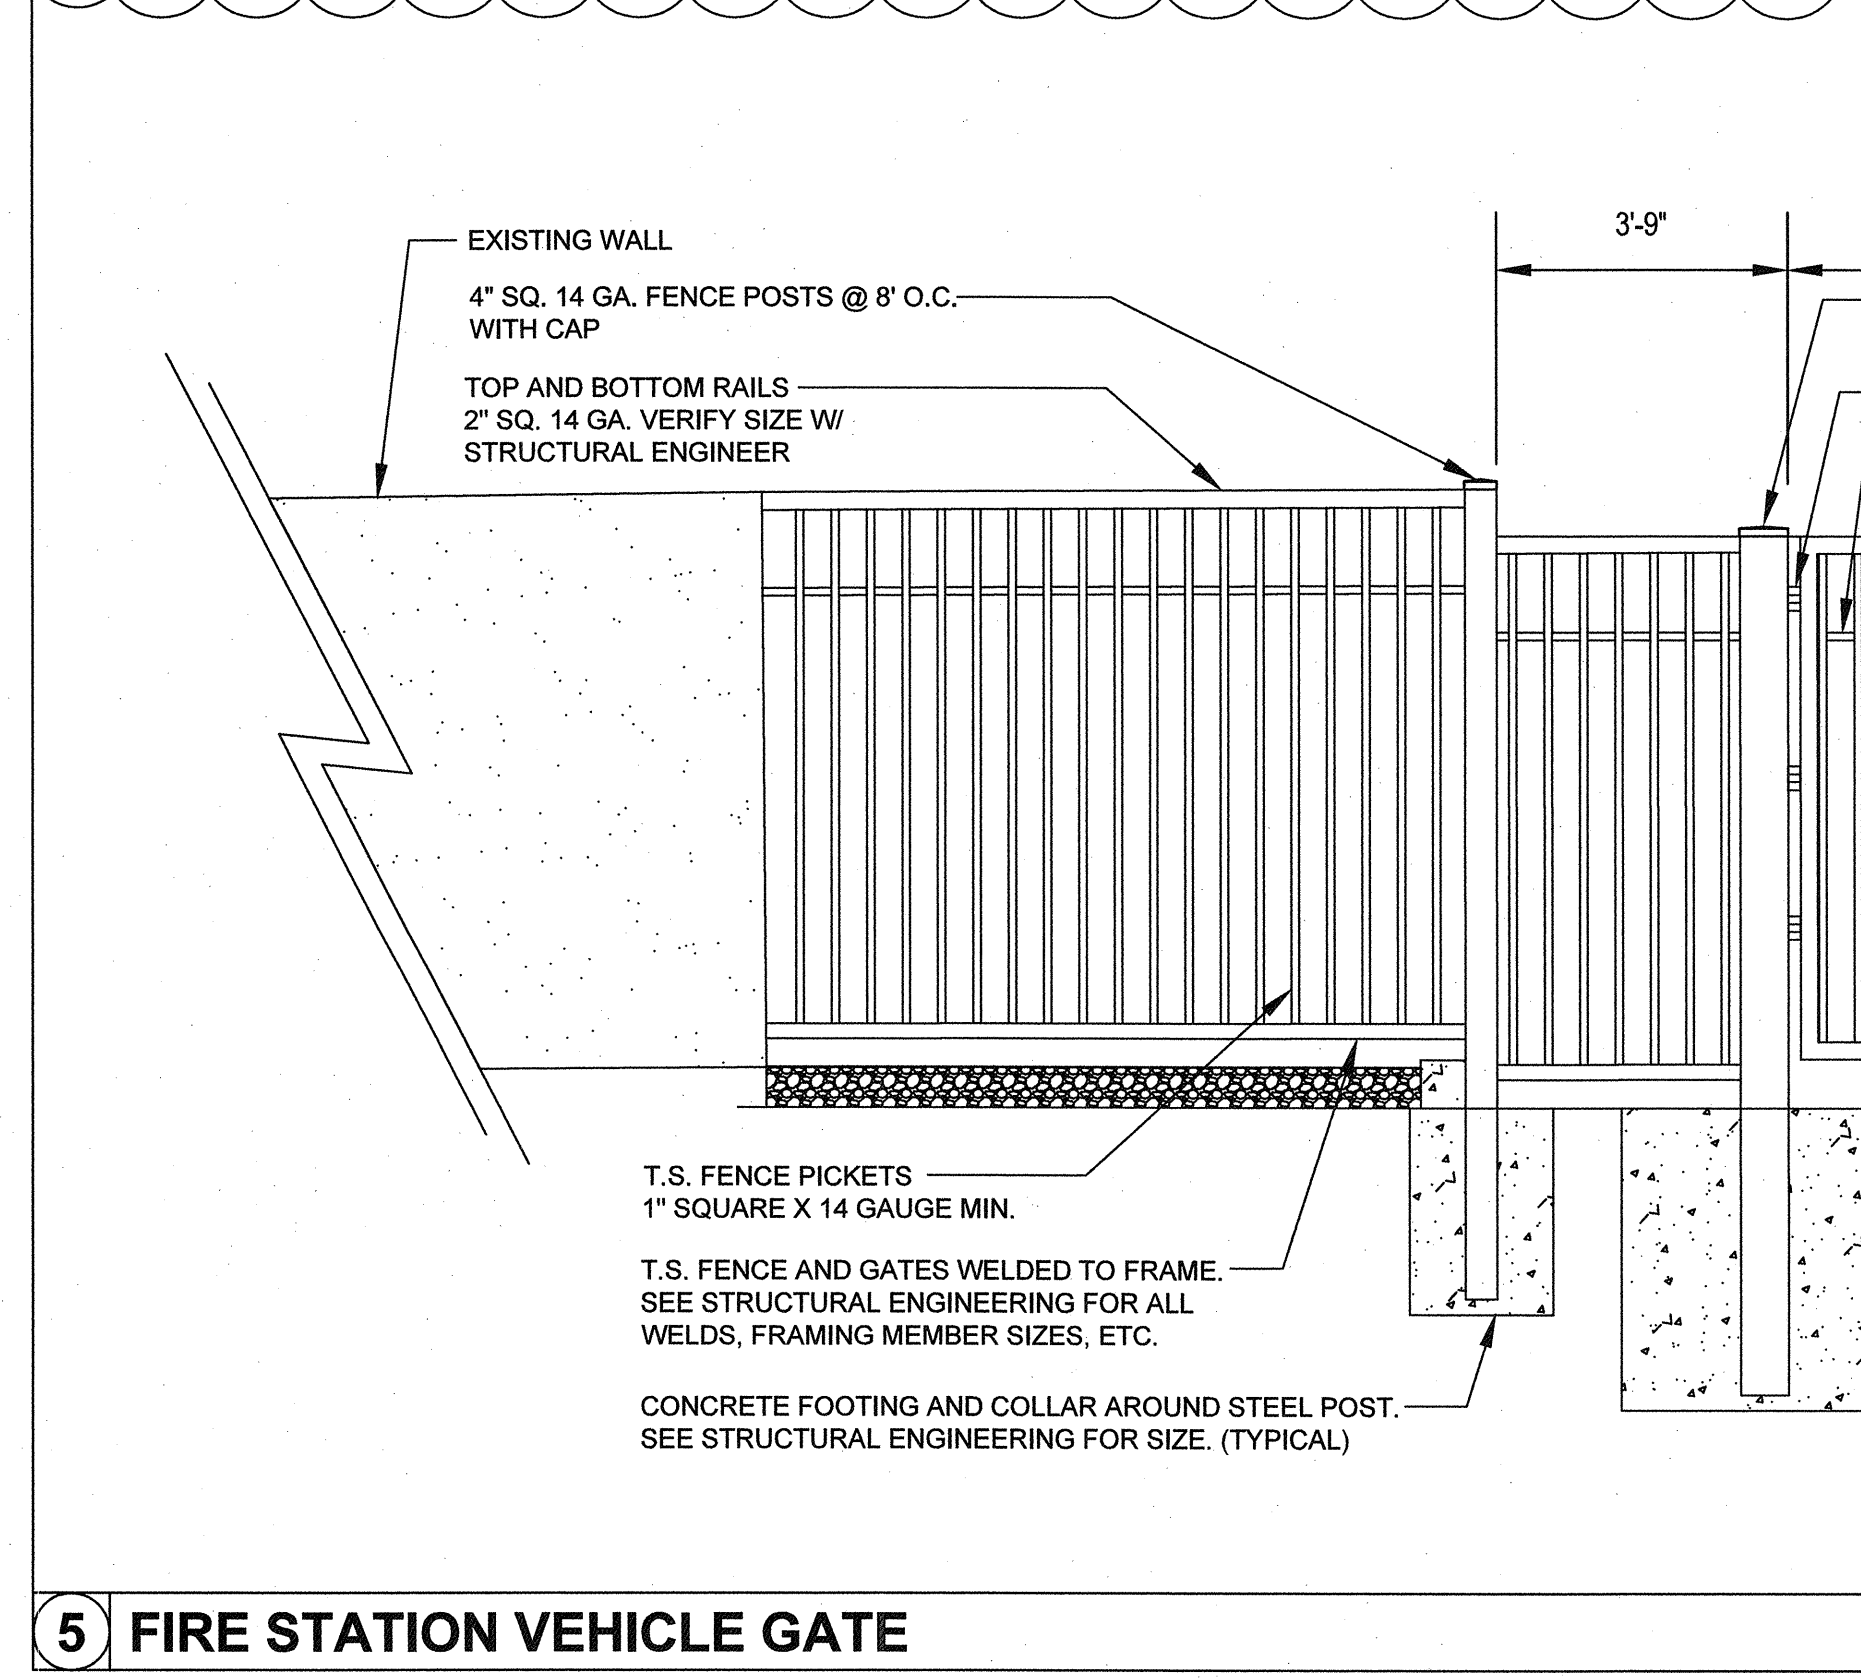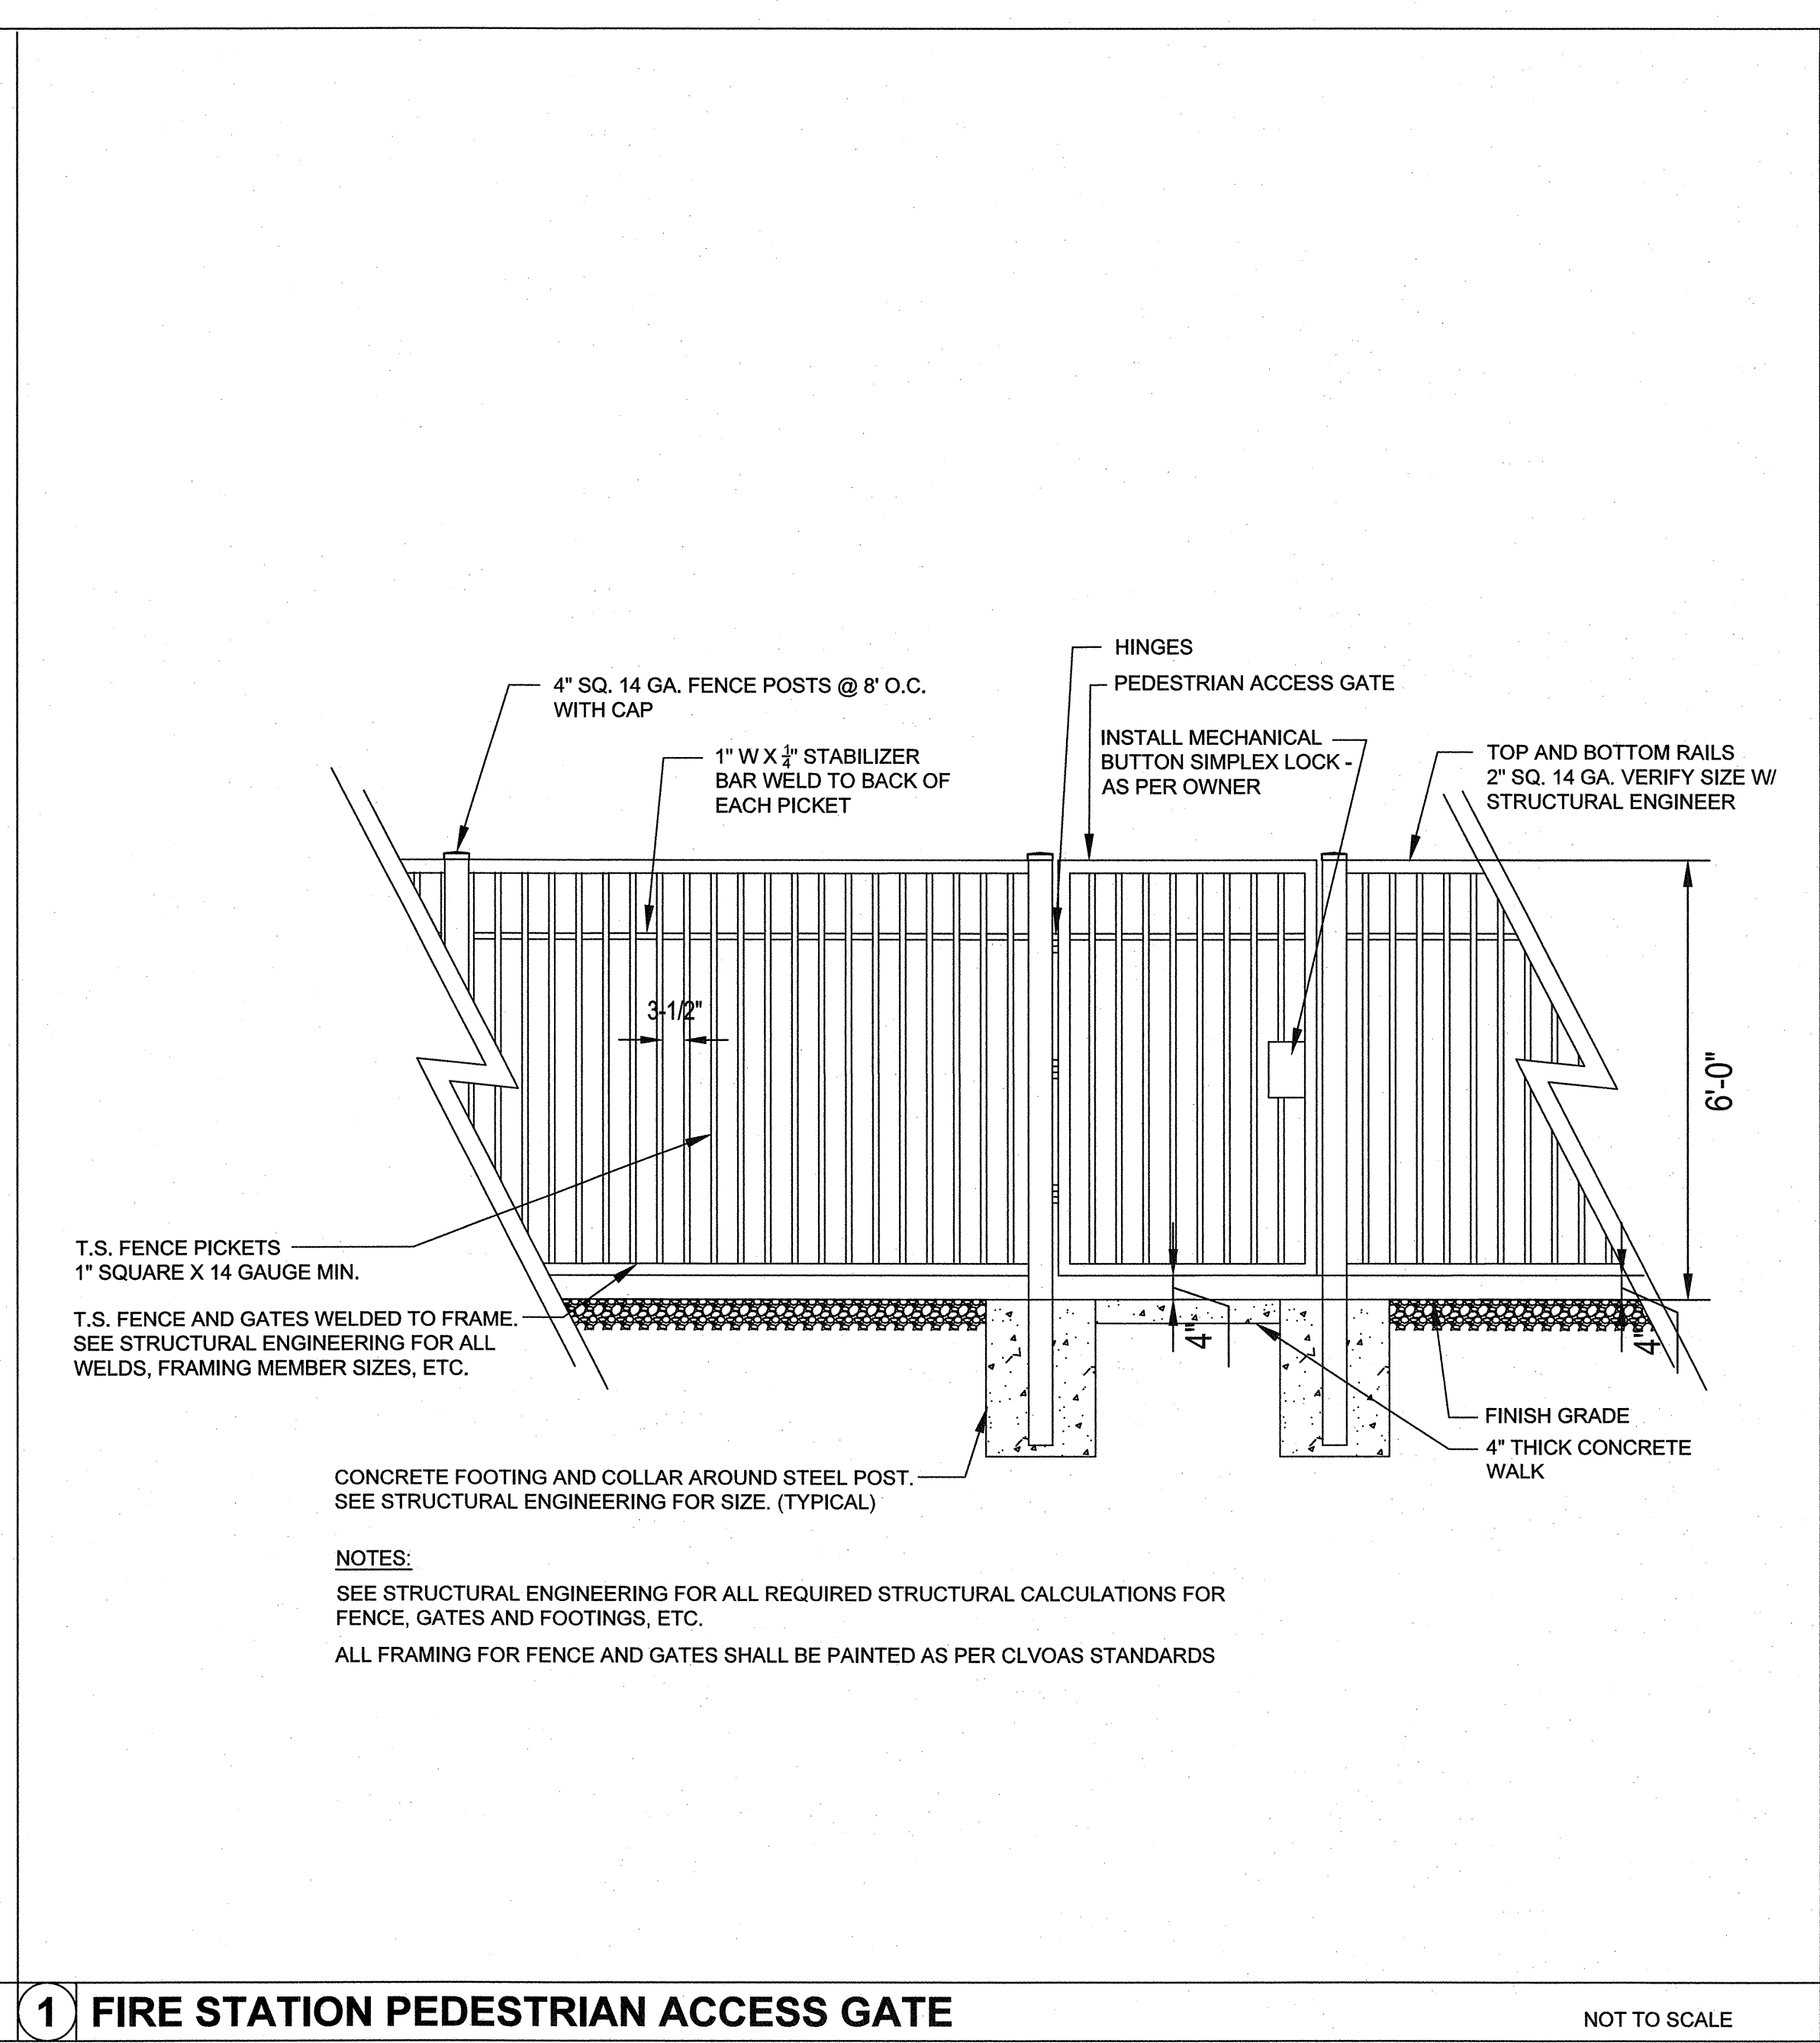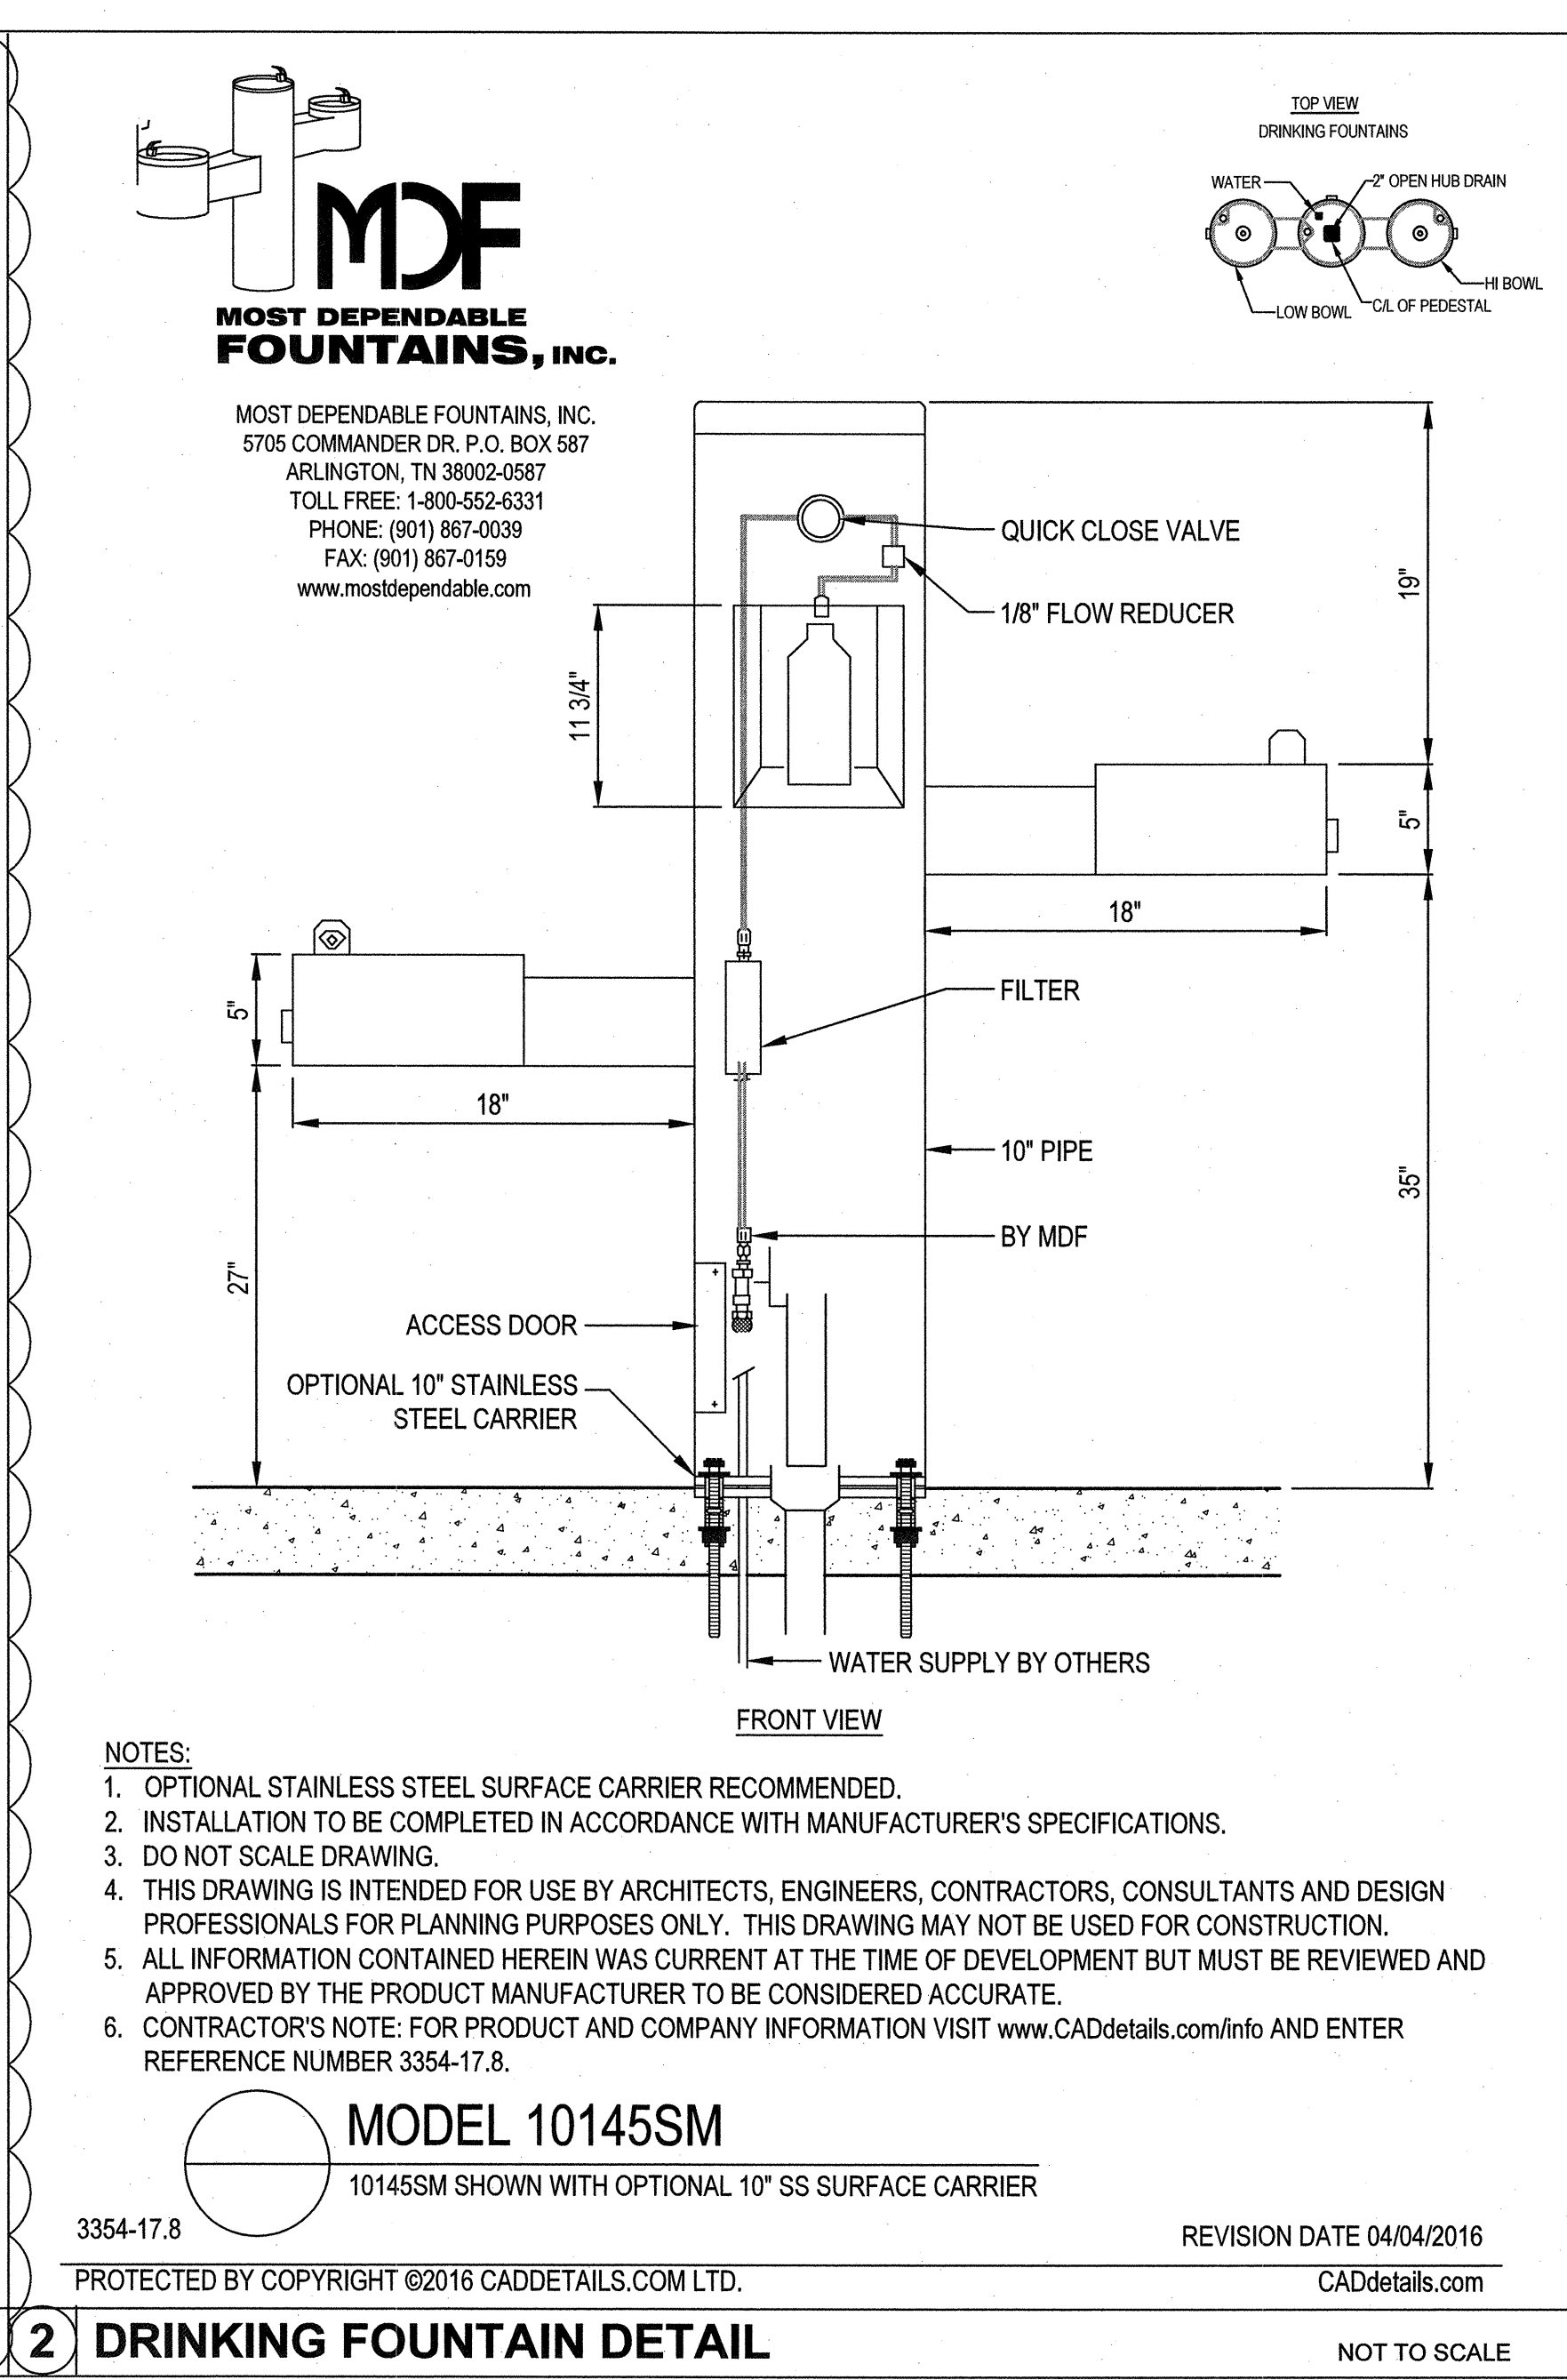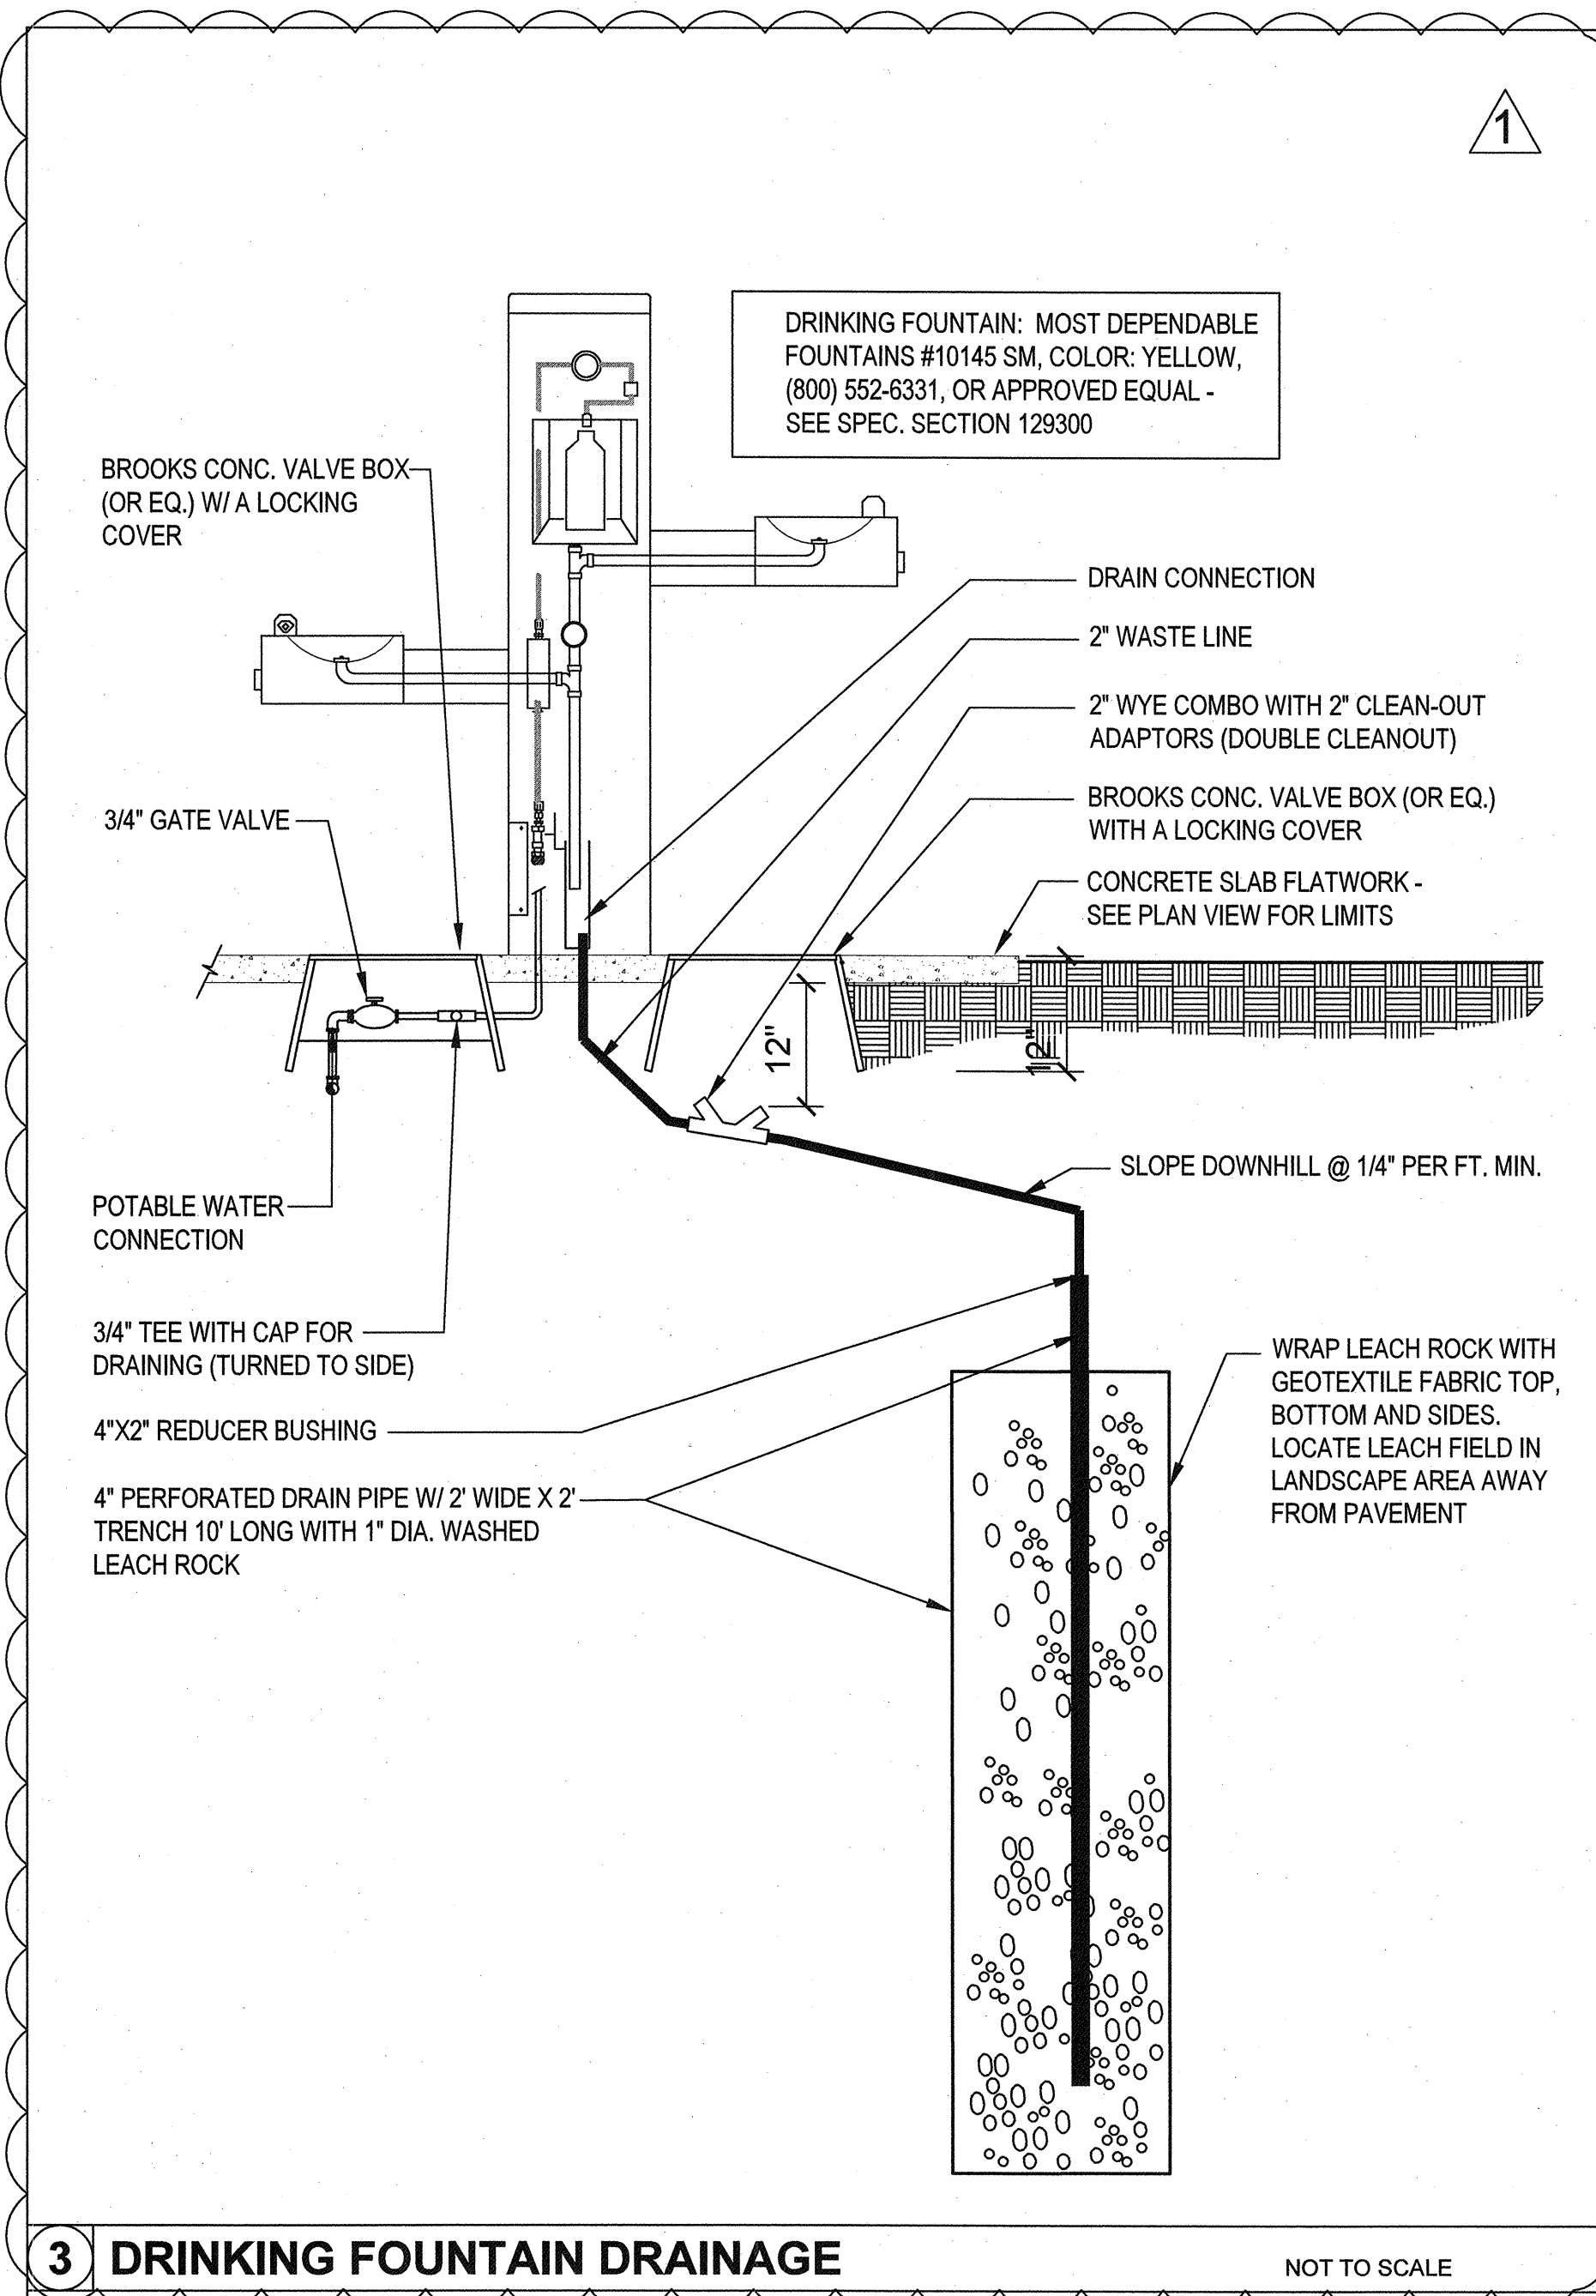

REVISIONS
REV/PLAN CHECK 10/19/16

CONSULTANT

Cardno
Shaping the Future

LAS VEGAS
7115 AMIGO STREET, STE 100, LAS VEGAS, NV 89119
TEL: (702) 990-9300 FAX: (702) 990-9305 www.cardno.com

MAYFAIR PLACE PARK
SITE DETAILS

STAMP
REGISTERED LANDSCAPE ARCHITECT
728
Expire: 06/30/17
12/1/16

OWNER: CITY OF LAS VEGAS
DEPARTMENT OF PUBLIC WORKS

400 EAST STEWART AVENUE
LAS VEGAS, NEVADA 89101
PHONE: (702) 229-6535
FAX: (702) 382-3232
TDD: (702) 386-9108

DRAWN
TCC

1099-CD-DETAILS L.1.01-1.06.DWG

DATE
2016-11-30

SCALE
N/A


BID NO
15.59812

CLV DWG NO
650.111

H#
66624


SHT NO
L.1.03

REVISED 8/22/03

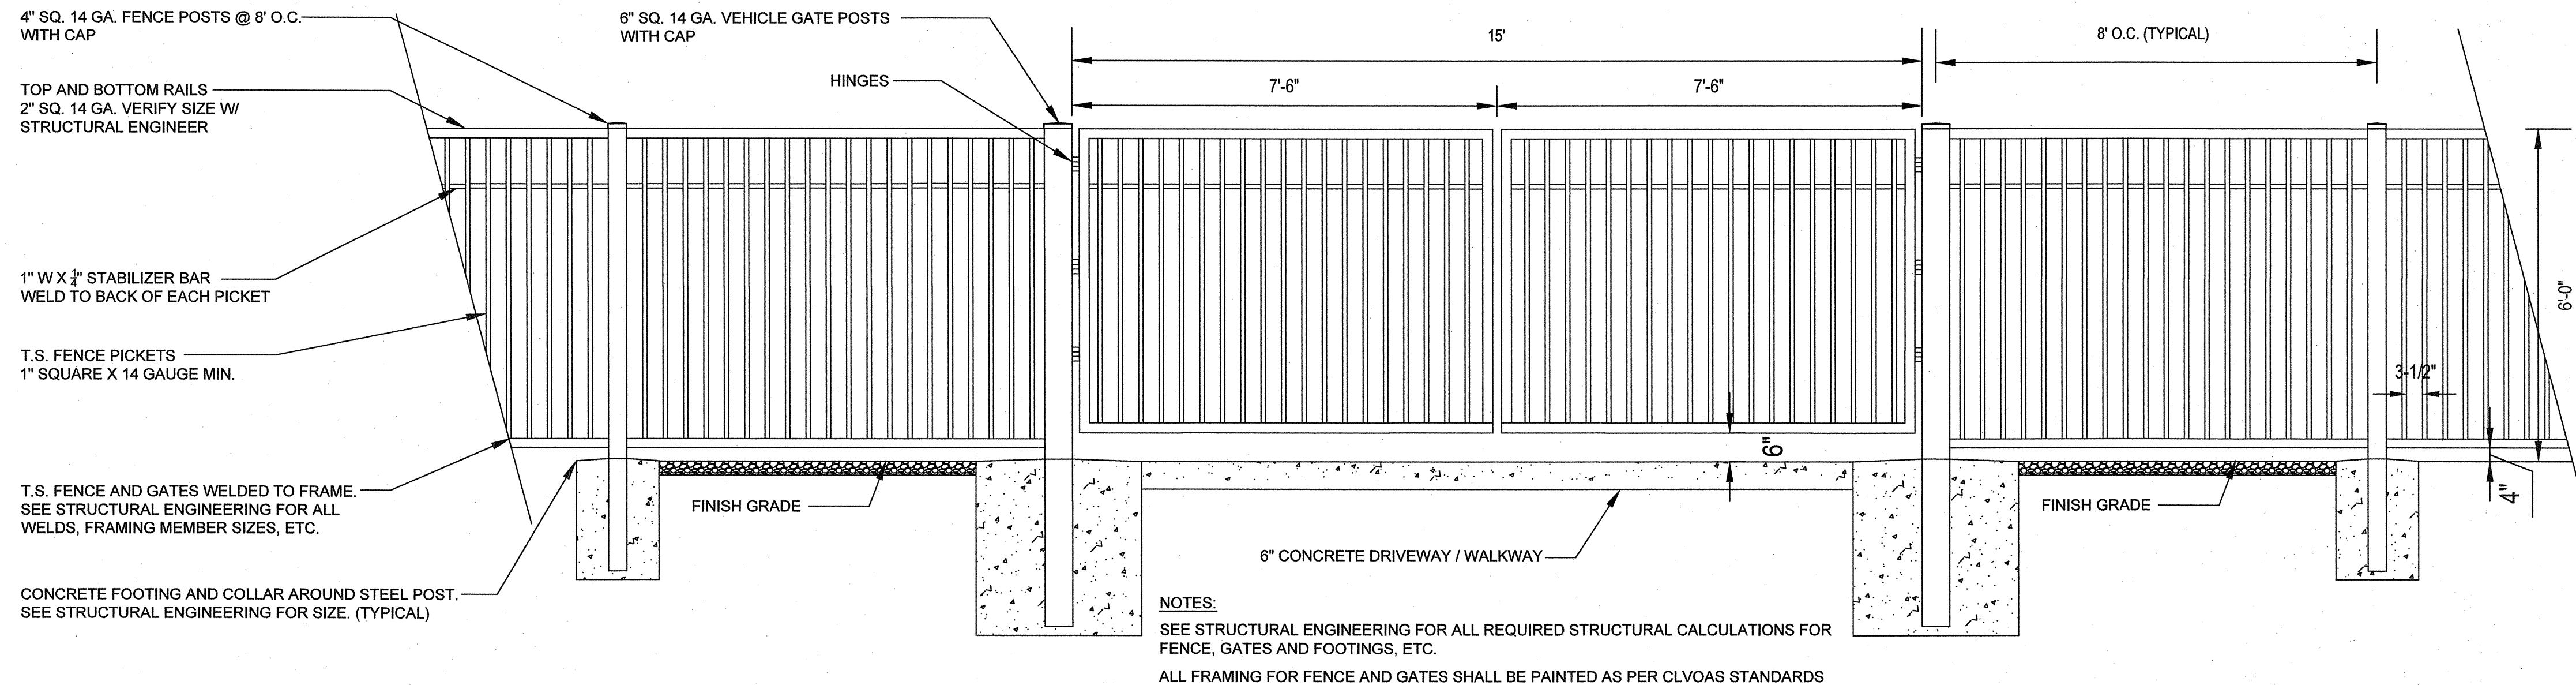

1 15TH STREET VEHICLE ACCESS GATE

NOT TO SCALE

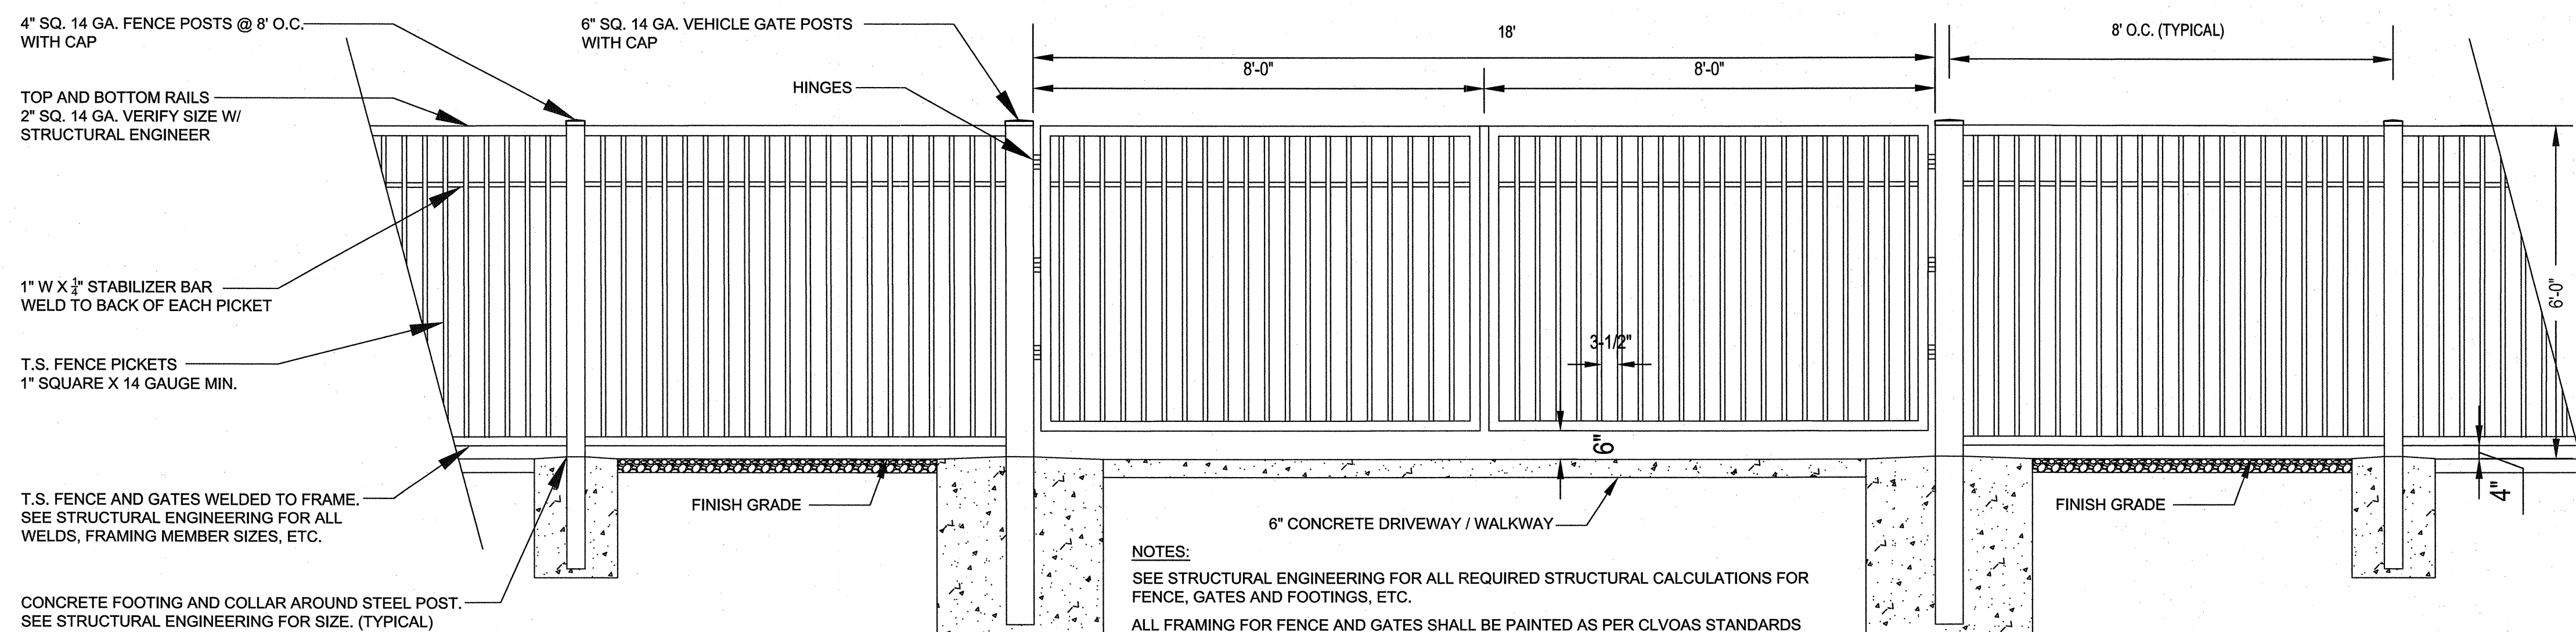


2 16TH STREET VEHICLE ACCESS GATE

NOT TO SCALE

REVISIONS

CONSULTANT

Cardno
Shaping the Future

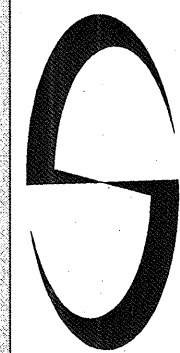


LAS VEGAS
7115 AMIGO STREET, STE 100, LAS VEGAS, NV 89119
TEL: (702) 990-9300 FAX: (702) 990-9305 www.cardno.com

MAYFAIR PLACE PARK

SITE DETAILS

STAMP

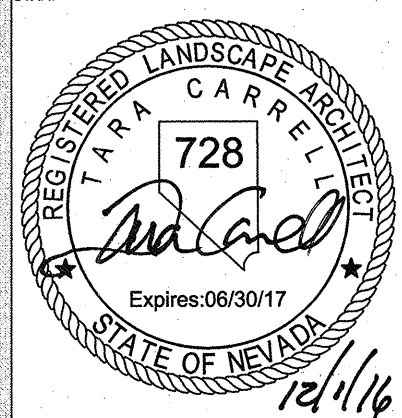

OWNER: CITY OF LAS VEGAS
DEPARTMENT OF PUBLIC WORKS

400 EAST STEWART AVENUE
LAS VEGAS, NEVADA 89101
PHONE: (702) 229-5535
FAX: (702) 382-3232
TDD: (702) 386-9108

DRAWN: TCC

PROJECT: 1099-CD-DETAILS L.1.01-1.06.DWG

DATE: 2016-11-30

SCALE: N/A

BID NO: 15.59812


CLV DWG NO: 650.111

H# 66624

SHT NO

L.1.04

REVISED 8/27/03

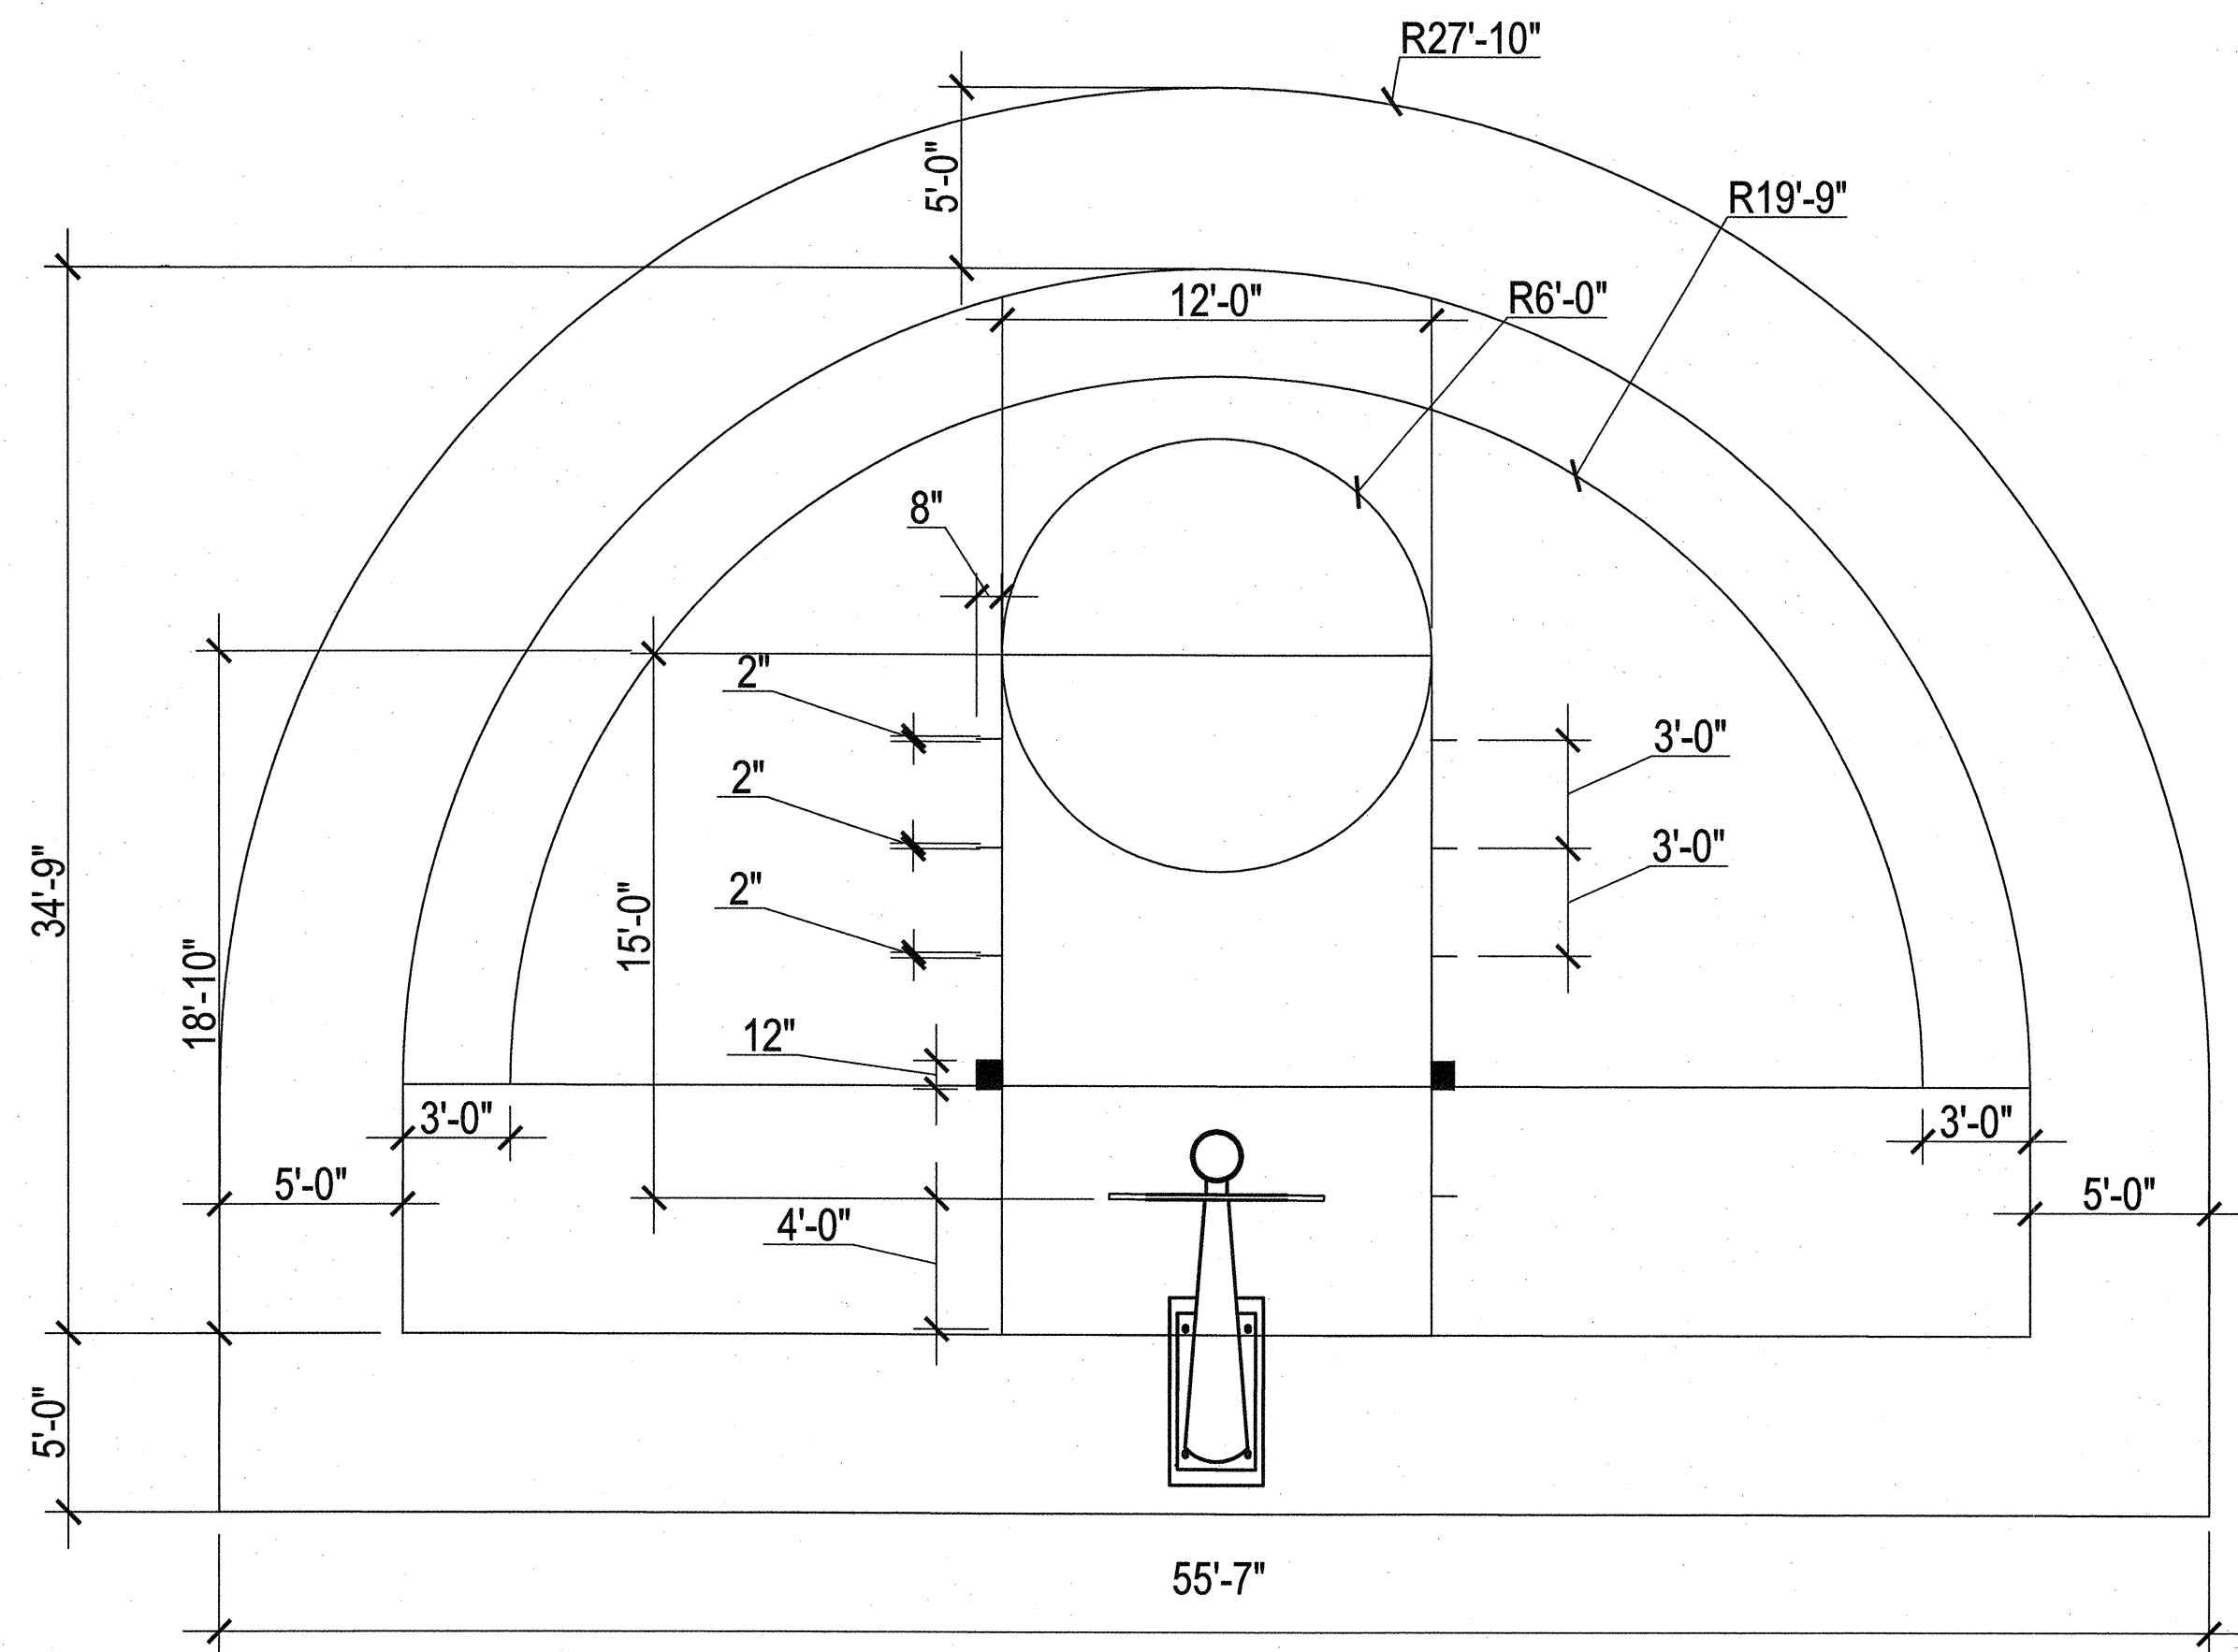


- NOTES:
1. DIMENSION FROM "OUT-OF-BOUNDS" LINE TO EDGE OF SLAB IS 5'-0" TYPICAL MINIMUM.
 2. ALL COURT STRIPING SHALL BE 2" WIDE & CENTERED OVER GUIDE LINES LAID OUT AS DIMENSIONED.
 3. ALL COURT LINES SHALL BE WHITE
 4. CONTRACTOR SHALL PROVIDE ALL POSTS, BACKBOARDS, NETS, INSTALLATION, AND FINISHING FOR A COMPLETE WORKING INSTALLATION. SEE SPECS.
 5. CONTRACTOR TO INSTALL PER MANUFACTURER'S RECOMMENDATIONS.
 6. CONTRACTOR SHALL BE RESPONSIBLE FOR COMPLYING WITH ALL GOVERNING CODES, AND PULLING ALL REQUIRED PERMITS
 7. WAUSAU TILE PRECAST BASKETBALL STANDARD MODEL #TF7175, COLOR L22 SAND..
 8. BISON BA33U DOUBLE-RIM HEAVY DUTY FLEX GOAL.

3 COURT STRIPING AND LAYOUT



NOT TO SCALE

- NOTES:
1. WORK SHALL BE PERFORMED BY CERTIFIED USTA CONTRACTORS - SEE STRUCTURAL SPECS
 2. LENGTH OF CABLE SECTIONS SHALL EXTEND BEYOND EDGES OF SLAB FOR TIGHTENING & ANCHORING
 3. COORDINATE CABLE LOCATIONS W/BASKETBALL STANDARDS.

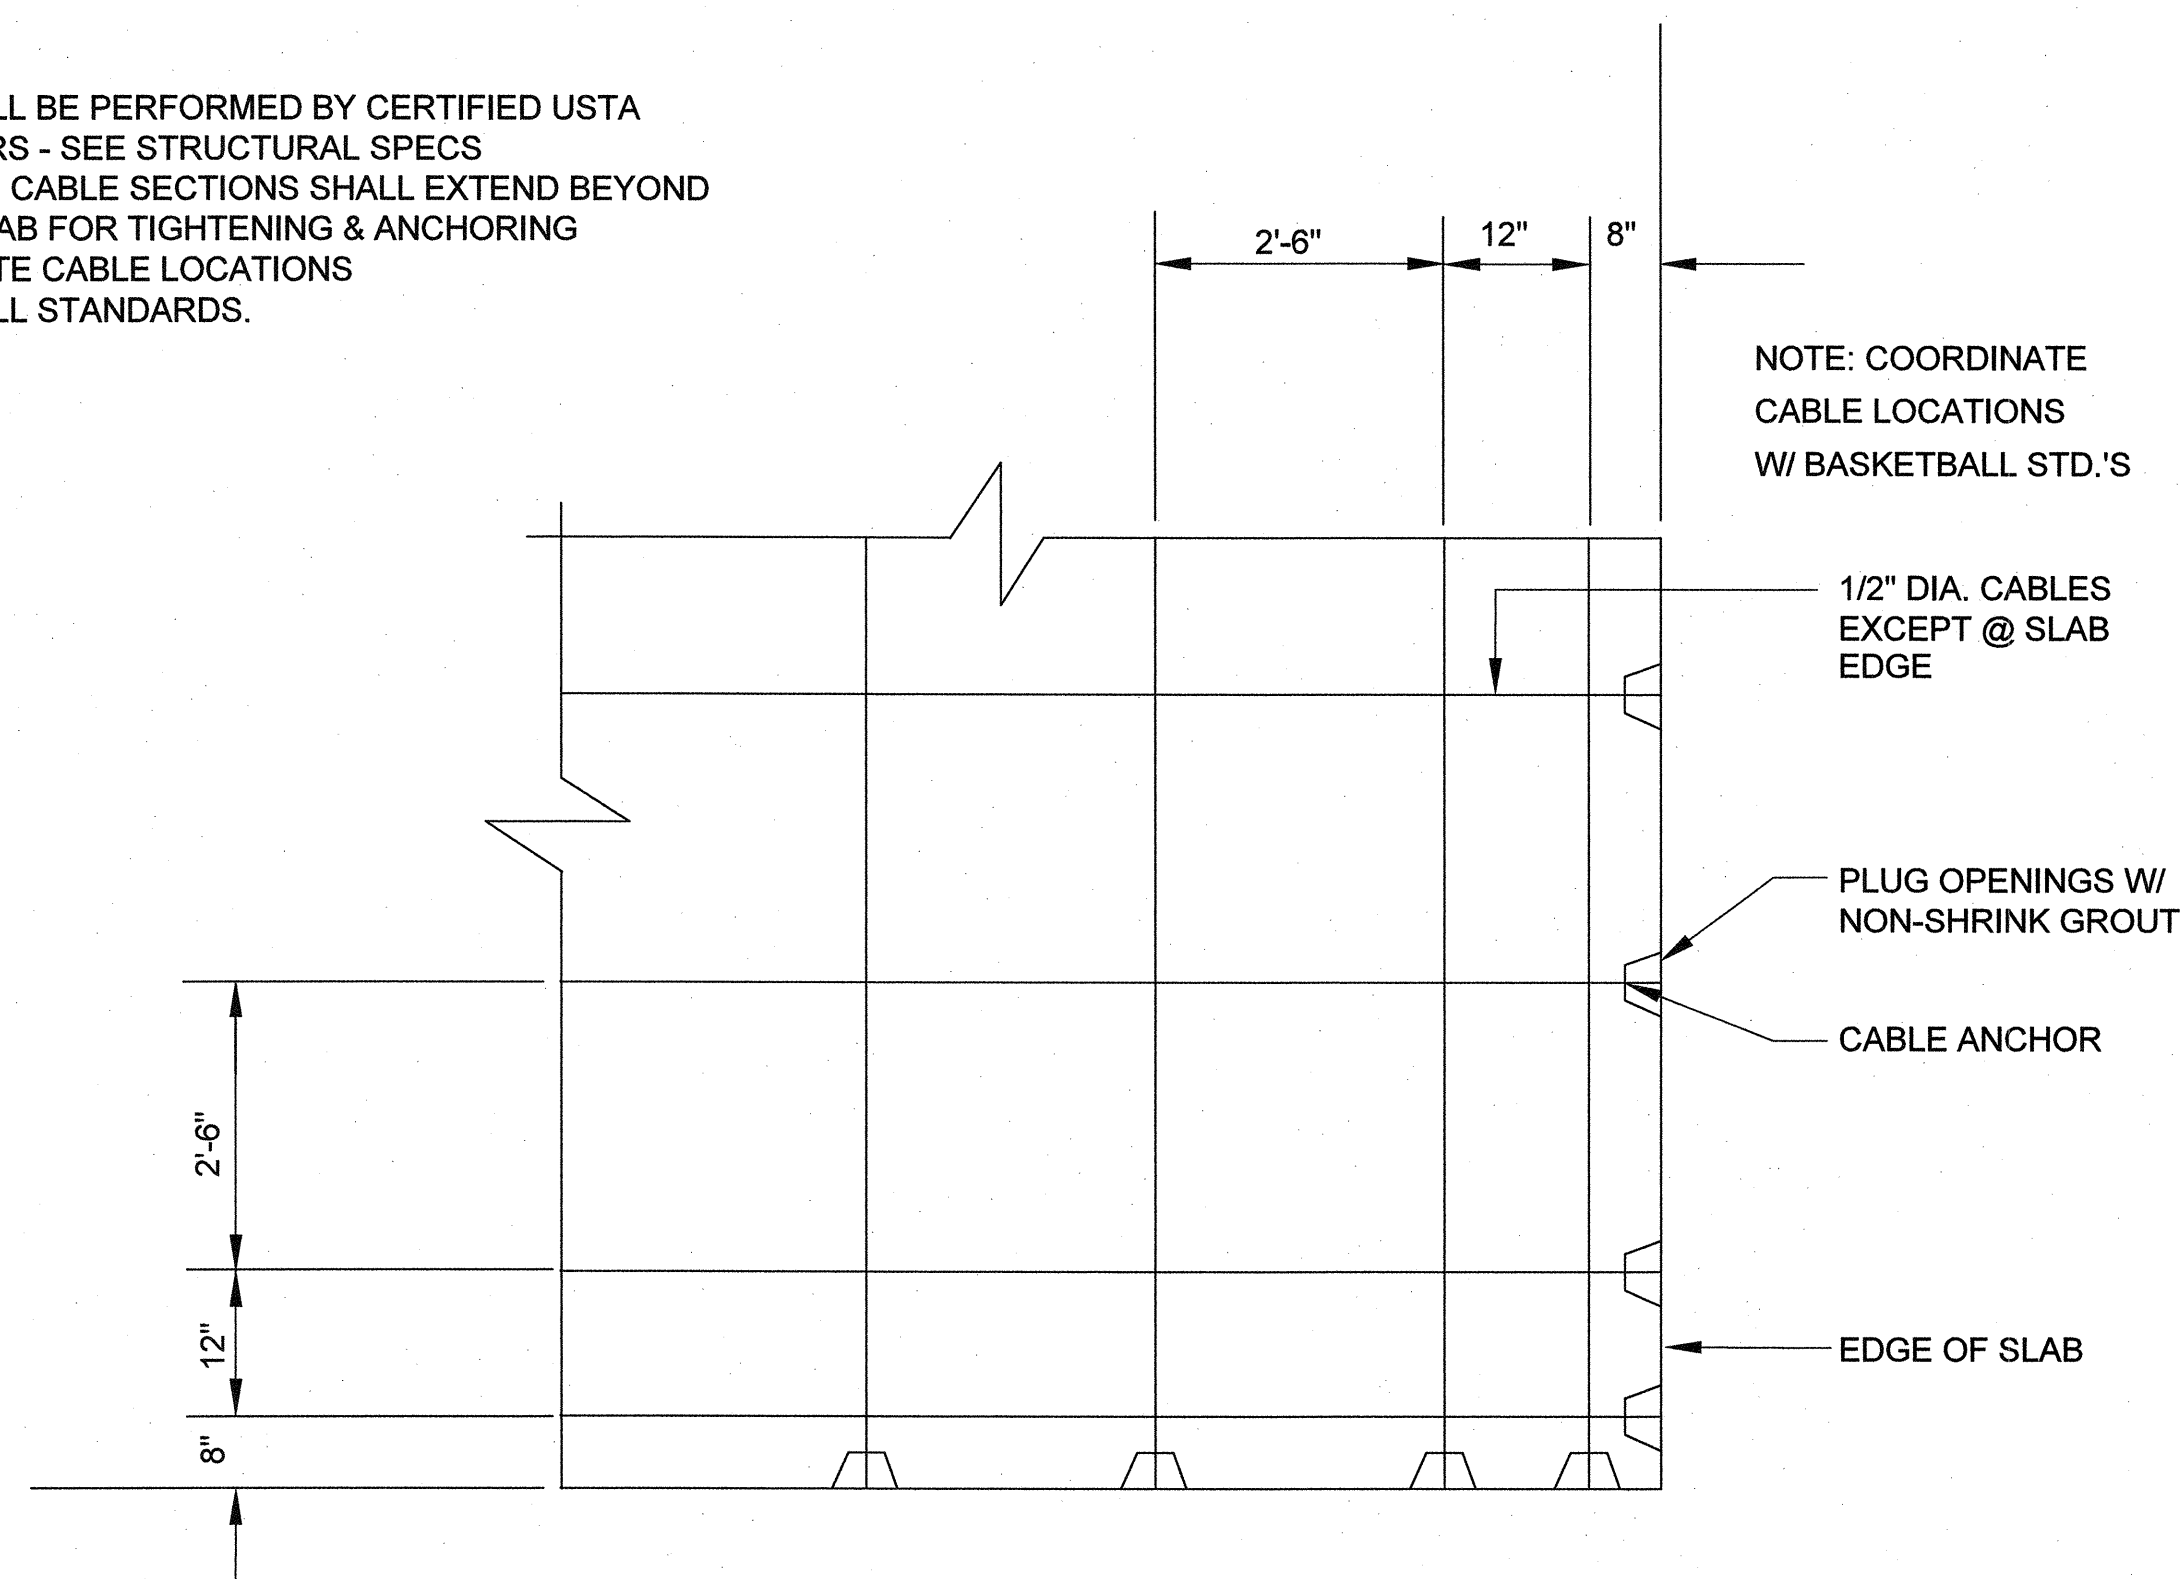

4 TENSION CABLE LAYOUT


NOT TO SCALE

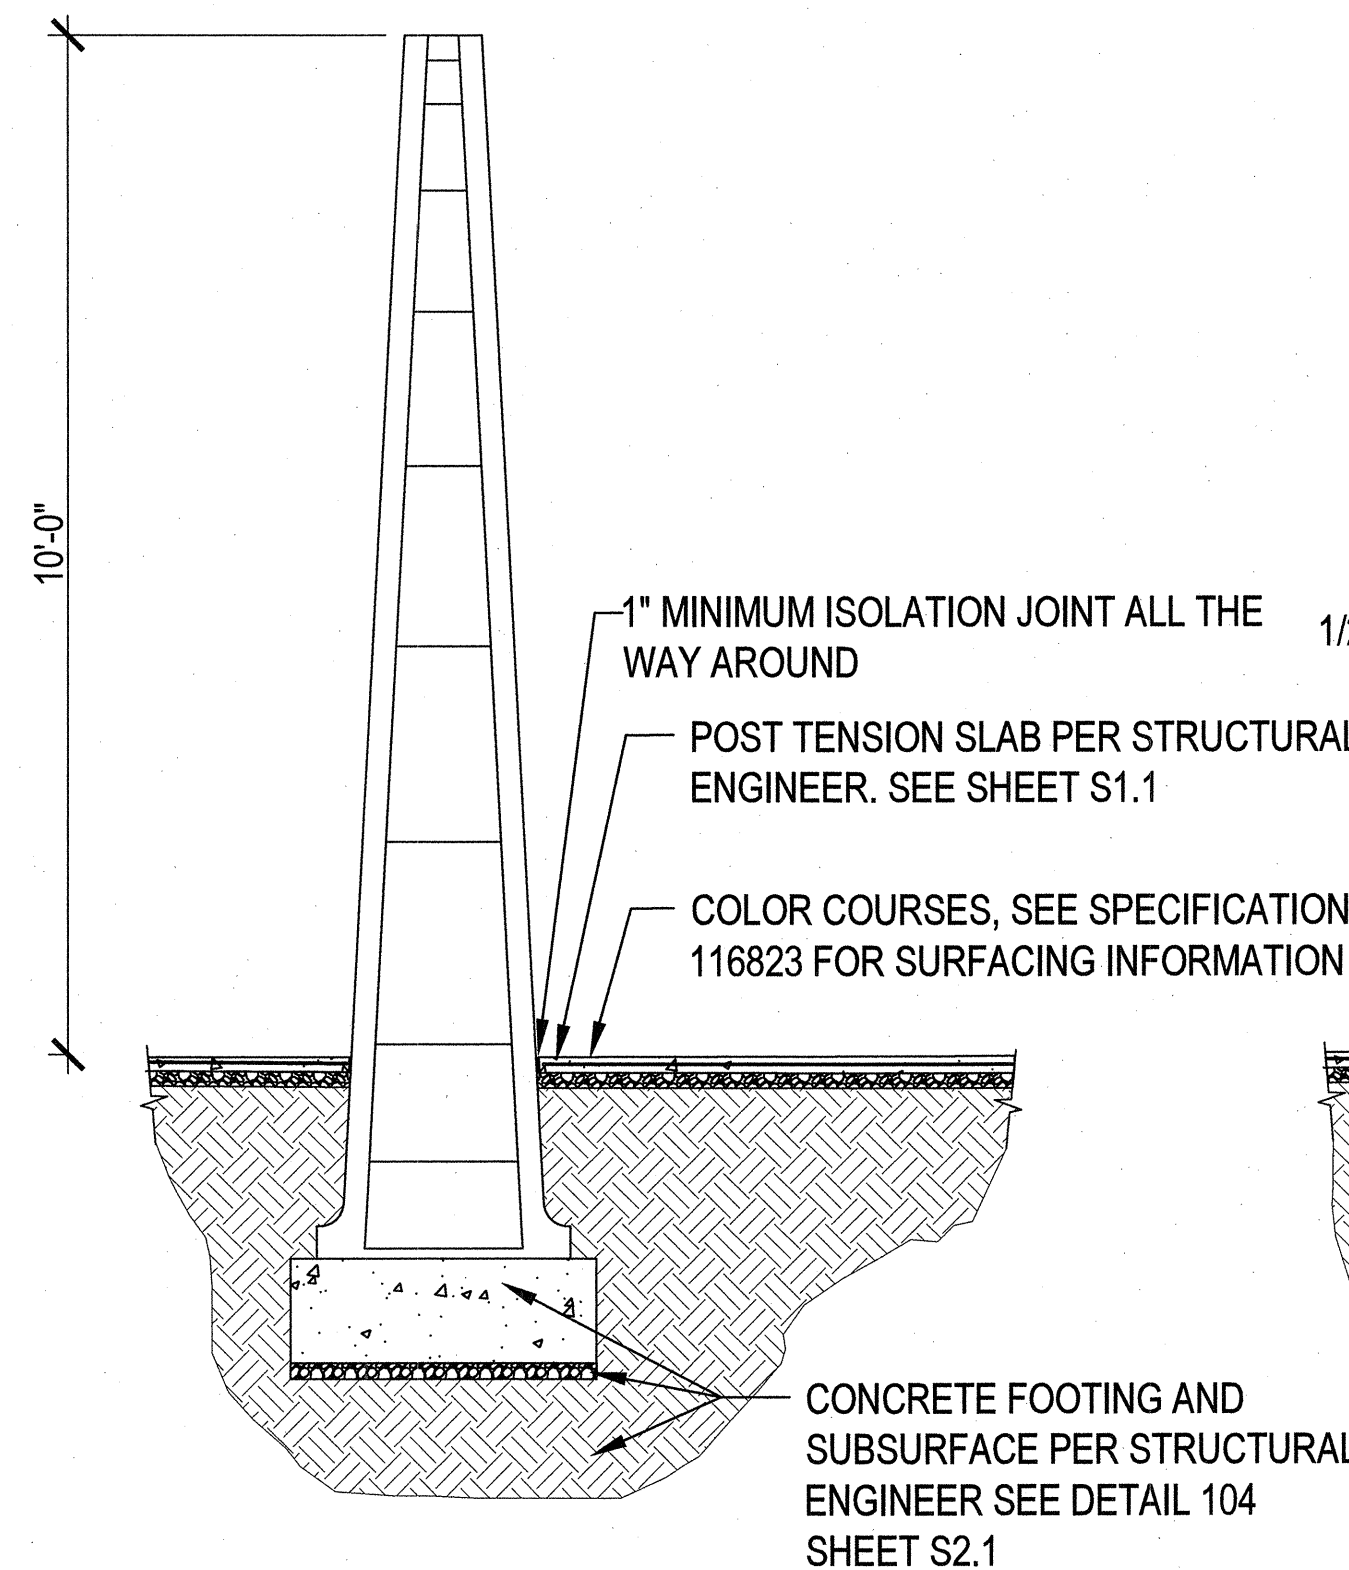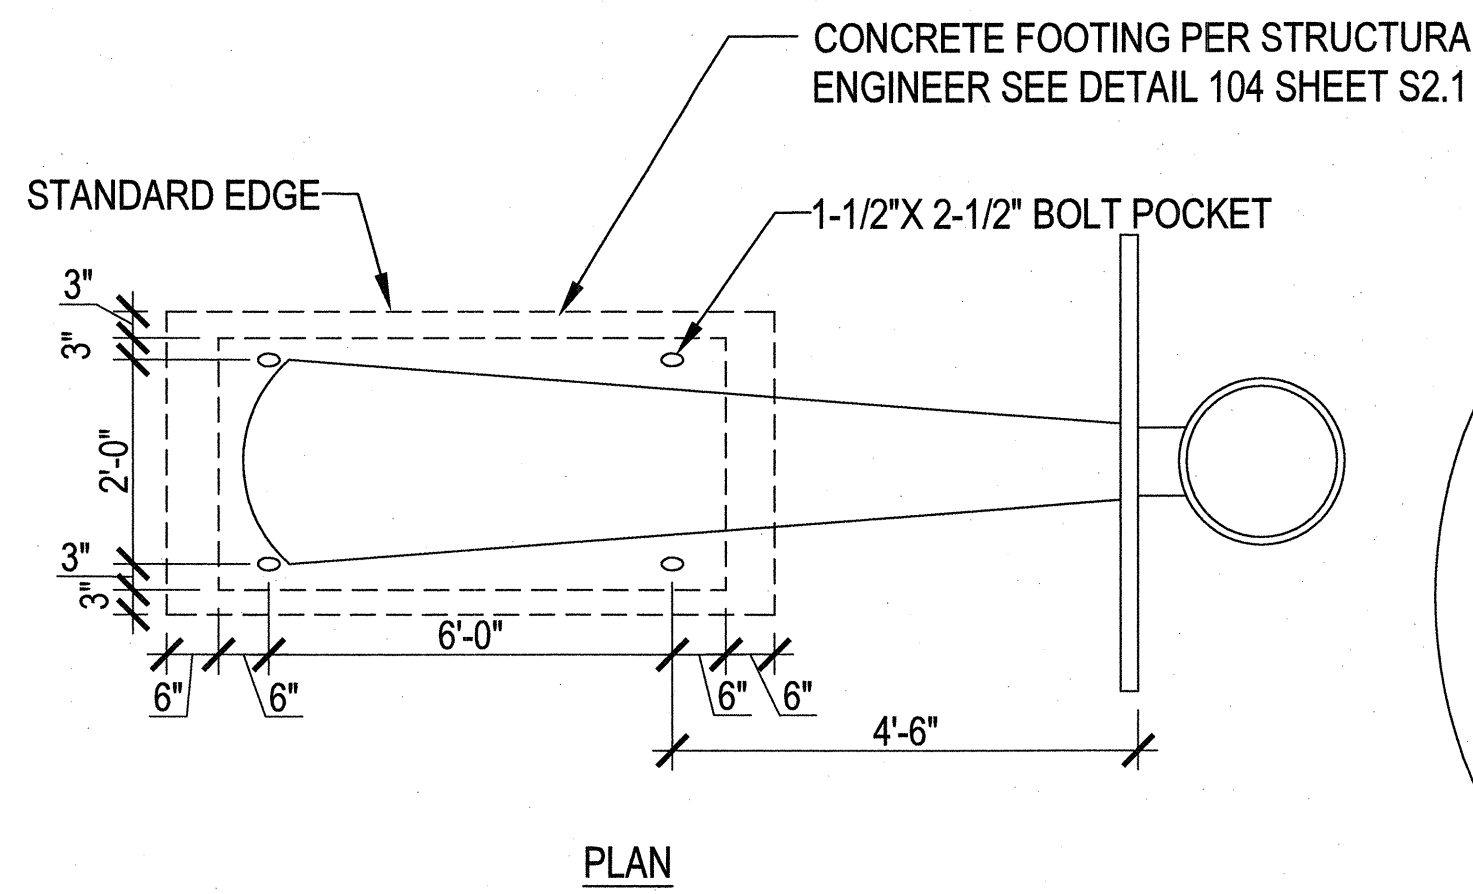

PRECAST CONCRETE BASKETBALL STANDARD MODEL # TF7175 COMPLETE WITH 60" x 42" STEEL RECTANGULAR BASKETBALL BACKBOARD MODEL # TF7182 AND DOUBLE RIM HEAVY DUTY RECREATION FLEX GOAL MODEL # TF7178. ALL STANDARD NYLON NETS TO BE REPLACED WITH OPTIONAL CHAIN NETS. CHAIN NETS MUST BE SPECIFIED WHEN ORDERING RIMS. AVAILABLE FROM WAUSAU (800) 388-8728 OR APPROVED EQUAL
COLOR: L22 SAND

1 BASKETBALL STANDARD

NOT TO SCALE

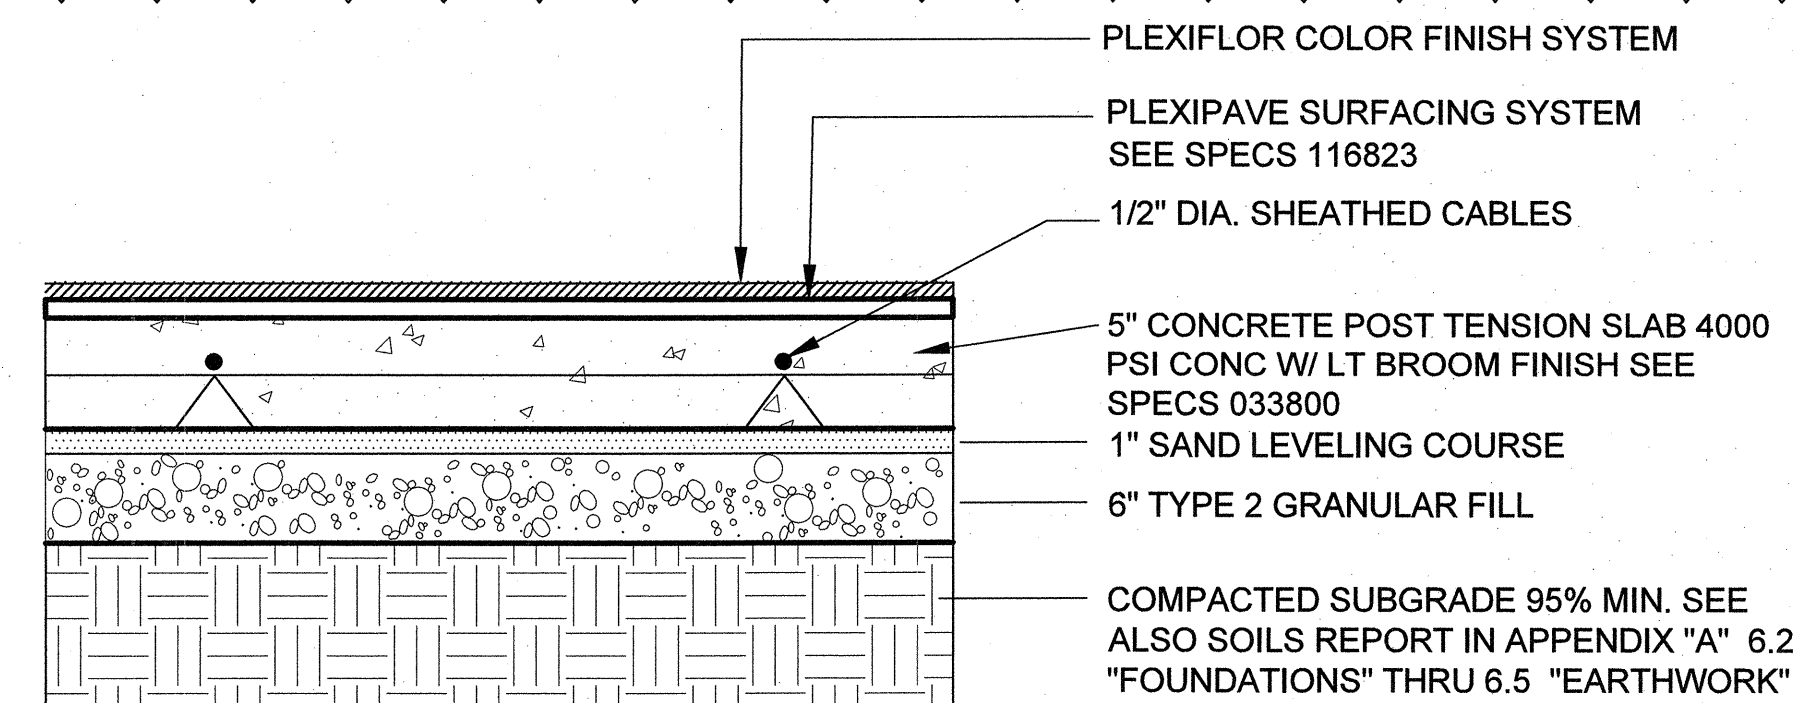


- NOTES:
1. WORK SHALL BE PERFORMED BY CERTIFIED USTA CONTRACTORS-SEE SPECS SECTION 033800
 2. NO CURING AGENTS/HARDENERS SHALL BE USED FOR SURFACING SYSTEM SPECIFIED - SEE SPECS 033800
 3. BASKETBALL COURTS MUST BE A LASER LEVELED INSTALLATION
 4. STAMP CONCRETE "POST-TENSION CABLES" OR AS DIRECTED BY OWNER IN MINIMUM 4 PLACES

2 POST TENSION SLAB

NOT TO SCALE

NOTE: ITEMS CALLED OUT AS PER STRUCTURAL ENGINEER ARE SHOWN IN THIS DETAIL FOR ILLUSTRATIVE PURPOSES ONLY - SEE SPECIFIED STRUCTURAL ENGINEERING DRAWING FOR BIDDING AND CONSTRUCTION PURPOSES.

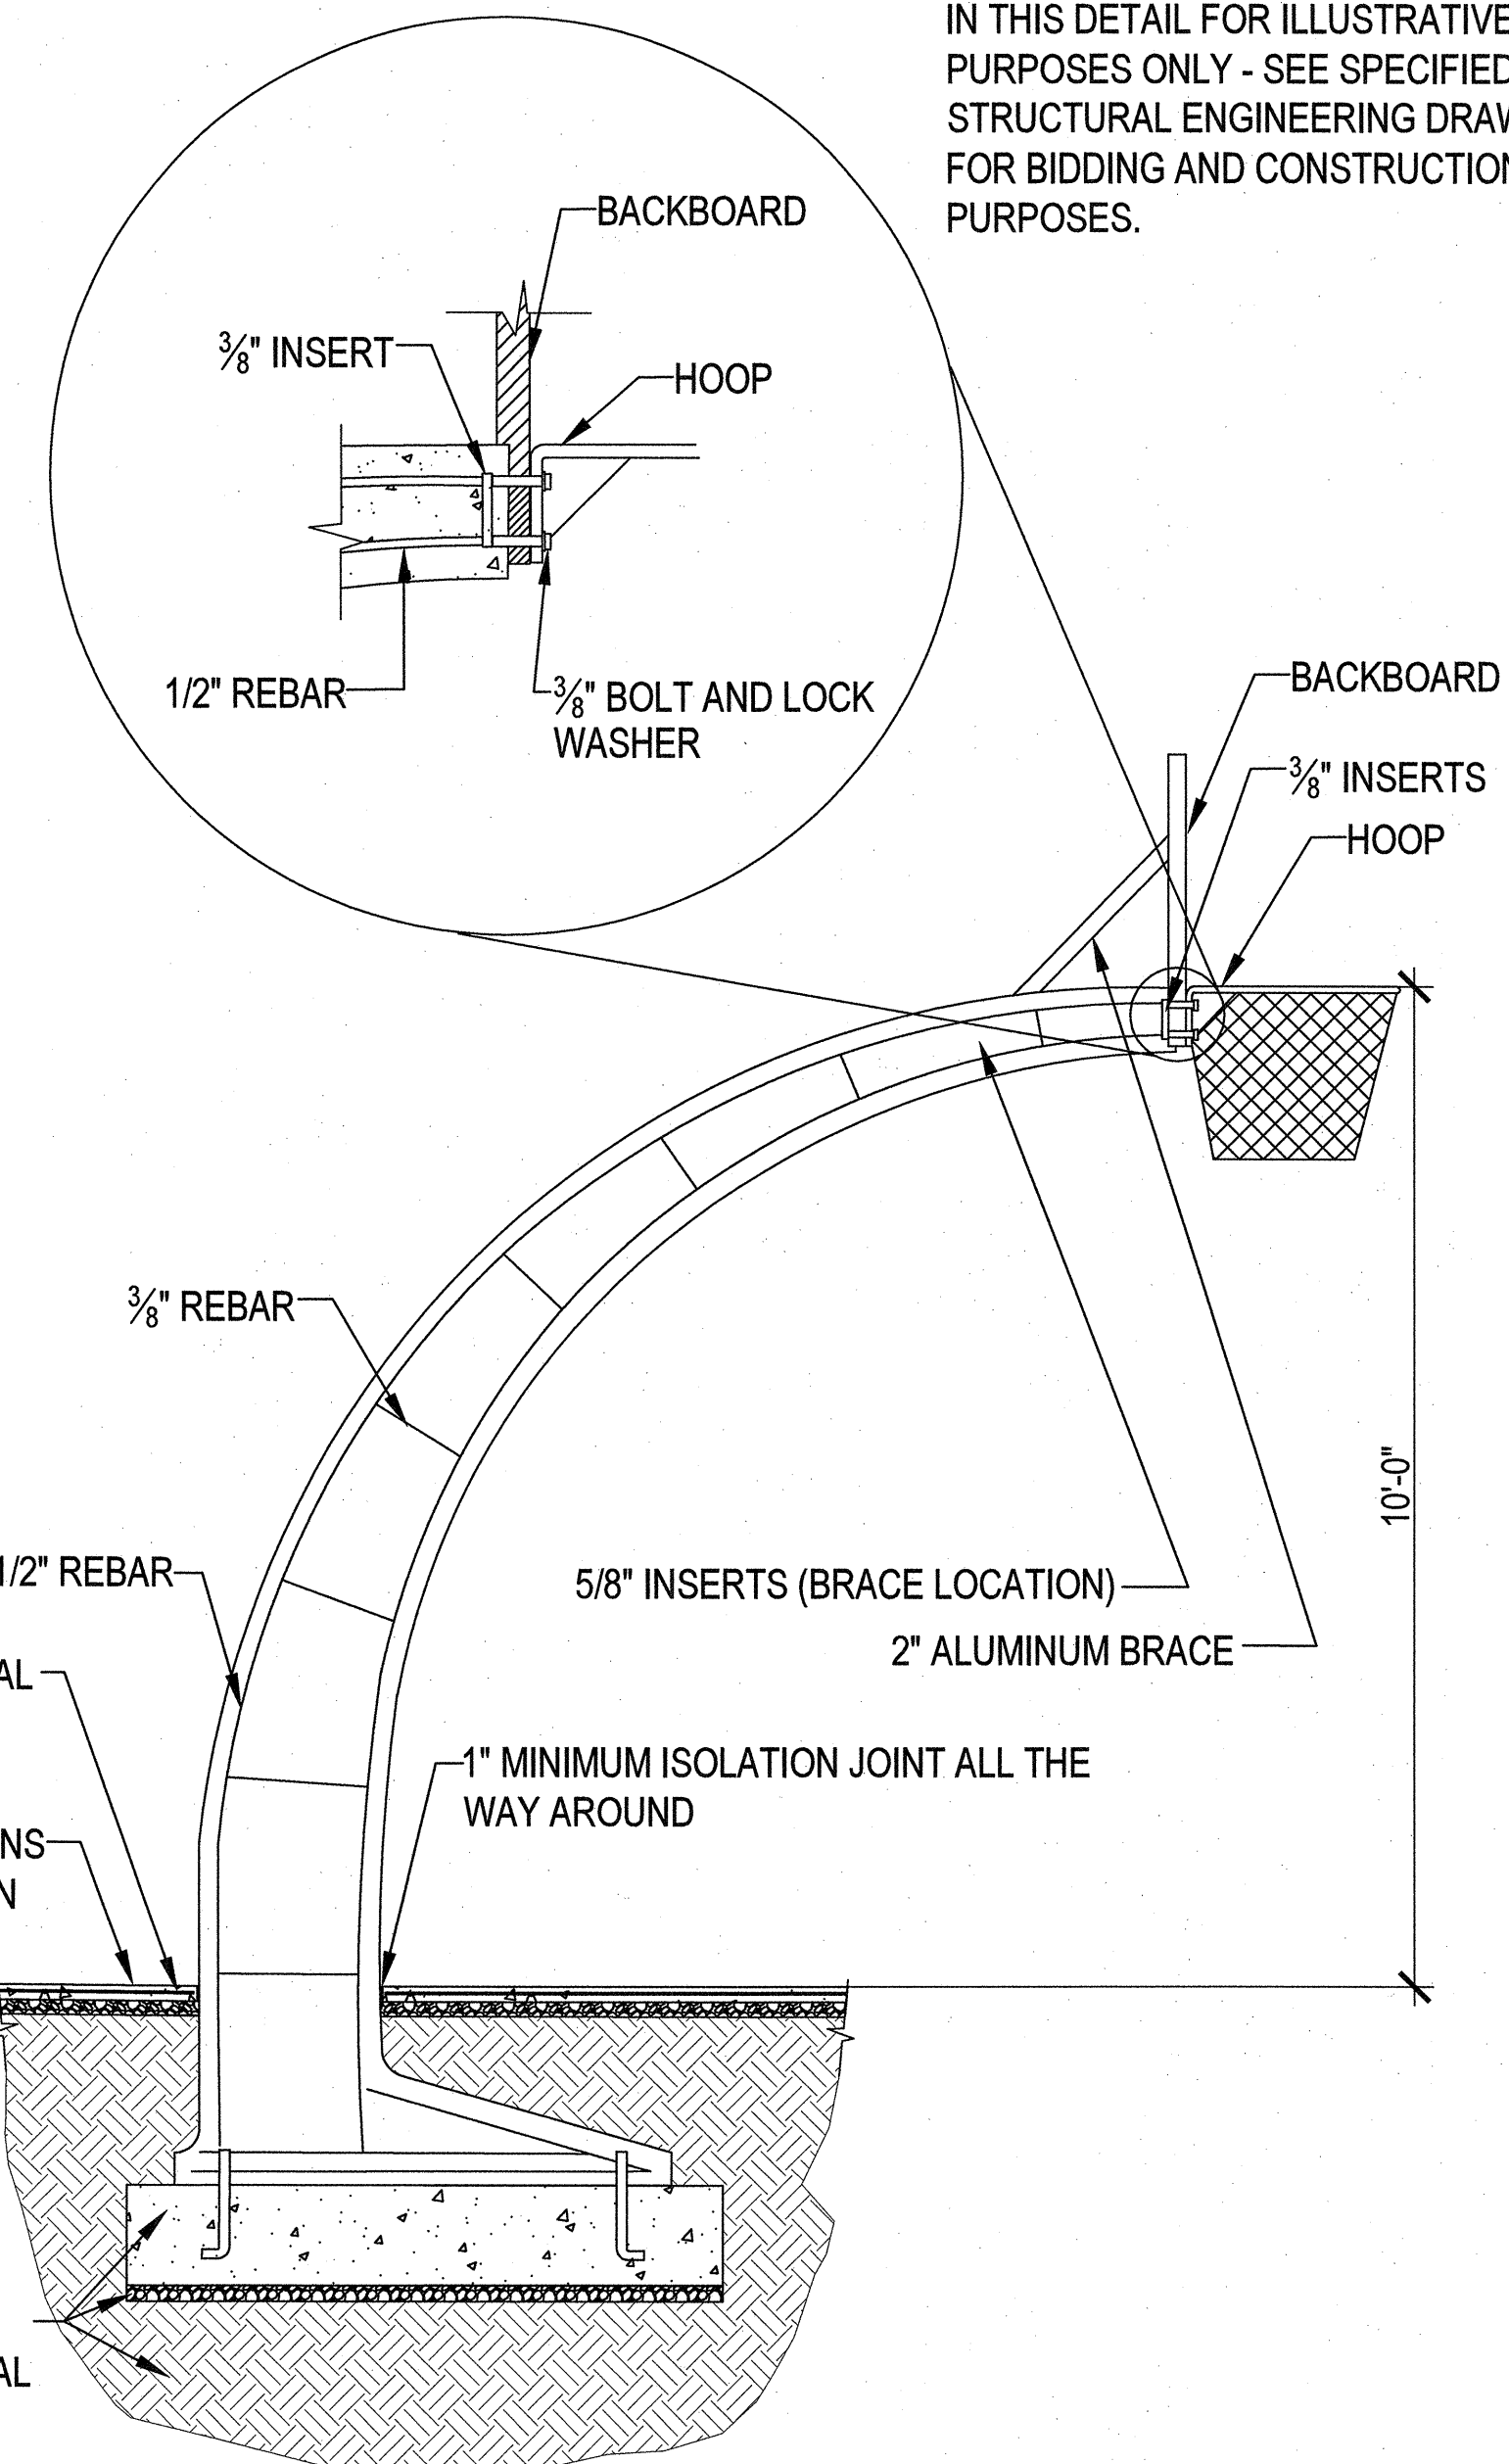

REVISIONS
REV/PLAN CHECK 10/19/16


CONSULTANT

Cardno
Shaping the Future
LAS VEGAS
7115 AMIGO STREET, STE 100, LAS VEGAS, NV 89119
TEL: (702) 990-9300 FAX: (702) 990-9305 www.cardno.com

MAYFAIR PLACE PARK

SITE DETAILS

STAMP

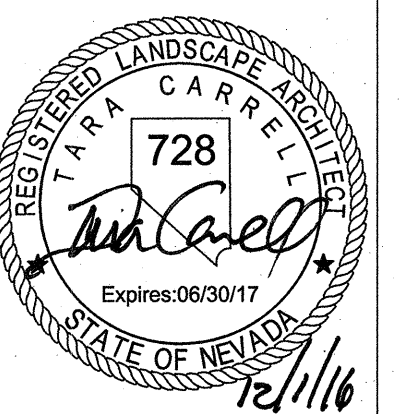

OWNER: CITY OF LAS VEGAS
DEPARTMENT OF PUBLIC WORKS

400 EAST STEWART AVENUE
LAS VEGAS, NEVADA 89101
PHONE: (702) 229-6535
FAX: (702) 386-3232
TDD: (702) 386-9108

DRAWN TCC

FILE 1099-CD-DETAILS L.1.01-1.06.DWG

DATE 2016-11-30

SCALE N/A

BID NO 15.59812


CLV DWG NO 650.111

H# 66624

SHEET NO

L.1.06

REVISED 8/27/03

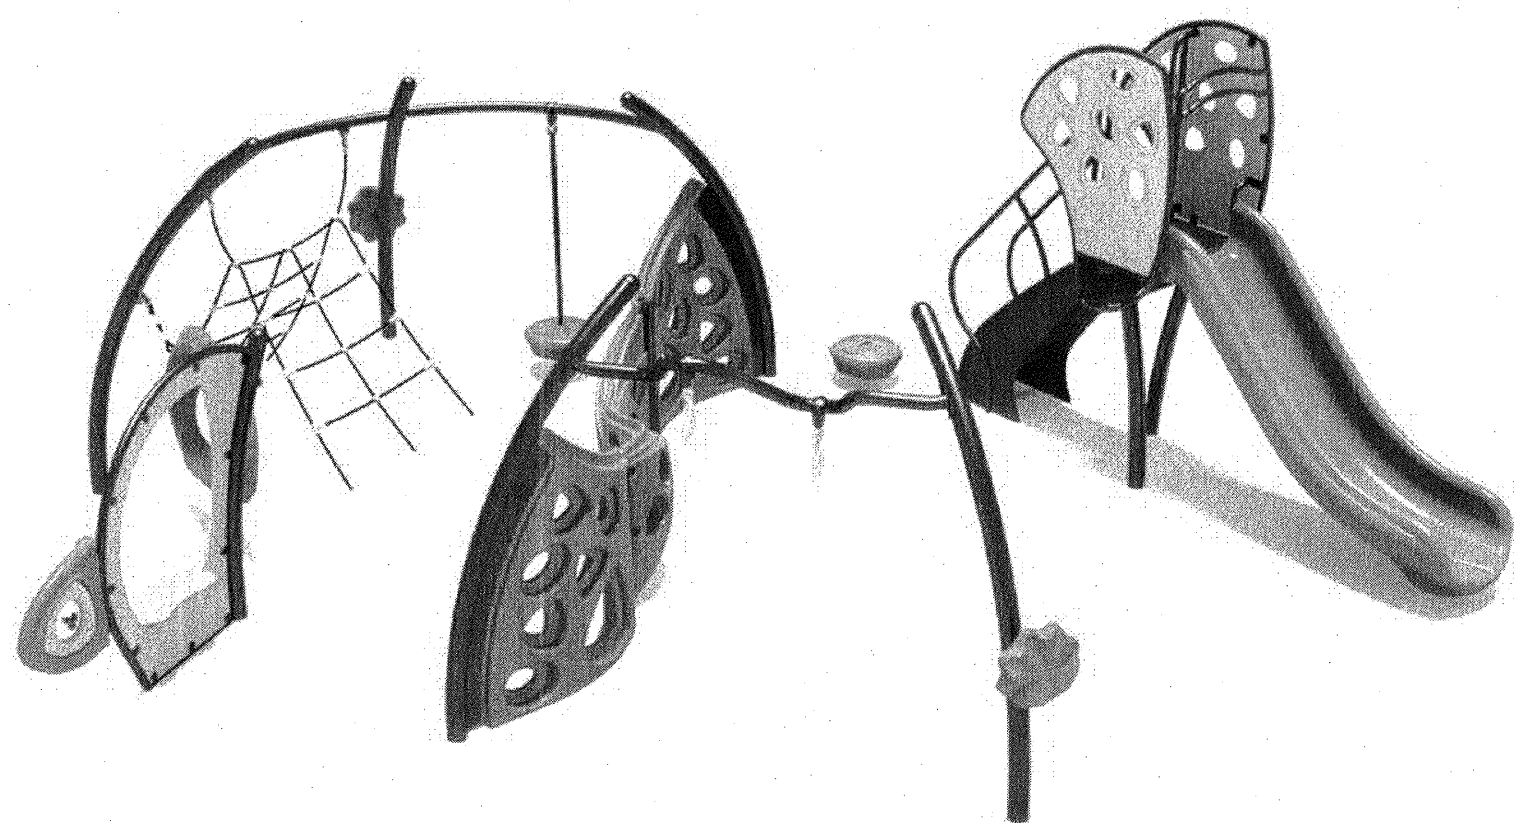

Front View

MANUFACTURER: PLAY & PARK STRUCTURES; 1-800-727-1907
MODEL #: 40-94450
COLORS: ENERGETIC SCHEME


UPRIGHT POSTS: YELLOW
PLASTICS: SKY BLUE / SPRING GREEN
METAL: SPRING GREEN
DECK: BLUE
CABLES: BLACK

5 2-5 YR. OLD TOT LOT PLAY EQUIPMENT

NOT TO SCALE


4 PLAY EQUIPMENT COLOR CHART

NOT TO SCALE

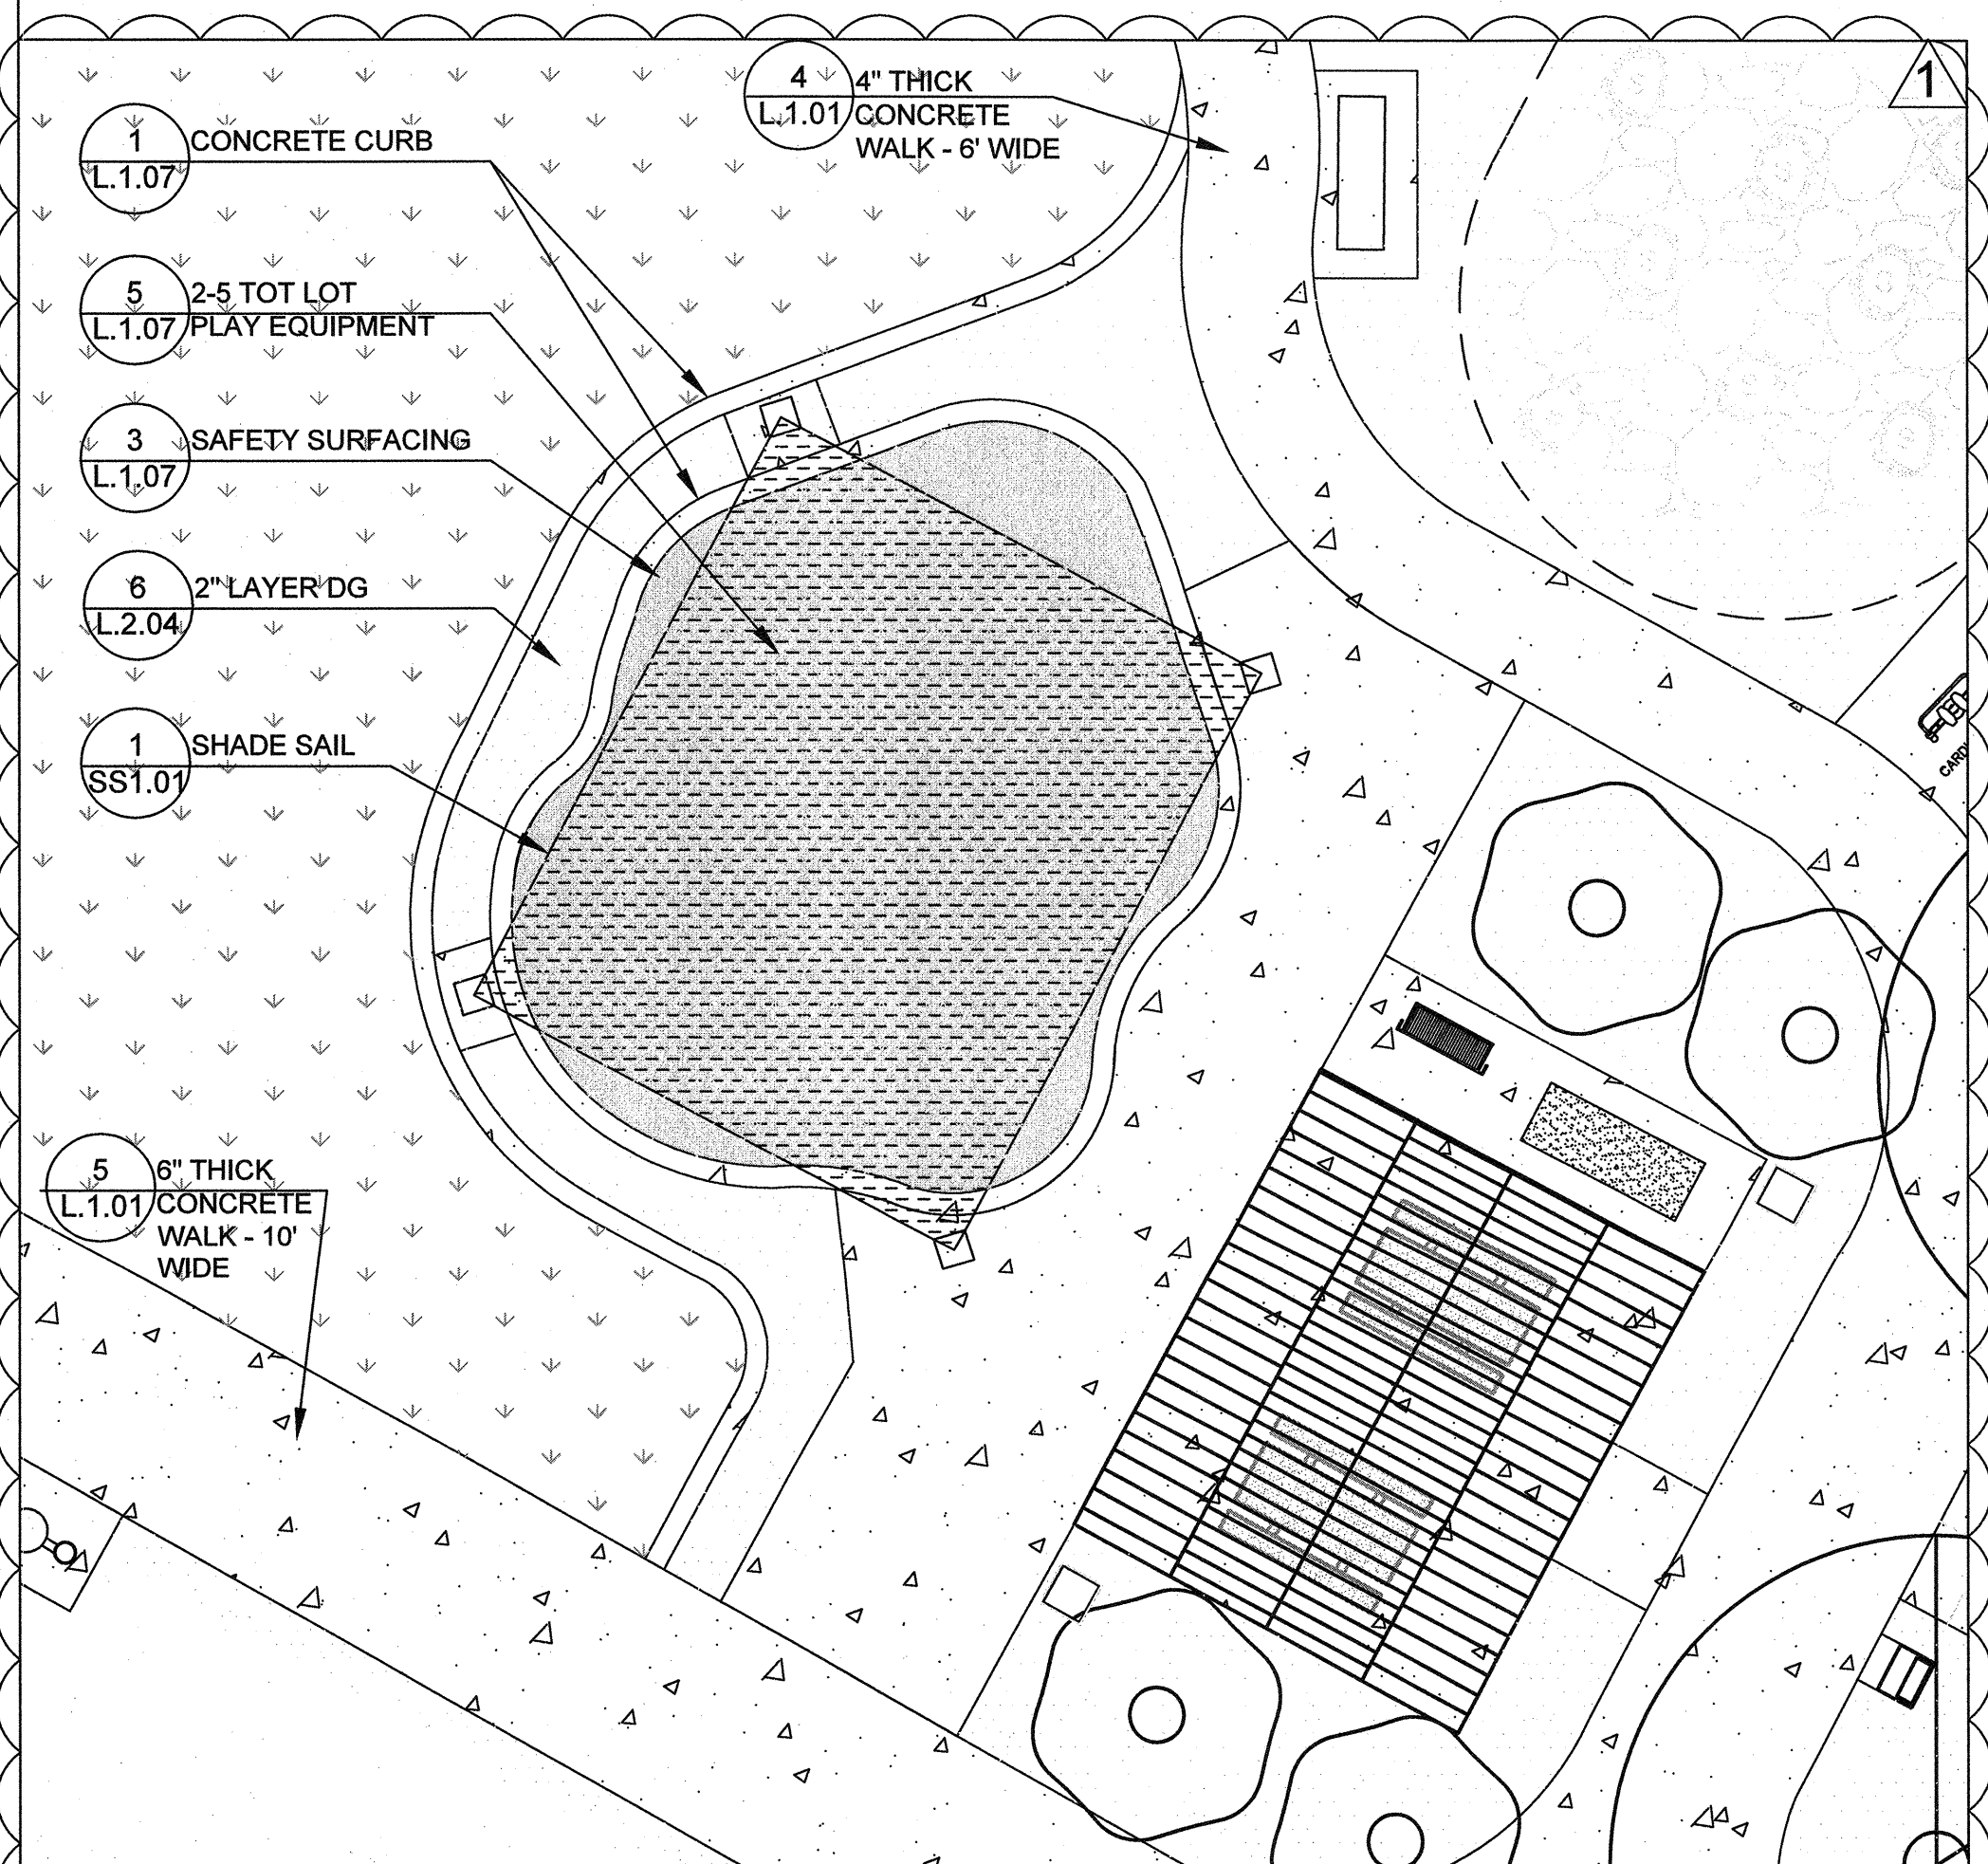

6 PLAYGROUND LAYOUT


NOT TO SCALE

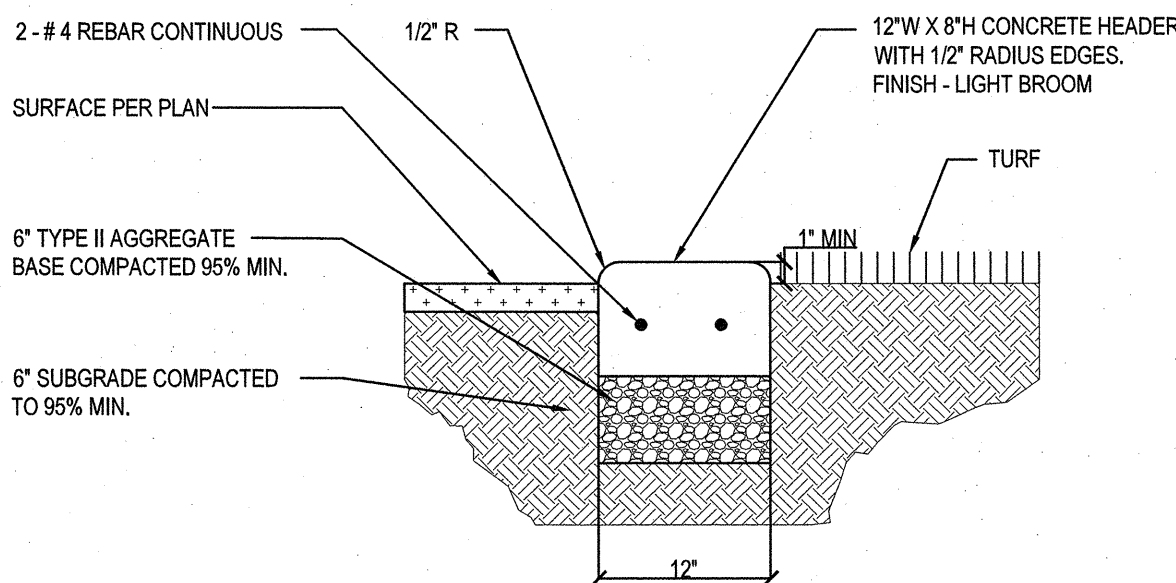

- NOTES:
- 1/2" EXPANSION JOINTS EVERY 10'
 - CONTROL JOINTS EVERY 5'

1 CONCRETE MOW CURB


NOT TO SCALE

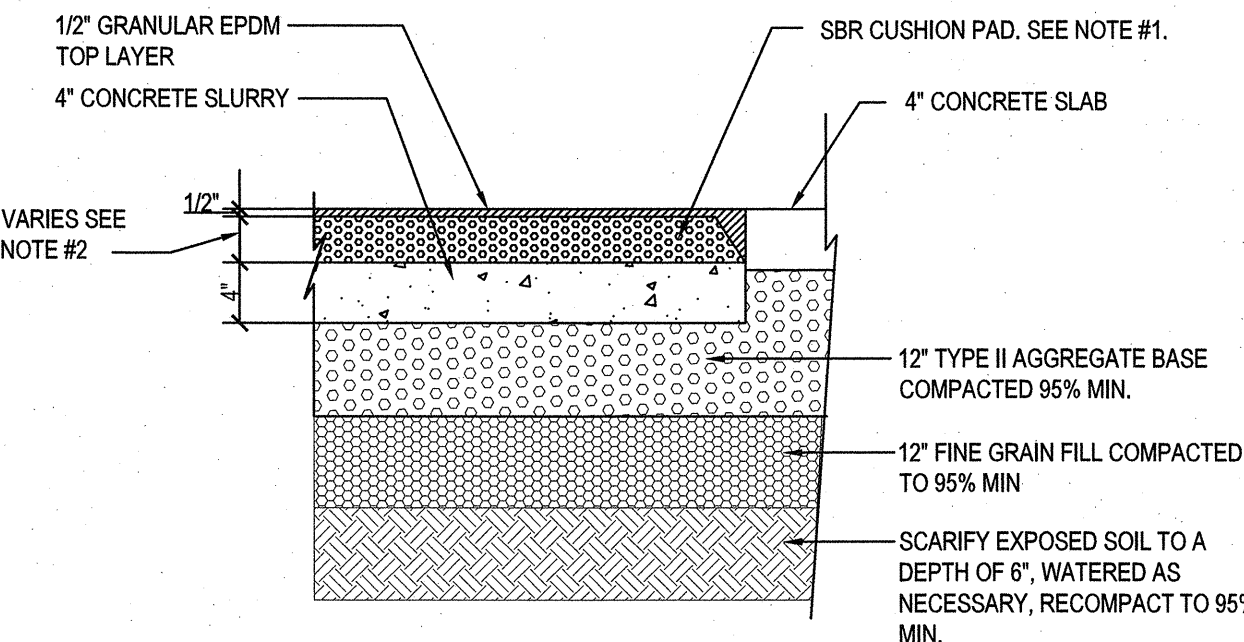

- NOTES:
- OWNERS REPRESENTATIVE SHALL APPROVE FORMWORK PRIOR TO PLACING CONCRETE.
 - CONCRETE UNDERNEATH THE RESILIENT SURFACE IS TO BE TYPE V, 2500 PSI AT 28 DAYS MINIMUM.
 - ALL SPILL OF EXCESS CONCRETE SHALL BE CLEANED UP AND REMOVED FROM SITE BY THE CONTRACTOR.
 - GRADING AT CURB SHALL BE BY THE CONTRACTOR.
 - CONTRACTOR SHALL INSTALL SAFETY SURFACE AS PER MANUFACTURER'S SPECIFICATIONS AND RECOMMENDATIONS.
 - SBR CUSHION PAD DEPTH SHALL BE DETERMINED BY SAFETY SURFACE MANUFACTURER BASED ON THE PLAYGROUND EQUIPMENT FALL HEIGHT.
 - MANUFACTURER: TOT TURF, 7665 COMMERCIAL WAY, SUITE H HENDERSON, NV 89015, 702-303-8701 OR APPROVED EQUAL.
 - COLOR SHALL BE TOT TURF 'MERMAID BLEND' - 50% BLUE, 25% LIGHT BLUE AND 25% TEAL.

2 SAFETY SURFACE AT CONCRETE WALK


NOT TO SCALE

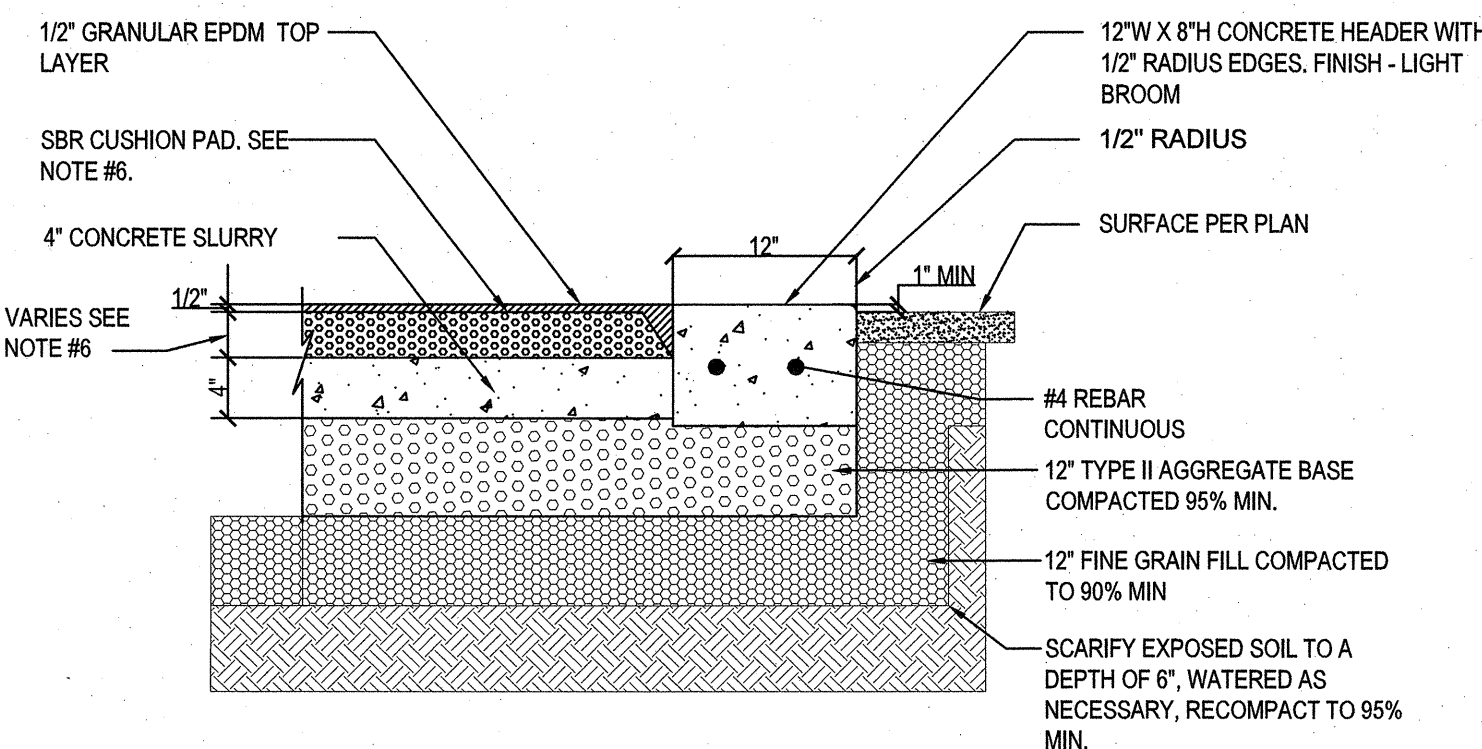

- NOTES:
- OWNERS REPRESENTATIVE SHALL APPROVE FORMWORK PRIOR TO PLACING CONCRETE.
 - CONCRETE UNDERNEATH THE RESILIENT SURFACE IS TO BE TYPE V, 2500 PSI AT 28 DAYS MINIMUM.
 - ALL SPILL OF EXCESS CONCRETE SHALL BE CLEANED UP AND REMOVED FROM SITE BY THE CONTRACTOR.
 - GRADING AT CURB SHALL BE BY THE CONTRACTOR.
 - CONTRACTOR SHALL INSTALL SAFETY SURFACE AS PER MANUFACTURER'S SPECIFICATIONS AND RECOMMENDATIONS.
 - SBR CUSHION PAD DEPTH SHALL BE DETERMINED BY SAFETY SURFACE MANUFACTURER BASED ON THE PLAYGROUND EQUIPMENT FALL HEIGHT.
 - MANUFACTURER: TOT TURF, 7665 COMMERCIAL WAY, SUITE H, HENDERSON, NV 89015, 702-303-8701 OR APPROVED EQUAL.
 - COLOR SHALL BE TOT TURF 'MERMAID BLEND' - 50% BLUE, 25% LIGHT BLUE AND 25% TEAL.


3 SAFETY SURFACE AT CONCRETE CURB

NOT TO SCALE

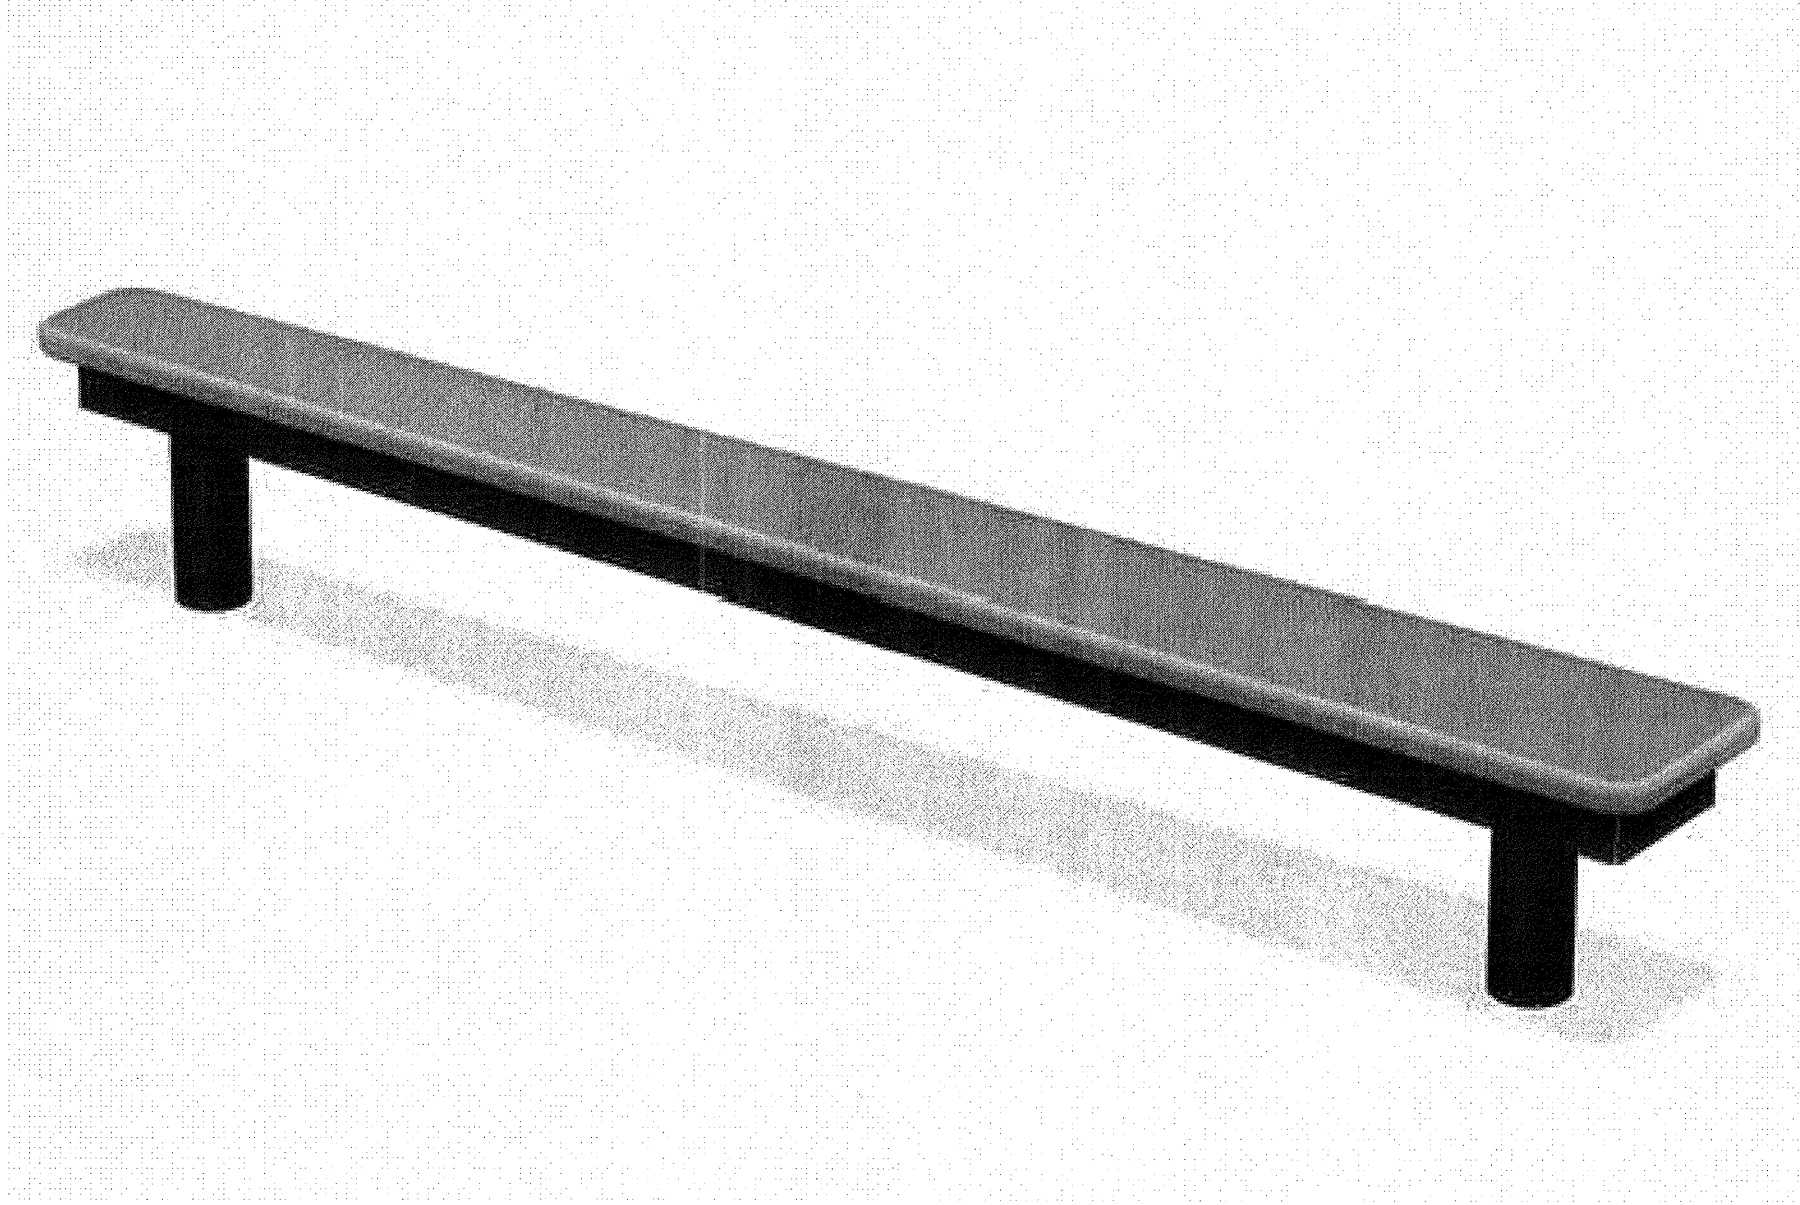

7 UP 176 BALANCE PLANK STATION

NOT TO SCALE

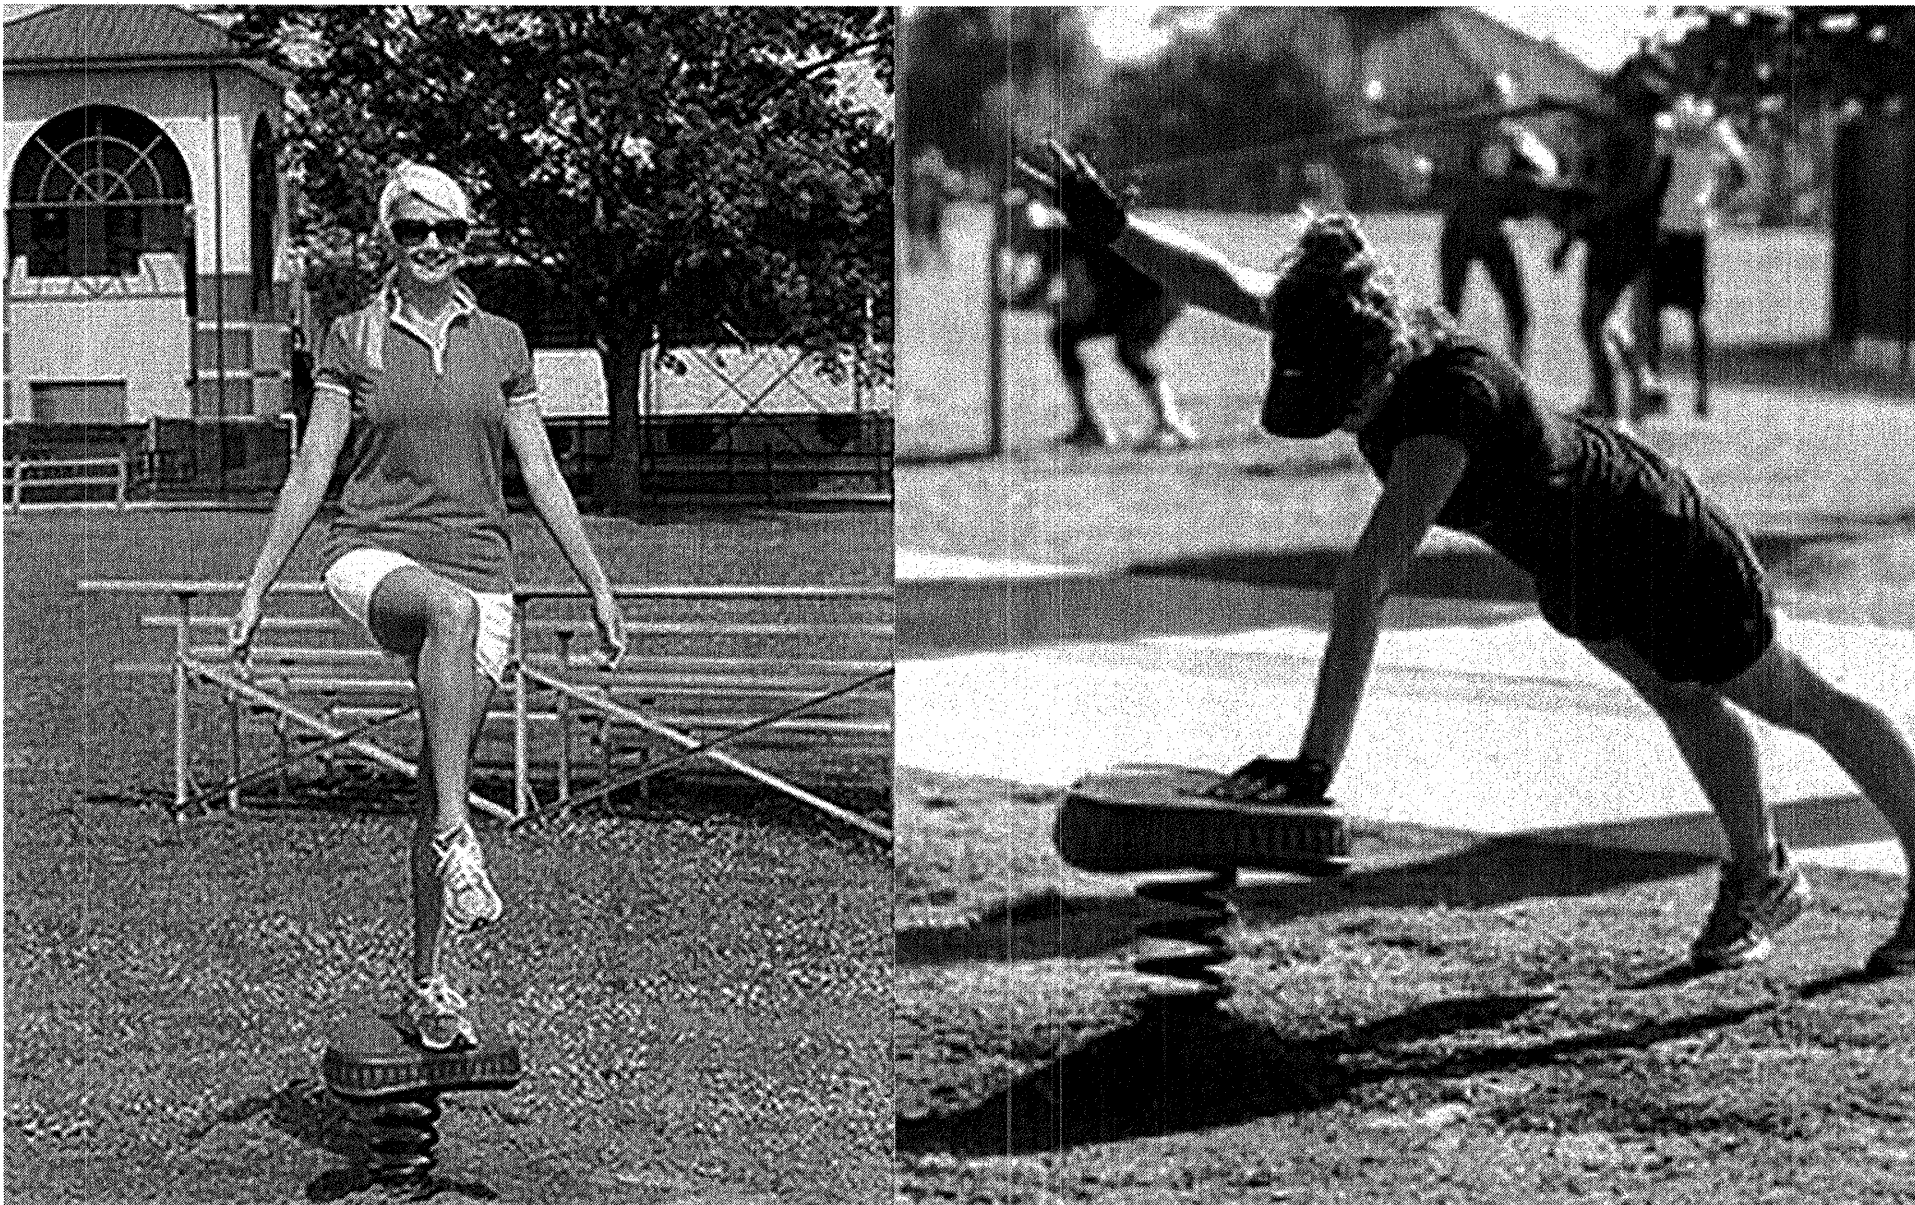


4 UP 260 WOBBLE BOARD STATION

NOT TO SCALE




1 UP 255 PUSH UP STATION

NOT TO SCALE

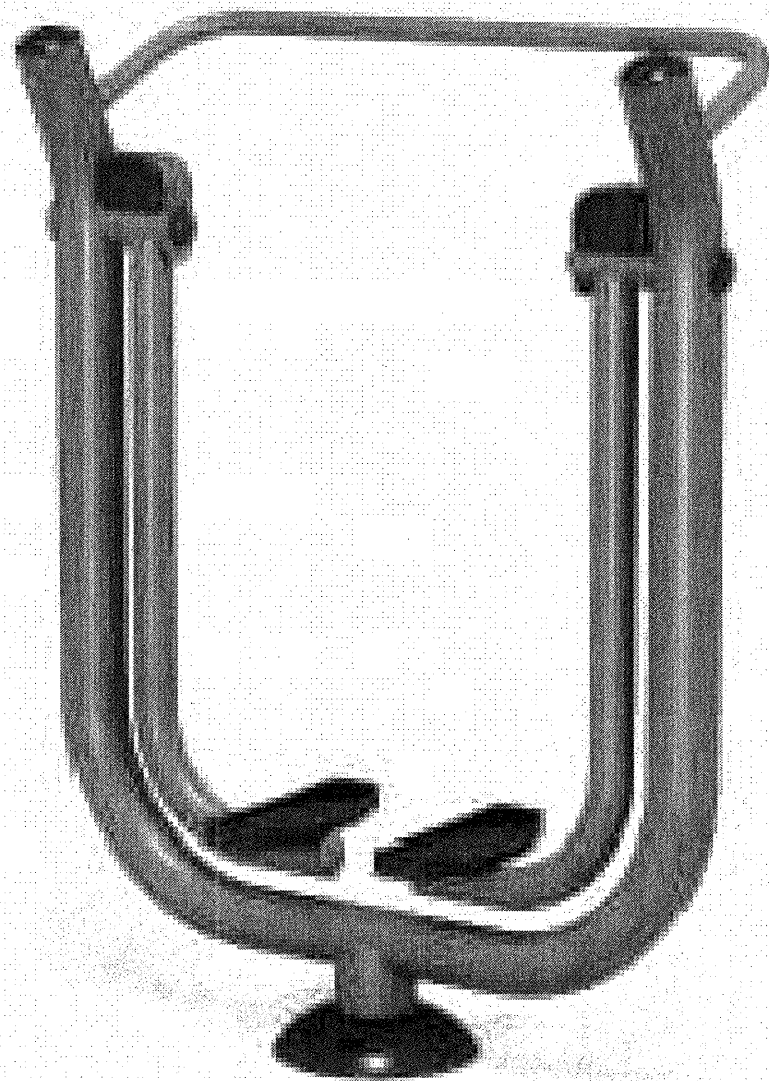

8 UP 164 CARDIO WALKER STATION

NOT TO SCALE

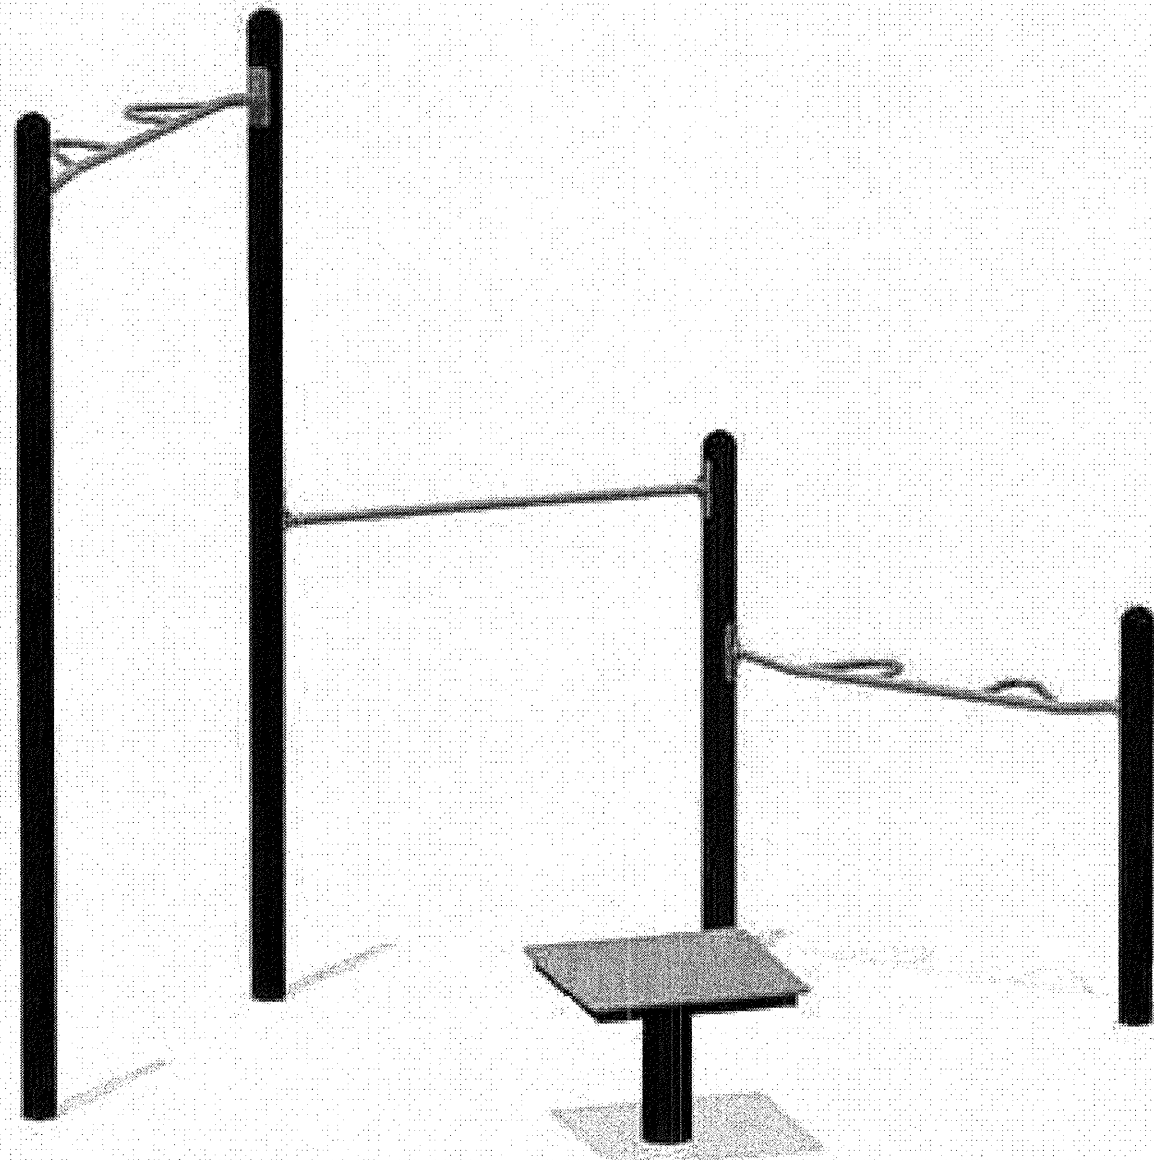


5 UP 189 MULTI GYM STATION

NOT TO SCALE




2 UP 264 STEP UP STATION

NOT TO SCALE

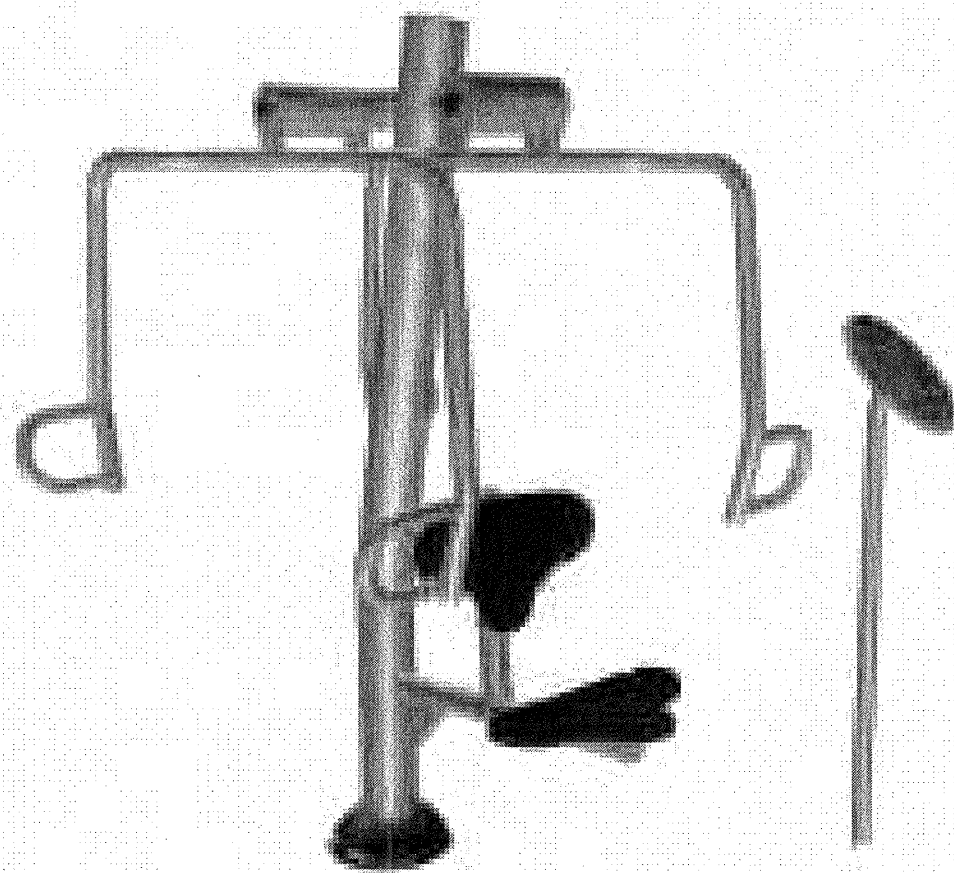


9 UP 170 ACCESSIBLE CHEST PRESS STATION

NOT TO SCALE

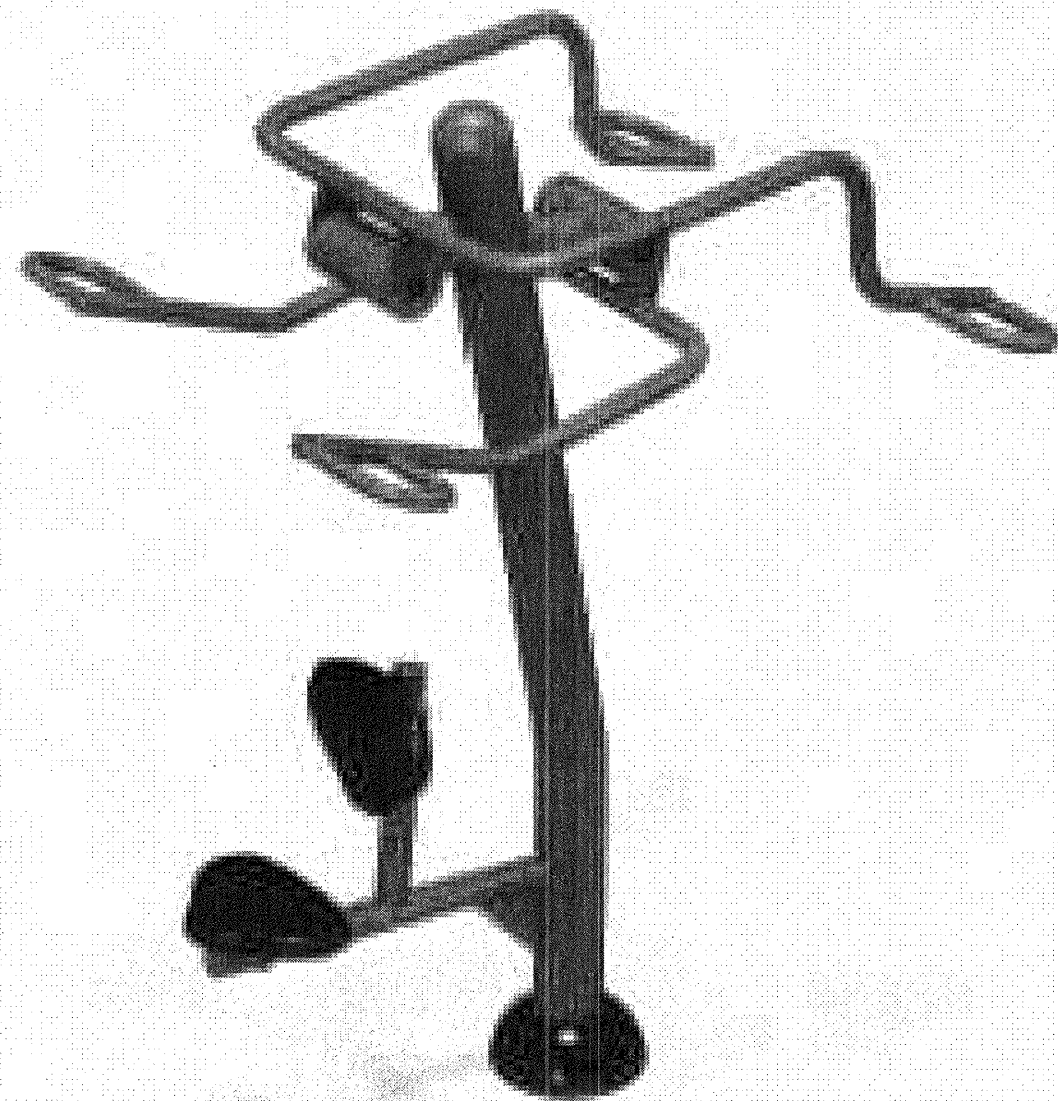

6 UP 180 ACCESSIBLE LAT PULL DOWN STATION

NOT TO SCALE

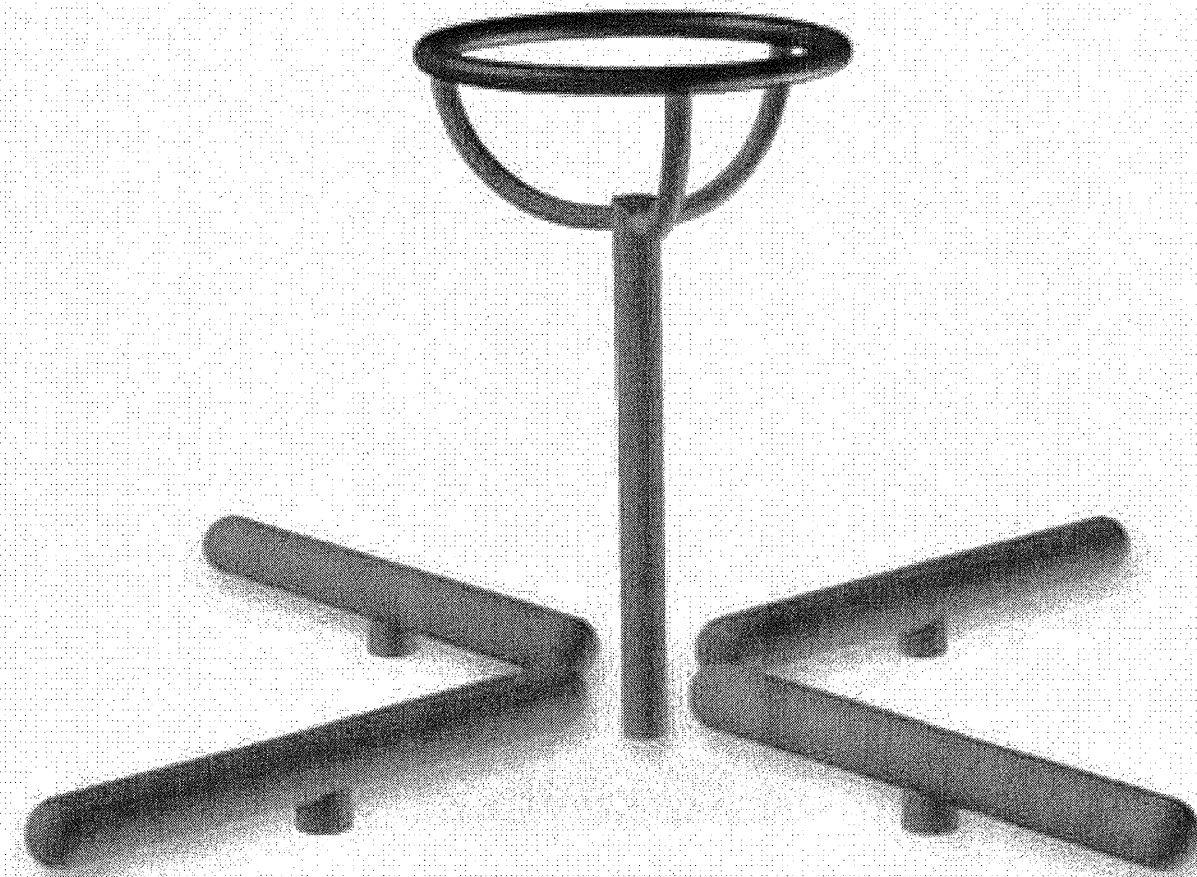


3 UP 355 ASSISTED STEP AROUND STATION

NOT TO SCALE

Cardno
Shaping the Future
LAS VEGAS
7115 AMIGO STREET, STE 100, LAS VEGAS, NV 89119
TEL: (702) 990-9300 FAX: (702) 990-9300 www.cardno.com

MAYFAIR PLACE PARK
FITNESS EQUIPMENT DETAILS

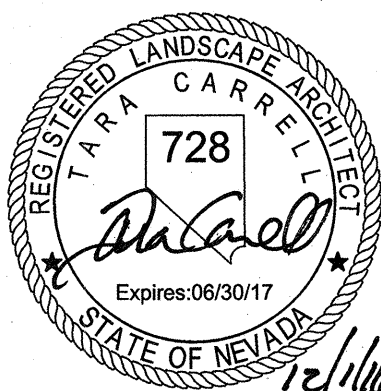

OWNER: CITY OF LAS VEGAS
DEPARTMENT OF PUBLIC WORKS

400 EAST STEWART AVENUE
LAS VEGAS, NEVADA 89101
PHONE: (702) 229-5535
FAX: (702) 382-3232
TDD: (702) 386-9108

DRAWN: TCC

FILE: 1099-CD-DETAILS L1.07-9.DWG

DATE: 2016-11-30

SCALE: N/A

BID NO: 15.59812

CLV DWG NO: 650.111


H# 66624

SHEET NO


L.1.08

REVISED 8/27/03



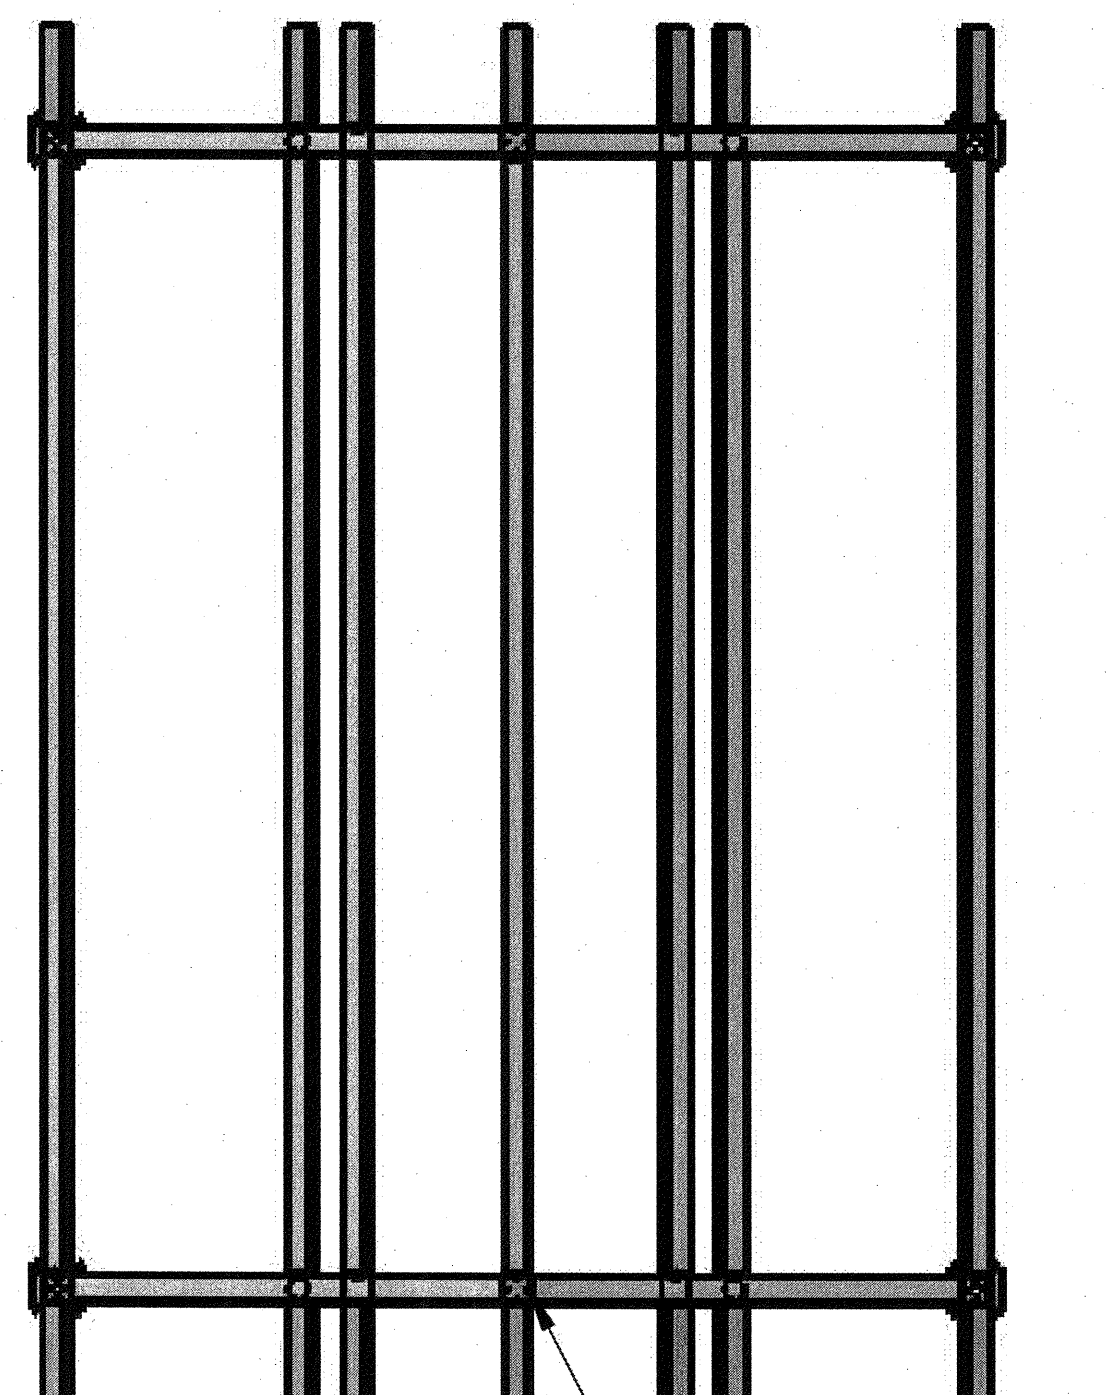


Compression Tube

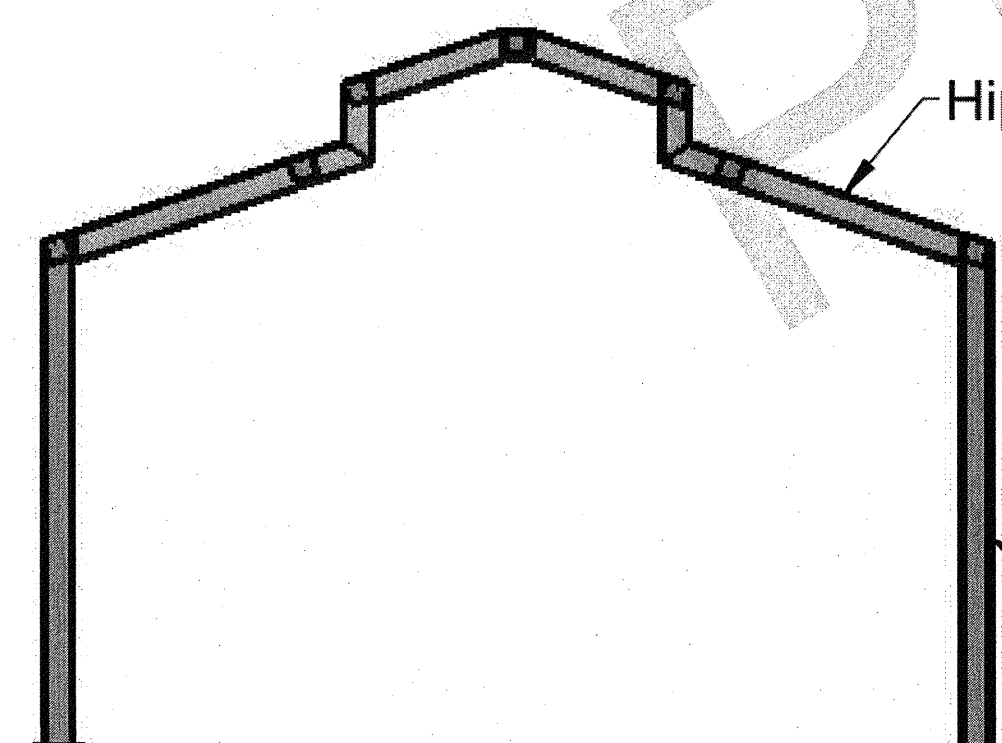

Hip Beam

Column

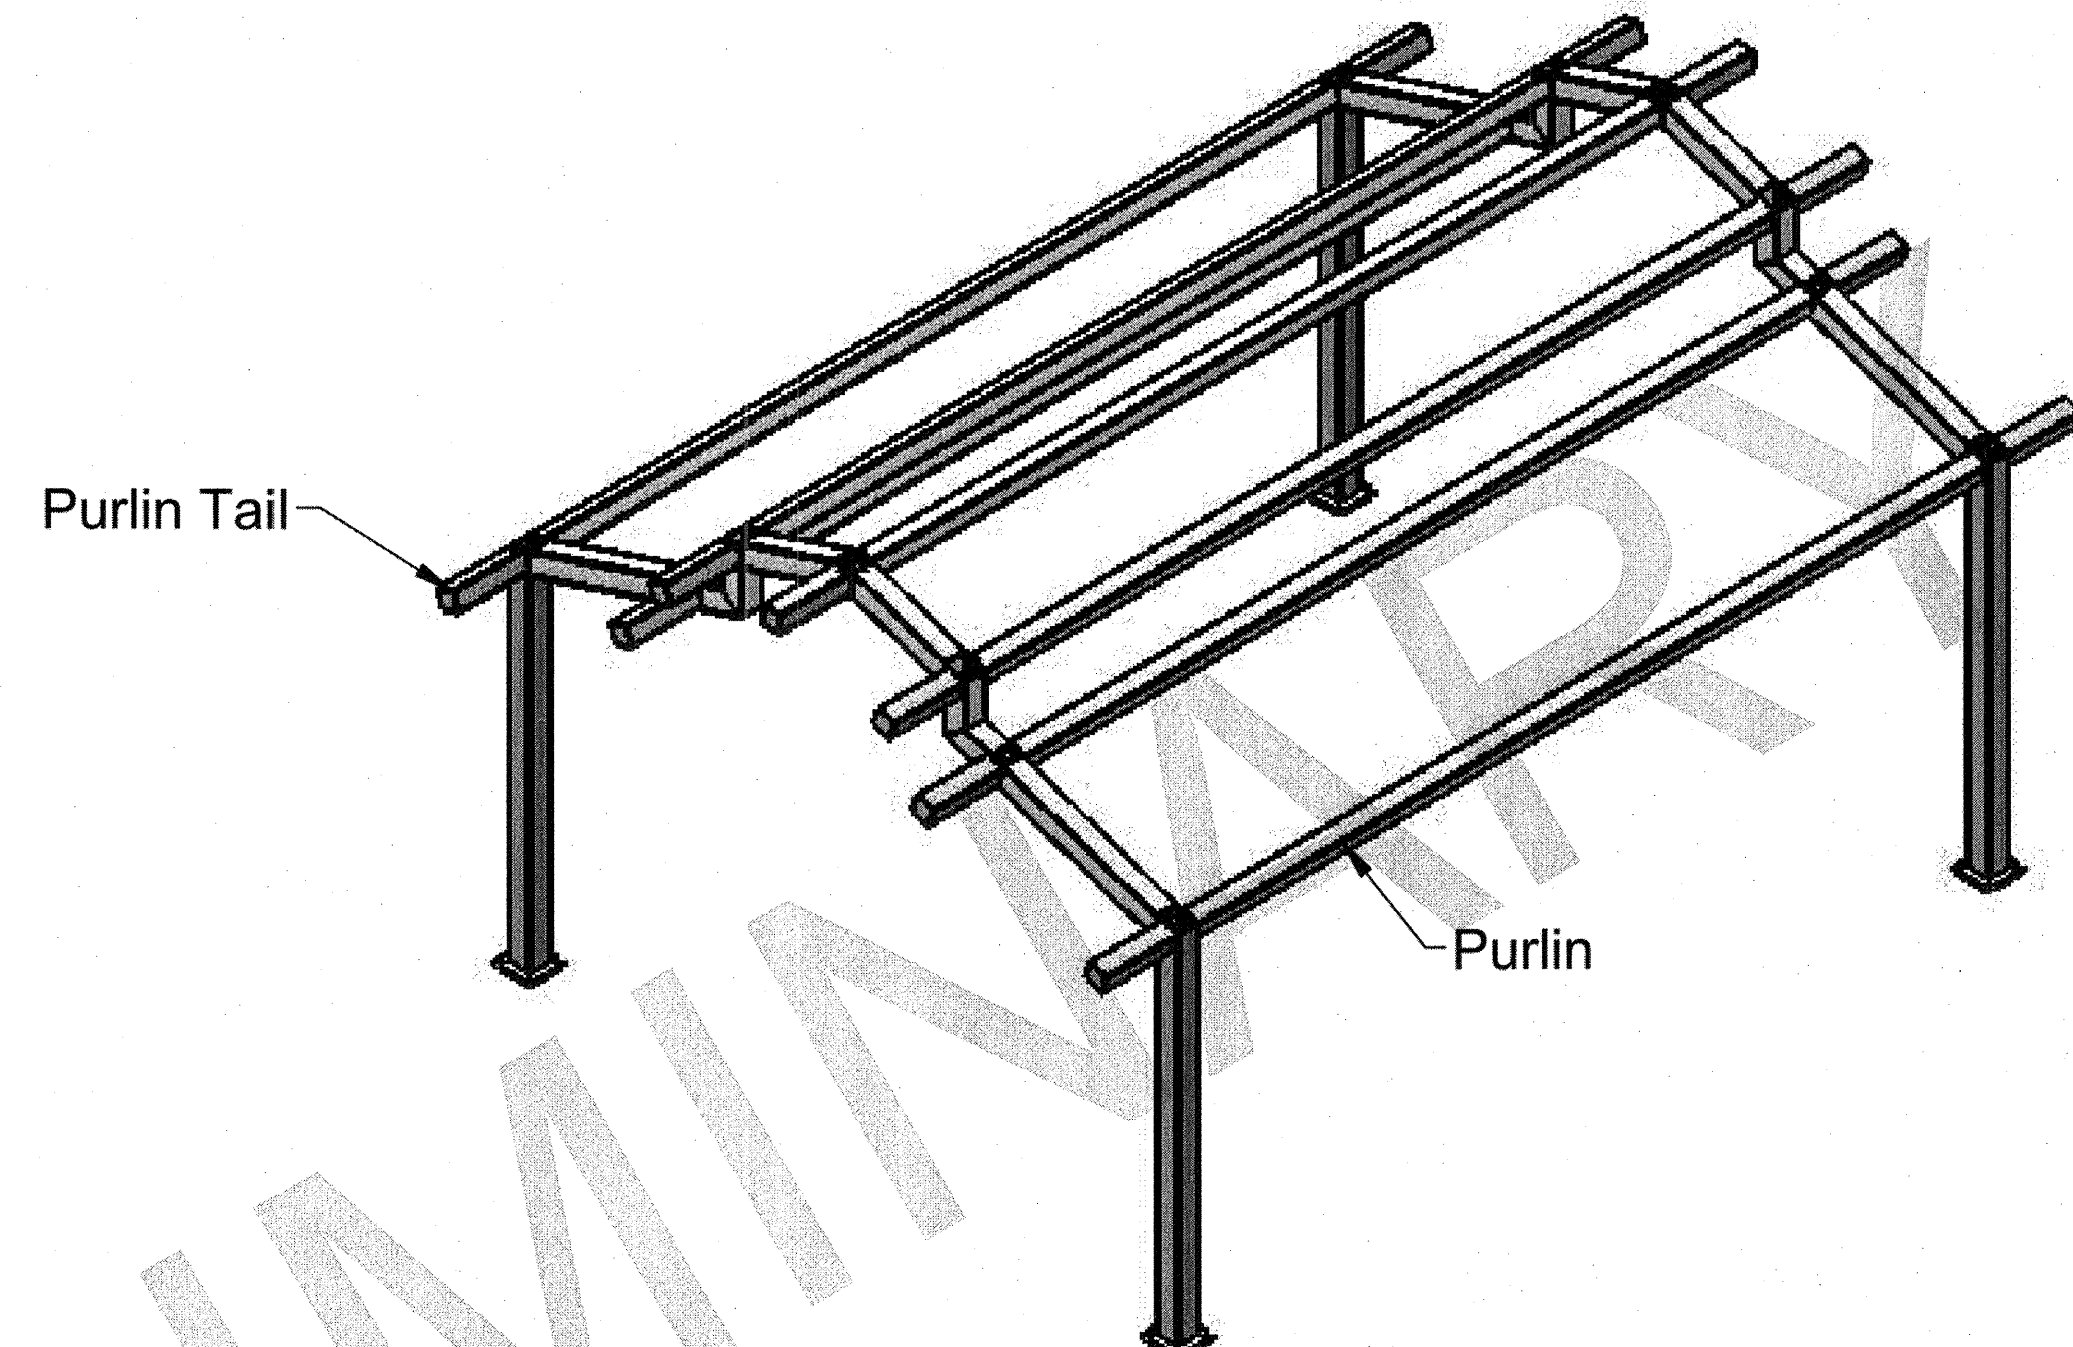

Purlin Tail

Purlin


1

SHOP DRAWINGS AND
ENGINEERING REQUIRED

NOTES:
1. DEFERRED SUBMITTAL REQUIREMENT FOR PREFABRICATED STRUCTURES:
THESE DRAWINGS REPRESENT DESIGN INTENT ONLY. UPON PRELIMINARY APPROVAL OF SHOP DRAWINGS, CONTRACTOR SHALL SUPPLY FROM THE PREFABRICATED STRUCTURE MANUFACTURER(S) DRAWINGS AND STRUCTURAL CALCULATIONS, INCLUDING MATERIALS AND CONNECTIONS WET-SEALED AND SIGNED BY A NEVADA REGISTERED PROFESSIONAL ENGINEER. CONTRACTOR SHALL SUBMIT TO CITY OF LAS VEGAS BUILDING DEPARTMENT FOR REVIEW AND APPROVAL BEFORE PERMITS AND INSPECTIONS CAN BE SCHEDULED. (MIN. 5 COPIES TO BUILDING DEPT.)
SEE SPECIFICATION #107300.
2. CONTRACTOR TO REFERENCE ELECTRICAL PLANS TO COORDINATE HOLES AND FITTINGS FOR LIGHTING SYSTEMS.
3. THERE SHALL BE A MINIMUM 8" VERTICAL DISTANCE BETWEEN THE TOP OF ANY AND ALL PLAY EQUIPMENT HANDRAILS, DECKS OR OTHER CLIMBABLE SURFACES (WHETHER THE SURFACE IS INTENDED TO BE CLIMBED OR NOT) AND THE BOTTOM OF THE SHADE FABRIC/STRUCTURE.

REVISIONS	BY

FRAMING PLAN

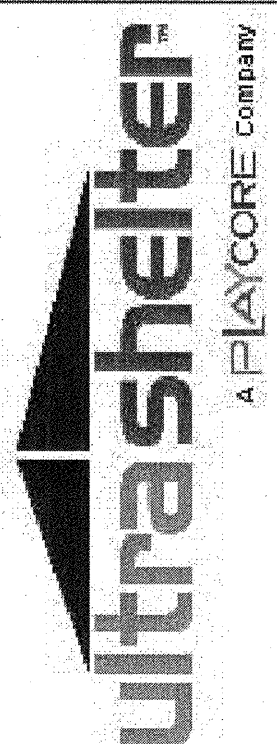

SHEET 2.0

6/9/2016

Page 2 of 1

REVISIONS
REV/PLAN CHECK 10/19/16

CONSULTANT
Cardno
Shaping the Future
LAS VEGAS
7115 AMIGO STREET, STE 100, LAS VEGAS, NV 89119
TEL: (702) 990-9300 FAX: (702) 990-9305 www.cardno.com

MAYFAIR PLACE PARK
GABLE SHELTER

STAMP
REGISTERED LANDSCAPE ARCHITECT
TARA CARRELL
728
Expire: 06/30/17
STATE OF NEVADA

OWNER: CITY OF LAS VEGAS
DEPARTMENT OF PUBLIC WORKS
400 EAST STEWART AVENUE
LAS VEGAS, NEVADA 89101
PHONE: (702) 229-6535
FAX: (702) 382-3232
TDD: (702) 386-9108

DRAWN
TCC

FILE
1099-CD-DETAILS-SHADE.DWG

DATE
2016-11-30

SCALE
AS NOTED

BID NO
15.59812

CLV DWG NO
650.111

H#
66624

SHT NO
GS1.02

REVISED 6/27/03