 


Avoid cutting underground utility lines. It's costly.

Call before you Dig.

1-800-227-2600

UNDERGROUND SERVICE ALERT (USA)



PROFILE SCALE:
HORIZ: 1"=50'
VERT: 1"=5'


NO.	DESCRIPTION	DATE	APP'D.

RECOMMENDED:

 DANIEL LA ROCOCA
 R.E. # 8925
 DATE: 11-15-97

DATE: OCT. 27, 1995
 DRAWN BY:
 DESIGNED BY:
 CHECKED BY:
 JOB NO.: 145.0012
 SCALE: 1"=50'

AS BUILT NOTE:
 THE SEWER SHOWN ON THIS SHEET IS WITHIN AN AREA UNDER CONTROL OF "ONE QUEENS RIDGE PLACE" REVISIONS AND TO BE COVERED BY THEIR "AS-BUILT" PLANS PER MEETING WITH CITY OF LAS VEGAS SANITATION ON 03/16/09

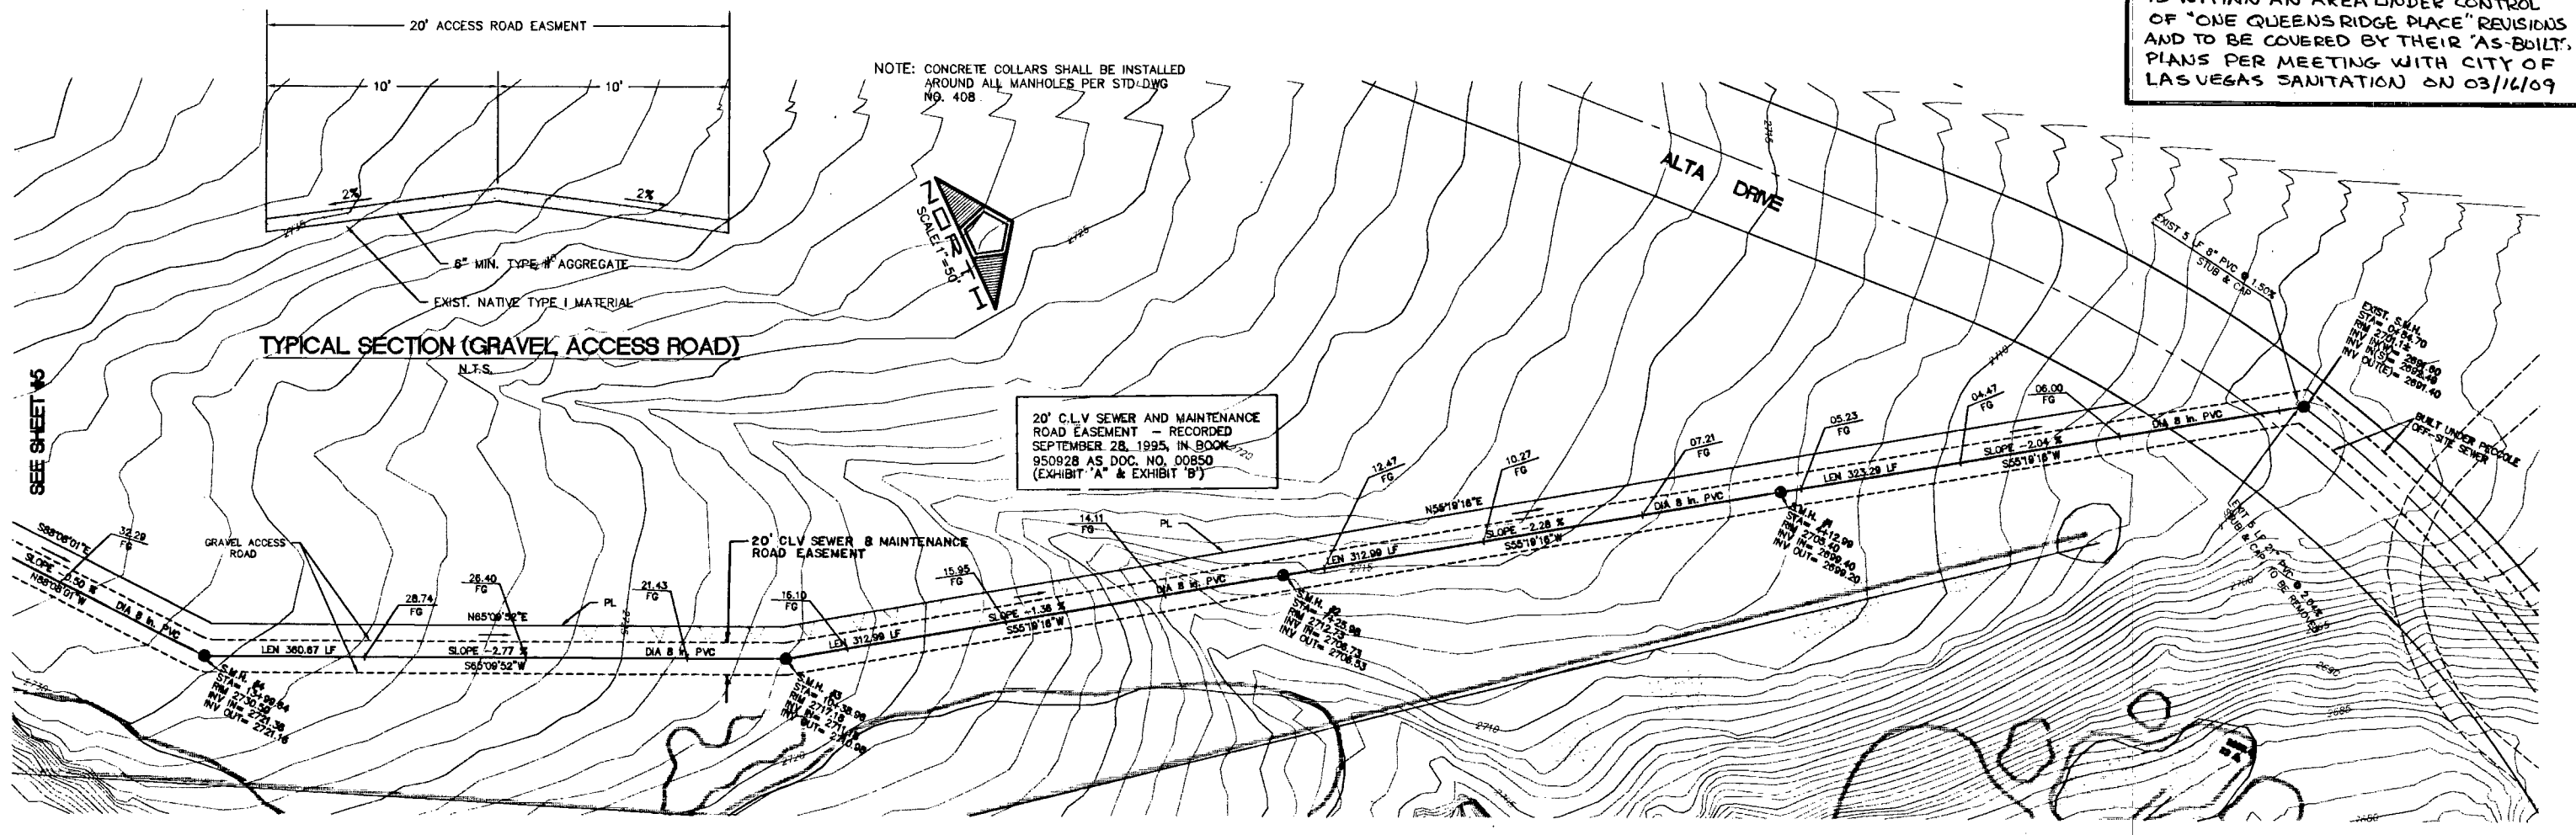

PENTACORE
 Engineering, Inc.
 6763 West Charleston Boulevard
 Las Vegas, Nevada 89102
 (702) 258-0115

PECCOLE NEVADA CORP.
 PECCOLE WEST
 GOLF COURSE SEWER
 PLAN AND PROFILE