

Avoid cutting underground utility lines. It's costly.

Call before you Dig.


1-800-227-2600

UNDERGROUND SERVICE ALERT (USA)

PROFILE SCALE:
HORIZ: 1"=50'
VERT: 1"=5'

NOTE:
THE SEWER AS BUILTS SHOW ON THIS PLAN IS PER FIELD SURVEY DONE BY SILVER STATE SURVEYING DATED 03/24/09.

AS BUILT NOTE:
THE SEWER SHOWN IN THIS AREA IS WITHIN AN AREA UNDER CONTROL OF "ONE QUEENS RIDGE PLACE" REVISIONS AND TO BE COVERED BY THEIR "AS BUILT" PLANS PER MEETING WITH CITY OF LAS VEGAS SANITATION ON 03/16/09

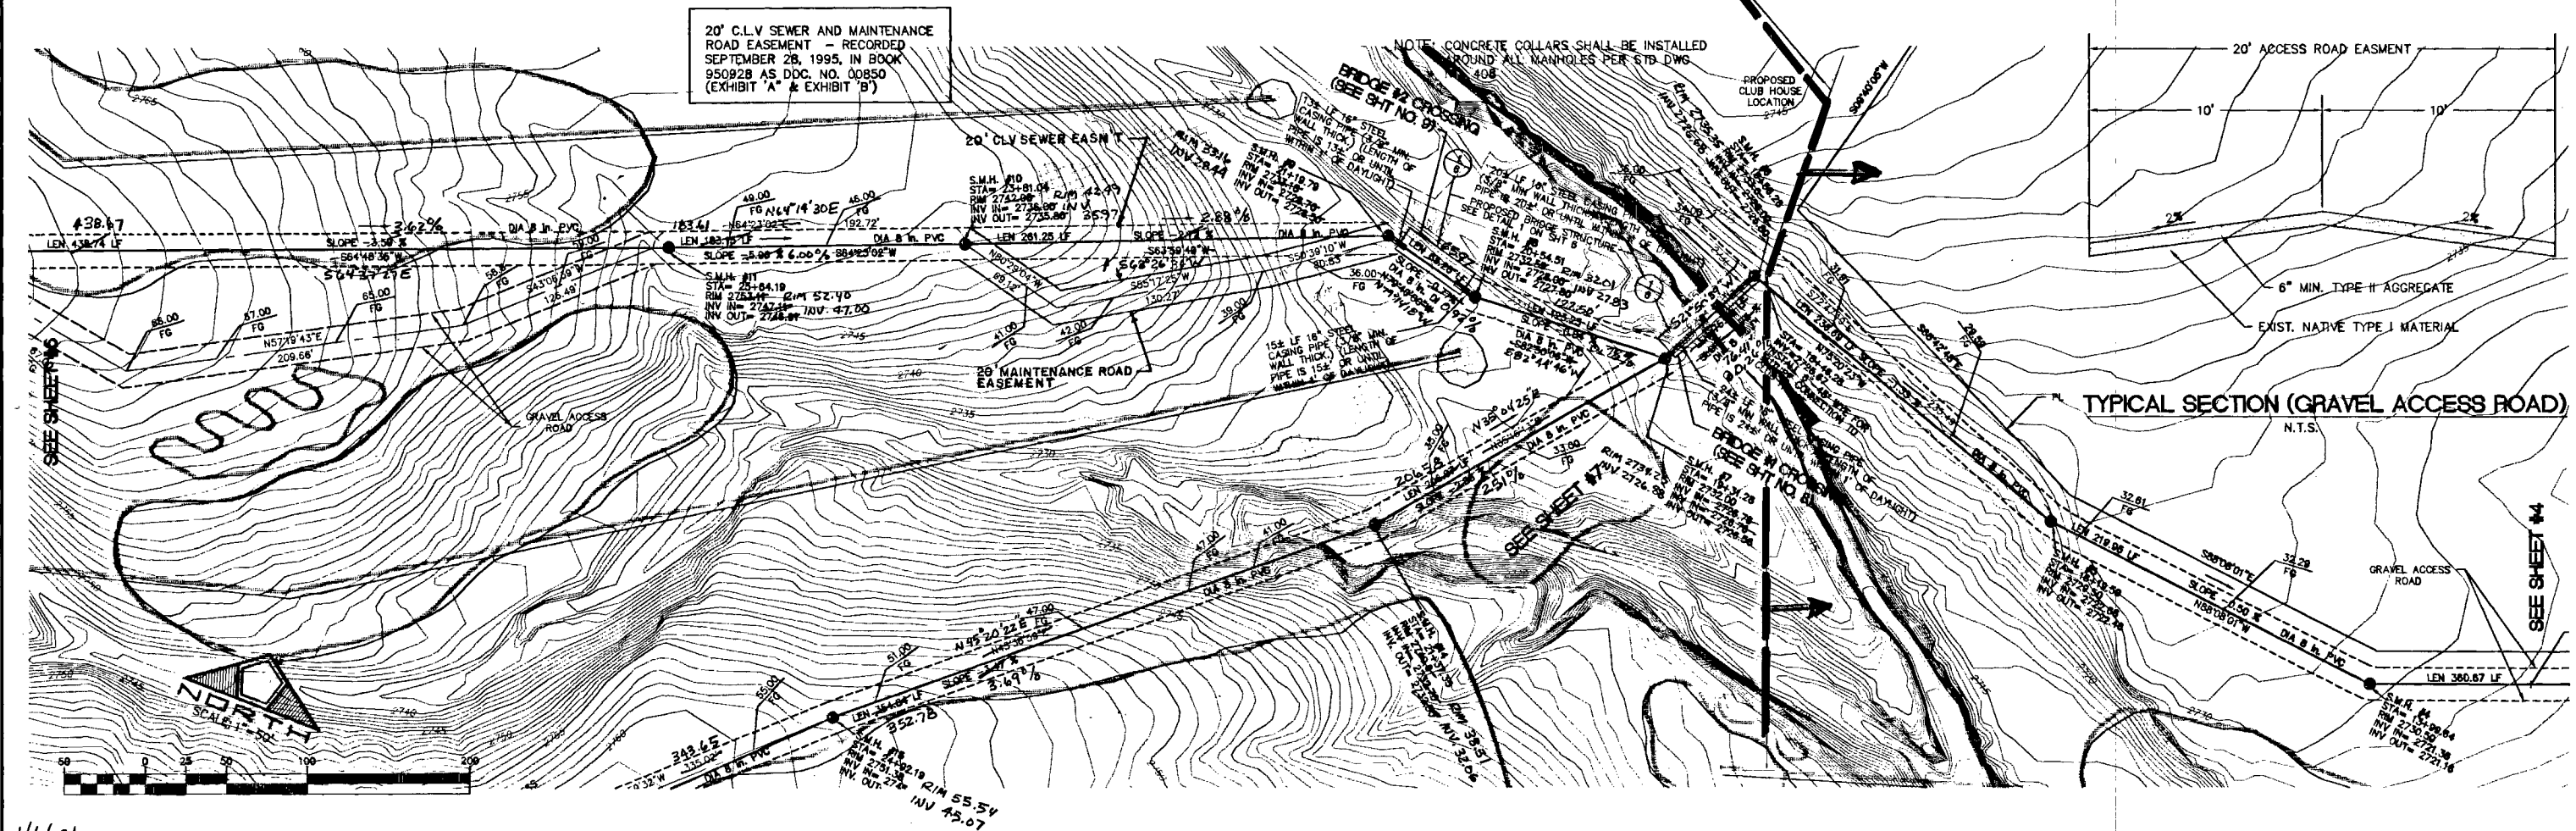

20' C.L.V. SEWER AND MAINTENANCE ROAD EASEMENT - RECORDED SEPTEMBER 28, 1995, IN BOOK 950928 AS DDC. NO. 00850 (EXHIBIT 'A' & EXHIBIT 'B')

TYPICAL SECTION (GRAVEL ACCESS ROAD)
N.T.S.

| NO. | DESCRIPTION | DATE | APP'D |
|-----|-------------|------|-------|
| | | | |

RECOMMENDED:
DANIEL L.A. ROBERT, JR.
P.E. 11/9/85

DATE: 11-15-91

DATE: OCT. 27, 1985
DRAWN BY:
CHECKED BY:
JOB NO.: 145.0012
SCALE: 1"=50'

PENTACORE
Engineering, Inc.
6763 West Charleston Boulevard
Las Vegas, Nevada 89102
(702) 258-0115

PECCOLE NEVADA CORP.
PECCOLE WEST
GOLF COURSE SEWER
PLAN AND PROFILE

SHEET
5
OF 9

AS CONSTRUCTED 307-V737-1