

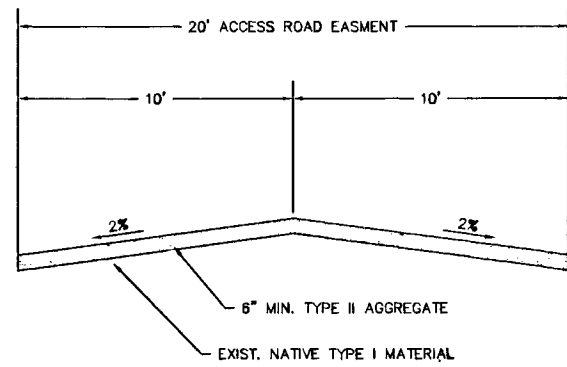



TYPICAL MANHOLE DETAIL AT THE BRIDGE STRUCTRE
NOT TO SCALE

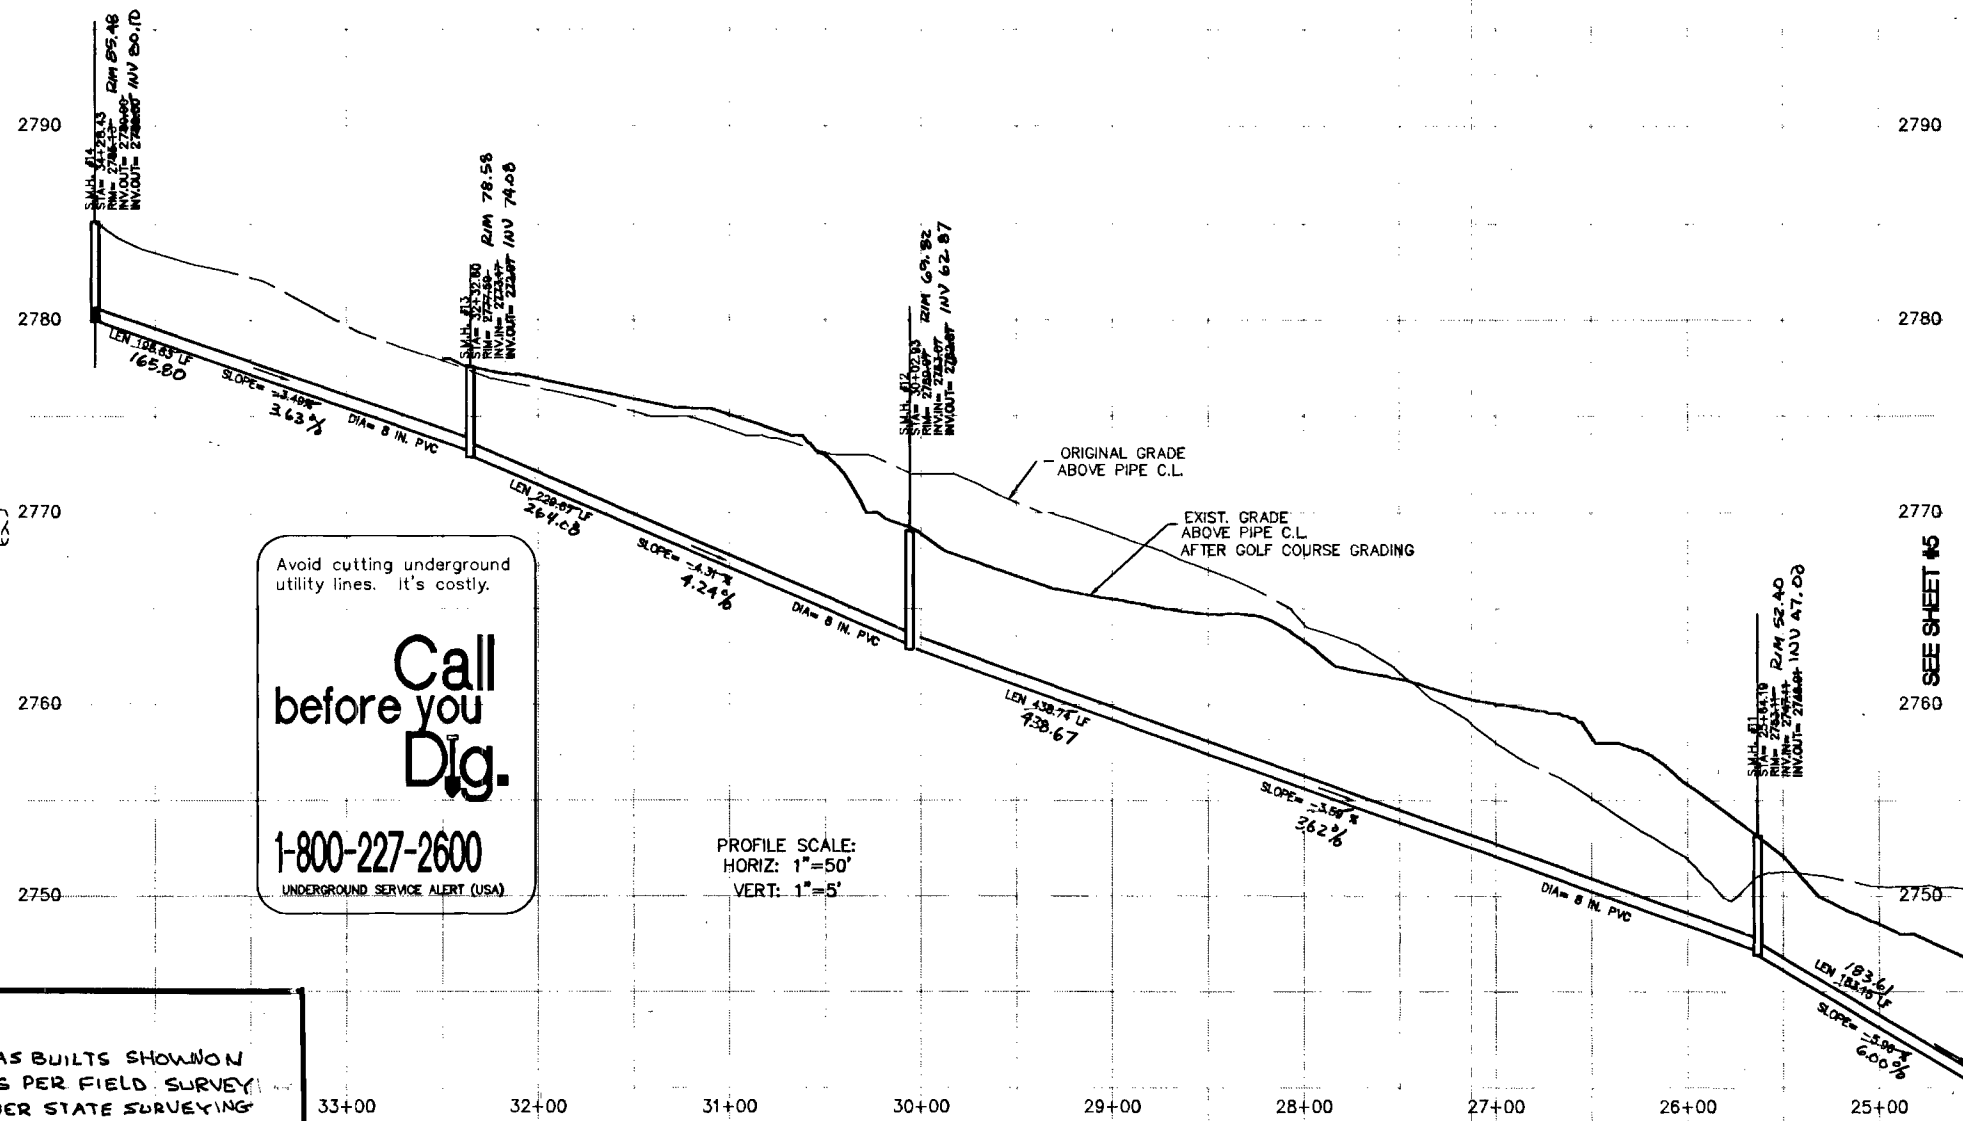

TYPICAL SECTION (GRAVEL ACCESS ROAD)
N.T.S.

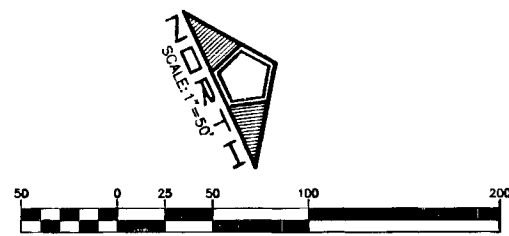

NOTE:
THE SEWER AS BUILT SHOWN
THIS PLAN IS PER FIELD SURVEY
DONE BY SILVER STATE SURVEYING
DATED 03/20/09

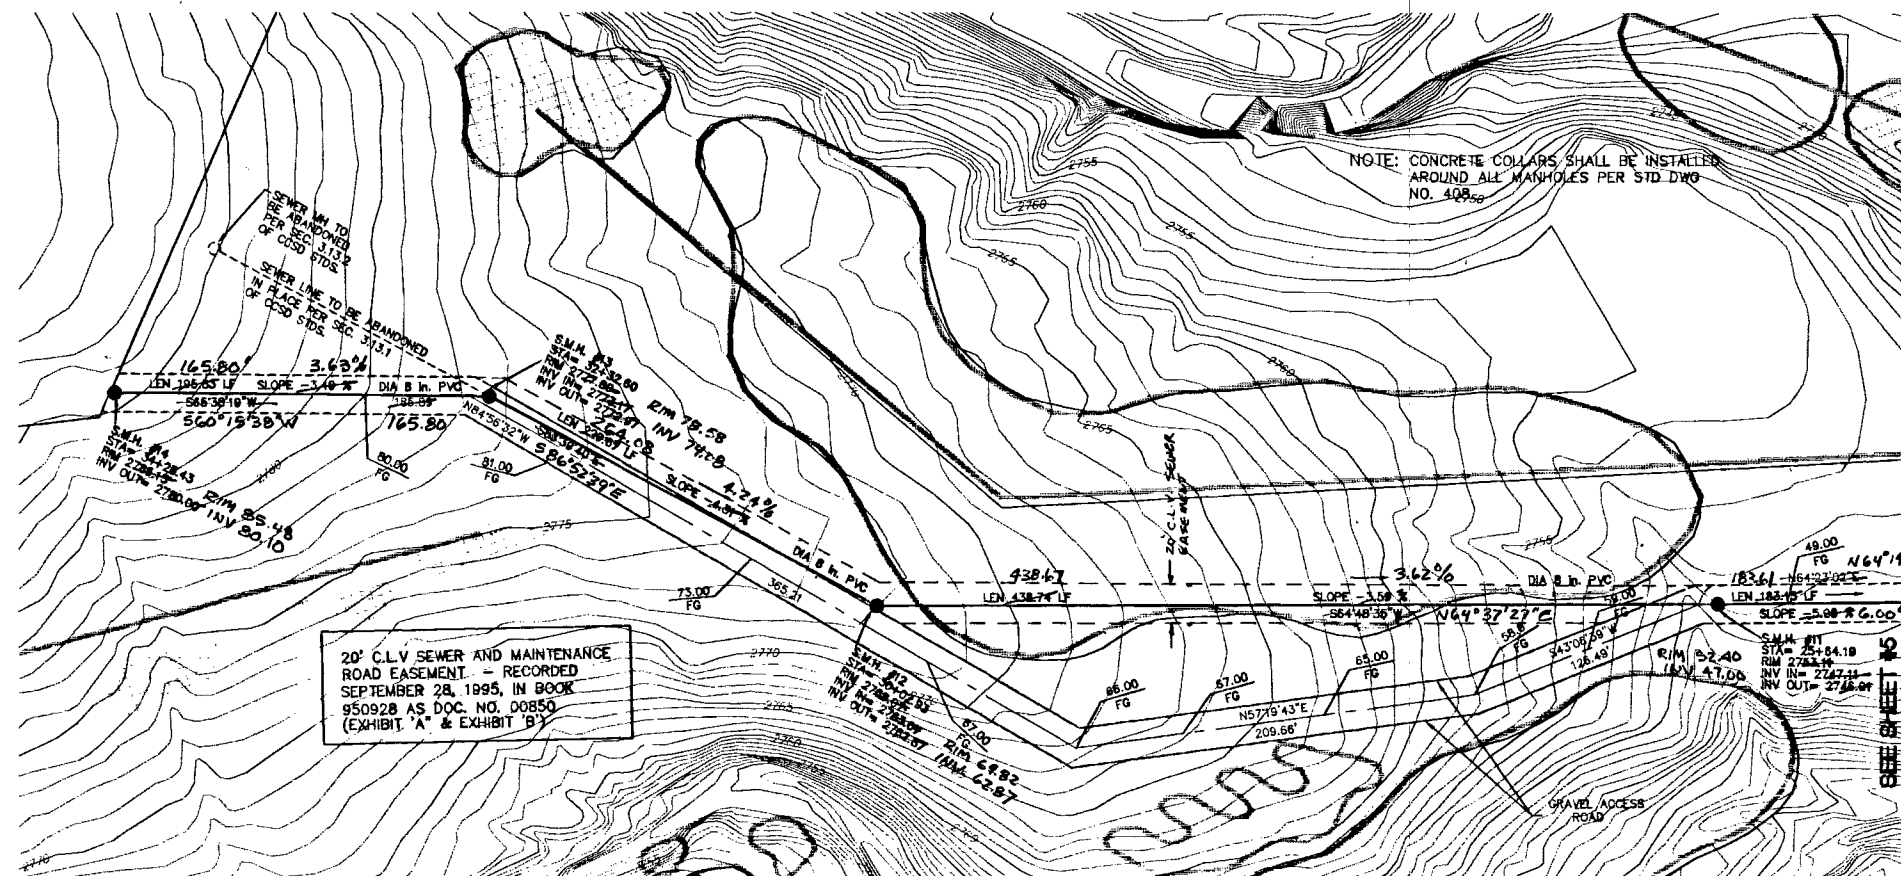

NO.	DESCRIPTION	DATE	APP'D

RECOMMENDED: *[Signature]* 11-15-95
DATE
DANIEL LA RUBIA, JR.
R. # 8825

DATE: OCT. 27, 1995
DRAWN BY:
DESIGNED BY:
CHECKED BY:
JOB NO.: 143.0012
SCALE: 1"=50'

PENTACORE
Engineering, Inc.
6763 West Charleston Boulevard
Las Vegas, Nevada 89102
(702) 258-0115

PECCOLE NEVADA CORP.
PECCOLE WEST
GOLF COURSE SEWER
PLAN AND PROFILE

SHEET
6
OF 9

116602

2059

AS CONSTRUCTED 307-V737-1