


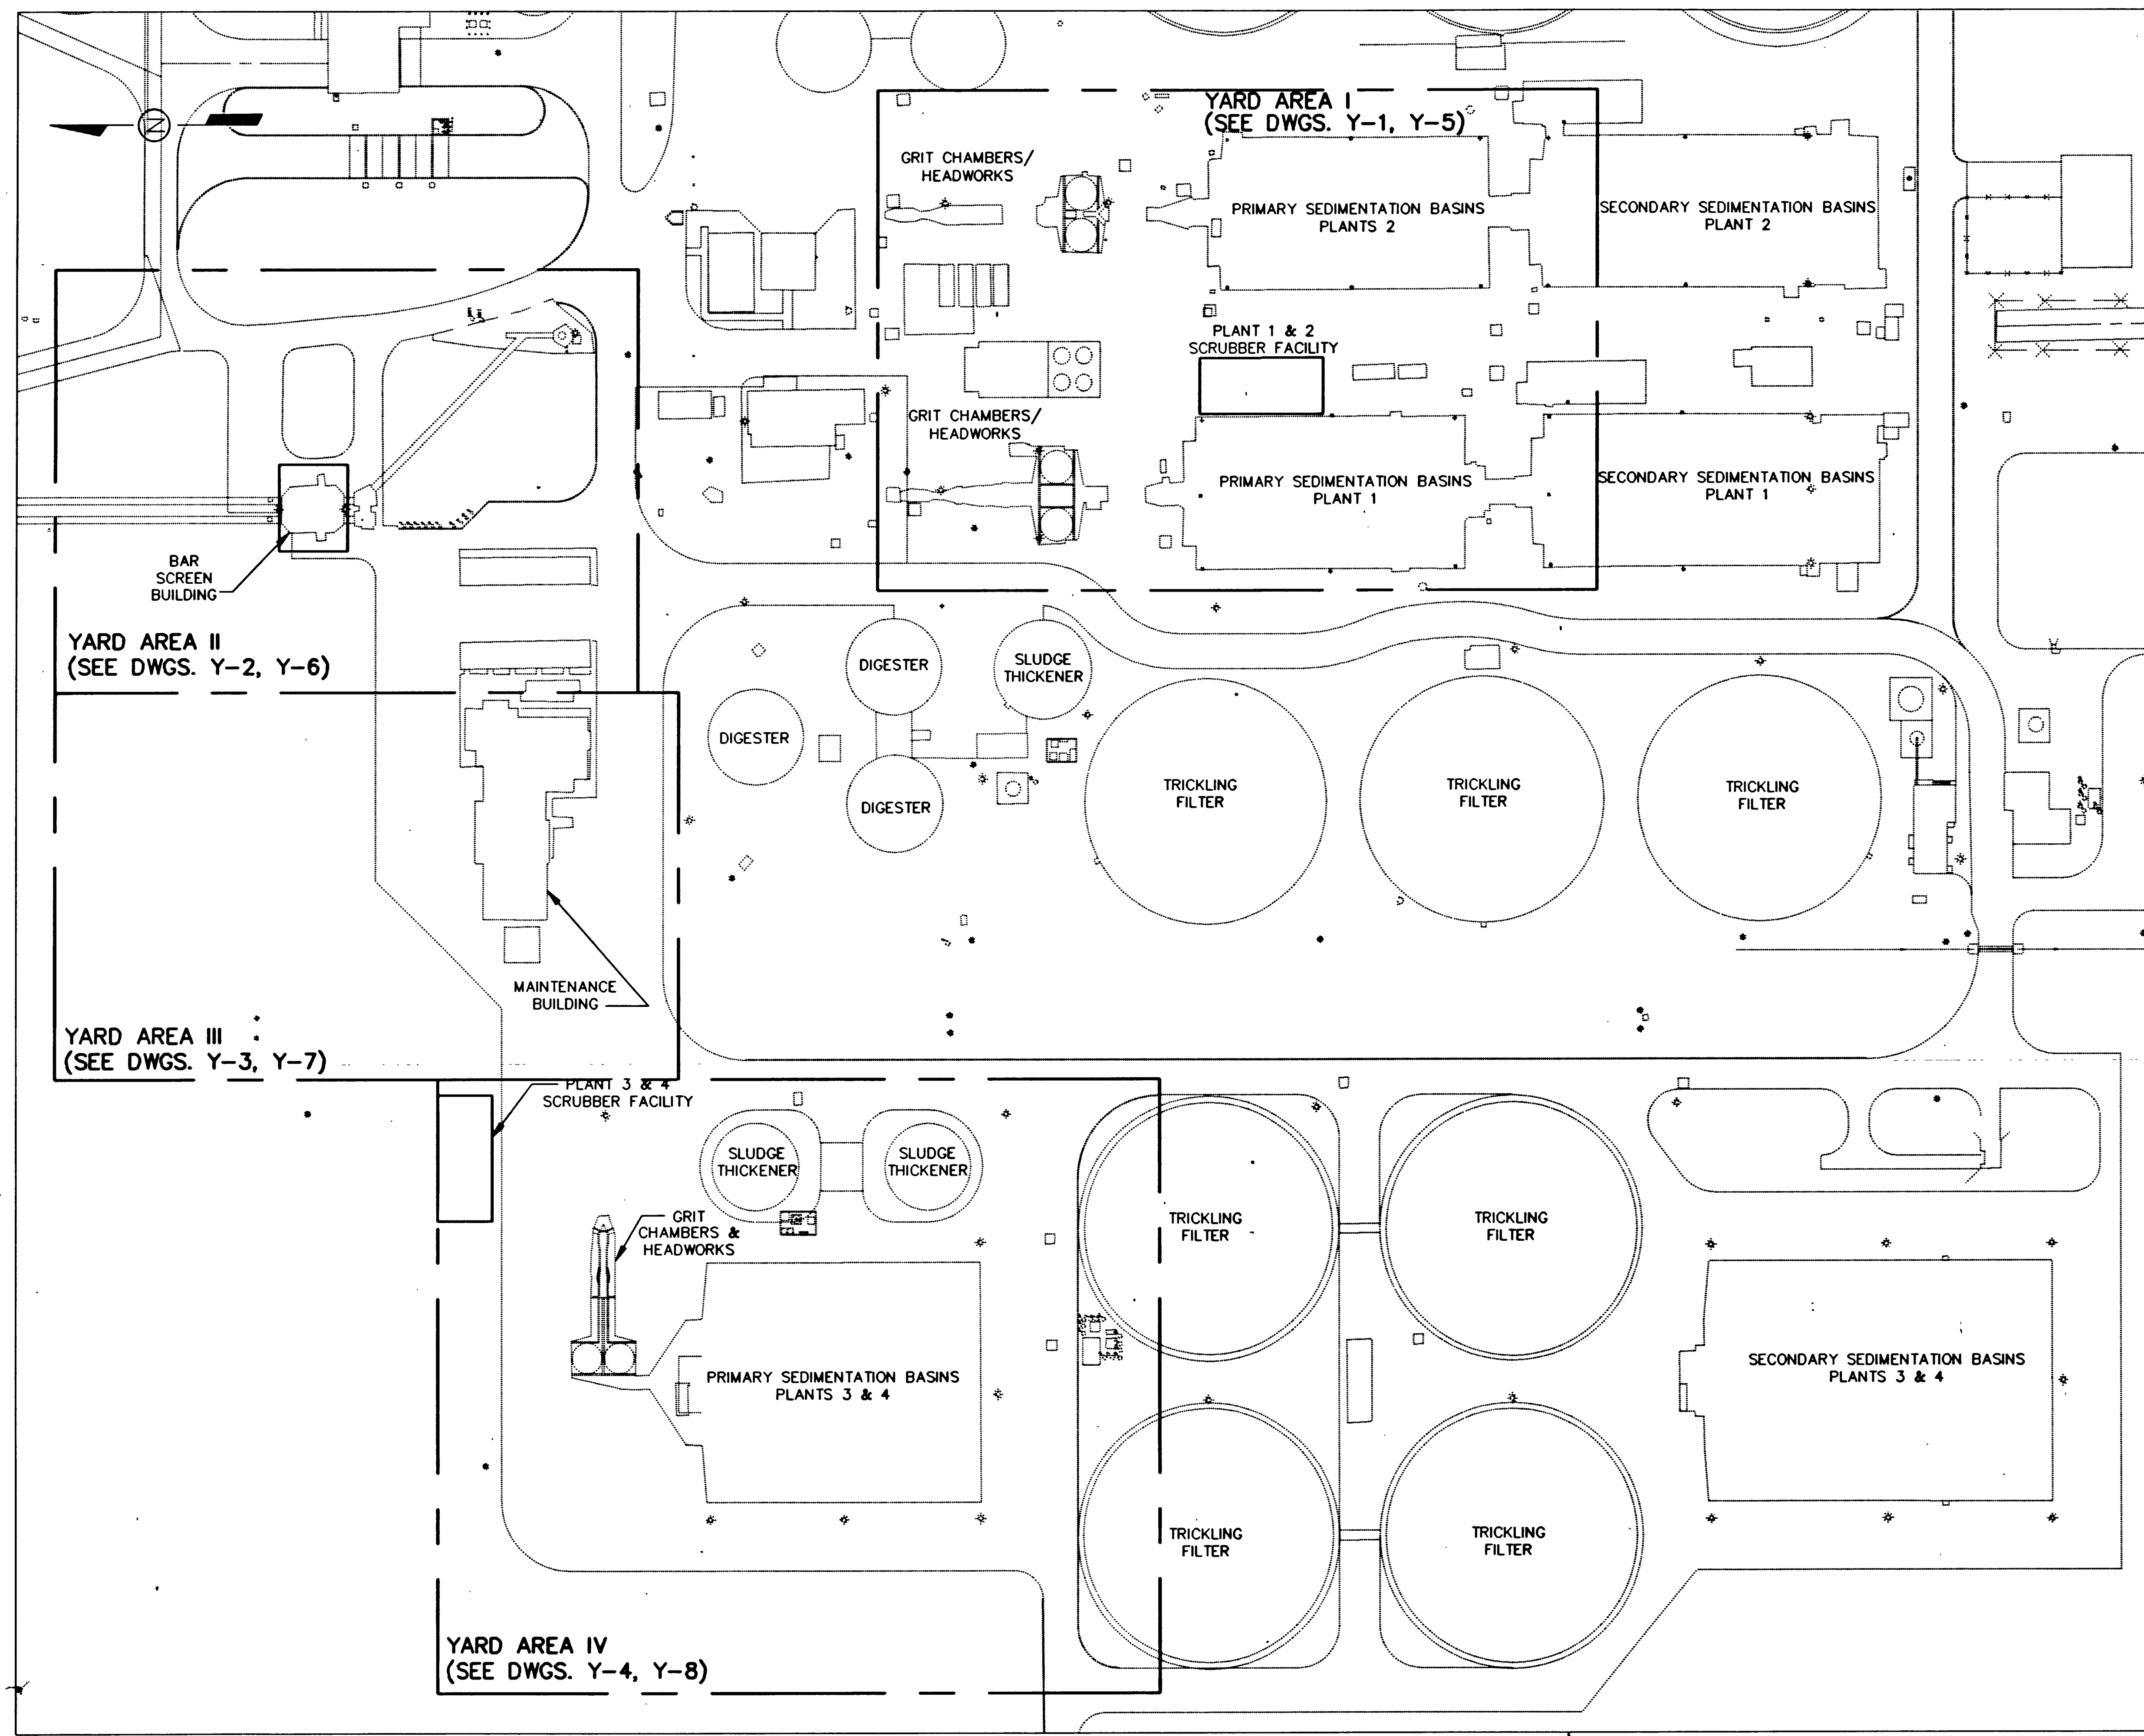


RECORD DRAWING
 THESE RECORD DRAWINGS HAVE BEEN PREPARED BASED
 ON PART ON INFORMATION PROVIDED BY OTHERS.

THIS DRAWING WAS PREPARED ONLY FOR THE
 PROJECT AND SITE SPECIFICALLY IDENTIFIED
 HEREON AND IS NOT TO BE USED ELSEWHERE.
 Date: 7/14/95
[Signature]

REV.	DATE	BY	DESCRIPTION

DESIGNED	KAP
DRAWN	DRS
CHECKED	THC
DATE	SEPT 1993

VERIFY SCALES
 BAR IS ONE INCH ON
 ORIGINAL DRAWING
 0 1"
 IF NOT ONE INCH ON
 THIS SHEET, ADJUST
 SCALES ACCORDINGLY

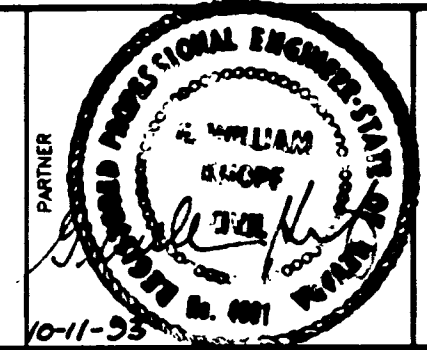

**JOHN CAROLLO
 ENGINEERS**
 PHOENIX, AZ IRVINE, CA IRVINE, CA
 SANTA ANA, CA VICKI, CA VICKI, CA
 SAN BERNARDINO, CA TRUCKEE, CA TRUCKEE, CA
 FRESNO, CA BAKERSFIELD, CA BAKERSFIELD, CA
 LAS VEGAS, NV EL PASO, TX



Las Vegas Water Pollution Control Facility	JOB NO. 3752B.10
ODOR CONTROL AT HEADWORKS AND PRIMARY CLARIFIERS	DRAWING NO. G-4
GENERAL SITE PLAN	SHEET NO. 4 OF 72

