


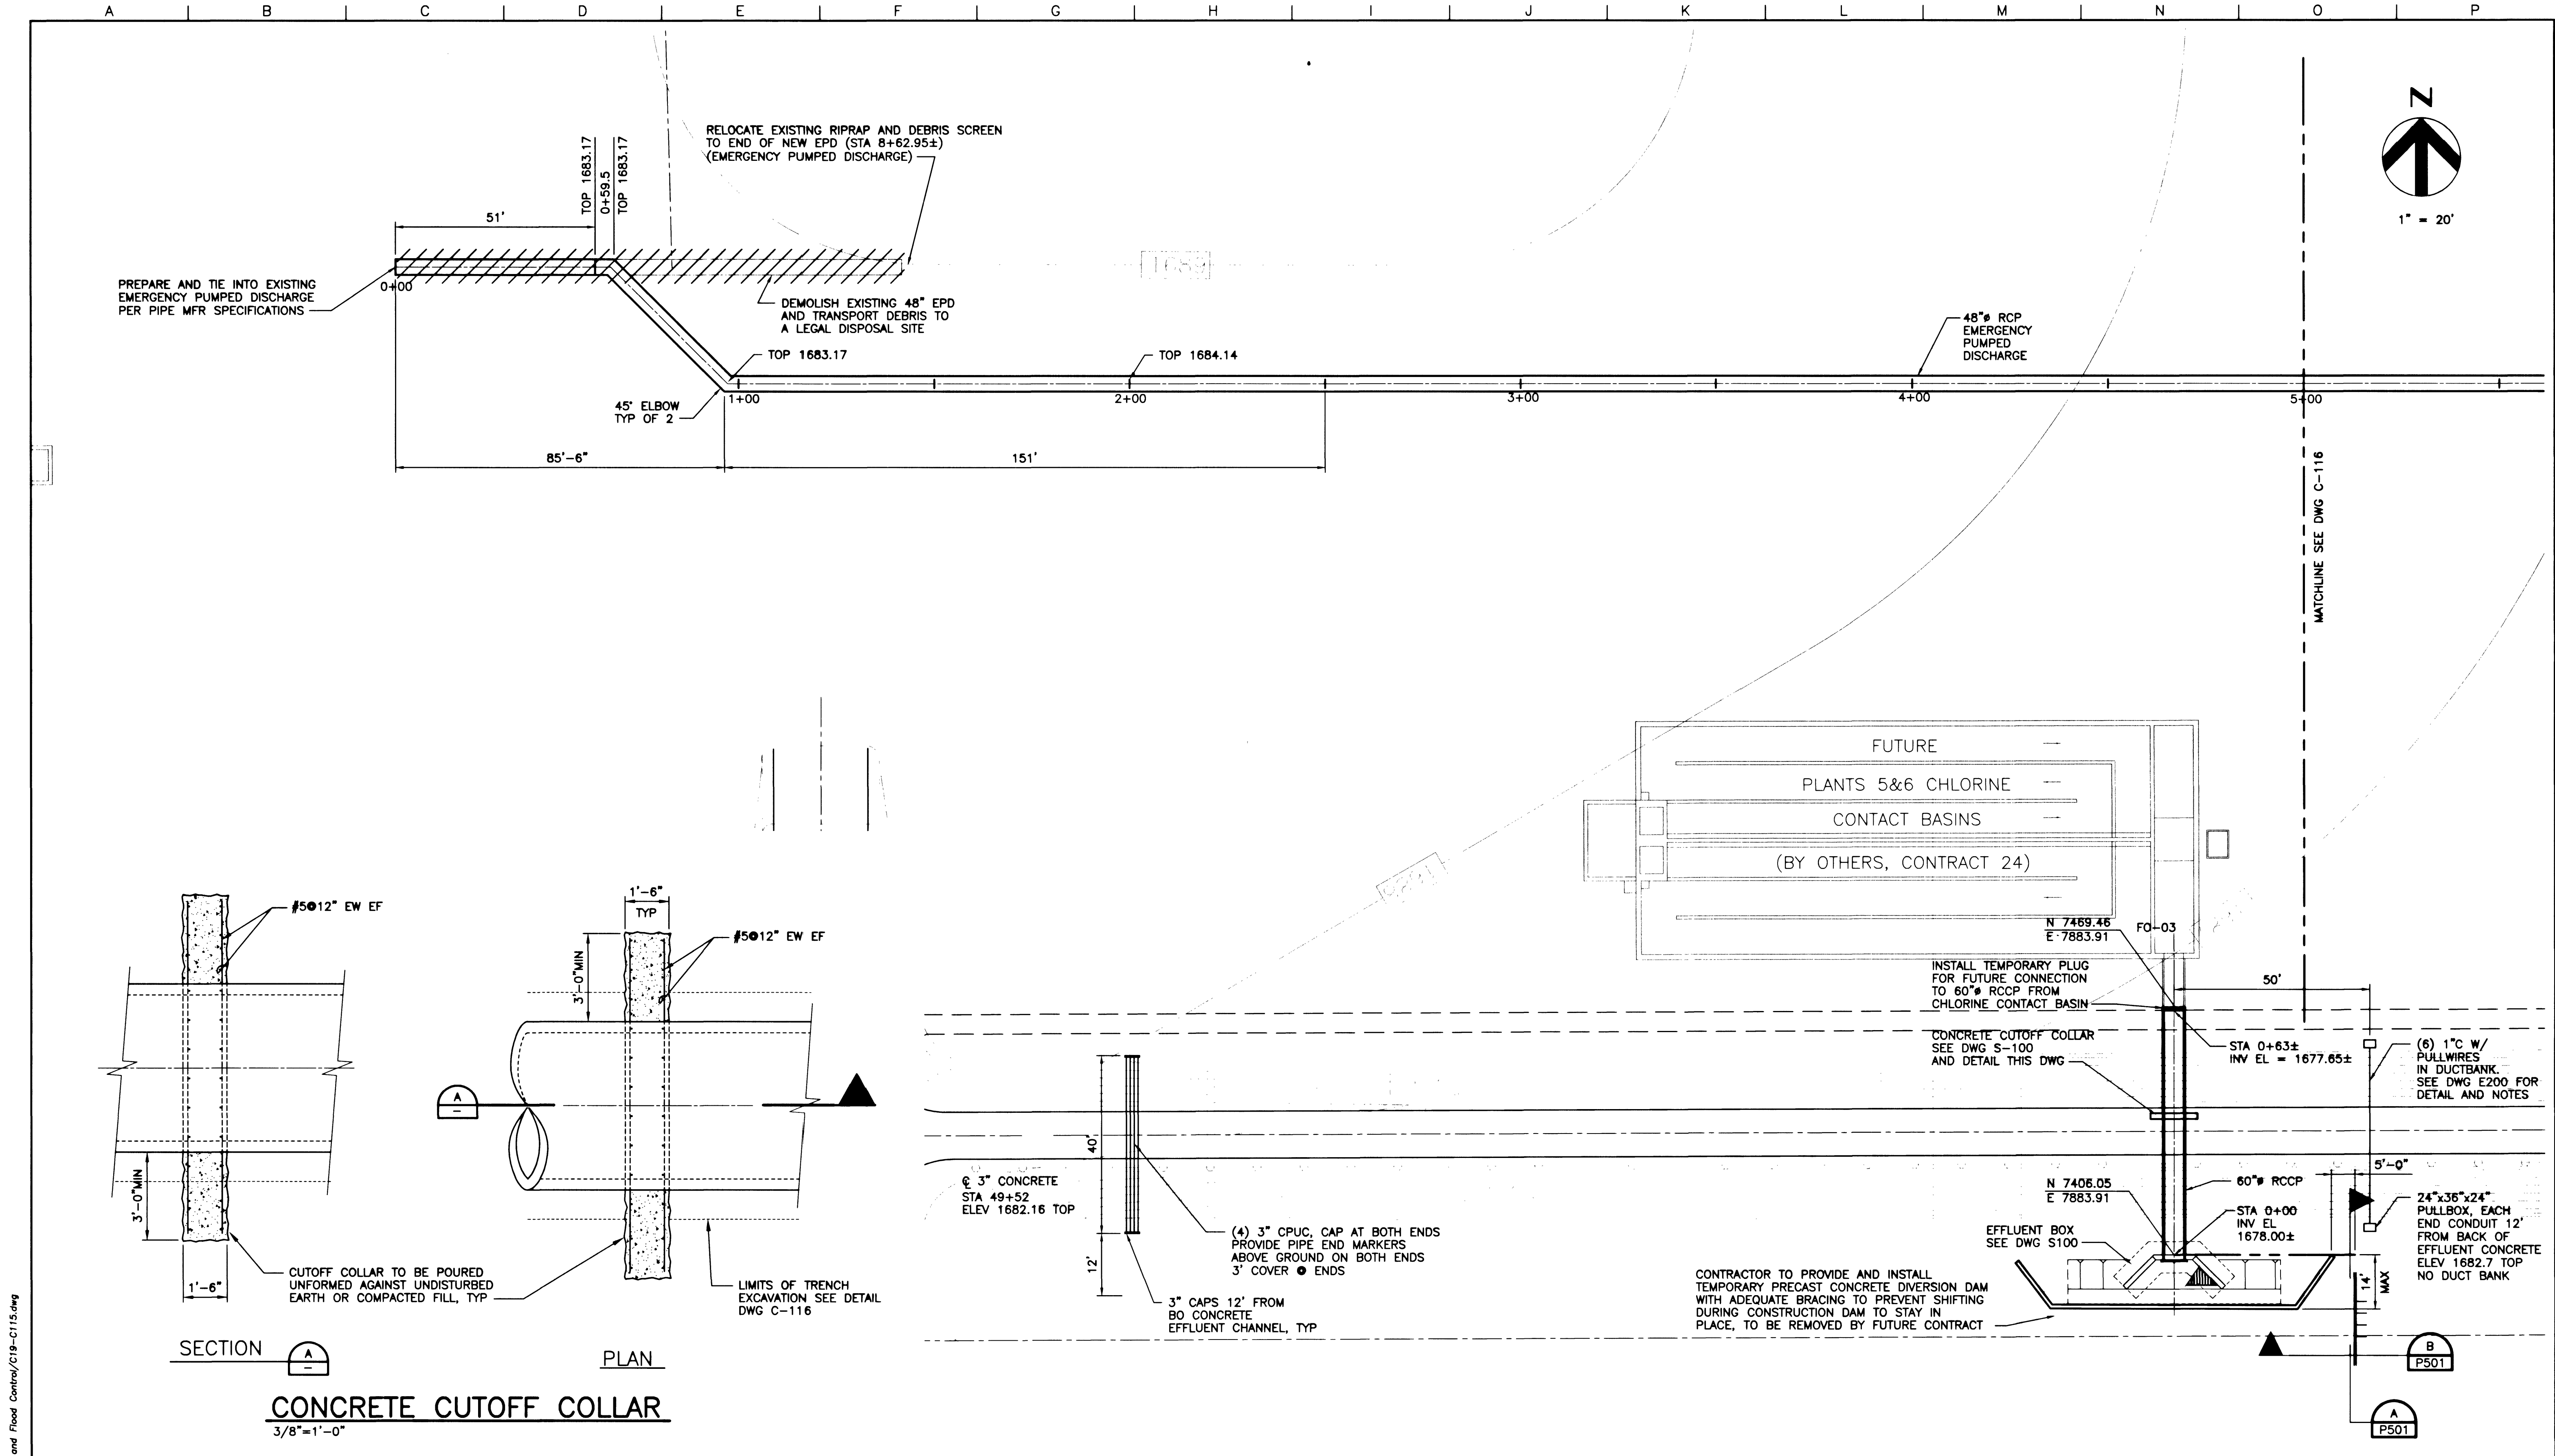

R:\001\001\Contract 19 - Demolition and Flood Control\CI15.dwg
01-29-02 JLD/HNSO 14:35:52

Issue No.	Description	Date	Drawn	Checked	Rev.	Proj. Mgr.
C	AS RECORDED	12/00	RJG	THK	DAP	JMC
B	ADDENDUM NO. 1	01/29/99	MCD	THK	DAP	JMC
A	ISSUED FOR BIDS	12/04/98	MCD	THK	DAP	JMC

HDR
HDR Engineering, Inc.
770 E. Warm Springs Road
Suite 360
Las Vegas, NV 89119
702-938-6000

ONE LENGTH ON ORIGINAL
DRAWING EQUALS ONE INCH
ADJUST SCALE ACCORDINGLY

Project Manager	D. GRABER
Designed	J. SZYTEL
Checked	
Drawn	B. PERSON

City of Las Vegas
**Water Pollution Control Facility
Plant Expansion**
Contract 19 - Demolition/Flood Control

**PLANTS 5 & 6
EFFLUENT STRUCTURES AND EMERGENCY PUMPED DISCHARGE
SITE PLAN**

Date
DECEMBER, 1998

Project No.
00120-154-141

Scale
AS NOTED

Drawing No.
C115

Sheet No.
25 of 45

3/11/99