

R:\001\20\Contract 19 - Demolition and Flood Control\C19-ED10.dwg
01-30-02 JDJ/HNS 16:36:21

C	AS RECORDED	12/00	JDJ	JMC	DAP	DJG
B	CHANGE PROPOSAL REQUEST 001	10/98				
A	ISSUED FOR BIDS	8/98				
Issue No.	Description	Date	Drawn	Chkd.	Resp. Engr.	Proj. Mgr.


HDR
HDR Engineering, Inc.
770 E. Warm Springs Road
Suite 360
Las Vegas, NV 89119
702-938-6000

Project Manager
D. GRABER
Designed
T. REARICK
Designed
Checked
Drawn
M. DAVIS


City of Las Vegas
**Water Pollution Control Facility
Plant Expansion**
Contract 19 - Demolition/Flood Control

**MISCELLANEOUS ELECTRICAL
MCC ELEVATIONS, ONE LINES, AND CONTROL SCHEMATICS**


Date DECEMBER, 1998	Project No. 00120-154-141	Scale NO SCALE	Drawing No. E010	Sheet No. 311.49 40 of 45
------------------------	------------------------------	-------------------	----------------------------	---------------------------------

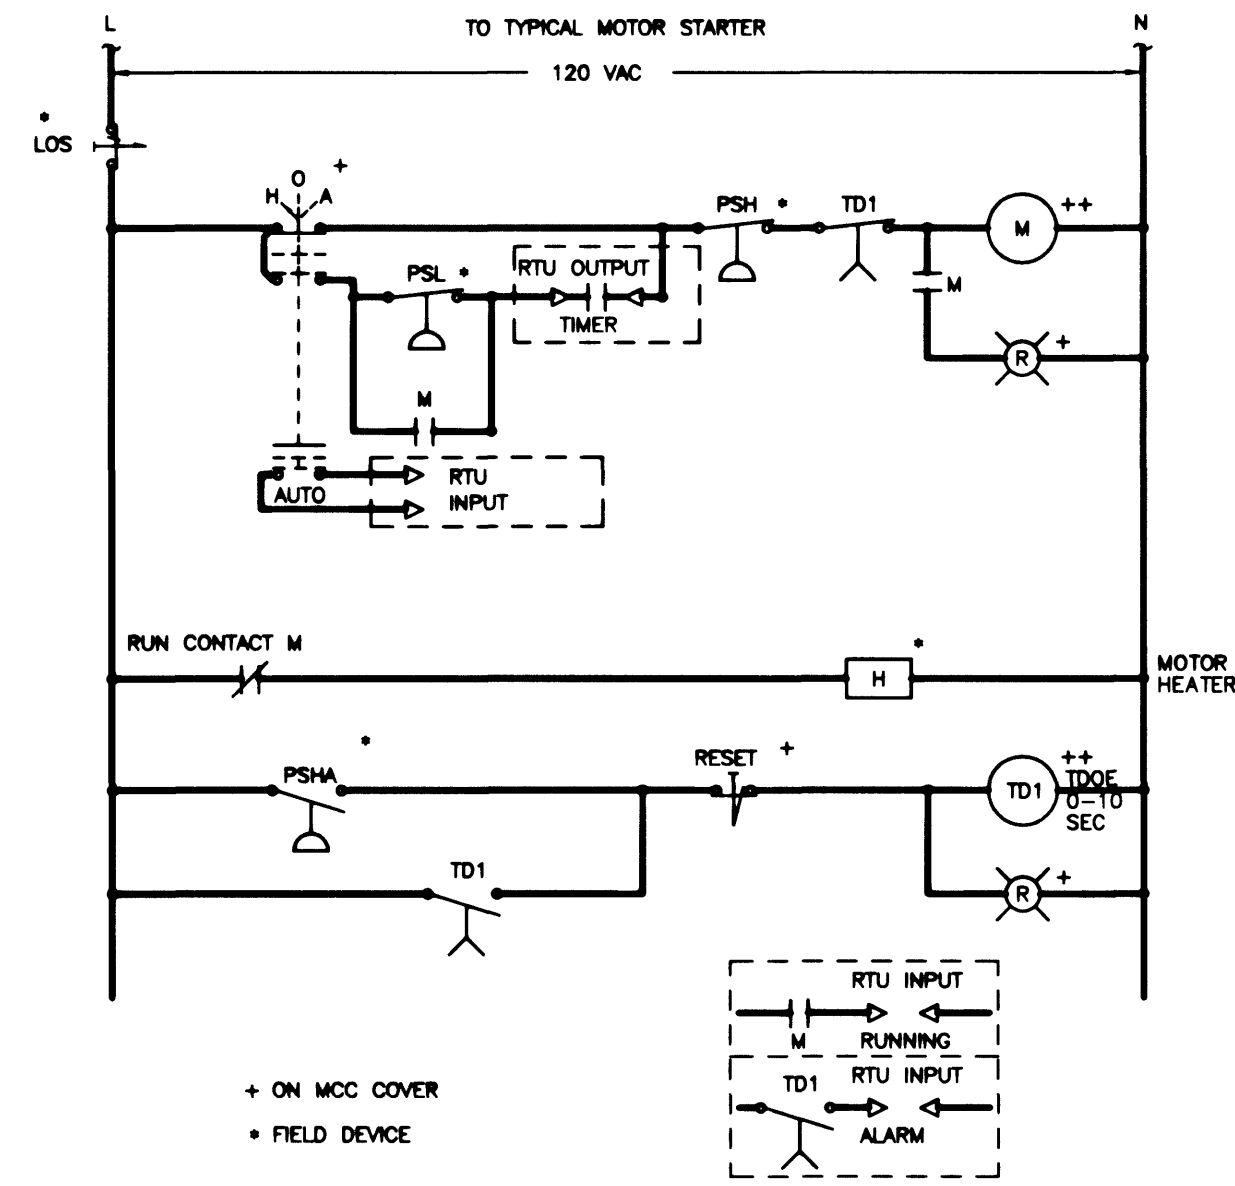


IRRIIGATION PUMP
PMP-V10IRP501
PMP-V10IRP502

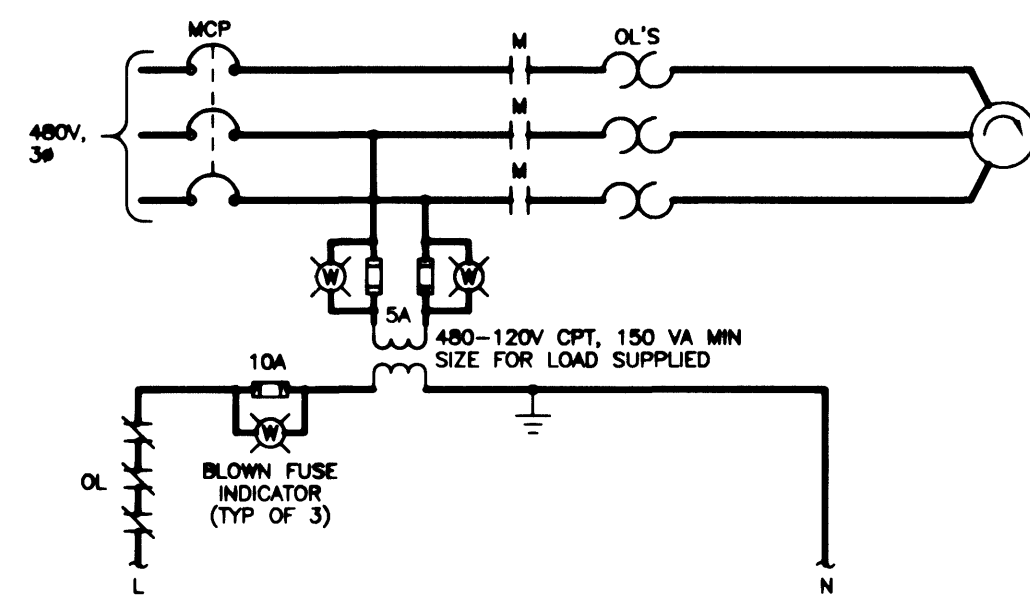


TYPICAL MOTOR CONTROL SCHEMATIC
NTS

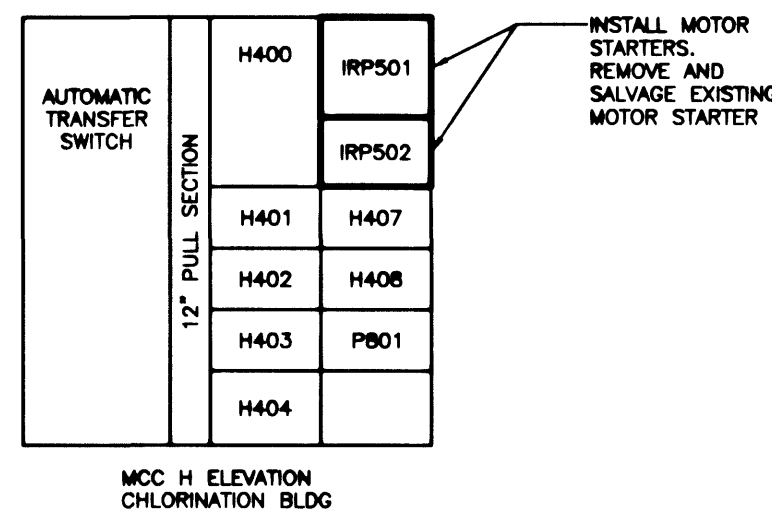


**MCC-H ELEVATION
CHLORINATION BLDG**
NTS

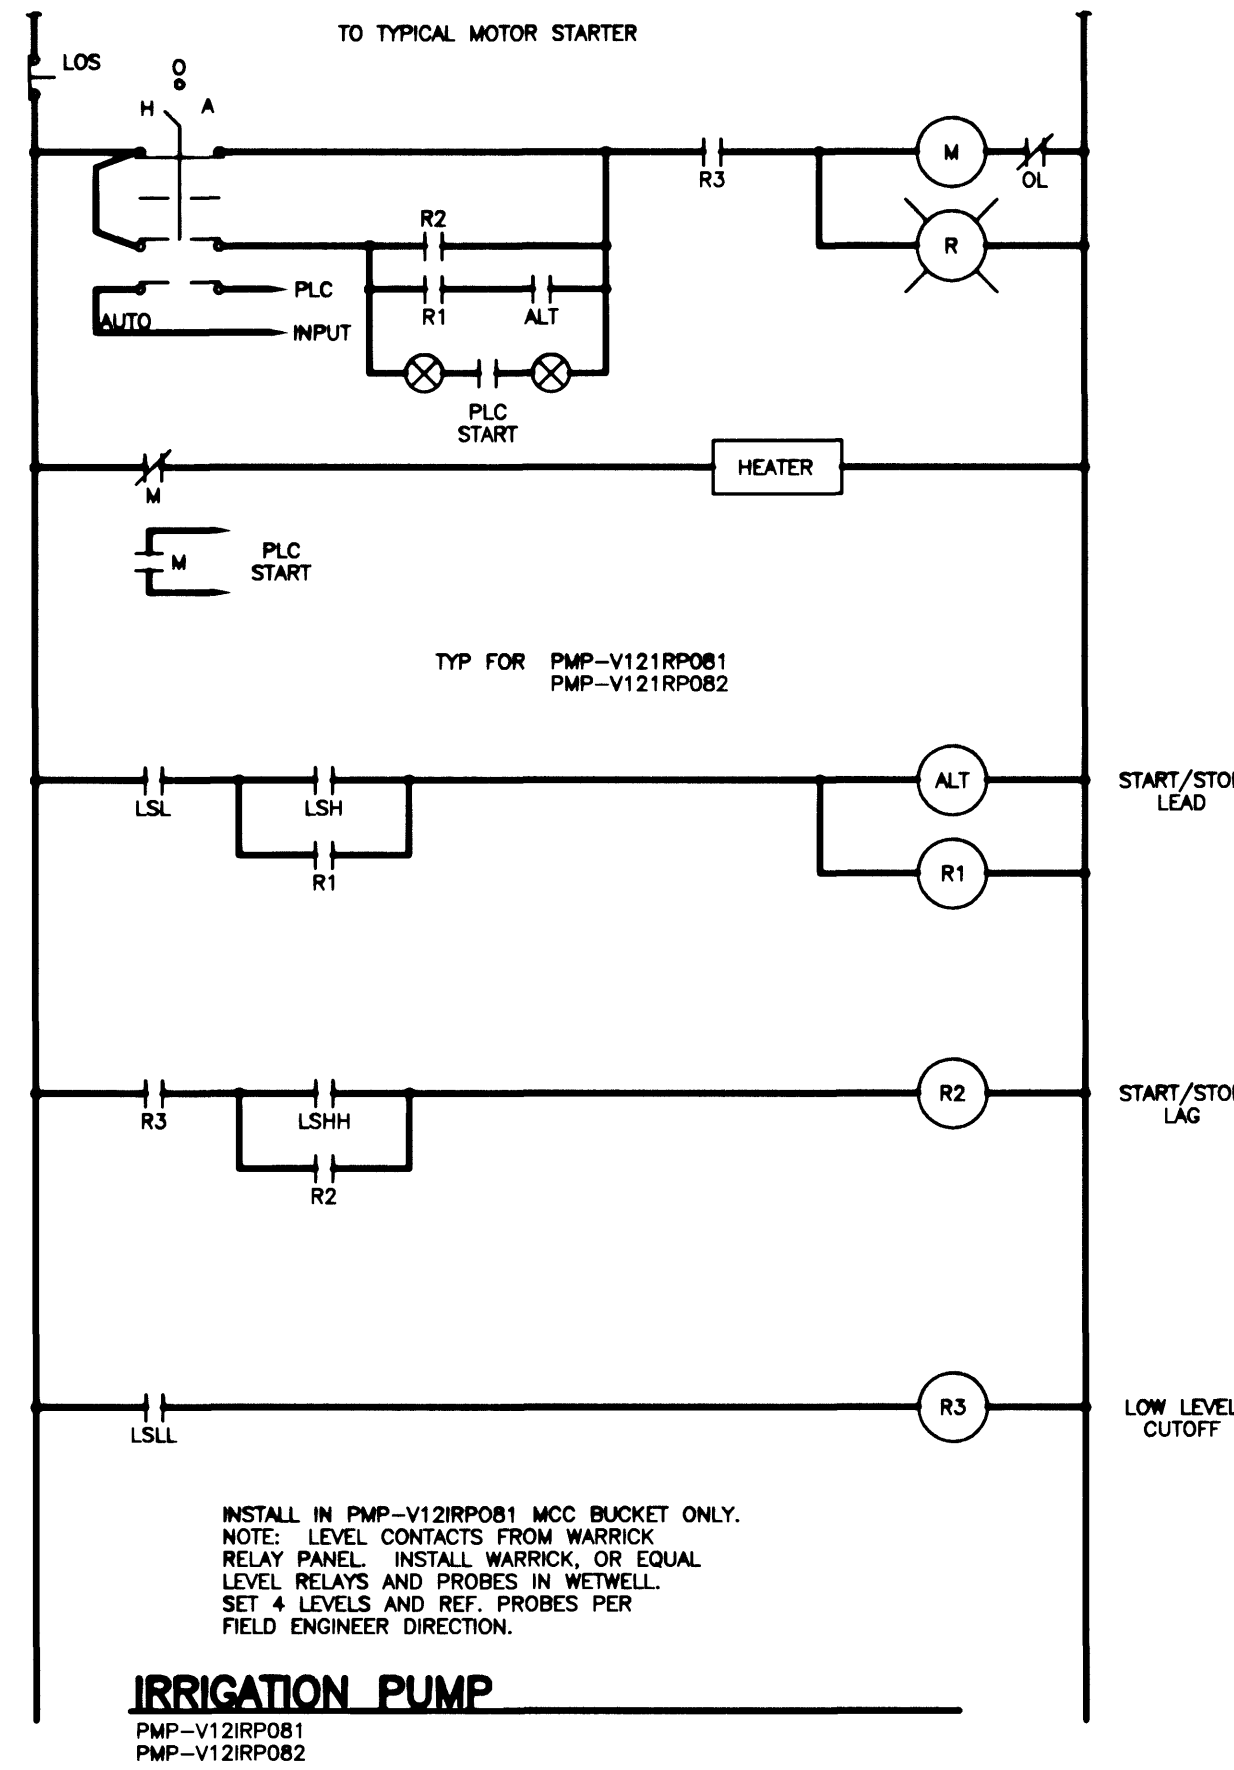


IRRIIGATION PUMP
PMP-V12IRP081
PMP-V12IRP082

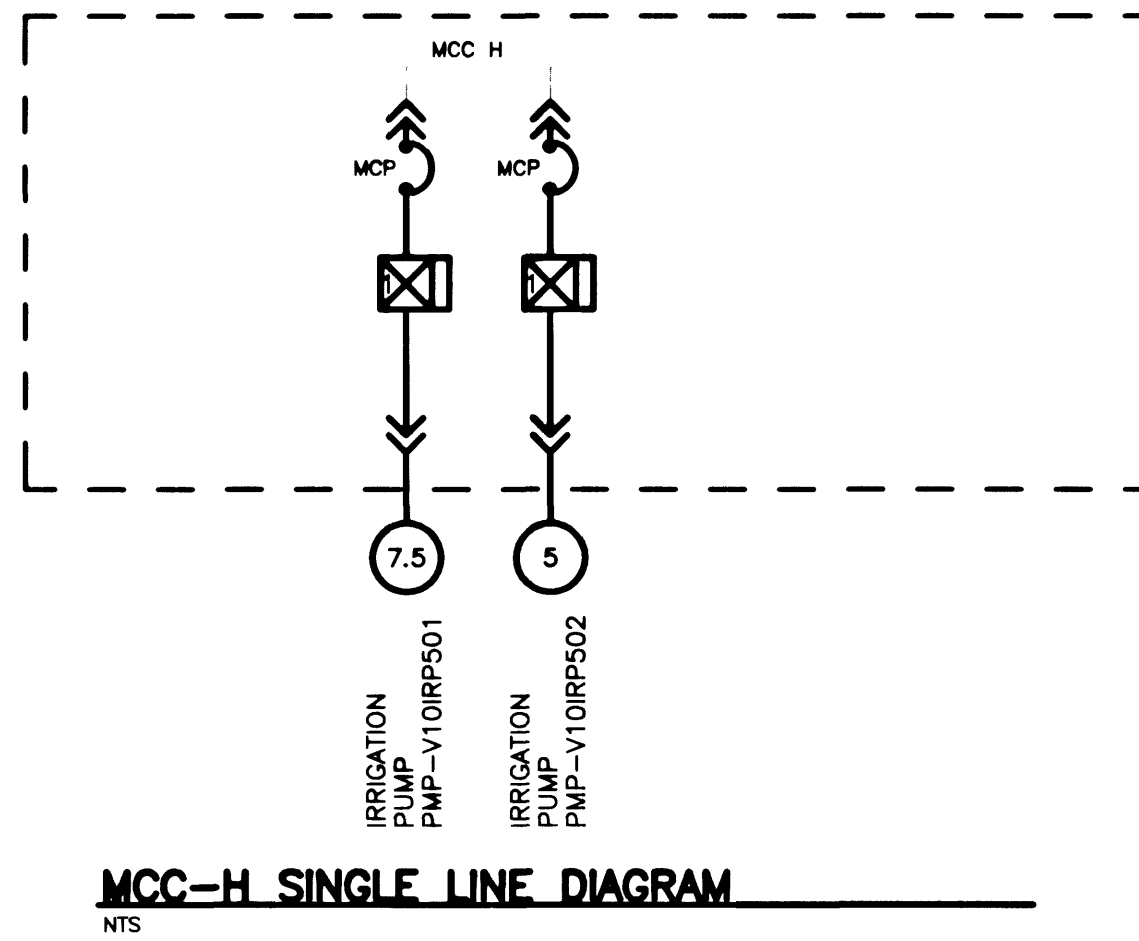

MCC-H SINGLE LINE DIAGRAM
NTS

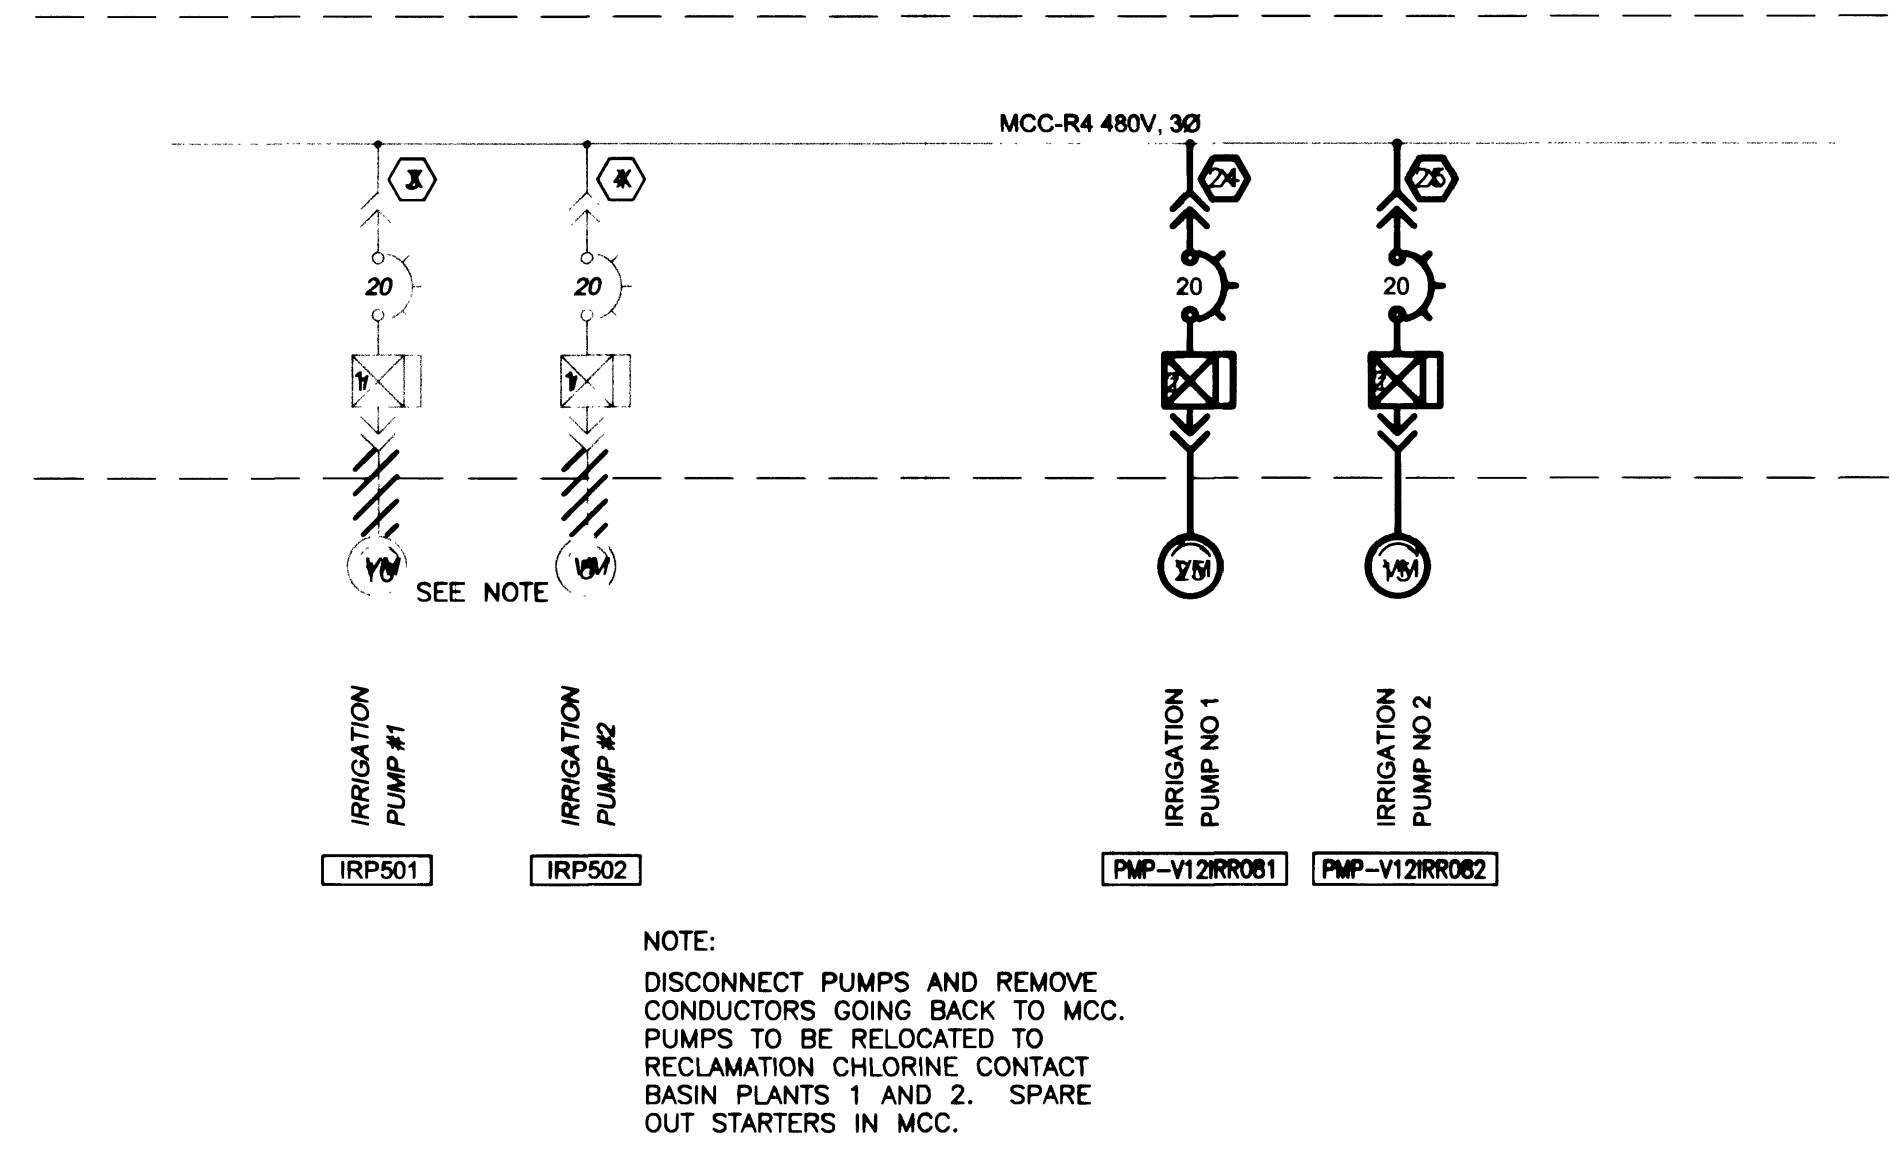

MCC-R4 ONE-LINE
NTS

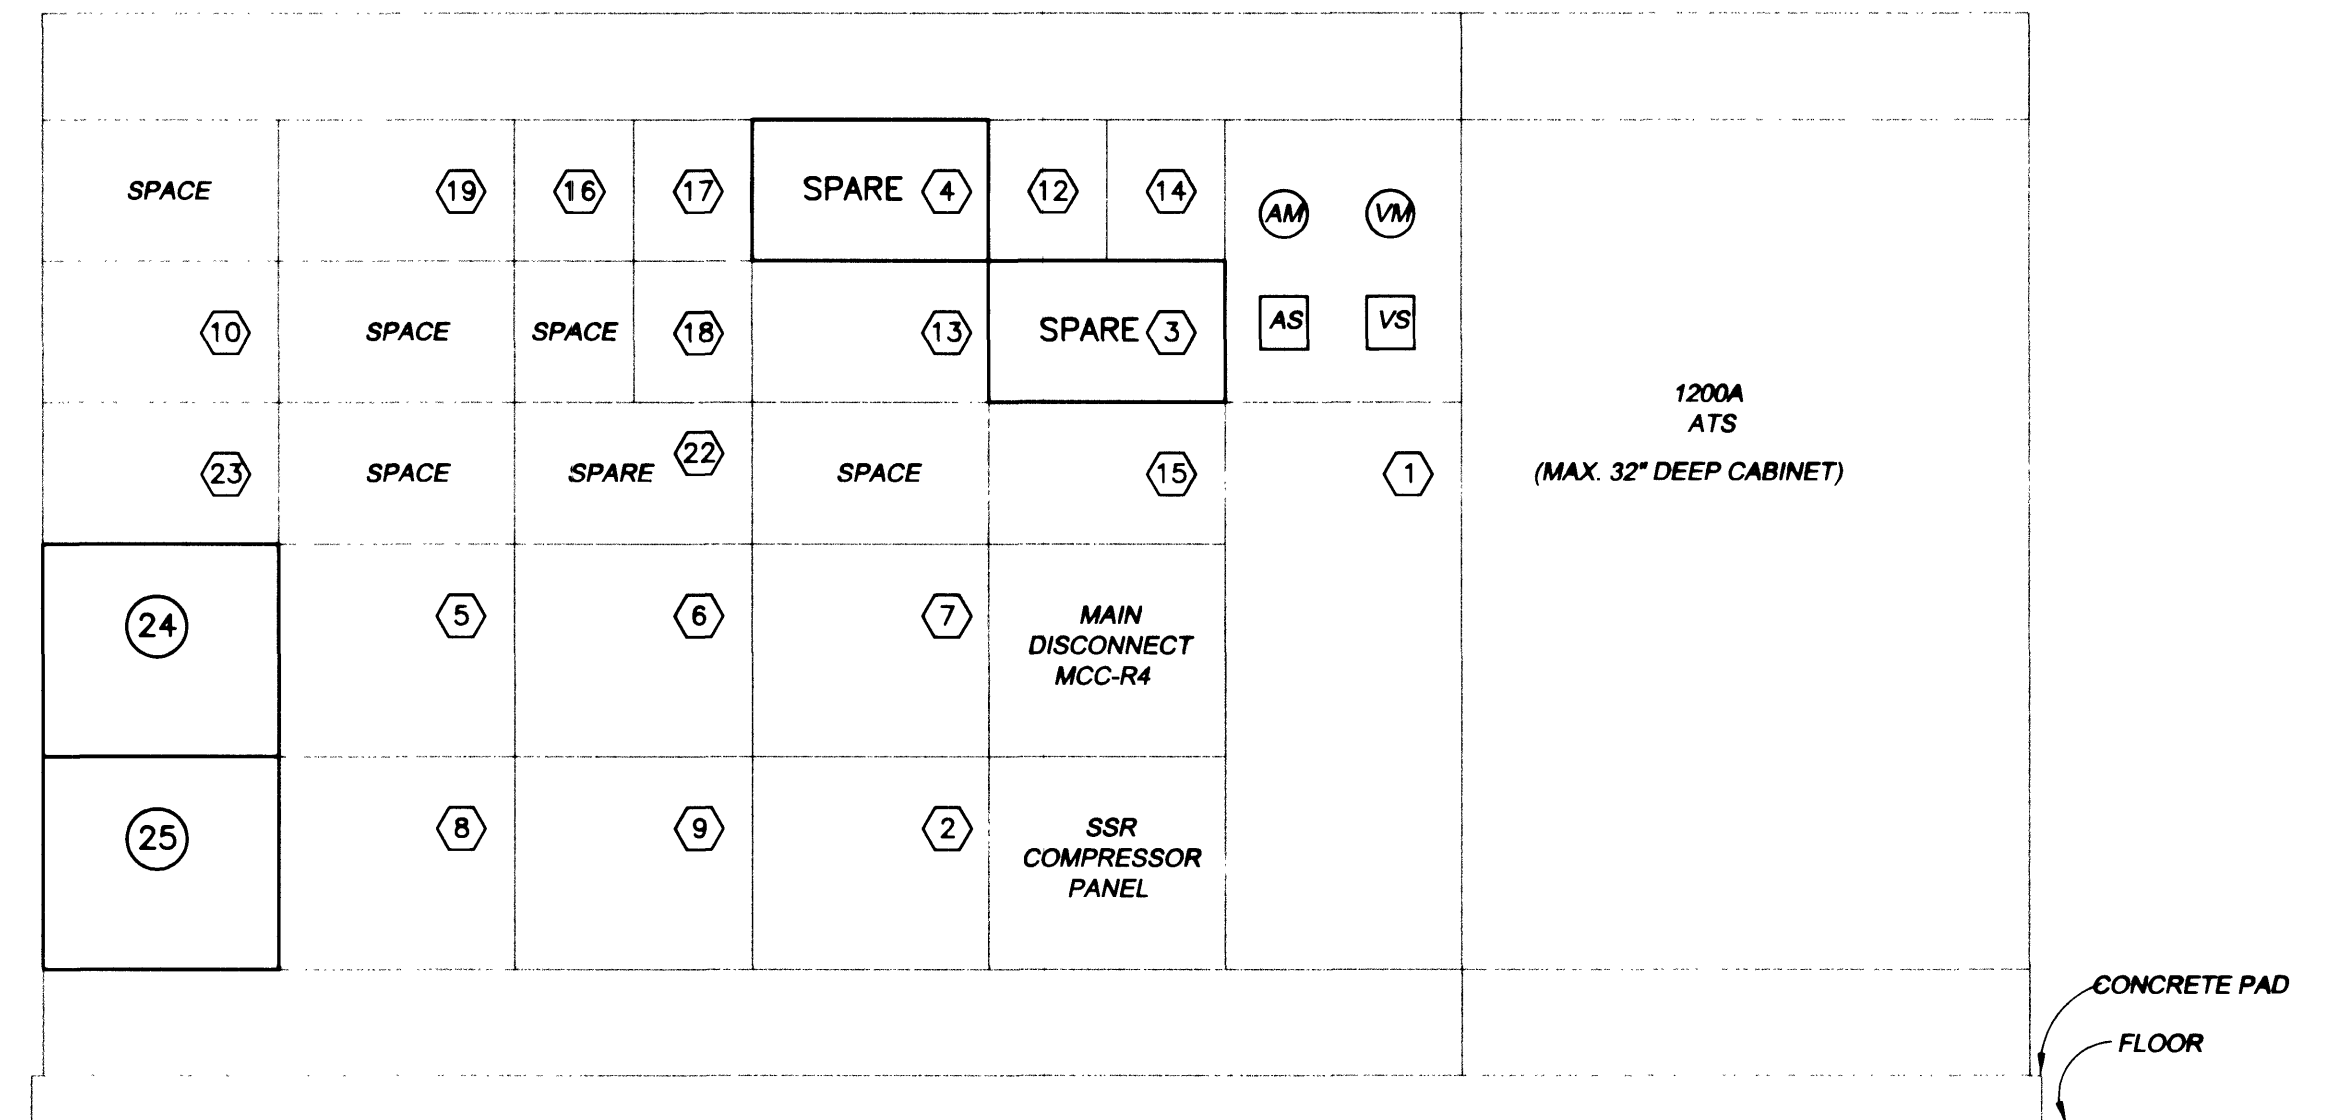

MCC-R4 ELEVATION
NTS